

ATTABAD LAKE HYDROPOWER PROJECT


LIST OF DRAWINGS

CATEGORY	SERIAL No.	DRAWING TITLE	DRAWING No.
GENERAL	1.	Project Location Map	AFS-GN-101
	2.	Project Area Accessibility Map from Islamabad	AFS-GN-102
	3.	Regional Map of Northern Area	AFS-GN-103
	4.	Catchment Area Map	AFS-GN-104
TOPOGRAPHIC SURVEY	5.	Project Area Topographic Survey Maps	AFS-TS-201
	6.	Project Area Topographic Survey Maps (Sheet 01 of 20)	AFS-TS-202
	7.	Project Area Topographic Survey Maps (Sheet 02 of 20)	AFS-TS-203
	8.	Project Area Topographic Survey Maps (Sheet 03 of 20)	AFS-TS-204
	9.	Project Area Topographic Survey Maps (Sheet 04 of 20)	AFS-TS-205
	10.	Project Area Topographic Survey Maps (Sheet 05 of 20)	AFS-TS-206
	11.	Project Area Topographic Survey Maps (Sheet 06 of 20)	AFS-TS-207
	12.	Project Area Topographic Survey Maps (Sheet 07 of 20)	AFS-TS-208
	13.	Project Area Topographic Survey Maps (Sheet 08 of 20)	AFS-TS-209
	14.	Project Area Topographic Survey Maps (Sheet 09 of 20)	AFS-TS-210
	15.	Project Area Topographic Survey Maps (Sheet 10 of 20)	AFS-TS-211
	16.	Project Area Topographic Survey Maps (Sheet 11 of 20)	AFS-TS-212
	17.	Project Area Topographic Survey Maps (Sheet 12 of 20)	AFS-TS-213
	18.	Project Area Topographic Survey Maps (Sheet 13 of 20)	AFS-TS-214
	19.	Project Area Topographic Survey Maps (Sheet 14 of 20)	AFS-TS-215
	20.	Project Area Topographic Survey Maps (Sheet 15 of 20)	AFS-TS-216
	21.	Project Area Topographic Survey Maps (Sheet 16 of 20)	AFS-TS-217
	22.	Project Area Topographic Survey Maps (Sheet 17 of 20)	AFS-TS-218
	23.	Project Area Topographic Survey Maps (Sheet 18 of 20)	AFS-TS-219
	24.	Project Area Topographic Survey Maps (Sheet 19 of 20)	AFS-TS-220
	25.	Project Area Topographic Survey Maps (Sheet 20 of 20)	AFS-TS-221
CROSS SECTIONS	26.	Project Area Cross Section Plan	AFS-CS-231
	27.	Project Area Cross Section at RD=000 & 0+200 (Sheet 1 of 10)	AFS-CS-232
	28.	Project Area Cross Section at RD=0+400 & 0+600 (Sheet 2 of 10)	AFS-CS-233
	29.	Project Area Cross Section at RD=0+800 & 1+000 (Sheet 3 of 10)	AFS-CS-234
	30.	Project Area Cross Section at RD=1+200 & 1+400 (Sheet 4 of 10)	AFS-CS-235
	31.	Project Area Cross Section at RD=1+600 & 1+800 (Sheet 5 of 10)	AFS-CS-236
	32.	Project Area Cross Section at RD=2+000, 2+200 & 2+400 (Sheet 6 of 10)	AFS-CS-237


CATEGORY	SERIAL No.	DRAWING TITLE	DRAWING No.
	33.	Project Area Cross Section at RD=2+600 & 2+800 (Sheet 7 of 10)	AFS-CS-238
	34.	Project Area Cross Section at RD=3+000 & 3+200 (Sheet 8 of 10)	AFS-CS-239
	35.	Project Area Cross Section at RD=3+400 & 3+600 (Sheet 9 of 10)	AFS-CS-240
	36.	Project Area Cross Section at RD=3+800 & 4+000 (Sheet 10 of 10)	AFS-CS-241
PLAN AND PROFILE	37.	Water Surface - Plan And Profile (Sheet 01 of 11)	AFS-SP-251
	38.	Water Surface - Plan And Profile (Sheet 02 of 11)	AFS-SP-252
	39.	Water Surface - Plan And Profile (Sheet 03 of 11)	AFS-SP-253
	40.	Water Surface - Plan And Profile (Sheet 04 of 11)	AFS-SP-254
	41.	Water Surface - Plan And Profile (Sheet 05 of 11)	AFS-SP-255
	42.	Water Surface - Plan And Profile (Sheet 06 of 11)	AFS-SP-256
	43.	Water Surface - Plan And Profile (Sheet 07 of 11)	AFS-SP-257
	44.	Water Surface - Plan And Profile (Sheet 08 of 11)	AFS-SP-258
	45.	Water Surface - Plan And Profile (Sheet 09 of 11)	AFS-SP-259
	46.	Water Surface - Plan And Profile (Sheet 10 of 11)	AFS-SP-260
	47.	Water Surface - Plan And Profile (Sheet 11 of 11)	AFS-SP-261
HYDROGRAPHIC SURVEY	48.	Hydrographic Survey of Attabad Lake X- Section No(1 to 4)	AFS-HS-271
	49.	Hydrographic Survey of Attabad Lake X- Section No(5 to 8)	AFS-HS-272
	50.	Hydrographic Survey of Attabad Lake X- Section No(9 to 12)	AFS-HS-273
	51.	Hydrographic Survey of Attabad Lake X- Section No(13 to 16)	AFS-HS-274
	52.	Hydrographic Survey of Attabad Lake X- Section No(17 to 20)	AFS-HS-275
	53.	Hydrographic Survey of Attabad Lake X- Section No(21 to 24)	AFS-HS-276
	54.	Hydrographic Survey of Attabad Lake X- Section No(25 to 27)	AFS-HS-277
	55.	Hydrographic Survey of Attabad Lake X- Section No(28 to 30)	AFS-HS-278
	56.	Hydrographic Survey of Attabad Lake X- Section No(31 to 34)	AFS-HS-279
	57.	Hydrographic Survey of Attabad Lake X- Section No(35 to 38)	AFS-HS-280
	58.	Hydrographic Survey of Attabad Lake X- Section No(39 to 40)	AFS-HS-281
GEOLOGY	59.	Regional Geological Map	AFS-GE-291
	60.	Regional Tectonics Map	AFS-GE-292
	61.	Surface Geological Map (Sheet 01 of 20)	AFS-GE-293
	62.	Surface Geological Map (Sheet 02 of 20)	AFS-GE-294
	63.	Surface Geological Map (Sheet 03 of 20)	AFS-GE-295
	64.	Surface Geological Map (Sheet 04 of 20)	AFS-GE-296
	65.	Surface Geological Map (Sheet 05 of 20)	AFS-GE-297
	66.	Surface Geological Map (Sheet 06 of 20)	AFS-GE-298
	67.	Surface Geological Map (Sheet 07 of 20)	AFS-GE-299
	68.	Surface Geological Map (Sheet 08 of 20)	AFS-GE-300
	69.	Surface Geological Map (Sheet 09 of 20)	AFS-GE-301

CATEGORY	SERIAL No.	DRAWING TITLE	DRAWING No.
	70.	Surface Geological Map (Sheet 10 of 20)	AFS-GE-302
	71.	Surface Geological Map (Sheet 11 of 20)	AFS-GE-303
	72.	Surface Geological Map (Sheet 12 of 20)	AFS-GE-304
	73.	Surface Geological Map (Sheet 13 of 20)	AFS-GE-305
	74.	Surface Geological Map (Sheet 14 of 20)	AFS-GE-306
	75.	Surface Geological Map (Sheet 15 of 20)	AFS-GE-307
	76.	Surface Geological Map (Sheet 16 of 20)	AFS-GE-308
	77.	Surface Geological Map (Sheet 17 of 20)	AFS-GE-309
	78.	Surface Geological Map (Sheet 18 of 20)	AFS-GE-310
	79.	Surface Geological Map (Sheet 19 of 20)	AFS-GE-311
	80.	Surface Geological Map (Sheet 20 of 20)	AFS-GE-312
	81.	Geological X Section AA', Weir Site	AFS-GE-313
	82.	Geological X Section BB', Intake Area	AFS-GE-314
	83.	Geological X Section DD', Penstock & P/H Area	AFS-GE-315
	84.	Borehole Location Map	AFS-GE-316
	85.	Location of Test Pits	AFS-GE-317
	86.	Neotectonic Study Area	AFS-GE-318
	87.	Neotectonic Study Area	AFS-GE-319
	88.	Neotectonic Study Area	AFS-GE-320
	89.	Project Location Area	AFS-GN-401
	90.	Project Vicinity Map	AFS-GN-402
	91.	Project Layout on G.T Sheet	AFS-LAY-403
PROJECT LAYOUT WEIR	92.	Project Layout	AFS-LAY-404
	93.	Weir and Power Intake Arrangements	AFS-LAY-405
	94.	Surge To Powerhouse Arrangements	AFS-LAY-406
	95.	Project Longitudinal Section	AFS-LAY-407
	96.	Weir Arrangement	AFS-WR-408
	97.	Plan For Weir	AFS-WR-409
	98.	Weir Longitudinal Sections	AFS-WR-410
	99.	Weir Cross sections	AFS-WR-411
	100.	Weir Diversion Scheme (Stage I)	AFS-WR-412
	101.	Weir Diversion Scheme (Stage II)	AFS- WR-413
	102.	Cross Section At RD 0+0 From Downstream of Weir Site	AFS-WR-414
	103.	Cross Section At RD 0+50 From Downstream of Weir Site	AFS-WR-415
	104.	Cross Section At RD 0+100 From Downstream of Weir Site	AFS-WR-416
	105.	Cross Section At RD 0+150 From Downstream of Weir Site	AFS-WR-417
	106.	Cross Section At RD 0+200 From Downstream of Weir Site	AFS-WR-418
	107.	Cross Section At RD 0+250 From Downstream of Weir Site	AFS-WR-419
	108.	Cross Section At RD 0+300 From Downstream of Weir Site	AFS-WR-420
	109.	Cross Section At RD 0+350 From Downstream of Weir Site	AFS-WR-421
	110.	Cross Section At RD 0+400 From Downstream of Weir Site	AFS-WR-422

CATEGORY	SERIAL No.	DRAWING TITLE	DRAWING No.
	111.	Cross Section At RD 0+450 From Downstream of Weir Site	AFS-WR-423
POWER INTAKE	112.	Plan For Power Intake	AFS-PI-424
	113.	Longitudinal Section For Power Intake	AFS-PI-425
	114.	Power Intake Sections	AFS-PI-426
SURGE TANK	115.	Surge Tank Layout	AFS-ST-427
	116.	Surge Tank Plan And Sections	AFS-ST-428
	117.	Surge Tank Sections	AFS-ST-429
	118.	Penstock Plan And Longitudinal Profile	AFS-ST-430
POWER HOUSE	119.	Power House Layout	AFS-PH-431
	120.	Plan For Power House	AFS-PH-432
	121.	Generator Floor Plan	AFS-PH-433
	122.	Machine Hall Plan	AFS-PH-434
	123.	Cross Section for Power House	AFS-PH-435
	124.	Longitudinal Section for Power House	AFS-PH-436
REINFORCEMENT DETAILS	125.	Typical Detail for Concrete Joints	AFS-MIS-437
	126.	Miscellaneous Reinforcement Details (Sheet 01 of 2)	AFS-MIS-438
	127.	Miscellaneous Reinforcement Details (Sheet 02 of 2)	AFS-MIS-439
PENSTOCK	128.	Penstock Details of Horizontal Anchor Blocks	AFS-MIS-440
	129.	Penstock Details of Vertical Anchor Blocks	AFS-MIS-441
ELECTRO-MECHANICAL	130.	Main Single Line Diagram	AFS-EM-451
	131.	AC Supply System	AFS-EM-452
	132.	AC LV Supply System	AFS-EM-453
	133.	DC Supply System	AFS-EM-454
	134.	Plant Control System	AFS-EM-455
	135.	Protection Schemes	AFS-EM-456
	136.	132KV- Transmission Line Type-ZM1	AFS-EM-457
	137.	132KV- Transmission Line Type-ZM30	AFS-EM-458
	138.	132KV- Transmission Line Type-ZM60	AFS-EM-459
	139.	Typical Tower Foundation	AFS-EM-460
OFFICES AND RESIDENTIAL COMPLEX	140.	Offices and Residential Complex Master Plan	AFS-ORC-471
	141.	Office Building Plan	AFS-ORC-472
	142.	Officers Hostel Ground Floor Plan	AFS-ORC-473
	143.	Officers Hostel First Floor Plan	AFS-ORC-474
	144.	Rest House Plan	AFS-ORC-475
	145.	Mosque Plan	AFS-ORC-476
ENVIRONMENTAL	146.	Project Land Requirement	AFS-EN-477
CONSTRUCTION PLANNING	147.	Project Implementation Plan	AFS-CP-478

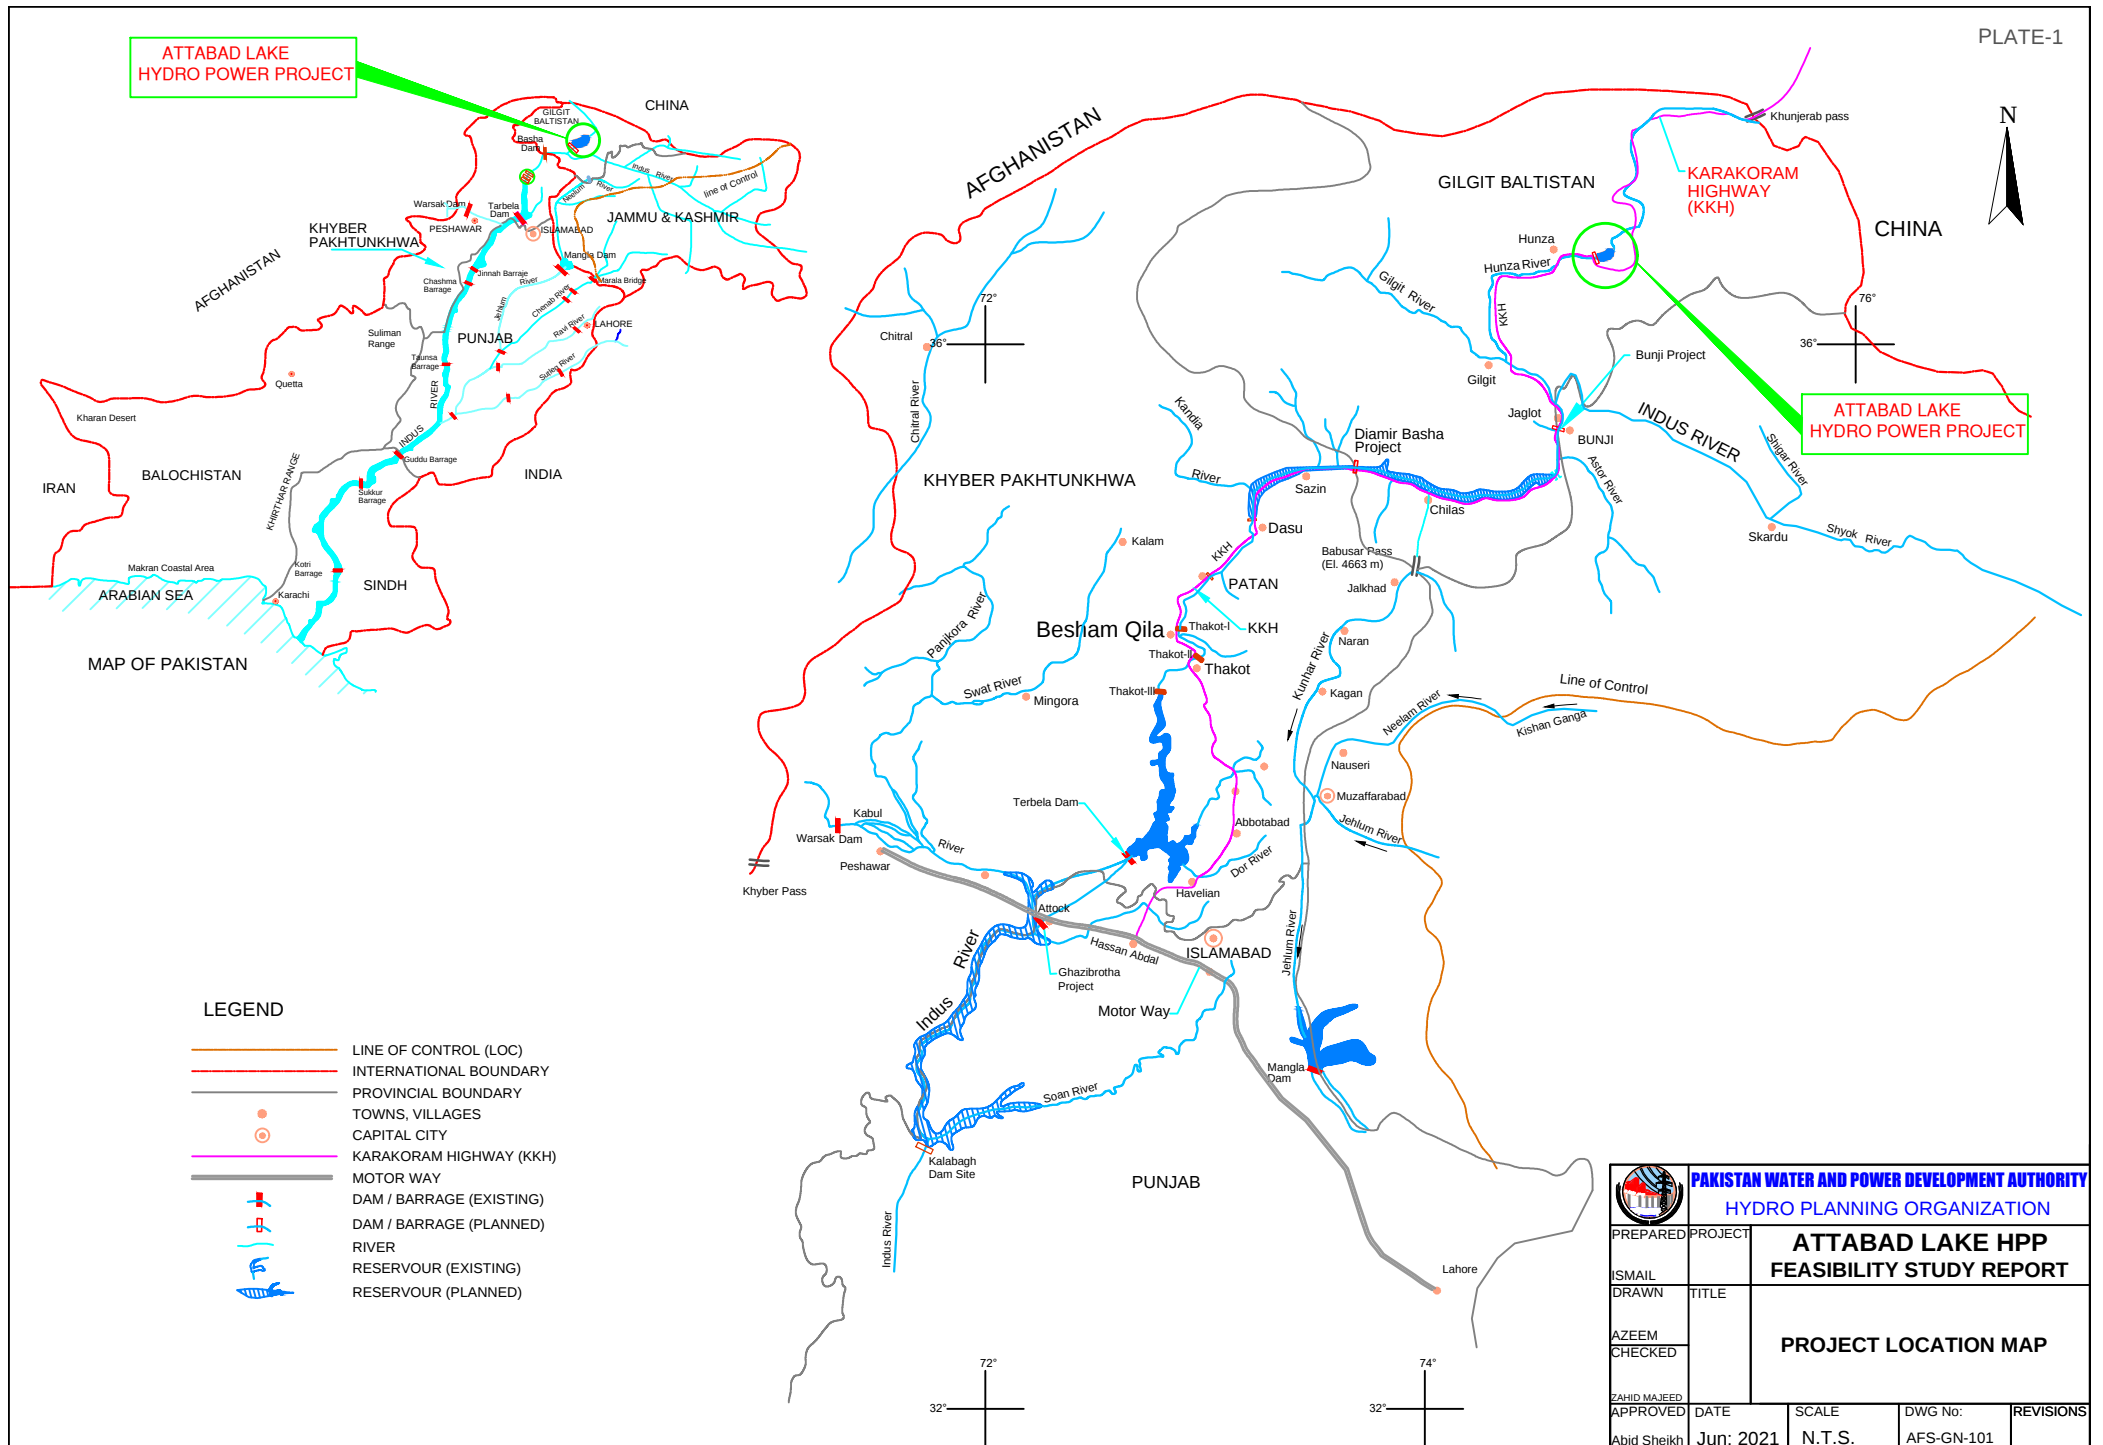


Destination	Kilometers
Abbottabad	116
Balekot	188
Bahrain	319
Bhurban	75
Besham	272
Bardeen	390
Chilas	482
Chitral	365
Dir	265
Gilgit	628
Gulmit	766
Haripur	89
Hassanabad	58
Hunza (Karimabad)	730
Kohat	185
Kaghan	275
Khunjerab Pass	906
Kalam	384
Muzaffarabad	152
Mardan	154
Malakand Pass	211
Madyan	308
Mansohra	140
Murree	62
Mingora	264
Naran	278
Nathigali	100
Nowshera	136
Pattan	312
Passu	780
Peshawar	176
Sost	806
Skardu	793
Saidu Sharif	266
Taxila (Museum)	40
Tarbela Dam	110
Thandiani	162

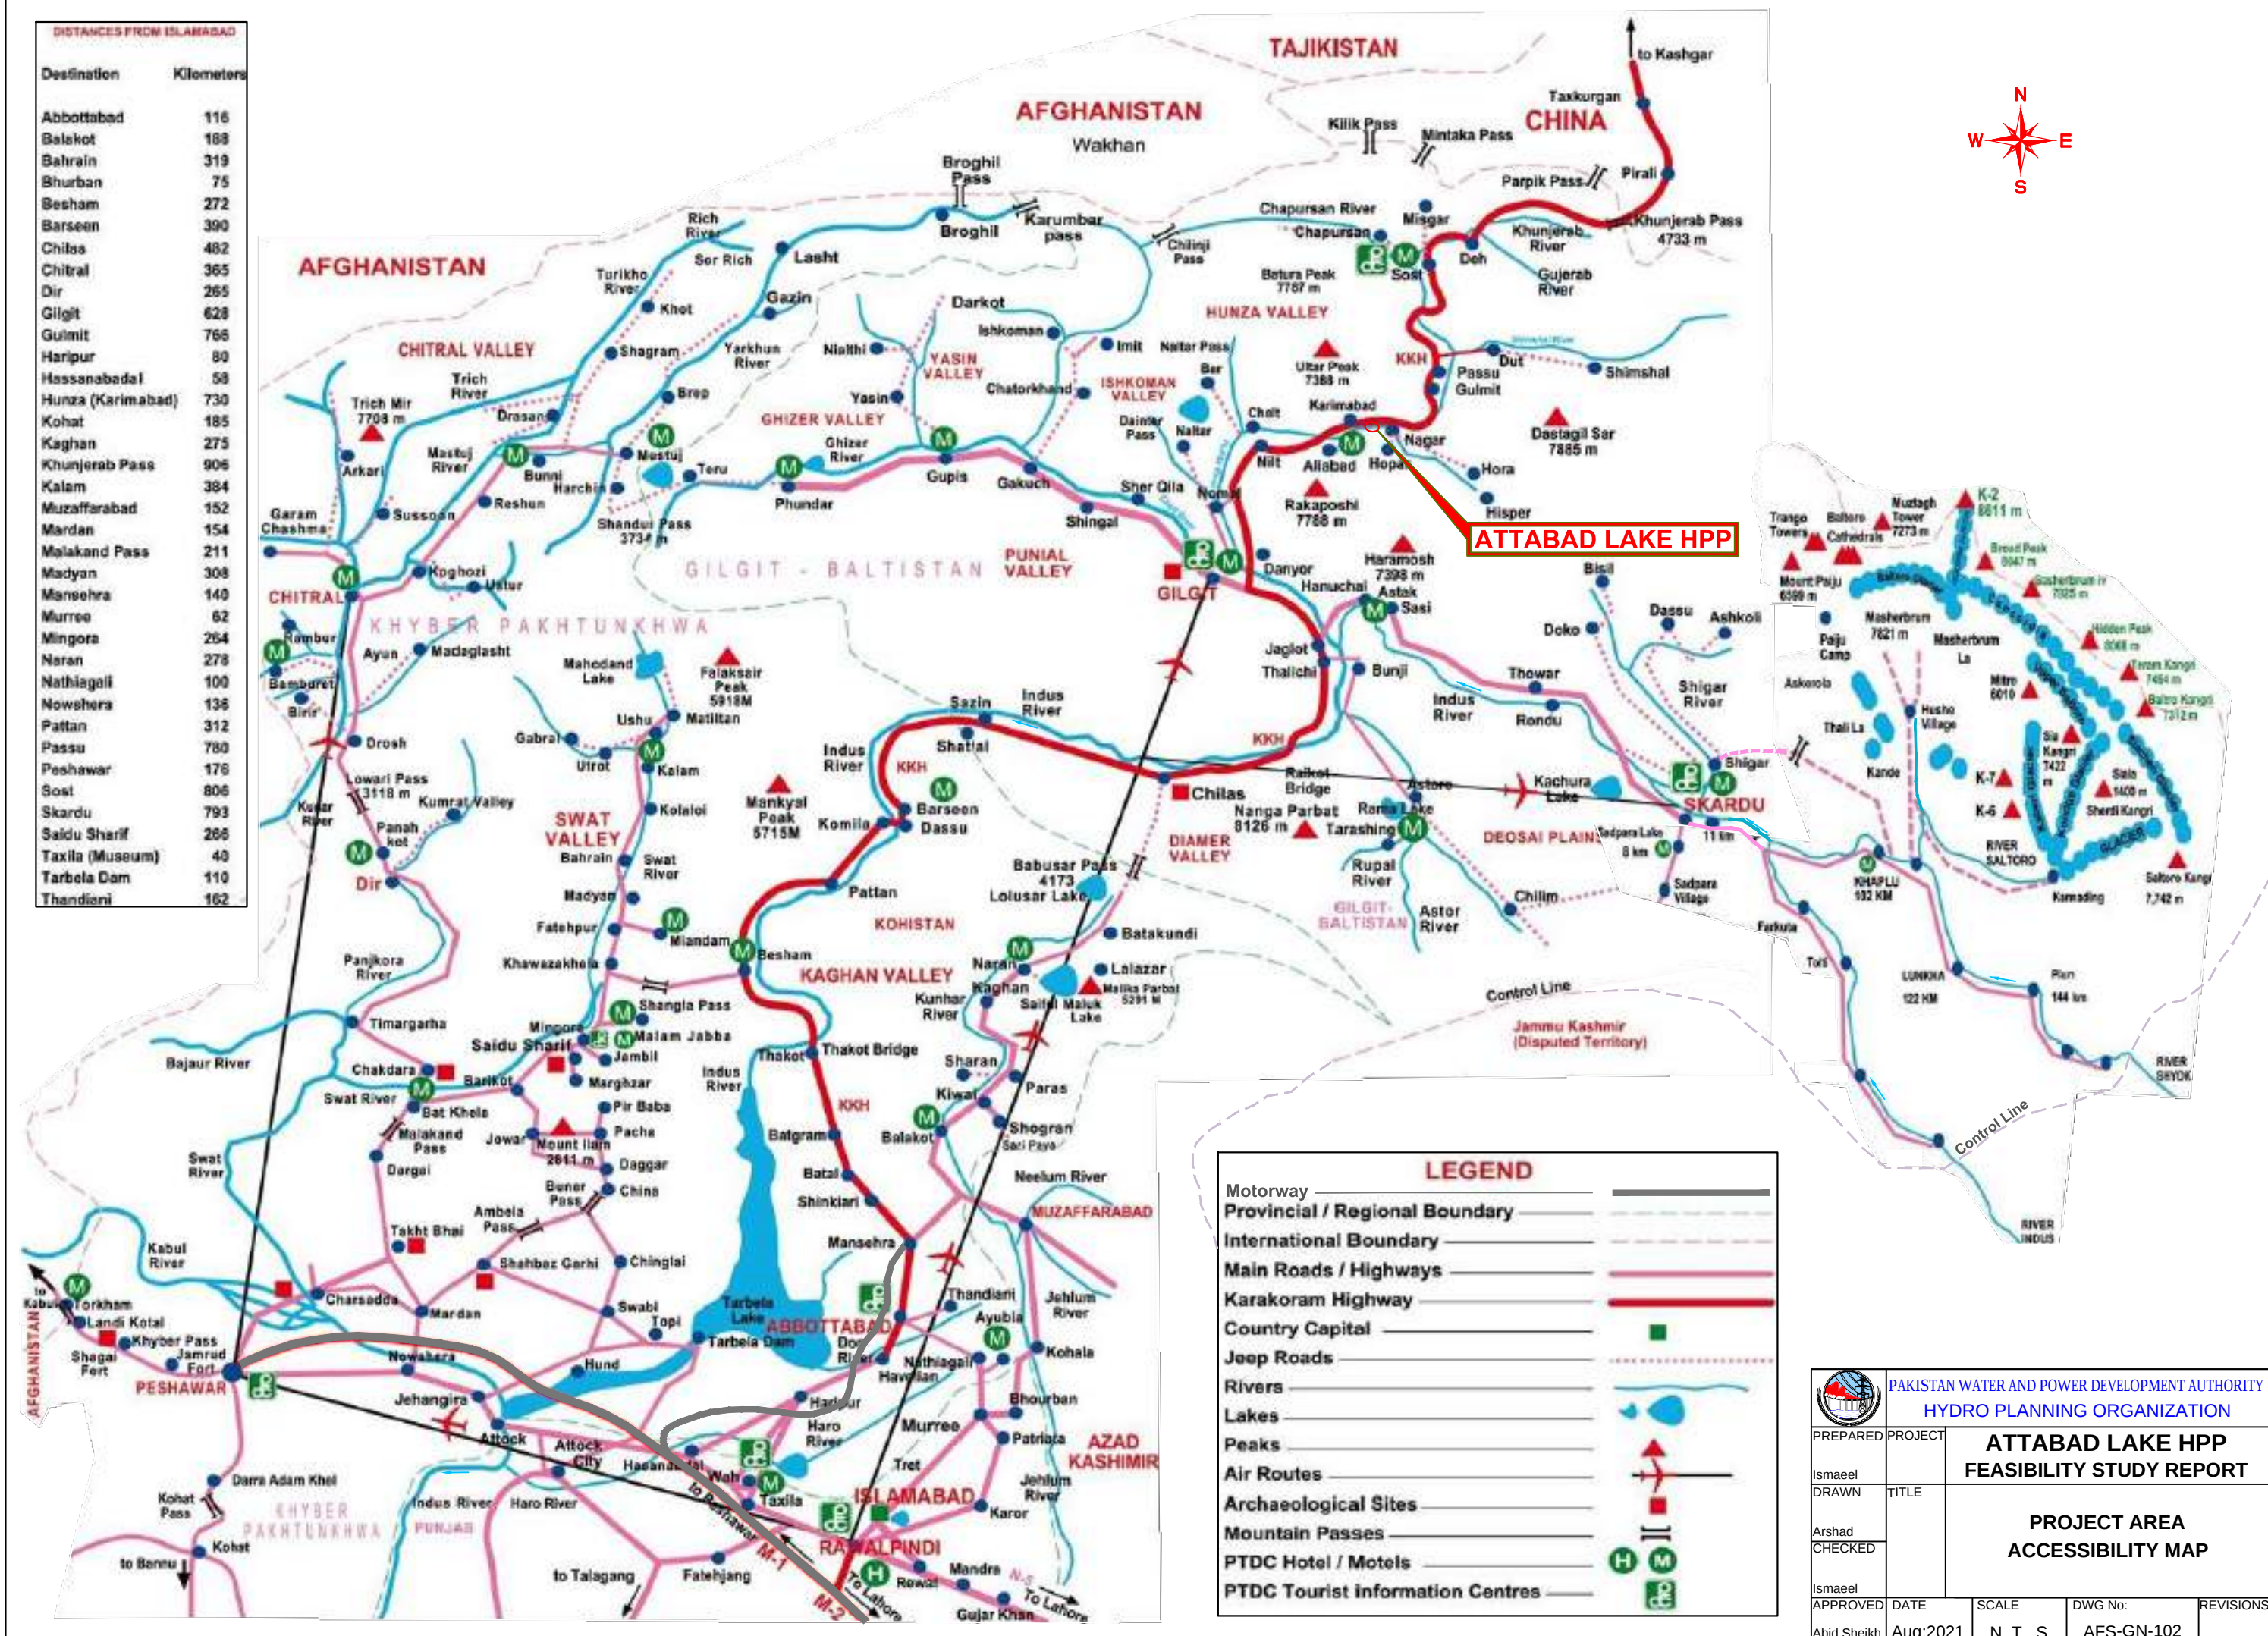


GILGIT-BALTISTAN



 PAKISTAN WATER AND POWER DEVELOPMENT AUTHORITY HYDRO PLANNING ORGANIZATION				
PREPARED	PROJECT	ATTABAD LAKE HPP		
ISMAIL		FEASIBILITY STUDY REPORT		
DRAWN	TITLE	REGIONAL MAP OF		
AZEEM		NORTHERN AREA		
CHECKED				
ZAHID MAJEED	DATE	SCALE	DWG No:	REVISIONS
APPROVED	Jun: 2021	1"=8'	AFS-GN=103	
Abid Sheikh				

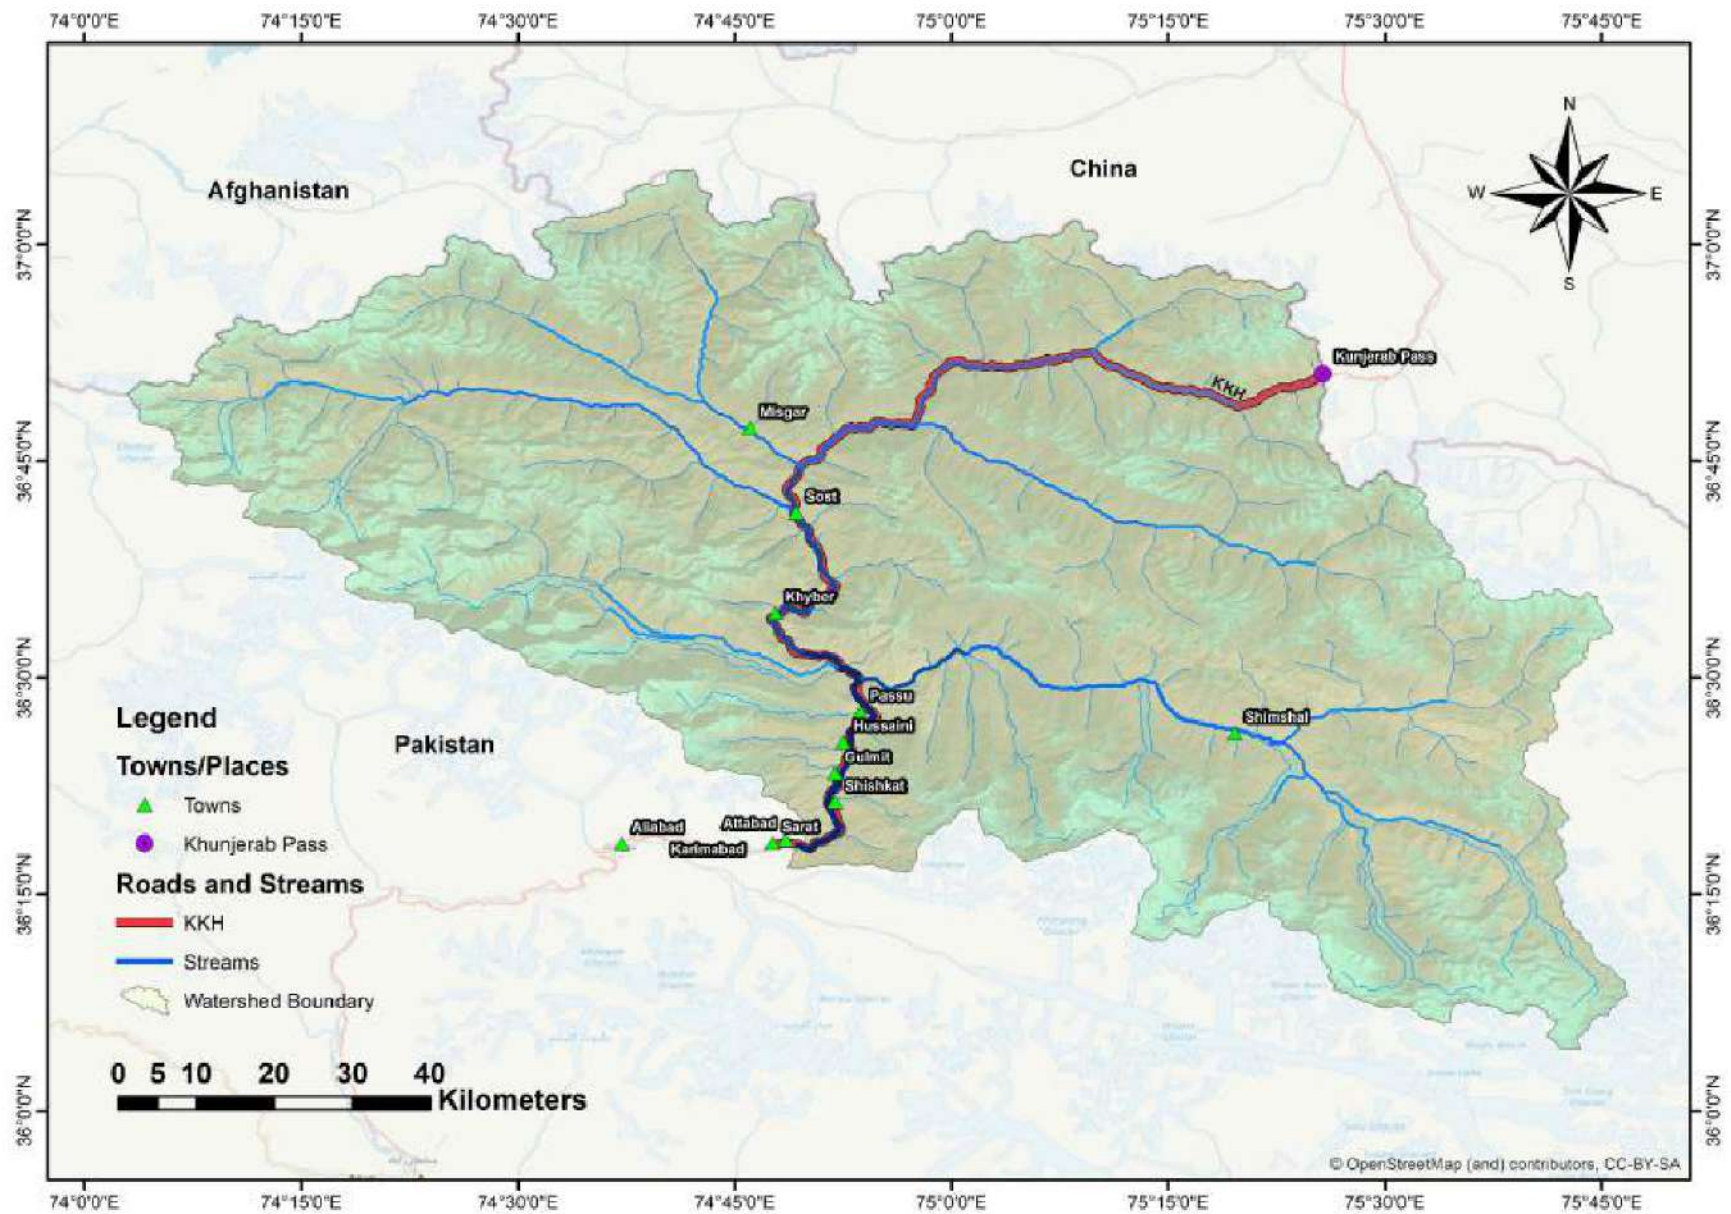


 PAKISTAN WATER AND POWER DEVELOPMENT AUTHORITY HYDRO PLANNING ORGANIZATION				
PREPARED BY	PROJECT	ATTABAD LAKE HPP		
ISMAIL		FEASIBILITY STUDY REPORT		
DRAWN	TITLE	CATCHMENT AREA MAP		
AZEEM				
CHECKED				
APPROVED	DATE	SCALE	DWG No:	REVISIONS
Abid Sheikh	Jun: 2021	1"=8'	AFS-CA=104	

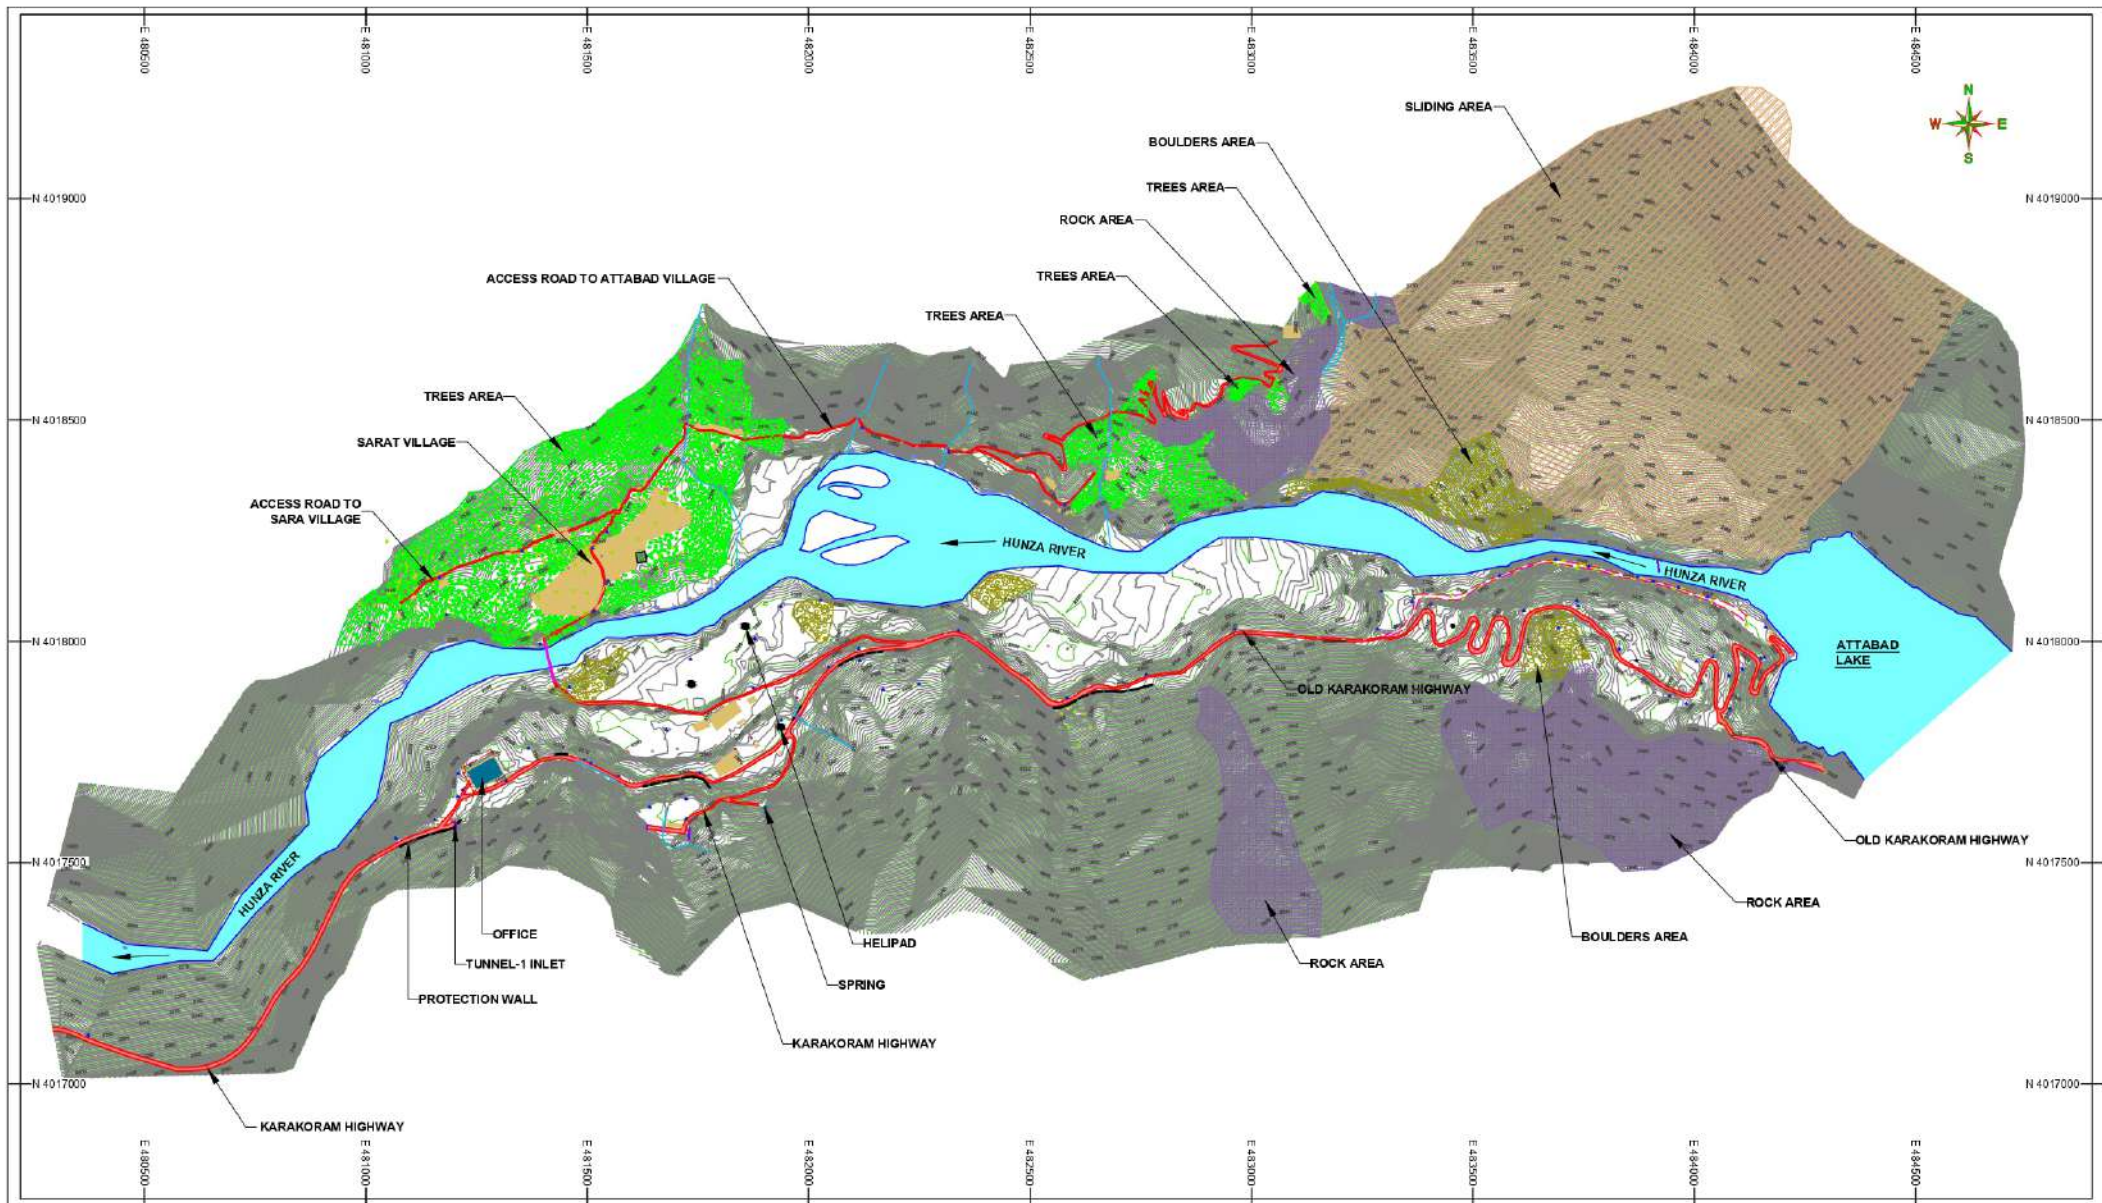

LEGENDS:

RIVER/NALLA		ELECTRIC POLE/T. POLE		WATER TANK	
HOUSES/SHOPS		RETAINING WALL		SPRING	
ROAD		TREES AREA		JAMAT KHANA	
KATCHA ROAD/TRACK		DRAIN AND NULLAH		HFL	
CONTROL POINTS		BRIDGE AND CULVERT		HELIPAD	
CONTOURS		BOULDERS		SLIDING	
				ROCK	

 


NOTE

1. ALL THE UNITS ARE IN METERS UNLESS OTHERWISE NOTED
2. SURVEY OF PAKISTAN (SOP) METRIC COORDINATE SYSTEM WAS USED FOR FIELD OBSERVATIONS.

WAS USED FOR FIELD OBSERVATIONS

		PAKISTAN WATER AND POWER DEVELOPMENT AUTHORITY HYDRO PLANNING ORGANIZATION			
PREPARED BY	PROJECT	ATTABAD LAKE HPP FEASIBILITY STUDY REPORT			
Ehsan					
DRAWN	TITLE	PROJECT AREA TOPOGRAPHIC SURVEY MAP			
Arshad					
CHECKED					
Ehsan					
APPROVED	DATE	SCALE	DWG No:	REVISIONS	
Abid Sheikh	Jun: 2021	1 : 12,000	AFS-TS-201		

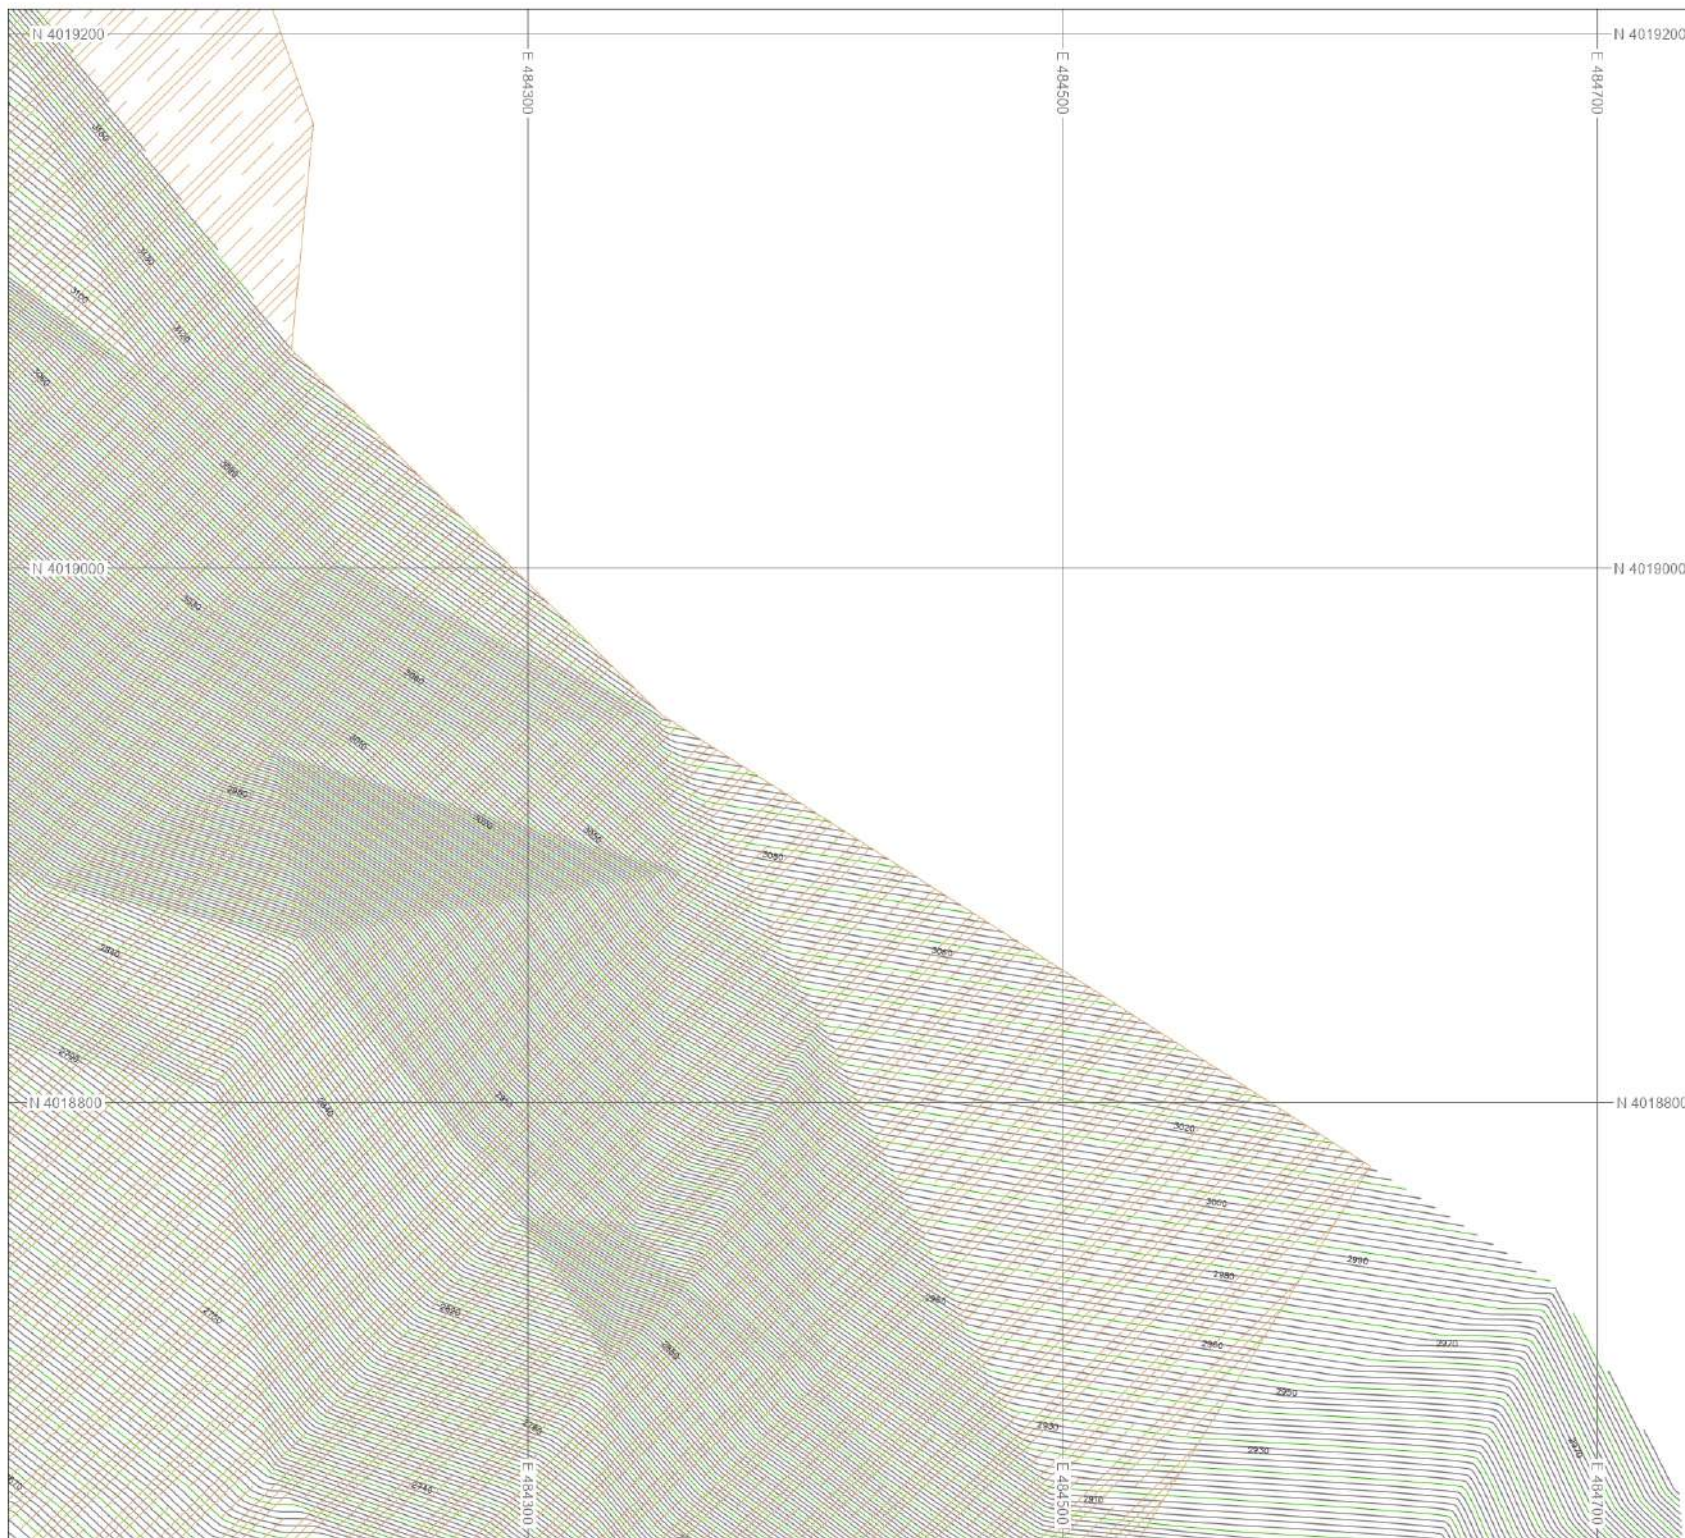

KEY PLAN

					4	1
	16	13	10	7	5	2
19	17	14	11	8	6	3
20	18	15	12	9		


LEGENDS:

RIVER/NALLA	
HOUSES/SHOPS	
ROADS	
KATCHA ROAD/TRACK	
CONTROL POINTS	
CONTOURS	
ELECTRIC POLE/T.POLE	
RETAINING WALL	
TREES AREA	
DRAIN AND NULLAH	
BRIDGE AND CULVERT	
BOULDERS	
WATER TANK	
SPRING	
JAMAT KHANA	
HFL	
HELIPAD	
SLIDING	
ROCK	



NOTE
1. ALL THE UNITS ARE IN METERS UNLESS OTHERWISE NOTED
2. SURVEY OF PAKISTAN (SOP) METRIC COORDINATE SYSTEM WAS USED FOR FILED OBSERVATIONS.

	PAKISTAN WATER AND POWER DEVELOPMENT AUTHORITY HYDRO PLANNING ORGANIZATION			
PREPARED PROJECT	ATTABAD LAKE HPP			
CHSAN	FEASIBILITY STUDY REPORT			
DRAWN				
AMSHAD				
CHECKED				
PROJECT AREA				
TOPOGRAPHIC SURVEY				
(Sheet 1 of 20)				
APPROVED	DATE	SCALE	DWG No.	REVISIONS
Abid Sheikh	Jun: 2021	1 : 2,000	AFS-TS-202	

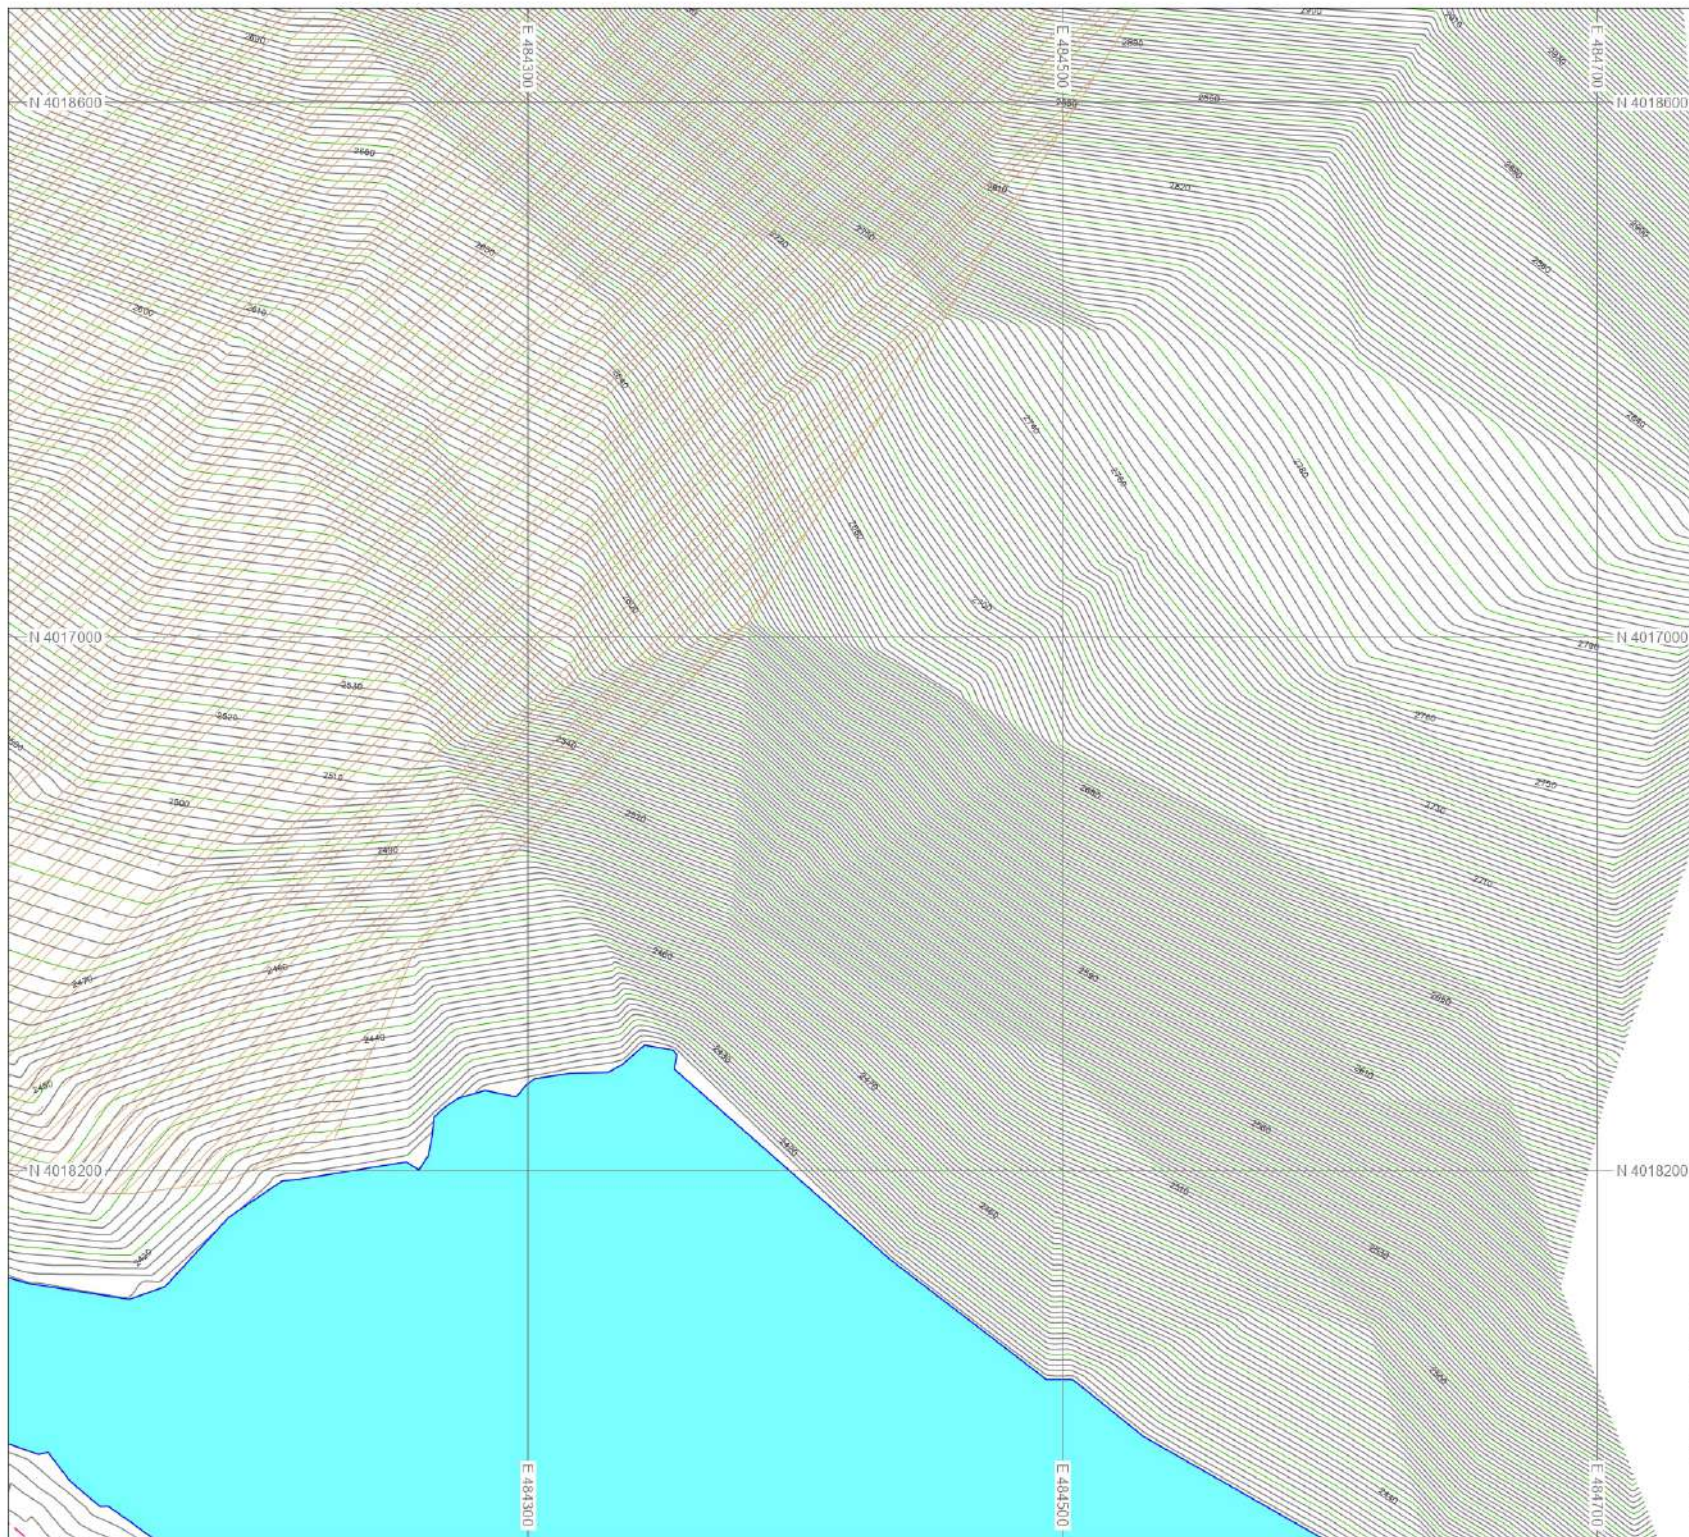

KEY PLAN

				4	1
	16	13	10	7	
	17	14	11	8	2
19	18	15	12	9	6
20					3

LEGENDS:

- RIVER/NALLA
- HOUSES/SHOPS
- ROADS
- KATCHA ROAD/TRACK
- CONTROL POINTS
- CONTOURS
- ELECTRIC POLE/T.POLE
- RETAINING WALL
- TREES AREA
- DRAIN AND NULLAH
- BRIDGE AND CULVERT
- BOULDERS
- WATER TANK
- SPRING
- JAMAT KHANA
- HFL
- HELIPAD
- SLIDING
- ROCK



NOTE

1. ALL THE UNITS ARE IN METERS UNLESS OTHERWISE NOTED
2. SURVEY OF PAKISTAN (SOP) METRIC COORDINATE SYSTEM WAS USED FOR FILED OBSERVATIONS.

PAKISTAN WATER AND POWER DEVELOPMENT AUTHORITY
HYDRO PLANNING ORGANIZATION

PREPARED PROJECT
ATTABAD LAKE HPP
FEASIBILITY STUDY REPORT

DRAWN TITLE
PROJECT AREA
TOPOGRAPHIC SURVEY
(Sheet 2 of 20)

APPROVED DATE SCALE DWG No. REVISIONS
Abid Sheikh Jun: 2021 1 : 2,000 AFS-TS-203




KEY PLAN

KEY PLAN						
	16	13	10	7	4	1
	17	14	11	8	5	2
19	18	15	12	9	6	3
20						

LEGENDS:


RIVER/NALLA	
HOUSES/SHOPS	
ROADS	
KATCHA ROAD/TRACK	
CONTROL POINTS	
CONTOURS	
ELECTRIC POLE/T.POLE	
RETAINING WALL	
TREES AREA	
DRAIN AND NULLAH	
BRIDGE AND CULVERT	
BOULDERS	
WATER TANK	
SPRING	
JAMAT KHANA	
HFL	
HELIPAD	
SLIDING	
ROCK	

 

NOTE:

1. ALL THE UNITS ARE IN METERS UNLESS OTHERWISE NOTED
2. SURVEY OF PAKISTAN (SOP) METRIC COORDINATE SYSTEM WAS USED FOR FIELD OBSERVATIONS.

	PAKISTAN WATER AND POWER DEVELOPMENT AUTHORITY HYDRO PLANNING ORGANIZATION			
PREPARED	PROJECT	ATTABAD LAKE HPP		
DRAWN	TITLE	FEASIBILITY STUDY REPORT		
Arshad		PROJECT AREA		
CHECKED		TOPOGRAPHIC SURVEY		
Ehsan		(Sheet 3 of 20)		
APPROVED	DATE	SCALE	DWG No.	REVISIONS
Abid Sheikh	Jun: 2021	1 : 2,000	AFS-TS-204	

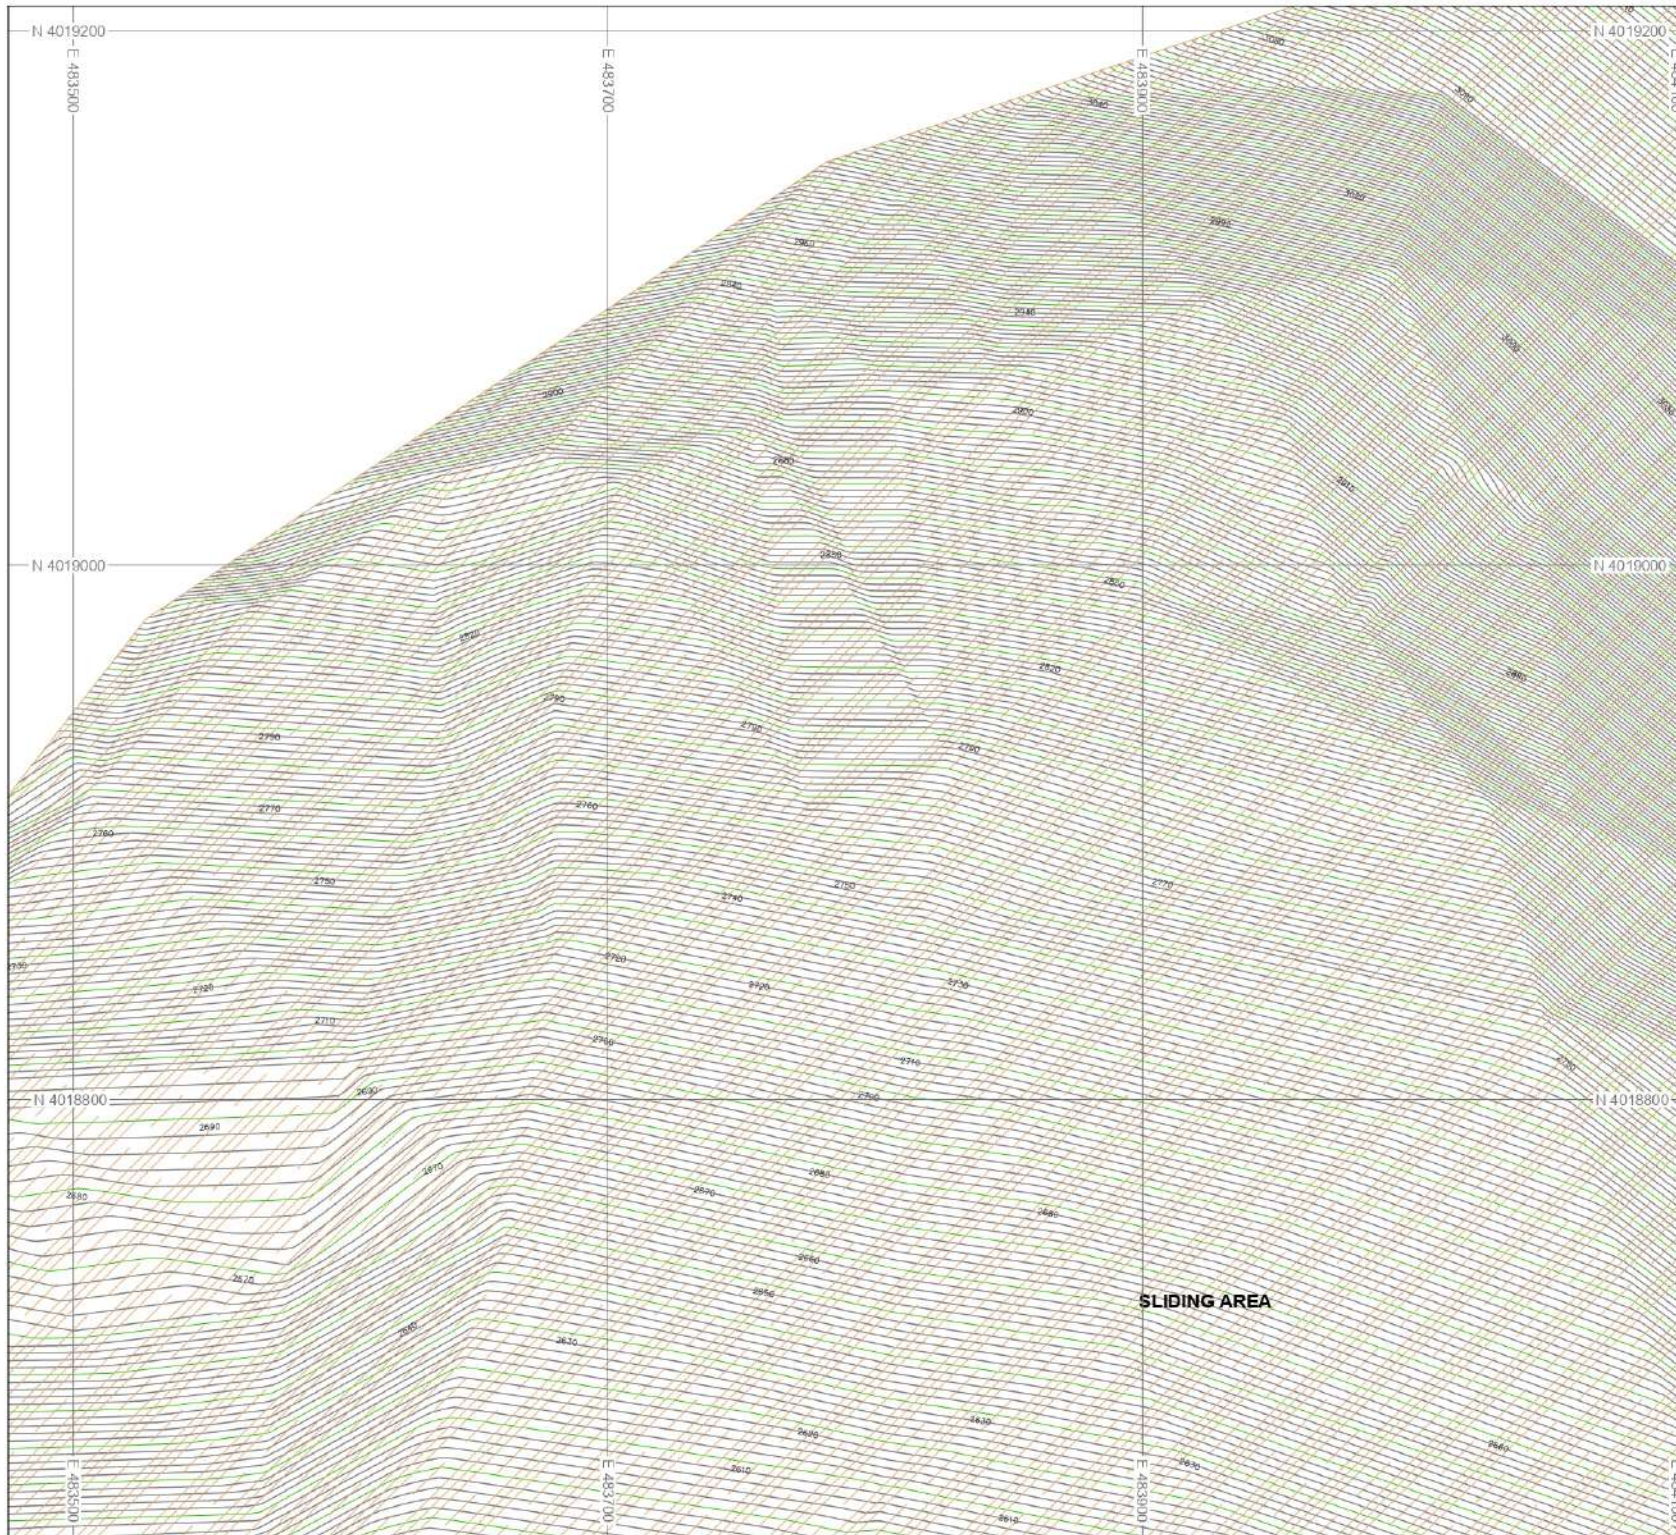

KEY PLAN

					4	1
	16	13	10	7	5	2
19	17	14	11	8	6	3
20	18	15	12	9		

LEGENDS:


- RIVER/NALLA
- HOUSES/SHOPS
- ROADS
- KATCHA ROAD/TRACK
- CONTROL POINTS
- CONTOURS
- ELECTRIC POLE/T.POLE
- RETAINING WALL
- TREES AREA
- DRAIN AND NULLAH
- BRIDGE AND CULVERT
- BOULDERS
- WATER TANK
- SPRING
- JAMAT KHANA
- HFL
- HELIPAD
- SLIDING
- ROCK



NOTE:

- ALL THE UNITS ARE IN METERS UNLESS OTHERWISE NOTED
- SURVEY OF PAKISTAN (SOP) METRIC COORDINATE SYSTEM WAS USED FOR FIELD OBSERVATIONS.

	PAKISTAN WATER AND POWER DEVELOPMENT AUTHORITY HYDRO PLANNING ORGANIZATION			
PREPARED	PROJECT	ATTABAD LAKE HPP		
Drawn	TITLE	FEASIBILITY STUDY REPORT		
Arshad	CHECKED	PROJECT AREA		
Ensan	APPROVED	TOPOGRAPHIC SURVEY		
Abid Sheikh	DATE	(Sheet 4 of 20)		
	Jun: 2021	SCALE	DWG No.	REVISIONS
		1 : 2,000	AFS-TS-205	

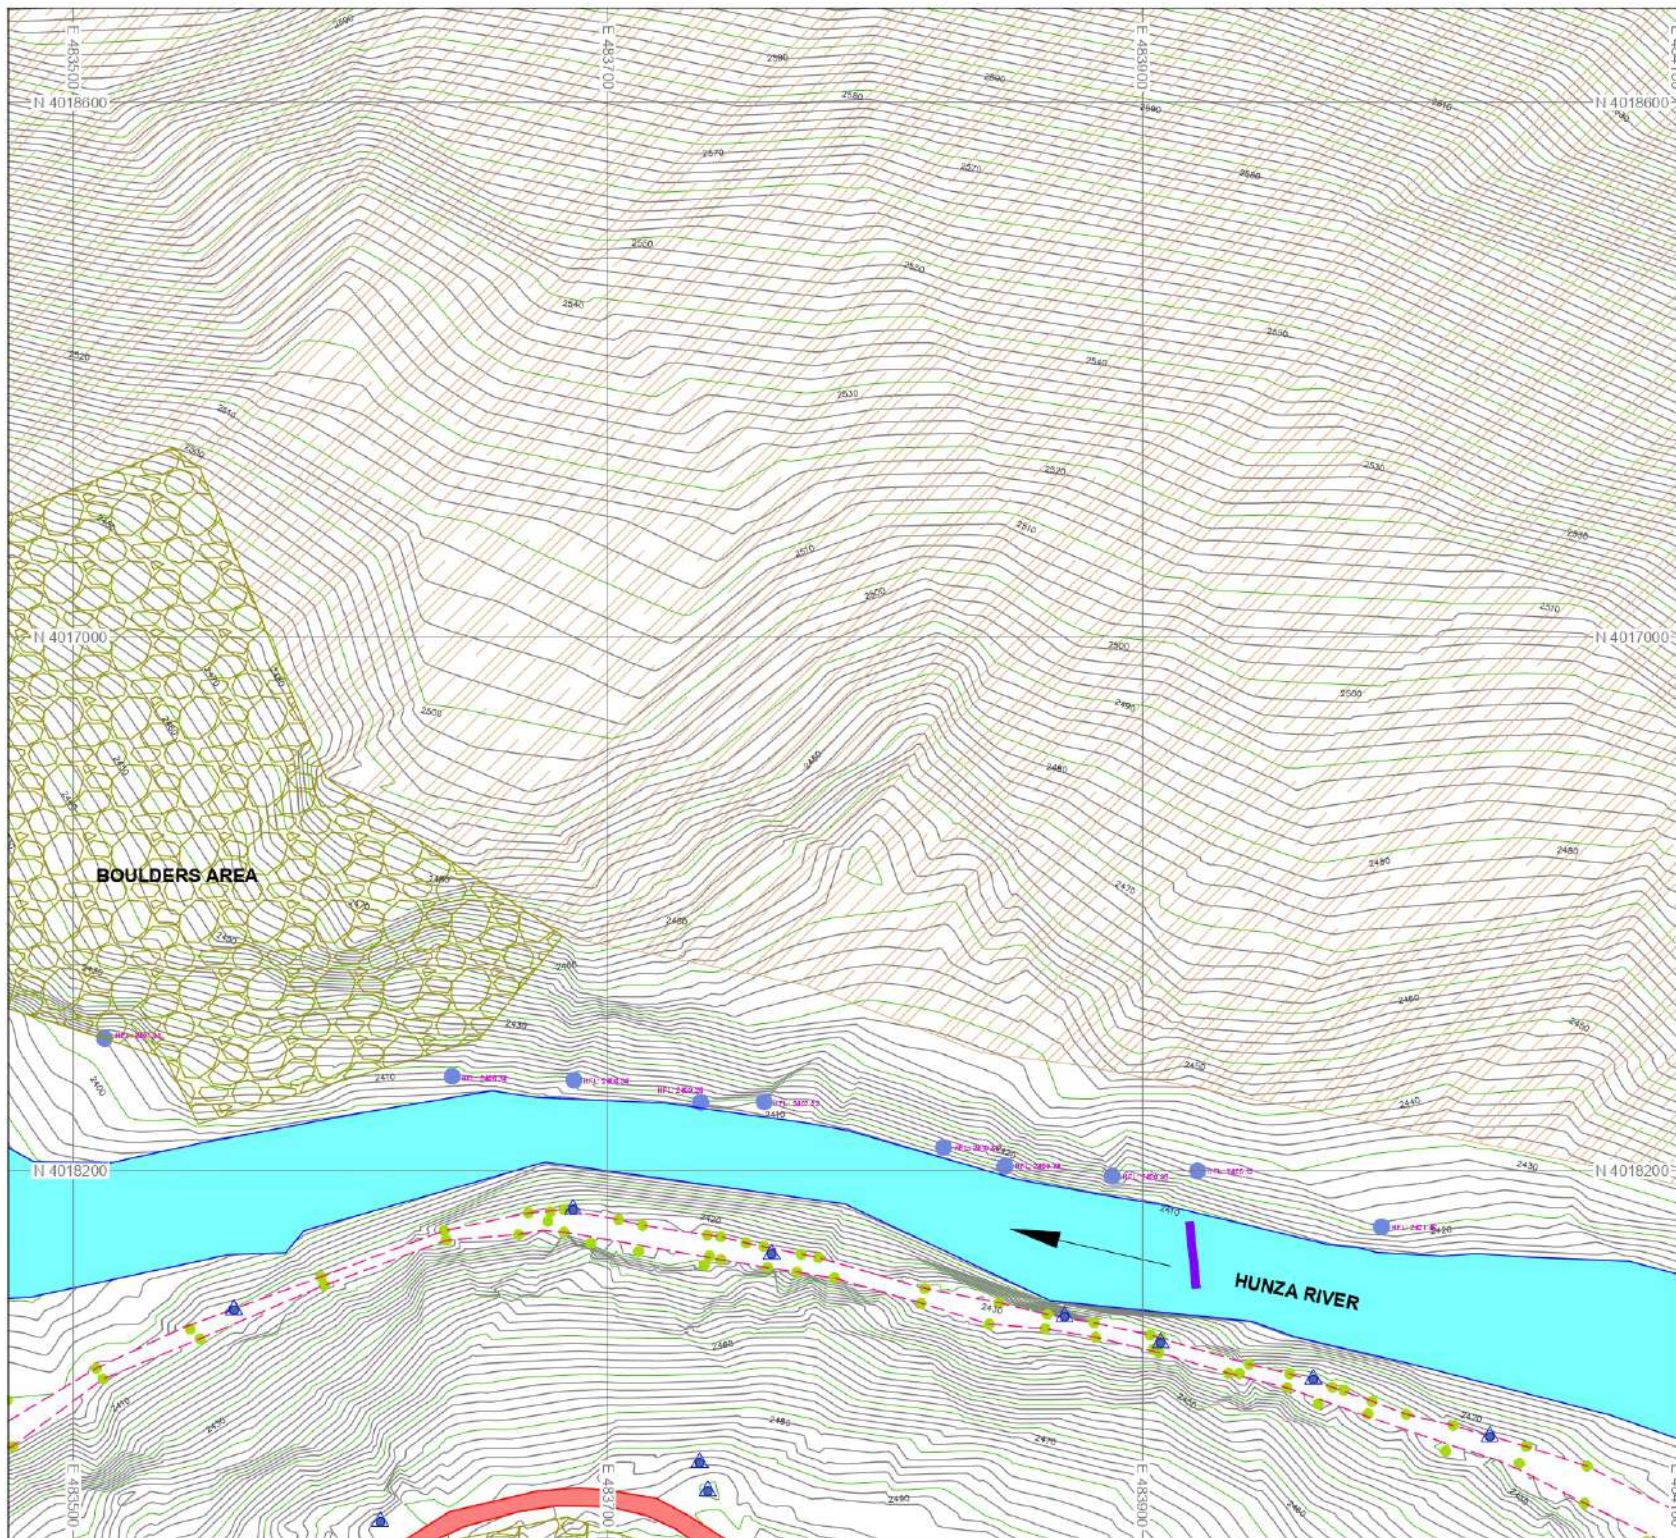

KEY PLAN

KEY PLAN							
						4	1
	16	13	10	7		5	
	17	14	11	8			2
19						6	3
20							

LEGENDS:

- RIVER/NALLA
- HOUSES/SHOPS
- ROADS
- KATCHA ROAD/TRACK
- CONTROL POINTS
- CONTOURS
- ELECTRIC POLE/T.POLE
- RETAINING WALL
- TREES AREA
- DRAIN AND NULLAH
- BRIDGE AND CULVERT
- BOULDERS
- WATER TANK
- SPRING
- JAMAT KHANA
- HFL
- HELIPAD
- SLIDING
- ROCK




NOTE:

1. ALL THE UNITS ARE IN METERS UNLESS OTHERWISE NOTED
2. SURVEY OF PAKISTAN (SOP) METRIC COORDINATE SYSTEM WAS USED FOR FIELD OBSERVATIONS.



PAKISTAN WATER AND POWER DEVELOPMENT AUTHORITY
HYDRO PLANNING ORGANIZATION

PREPARED	PROJECT	ATTABAD LAKE HPP	
Drawn	TITLE	FEASIBILITY STUDY REPORT	
Arshad		PROJECT AREA	
CHECKED		TOPOGRAPHIC SURVEY	
Ehsan		(Sheet 5 of 20)	
APPROVED	DATE	SCALE	DWG No.
Abid Sheikh	Jun: 2021	1 : 2,000	AFS-TS-206
		REVISIONS	

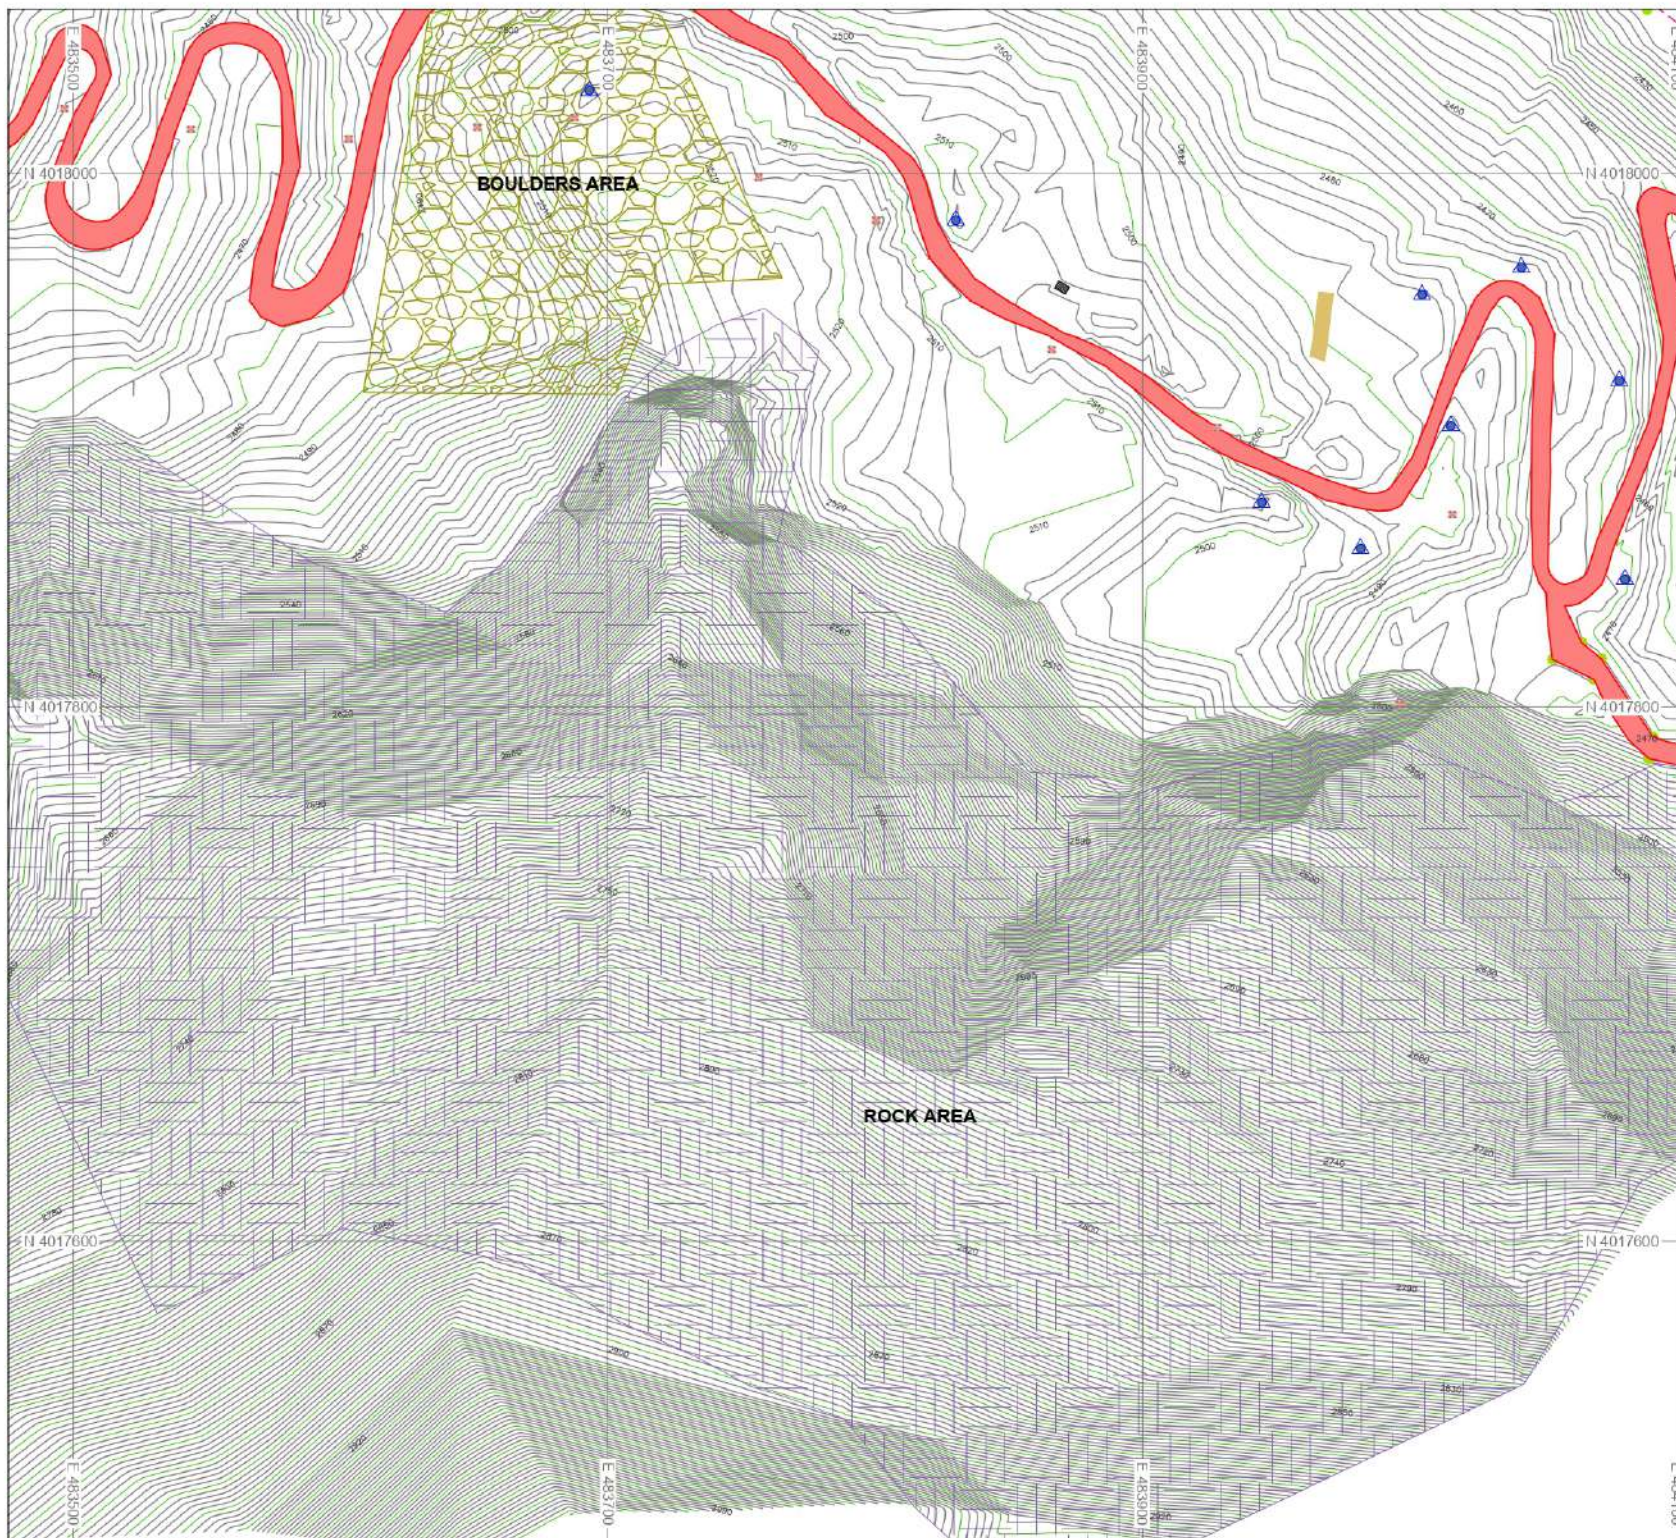

KEY PLAN

					4	1
	16	13	10	7	5	2
19	17	14	11	8	6	3
20	18	15	12	9		

LEGENDS:

- RIVER/NALLA
- HOUSES/SHOPS
- ROADS
- KATCHA ROAD/TRACK
- CONTROL POINTS
- CONTOURS
- ELECTRIC POLE/T.POLE
- RETAINING WALL
- TREES AREA
- DRAIN AND NULLAH
- BRIDGE AND CULVERT
- BOULDERS
- WATER TANK
- SPRING
- JAMAT KHANA
- HFL
- HELIPAD
- SLIDING
- ROCK



NOTE:

1. ALL THE UNITS ARE IN METERS UNLESS OTHERWISE NOTED
2. SURVEY OF PAKISTAN (SOP) METRIC COORDINATE SYSTEM WAS USED FOR FIELD OBSERVATIONS.



PAKISTAN WATER AND POWER DEVELOPMENT AUTHORITY
HYDRO PLANNING ORGANIZATION

PREPARED

PROJECT

ATTABAD LAKE HPP
FEASIBILITY STUDY REPORT

DRAWN

TITLE

PROJECT AREA
TOPOGRAPHIC SURVEY
(Sheet 6 of 20)

CHECKED

DATE

SCALE

DWG No.

REVISIONS

APPROVED

DATE

SCALE

DWG No.


REVISIONS

Abid Sheikh

Jun: 2021

1 : 2,000

AFS-TS-207

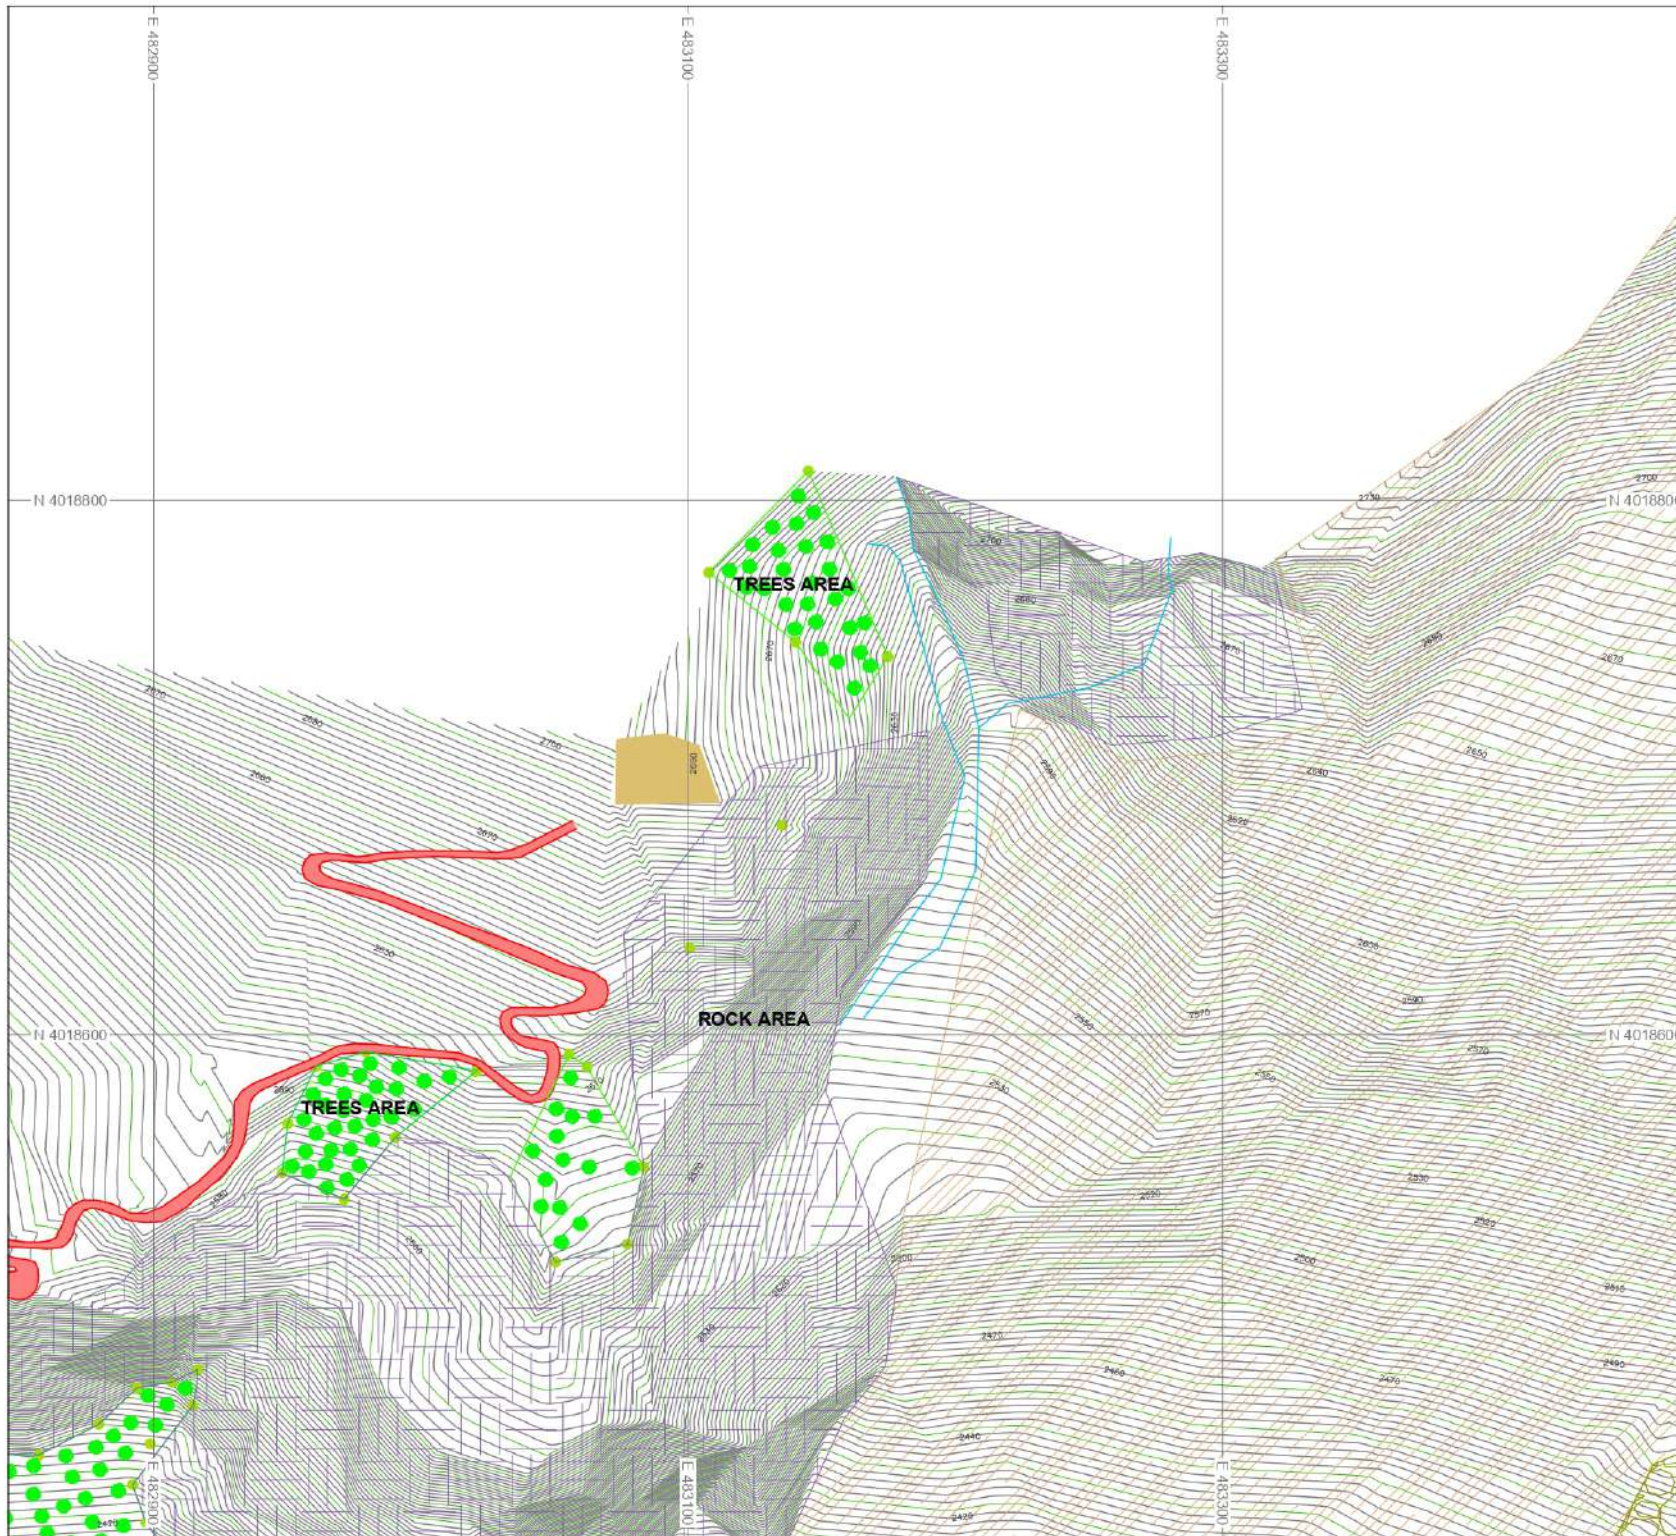

KEY PLAN

	16	13	10	7	4	1
	17	14	11	8	5	2
19	18	15	12	9	6	3
20						

LEGENDS:

RIVER/NALLA
 HOUSES/SHOPS
 ROADS
 KATCHA ROAD/TRACK
 CONTROL POINTS
 CONTOURS
 ELECTRIC POLE/T.POLE
 RETAINING WALL
 TREES AREA
 DRAIN AND NULLAH
 BRIDGE AND CULVERT
 BOULDERS
 WATER TANK
 SPRING
 JAMAT KHANA
 HFL
 HELIPAD
 SLIDING
 ROCK



NOTE:

1. ALL THE UNITS ARE IN METERS UNLESS OTHERWISE NOTED
2. SURVEY OF PAKISTAN (SOP) METRIC COORDINATE SYSTEM WAS USED FOR FIELD OBSERVATIONS.



PAKISTAN WATER AND POWER DEVELOPMENT AUTHORITY
HYDRO PLANNING ORGANIZATION

PREPARED PROJECT

ATTABAD LAKE HPP
FEASIBILITY STUDY REPORT

ENSAH

DRAWN

ARSHAD

CHECKED

ENSAH

APPROVED

ABID SHEIKH

DATE

JUN: 2021

SCALE


1 : 2,000

DWG No.

AFS-TS-208

REVISIONS

PROJECT AREA
TOPOGRAPHIC SURVEY
 (Sheet 7 of 20)

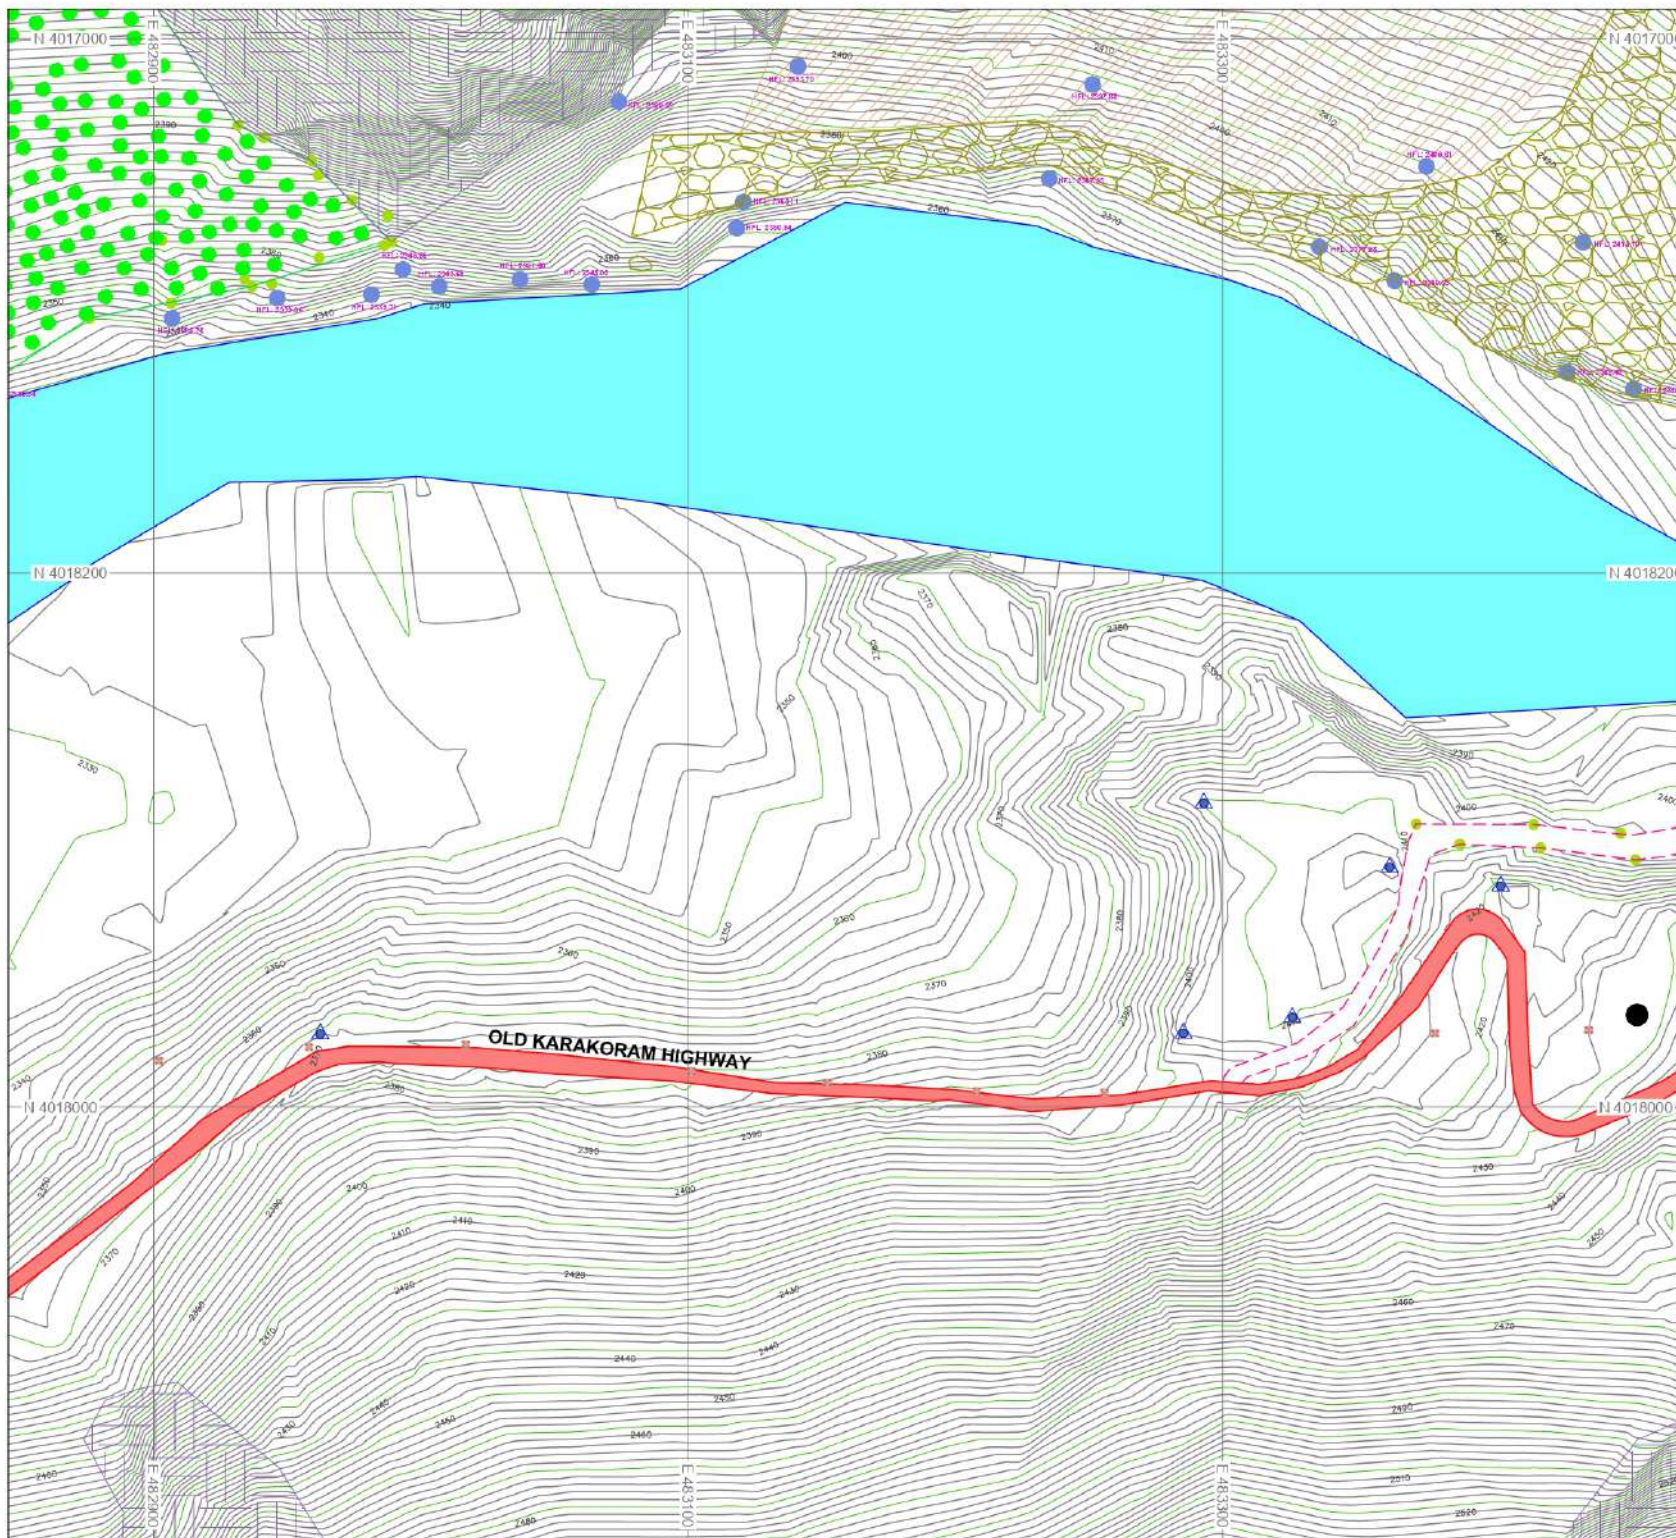

KEY PLAN

				4	1
	16	13	10	7	5
19	17	14	11	8	6
20	18	15	12	9	3


LEGENDS:

RIVER/NALLA	
HOUSES/SHOPS	
ROADS	
KATCHA ROAD/TRACK	
CONTROL POINTS	
CONTOURS	
ELECTRIC POLE/T.POLE	
RETAINING WALL	
TREES AREA	
DRAIN AND NULLAH	
BRIDGE AND CULVERT	
BOULDERS	
WATER TANK	
SPRING	
JAMAT KHANA	
HFL	
HELIPAD	
SLIDING	
ROCK	



NOTE:
 1. ALL THE UNITS ARE IN METERS UNLESS OTHERWISE NOTED
 2. SURVEY OF PAKISTAN (SOP) METRIC COORDINATE SYSTEM WAS USED FOR FIELD OBSERVATIONS.

	PAKISTAN WATER AND POWER DEVELOPMENT AUTHORITY HYDRO PLANNING ORGANIZATION			
PREPARED	PROJECT	ATTABAD LAKE HPP FEASIBILITY STUDY REPORT		
DRAWN	TITLE	PROJECT AREA TOPOGRAPHIC SURVEY (Sheet 8 of 20)		
CHECKED	DATE	SCALE	DWG No.	REVISIONS
APPROVED	Jun: 2021	1 : 2,000	AFS-TS-209	

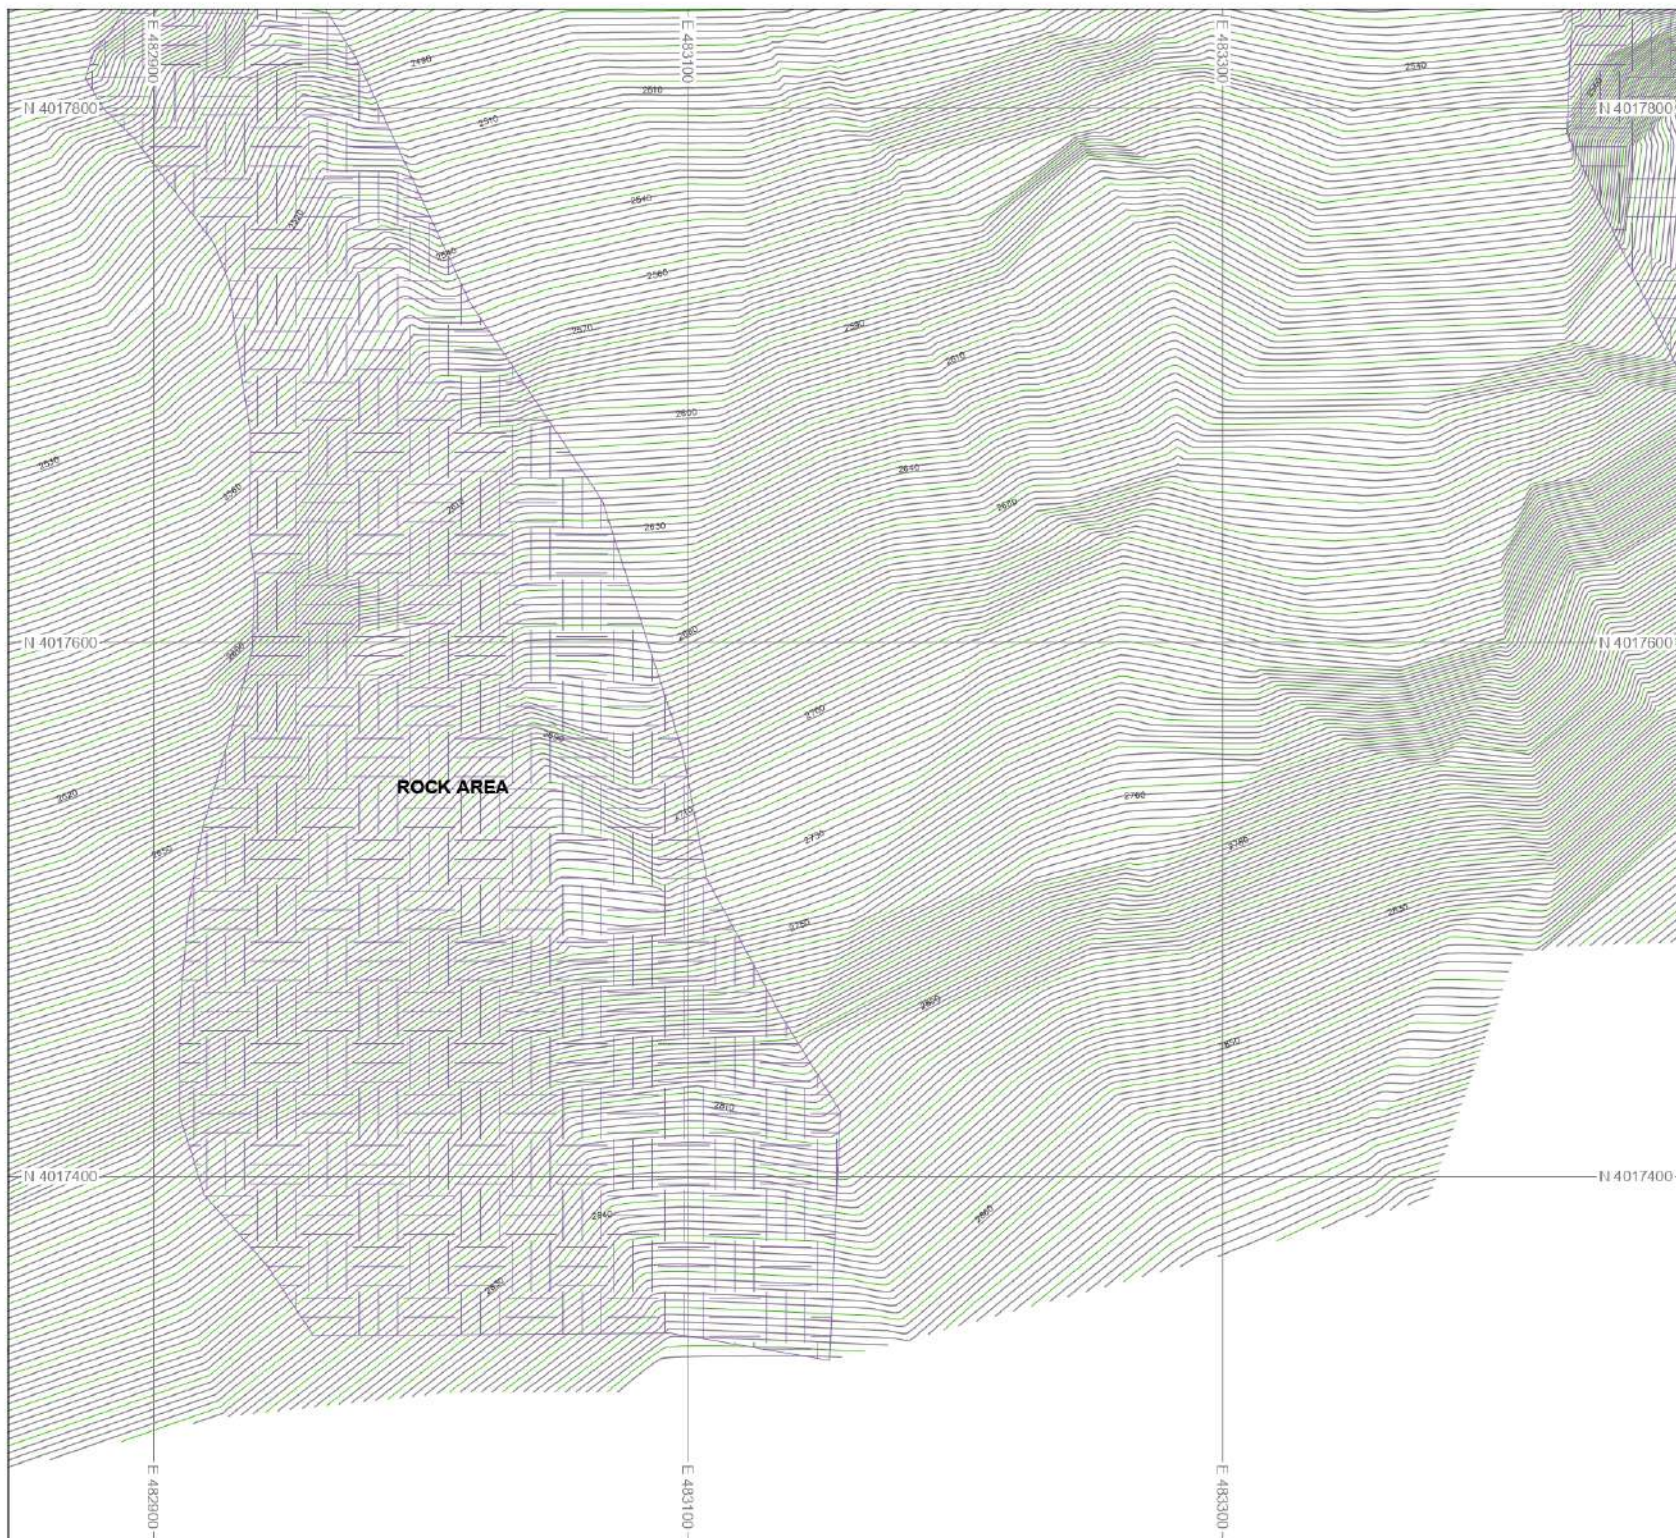

KEY PLAN

KEY PLAN						
	16	13	10	7	4	1
	17	14	11	8	5	2
19	18	15	12	9	6	3
20						

LEGENDS:

- RIVER/NALLA
- HOUSES/SHOPS
- ROADS
- KATCHA ROAD/TRACK
- CONTROL POINTS
- CONTOURS
- ELECTRIC POLE/T.POLE
- RETAINING WALL
- TREES AREA
- DRAIN AND NULLAH
- BRIDGE AND CULVERT
- BOULDERS
- WATER TANK
- SPRING
- JAMAT KHANA
- HFL
- HELIPAD
- SLIDING
- ROCK



NOTE:

1. ALL THE UNITS ARE IN METERS UNLESS OTHERWISE NOTED
2. SURVEY OF PAKISTAN (SOP) METRIC COORDINATE SYSTEM WAS USED FOR FIELD OBSERVATIONS.



PAKISTAN WATER AND POWER DEVELOPMENT AUTHORITY
HYDRO PLANNING ORGANIZATION

PREPARED

PROJECT

ATTABAD LAKE HPP
FEASIBILITY STUDY REPORT

DRAWN

TITLE

PROJECT AREA
TOPOGRAPHIC SURVEY
(Sheet 9 of 20)

CHECKED

DATE

SCALE

DWG No.

REVISIONS

APPROVED

DATE

SCALE


DWG No.

Abid Sheikh

Jun: 2021

1 : 2,000

AFS-TS-210

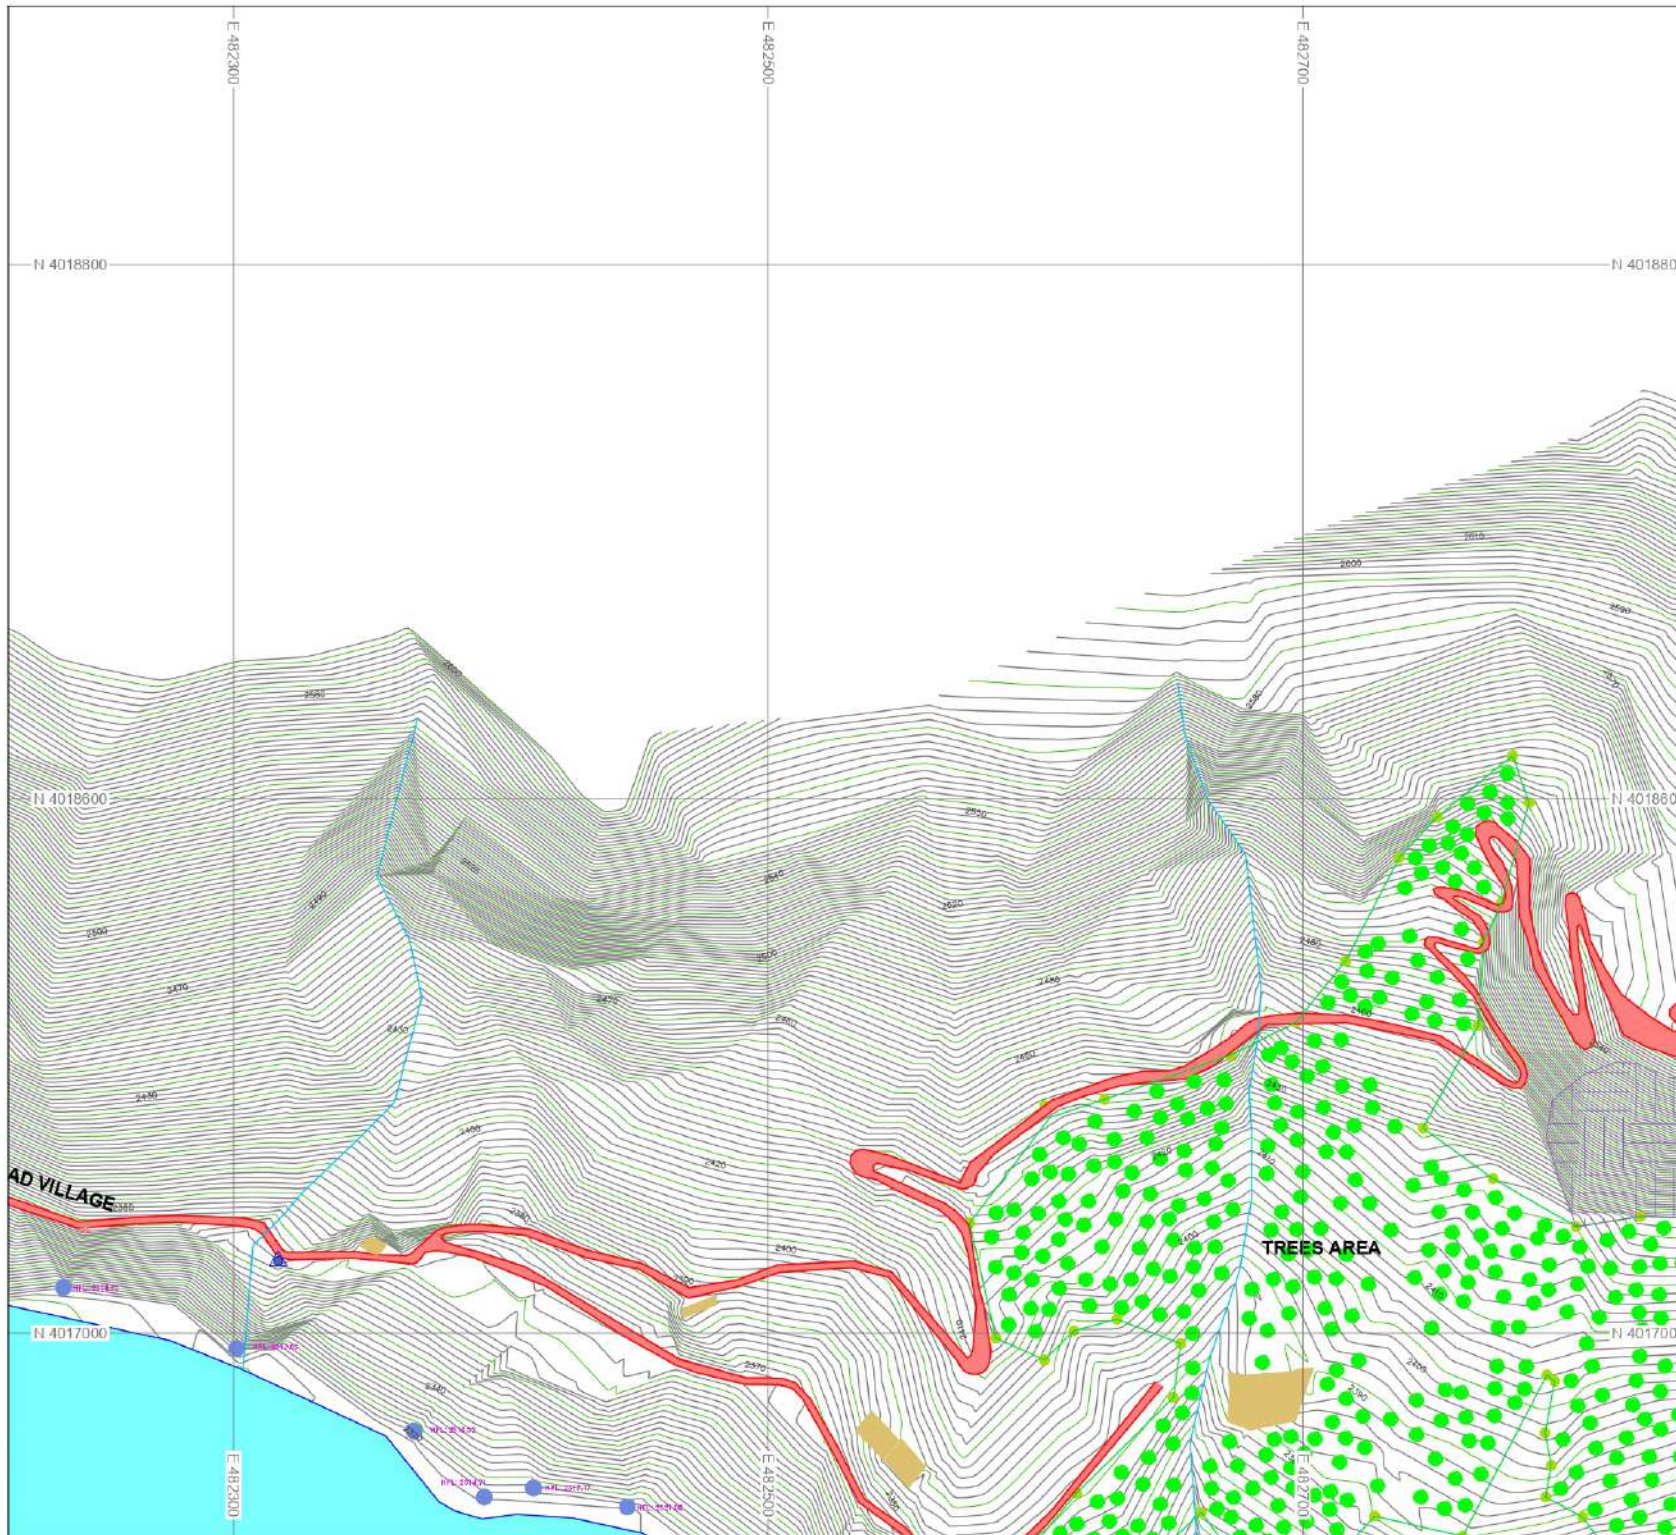

KEY PLAN

KEY PLAN						
	16	13	10	7	4	1
	17	14	11	8	5	2
19	18	15	12	9	6	3
20						

LEGENDS:

- RIVER/NALLA
- HOUSES/SHOPS
- ROADS
- KATCHA ROAD/TRACK
- CONTROL POINTS
- CONTOURS
- ELECTRIC POLE/T.POLE
- RETAINING WALL
- TREES AREA
- DRAIN AND NULLAH
- BRIDGE AND CULVERT
- BOULDERS
- WATER TANK
- SPRING
- JAMAT KHANA
- HFL
- HELIPAD
- SLIDING
- ROCK



NOTE:

1. ALL THE UNITS ARE IN METERS UNLESS OTHERWISE NOTED
2. SURVEY OF PAKISTAN (SOP) METRIC COORDINATE SYSTEM WAS USED FOR FIELD OBSERVATIONS.



PAKISTAN WATER AND POWER DEVELOPMENT AUTHORITY
HYDRO PLANNING ORGANIZATION

PREPARED

PROJECT

ATTABAD LAKE HPP
FEASIBILITY STUDY REPORT

DRAWN

TITLE

CHECKED

DATE

PROJECT AREA
TOPOGRAPHIC SURVEY
(Sheet 10 of 20)

APPROVED

DATE

SCALE

DWG No.


REVISIONS

Abid Sheikh

Jun: 2021

1 : 2,000

AFS-TS-211

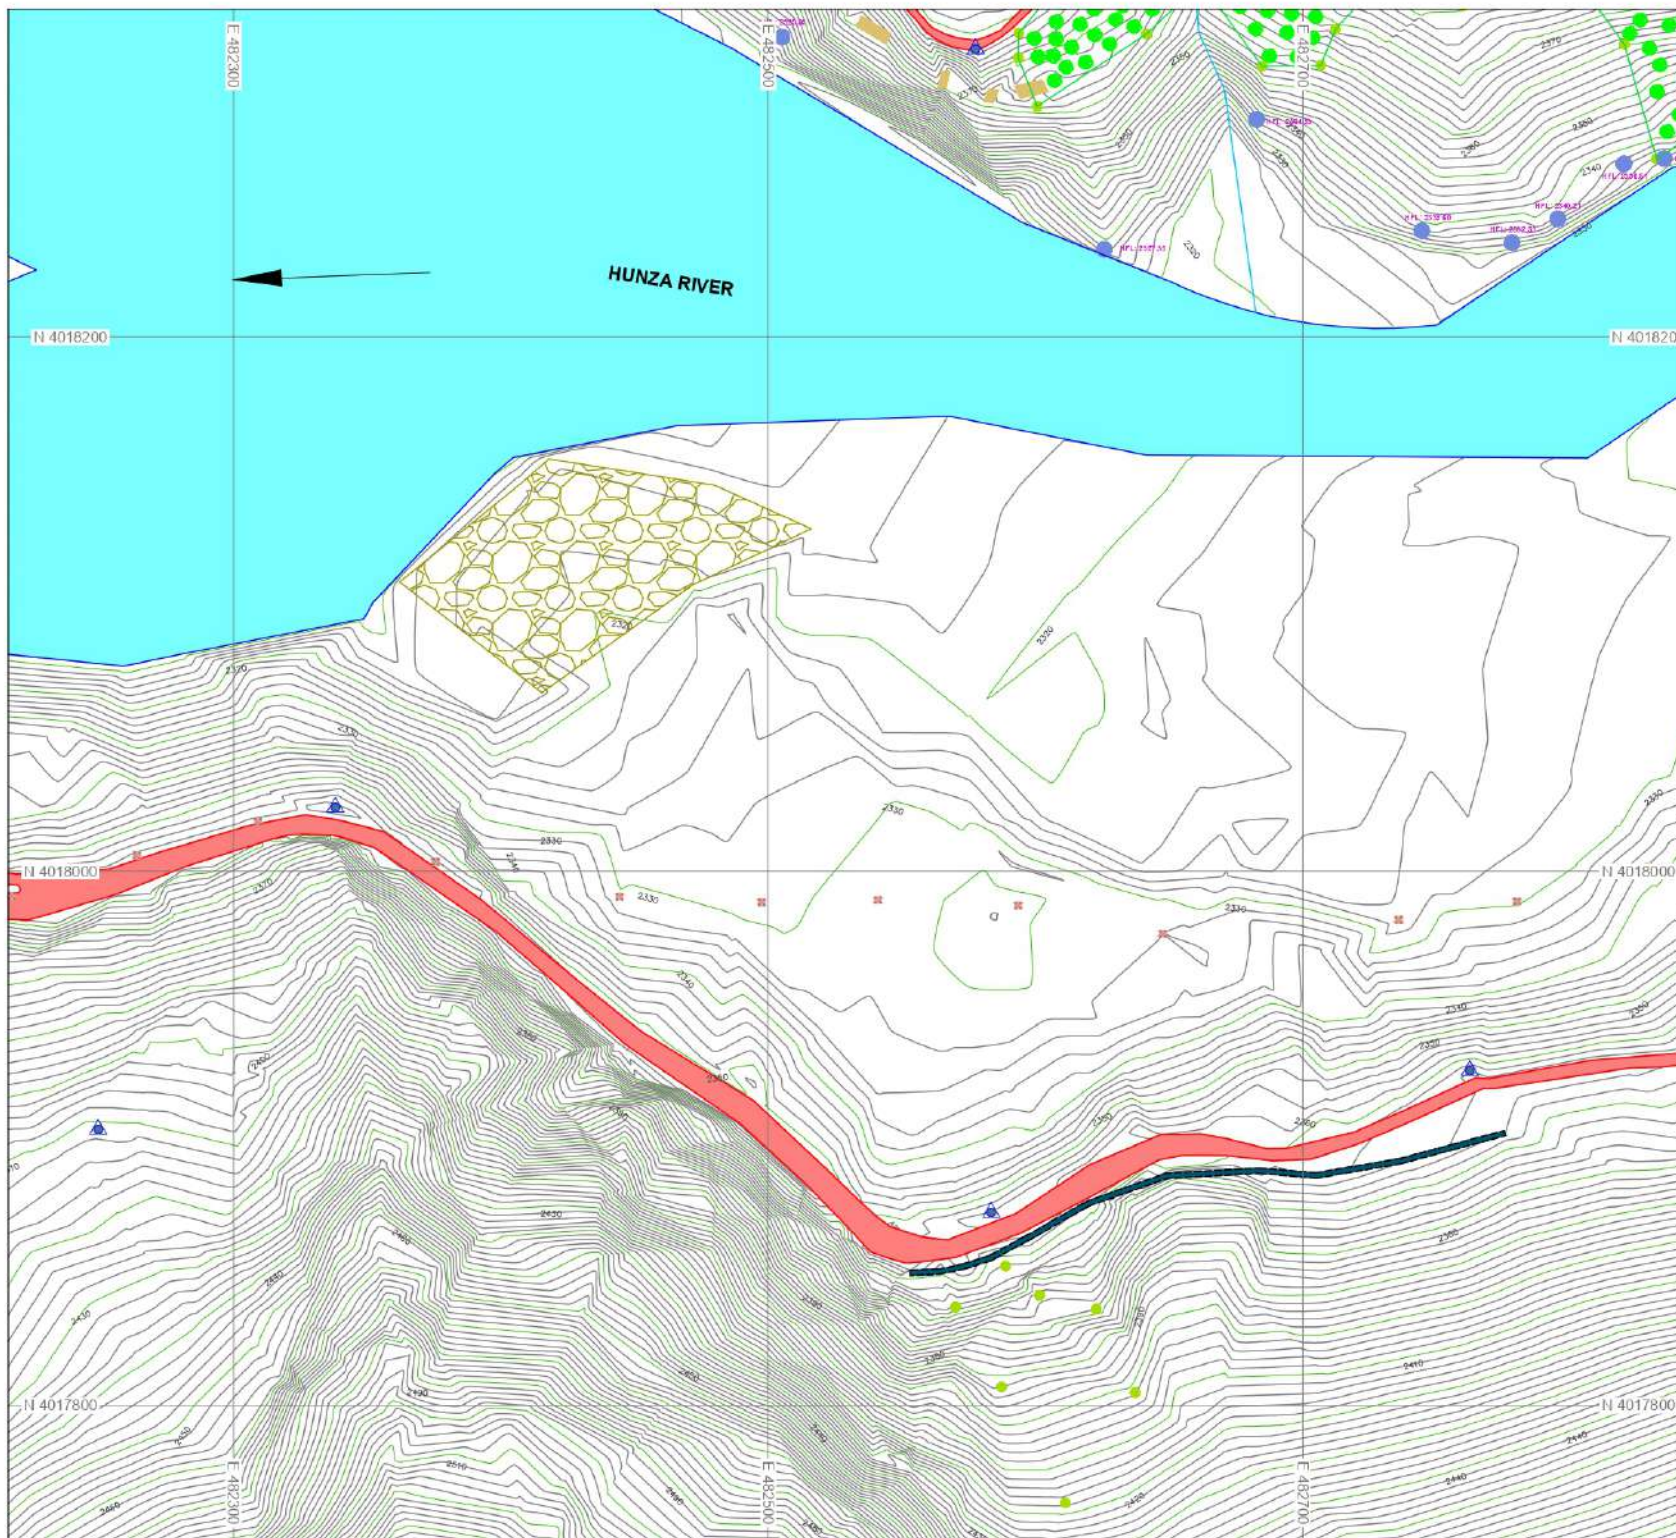


KEY PLAN

KEY PLAN						
	16	13	10	7	4	1
	17	14	11	8	5	2
19	18	15	12	9	6	3
20						

LEGENDS:

 - RIVER/NALLA
- HOUSES/SHOPS
- ROADS
- KATCHA ROAD/TRACK
- CONTROL POINTS
- CONTOURS
- ELECTRIC POLE/T.POLE
- RETAINING WALL
- TREES AREA
- DRAIN AND NULLAH
- BRIDGE AND CULVERT
- BOULDERS
- WATER TANK
- SPRING
- JAMAT KHANA
- HFL
- HELIPAD
- SLIDING
- ROCK



NOTE:

1. ALL THE UNITS ARE IN METERS UNLESS OTHERWISE NOTED
2. SURVEY OF PAKISTAN (SOP) METRIC COORDINATE SYSTEM WAS USED FOR FIELD OBSERVATIONS.



PAKISTAN WATER AND POWER DEVELOPMENT AUTHORITY
HYDRO PLANNING ORGANIZATION

PREPARED	PROJECT	ATTABAD LAKE HPP	
Ensan		FEASIBILITY STUDY REPORT	
DRAWN	TITLE	PROJECT AREA	
Arshad		TOPOGRAPHIC SURVEY	
CHECKED		(Sheet 11 of 20)	
Ensan	DATE	SCALE	DWG No.
Abid Sheikh	Jun: 2021	1 : 2,000	AFS-TS-212
		REVISIONS	