


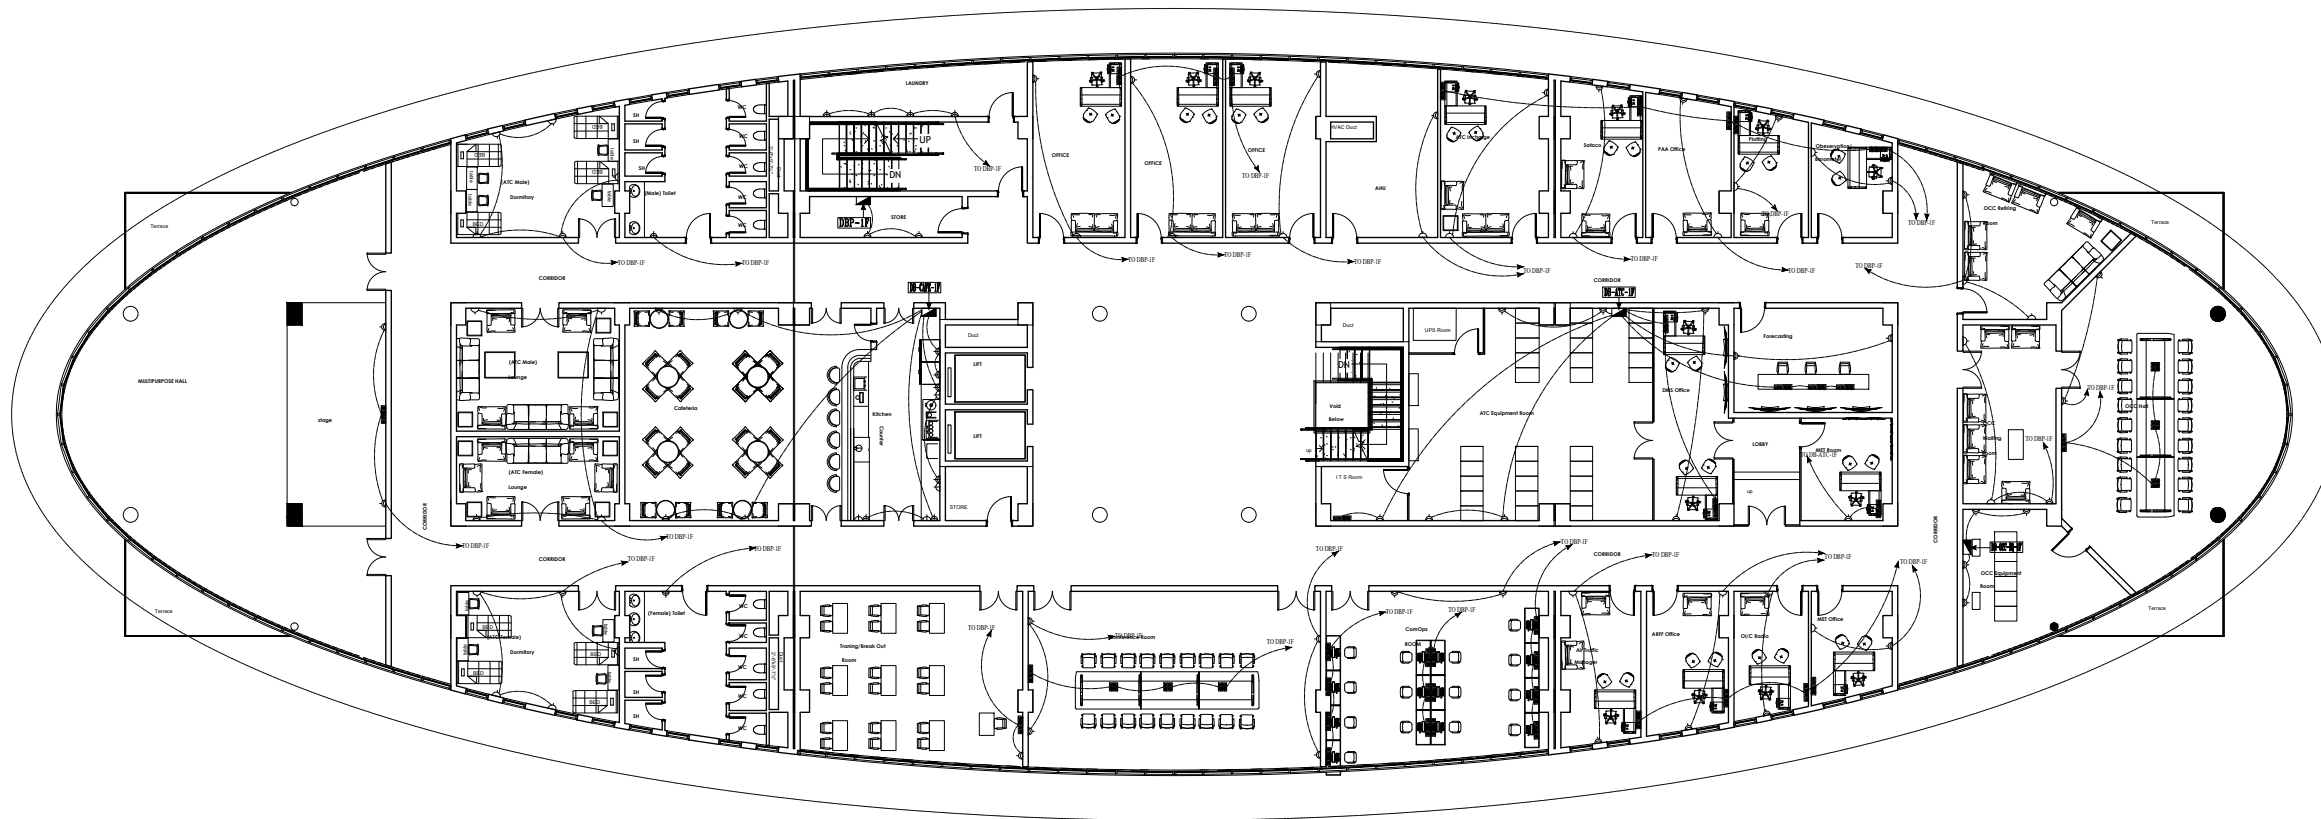

FIRST FLOOR PLAN

NOTES:

This drawing is confidential and is the exclusive property of AAA (Pvt)Ltd.and is loaned subject to the condition that it is not to be reproduced or used to furnish for the making of drawing or prints except as sanctioned in writing by AAA (Pvt)Ltd.

CLIENT NAME

C:\Users\Devi\Downloads\WhatsApp Image 2025-10-15 at 12.12.04 PM.png

MAIN CONSULTANT


Anwar Ali Architects (Pvt.) Ltd.
Consulting,Architects,Engineers
Planners & Management Consultants
06 HBFC BLOCK A FAISAL TOWN LAHORE

JV MEMBERS

C:\Users\Devi\Downloads\WhatsApp Image 2025-10-15 at 12.12.03 PM.png

STRUCTURAL CONSULTANT


AR ENGINEERS
Architects, Structural, Earthquake Engineering, Geo Technical, Public Health,
Highway, Electrical Design Solution.
Office # 4, 2nd Floor,Sultana Arcade Firdous Market, Gulberg-II, Lahore.
Ph: 042-35631906 03008813921, E-mail: arengineers786@gmail.com

MEP CONSULTANT


ABSTRACTORS
MEP CONSULTANT
SUITE-14,3RD FLOOR JINNAH MALL QZMIR TOWN, LHR
Cell no: 0322-3924199
E-mail: abstractorseng@gmail.com

Project Name


Consultancy Services for
New Air Traffic Control Tower
(ATCT), Fire Station and Allied
Facilities at Skardu
International Airport

**DETAILED ELECTRICAL
Design Drawings**

Sheet Name

POWER SOCKETS LAYOUT

Date	April, 2026
Scale	NTS
Drawn by	A.S.B
Checked by	M.K
Approved by	M.F
Drawing No.	E-21

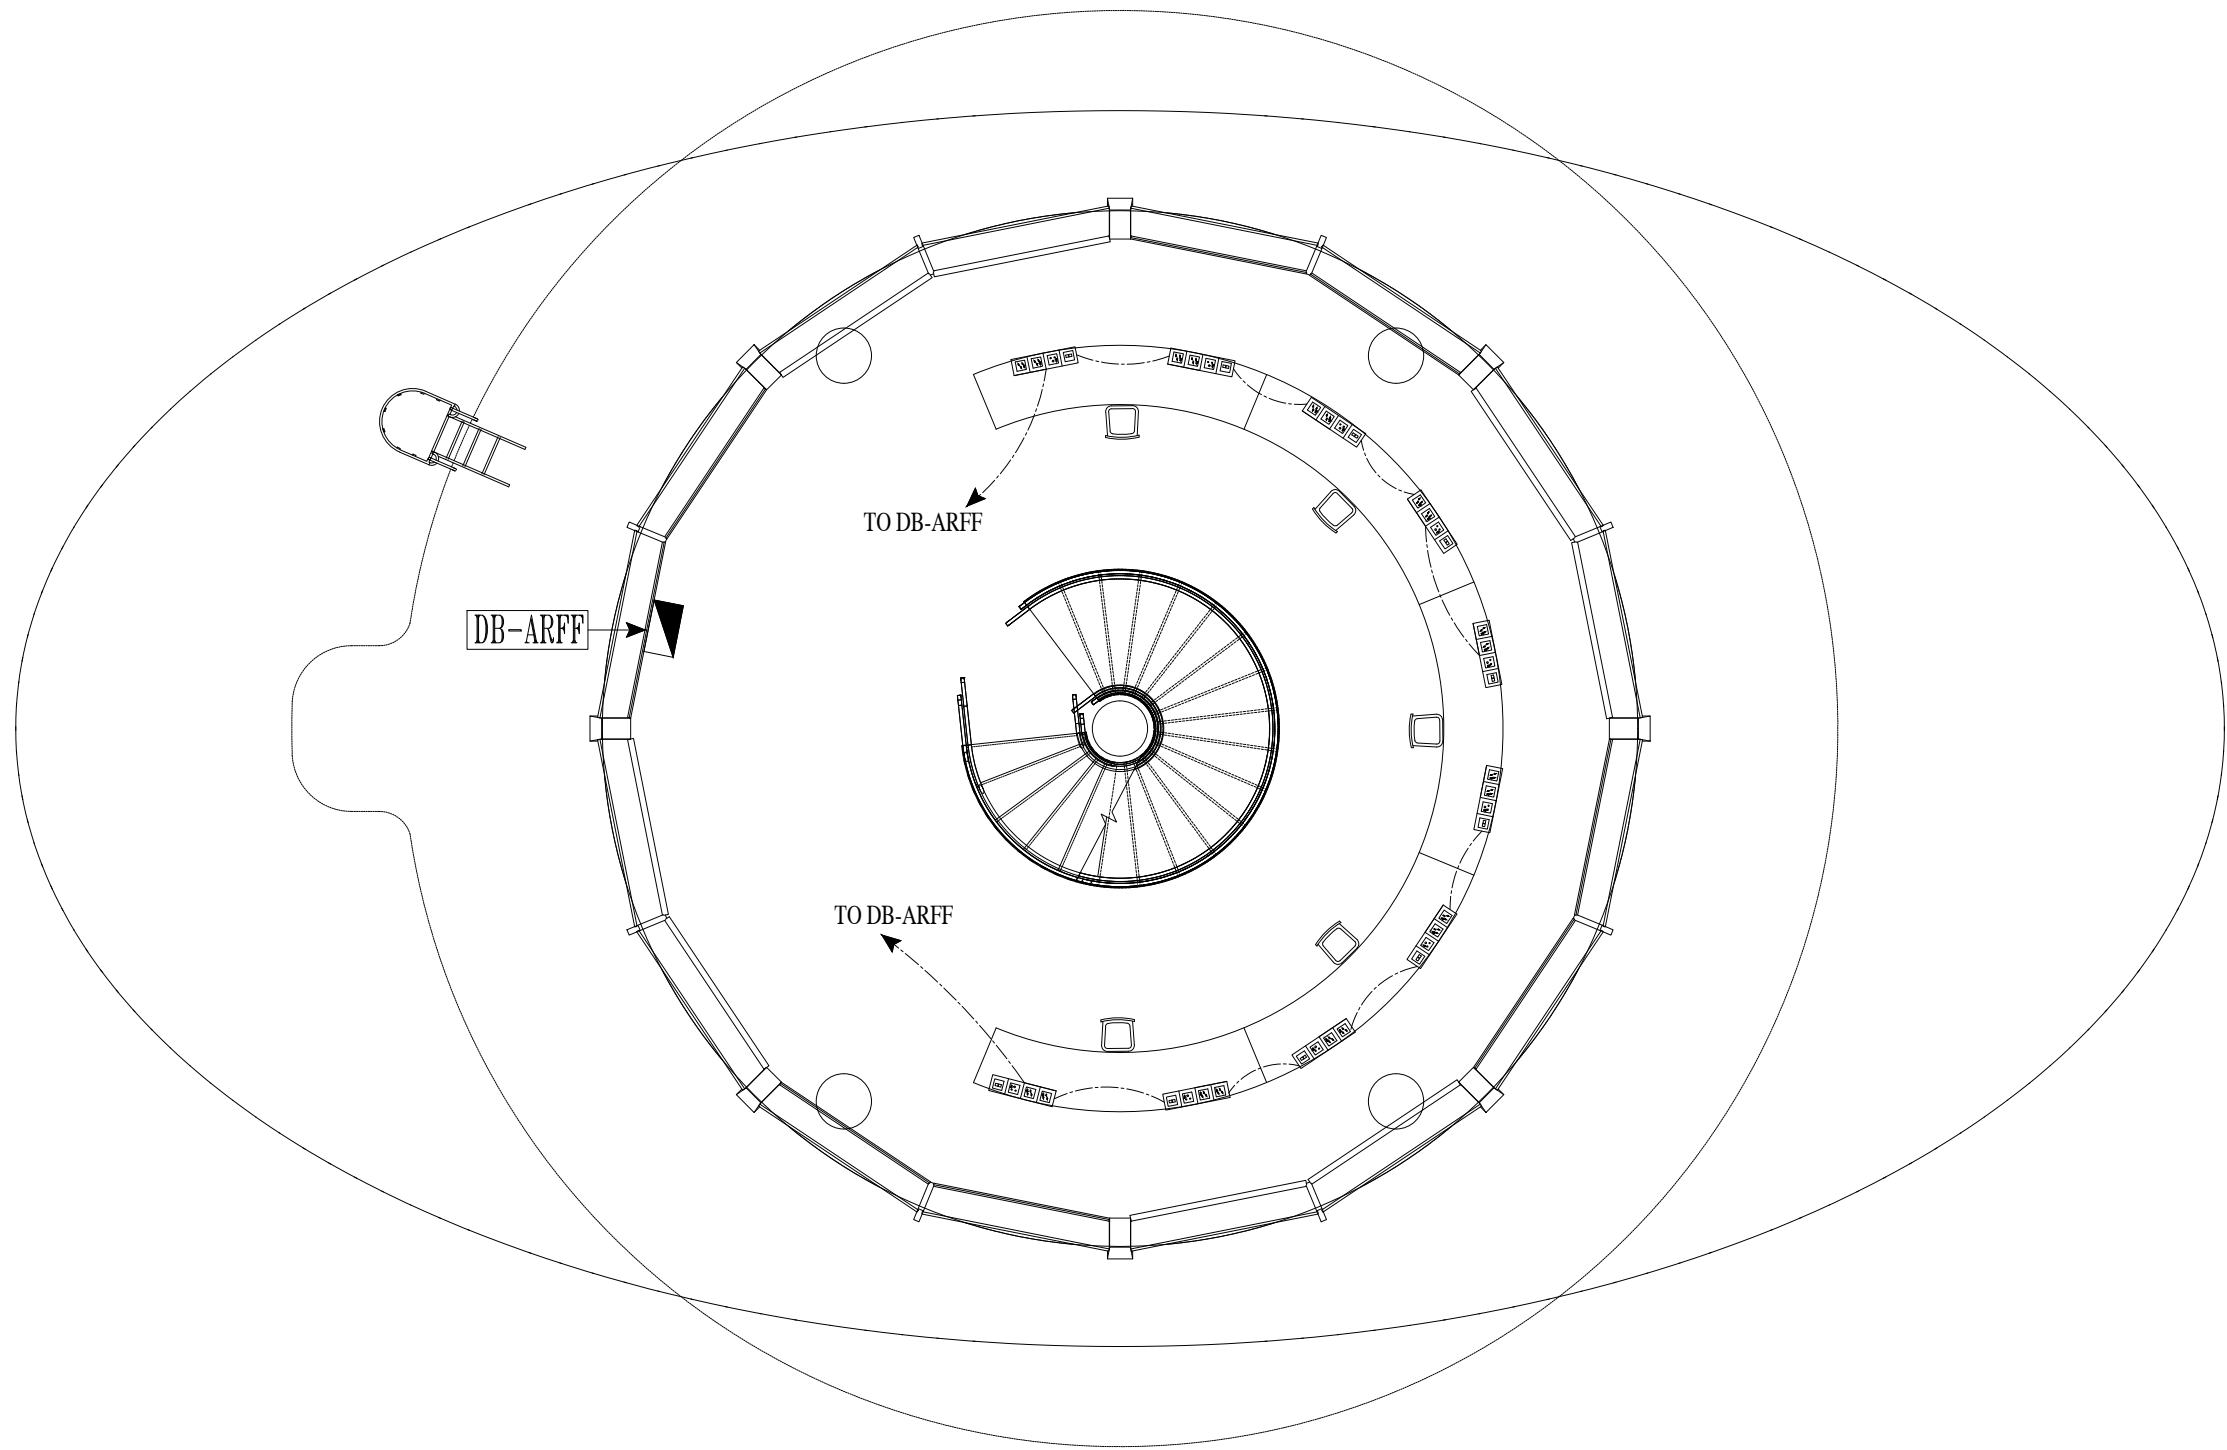

ARFF FLOOR PLAN LEVEL AT 53'-6"
COVERED AREA 2123 Sft

NOTES:
This drawing is confidential and is the exclusive property of AAA (Pvt)Ltd.and is loaned subject to the condition that it is not to be reproduced or used to furnish for the making of drawing or prints except as sanctioned in writing by AAA (Pvt)Ltd.

CLIENT NAME

C:\Users\Devl\Downloads\WhatsApp Image 2025-10-15 at 12.12.04 PM.png

MAIN CONSULTANT


Anwar Ali Architects (Pvt.) Ltd.
Consulting,Architects,Engineers
Planners & Management Consultants
06 HBFC BLOCK A FAISAL TOWN LAHORE

JV MEMBERS

C:\Users\Devl\Downloads\WhatsApp Image 2025-10-15 at 12.12.03 PM.png

STRUCTURAL CONSULTANT

 **AR ENGINEERS**
Architects, Structural, Earthquake Engineering, Geo Technical, Public Health,
Highway, Electrical Design Solution.
Office # 4, 2nd Floor,Sultana Arcade Firdous Market, Gulberg-III, Lahore.
Ph: 042-35831908 03008813921, E-mail: arengineers78@gmail.com


MEP CONSULTANT

 **ABSTRACTORS**
MEP CONSULTANT
SUITE-14,3RD FLOOR JINNAH MALL QZMIR TOWN, LHR
Cell no: 0322-3924199
E-mail: abstractorseng@gmail.com

Project Name
Consultancy Services for
New Air Traffic Control Tower
(ATCT), Fire Station and Allied
Facilities at Skardu
International Airport

**DETAILED ELECTRICAL
Design Drawings**

Sheet Name	
POWER SOCKETS LAYOUT	
Date	April, 2026
Scale	NTS
Drawn by	A.S.B
Checked by	M.K
Approved by	M.F
Drawing No.	E-22

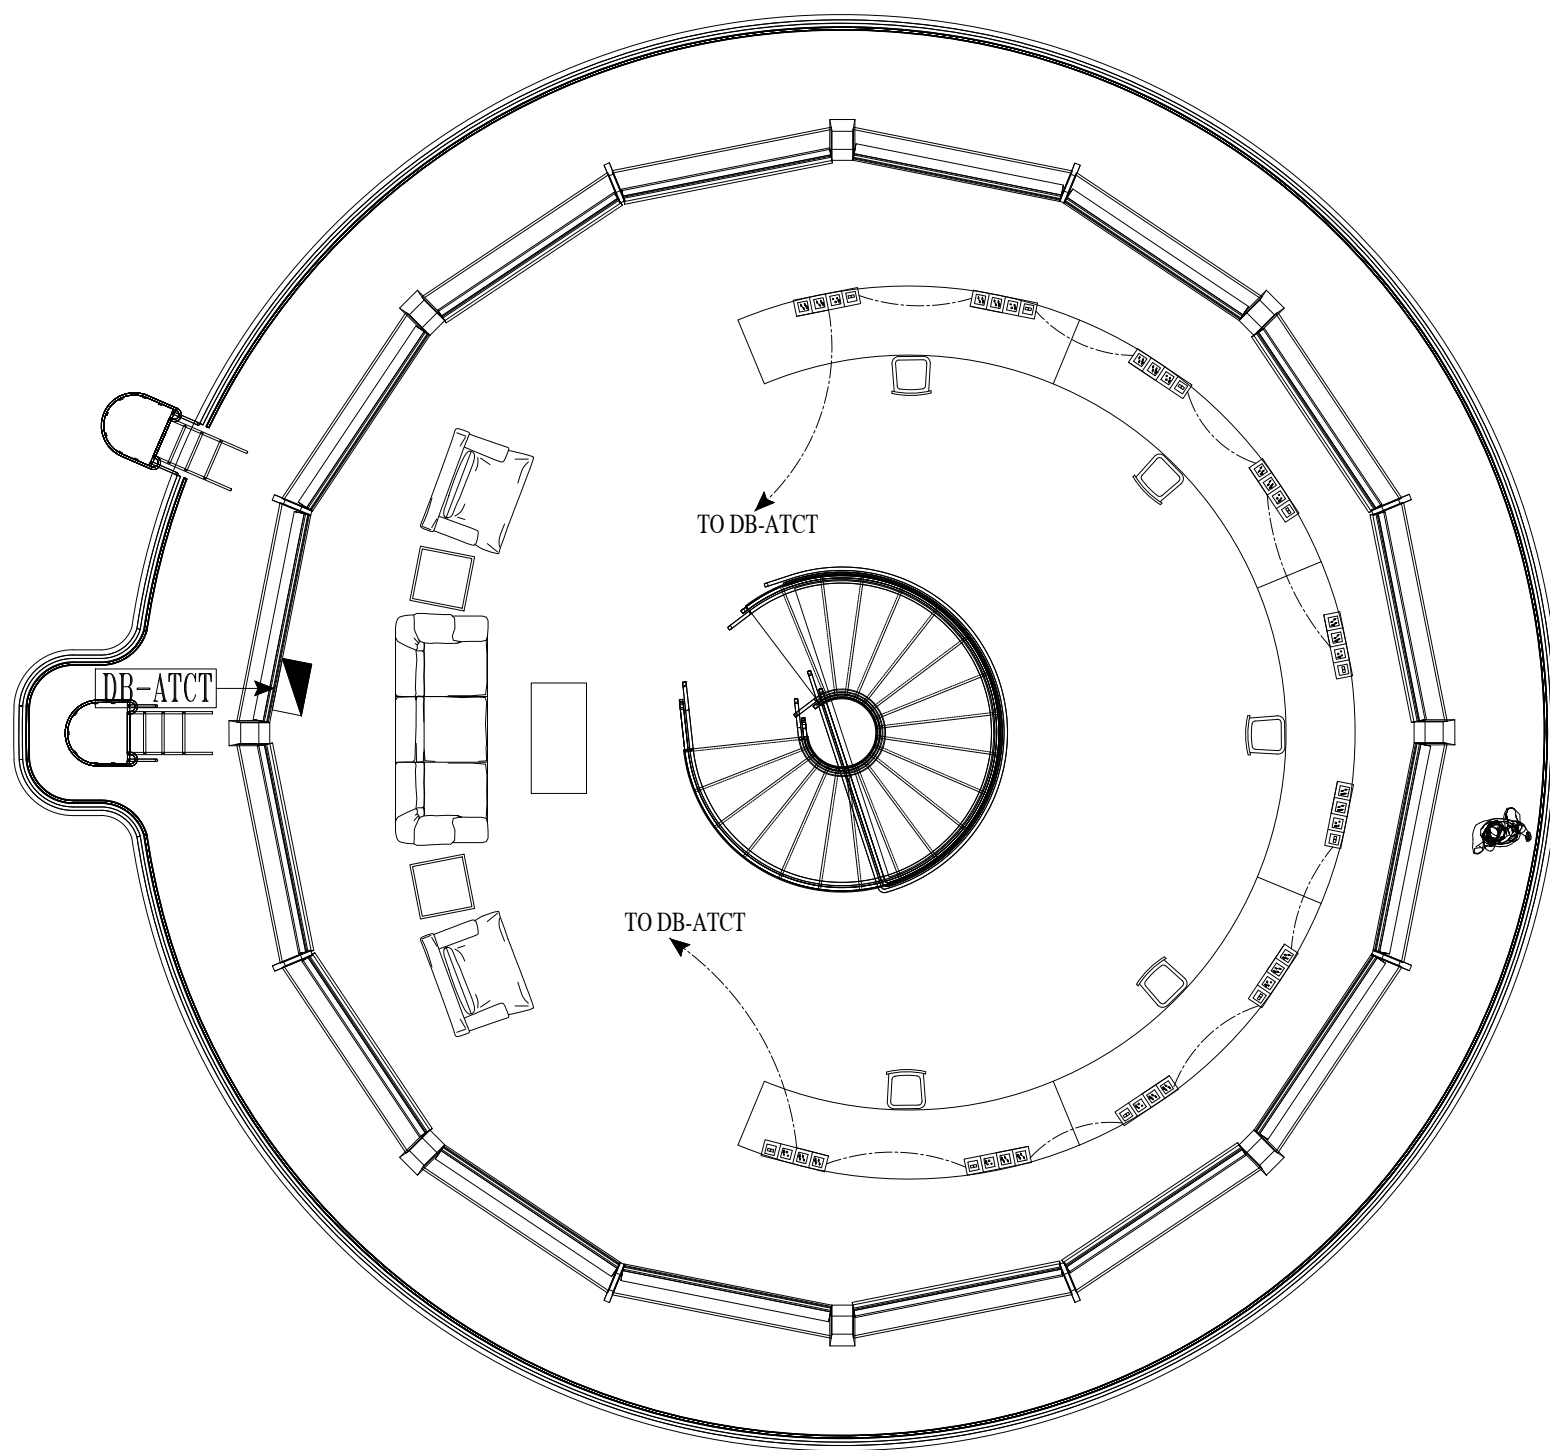

ATCT FLOOR PLAN LEVEL AT 65'-6"
COVERED AREA 1548 Sft

NOTES:
This drawing is confidential and is the exclusive property of AAA (Pvt)Ltd.and is loaned subject to the condition that it is not to be reproduced or used to furnish for the making of drawing or prints except as sanctioned in writing by AAA (Pvt)Ltd.

CLIENT NAME

C:\Users\Devl\Downloads\WhatsApp Image 2025-10-15 at 12.12.04 PM.png

MAIN CONSULTANT


Anwar Ali Architects (Pvt.) Ltd.
Consulting,Architects,Engineers
Planners & Management Consultants
06 HBFC BLOCK A FAISAL TOWN LAHORE

JV MEMBERS

C:\Users\Devl\Downloads\WhatsApp Image 2025-10-15 at 12.12.03 PM.png

STRUCTURAL CONSULTANT


AR ENGINEERS
Architects, Structural, Earthquake Engineering, Geo Technical, Public Health,
Highway, Electrical Design Solution.
Office # 4, 2nd Floor,Sultana Arcade Firdous Market, Gulberg-III, Lahore.
Ph: 042-35831908 03008813921, E-mail: arengineers78@gmail.com

MEP CONSULTANT


ABSTRACTORS
MEP CONSULTANT
SUITE-14,3RD FLOOR JINNAH MALL QZMIR TOWN, LHR
Cell no: 0322-3924199
E-mail: abstractorseng@gmail.com


Project Name
Consultancy Services for
New Air Traffic Control Tower
(ATCT), Fire Station and Allied
Facilities at Skardu
International Airport

**DETAILED ELECTRICAL
Design Drawings**

Sheet Name

POWER SOCKETS LAYOUT

Date	April, 2026
Scale	NTS
Drawn by	A.S.B
Checked by	M.K
Approved by	M.F
Drawing No.	E-23

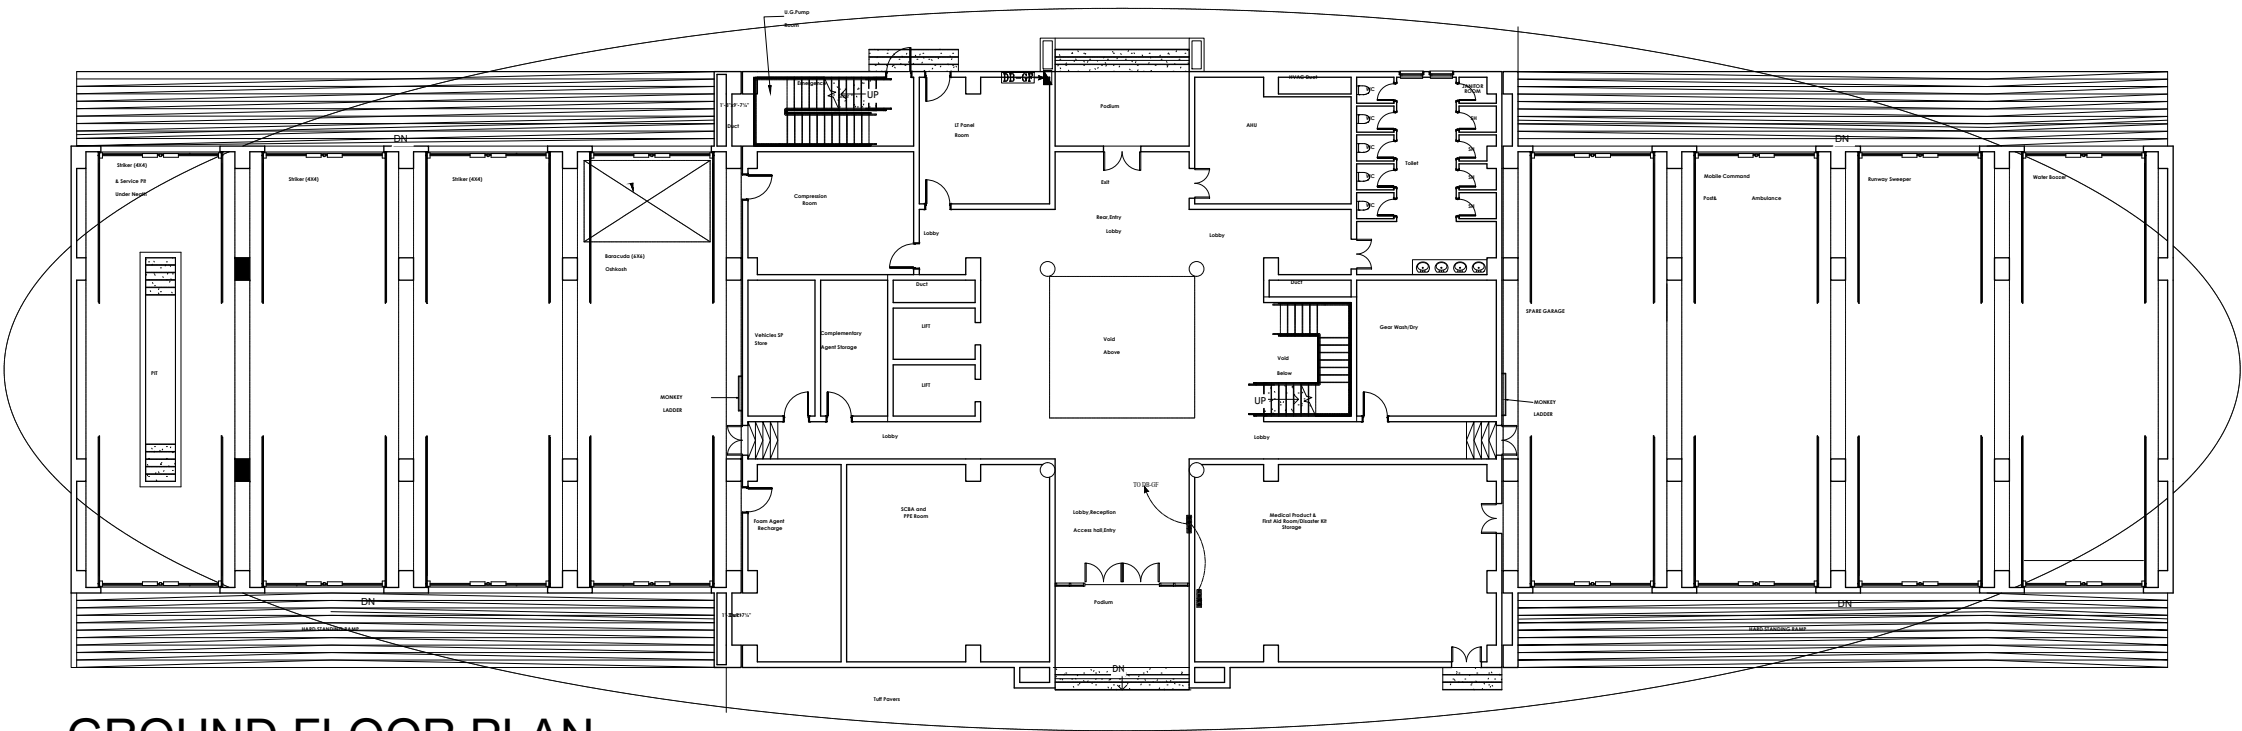

GROUND FLOOR PLAN

NOTES:

This drawing is confidential and is the exclusive property of AAA (Pvt)Ltd.and is loaned subject to the condition that it is not to be reproduced or used to furnish for the making of drawing or prints except as sanctioned in writing by AAA (Pvt)Ltd.

CLIENT NAME

C:\Users\Devl\Downloads\WhatsApp Image 2025-10-15 at 12.12.04 PM.png

MAIN CONSULTANT

Anwar Ali Architects (Pvt.) Ltd.
Consulting,Architects,Engineers
Planners & Management Consultants
06 HBFC BLOCK A FAISAL TOWN LAHORE

JV MEMBERS

C:\Users\Devl\Downloads\WhatsApp Image 2025-10-15 at 12.12.03 PM.png

STRUCTURAL CONSULTANT

AR ENGINEERS
Architects, Structural, Earthquake Engineering, Geo Technical, Public Health,
Highway, Electrical Design Solution.
Office # 4, 2nd Floor,Sultana Arcade Firdous Market, Gulberg-II, Lahore.
Ph: 042-35631906 03008813921, E-mail: arengineers786@gmail.com

MEP CONSULTANT

ABSTRACTORS
MEP CONSULTANT
SUITE-14,3RD FLOOR JINNAH MALL QZMIR TOWN, LHR
Cell no: 0322-3924199
E-mail: abstractorseng@gmail.com

Project Name


Consultancy Services for
New Air Traffic Control Tower
(ATCT), Fire Station and Allied
Facilities at Skardu
International Airport

DETAILED ELECTRICAL
Design Drawings

Sheet Name

UPS POWER SOCKETS LAYOUT

Date	April, 2026
Scale	NTS
Drawn by	A.S.B
Checked by	M.K
Approved by	M.F
Drawing No.	E-24

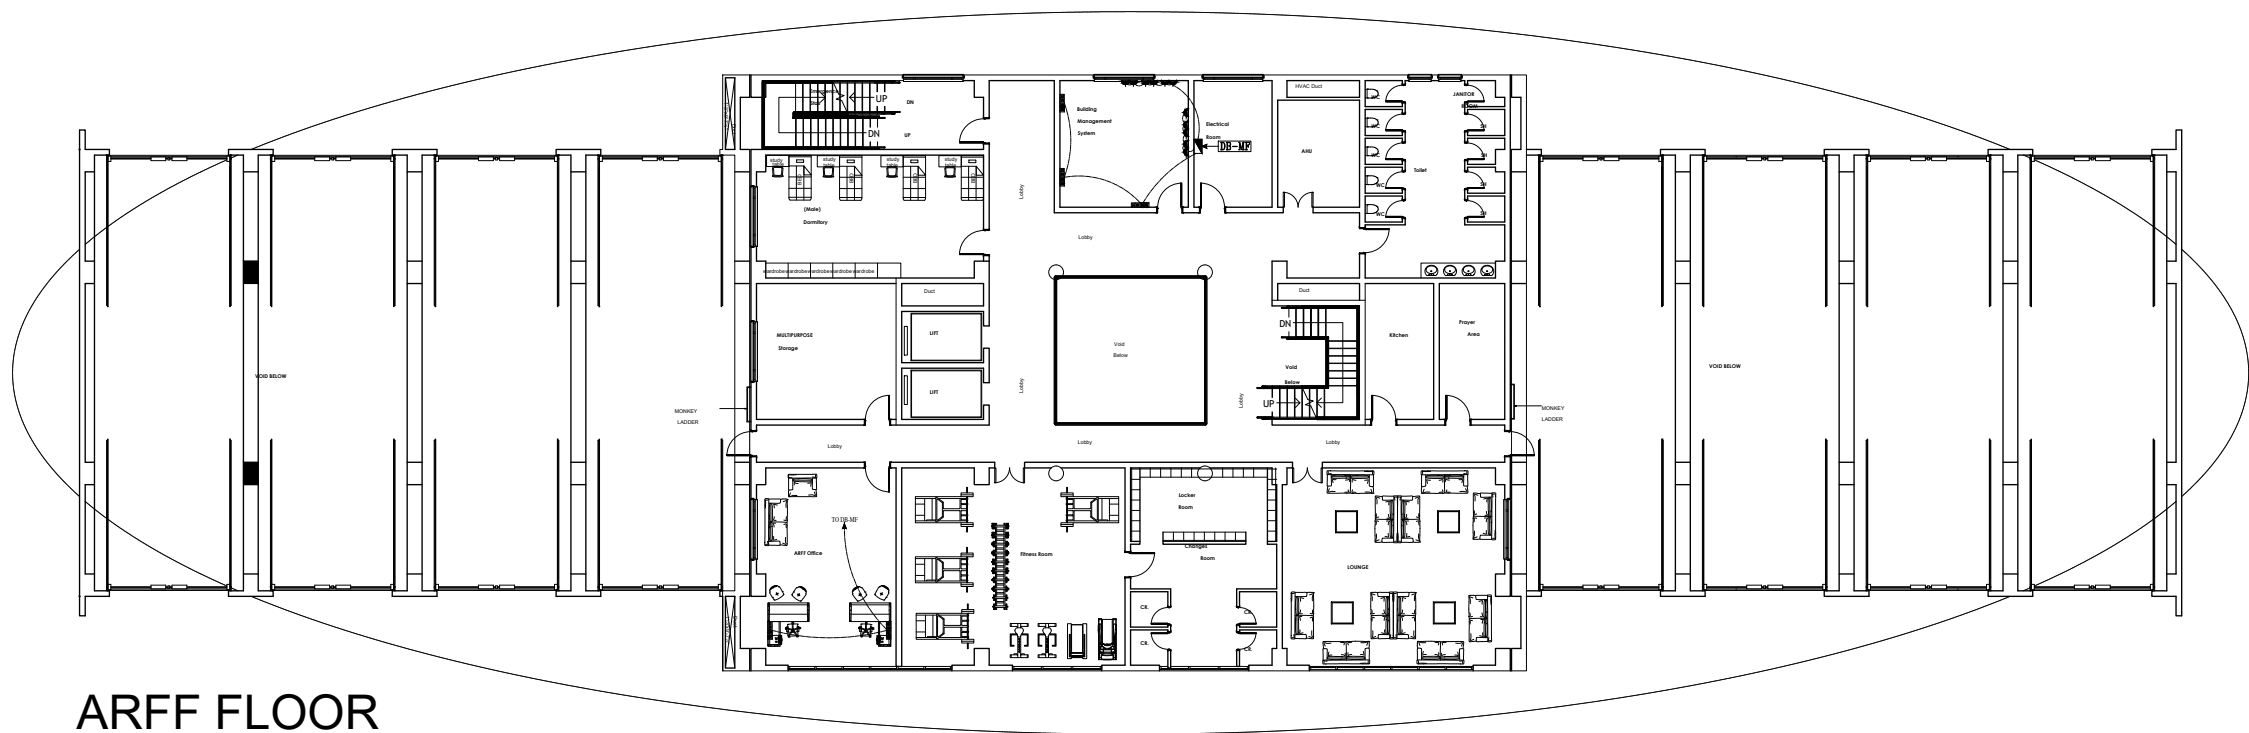

ARFF FLOOR
MEZZANINE FLOOR PLAN

NOTES:

This drawing is confidential and is the exclusive property of AAA (Pvt)Ltd.and is loaned subject to the condition that it is not to be reproduced orused to furnish for the making of drawing or prints except as sanctioned in writing by AAA (Pvt)Ltd.

CLIENT NAME

C:\Users\Devl\Downloads\WhatsApp Image 2025-10-15 at 12.12.04 PM.png

MAIN CONSULTANT



Anwar Ali Architects (Pvt.) Ltd.
Consulting,Architects,Engineers
Planners & Management Consultants
06 HBFC BLOCK A FAISAL TOWN LAHORE

JV MEMBERS

C:\Users\Devl\Downloads\WhatsApp Image 2025-10-15 at 12.12.03 PM.png

STRUCTURAL CONSULTANT



AR ENGINEERS
Architects, Structural, Earthquake Engineering, Geo Technical, Public Health,
Highway, Electrical Design Solution.
Office # A, 2nd Floor,Sultana Arcade Firdous Market, Gulberg-III, Lahore.
Ph: 042-35831908 03008813921, E-mail: arengineers786@gmail.com

MEP CONSULTANT



ABSTRACTORS
MEP CONSULTANT
SUITE-14,3RD FLOOR JINNAH MALL QZMIR TOWN, LHR
Cell no: 0322-3924199
E-mail: abstractorseng@gmail.com

Project Name


Consultancy Services for
New Air Traffic Control Tower
(ATCT), Fire Station and Allied
Facilities at Skardu
International Airport

DETAILED ELECTRICAL
Design Drawings

Sheet Name

UPS POWER SOCKETS LAYOUT

Date	April, 2026
Scale	NTS
Drawn by	A.S.B
Checked by	M.K
Approved by	M.F
Drawing No.	E-25

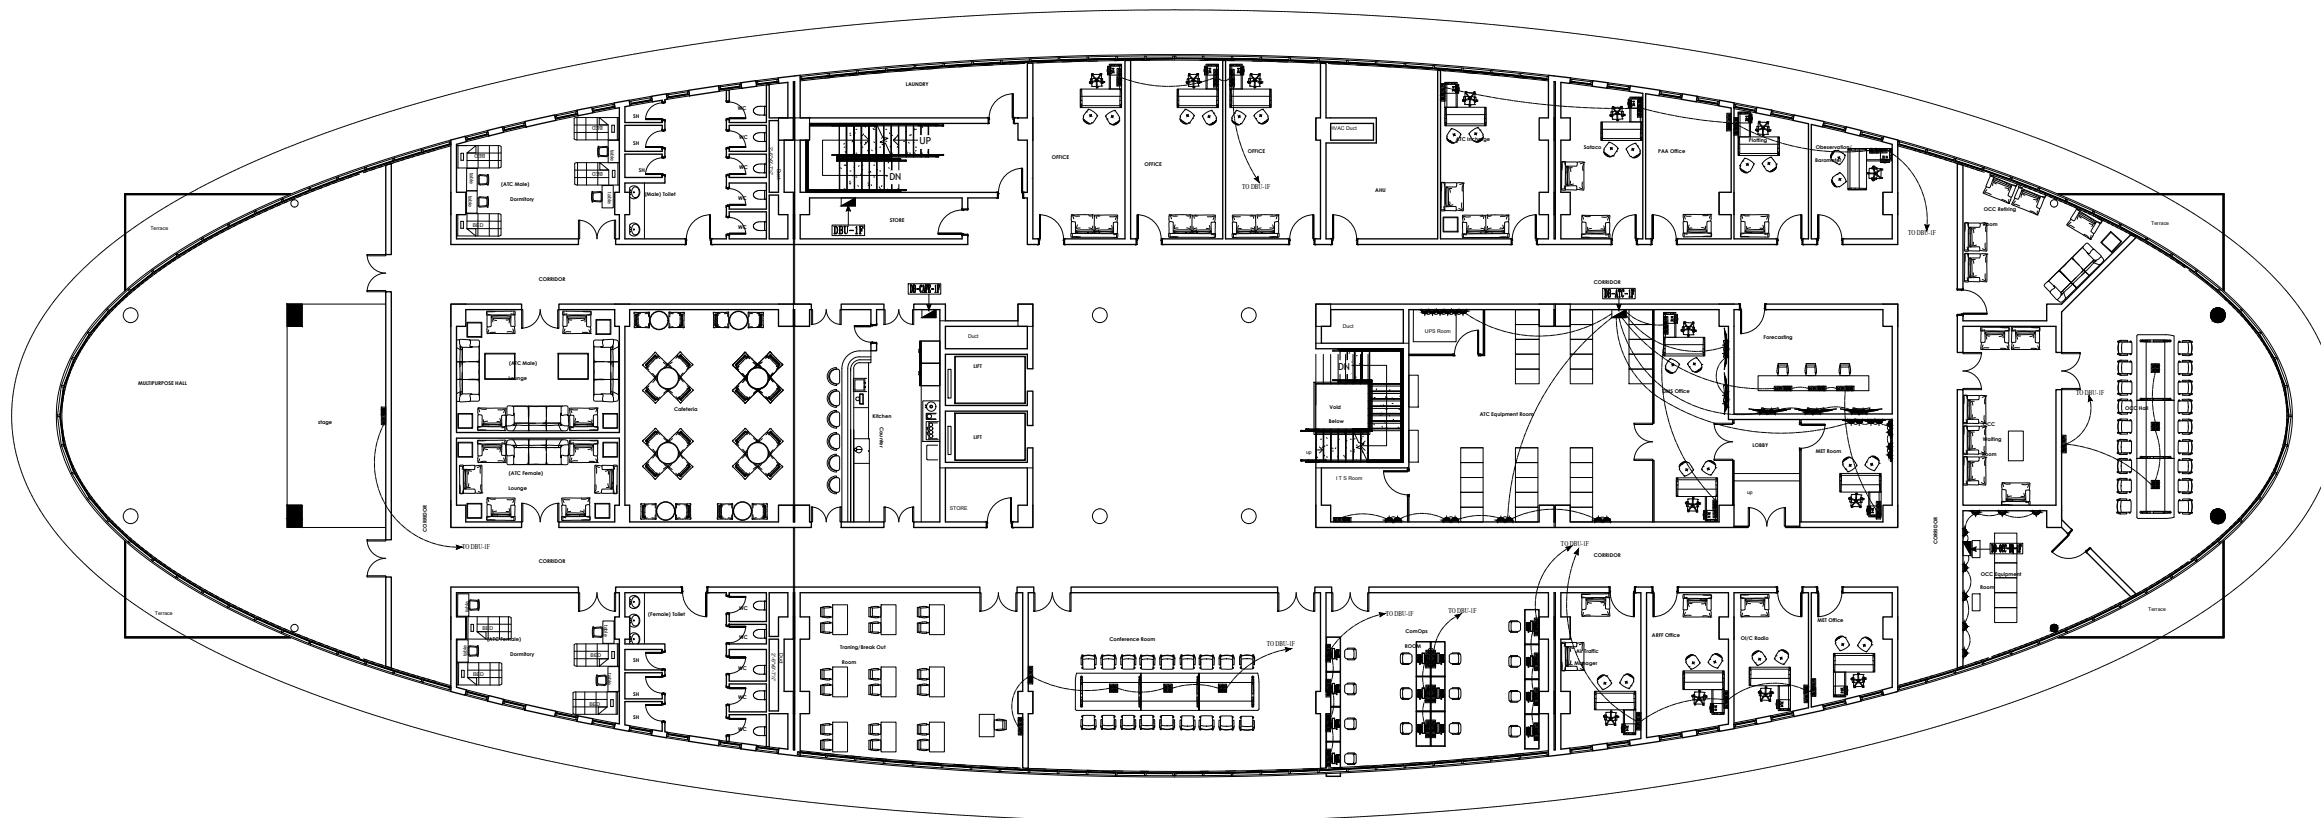

FIRST FLOOR PLAN

NOTES:

This drawing is confidential and is the exclusive property of AAA (Pvt)Ltd.and is loaned subject to the condition that it is not to be reproduced or used to furnish for the making of drawing or prints except as sanctioned in writing by AAA (Pvt)Ltd.

CLIENT NAME

C:\Users\Devl\Downloads\WhatsApp Image 2025-10-15 at 12.12.04 PM.png

MAIN CONSULTANT


Anwar Ali Architects (Pvt.) Ltd.
Consulting,Architects,Engineers
Planners & Management Consultants
06 HBFC BLOCK A FAISAL TOWN LAHORE

JV MEMBERS

C:\Users\Devl\Downloads\WhatsApp Image 2025-10-15 at 12.12.03 PM.png

STRUCTURAL CONSULTANT

 **AR ENGINEERS**
Architects, Structural, Earthquake Engineering, Geo Technical, Public Health,
Highway, Electrical Design Solution.
Office # 4, 2nd Floor,Sultana Arcade Firdous Market, Gulberg-III, Lahore.
Ph: 042-35631906 03008813921, E-mail: arengineers786@gmail.com

MEP CONSULTANT

 **ABSTRACTORS**
MEP CONSULTANT
SUITE-14,3RD FLOOR JINNAH MALL 02MIR TOWN, LHR
Cell no: 0322-3924199
E-mail: abstractorseng@gmail.com

Project Name


Consultancy Services for
New Air Traffic Control Tower
(ATCT), Fire Station and Allied
Facilities at Skardu
International Airport

DETAILED ELECTRICAL
Design Drawings

Sheet Name

UPS POWER SOCKETS LAYOUT

Date	April, 2026
Scale	NTS
Drawn by	A.S.B
Checked by	M.K
Approved by	M.F
Drawing No.	E-26

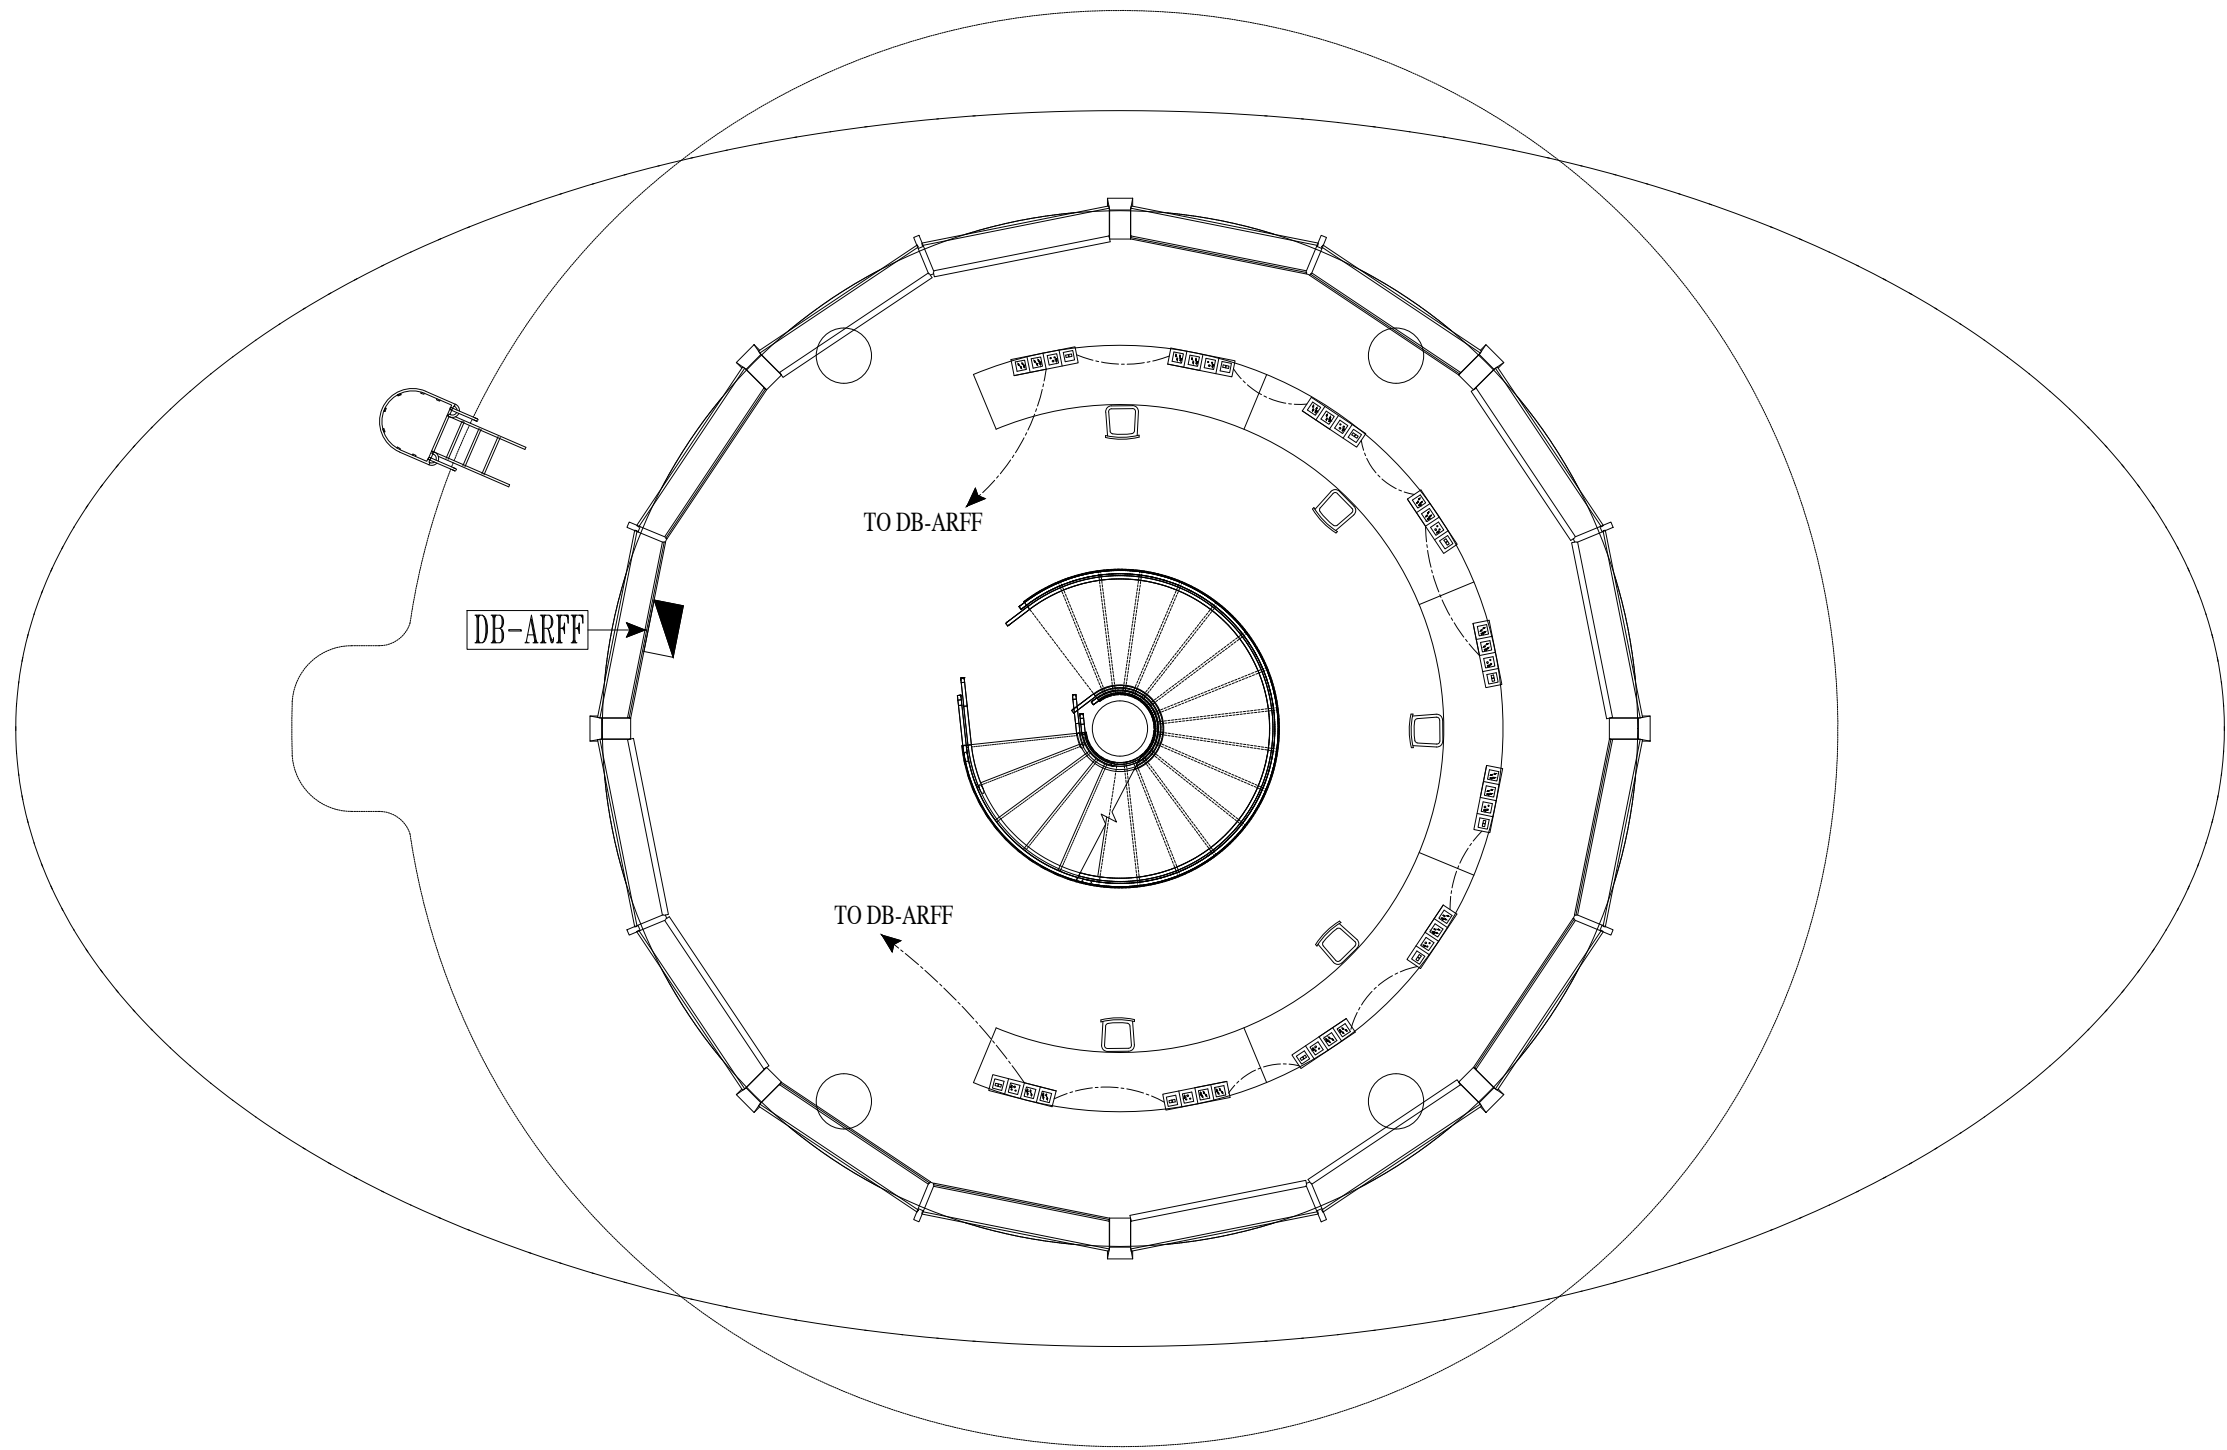

ARFF FLOOR PLAN LEVEL AT 53'-6"
COVERED AREA 2123 Sft

NOTES:
This drawing is confidential and is the exclusive property of AAA (Pvt)Ltd.and is loaned subject to the condition that it is not to be reproduced or used to furnish for the making of drawing or prints except as sanctioned in writing by AAA (Pvt)Ltd.

CLIENT NAME

C:\Users\Devl\Downloads\WhatsApp Image 2025-10-15 at 12.12.04 PM.png

MAIN CONSULTANT


Anwar Ali Architects (Pvt.) Ltd.
Consulting,Architects,Engineers
Planners & Management Consultants
06 HBFC BLOCK A FAISAL TOWN LAHORE

JV MEMBERS

C:\Users\Devl\Downloads\WhatsApp Image 2025-10-15 at 12.12.03 PM.png

STRUCTURAL CONSULTANT

 **AR ENGINEERS**
Architects, Structural, Earthquake Engineering, Geo Technical, Public Health,
Highway, Electrical Design Solution.
Office # 4, 2nd Floor,Sultana Arcade Firdous Market, Gulberg-III, Lahore.
Ph: 042-35831908 03008813921, E-mail: arengineers78@gmail.com


MEP CONSULTANT

 **ABSTRACTORS**
MEP CONSULTANT
SUITE-14,3RD FLOOR JINNAH MALL QZMIR TOWN, LHR
Cell no: 0322-3924199
E-mail: abstractorseng@gmail.com

Project Name
Consultancy Services for
New Air Traffic Control Tower
(ATCT), Fire Station and Allied
Facilities at Skardu
International Airport

**DETAILED ELECTRICAL
Design Drawings**

Sheet Name	
UPS POWER SOCKETS LAYOUT	
Date	April, 2026
Scale	NTS
Drawn by	A.S.B
Checked by	M.K
Approved by	M.F
Drawing No.	E-27

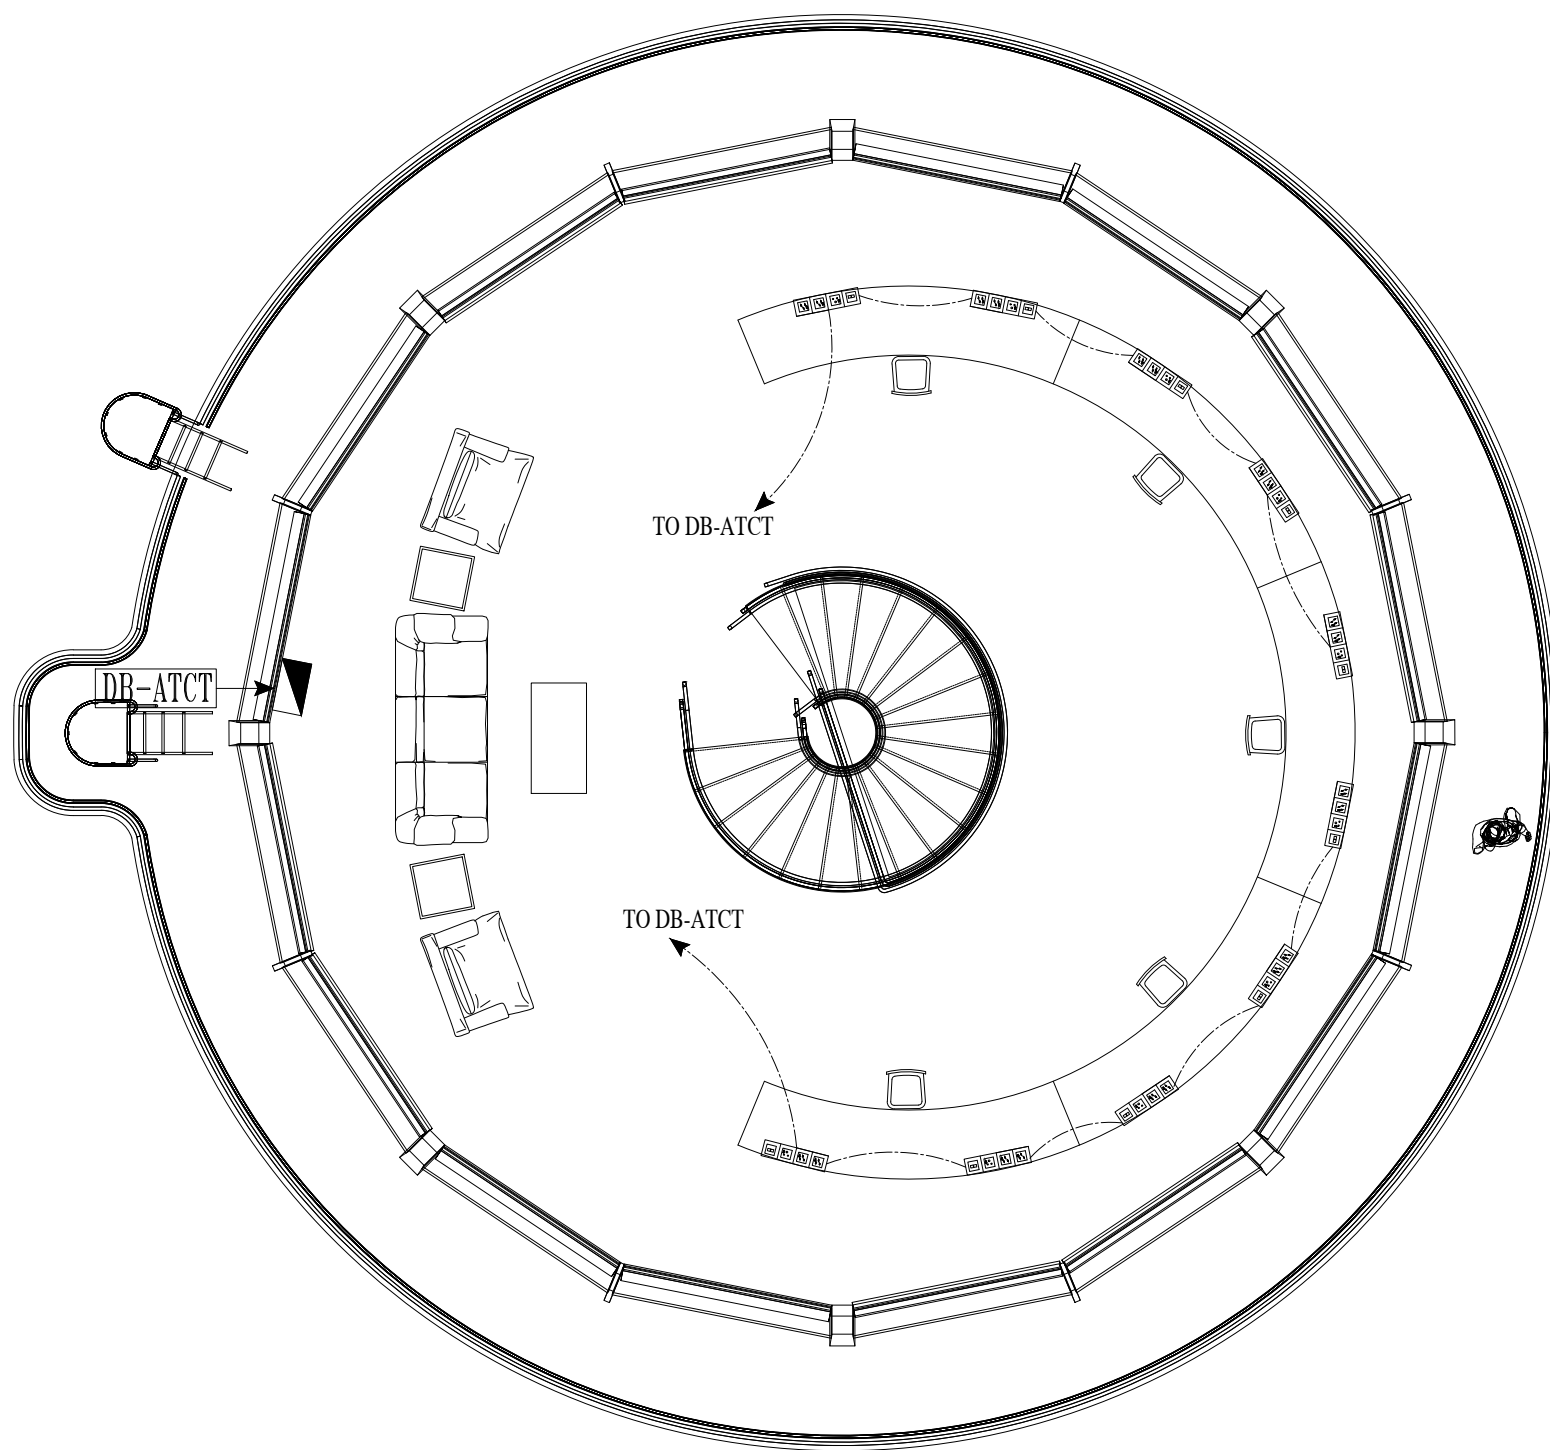

ATCT FLOOR PLAN LEVEL AT 65'-6"
COVERED AREA 1548 Sft

NOTES:

This drawing is confidential and is the exclusive property of AAA (Pvt)Ltd.and is loaned subject to the condition that it is not to be reproduced orused to furnish for the making of drawing or prints except as sanctioned in writing by AAA (Pvt)Ltd.

CLIENT NAME

C:\Users\Devl\Downloads\WhatsApp Image 2025-10-15 at 12.12.04 PM.png

MAIN CONSULTANT


Anwar Ali Architects (Pvt.) Ltd.
Consulting,Architects,Engineers
Planners & Management Consultants
06 HBFC BLOCK A FAISAL TOWN LAHORE

JV MEMBERS

C:\Users\Devl\Downloads\WhatsApp Image 2025-10-15 at 12.12.03 PM.png

STRUCTURAL CONSULTANT


AR ENGINEERS
Architects, Stuctural, Earthquake Engineering, Geo Technical, Public Health,
Highway, Electrical Design Solution.
Office # 4, 2nd Floor,Sultana Arcade Firdous Market, Gulberg-III, Lahore.
Ph: 042-35831908 0300813921, E-mail: arengineers78@gmail.com

MEP CONSULTANT


ABSTRACTORS
MEP CONSULTANT
SUITE-14,3RD FLOOR JINNAH MALL QZMIR TOWN, LHR
Cell no: 0322-3924199
E-mail: abstractorseng@gmail.com

Project Name


Consultancy Services for
New Air Traffic Control Tower
(ATCT), Fire Station and Allied
Facilities at Skardu
International Airport

DETAILED ELECTRICAL
Design Drawings

Sheet Name

UPS POWER SOCKETS LAYOUT

Date	April, 2026
Scale	NTS
Drawn by	A.S.B
Checked by	M.K
Approved by	M.F
Drawing No.	E-28

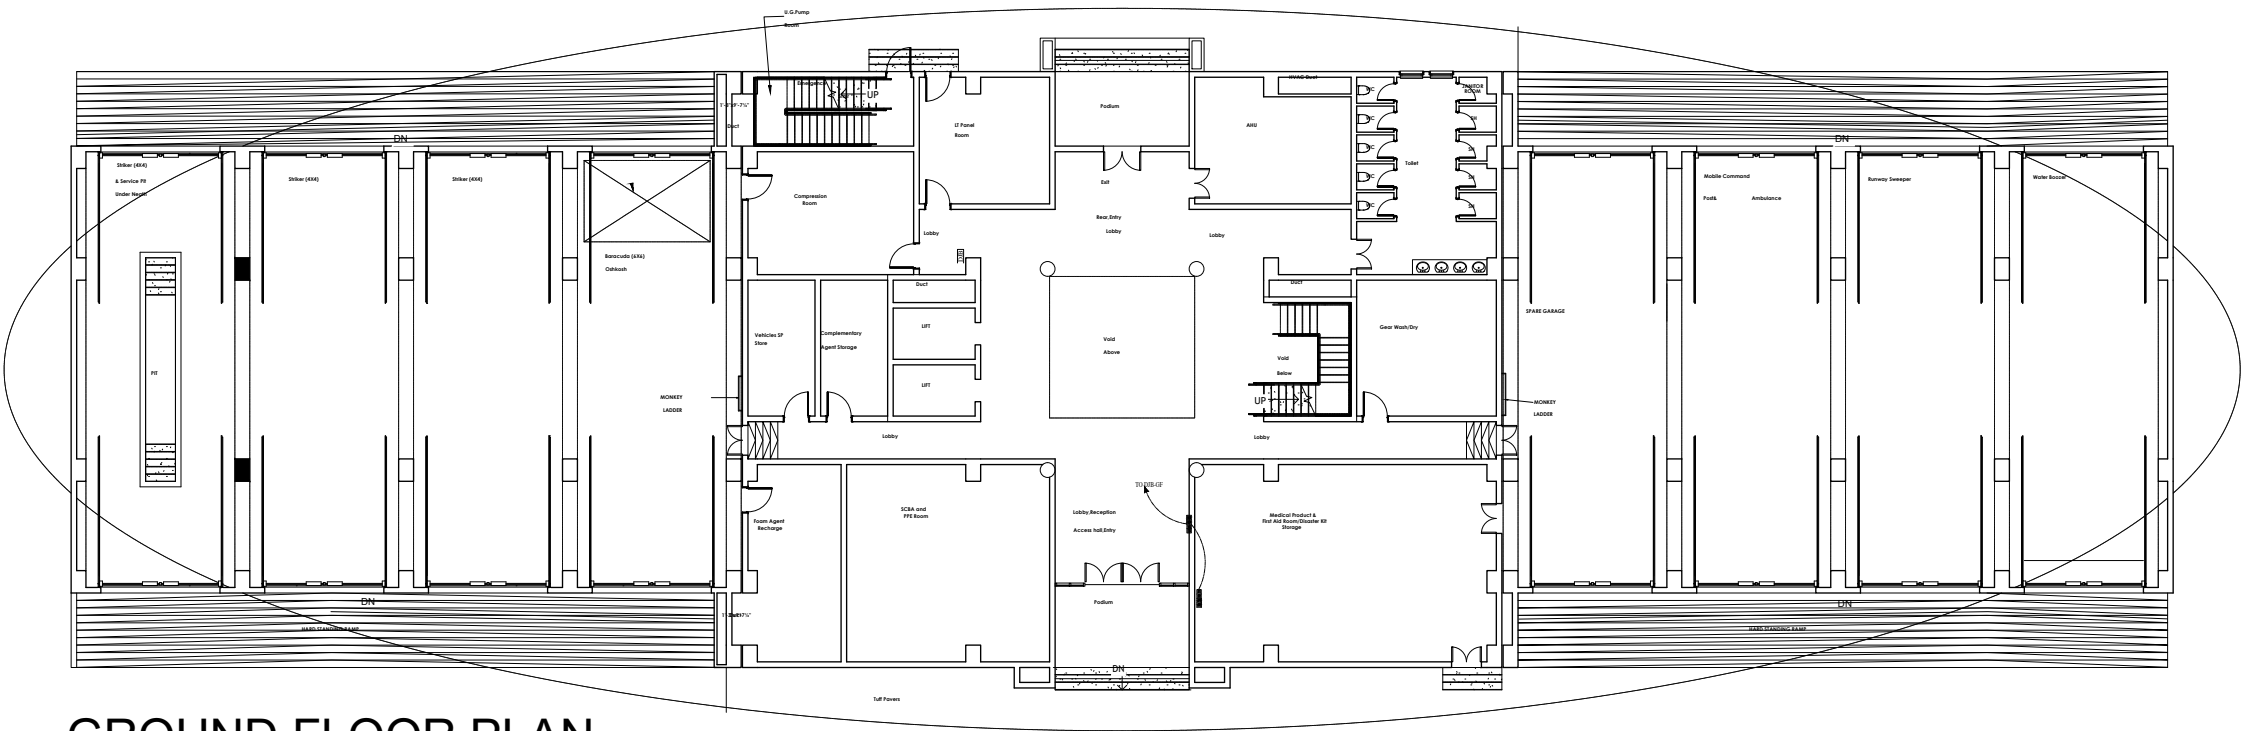

GROUND FLOOR PLAN

NOTES:

This drawing is confidential and is the exclusive property of AAA (Pvt)Ltd.and is loaned subject to the condition that it is not to be reproduced or used to furnish for the making of drawing or prints except as sanctioned in writing by AAA (Pvt)Ltd.

CLIENT NAME

C:\Users\Devl\Downloads\WhatsApp Image 2025-10-15 at 12.12.04 PM.png

MAIN CONSULTANT

Anwar Ali Architects (Pvt.) Ltd.
Consulting,Architects,Engineers
Planners & Management Consultants
06 HBFC BLOCK A FAISAL TOWN LAHORE

JV MEMBERS

C:\Users\Devl\Downloads\WhatsApp Image 2025-10-15 at 12.12.03 PM.png

STRUCTURAL CONSULTANT

AR ENGINEERS
Architects, Structural, Earthquake Engineering, Geo Technical, Public Health,
Highway, Electrical Design Solution.
Office # 4, 2nd Floor,Sultana Arcade Firdous Market, Gulberg-II, Lahore.
Ph: 042-35631906 03008813921, E-mail: arengineers786@gmail.com

MEP CONSULTANT

ABSTRACTORS
MEP CONSULTANT
SUITE-14,3RD FLOOR JINNAH MALL QZMIR TOWN, LHR
Cell no: 0322-3924199
E-mail: abstractorseng@gmail.com

Project Name


Consultancy Services for
New Air Traffic Control Tower
(ATCT), Fire Station and Allied
Facilities at Skardu
International Airport

DETAILED ELECTRICAL
Design Drawings

Sheet Name

DATA NETWORKING LAYOUT

Date	April, 2026
Scale	NTS
Drawn by	A.S.B
Checked by	M.K
Approved by	M.F
Drawing No.	E-29

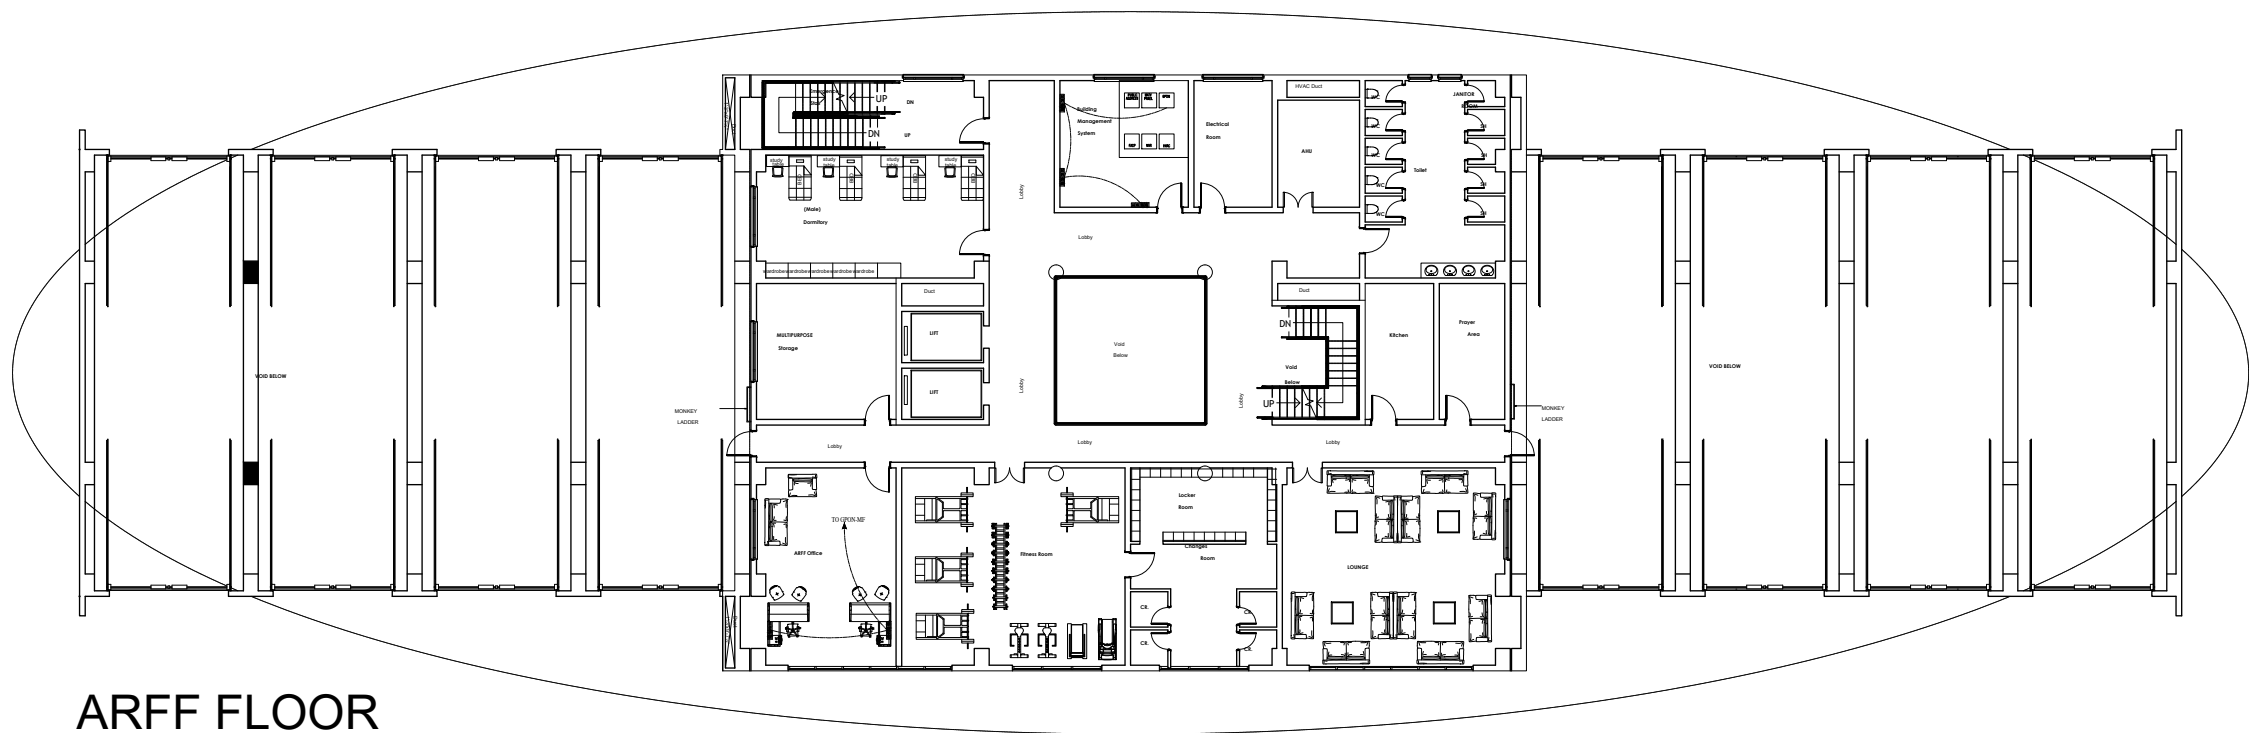

ARFF FLOOR
MEZZANINE FLOOR PLAN

NOTES:

This drawing is confidential and is the exclusive property of AAA (Pvt)Ltd.and is loaned subject to the condition that it is not to be reproduced or used to furnish for the making of drawing or prints except as sanctioned in writing by AAA (Pvt)Ltd.

CLIENT NAME

C:\Users\Devl\Downloads\WhatsApp Image 2025-10-15 at 12.12.04 PM.png

MAIN CONSULTANT

Anwar Ali Architects (Pvt.) Ltd.
Consulting,Architects,Engineers
Planners & Management Consultants
06 HBFC BLOCK A FAISAL TOWN LAHORE

JV MEMBERS

C:\Users\Devl\Downloads\WhatsApp Image 2025-10-15 at 12.12.03 PM.png

STRUCTURAL CONSULTANT

AR ENGINEERS
Architects, Structural, Earthquake Engineering, Geo Technical, Public Health,
Highway, Electrical Design Solution.
Office # 4, 2nd Floor,Sultana Arcade Firdous Market, Gulberg-III, Lahore.
Ph: 042-35831908 03008813921, E-mail: arengineers786@gmail.com

MEP CONSULTANT

ABSTRACTORS
MEP CONSULTANT
SUITE-14,3RD FLOOR JINNAH MALL QZMIR TOWN, LHR
Cell no: 0322-3924199
E-mail: abstractorseng@gmail.com

Project Name


Consultancy Services for
New Air Traffic Control Tower
(ATCT), Fire Station and Allied
Facilities at Skardu
International Airport

DETAILED ELECTRICAL
Design Drawings

Sheet Name

DATA NETWORKING LAYOUT

Date	April, 2026
Scale	NTS
Drawn by	A.S.B
Checked by	M.K
Approved by	M.F
Drawing No.	E-30

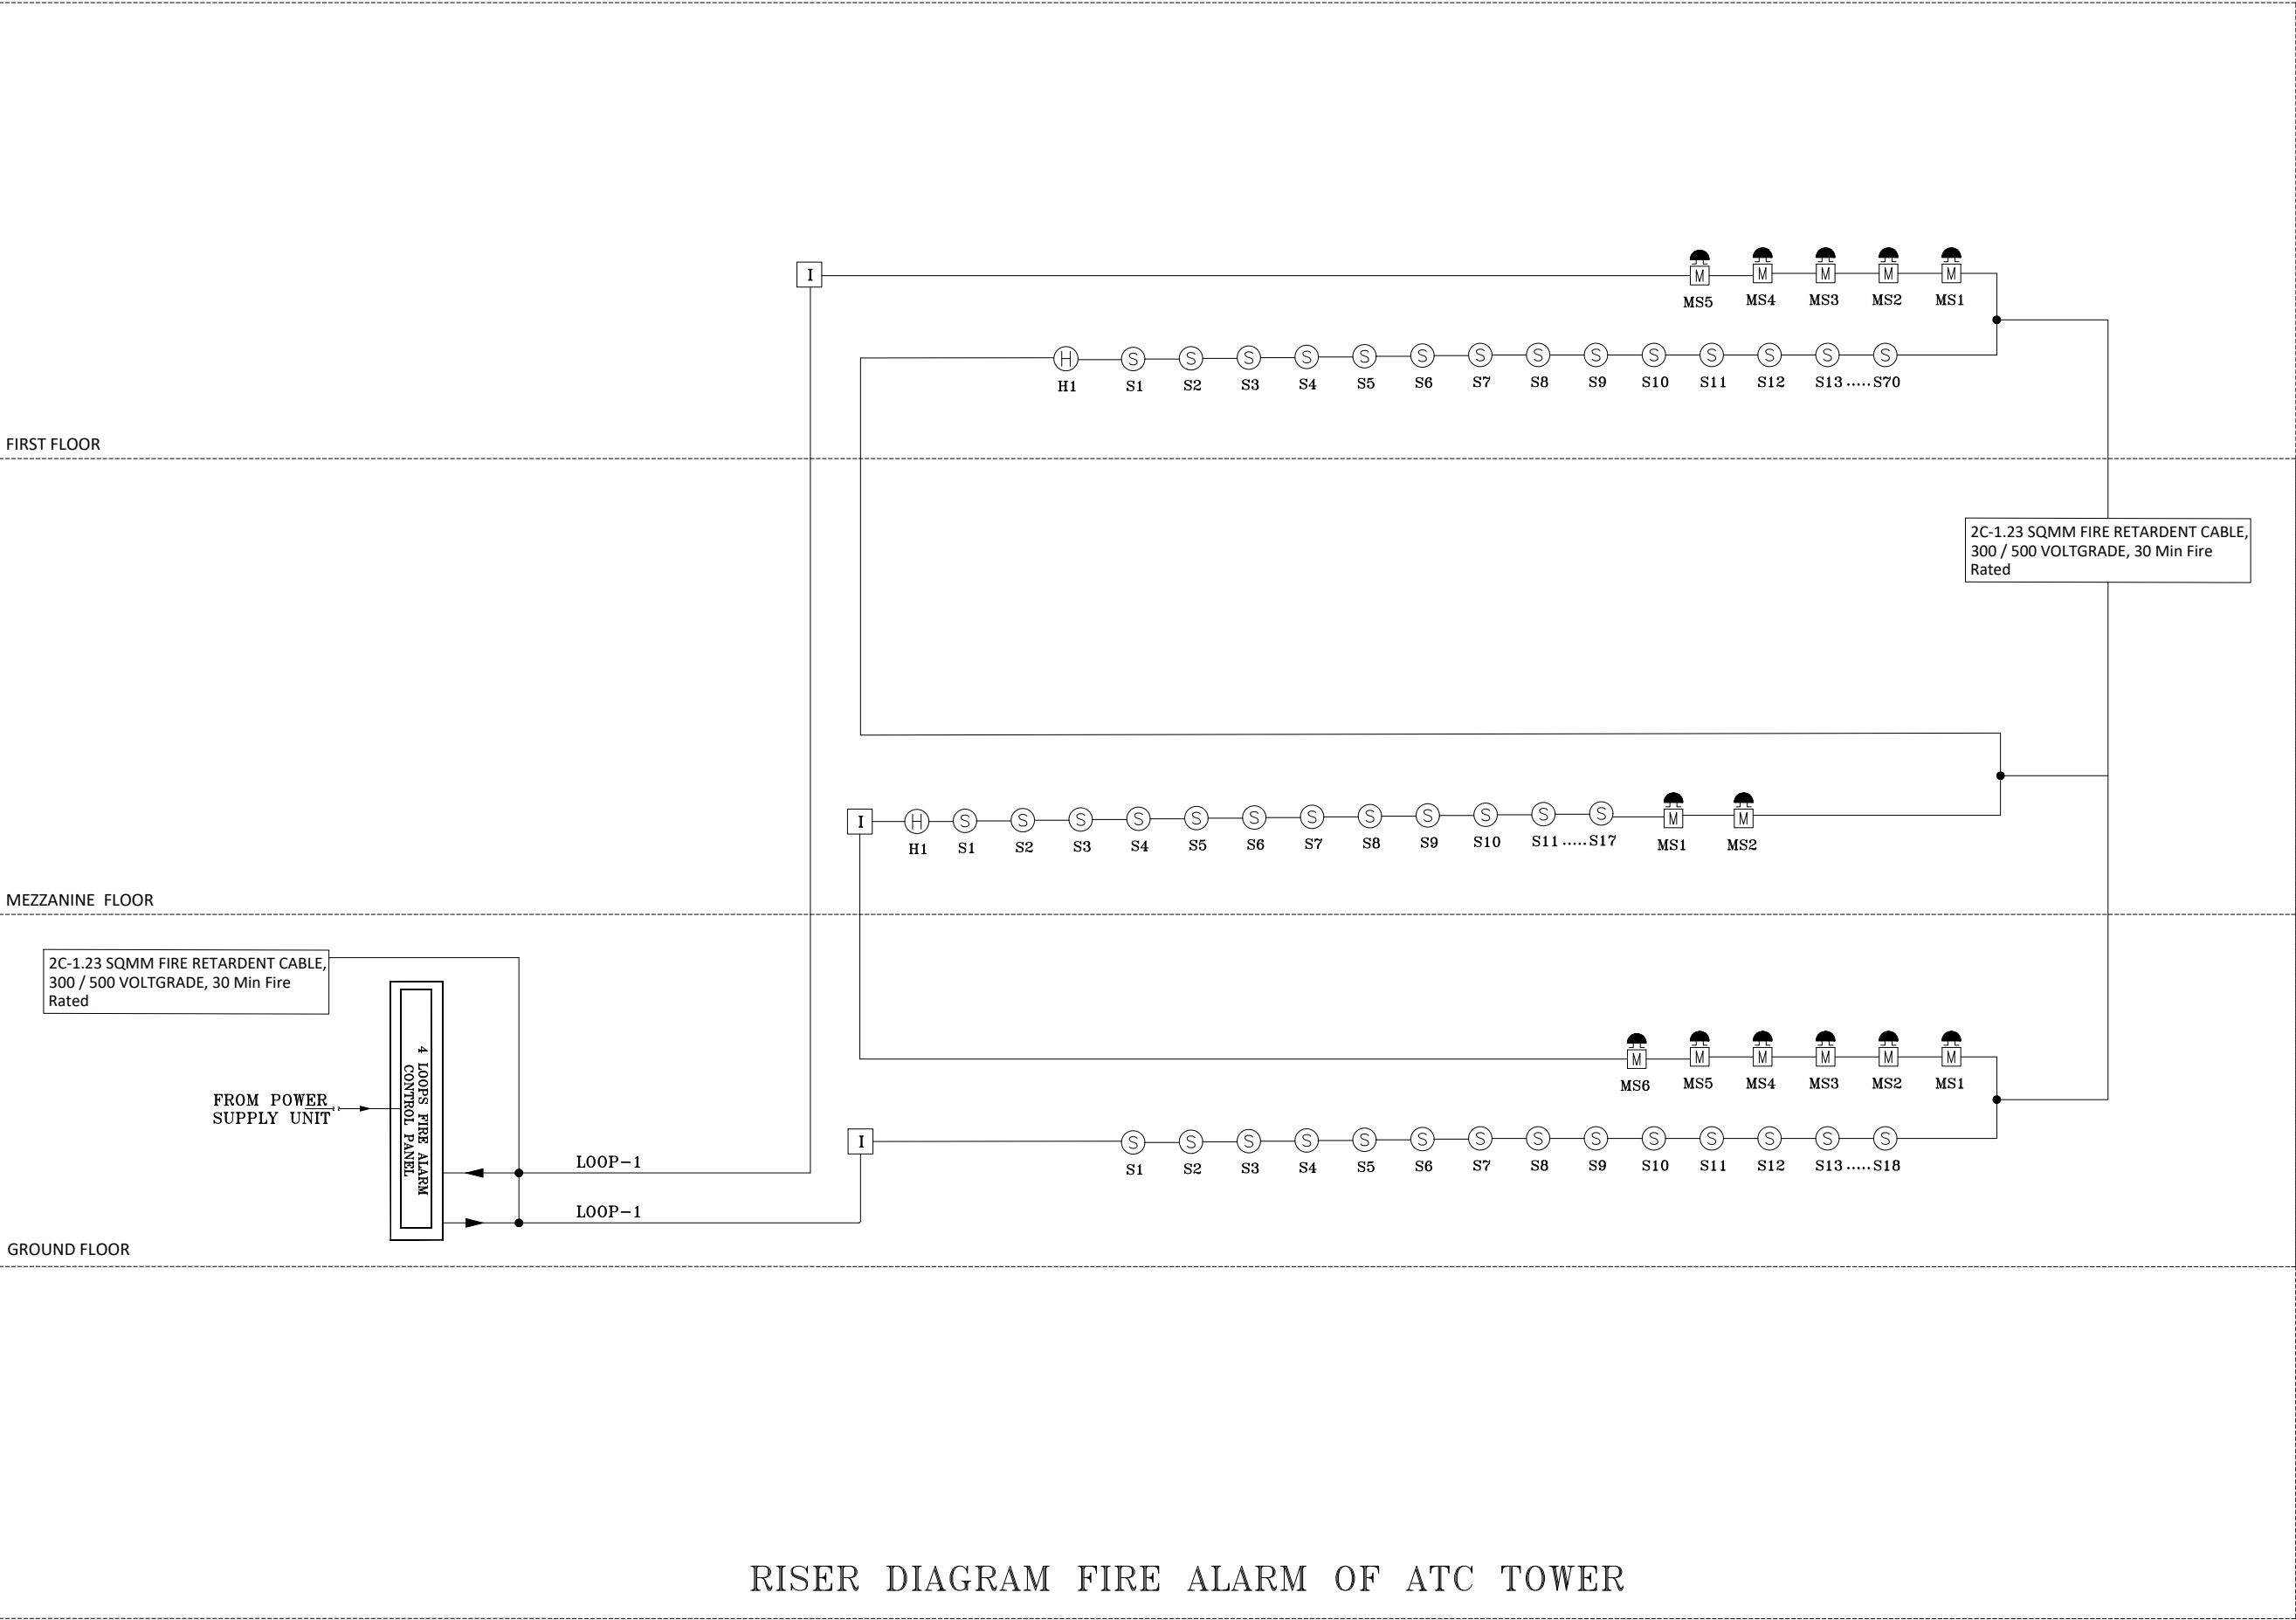

RISER DIAGRAM FIRE ALARM OF ATC TOWER

ISSUED FOR REVIEW

NOTES:
These drawings are confidential and is the exclusive property of AAA (Pvt)Ltd. And is loaned subject to the condition that it is not to be reproduced to furnish for the making of drawing or prints except as sanctioned in writing by AAA (Pvt)Ltd.

TITLE PAGE:

**DETAILED ELECTRICAL
DESIGN DRAWINGS**

CLIENT NAME



MAIN CONSULTANT



JV MEMBERS



STRUCTURAL CONSULTANT

AR ENGINEERS
Architects, Structural, Earthquake Engineering, Geo Technical, Public Health, Highway, Electrical Design Solution.
Office # 4, 2nd Floor, Sultana Arcade, Firdous Market, Gulberg-III, Lahore.
Ph: 042-35631506 03008813921, E-mail: arengineers786@gmail.com

MEP CONSULTANT




Project Name
Consultancy Services for the Preparation of Detailed Design, Procurement Support and Construction Supervision of New Air Traffic Control Tower (ATCT), Fire Station and Allied Facilities at Skardu International Airport

Sheet Name

FIRE ALARM RISER DIAGRAM

Date	APRIL, 2026
Scale	NTS
Drawn by	A.S.B
Checked by	M.K
Approved by	M.F
Drawing No.	E-55

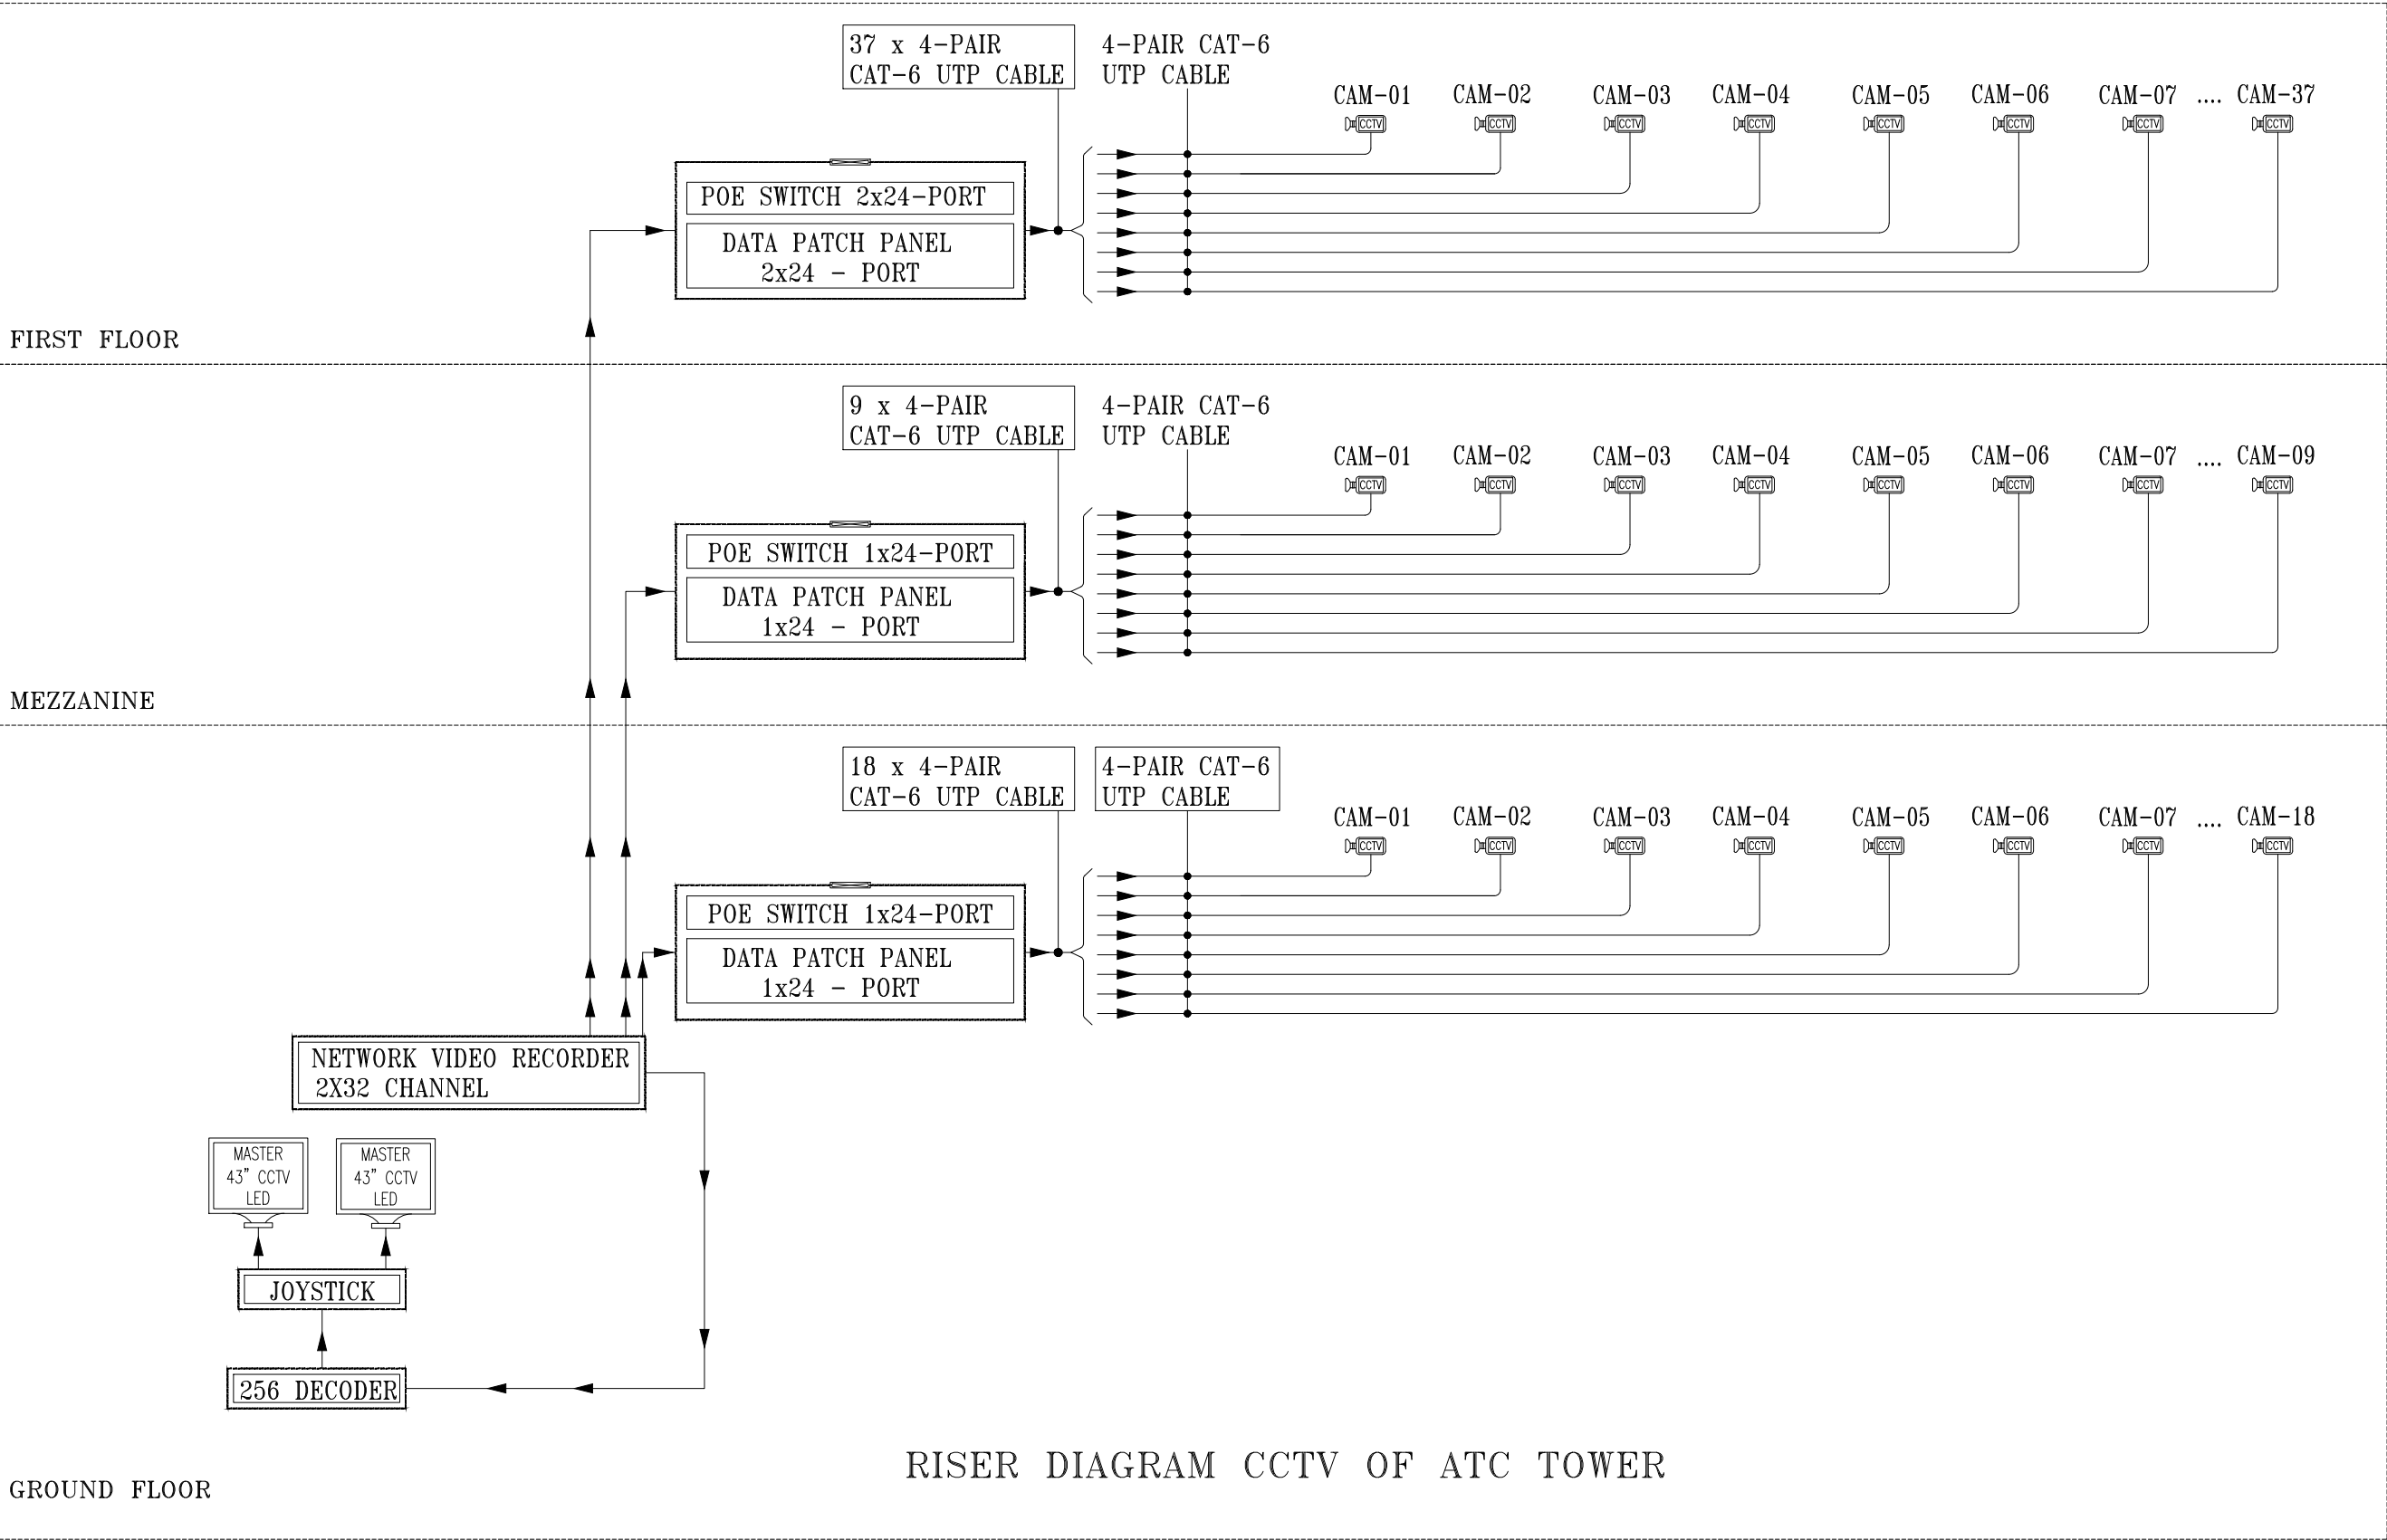

RISER DIAGRAM CCTV OF ATC TOWER

ISSUED FOR REVIEW

NOTES:
These drawings are confidential and is the exclusive property of AAA (Pvt)Ltd. And is loaned subject to the condition that it is not to be reproduced to furnish for the making of drawing or prints except as sanctioned in writing by AAA (Pvt)Ltd.

TITLE PAGE:

**DETAILED ELECTRICAL
DESIGN DRAWINGS**

CLIENT NAME



MAIN CONSULTANT



JV MEMBERS



STRUCTURAL CONSULTANT

AR ENGINEERS
Architects, Structural, Earthquake Engineering, Geo Technical, Public Health, Highway, Electrical Design Solution.
Office # 4, 2nd Floor, Sultana Arcade Firdous Market, Gulberg-III, Lahore.
Ph: 042-35831906 03008613921, E-mail: arengineers786@gmail.com

MEP CONSULTANT

ABSTRACTORS
MEP CONSULTANT
SUITE-14, 3RD FLOOR, JINNAH MALL, DHAIR TOWN, LHR
Cell no: 0322-3924199
E-mail: abstractorseng@gmail.com


Project Name

Consultancy Services for the Preparation of Detailed Design, Procurement Support and Construction Supervision of New Air Traffic Control Tower (ATCT), Fire Station and Allied Facilities at Skardu International Airport

Sheet Name

CCTV RISER DIAGRAM

Date	APRIL, 2026
Scale	NTS
Drawn by	A.S.B
Checked by	M.K
Approved by	M.F
Drawing No.	E-56

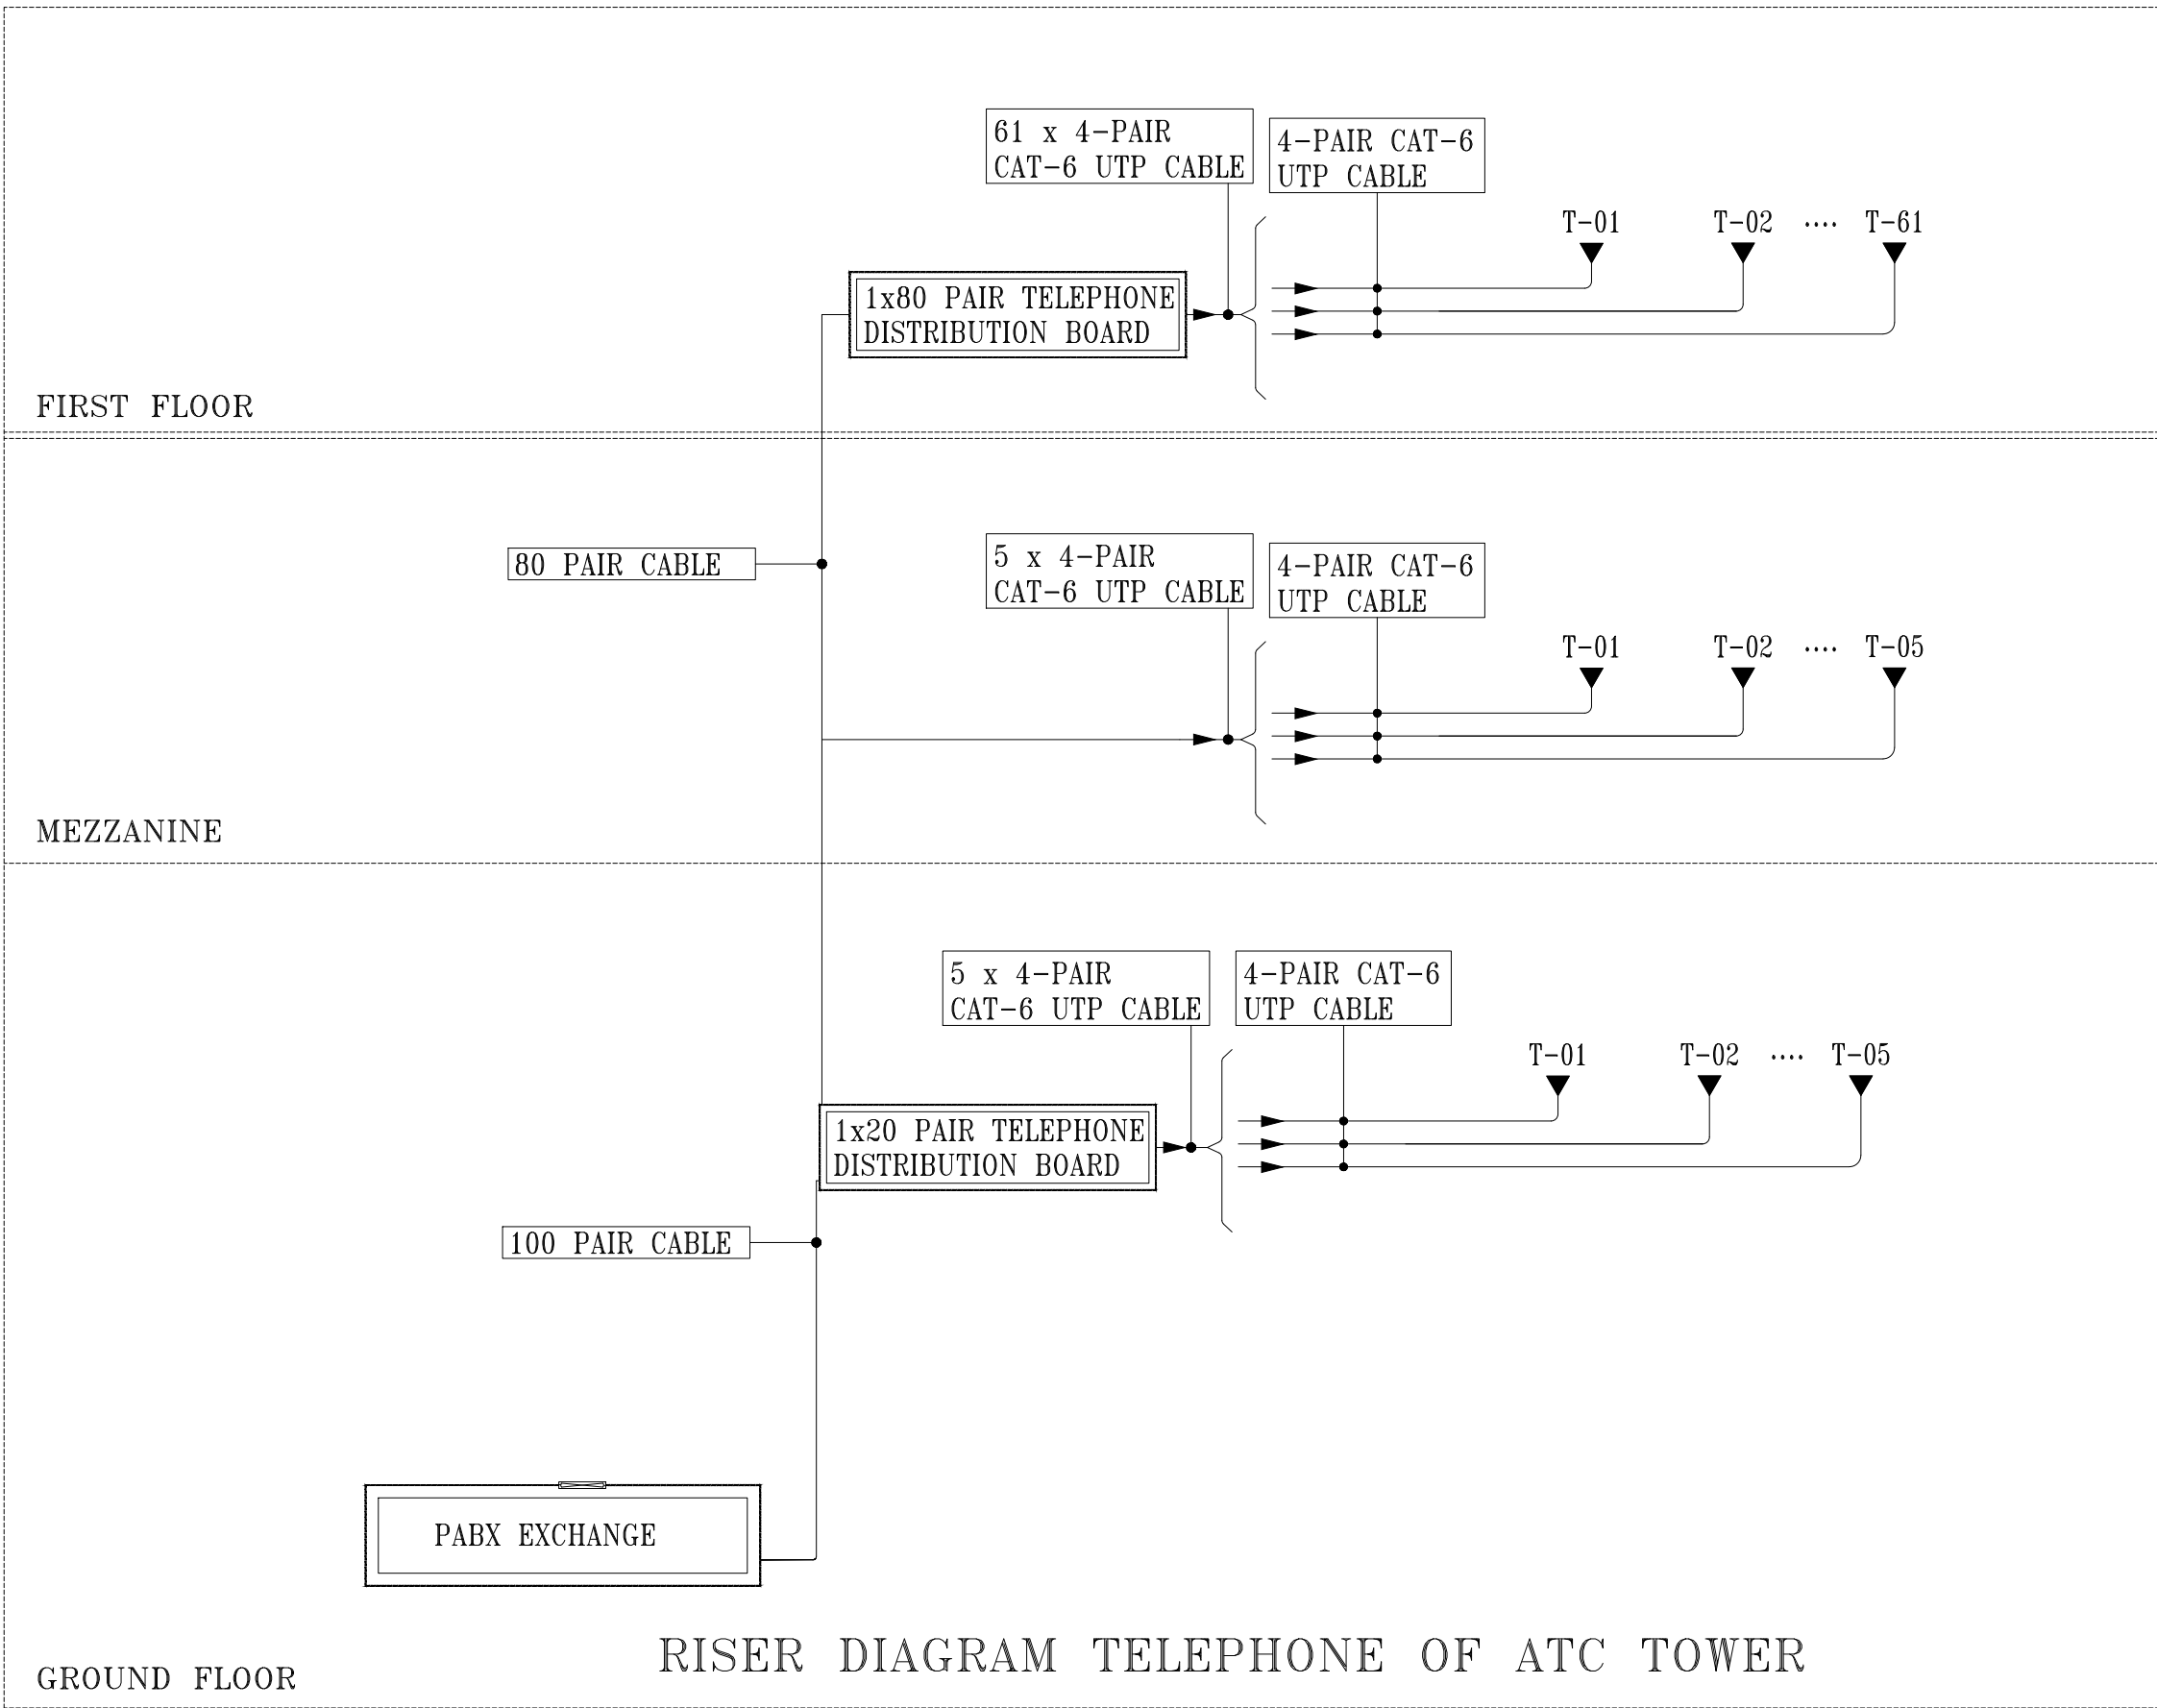

NOTES:

These drawings are confidential and is the exclusive property of AAA (Pvt)Ltd. And is loaned subject to the condition that it is not to be reproduced to furnish for the making of drawing or prints except as sanctioned in writing by AAA (Pvt)Ltd.

TITLE PAGE:

**DETAILED ELECTRICAL
DESIGN DRAWINGS**

CLIENT NAME



MAIN CONSULTANT



JV MEMBERS



leit-werk

STRUCTURAL CONSULTANT

AR ENGINEERS

Architects, Structural, Earthquake Engineering, Geo Technical, Public Health, Highway, Electrical Design Solution.
Office # 4, 2nd Floor, Sultana Arcade Firdous Market, Gulberg-III, Lahore.
Ph: 042-35811906 03008613921, E-mail: arengineers78@gmail.com

MEP CONSULTANT



Project Name

**Consultancy Services for the
Preparation of Detailed Design,
Procurement Support and
Construction Supervision of
New Air Traffic Control Tower
(ATCT), Fire Station and Allied
Facilities at Skardu
International Airport**

Sheet Name

TELEPHONE RISER DIAGRAM

Date	APRIL, 2026
Scale	NTS
Drawn by	A.S.B
Checked by	M.K
Approved by	M.F
Drawing No.	E-57

ISSUED FOR REVIEW