



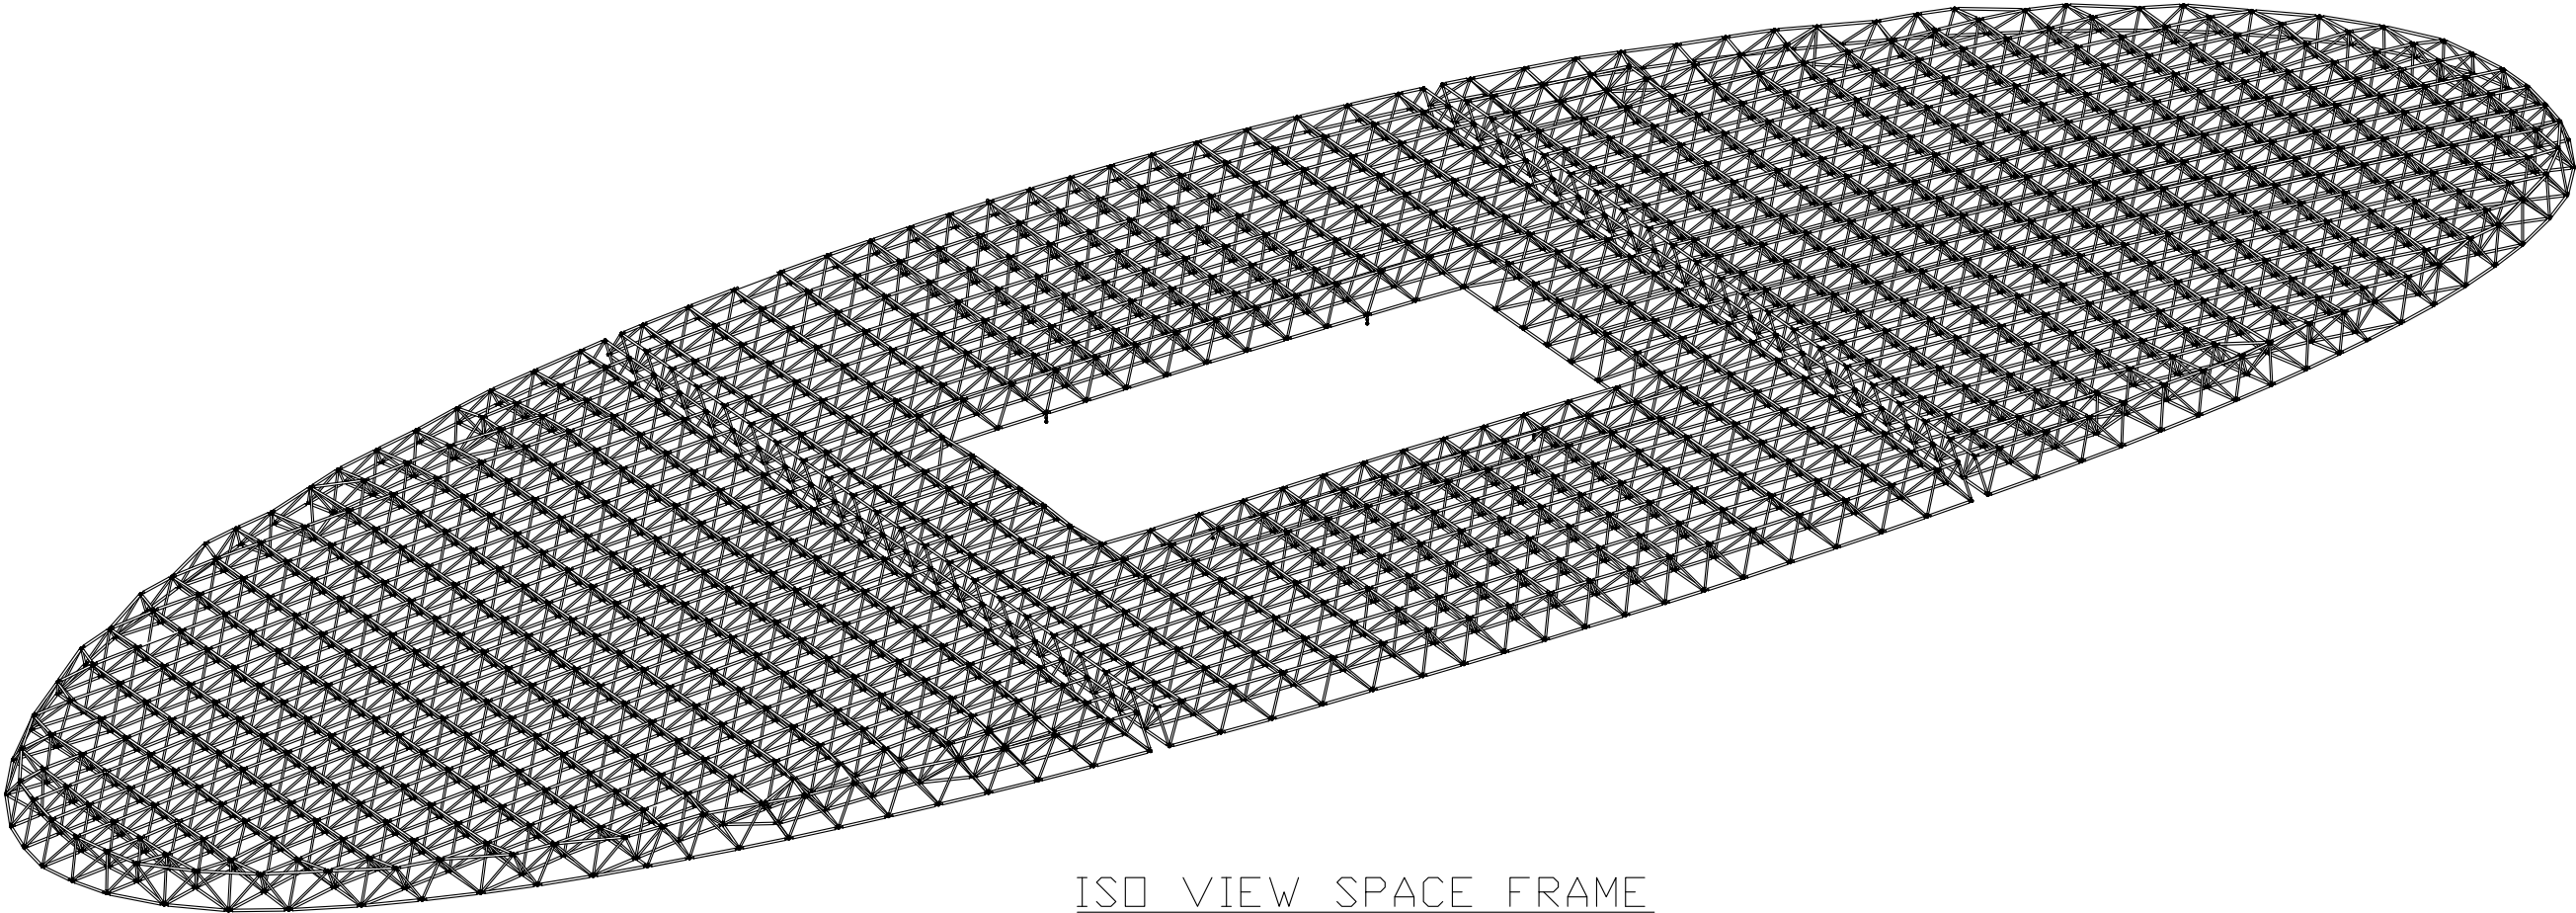

ISO VIEW SPACE FRAME


ISSUE FOR TENDER

NOTES: This drawing is confidential and is the exclusive property of AAA (Pvt)Ltd.and is loaned subject to the condition that it is not to be reproduced orused to furnish for the making of drawing or prints except as sanctioned in writing by AAA (Pvt)Ltd.	
CLIENT NAME	
	
MAIN CONSULTANT	
 Anwar Ali Architects (Pvt.) Ltd. Consulting,Architects,Engineers Planners & Management Consultants 06 HBFC BLOCK A FAISAL TOWN LAHORE	
JV MEMBERS	
 	
STRUCTURAL CONSULTANT	
 AR ENGINEERS Architects, Stuctural, Earthquake Engineering, Geo Technical, Public Health, Highway, Electrical Design Solution. Office # 4, 2nd Floor,Sultana Arcade Firdous Market, Gulberg-III, Lahore. Ph: 042-35831906 03008813921, E-mail: arengineers786@gmail.com	
MEP CONSULTANT	
Project Name	
Consultancy Services for New Air Traffic Control Tower (ATCT), Fire Station and Allied Facilities at Skardu International Airport	
Detailed Structural Design Drawings	
Sheet Name	
ISO VIEW SPACE FRAME	
Date	April, 2026
Scale	NTS
Drawn by	Engr. ABDULLAH JAVAID (Civl/59178)
Checked by	Engr M. Aamir (Civl/10584)
Approved by	Engr. Dr M- Rizwan
Drawing No.	S-15

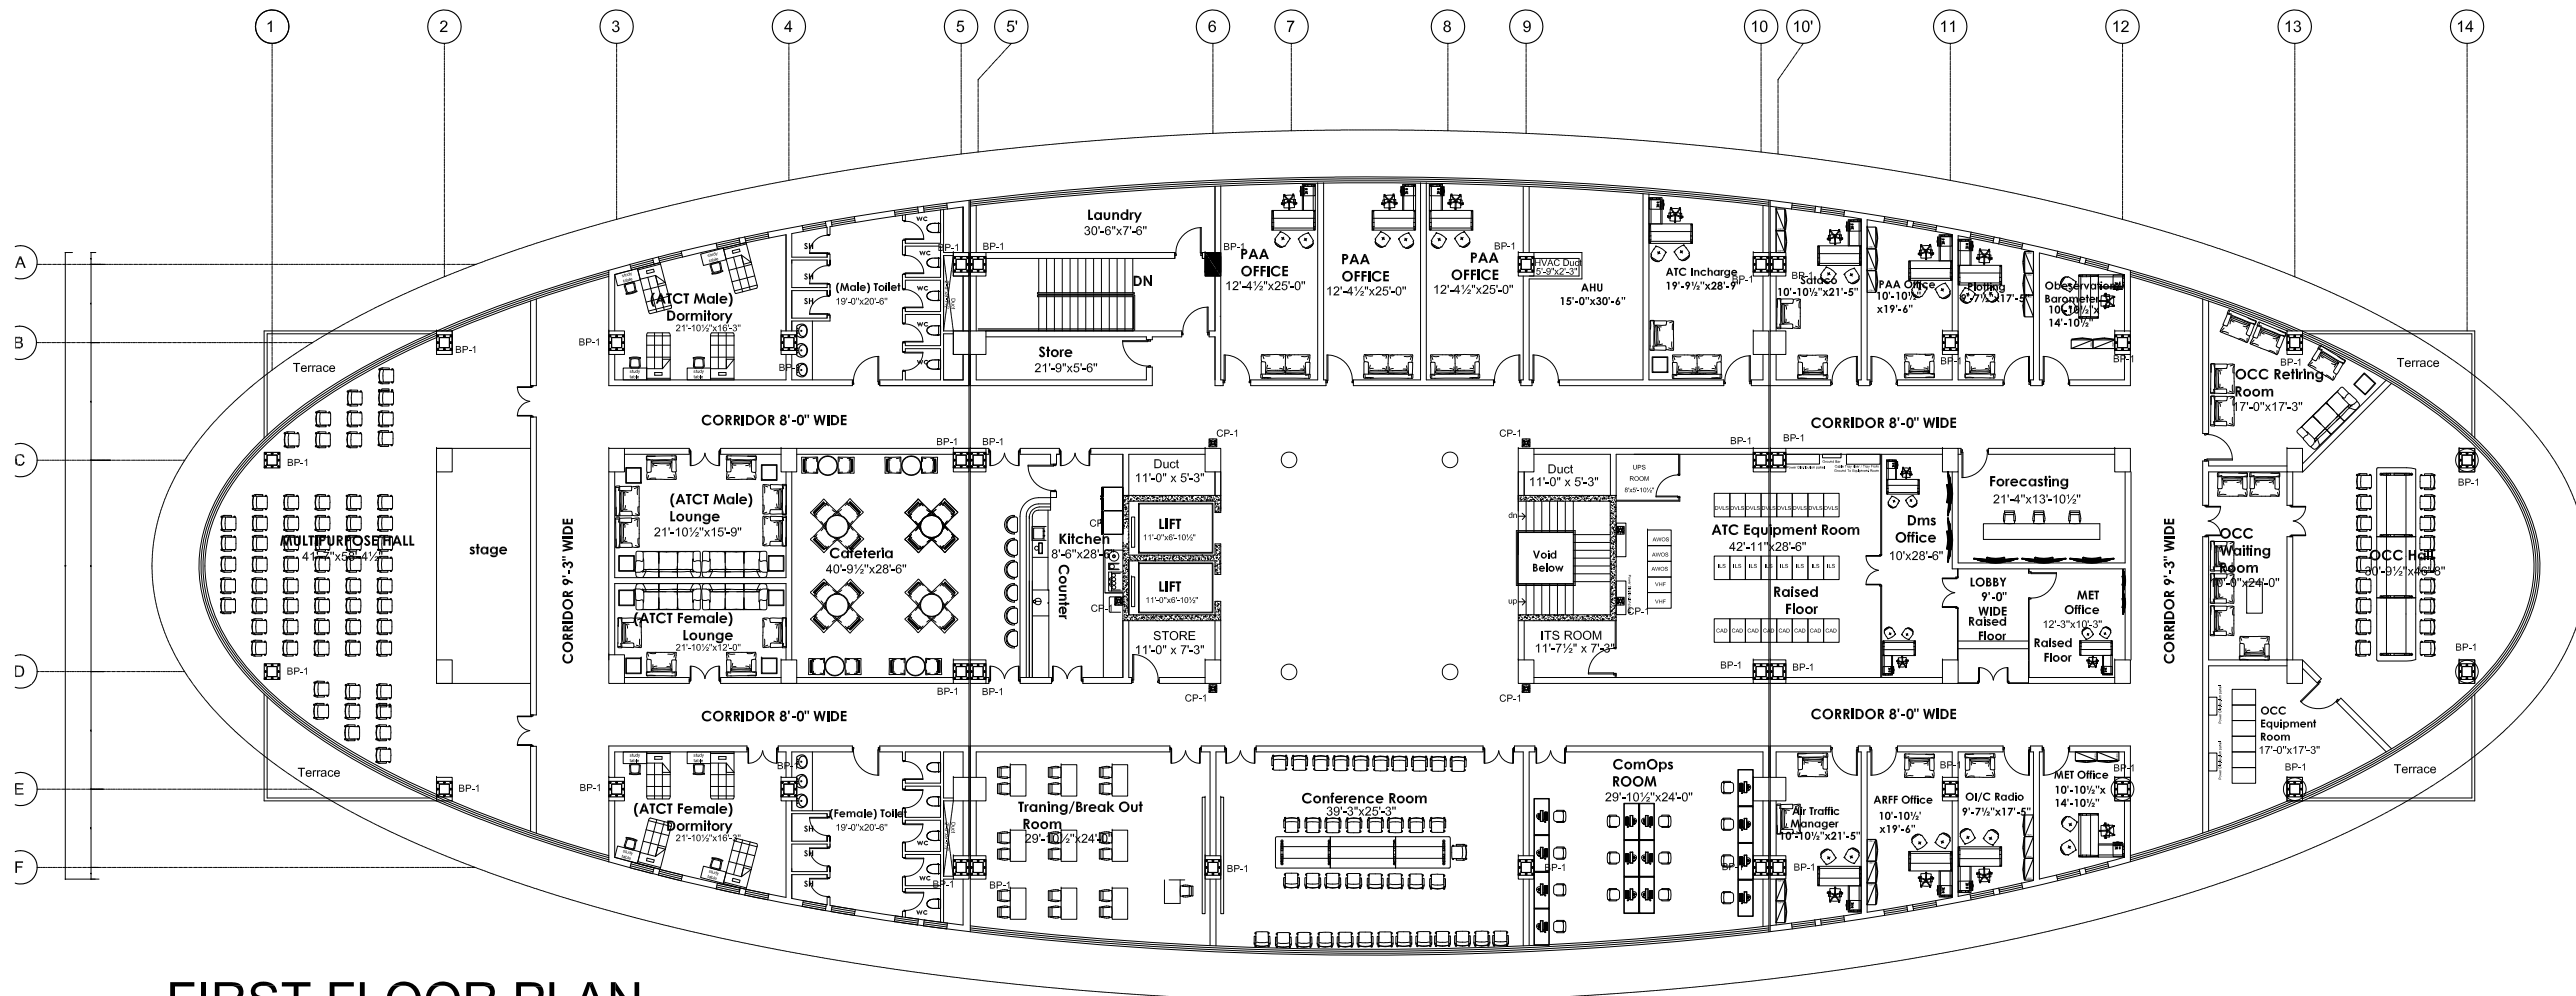

FIRST FLOOR PLAN
Covered Area = 27439 Sft

BASE PLATE & COLUMN LAYOUT PLAN

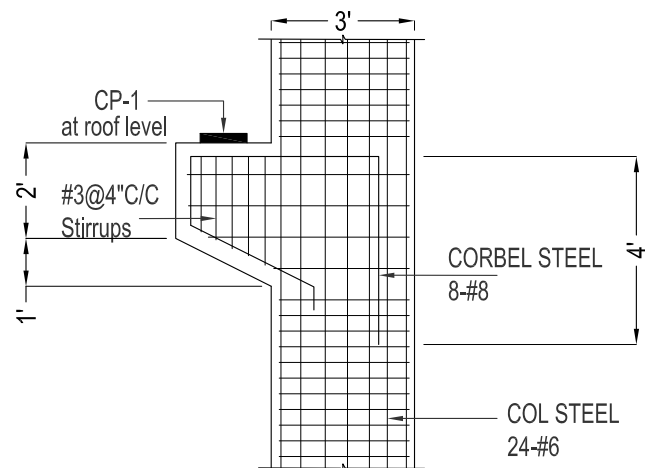

DETAIL "1"

ISSUE FOR TENDER

NOTES:
This drawing is confidential and is the exclusive property of AAA (Pvt)Ltd.and is loaned subject to the condition that it is not to be reproduced or used to furnish for the making of drawing or prints except as sanctioned in writing by AAA (Pvt)Ltd.

CLIENT NAME


پاکستان ایئر پورٹس اتھارٹی

MAIN CONSULTANT


Anwar Ali Architects (Pvt.) Ltd.
Consulting,Architects,Engineers
Planners & Management Consultants
06 HBFC BLOCK A FAISAL TOWN LAHORE

JV MEMBERS


leit-werk

STRUCTURAL CONSULTANT


AR ENGINEERS
Architects, Structural, Earthquake Engineering, Geo Technical,
Public Health, Highway, Electrical Design Solution,
Office # 4, 2nd Floor,Sultana Arcade Firdous Market, Gulberg-III, Lahore.
Ph: 042-35831906 03008813921, E-mail: arengineers78@gmail.com

MEP CONSULTANT

Project Name
Consultancy Services for
New Air Traffic Control Tower
(ATCT), Fire Station and Allied
Facilities at Skardu
International Airport

**Detailed Structural
Design Drawings**

Sheet Name
BASE PLATE & COL LAYOUT

Date	April, 2026
Scale	NTS
Drawn by	Engr. ABDULLAH JAVAID (CIVIL/59178)
Checked by	Engr M. Aamir (CIVIL/10584)
Approved by	Engr. Dr M- Rizwan
Drawing No.	S-16