

NOTES:

This drawing is confidential and is the exclusive property of AAA (Pvt)Ltd.and is loaned subject to the condition that it is not to be reproduced orused to furnish for the making of drawing or prints except as sanctioned in writing by AAA (Pvt)Ltd.

CLIENT NAME



MAIN CONSULTANT



JV MEMBERS



STRUCTURAL CONSULTANT



MEP CONSULTANT



Project Name


Consultancy Services for New Air Traffic Control Tower (ATCT), Fire Station and Allied Facilities at Skardu International Airport

DETAILED ELECTRICAL Design Drawings

Sheet Name


TELEPHONE & TV SYSTEM LAYOUT

Date	April, 2026
Scale	NTS
Drawn by	A.S.B
Checked by	M.K
Approved by	M.F
Drawing No.	E-36

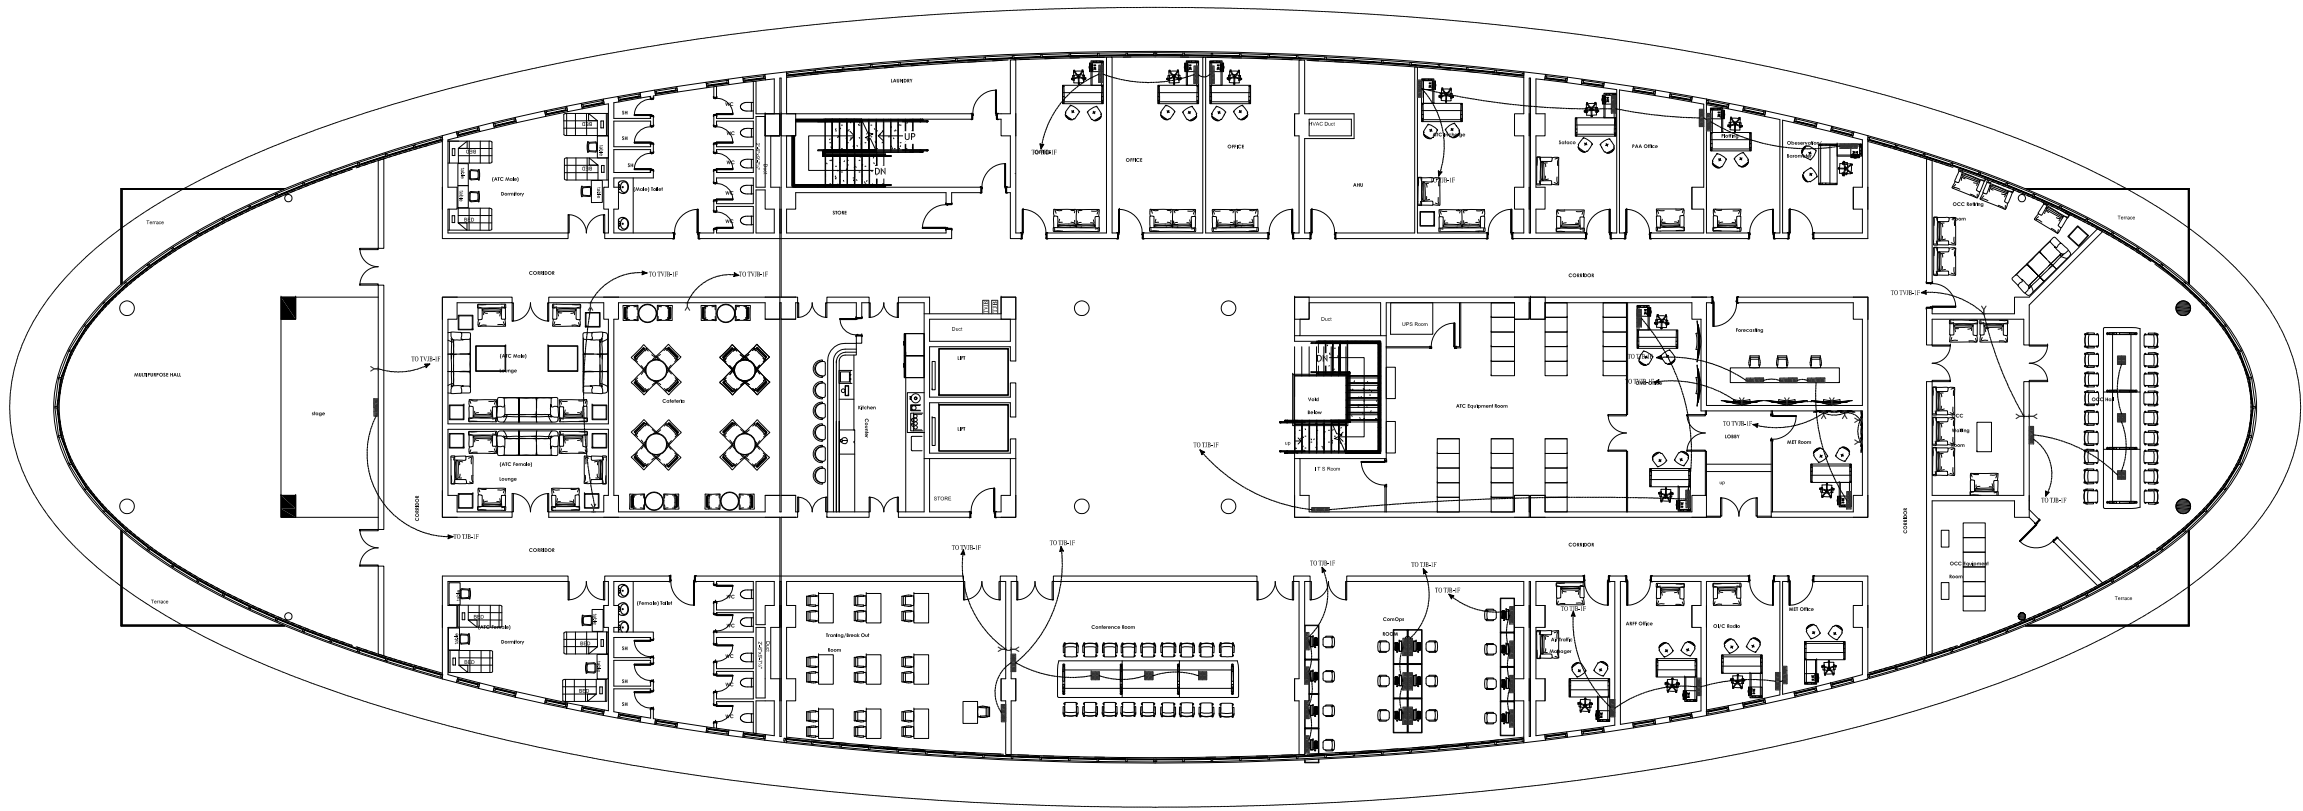

FIRST FLOOR PLAN


ISSUE FOR TENDER

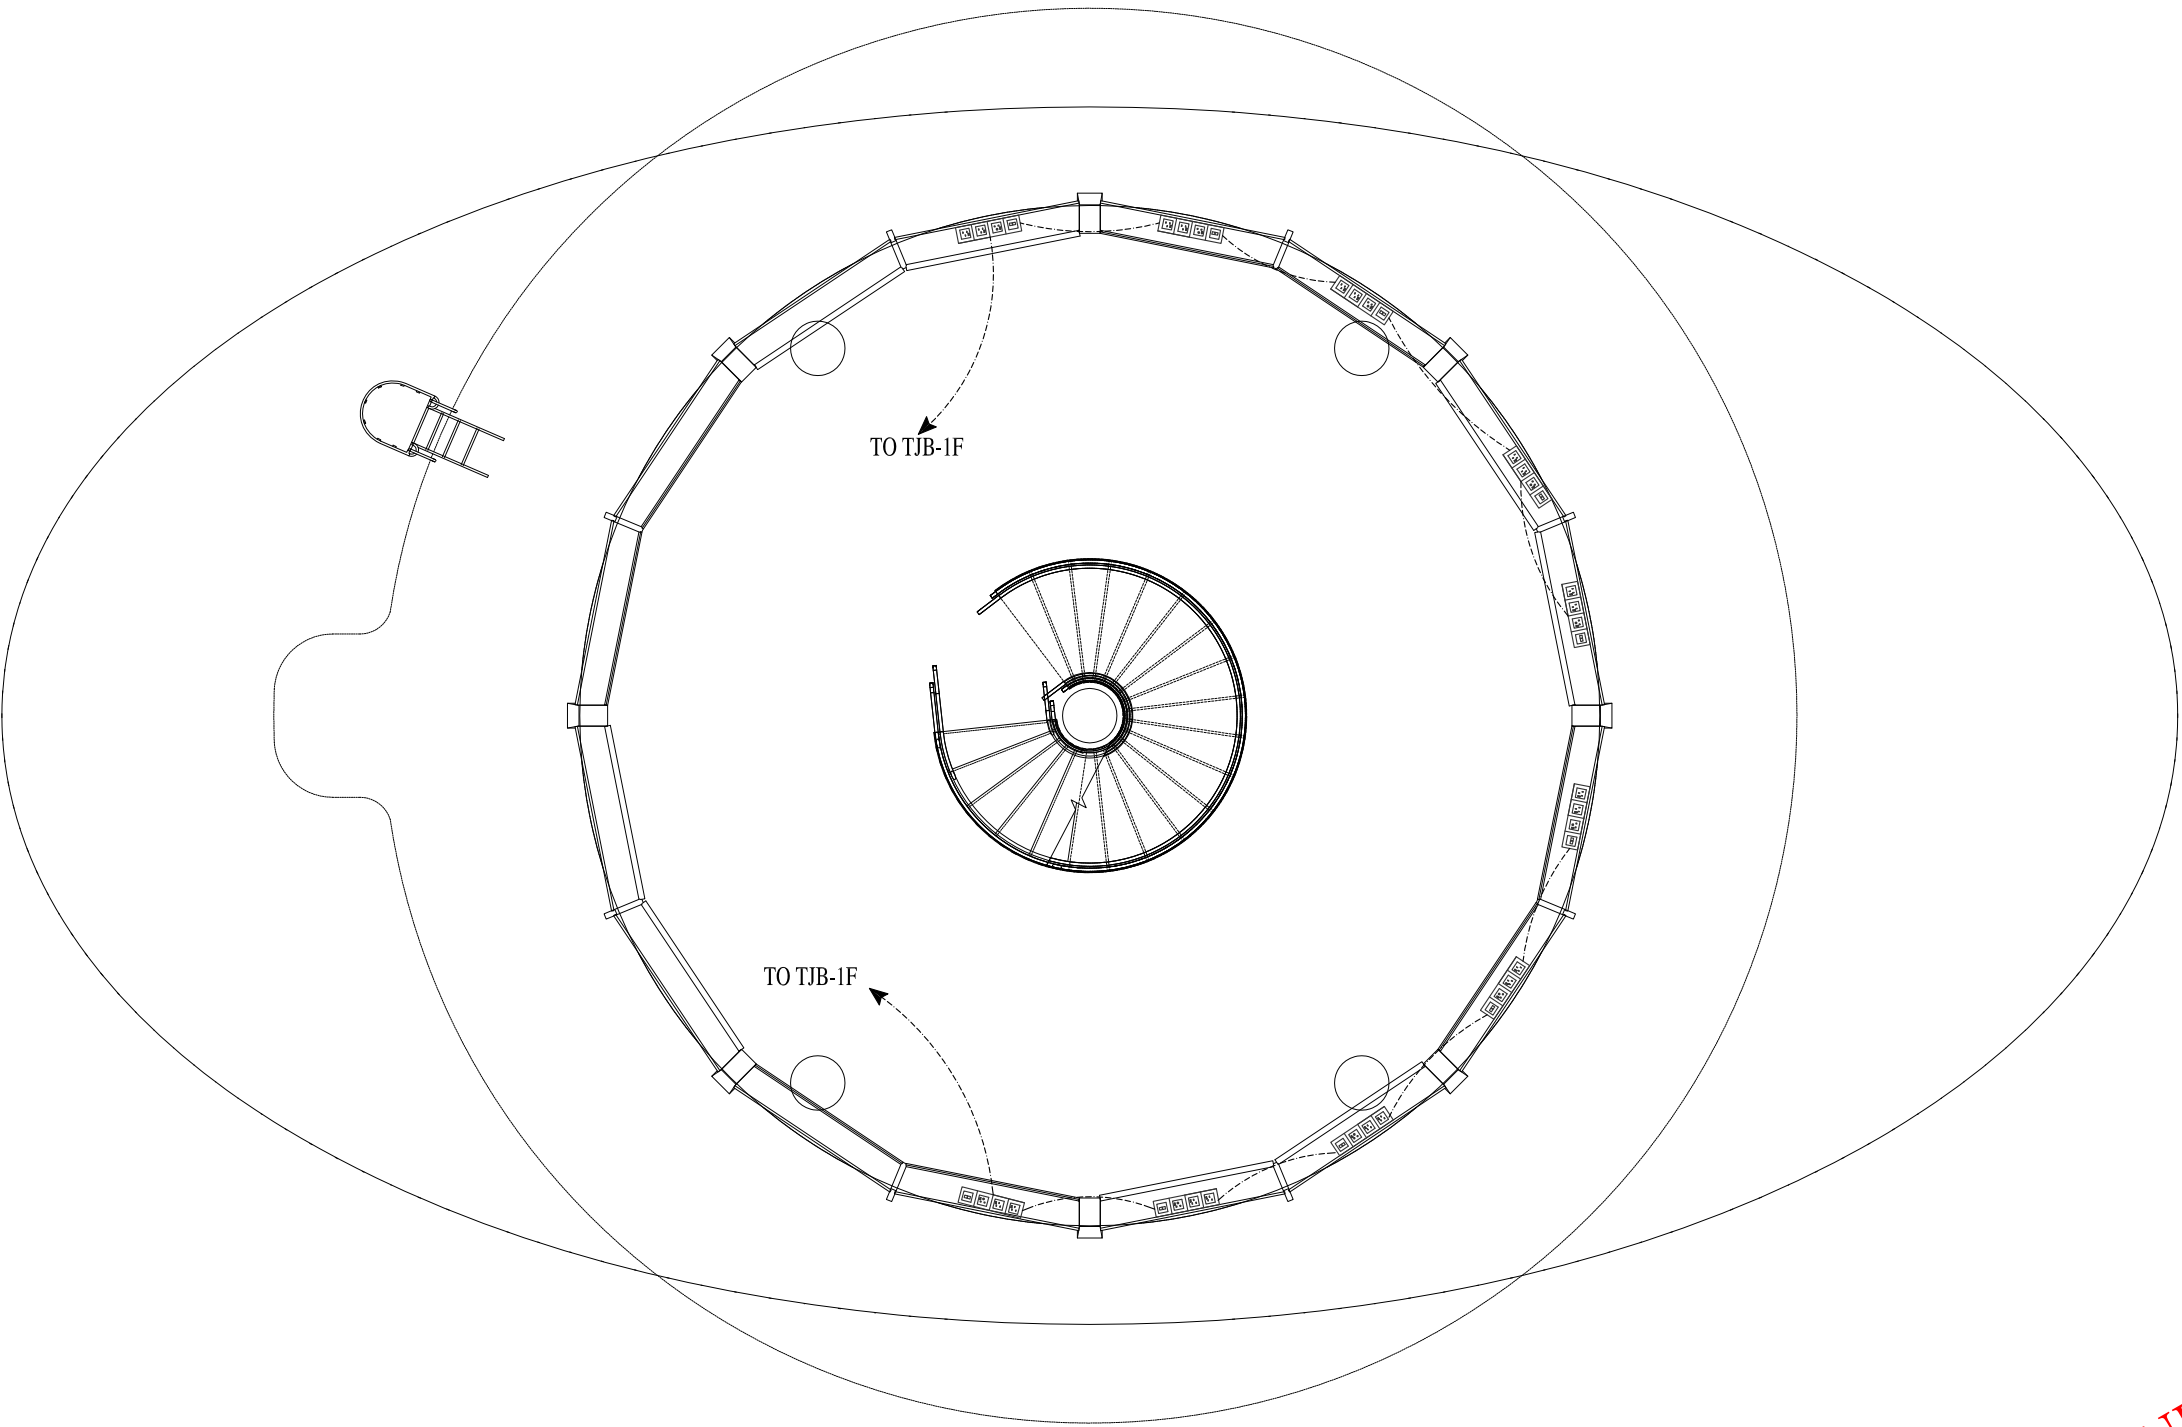

ARFF FLOOR PLAN LEVEL AT 53'-6"
COVERED AREA 2123 Sft

ISSUE FOR TENDER

NOTES: This drawing is confidential and is the exclusive property of AAA (Pvt)Ltd.and is loaned subject to the condition that it is not to be reproduced orused to furnish for the making of drawing or prints except as sanctioned in writing by AAA (Pvt)Ltd.	
CLIENT NAME	
MAIN CONSULTANT	
 Anwar Ali Architects (Pvt.) Ltd. Consulting,Architects,Engineers Planners & Management Consultants 06 HBFC BLOCK A FAISAL TOWN LAHORE	
JV MEMBERS	
STRUCTURAL CONSULTANT	
 AR ENGINEERS Architects, Structural, Earthquake Engineering, Geo Technical, Public Health, Highway, Electrical Design Solution. Office # A, 2nd Floor,Sultana Arcade Firdous Market, Gulberg-II, Lahore. Ph: 042-35831908 03008813921, E-mail: arengineers78@gmail.com	
MEP CONSULTANT	
 ABSTRACTORS MEP CONSULTANT SUITE-14,3RD FLOOR JINNAH MALL IZMIR TOWN, IZMIR Cell no: 0322-3924199 E-mail: abstractorseng@gmail.com	
Project Name	
Consultancy Services for New Air Traffic Control Tower (ATCT), Fire Station and Allied Facilities at Skardu International Airport	
DETAILED ELECTRICAL Design Drawings	
Sheet Name	
TELEPHONE & TV SYSTEM LAYOUT	
Date	April, 2026
Scale	NTS
Drawn by	A.S.B
Checked by	M.K
Approved by	M.F
Drawing No.	E-37

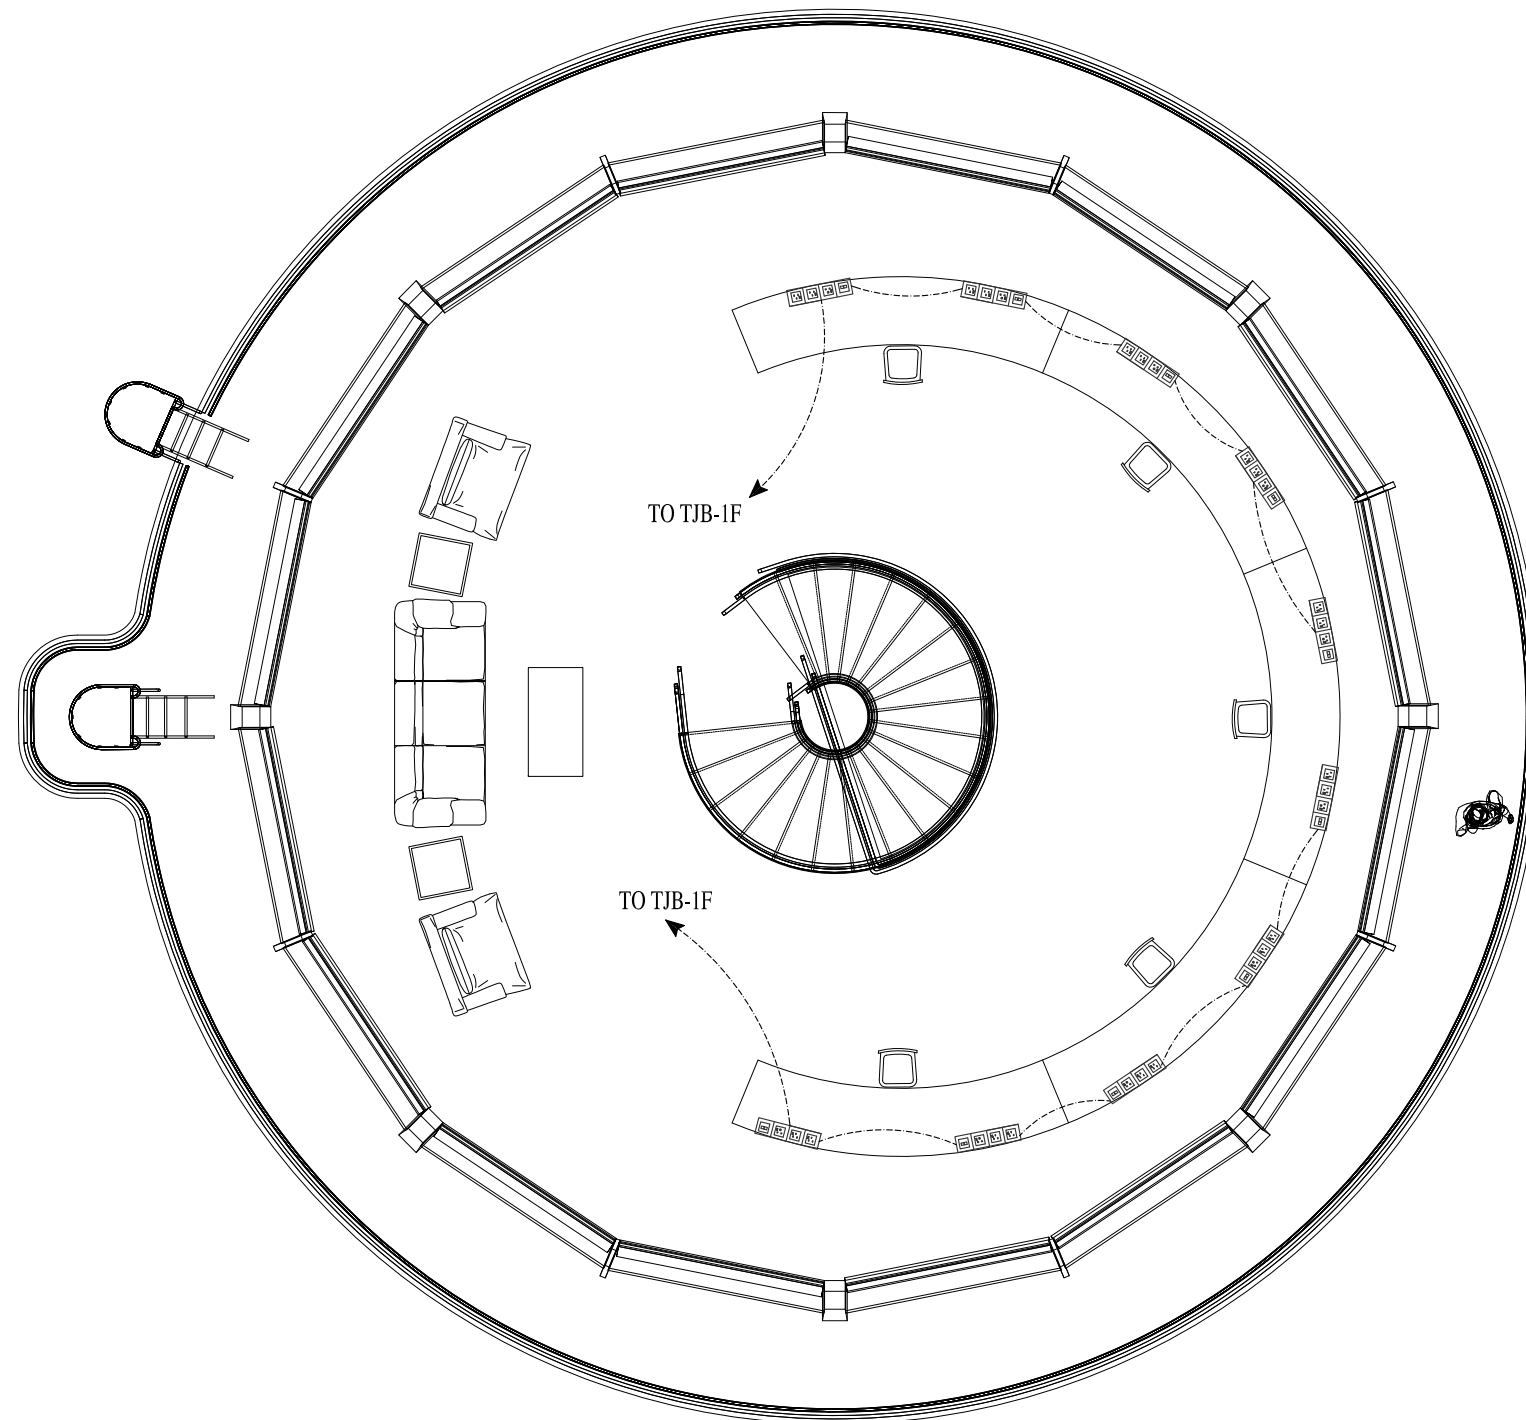

ATCT FLOOR PLAN LEVEL AT 65'-6"
COVERED AREA 1548 Sft

ISSUE FOR TENDER

NOTES:

This drawing is confidential and is the exclusive property of AAA (Pvt)Ltd.and is loaned subject to the condition that it is not to be reproduced or used to furnish for the making of drawing or prints except as sanctioned in writing by AAA (Pvt)Ltd.

CLIENT NAME



MAIN CONSULTANT



JV MEMBERS



STRUCTURAL CONSULTANT



MEP CONSULTANT



Project Name


Consultancy Services for New Air Traffic Control Tower (ATCT), Fire Station and Allied Facilities at Skardu International Airport

DETAILED ELECTRICAL Design Drawings

Sheet Name

TELEPHONE & TV SYSTEM LAYOUT


Date	April, 2026
Scale	NTS
Drawn by	A.S.B
Checked by	M.K
Approved by	M.F
Drawing No.	E-38

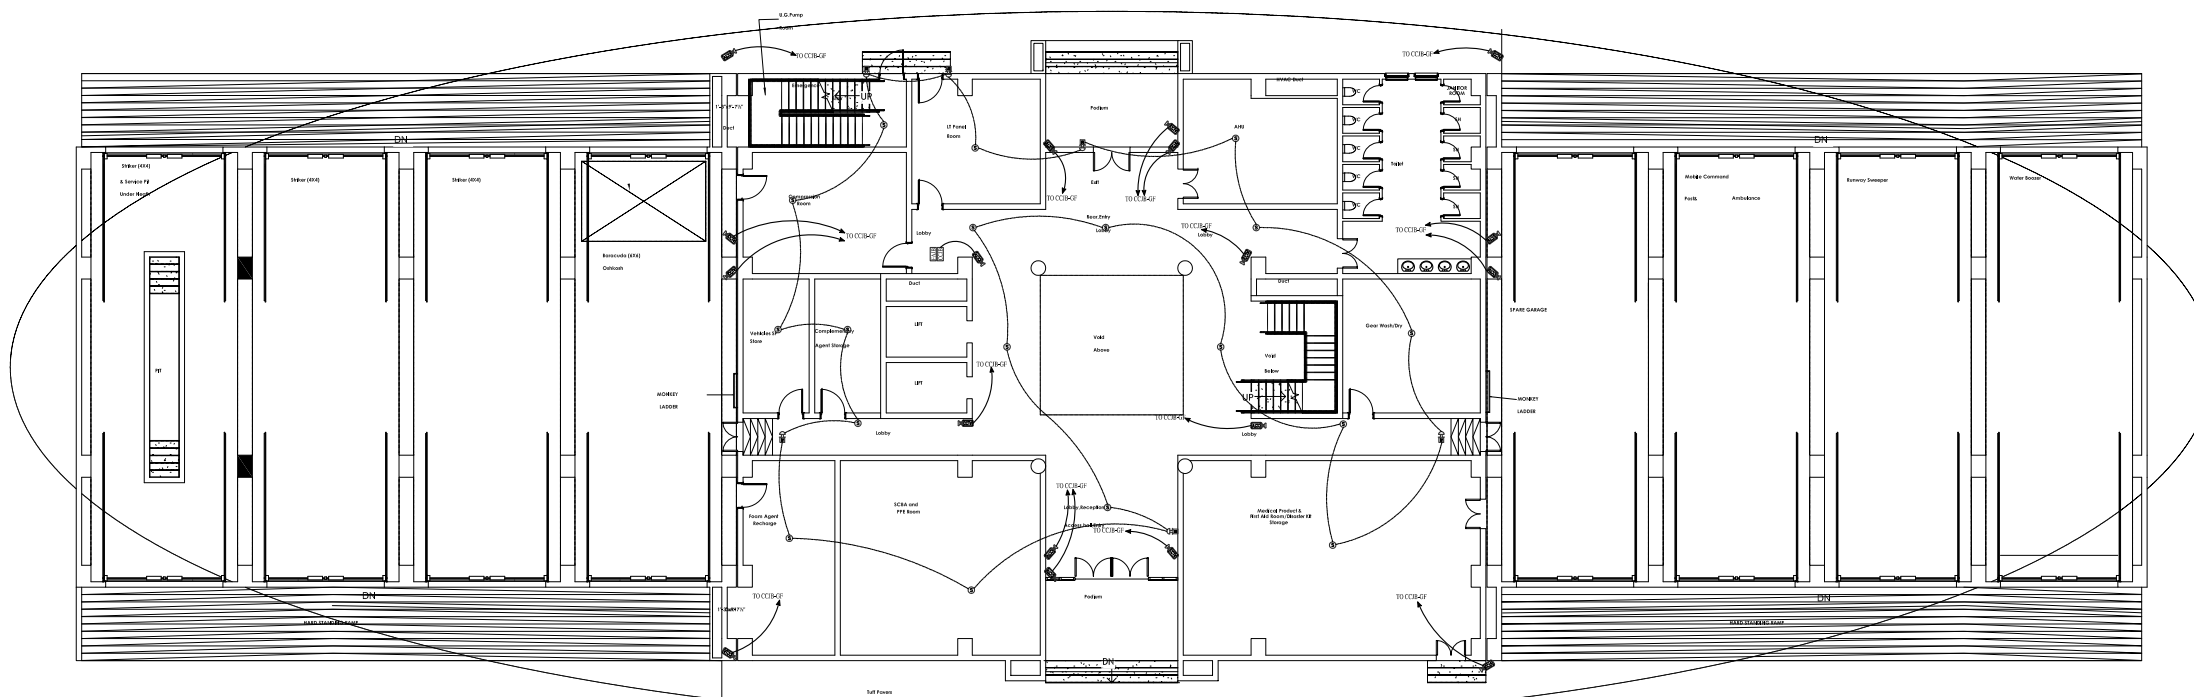

GROUND FLOOR PLAN

ISSUE FOR TENDER

NOTES: This drawing is confidential and is the exclusive property of AAA (Pvt)Ltd.and is loaned subject to the condition that it is not to be reproduced orused to furnish for the making of drawing or prints except as sanctioned in writing by AAA (Pvt)Ltd.	
CLIENT NAME	
MAIN CONSULTANT	
JV MEMBERS	
STRUCTURAL CONSULTANT	
MEP CONSULTANT	
Project Name	
Consultancy Services for New Air Traffic Control Tower (ATCT), Fire Station and Allied Facilities at Skardu International Airport	
DETAILED ELECTRICAL Design Drawings	
Sheet Name	
FIRE ALARM & CCTV SYSTEM LAYOUT	
Date	April, 2026
Scale	NTS
Drawn by	A.S.B
Checked by	M.K
Approved by	M.F
Drawing No.	E-39

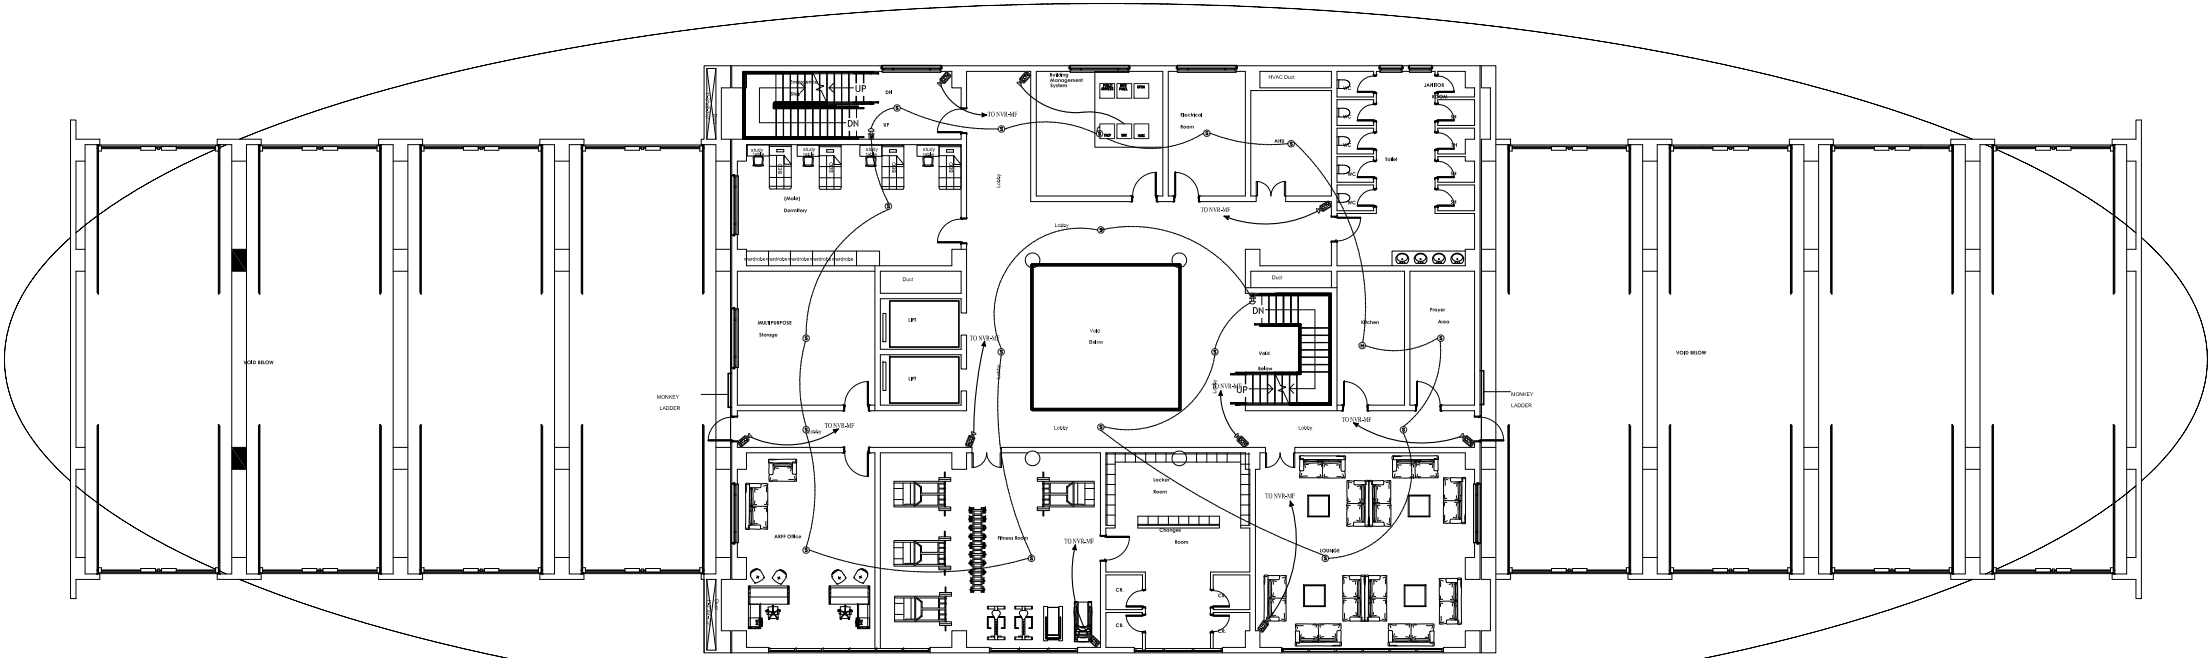

ARFF FLOOR
MEZZANINE FLOOR PLAN

ISSUE FOR TENDER

NOTES: This drawing is confidential and is the exclusive property of AAA (Pvt)Ltd.and is loaned subject to the condition that it is not to be reproduced orused to furnish for the making of drawing or prints except as sanctioned in writing by AAA (Pvt)Ltd.	
CLIENT NAME	
MAIN CONSULTANT	
JV MEMBERS	
STRUCTURAL CONSULTANT	
MEP CONSULTANT	
Project Name	
Consultancy Services for New Air Traffic Control Tower (ATCT), Fire Station and Allied Facilities at Skardu International Airport	
DETAILED ELECTRICAL Design Drawings	
Sheet Name	
FIRE ALARM & CCTV SYSTEM LAYOUT	
Date	April, 2026
Scale	NTS
Drawn by	A.S.B
Checked by	M.K
Approved by	M.F
Drawing No.	E-40

NOTES:

This drawing is confidential and is the exclusive property of AAA (Pvt)Ltd.and is loaned subject to the condition that it is not to be reproduced orused to furnish for the making of drawing or prints except as sanctioned in writing by AAA (Pvt)Ltd.

CLIENT NAME



MAIN CONSULTANT



JV MEMBERS



STRUCTURAL CONSULTANT



MEP CONSULTANT



Project Name


Consultancy Services for New Air Traffic Control Tower (ATCT), Fire Station and Allied Facilities at Skardu International Airport

DETAILED ELECTRICAL Design Drawings

Sheet Name


FIRE ALARM & CCTV SYSTEM LAYOUT

Date	April, 2026
Scale	NTS
Drawn by	A.S.B
Checked by	M.K
Approved by	M.F
Drawing No.	E-41

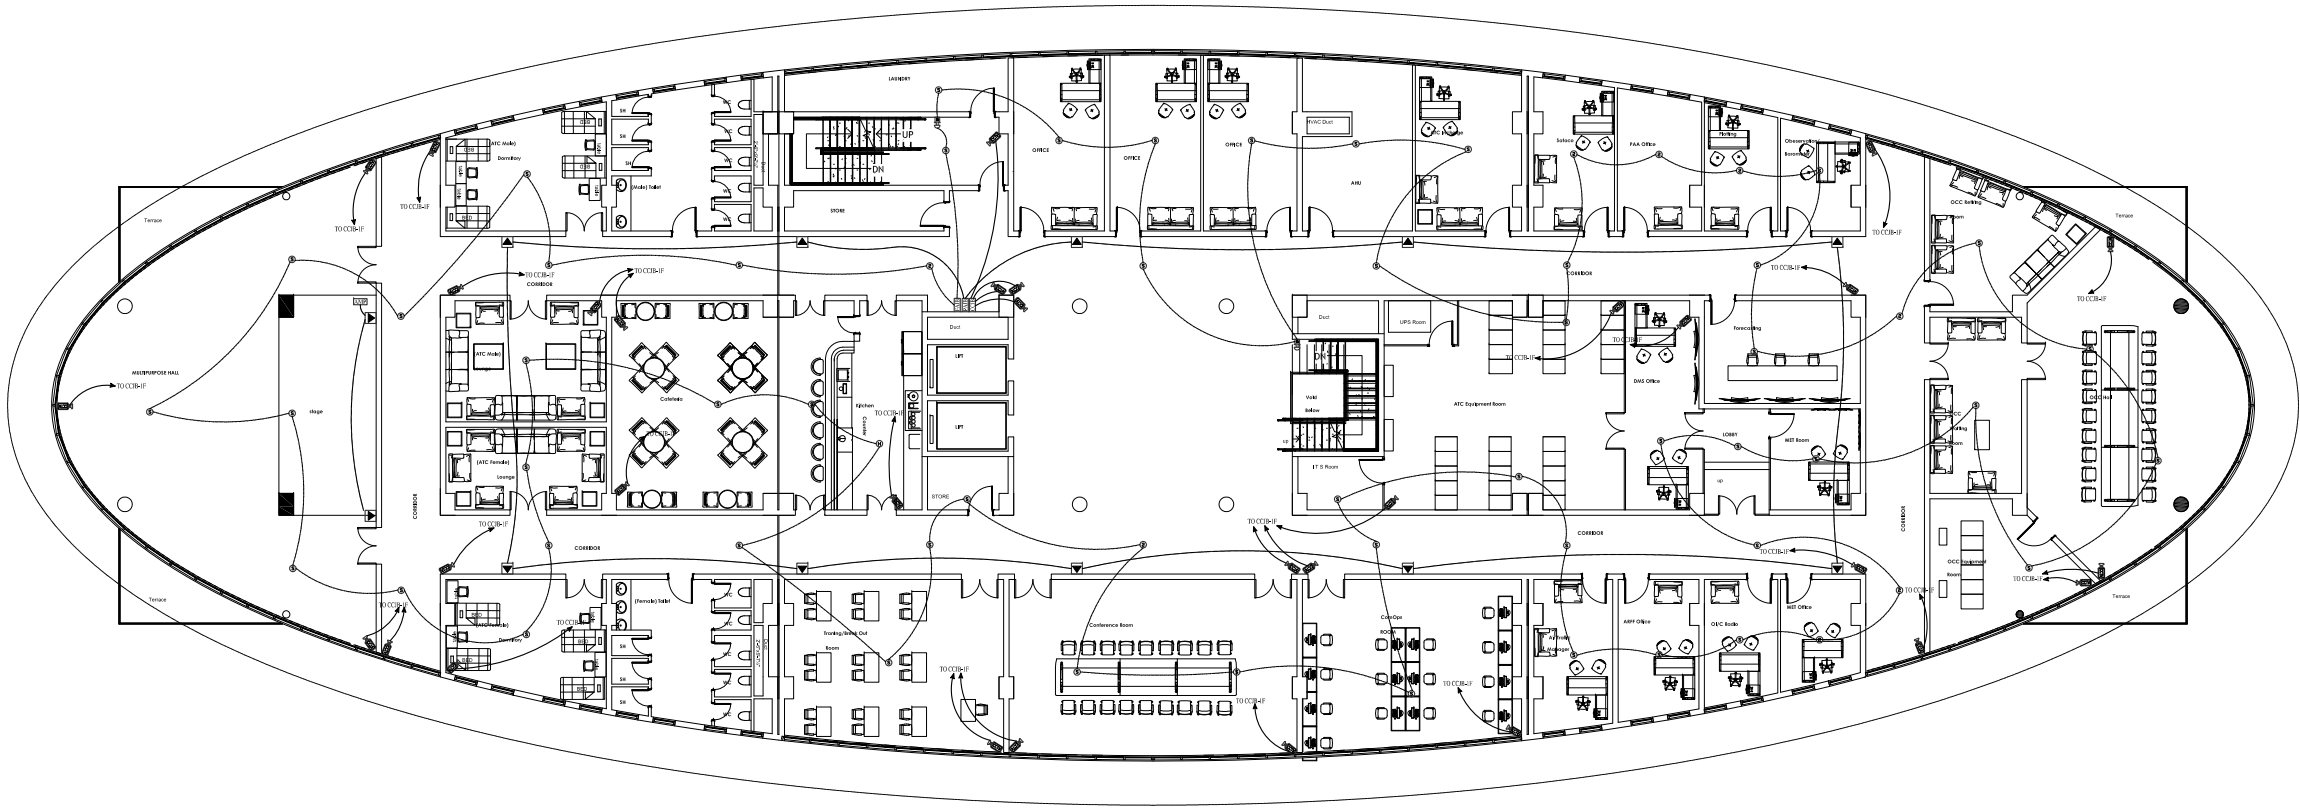

FIRST FLOOR PLAN


ISSUE FOR TENDER

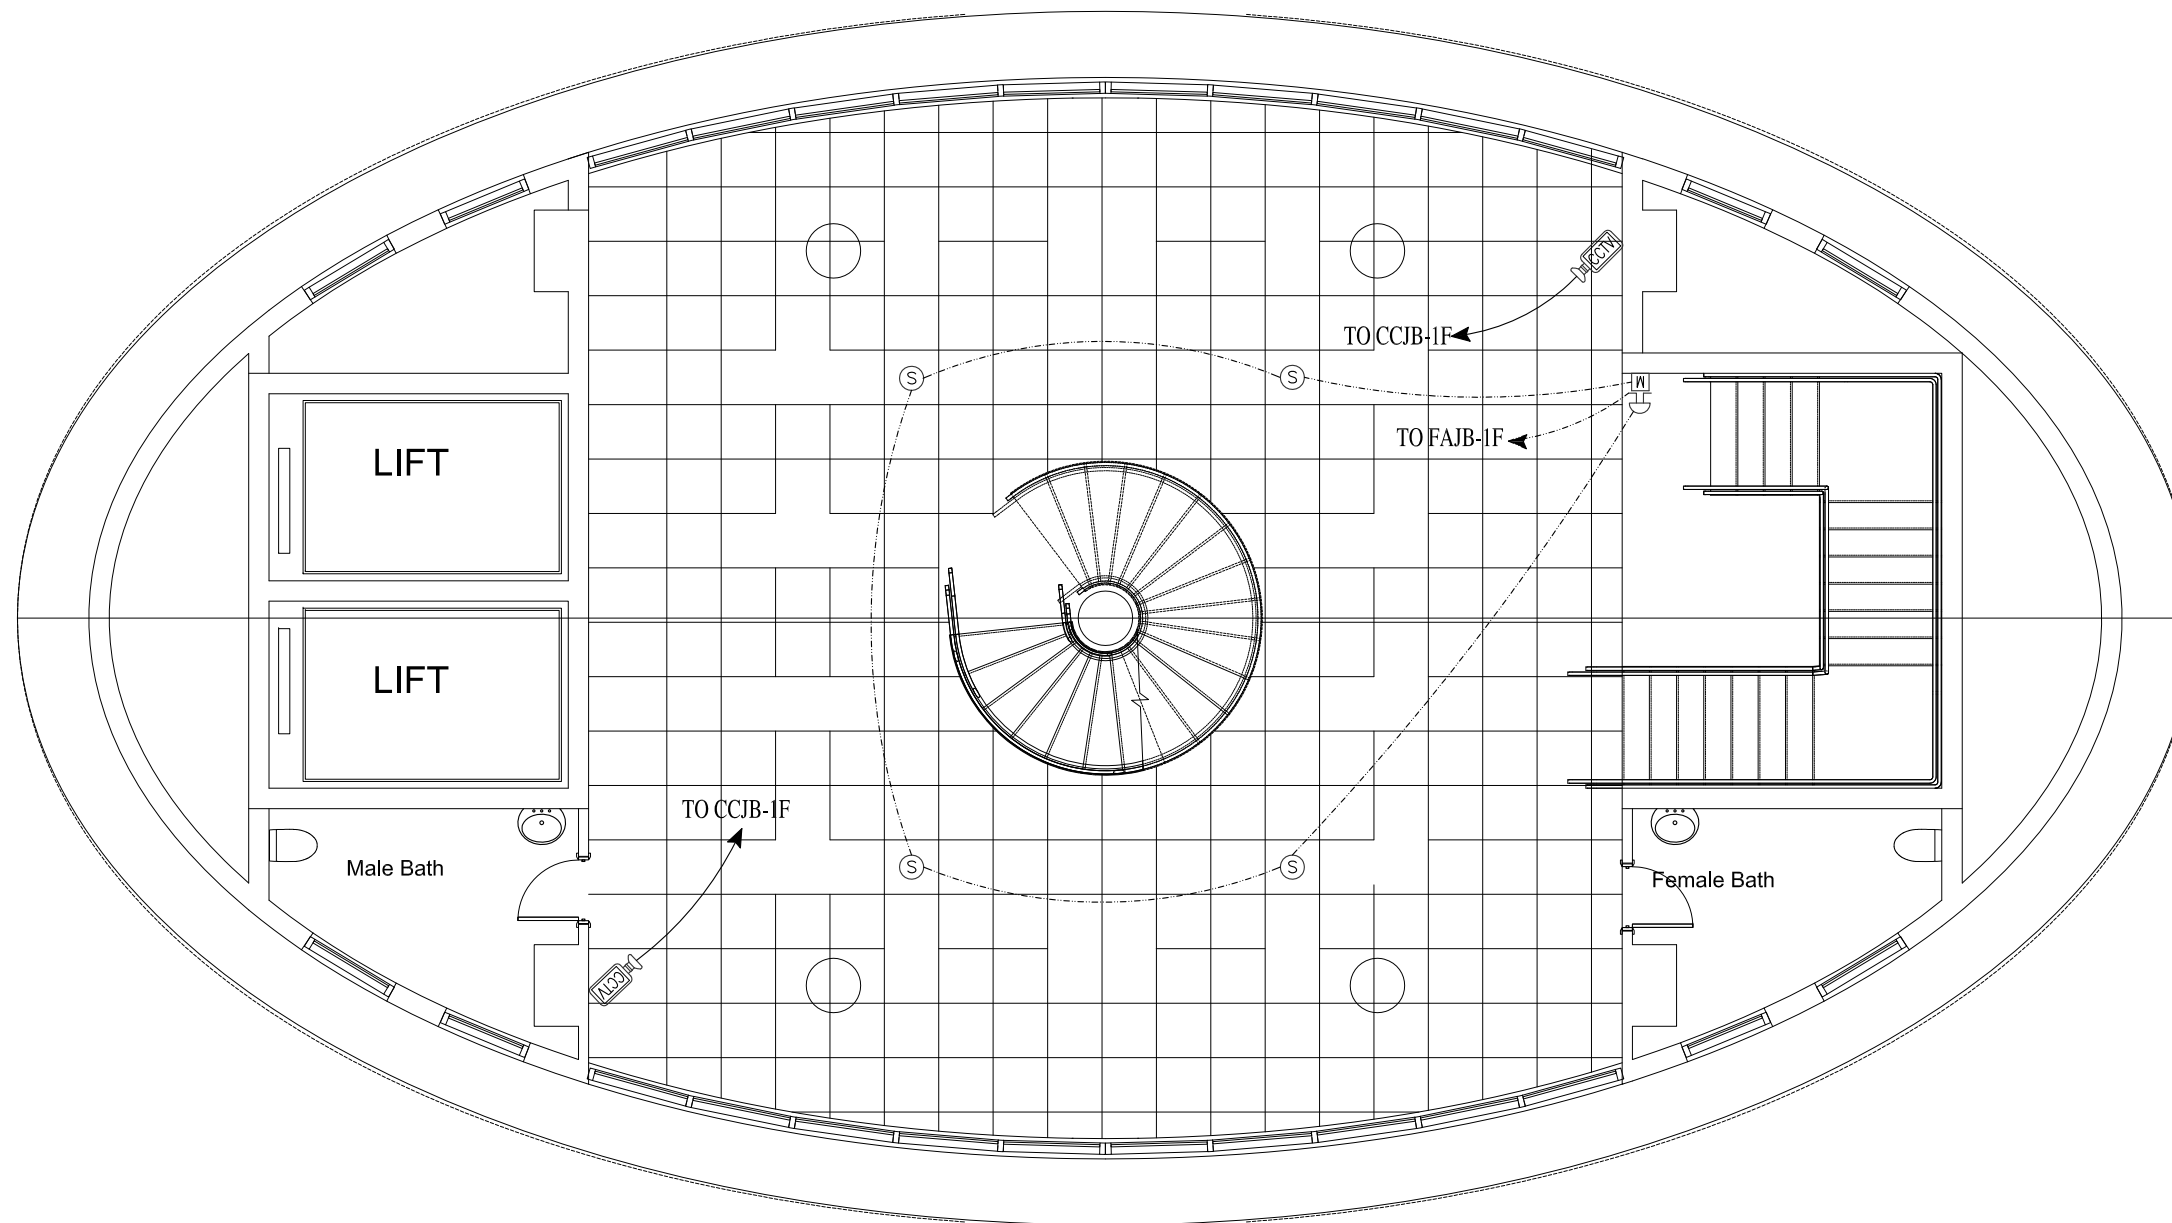

ROOF FLOOR PLAN LEVEL AT 43'-6"
COVERED AREA 2802 Sft

ISSUE FOR TENDER


NOTES: This drawing is confidential and is the exclusive property of AAA (Pvt)Ltd.and is loaned subject to the condition that it is not to be reproduced orused to furnish for the making of drawing or prints except as sanctioned in writing by AAA (Pvt)Ltd.	
CLIENT NAME	
MAIN CONSULTANT	
JV MEMBERS	
STRUCTURAL CONSULTANT	
MEP CONSULTANT	
Project Name	
Consultancy Services for New Air Traffic Control Tower (ATCT), Fire Station and Allied Facilities at Skardu International Airport	
DETAILED ELECTRICAL Design Drawings	
Sheet Name	
FIRE ALARM & CCTV SYSTEM LAYOUT	
Date	April, 2026
Scale	NTS
Drawn by	A.S.B
Checked by	M.K
Approved by	M.F
Drawing No.	E-42

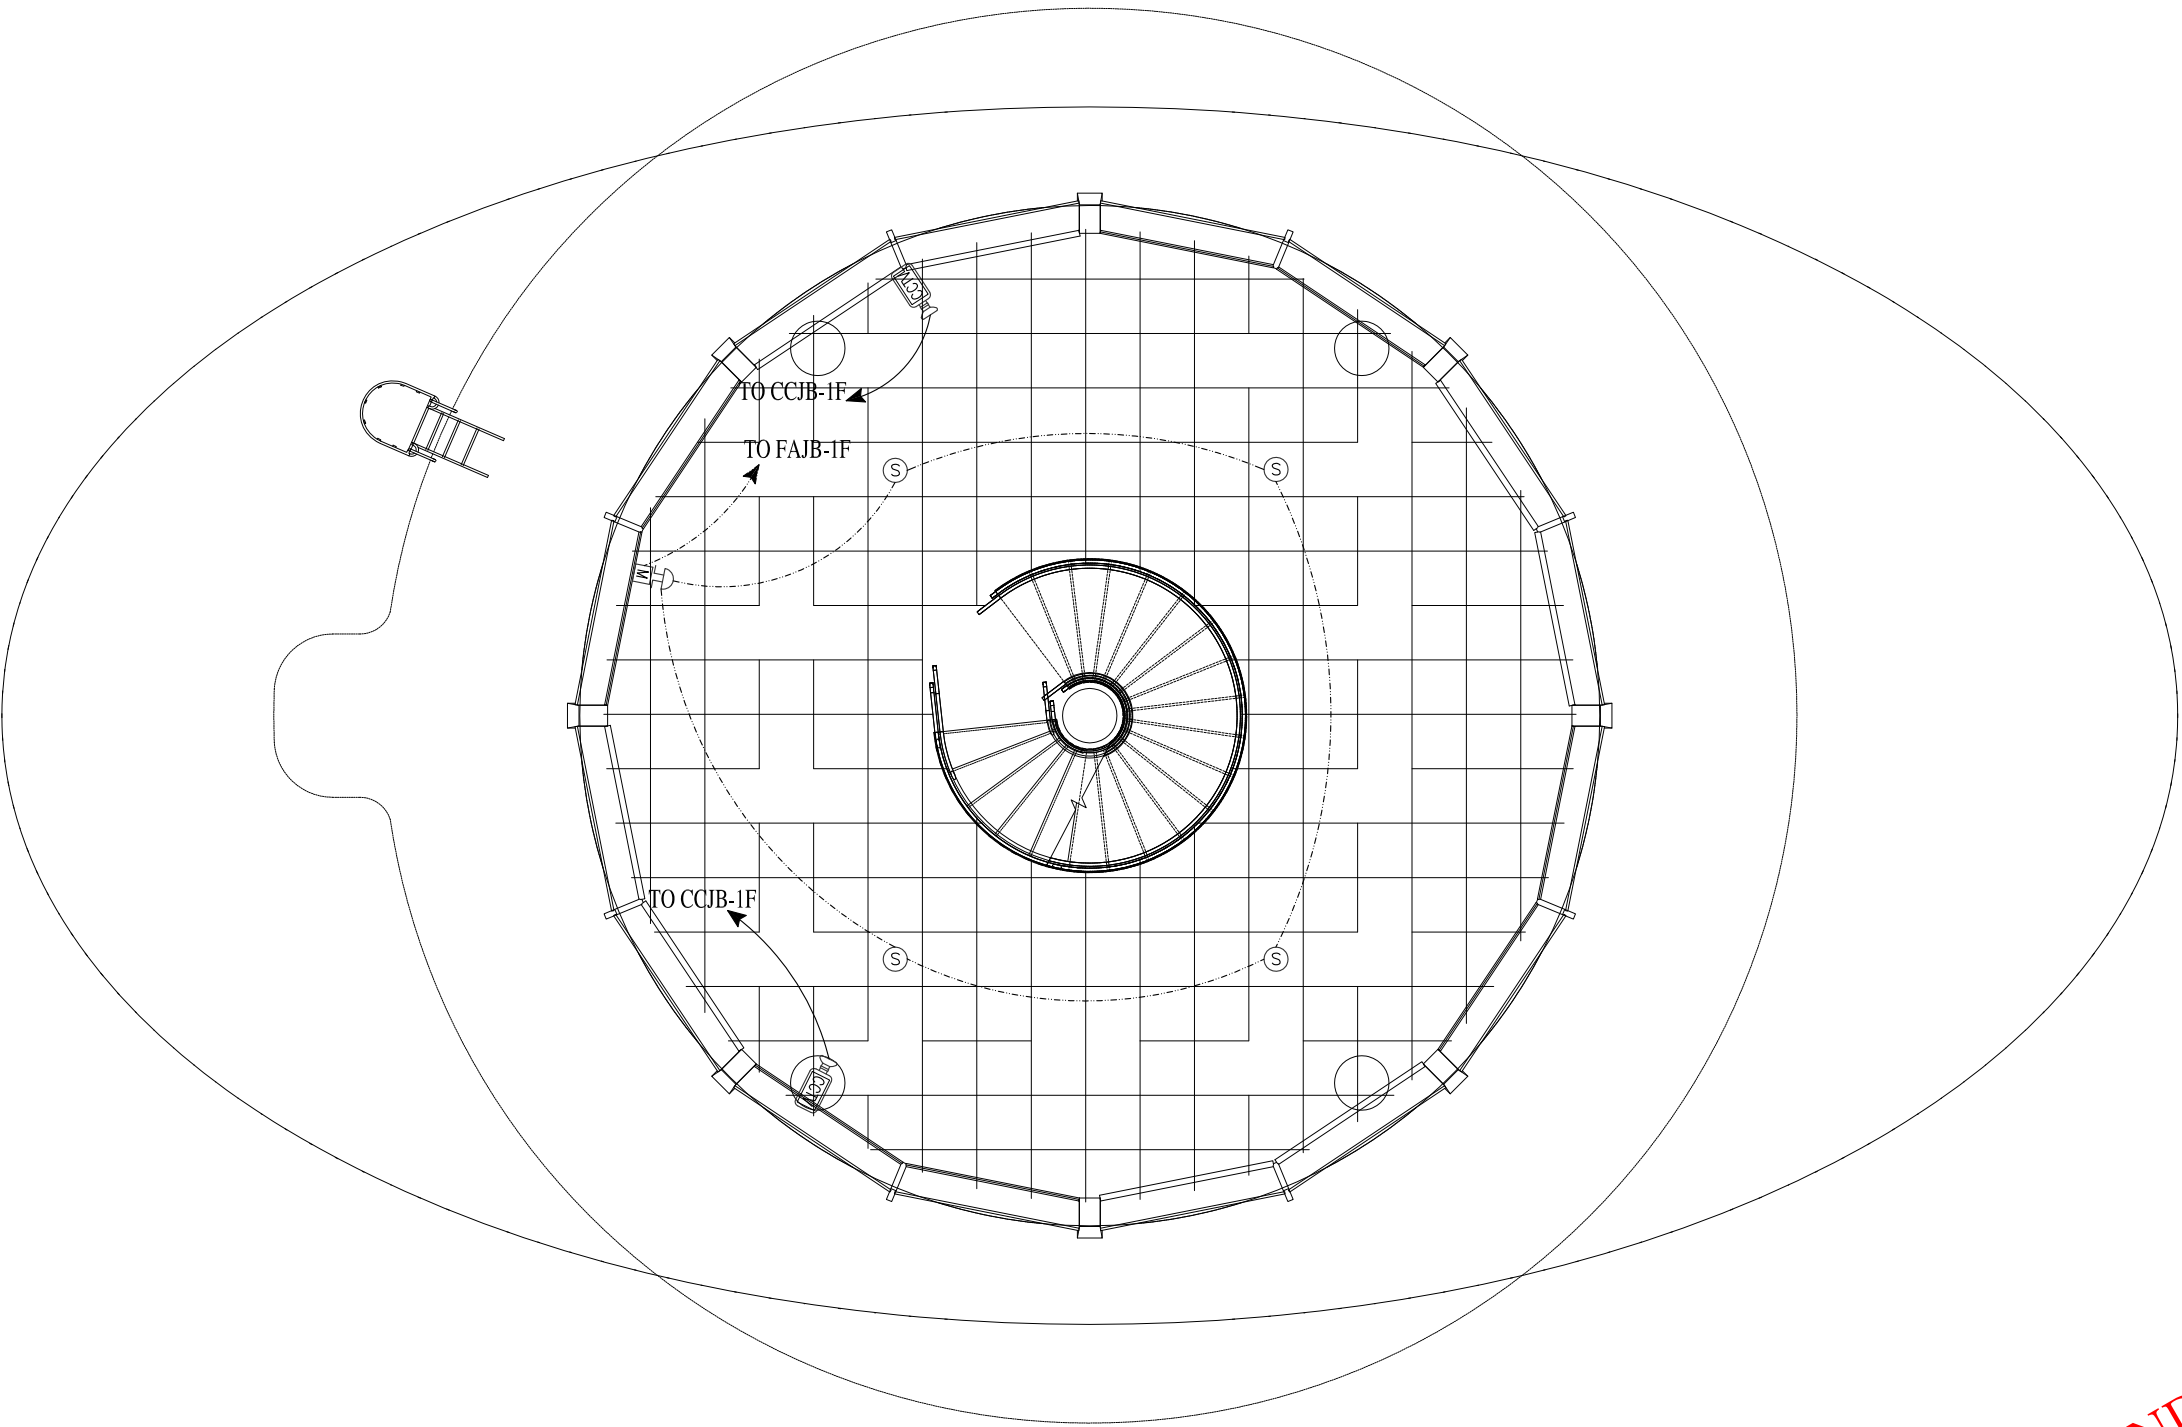

ARFF FLOOR PLAN LEVEL AT 53'-6"
COVERED AREA 2123 Sft

ISSUE FOR TENDER

NOTES: This drawing is confidential and is the exclusive property of AAA (Pvt)Ltd.and is loaned subject to the condition that it is not to be reproduced orused to furnish for the making of drawing or prints except as sanctioned in writing by AAA (Pvt)Ltd.	
CLIENT NAME	
MAIN CONSULTANT	
JV MEMBERS	
STRUCTURAL CONSULTANT	
MEP CONSULTANT	
Project Name	
Consultancy Services for New Air Traffic Control Tower (ATCT), Fire Station and Allied Facilities at Skardu International Airport	
DETAILED ELECTRICAL Design Drawings	
Sheet Name	
FIRE ALARM & CCTV SYSTEM LAYOUT	
Date	April, 2026
Scale	NTS
Drawn by	A.S.B
Checked by	M.K
Approved by	M.F
Drawing No.	E-43

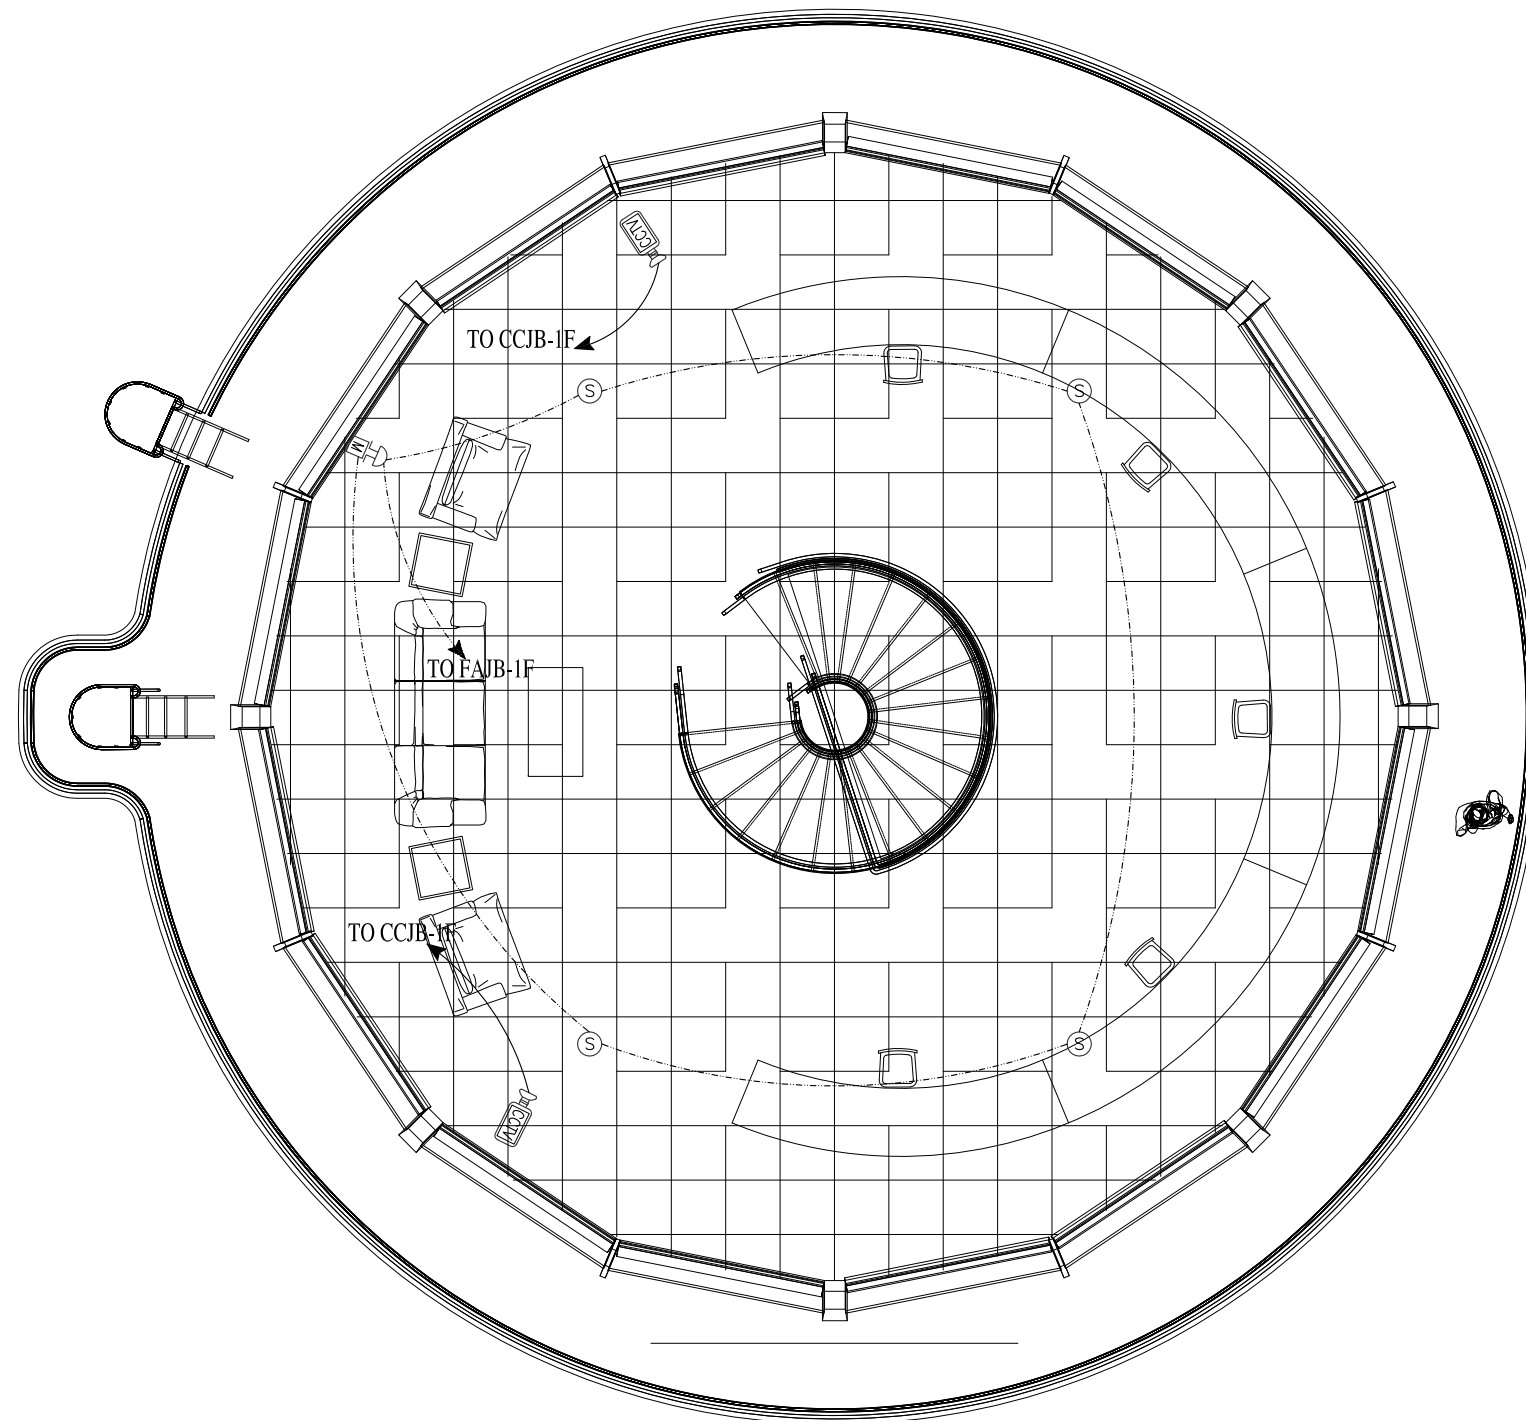

ATCT FLOOR PLAN LEVEL AT 65'-6"
COVERED AREA 1548 Sft

ISSUE FOR TENDER

NOTES:

This drawing is confidential and is the exclusive property of AAA (Pvt)Ltd.and is loaned subject to the condition that it is not to be reproduced or used to furnish for the making of drawing or prints except as sanctioned in writing by AAA (Pvt)Ltd.

CLIENT NAME



MAIN CONSULTANT



JV MEMBERS

leit-werk



STRUCTURAL CONSULTANT



MEP CONSULTANT



Project Name


Consultancy Services for New Air Traffic Control Tower (ATCT), Fire Station and Allied Facilities at Skardu International Airport

DETAILED ELECTRICAL Design Drawings

Sheet Name

FIRE ALARM & CCTV SYSTEM LAYOUT

Date	April, 2026
Scale	NTS
Drawn by	A.S.B
Checked by	M.K
Approved by	M.F
Drawing No.	E-44

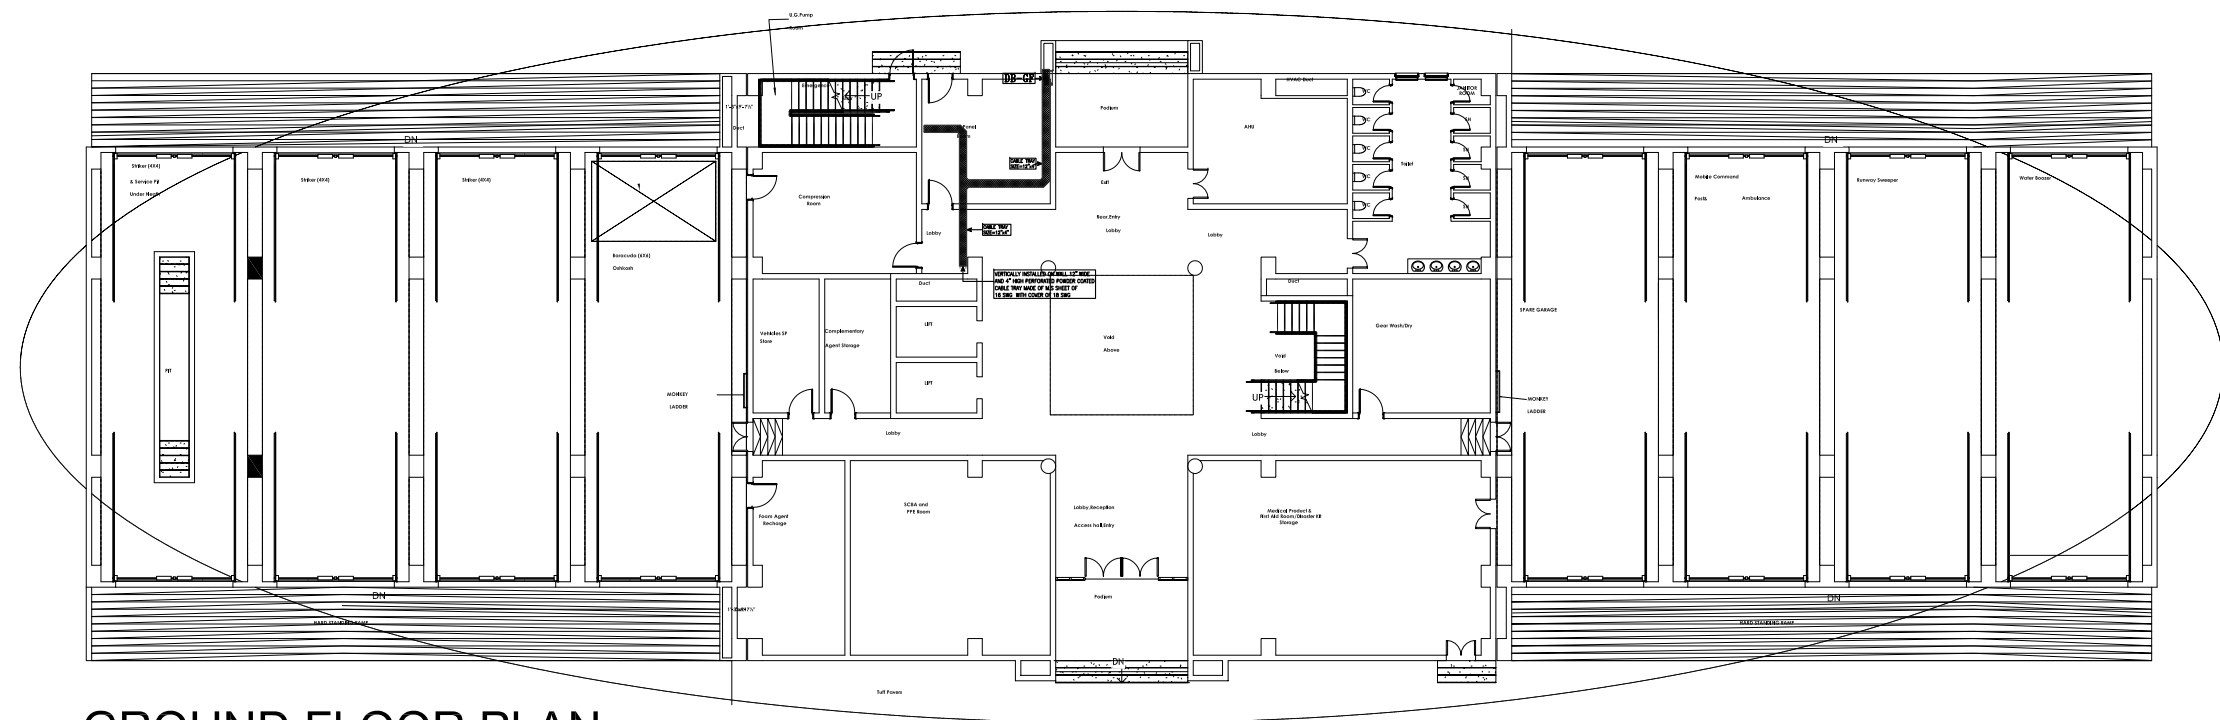

GROUND FLOOR PLAN

ISSUE FOR TENDER

NOTES: This drawing is confidential and is the exclusive property of AAA (Pvt)Ltd.and is loaned subject to the condition that it is not to be reproduced orused to furnish for the making of drawing or prints except as sanctioned in writing by AAA (Pvt)Ltd.	
CLIENT NAME	
MAIN CONSULTANT	
 Anwar Ali Architects (Pvt.) Ltd. Consulting,Architects,Engineers Planners & Management Consultants 06 HBFC BLOCK A FAISAL TOWN LAHORE	
JV MEMBERS	
STRUCTURAL CONSULTANT	
 AR ENGINEERS Architects, Stuctural, Earthquake Engineering, Geo Technical, Public Health, Highway, Electrical Design Solution. Office # 4, 2nd Floor,Quilans Arcade Firdous Market, Gulberg-II, Lahore. Ph: 042-35831968 0300813921, E-mail: arengineers78@gmail.com	
MEP CONSULTANT	
 ABSTRACTORS MEP CONSULTANT SUITE-14,3RD FLOOR, JINNAH MALL, IZMIR TOWN, LHR Cell no: 0322-3924199 E-mail: abstractorseng@gmail.com	
Project Name	
Consultancy Services for New Air Traffic Control Tower (ATCT), Fire Station and Allied Facilities at Skardu International Airport	
DETAILED ELECTRICAL Design Drawings	
Sheet Name	
POWER CABLE TRAY LAYOUT	
Date	April, 2026
Scale	NTS
Drawn by	A.S.B
Checked by	M.K
Approved by	M.F
Drawing No.	E-45



ISSUE FOR TENDER

This drawing is confidential and is the exclusive property of AAA (Pvt)Ltd.and is loaned subject to the condition that it is not to be reproduced or used to furnish for the making of drawing or prints except as sanctioned in writing by AAA (Pvt)Ltd.

Anwar Ali Architects (Pvt.) Ltd.
Consulting, Architects, Engineers
Planners & Management Consultants
06 HBFIC BLOCK A, FAISAL TOWN LAHORE

AR ENGINEERS
Architects, Structural, Earthquake Engineering, Geo Technical, Public Health,
Highway, Electrical Design Solution.


Office # 4, 2nd Floor, Sultana Arcade Firdous Market, Gulberg-III, Lahore.
Ph: 042-35831906 03008813921, E-mail: arengineers786@gmail.com

 ABSTRACTORS
MEP CONSULTANT
SUITE-14,3RD FLOOR JINNAH MALL IZMIR TOWN, LHR
Cell no: 0322-3924199
E-mail: abstractorsena@gmail.com

**Consultancy Services for
New Air Traffic Control Tower
(ATCT), Fire Station and Allied
Facilities at Skardu
International Airport**

POWER CABLE TRAY LAYOUT


Date	April, 2026
Scale	NTS
Drawn by	A.S.B
Checked by	M.K
Approved by	M.F
Drawing No.	E-46

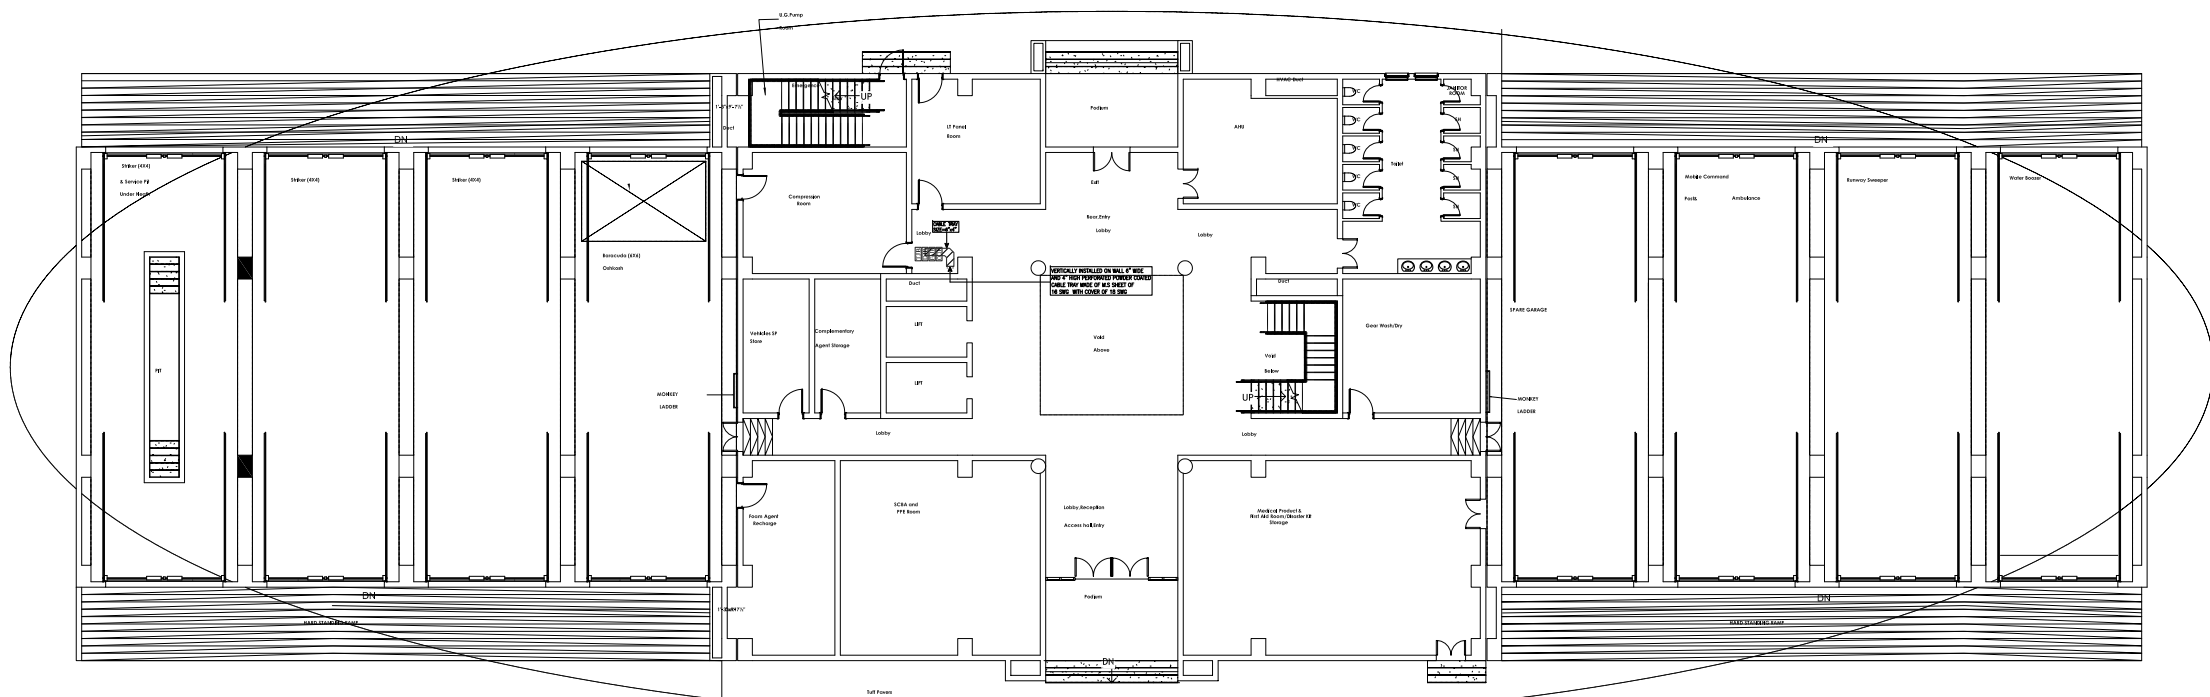

GROUND FLOOR PLAN

ISSUE FOR TENDER

NOTES: This drawing is confidential and is the exclusive property of AAA (Pvt)Ltd.and is loaned subject to the condition that it is not to be reproduced orused to furnish for the making of drawing or prints except as sanctioned in writing by AAA (Pvt)Ltd.	
CLIENT NAME	
MAIN CONSULTANT	
JV MEMBERS	
STRUCTURAL CONSULTANT	
MEP CONSULTANT	
Project Name	
Consultancy Services for New Air Traffic Control Tower (ATCT), Fire Station and Allied Facilities at Skardu International Airport	
DETAILED ELECTRICAL Design Drawings	
Sheet Name	
ELV CABLE TRAY LAYOUT	
Date	April, 2026
Scale	NTS
Drawn by	A.S.B
Checked by	M.K
Approved by	M.F
Drawing No.	E-48

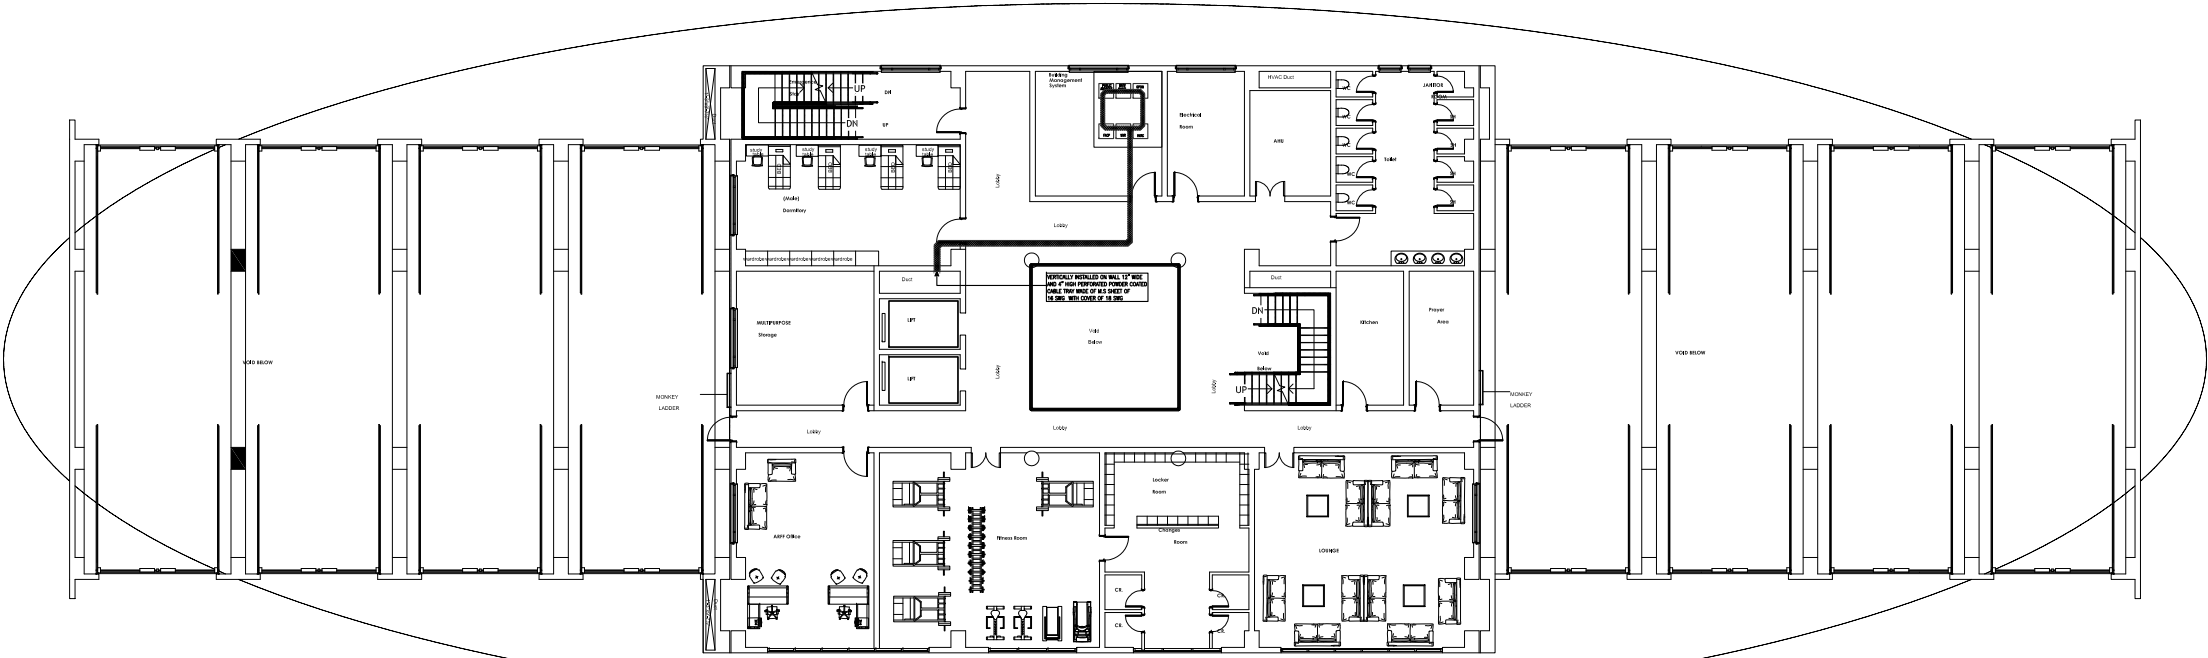

ARFF FLOOR
MEZZANINE FLOOR PLAN

ISSUE FOR TENDER

NOTES: This drawing is confidential and is the exclusive property of AAA (Pvt)Ltd.and is loaned subject to the condition that it is not to be reproduced orused to furnish for the making of drawing or prints except as sanctioned in writing by AAA (Pvt)Ltd.	
CLIENT NAME	
	
MAIN CONSULTANT	
 Anwar Ali Architects (Pvt.) Ltd. Consulting,Architects,Engineers Planners & Management Consultants 06 HBFC BLOCK A FAISAL TOWN LAHORE	
JV MEMBERS	
	
STRUCTURAL CONSULTANT	
 AR ENGINEERS Architects, Structural, Earthquake Engineering, Geo Technical, Public Health, Highway, Electrical Design Solution. Office # A, 2nd Floor,Sultana Arcade Firdous Market, Gulberg-II, Lahore. Ph: 042-35831908, 03008813321, E-mail: arengineers78@gmail.com	
MEP CONSULTANT	
 ABSTRACTORS MEP CONSULTANT SUITE-14,3RD FLOOR JINNAH MALL IZMIR TOWN, IZMIR Cell no: 0322-3924199 E-mail: abstractorseng@gmail.com	
Project Name	
Consultancy Services for New Air Traffic Control Tower (ATCT), Fire Station and Allied Facilities at Skardu International Airport	
DETAILED ELECTRICAL Design Drawings	
Sheet Name	
ELV CABLE TRAY LAYOUT	
Date	April, 2026
Scale	NTS
Drawn by	A.S.B
Checked by	M.K
Approved by	M.F
Drawing No.	E-49

NOTES:

This drawing is confidential and is the exclusive property of AAA (Pvt)Ltd.and is loaned subject to the condition that it is not to be reproduced orused to furnish for the making of drawing or prints except as sanctioned in writing by AAA (Pvt)Ltd.

CLIENT NAME



MAIN CONSULTANT



JV MEMBERS



STRUCTURAL CONSULTANT



MEP CONSULTANT



Project Name


Consultancy Services for New Air Traffic Control Tower (ATCT), Fire Station and Allied Facilities at Skardu International Airport

DETAILED ELECTRICAL Design Drawings

Sheet Name

ELV CABLE TRAY LAYOUT


Date	April, 2026
Scale	NTS
Drawn by	A.S.B
Checked by	M.K
Approved by	M.F
Drawing No.	E-50

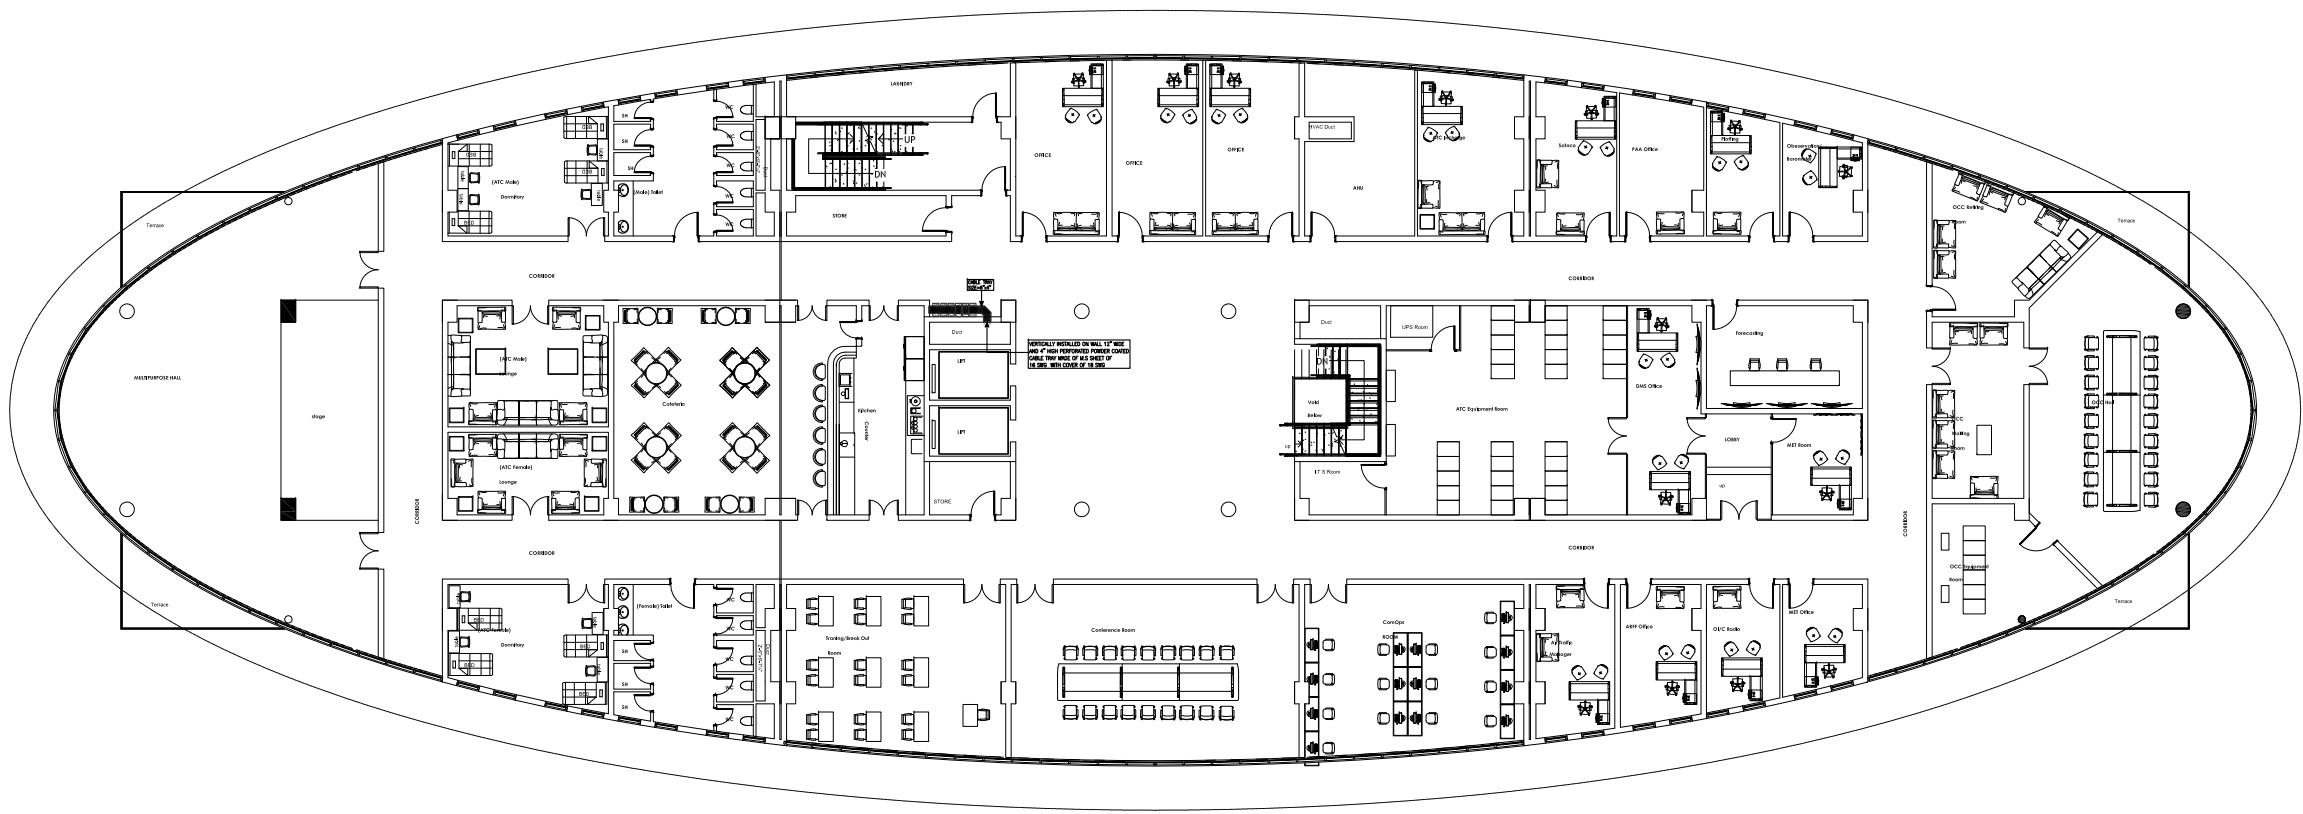


FIRST FLOOR PLAN

ISSUE FOR TENDER

LIGHT FIXTURES			
S.NO	SYMBOLS	DESCRIPTION	MOUNTING HEIGHT
1		WALL EMBEDDED LIGHT 36 WATT LED UP LIGHTER	ON WALL
2		LINEAR FLEXIBLE LIGHT	ON WALL OR AS REQ
3		LINEAR PROFILE LIGHT	ON WALL OR AS REQ

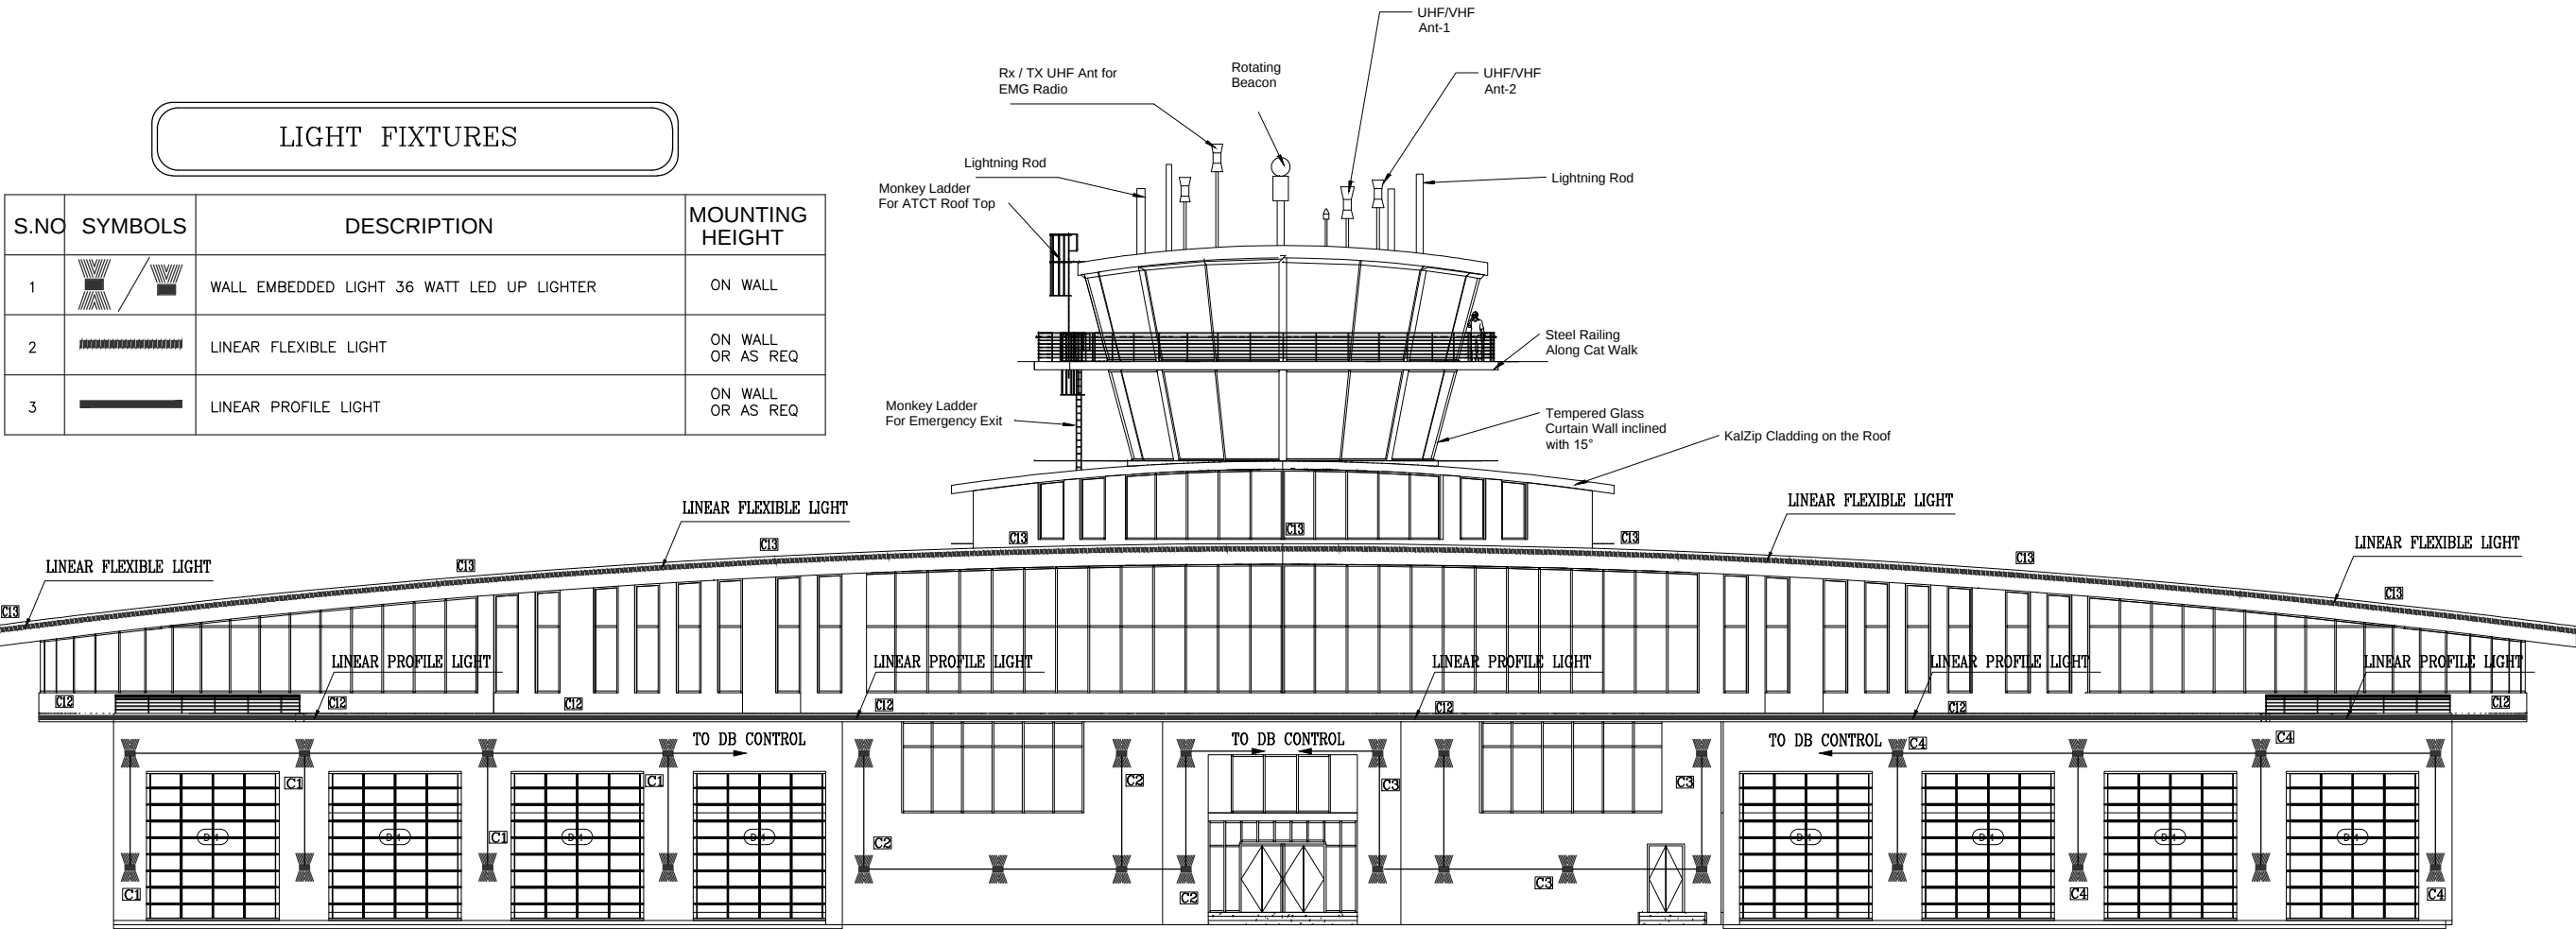

Front Elevation

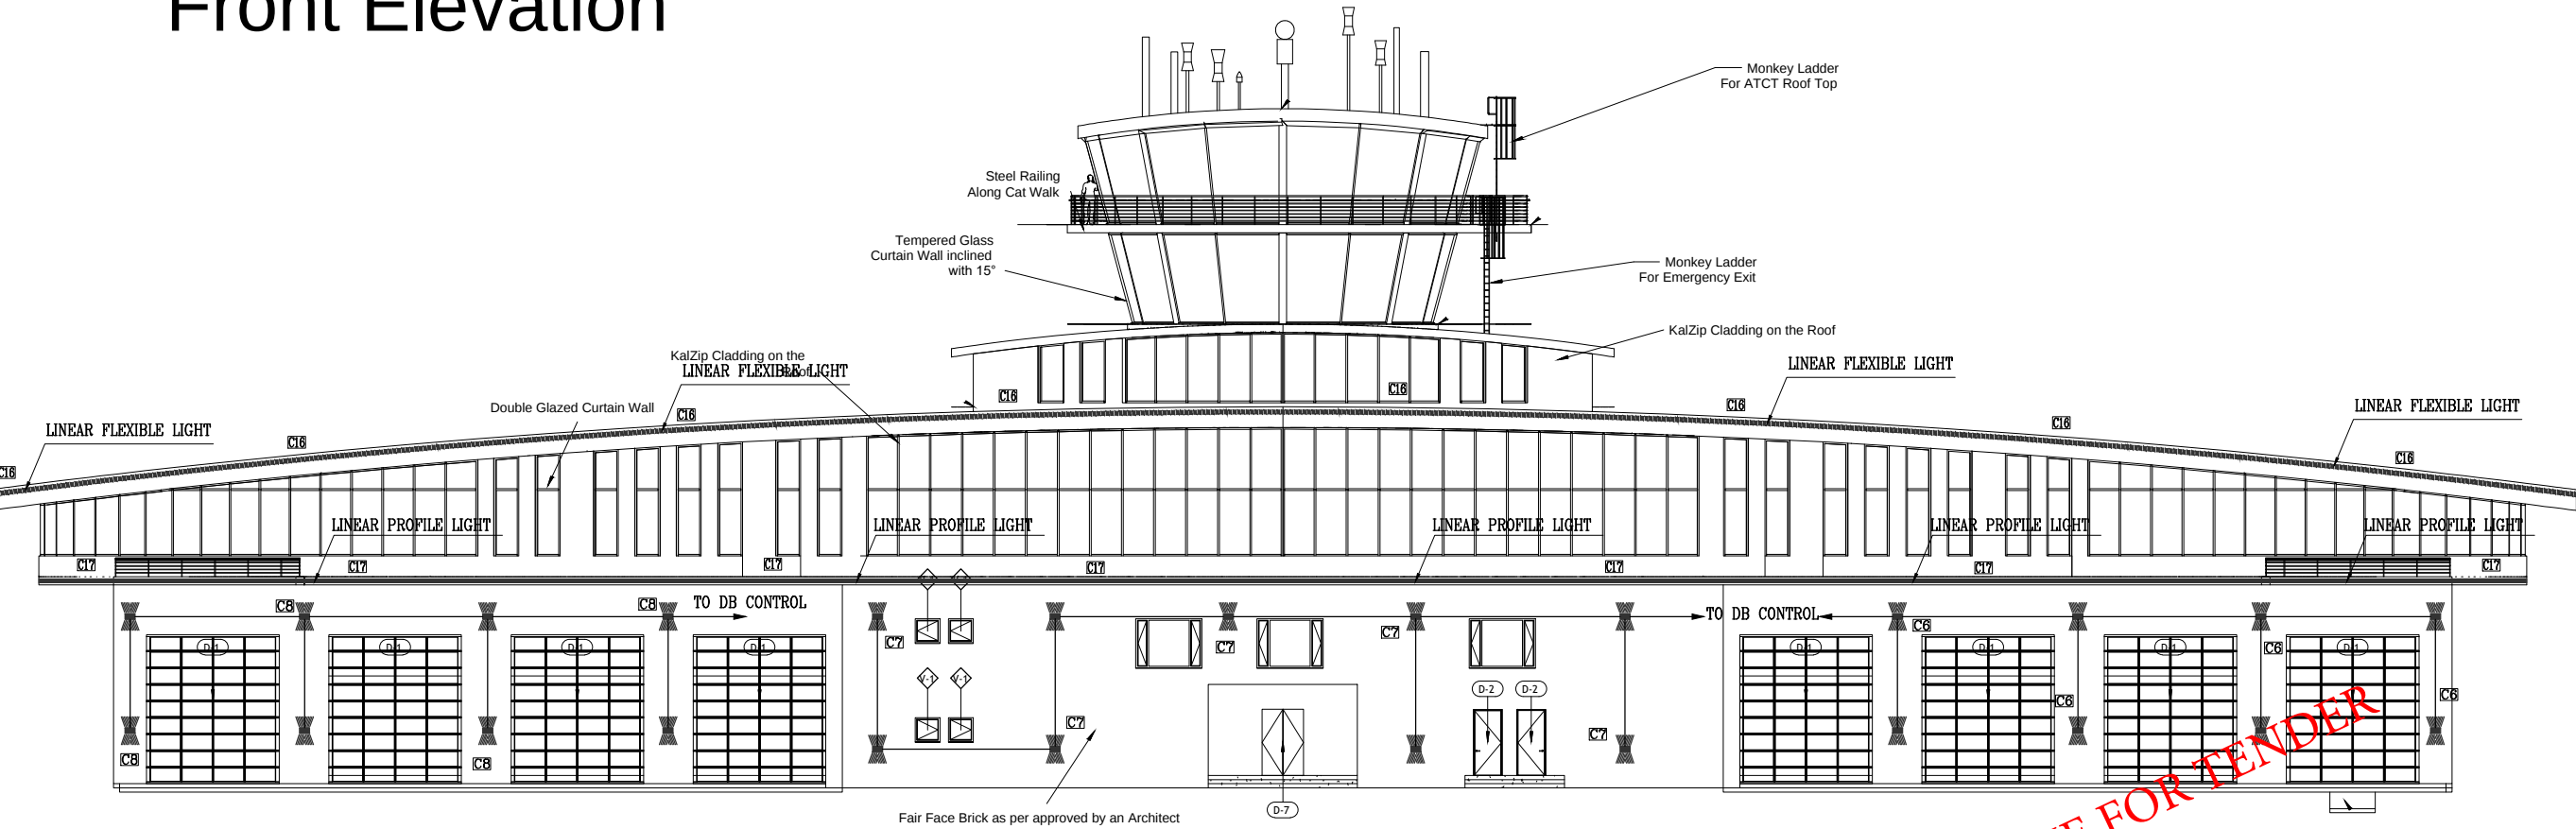

Rear Elevation

ISSUE FOR TENDER

NOTES:

This drawing is confidential and is the exclusive property of AAA (Pvt)Ltd.and is loaned subject to the condition that it is not to be reproduced or used to furnish for the making of drawing or prints except as sanctioned in writing by AAA (Pvt)Ltd.

CLIENT NAME



MAIN CONSULTANT



JV MEMBERS



STRUCTURAL CONSULTANT



MEP CONSULTANT



Project Name

Consultancy Services for New Air Traffic Control Tower (ATCT), Fire Station and Allied Facilities at Skardu International Airport

DETAILED ELECTRICAL Design Drawings

Sheet Name


ELEVATION LIGHTING LAYOUT

Date	April, 2026
Scale	NTS
Drawn by	A.S.B
Checked by	M.K
Approved by	M.F
Drawing No.	E-51


LIGHT FIXTURES

S.NO	SYMBOLS	DESCRIPTION	MOUNTING HEIGHT
1		WALL EMBEDDED LIGHT 36 WATT LED UP LIGHTER	ON WALL
2		LINEAR FLEXIBLE LIGHT	ON WALL OR AS REQ
3		LINEAR PROFILE LIGHT	ON WALL OR AS REQ

ISSUE FOR TENDER

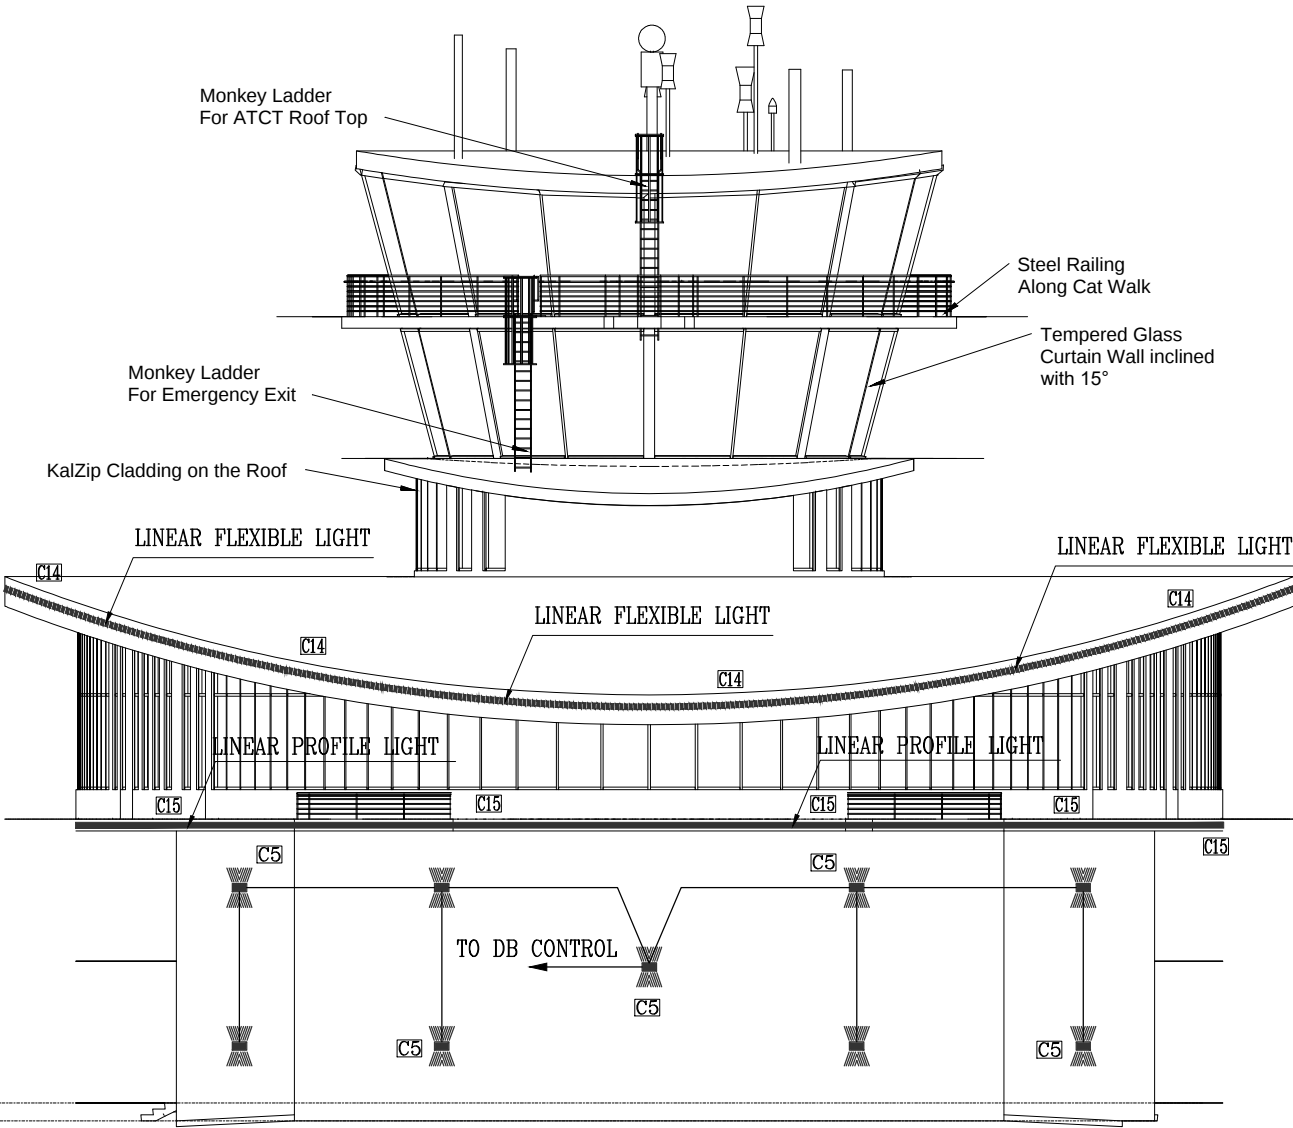

Left Side Elevation

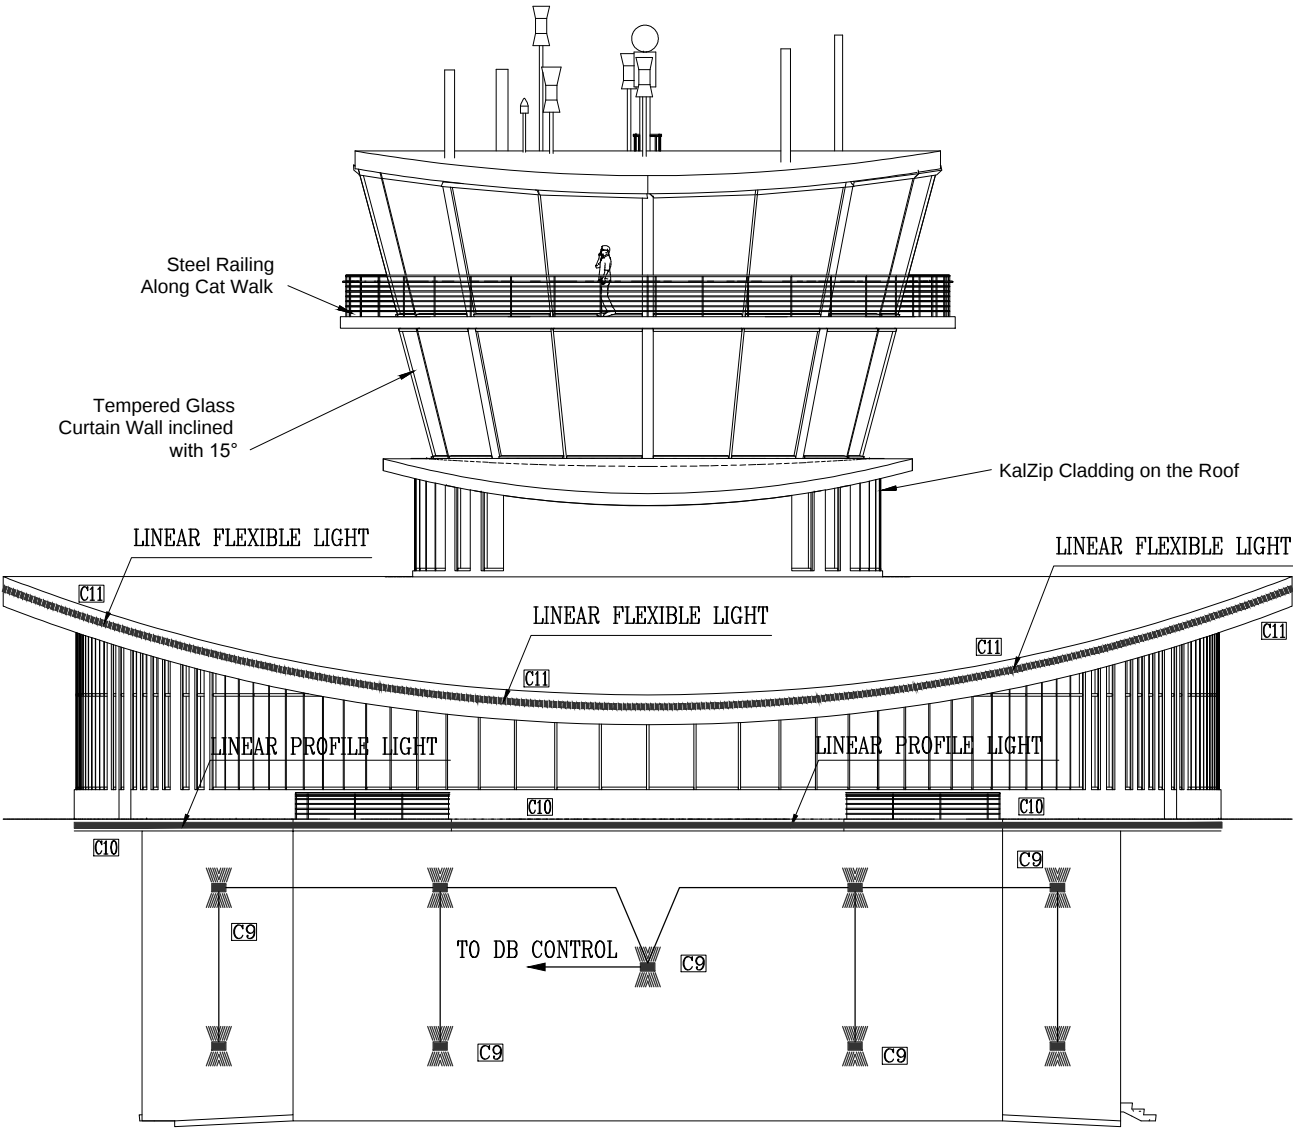

Right Side Elevation

NOTES:

This drawing is confidential and is the exclusive property of AAA (Pvt)Ltd.and is loaned subject to the condition that it is not to be reproduced or used to furnish for the making of drawing or prints except as sanctioned in writing by AAA (Pvt)Ltd.

CLIENT NAME



MAIN CONSULTANT



JV MEMBERS



STRUCTURAL CONSULTANT



MEP CONSULTANT



Project Name

Consultancy Services for New Air Traffic Control Tower (ATCT), Fire Station and Allied Facilities at Skardu International Airport

DETAILED ELECTRICAL Design Drawings

Sheet Name

ELEVATION LIGHTING LAYOUT

Date	April, 2026
Scale	NTS
Drawn by	A.S.B
Checked by	M.K
Approved by	M.F
Drawing No.	E-52