




NOTES:
1-ALL DIMENSIONS ARE IN METERS
2-COORDINATE SYSTEM IS WGS84
3-PAVEMENT HEIGHT IS 0.95m

REV. NO.	MODIFICATIONS	DATE	DRAWN	
CLIENT:				
 پاکستان ایئر پورٹ اتھارٹی				
CONSULTANT:				
 Anwar Ali Architects (Pvt.) Ltd. Consulting Architects, Engineers, Planners & Management Consultants				
 leit-werk				
 COMRADES CONSULTANTS				
PROJECT : Consultancy Services for the Preparation of Detailed Design, Procurement Support and Construction Supervision of New Air Traffic Control Tower (ATCT), Fire Station and Allied Facilities at Skardu International Airport				
STATUS : ISSUED FOR INFORMATION				
DRAWING TITLE : ATC ROADS PLAN				
JOB No. :		SCALE :		
NAME	DATE	SIZEA0	PROJECTION 	
DSGN				
DRWN				
CHKD				
APPD				
DRAWING NO.			REV:	
RELEASED FOR				
☒ INFORMATION	☐ TENDER	☐ APPROVAL	☐ CONSTRUCTION	☐ AS BUILT

ISSUE FOR TENDER

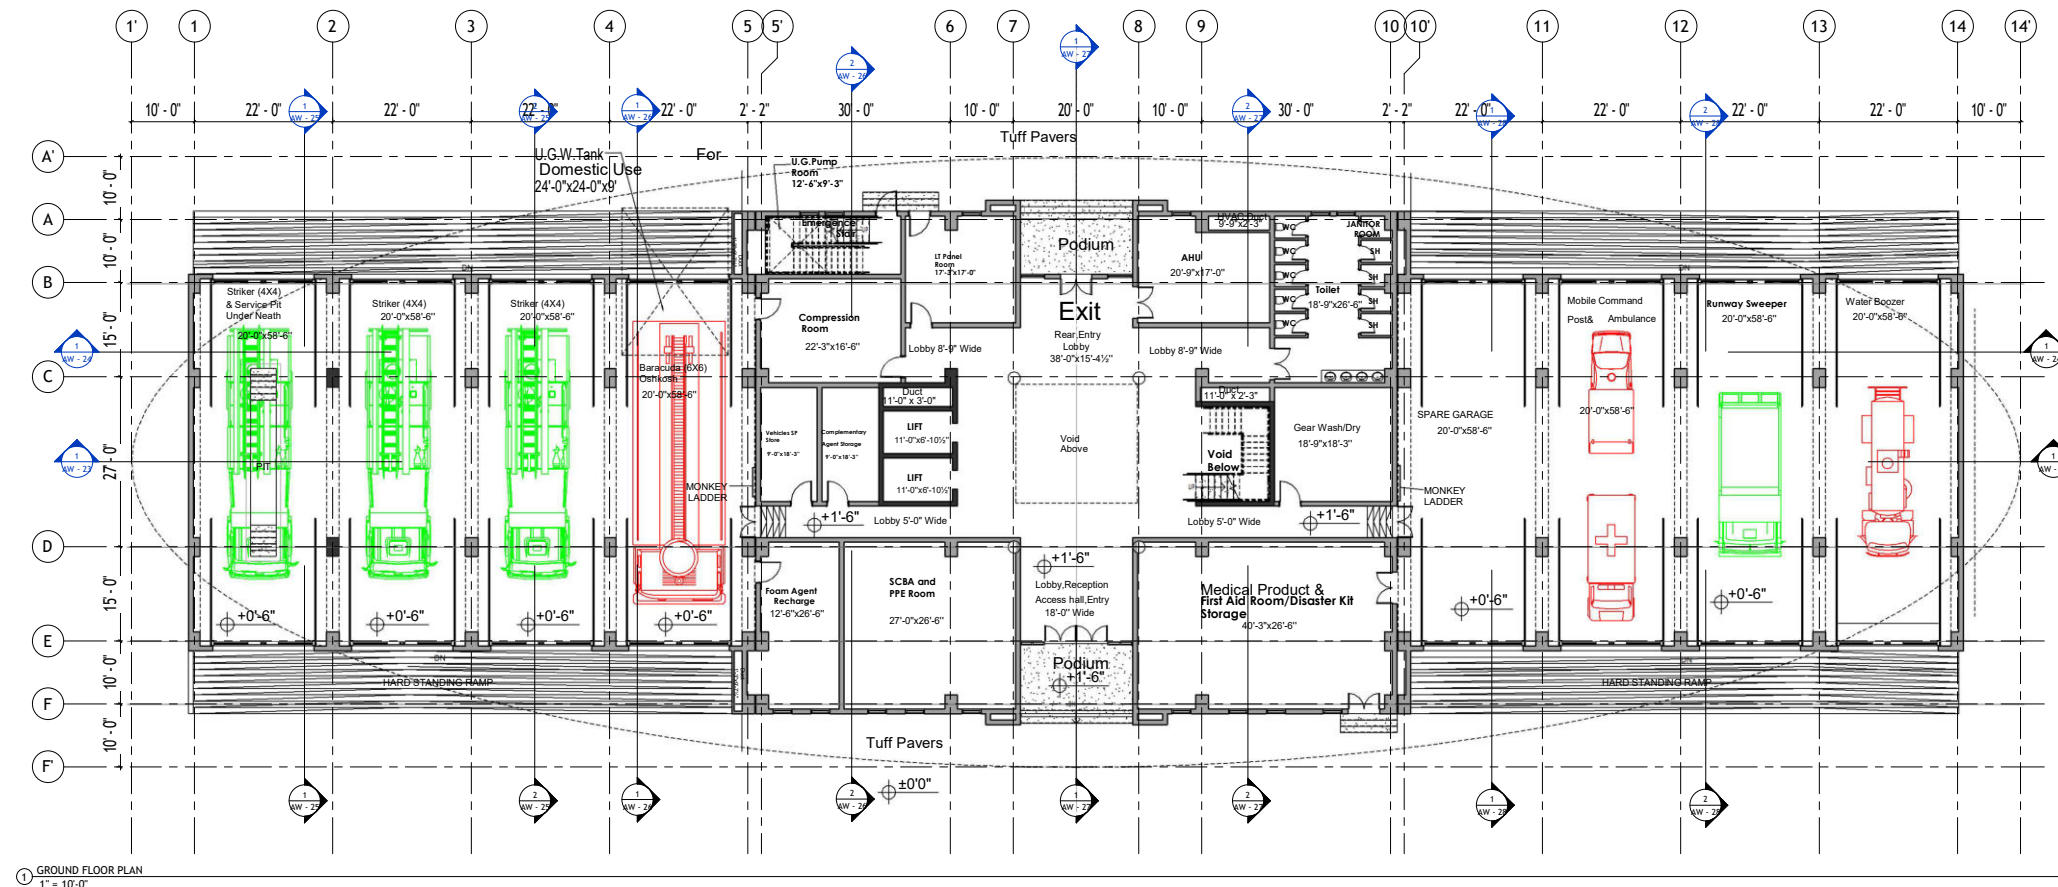

NOTES:

These drawings are confidential and are the exclusive property of AAA (Pvt) Ltd. and are loaned subject to the condition that it is not to be reproduced or furnished for the making of drawings or prints except as mentioned in writing by AAA (Pvt) Ltd.

CLIENT NAME



MAIN CONSULTANT



JV MEMBERS



Structural Consultant

North Orientation



Project Name

Consultancy Services for the Design of New Air Traffic Control Tower (ATCT), Fire Station and Allied Facilities at Skardu International Airport

Detailed Architectural Design Drawings


GROUND FLOOR PLAN

Design By Ar. Henrik Rothe
Checked By Ar. Ahmed Ali
Approved By Ar. Anwar Ali
Drawn By Ar. Muhammad Tayyab
Date March 2026

AW - 07

Scale @ 42" X 30" 1" = 10'-0"

ISSUE FOR TENDER

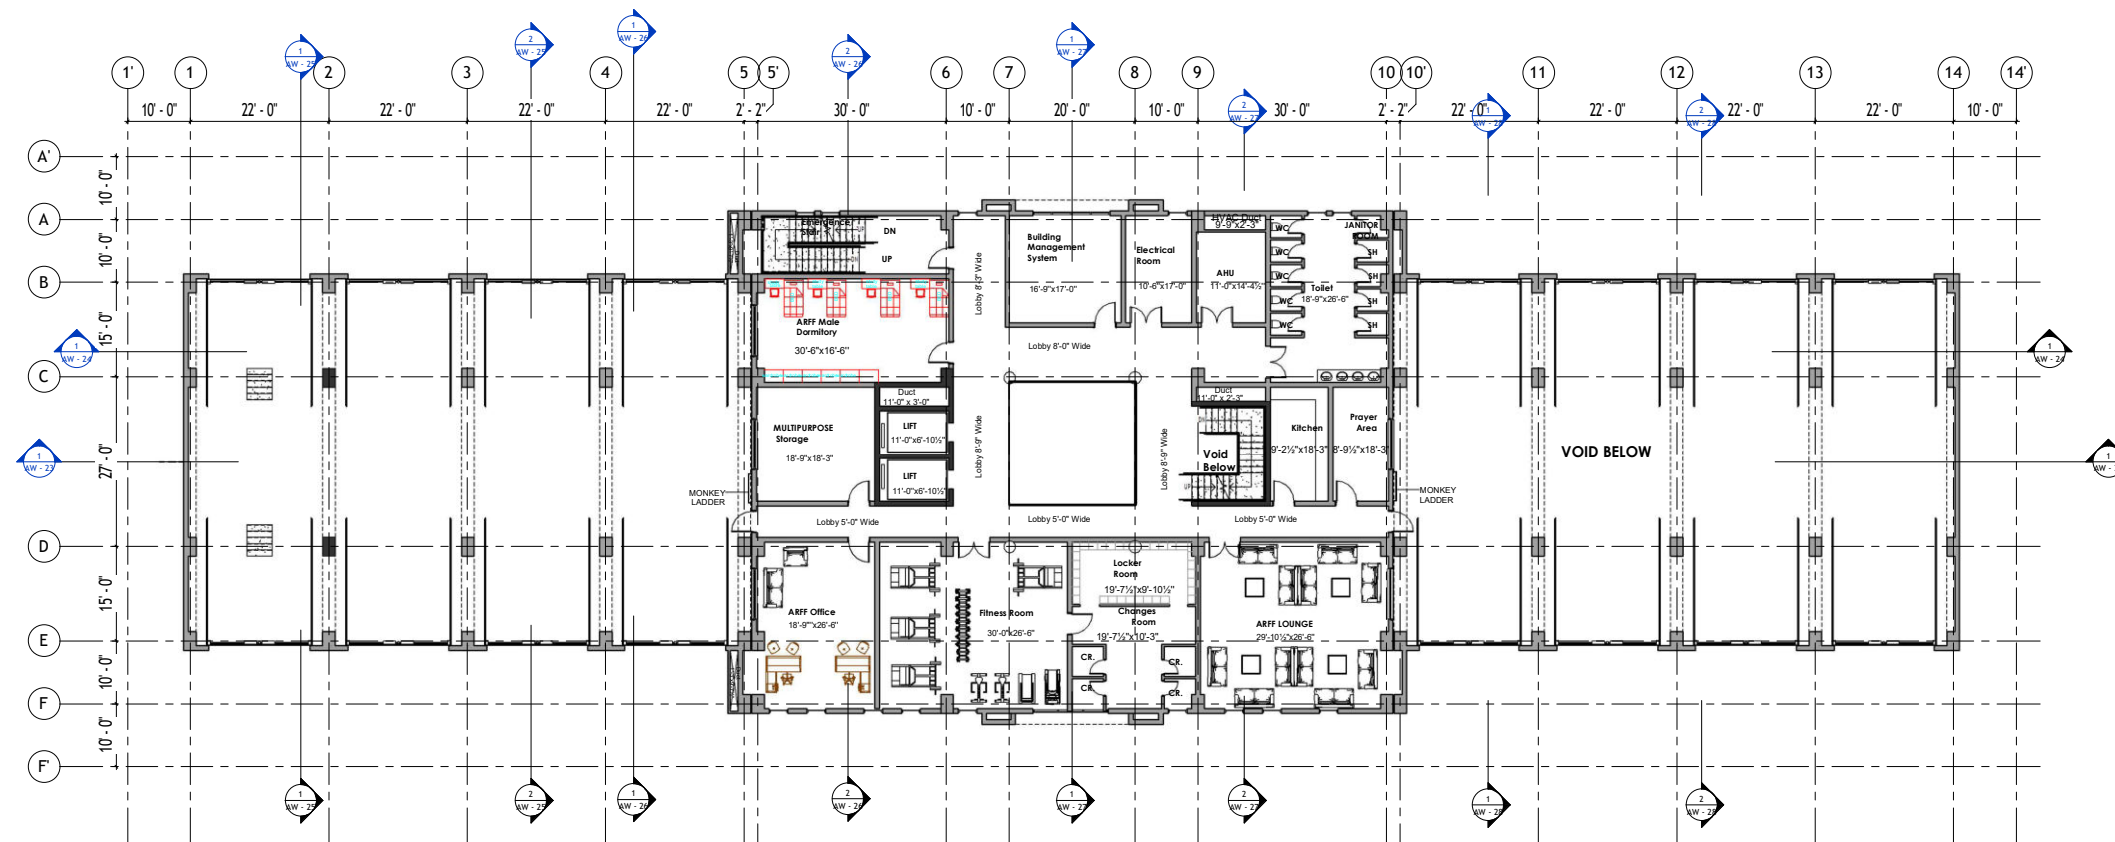

MEZZANINE FLOOR PLAN (ARFF)
1" = 10'-0"

ISSUE FOR TENDER

NOTES:

These drawings are confidential and are the exclusive property of PAA (Pvt.) Ltd. and are loaned subject to the condition that it is not to be reproduced or furnished for the making of drawings or prints except as mentioned in writing by PAA (Pvt.) Ltd.

CLIENT NAME



MAIN CONSULTANT




JV MEMBERS



Structural Consultant

North Orientation

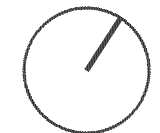

Project Name

Consultancy Services for
the Design of New Air
Traffic Control Tower
(ATCT), Fire Station and
Allied Facilities at
Skardu International
Airport

Detailed Architectural Design Drawings


MEZZANINE FLOOR PLAN

Design By	Ar. Henrik Rothe
Checked By	Ar. Ahmed Ali
Approved By	Ar. Anwar Ali
Drawn By	Ar. Muhammad Tayyab
Date	March 2026

AW - 08

Scale @ 42" X 30"

1" = 10'-0"

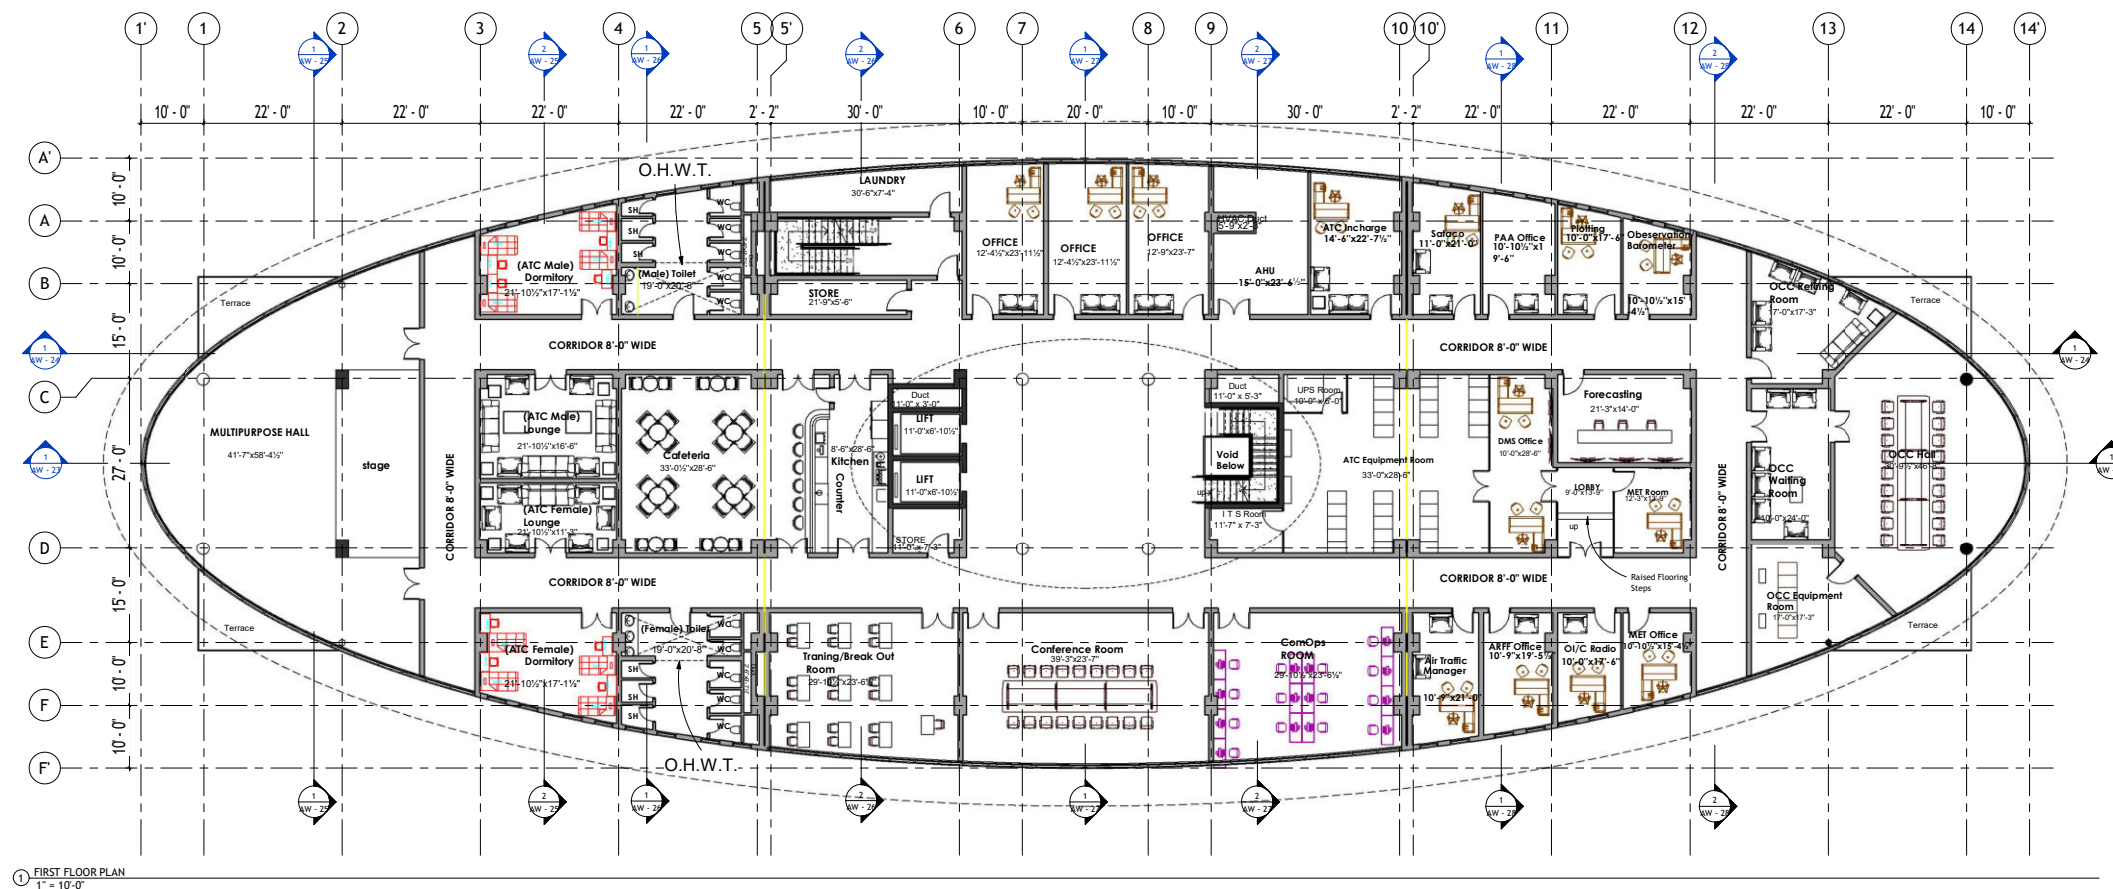

NOTES:

These drawings are confidential and are the exclusive property of AAA (Pvt.) Ltd. and are loaned subject to the condition that it is not to be reproduced or furnished for the making of drawings or prints except as mentioned in writing by AAA (Pvt.) Ltd.

CLIENT NAME



MAIN CONSULTANT




JV MEMBERS



Structural Consultant

North Orientation

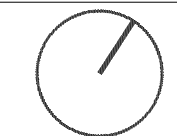

Project Name

Consultancy Services for the Design of New Air Traffic Control Tower (ATCT), Fire Station and Allied Facilities at Skardu International Airport

Detailed Architectural Design Drawings

FIRST FLOOR PLAN


Design By Ar. Henrik Rothe
Checked By Ar. Ahmed Ali
Approved By Ar. Anwar Ali
Drawn By Ar. Muhammad Tayyab
Date March 2026

AW - 09

Scale @ 42" X 30"

1" = 10'-0"

ISSUE FOR TENDER

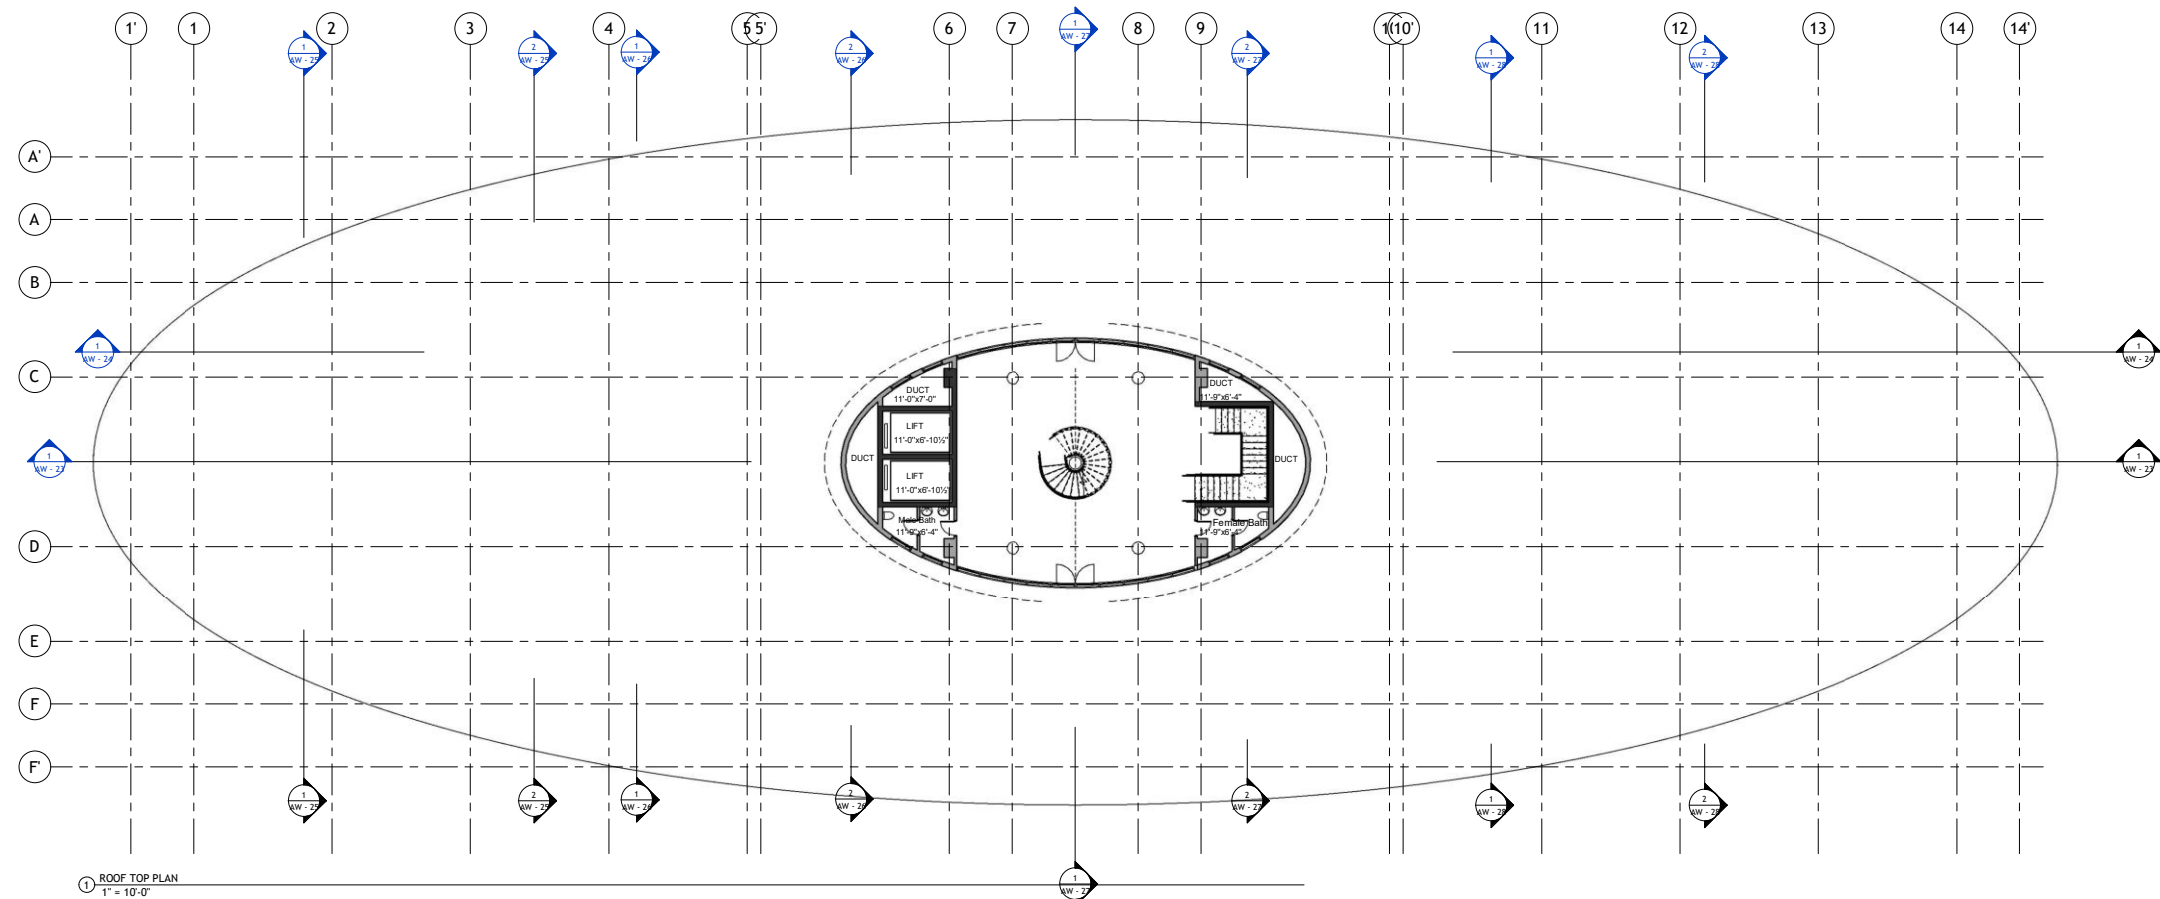

1 ROOF TOP PLAN
1" = 10'-0"

ISSUE FOR TENDER

NOTES:

These drawings are confidential and are the exclusive property of AAA (Pvt) Ltd. and are loaned subject to the condition that it is not to be reproduced or furnished for the making of drawing or prints except as mentioned in writing by AAA (Pvt) Ltd.

CLIENT NAME



MAIN CONSULTANT




JV MEMBERS



Structural Consultant

North Orientation

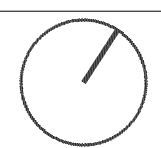

Project Name

Consultancy Services for the Design of New Air Traffic Control Tower (ATCT), Fire Station and Allied Facilities at Skardu International Airport


Detailed Architectural Design Drawings

ROOF TOP FLOOR PLAN

Design By	Ar. Henrik Rothe
Checked By	Ar. Ahmed Ali
Approved By	Ar. Anwar Ali
Drawn By	Ar. Muhammad Tayyab
Date	March 2026

AW - 10

Scale @ 42" X 30" 1" = 10'-0"

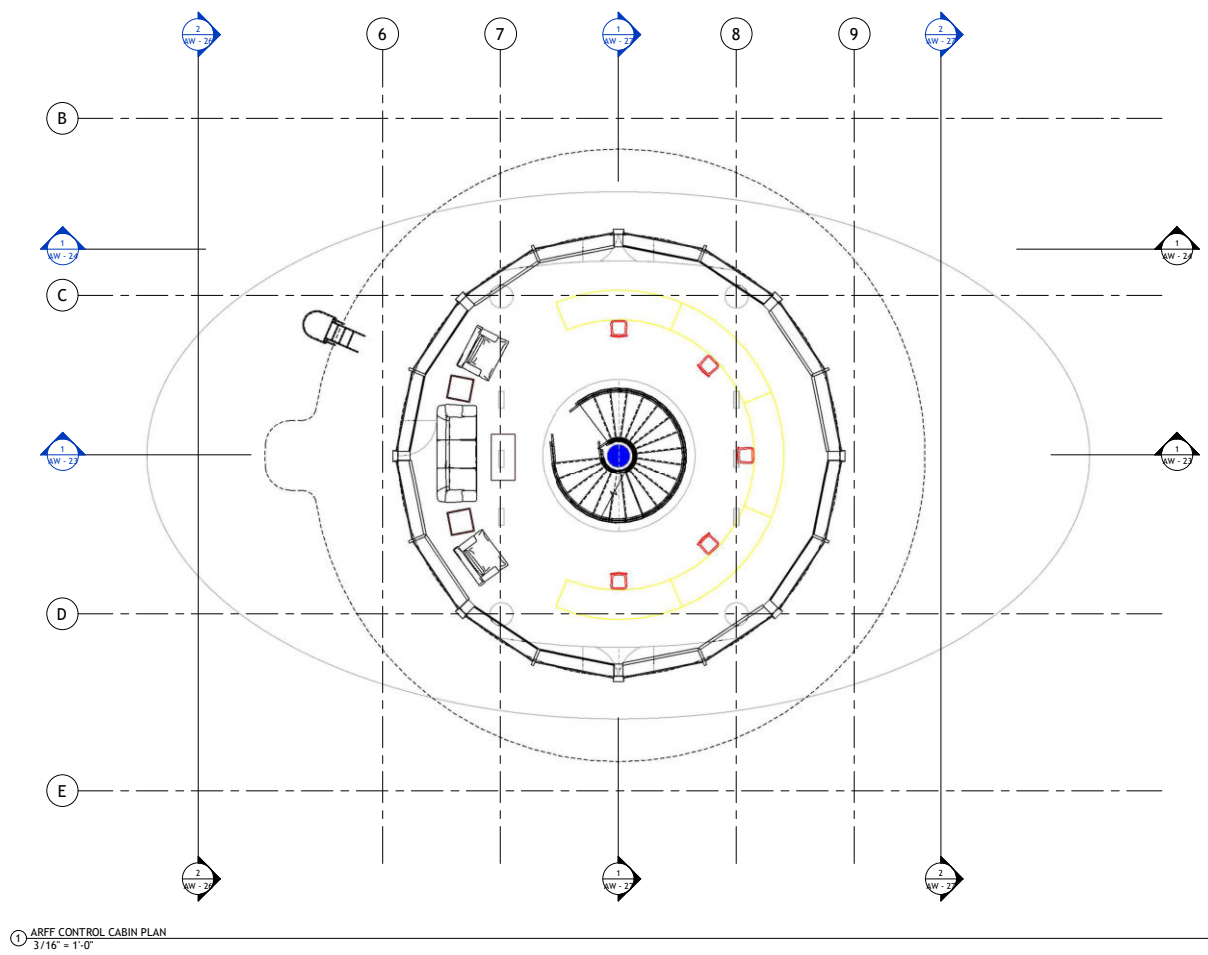

ISSUE FOR TENDER

NOTES:

These drawings are confidential and are the exclusive property of AAA (Pvt.) Ltd. and are loaned subject to the condition that it is not to be reproduced or furnished for the making of drawings or prints except as mentioned in writing by AAA (Pvt.) Ltd.

CLIENT NAME



MAIN CONSULTANT




JV MEMBERS



Structural Consultant

North Orientation

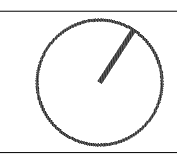

Project Name

Consultancy Services for the Design of New Air Traffic Control Tower (ATCT), Fire Station and Allied Facilities at Skardu International Airport


Detailed Architectural Design Drawings

ARFF CONTROL CABIN FLOOR PLAN

Design By	Ar. Henrik Rothe
Checked By	Ar. Ahmed Ali
Approved By	Ar. Anwar Ali
Drawn By	Ar. Muhammad Tayyab
Date	March 2026

AW - 11

Scale @ 42" X 30" 3/16" = 1'-0"

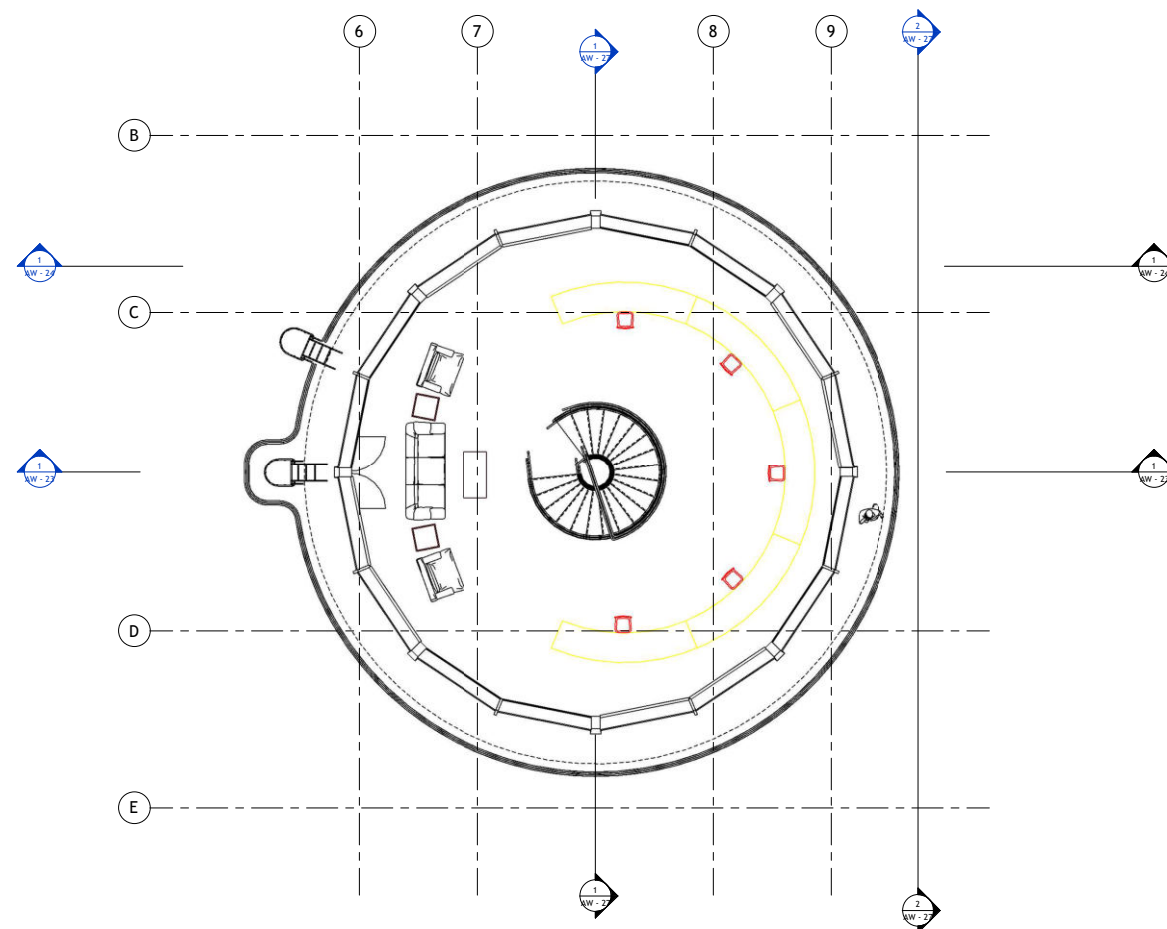

① ATCT CONTROL CABIN PLAN
3/16" = 1'-0"

ISSUE FOR TENDER

NOTES:

These drawings are confidential and are the exclusive property of AAA (Pvt.) Ltd. and are loaned subject to the condition that it is not to be reproduced or furnished for the making of drawing or prints except as mentioned in writing by AAA (Pvt.) Ltd.

CLIENT NAME



MAIN CONSULTANT



JV MEMBERS



Structural Consultant

North Orientation



Project Name

Consultancy Services for the Design of New Air Traffic Control Tower (ATCT), Fire Station and Allied Facilities at Skardu International Airport


Detailed Architectural Design Drawings

ATCT CONTROL CABIN FLOOR PLAN

Design By	Ar. Henrik Rothe
Checked By	Ar. Ahmed Ali
Approved By	Ar. Anwar Ali
Drawn By	Ar. Muhammad Tayyab
Date	March 2026

AW - 12

Scale @ 42" X 30" 3/16" = 1'-0"

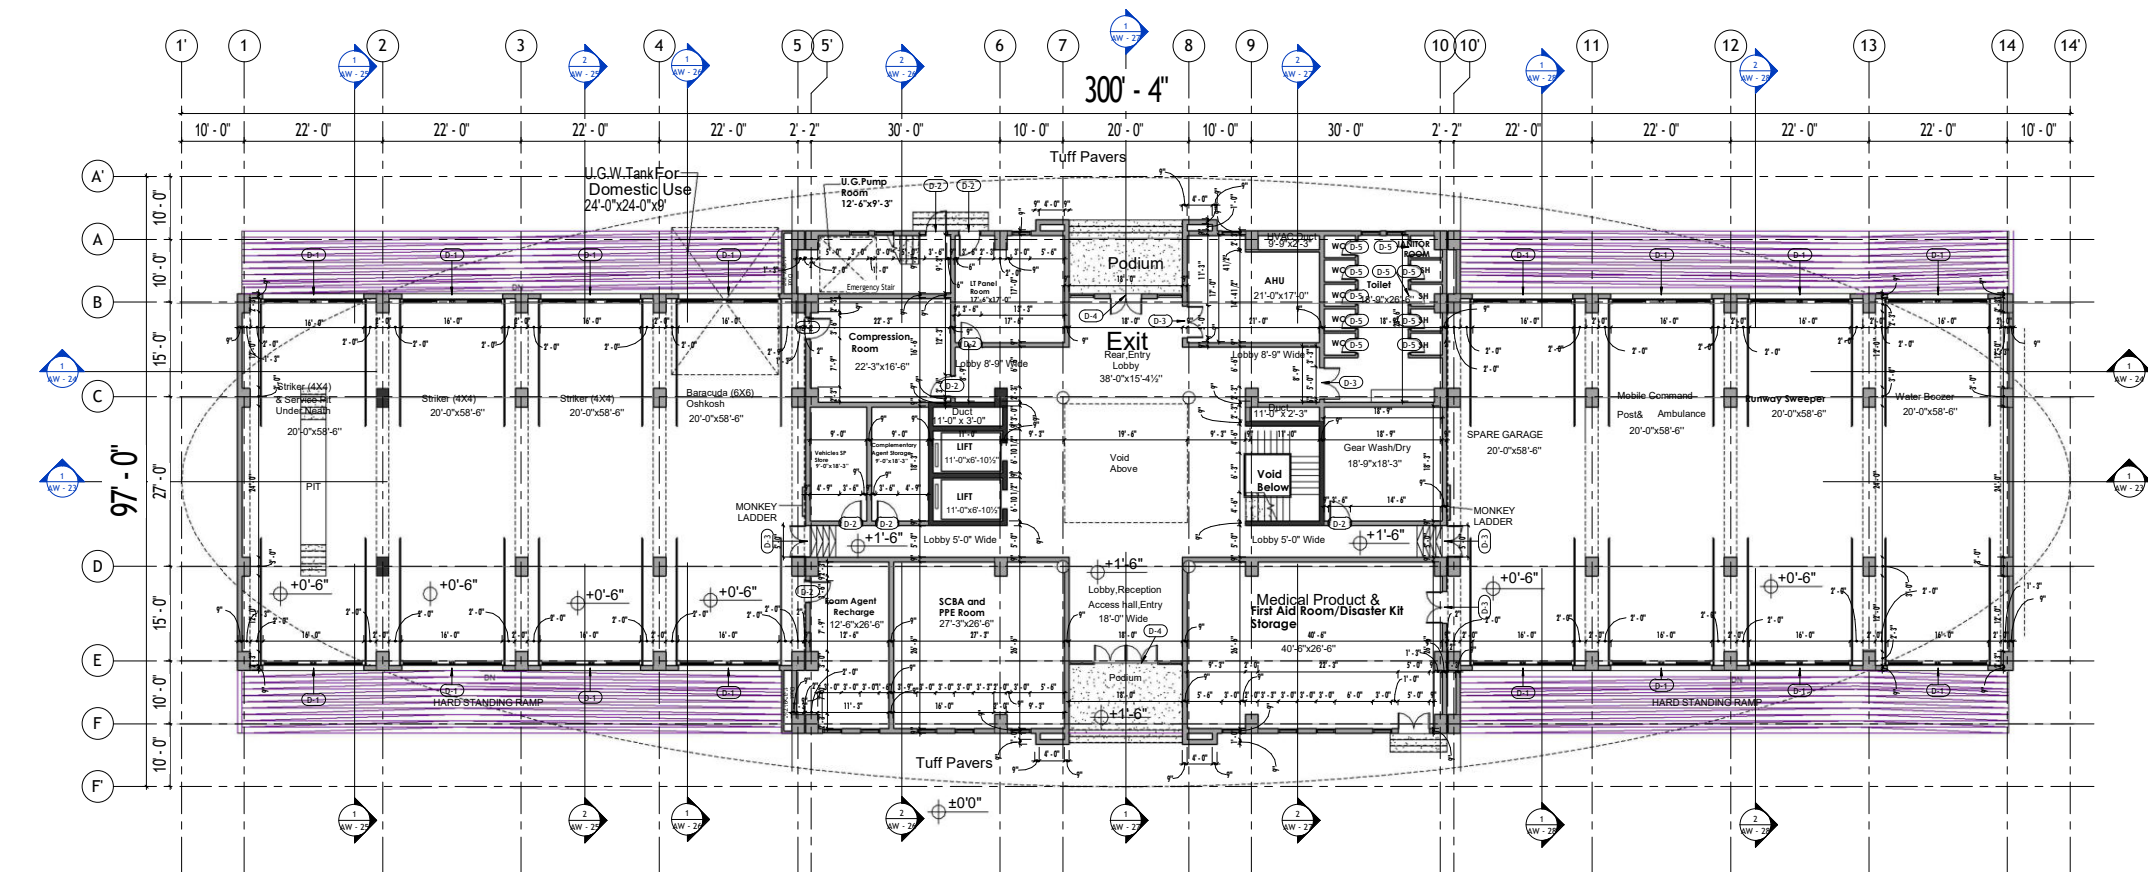

GROUND FLOOR WORKING PLAN
1" = 10'-0"

NOTES:

These drawings are confidential and are the exclusive property of PAA (Pvt.) Ltd. and are loaned subject to the condition that they are not to be reproduced or used for the making of drawings or prints except as mentioned in writing by PAA (Pvt.) Ltd.

CLIENT NAME



MAIN CONSULTANT



JV MEMBERS



Structural Consultant

North Orientation



Project Name

Consultancy Services for
the Design of New Air
Traffic Control Tower
(ATCT), Fire Station and
Allied Facilities at
Skardu International
Airport

Detailed Architectural Design Drawings


GROUND FLOOR WORKING PLAN

Design By Ar. Henrik Rothe
Checked By Ar. Ahmed Ali
Approved By Ar. Anwar Ali
Drawn By Ar. Muhammad Tayyab
Date March 2026

AW - 13

Scale @ 42" X 30" 1" = 10'-0"

ISSUE FOR TENDER

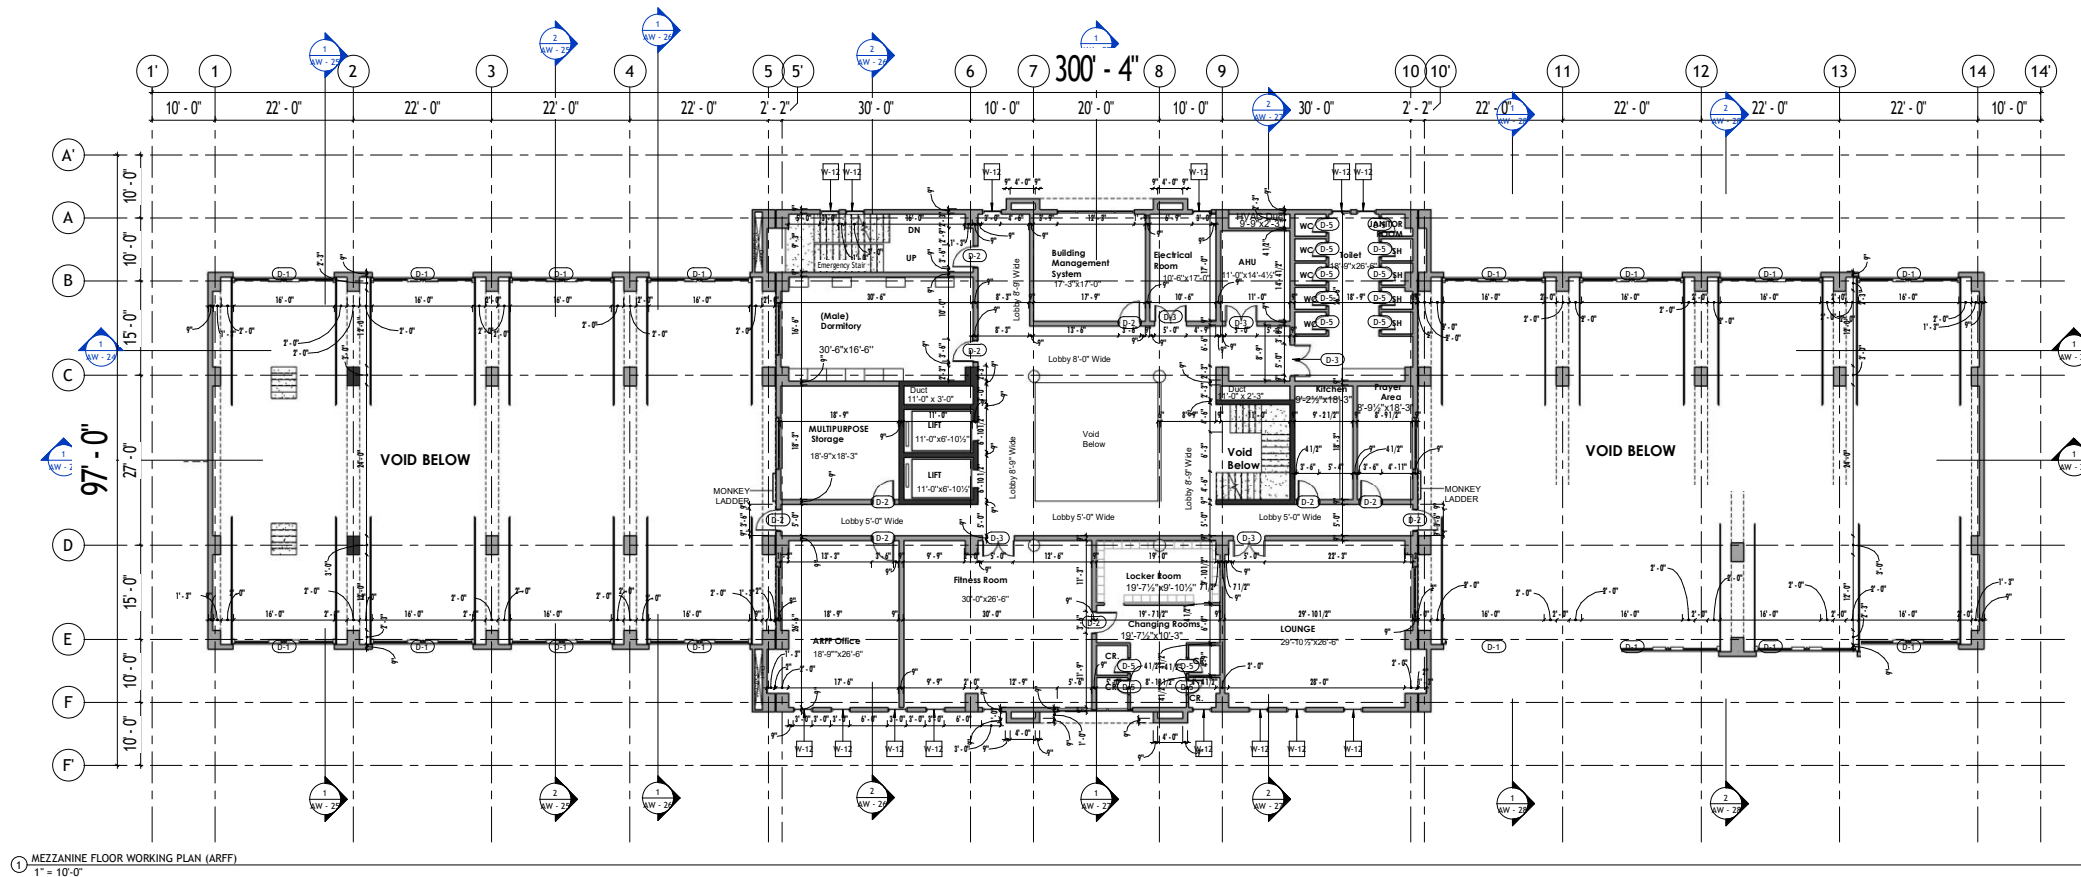

ISSUE FOR TENDER

NOTES:

These drawings are confidential and are the exclusive property of PAA (Pvt.) Ltd. and are loaned subject to the condition that they are not to be reproduced or used for the making of drawings or prints except as mentioned in writing by PAA (Pvt.) Ltd.

CLIENT NAME



MAIN CONSULTANT




JV MEMBERS



Structural Consultant

North Orientation

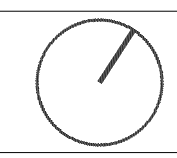

Project Name

Consultancy Services for the Design of New Air Traffic Control Tower (ATCT), Fire Station and Allied Facilities at Skardu International Airport

Detailed Architectural Design Drawings

MEZZANINE FLOOR WORKING PLAN (ARFF)

Design By	Ar. Henrik Rothe
Checked By	Ar. Ahmed Ali
Approved By	Ar. Anwar Ali
Drawn By	Ar. Muhammad Tayyab
Date	March 2026

AW - 14

Scale @ 42" X 30" 1" = 10'-0"

These drawings are confidential and is the exclusive property of AAA (Pvt)Ltd. And is loaned subject to the condition that it is not to be reproduced to furnish for the making of drawing or prints except as sanctioned in writing by AAA (Pvt)Ltd.



پاکستان ایئر فورس اتھارٹی

Anwar Ali Architects (Pvt.) Ltd.
Formerly Anwar Ali & Associates Since March 2006 to June 2018
Consulting Architects, Engineers, Planners & Management Consultant




leit-werl



**Consultancy Services for
the Design of New Air
Traffic Control Tower
(ATCT), Fire Station and
Allied Facilities at
Skardu International
Airport**

FIRST FLOOR WORKING PLAN

AW - 15
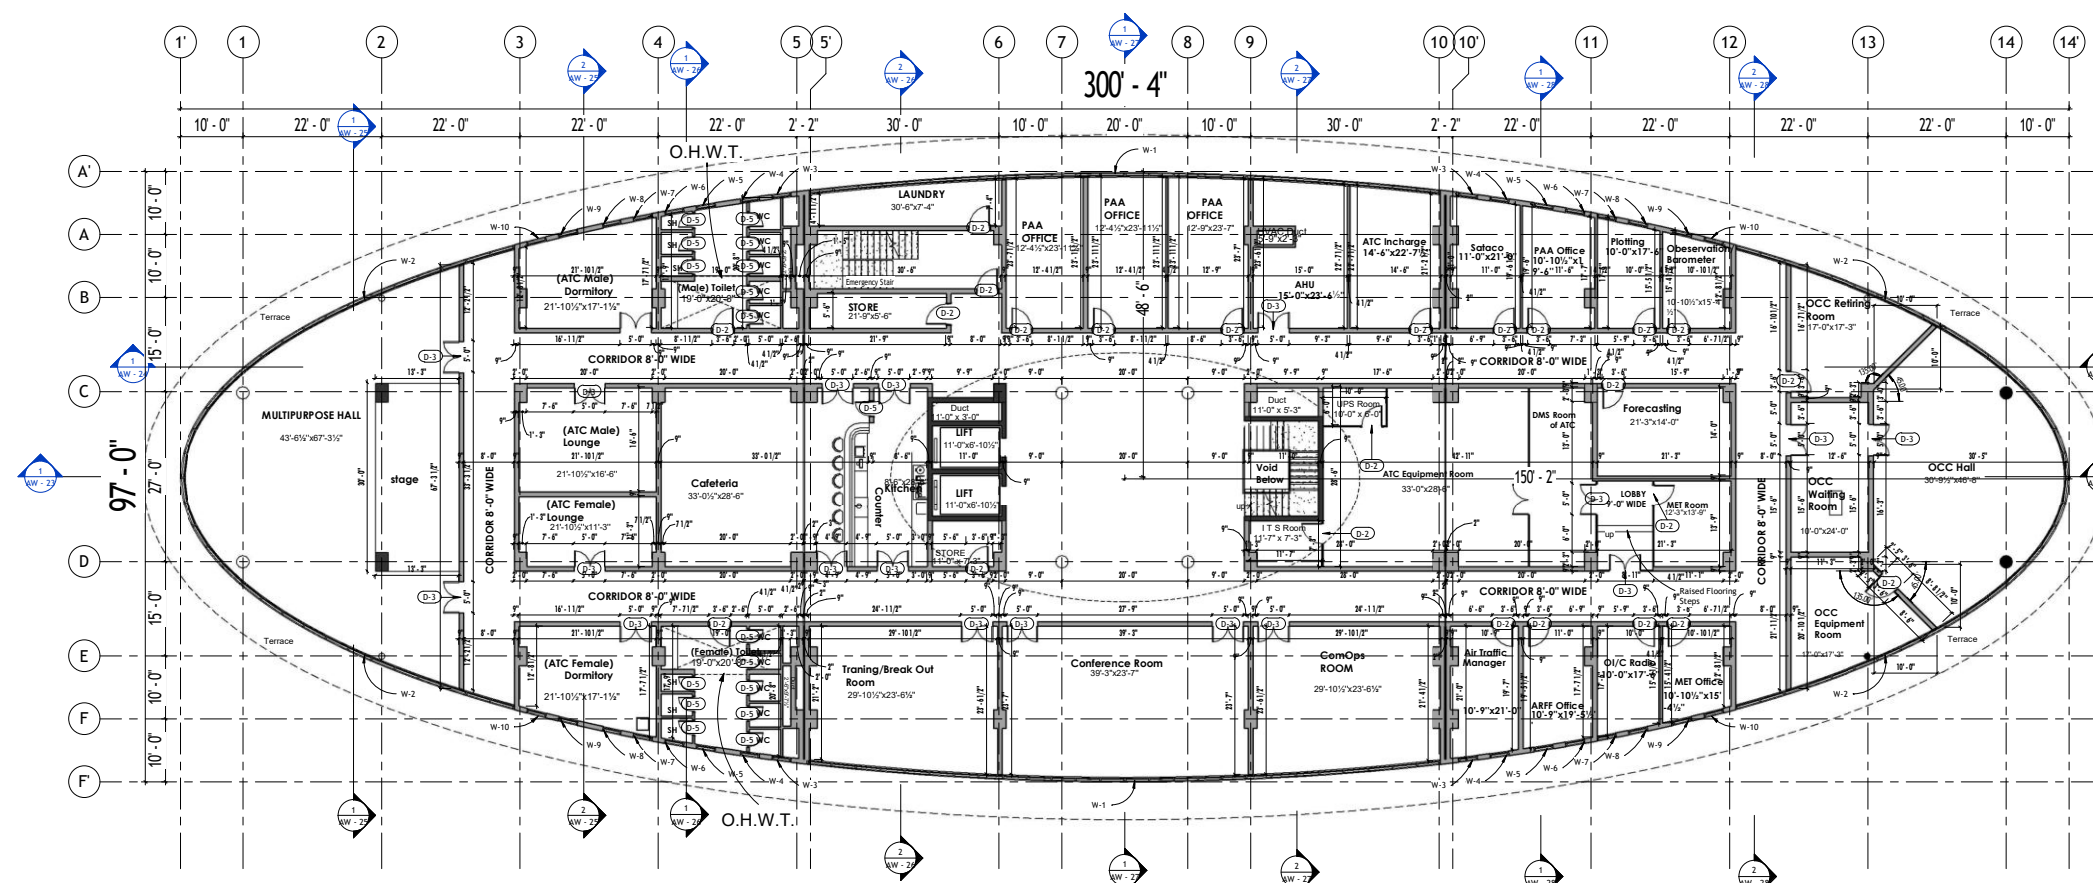
$$1'' = 10'-0''$$


① FIRST FLOOR WORKING PLAN
1" = 10'-0"

ISSUE FOR TENDER