


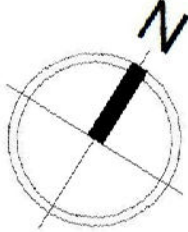


NOTES: These drawings are confidential and is the exclusive property of AAA (Pvt)Ltd. And is loaned subject to the condition that it is not to be reproduced to furnish for the making of drawing or prints except as sanctioned in writing by AAA (Pvt)Ltd.	
CLIENT NAME	
	
MAIN CONSULTANT	
	
JV MEMBERS	
	
	
STRUCTURAL CONSULTANT	
	
Project Name	
Consultancy Services for New Air Traffic Control Tower (ATCT), Fire Station and Allied Facilities at Skardu International Airport	
Detailed Architectural Design Drawings	
Sheet Name	
WINDOW'S DETAIL	
Date	12 January, 2026
Scale	NTS
Drawn by	Asad
Checked by	Ar. Ahmed Ali
Approved by	Ar. Anwar Ali
Drawing No.	AW-29 @A3

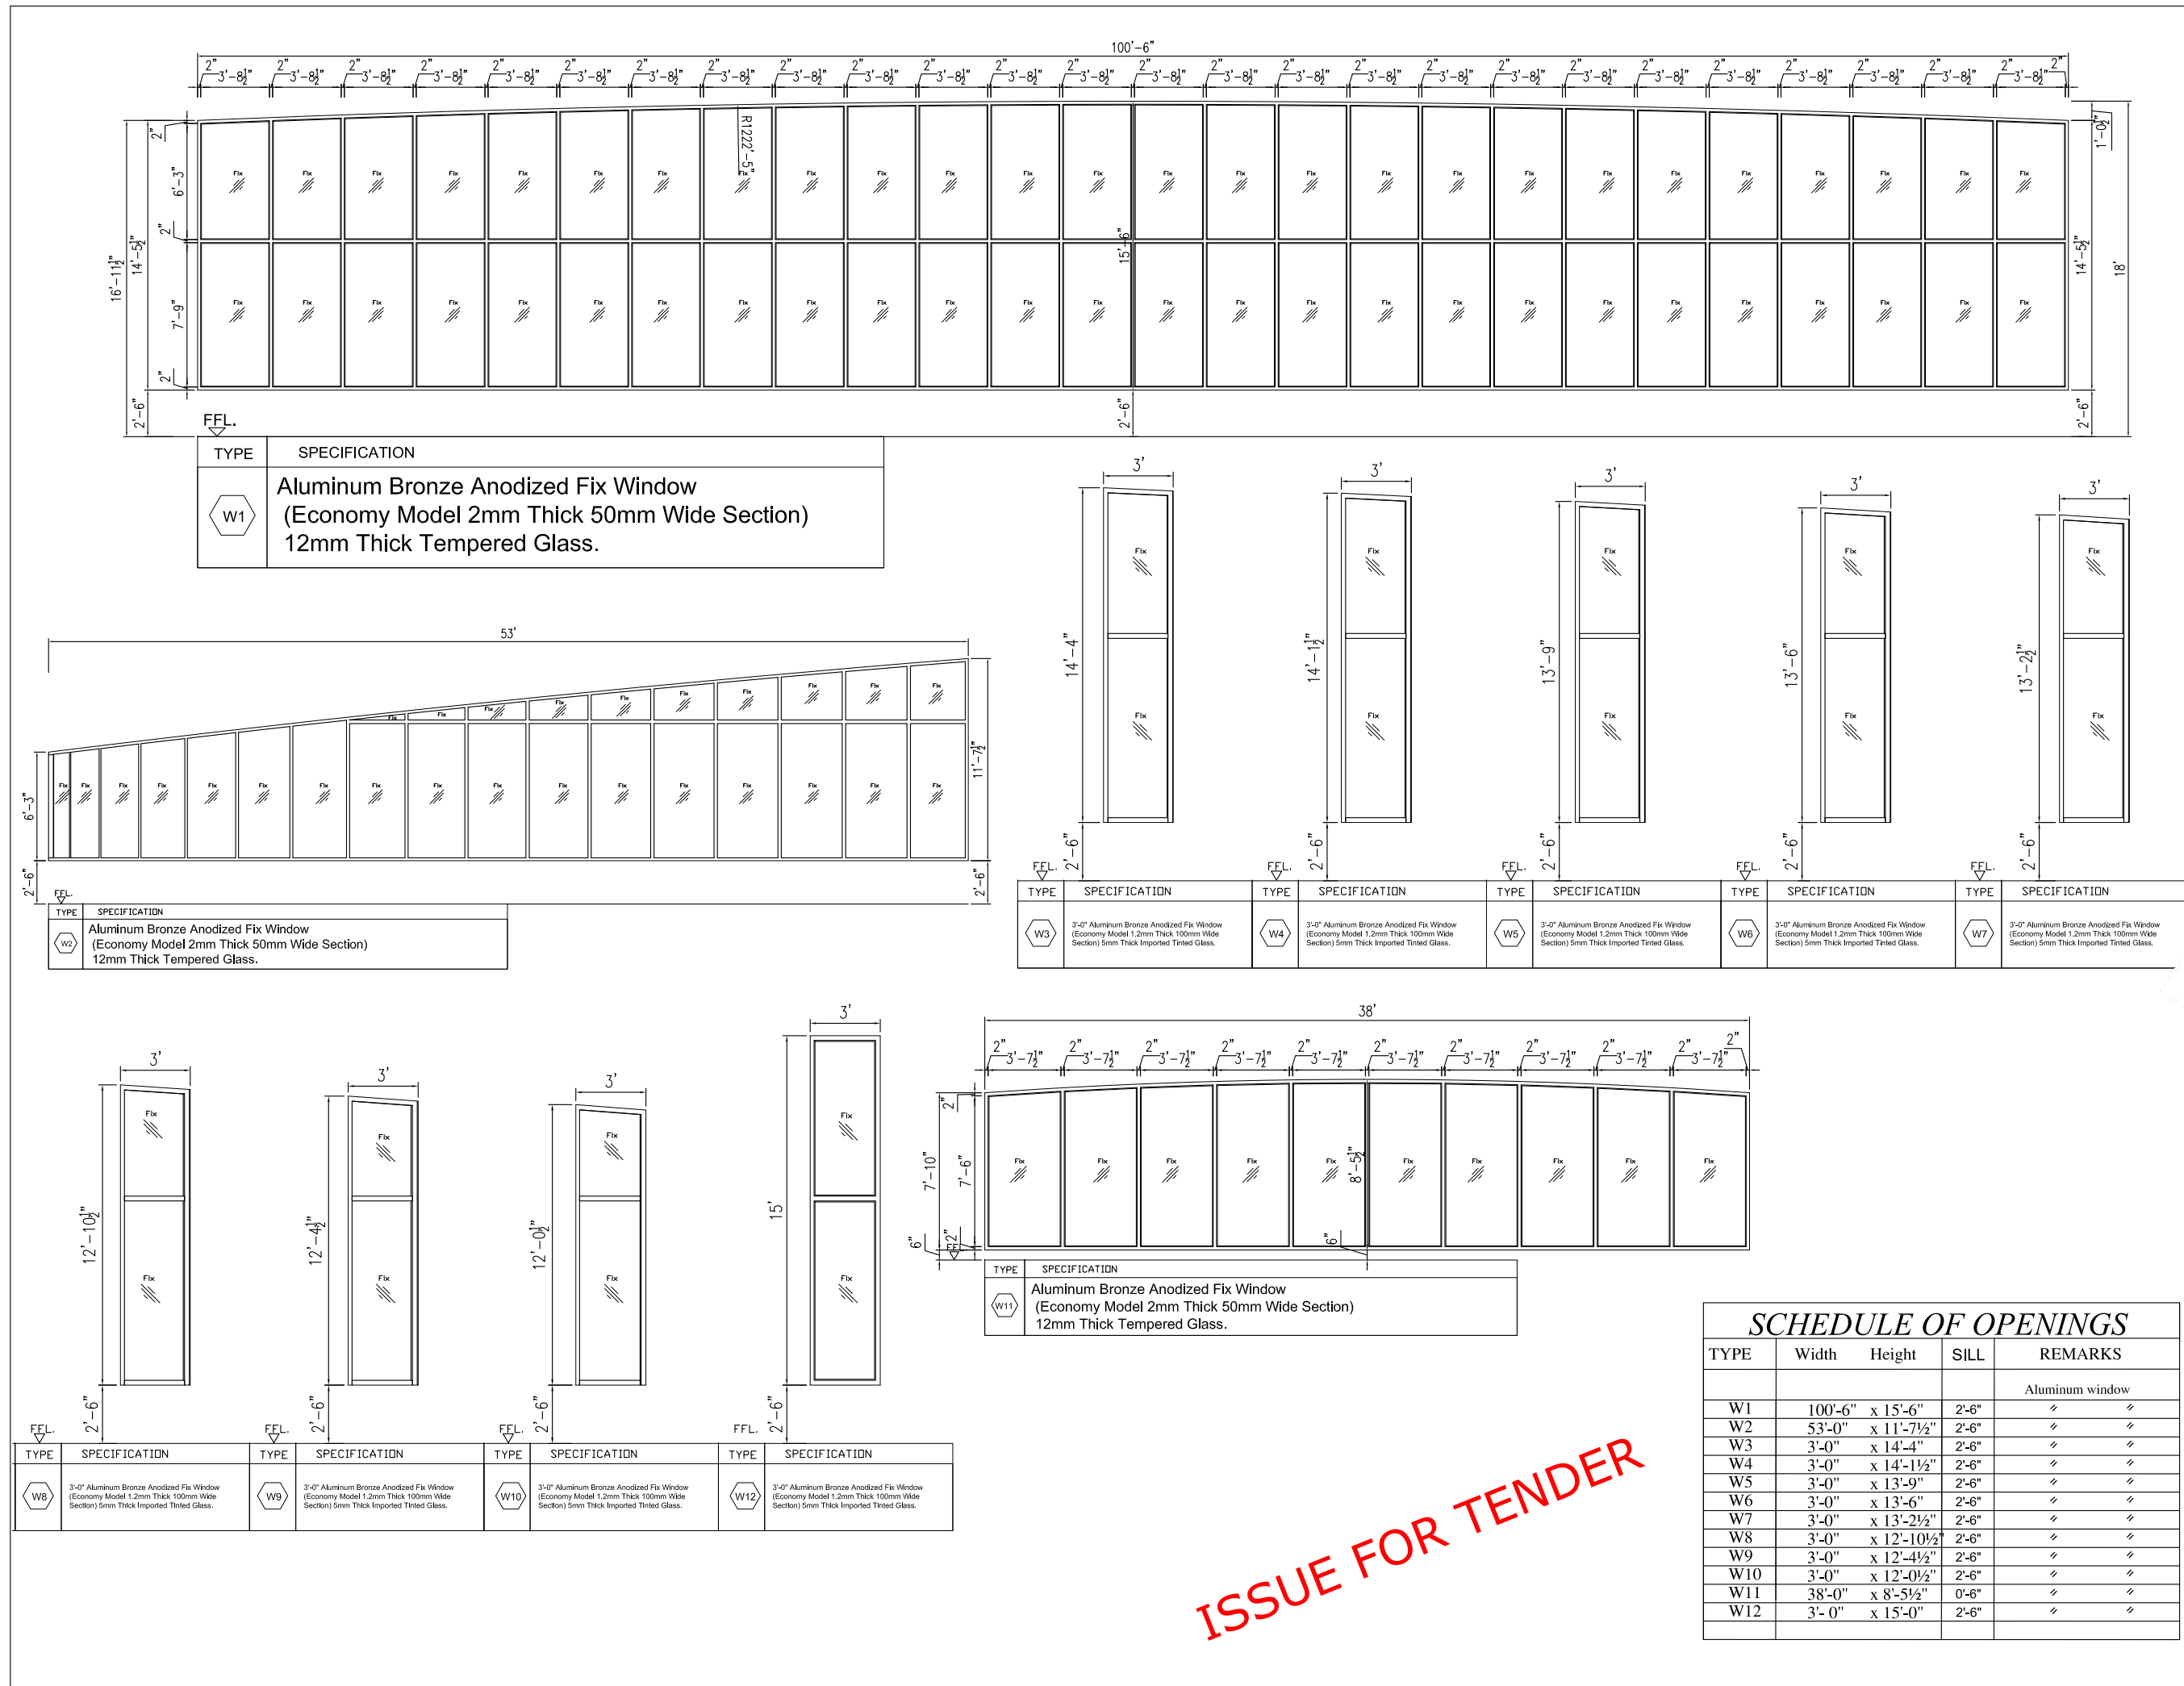


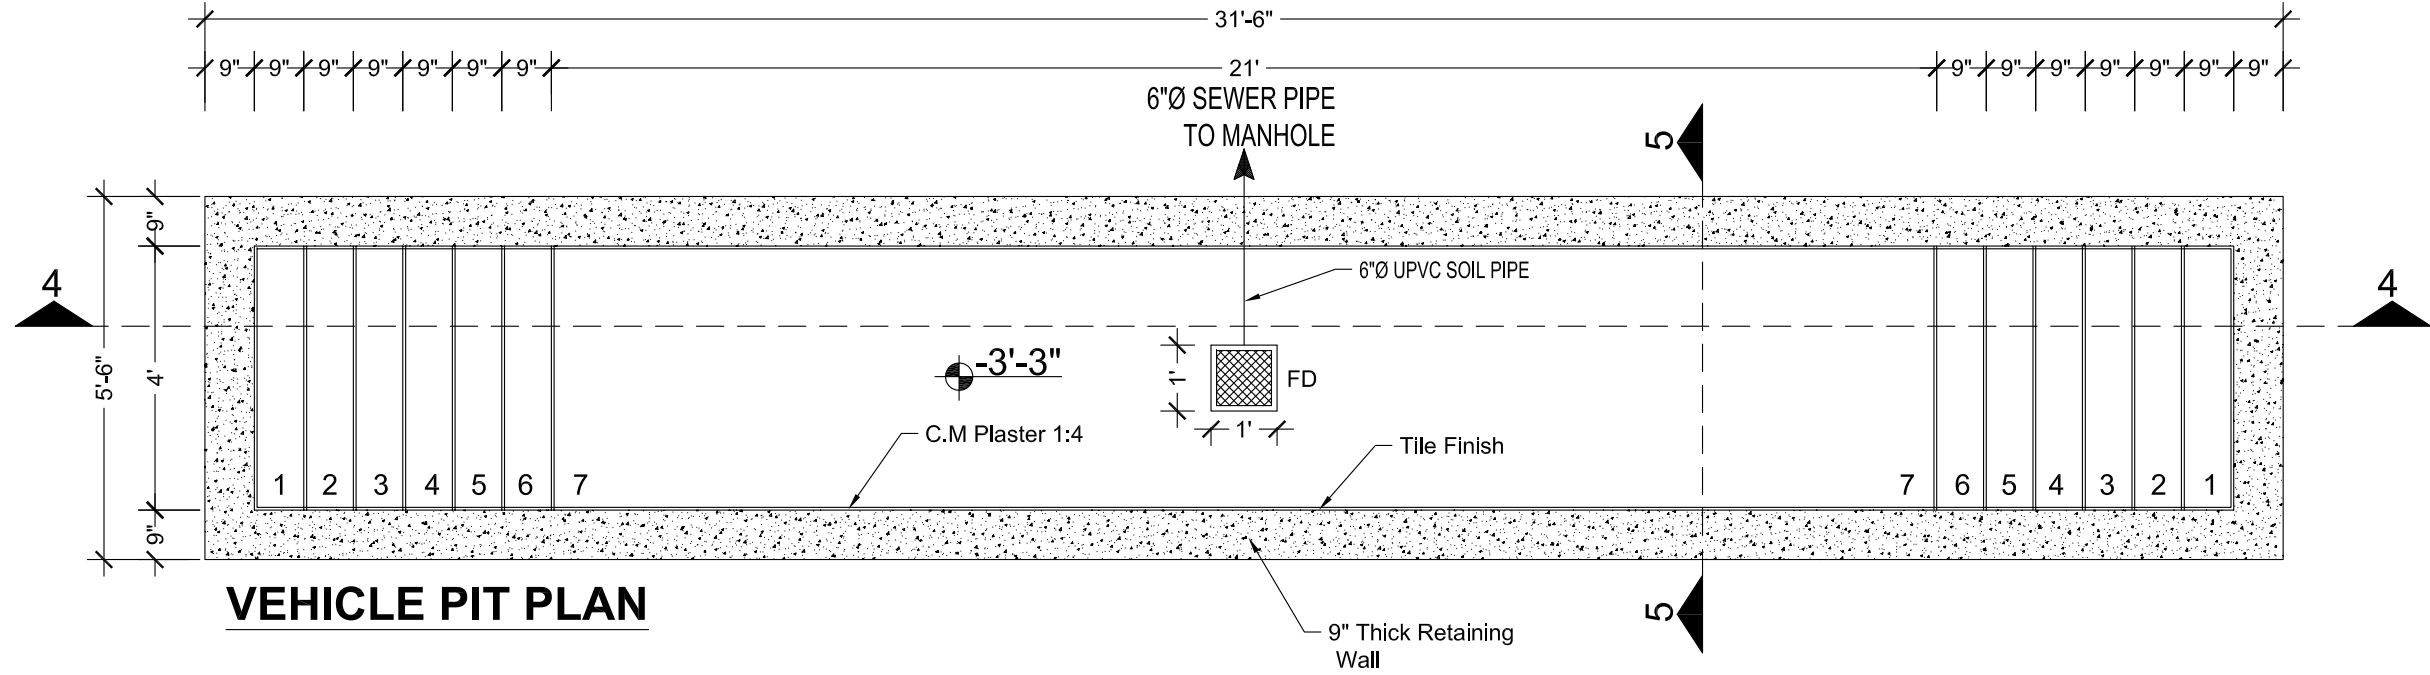

VEHICLE PIT PLAN

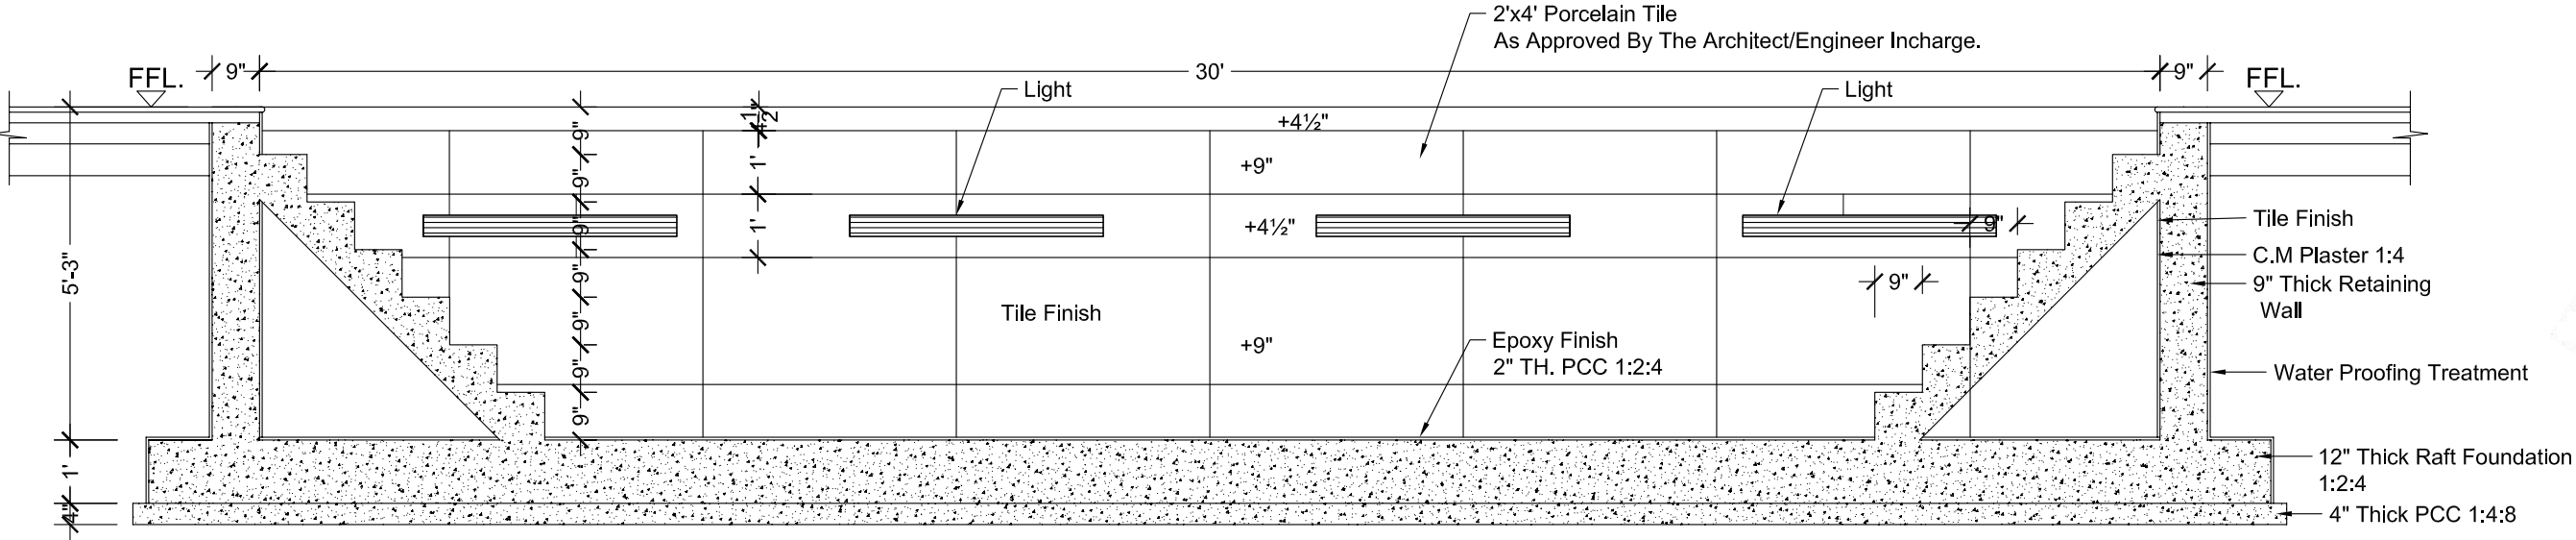

PIT SECTION 4-4

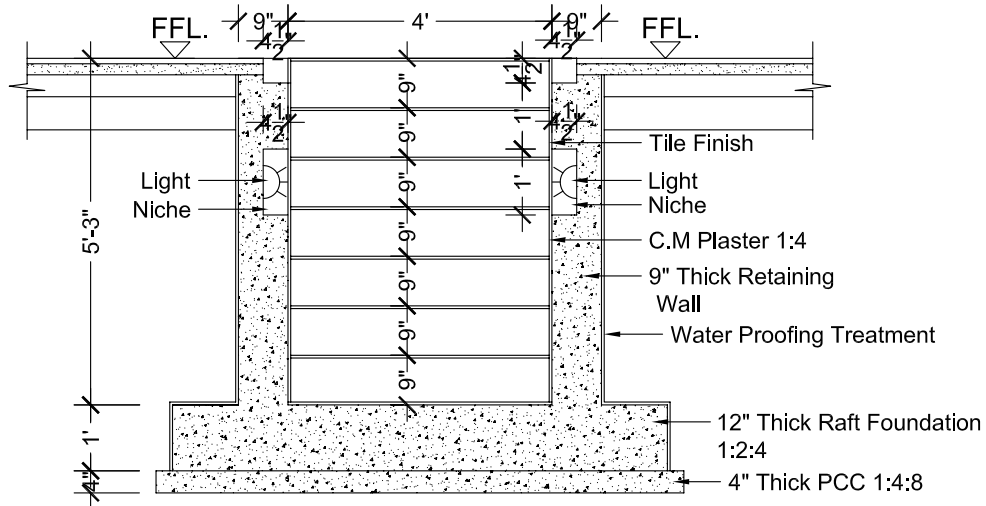

PIT SECTION 5-5

ISSUE FOR TENDER

NOTES:
These drawings are confidential and is the exclusive property of AAA (Pvt)Ltd. And is loaned subject to the condition that it is not to be reproduced to furnish for the making of drawing or prints except as sanctioned in writing by AAA (Pvt)Ltd.

CLIENT NAME


پاکستان ایئر پورٹس اتھارٹی

MAIN CONSULTANT


Formerly Anwar Ali & Associates Since March 2006 to June 2018
Consulting Architects, Engineers, Planners & Management Consultants


JV MEMBERS





STRUCTURAL CONSULTANT

NORTH ORIENTATION

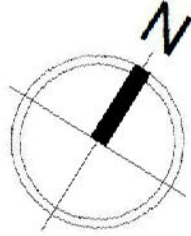

Project Name


Consultancy Services for
New Air Traffic
Control Tower (ATCT),
Fire Station and Allied
Facilities at Skardu
International Airport

Detailed Architectural
Design Drawings




Sheet Name

VEHICLE PIT DETAIL


Date	12 January, 2026
Scale	NTS
Drawn by	Asad
Checked by	Ar. Ahmed Ali
Approved by	Ar. Anwar Ali
Drawing No.	AW-29a @A3

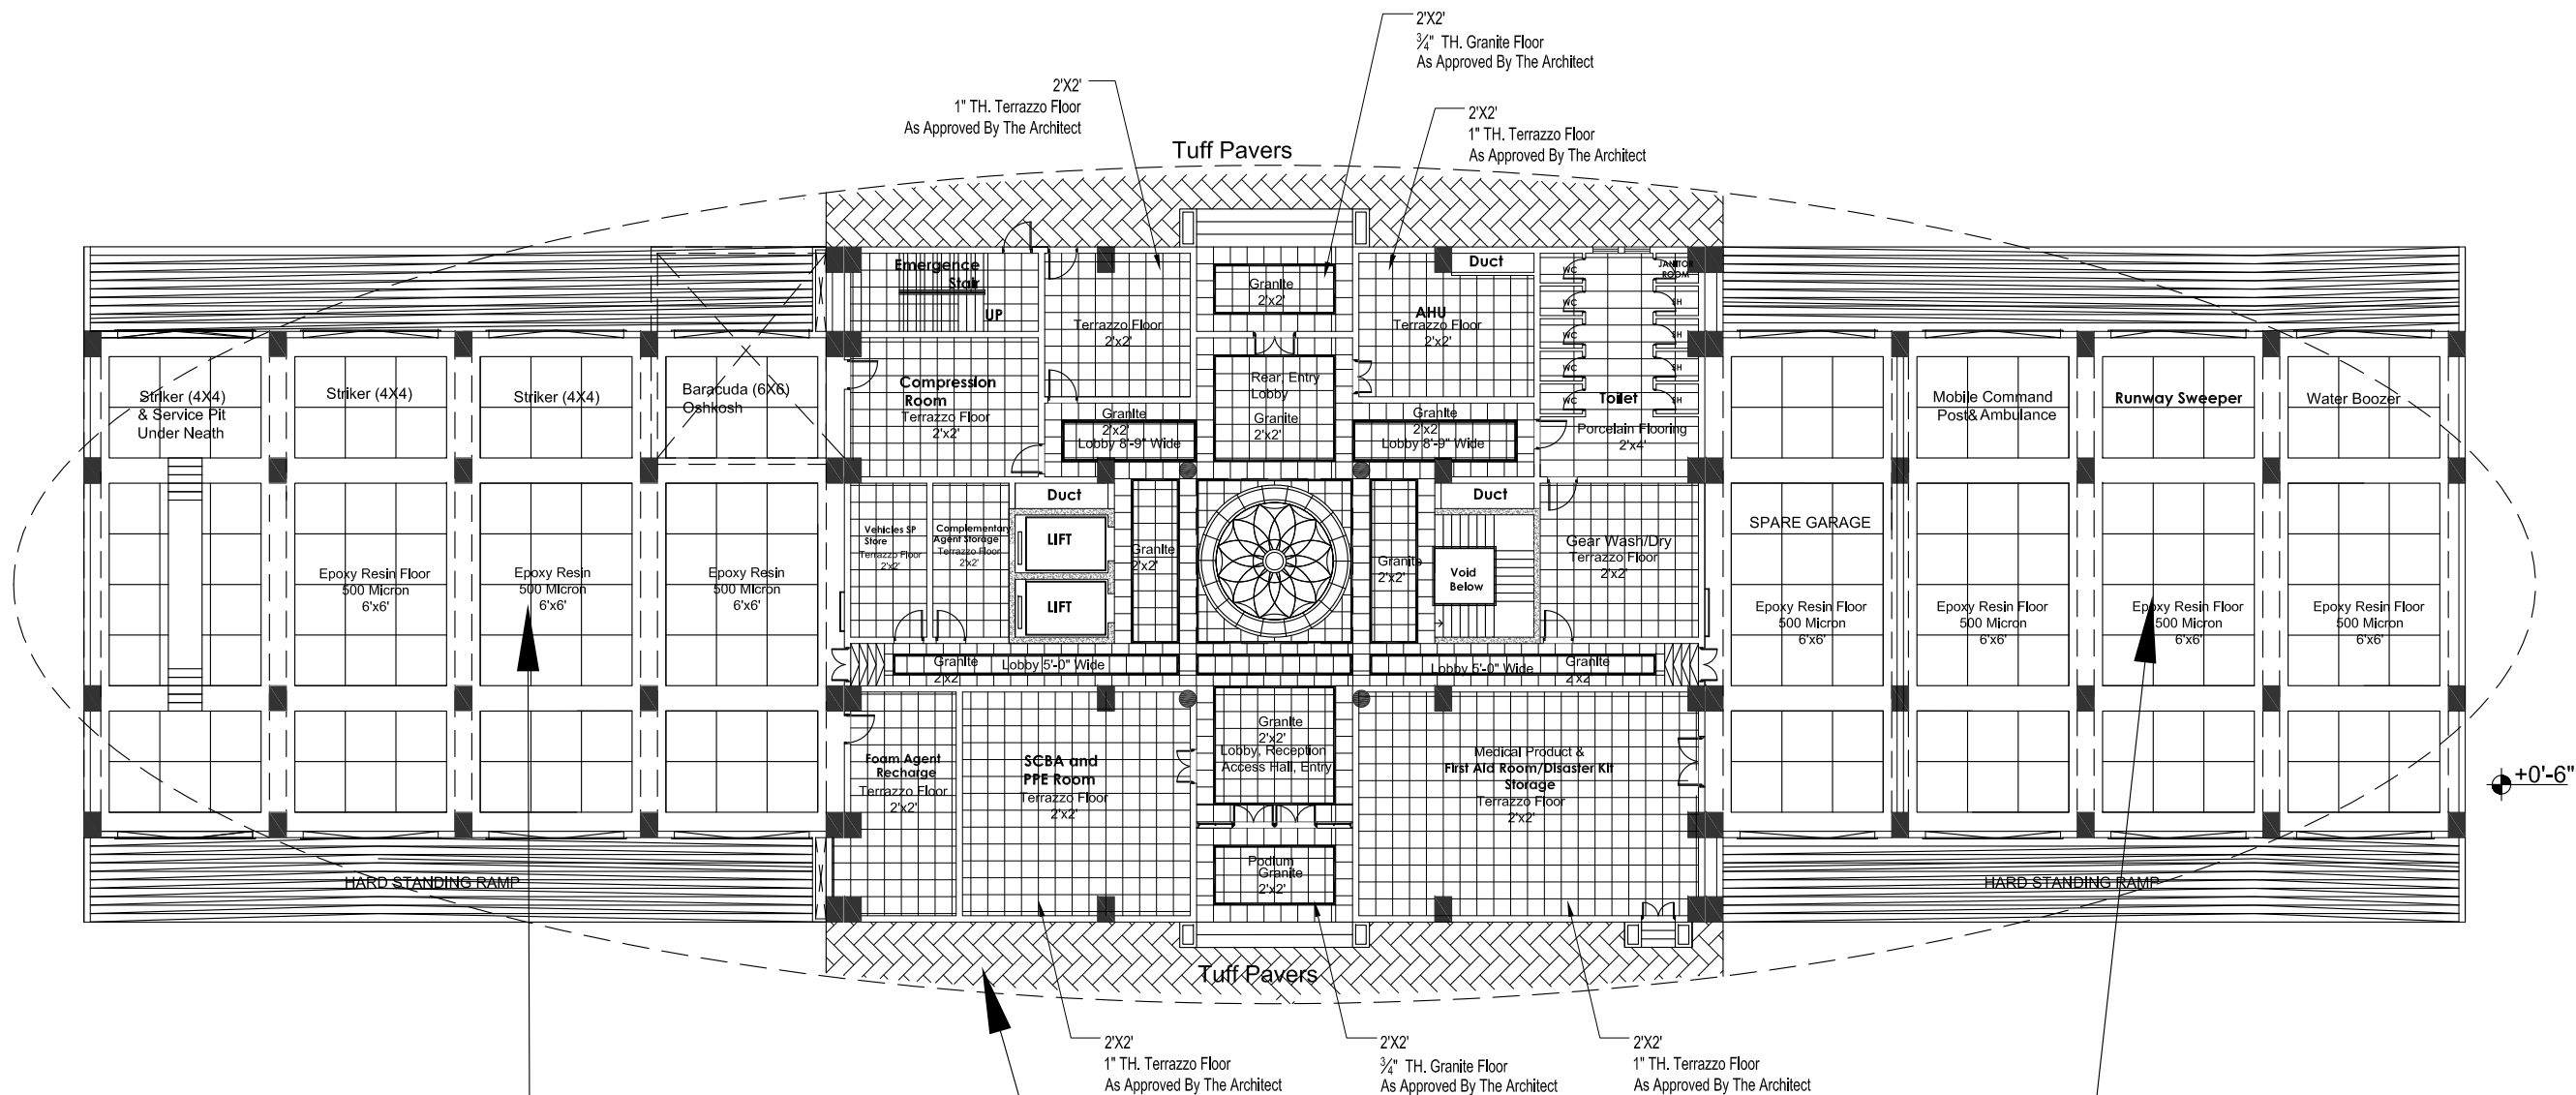




GROUND FLOOR PLAN

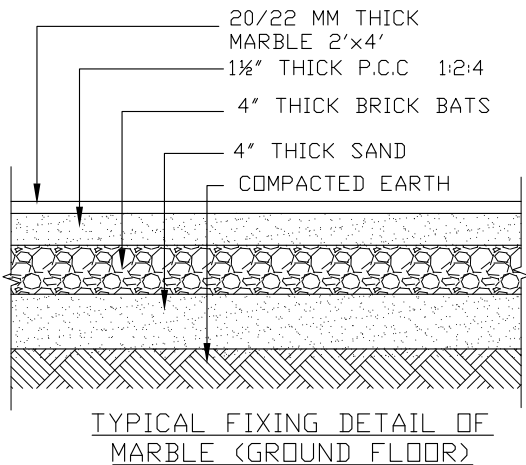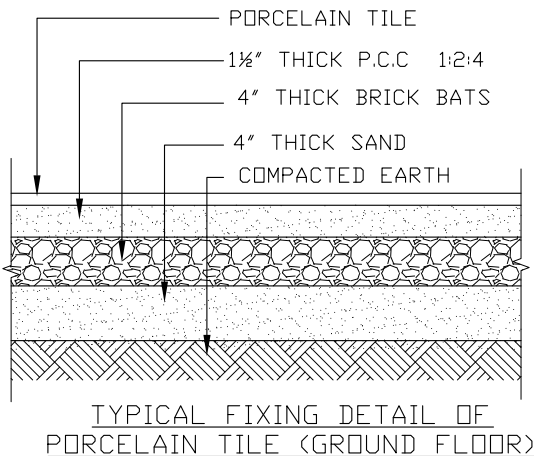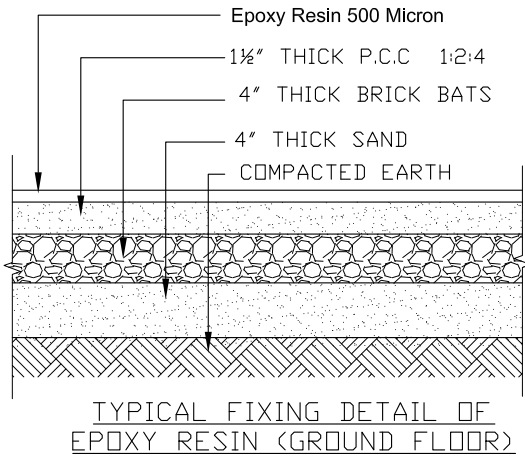


ISSUE FOR TENDER

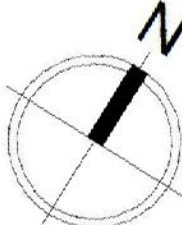
NOTES: These drawings are confidential and is the exclusive property of AAA (Pvt)Ltd. And is loaned subject to the condition that it is not to be reproduced to furnish for the making of drawing or prints except as sanctioned in writing by AAA (Pvt)Ltd.	
CLIENT NAME	
 پاکستان ایئر پورٹس اتھارٹی	
MAIN CONSULTANT	
 Formerly Anwar Ali & Associates Since March 2006 to June 2018 Consulting Architects, Engineers, Planners & Management Consultants	
JV MEMBERS	
	
 STRUCTURAL CONSULTANT	
NORTH ORIENTATION	
	
Project Name	
Consultancy Services for New Air Traffic Control Tower (ATCT), Fire Station and Allied Facilities at Skardu International Airport	
Detailed Architectural Design Drawings	
Sheet Name	
GROUND FLOOR PATTERN	
Date	14 JANUARY, 2026
Scale	NTS
Drawn by	Ar. Sidra Tabassum
Checked by	Ar. Ahmed Ali
Approved by	Ar. Anwar Ali
Drawing No.	AW-30 @A3

ARFF FLOOR
MEZZANINE FLOOR PLAN

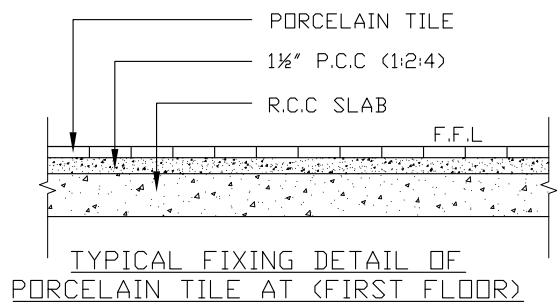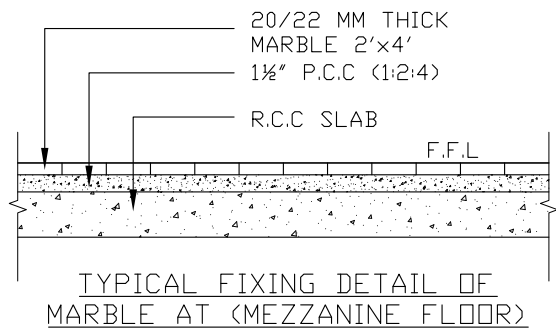
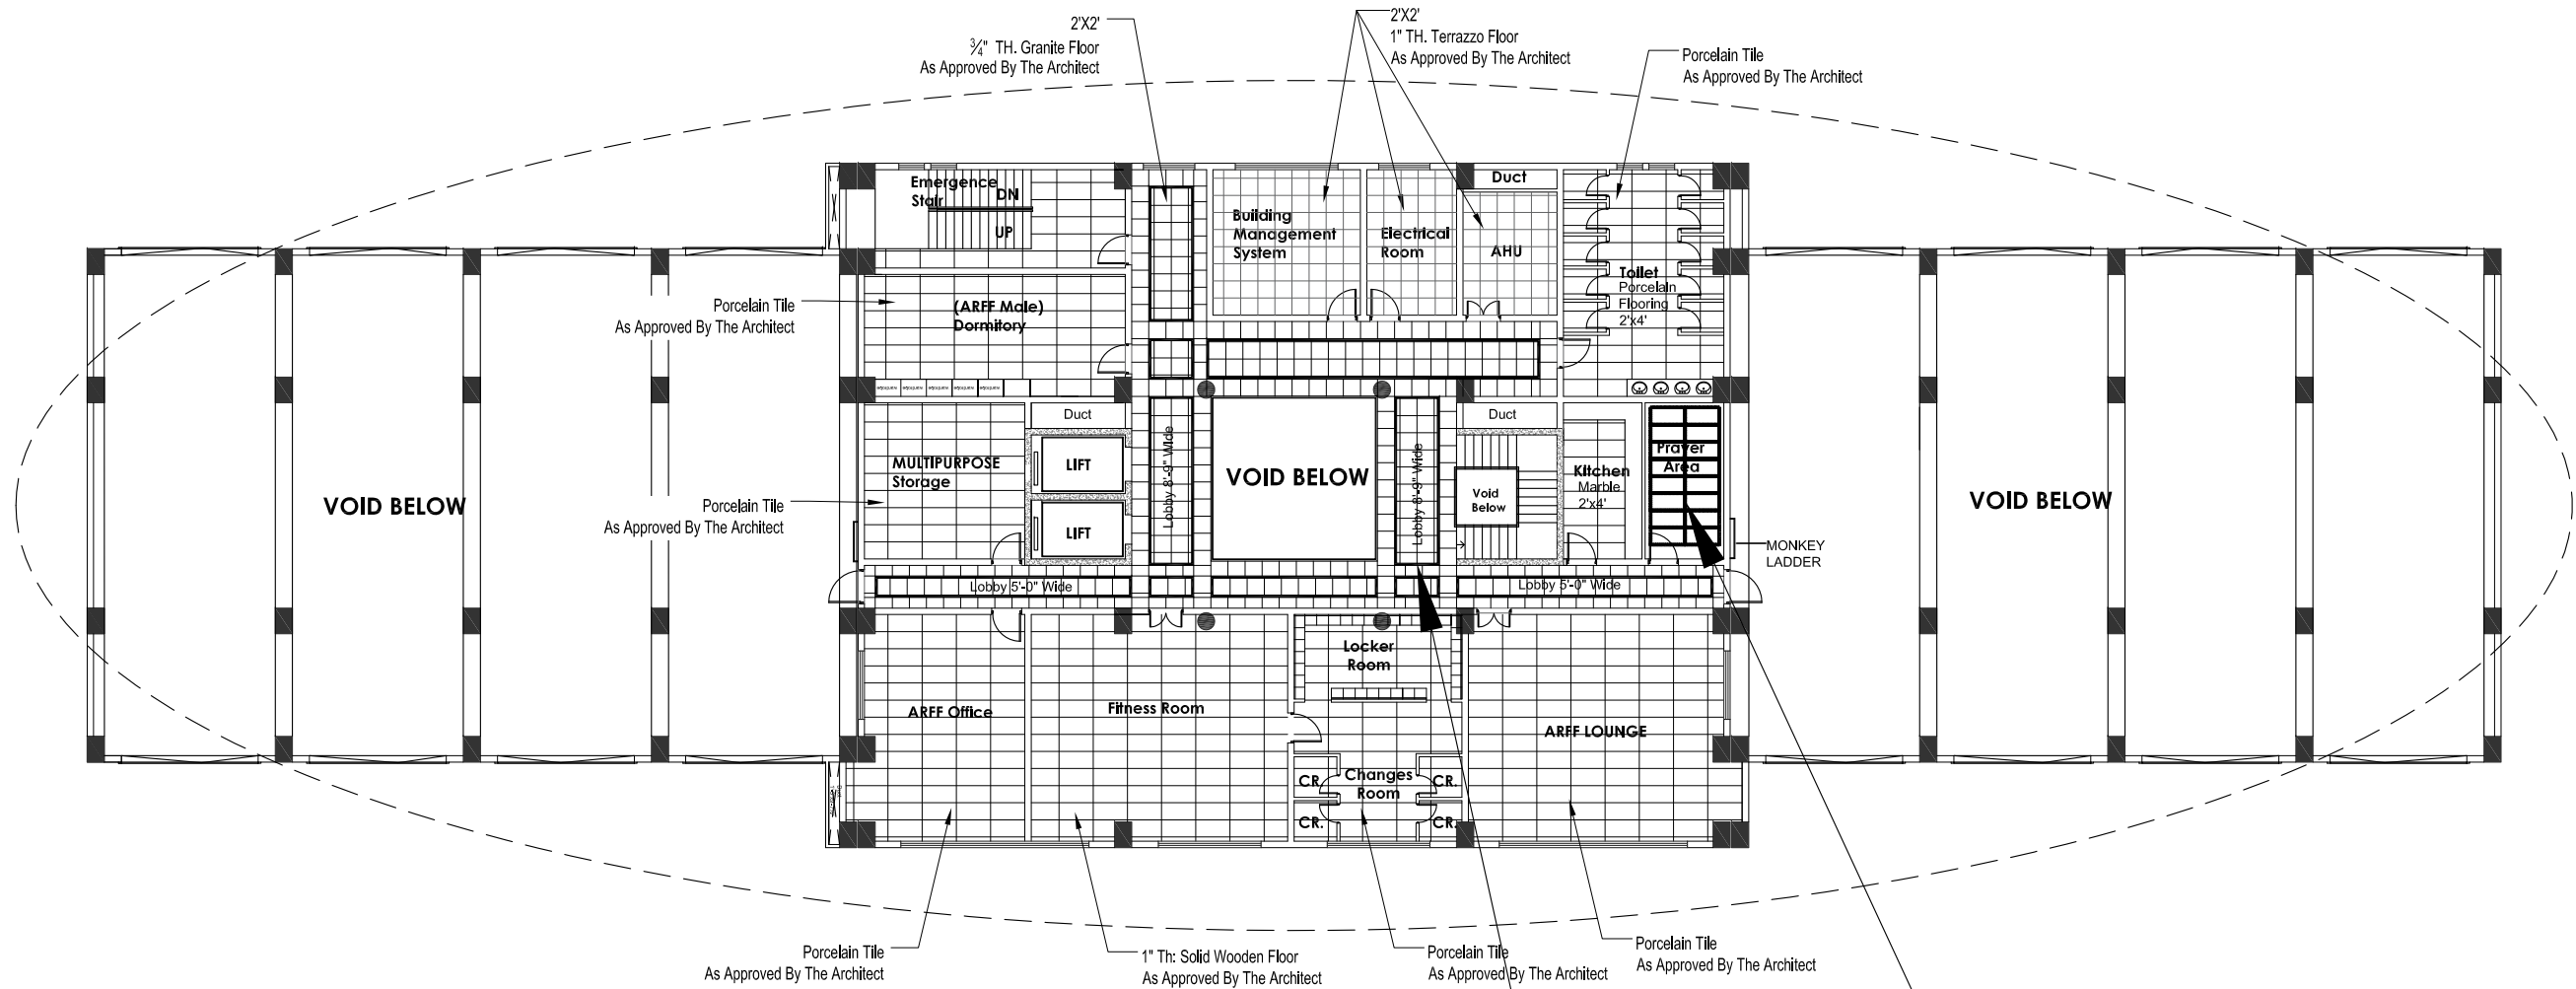


ISSUE FOR TENDER

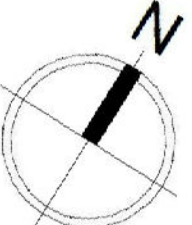
NOTES: These drawings are confidential and is the exclusive property of AAA (Pvt)Ltd. And is loaned subject to the condition that it is not to be reproduced to furnish for the making of drawing or prints except as sanctioned in writing by AAA (Pvt)Ltd.	
CLIENT NAME	
 پاکستان ایئر پورٹس اتھارٹی	
MAIN CONSULTANT	
 Formerly Anwar Ali & Associates Since March 2006 to June 2018 Consulting Architects, Engineers, Planners & Management Consultants	
JV MEMBERS	
 leit-werk	
STRUCTURAL CONSULTANT	
NORTH ORIENTATION	
	
Project Name	
Consultancy Services for New Air Traffic Control Tower (ATCT), Fire Station and Allied Facilities at Skardu International Airport	
Detailed Architectural Design Drawings	
Sheet Name	
MEZZANINE FLOOR PATTERN	
Date	14 JANUARY, 2026
Scale	NTS
Drawn by	Ar. Sidra Tabassum
Checked by	Ar. Ahmed Ali
Approved by	Ar. Anwar Ali
Drawing No.	AW-31 @A3

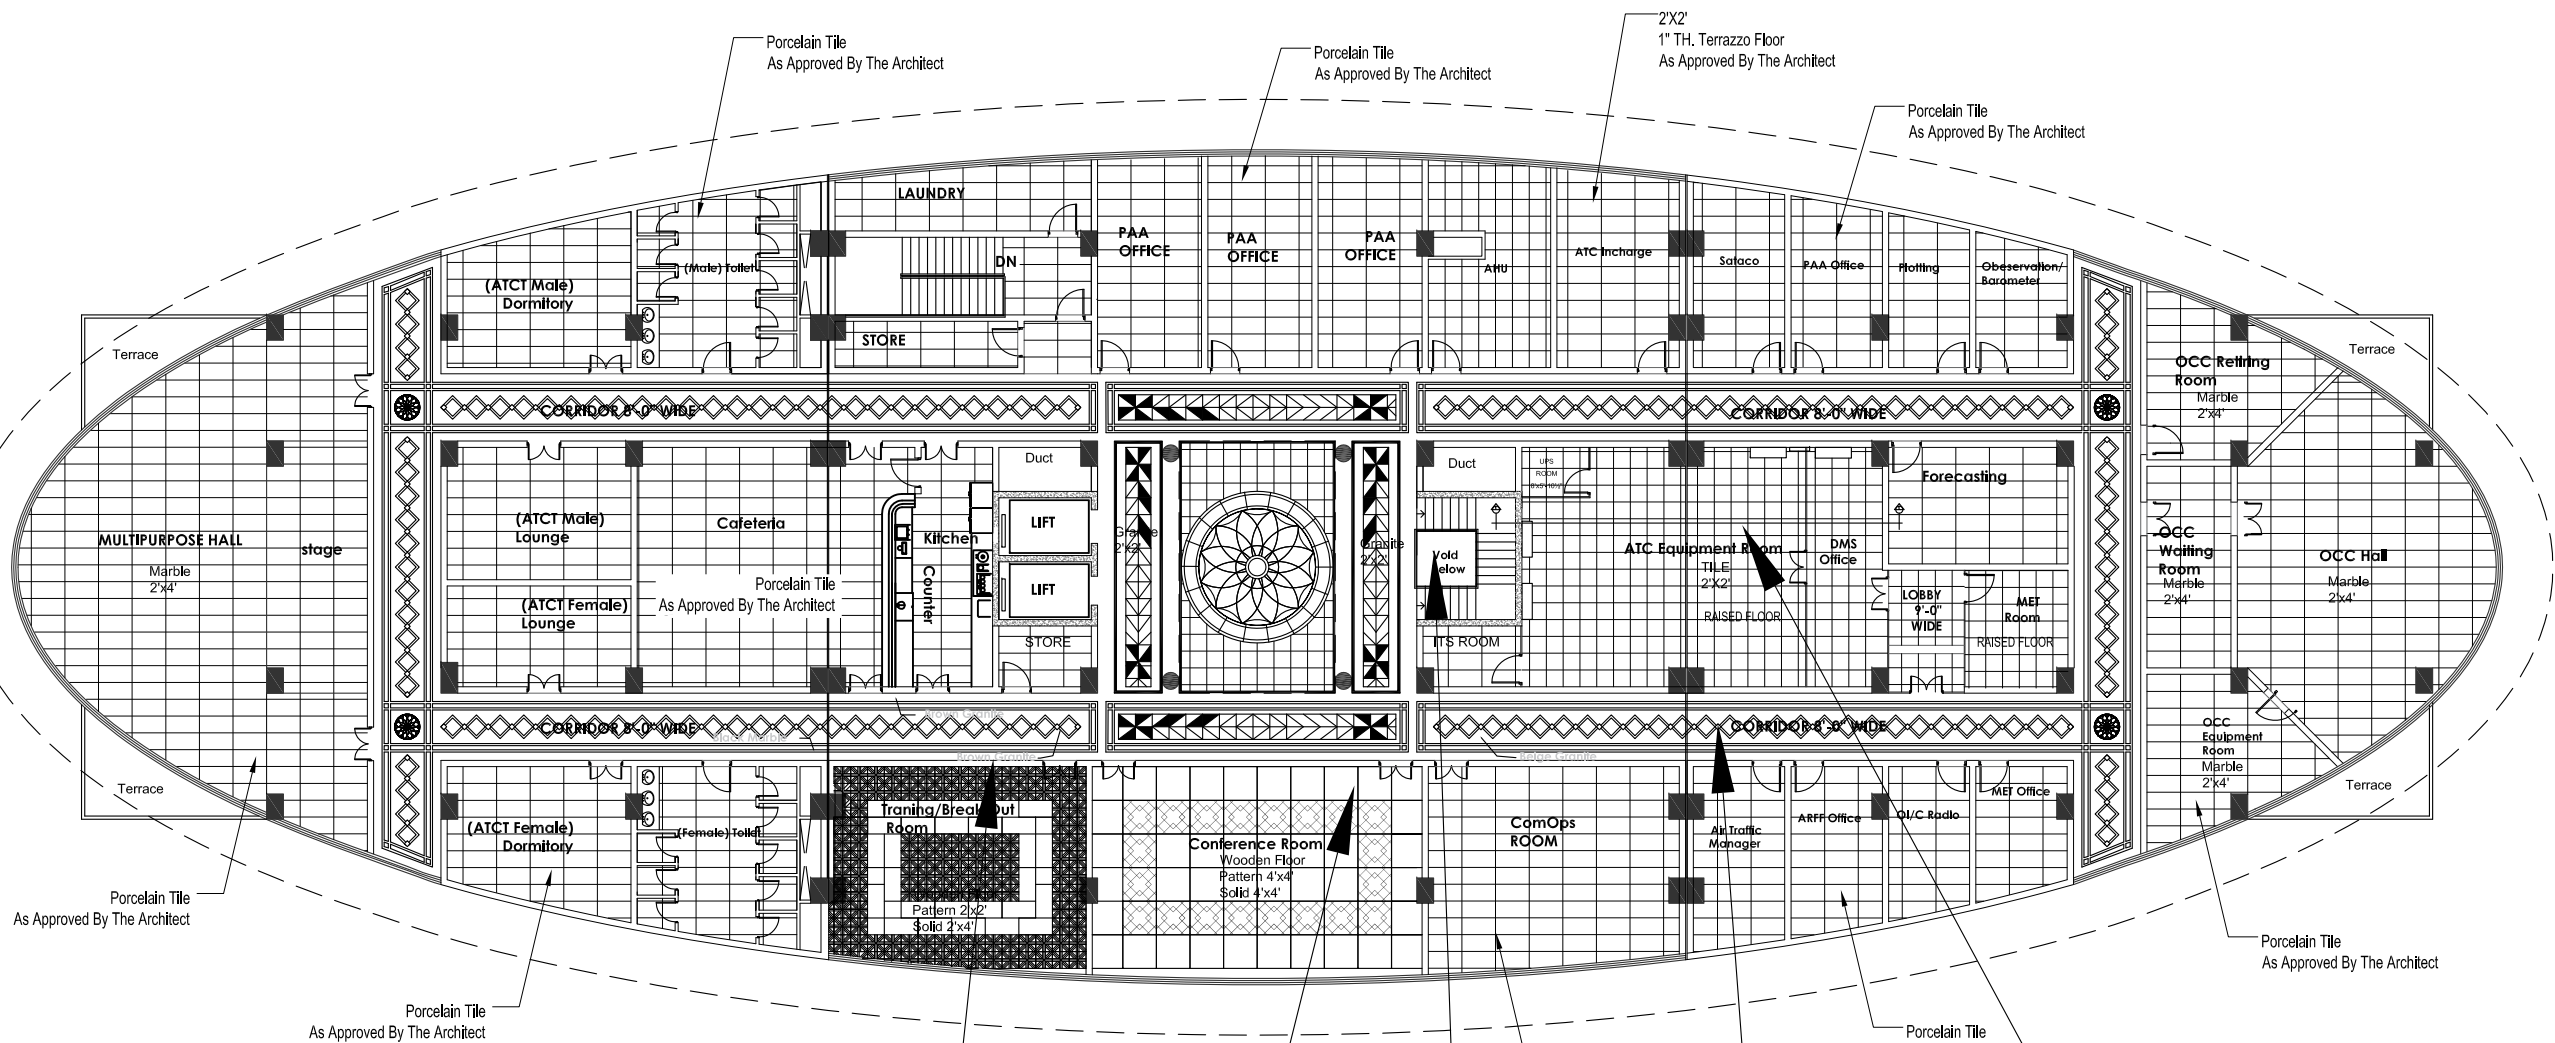

FIRST FLOOR PLAN

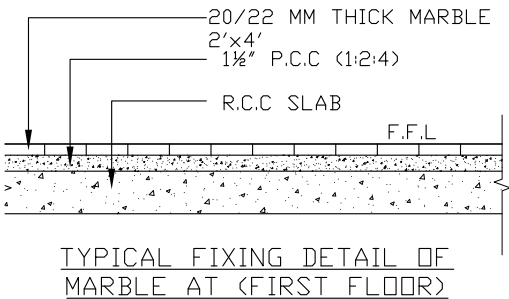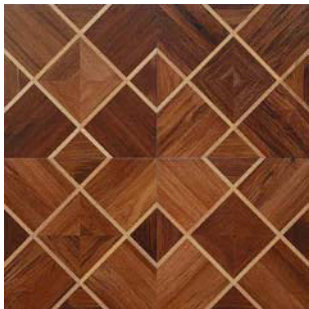

TYPICAL FIXING DETAIL OF MARBLE AT (FIRST FLOOR)

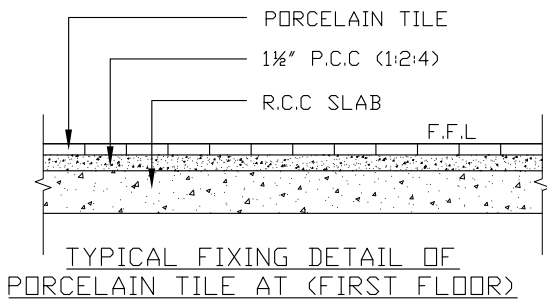

TYPICAL FIXING DETAIL OF PORCELAIN TILE AT (FIRST FLOOR)

ISSUE FOR TENDER

NOTES:

These drawings are confidential and is the exclusive property of AAA (Pvt)Ltd. And is loaned subject to the condition that it is not to be reproduced to furnish for the making of drawing or prints except as sanctioned in writing by AAA (Pvt)Ltd.

CLIENT NAME



MAIN CONSULTANT




JV MEMBERS



leit-werk

STRUCTURAL CONSULTANT

NORTH ORIENTATION

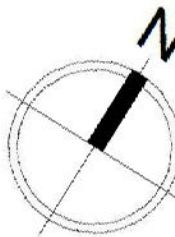

Project Name


Consultancy Services for New Air Traffic Control Tower (ATCT), Fire Station and Allied Facilities at Skardu International Airport

Detailed Architectural Design Drawings




Sheet Name

FIRST FLOOR PATTERN


Date	14 JANUARY, 2026
Scale	NTS
Drawn by	Ar. Sidra Tabassum
Checked by	Ar. Ahmed Ali
Approved by	Ar. Anwar Ali
Drawing No.	AW-32 @A3

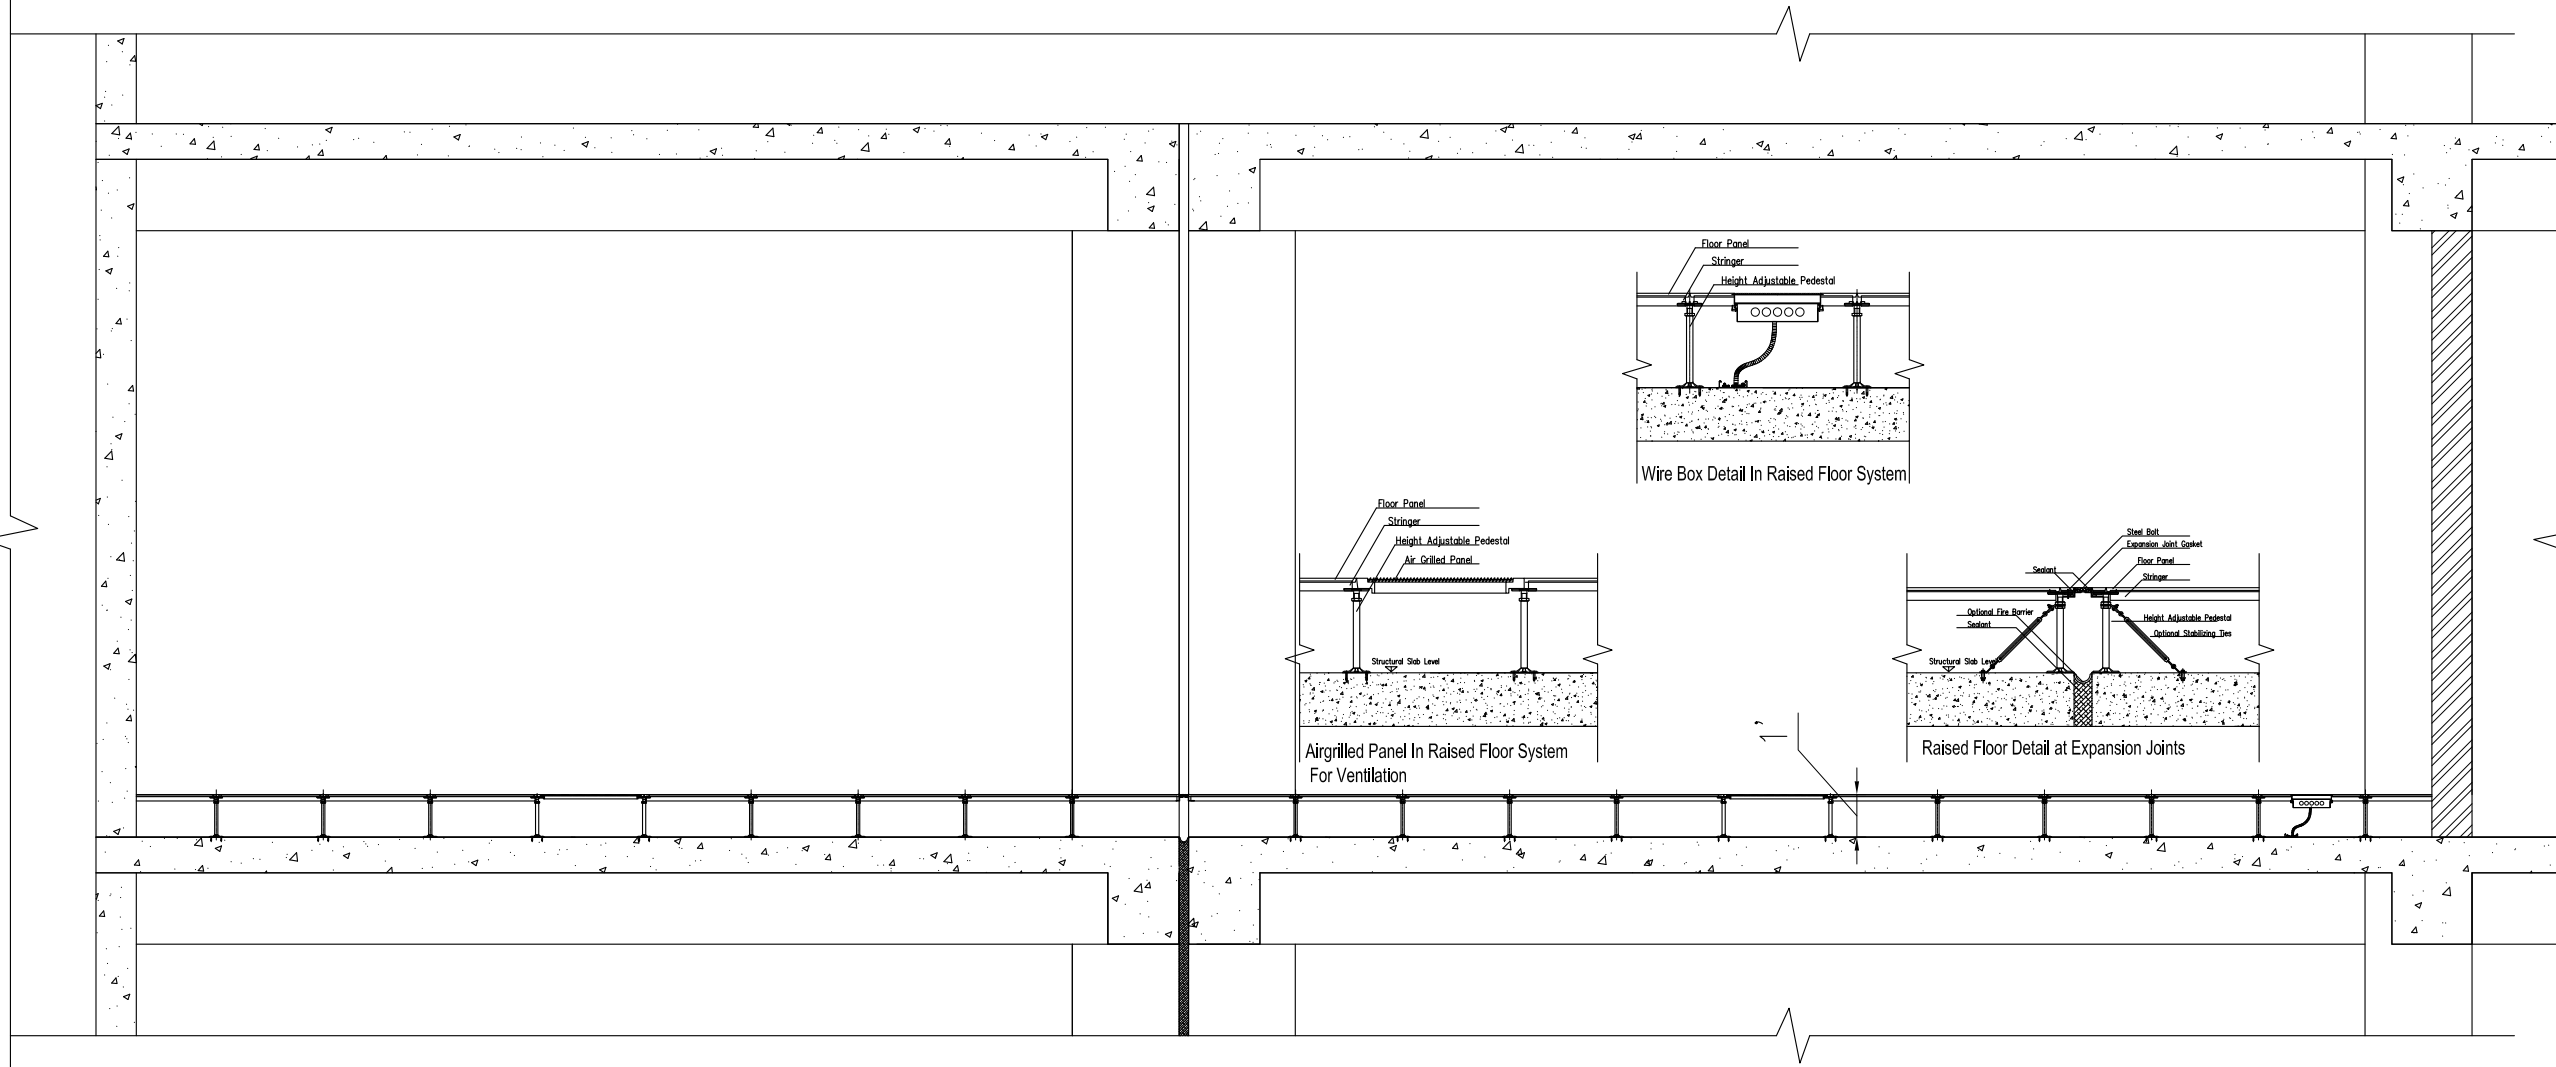


DETAIL-1
ATC Equipment Room
RAISED FLOOR

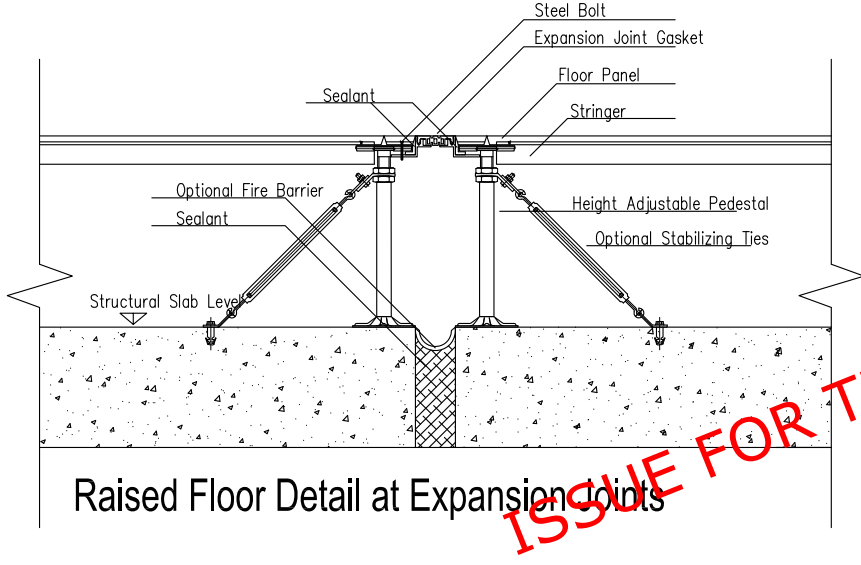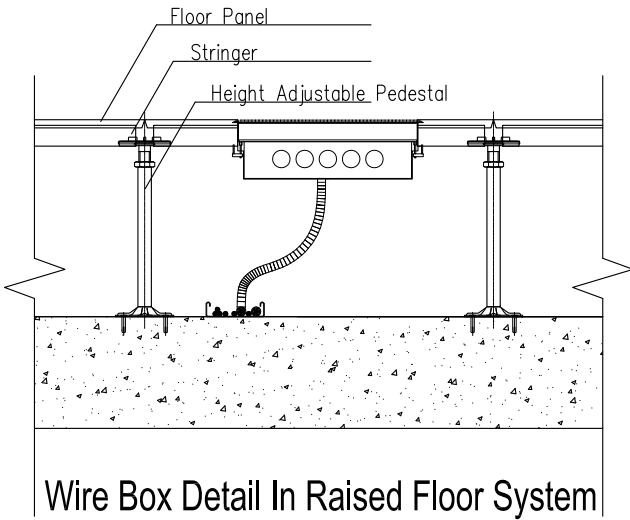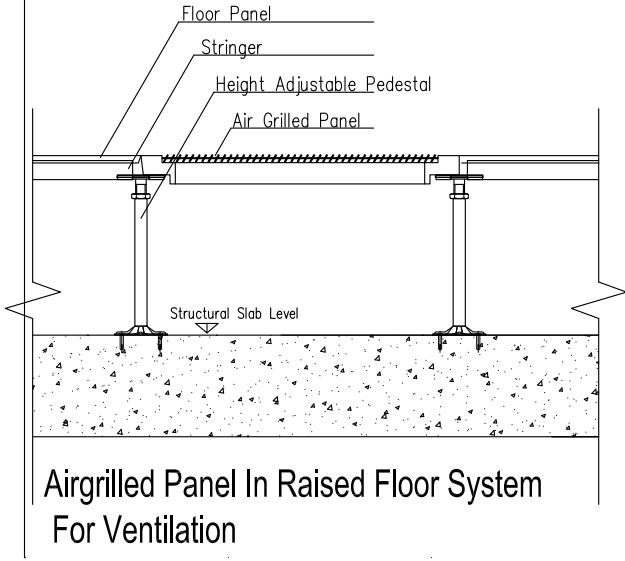

ISSUE FOR TENDER

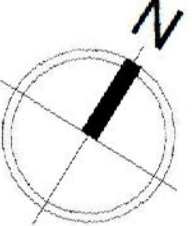NOTES: These drawings are confidential and is the exclusive property of AAA (Pvt)Ltd. And is loaned subject to the condition that it is not to be reproduced to furnish for the making of drawing or prints except as sanctioned in writing by AAA (Pvt)Ltd.	
CLIENT NAME	
 پاکستان ایئر پورٹس اتھارٹی	
MAIN CONSULTANT	
 Formerly Anwar Ali & Associates Since March 2006 to June 2018 Consulting Architects, Engineers, Planners & Management Consultants	
JV MEMBERS	
 leit-werk	
STRUCTURAL CONSULTANT	
NORTH ORIENTATION	
	
Project Name	
Consultancy Services for New Air Traffic Control Tower (ATCT), Fire Station and Allied Facilities at Skardu International Airport	
Detailed Architectural Design Drawings	
Sheet Name	
ATC EQUIPMENT ROOM RAISED FLOOR DETAIL	
Date	14 JANUARY, 2026
Scale	NTS
Drawn by	Ar. Sidra Tabassum
Checked by	Ar. Ahmed Ali
Approved by	Ar. Anwar Ali
Drawing No.	AW-32a @A3

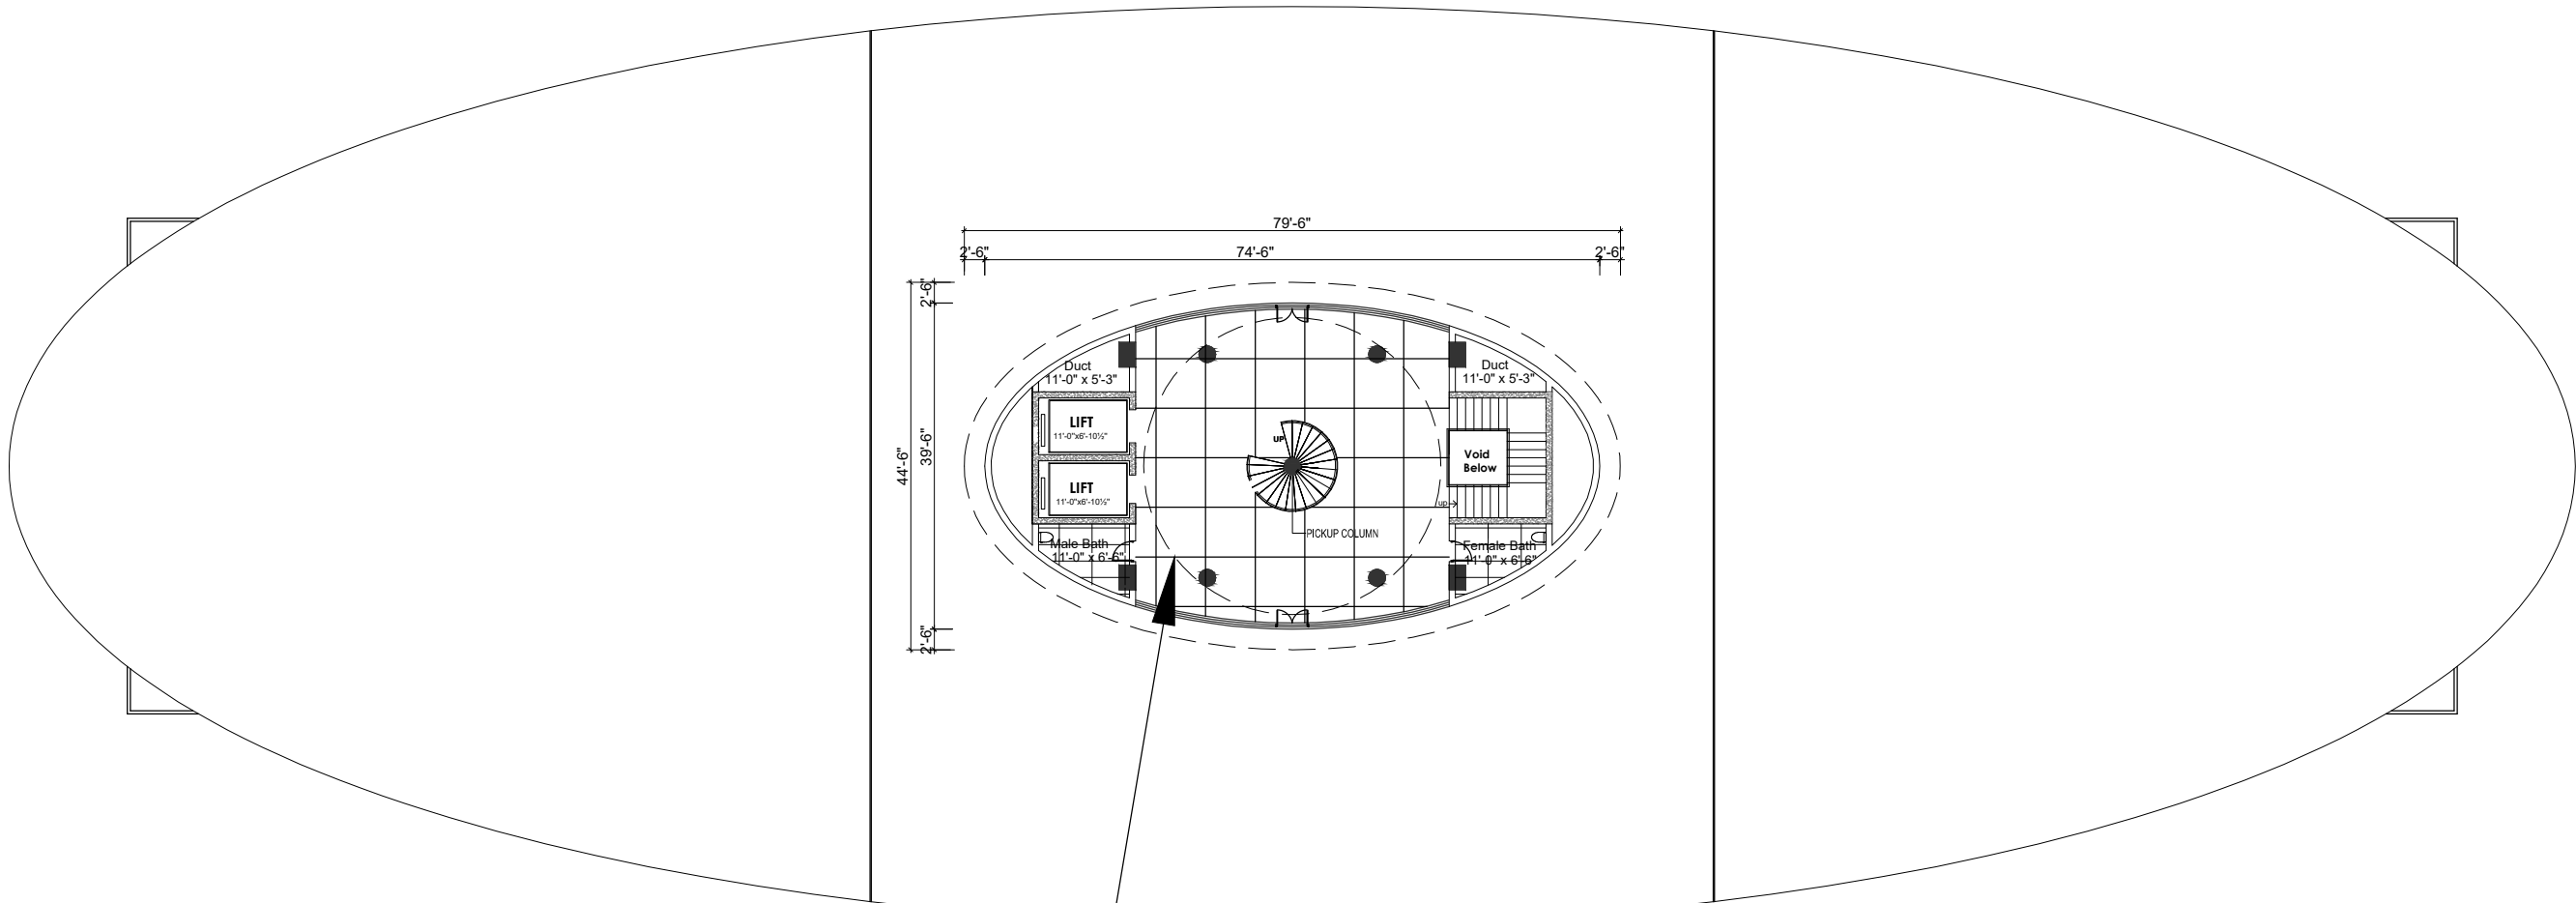


ROOF FLOOR PLAN LEVEL AT 46'-0"




ISSUE FOR TENDER


NOTES: These drawings are confidential and is the exclusive property of AAA (Pvt)Ltd. And is loaned subject to the condition that it is not to be reproduced to furnish for the making of drawing or prints except as sanctioned in writing by AAA (Pvt)Ltd.	
CLIENT NAME	
MAIN CONSULTANT	
JV MEMBERS	
STRUCTURAL CONSULTANT	
NORTH ORIENTATION	
Project Name	
Consultancy Services for New Air Traffic Control Tower (ATCT), Fire Station and Allied Facilities at Skardu International Airport	
Detailed Architectural Design Drawings	
Sheet Name	
ROOF FLOOR PATTERN	
Date	14 JANUARY, 2026
Scale	NTS
Drawn by	Ar. Sidra Tabassum
Checked by	Ar. Ahmed Ali
Approved by	Ar. Anwar Ali
Drawing No.	AW-33 @A3

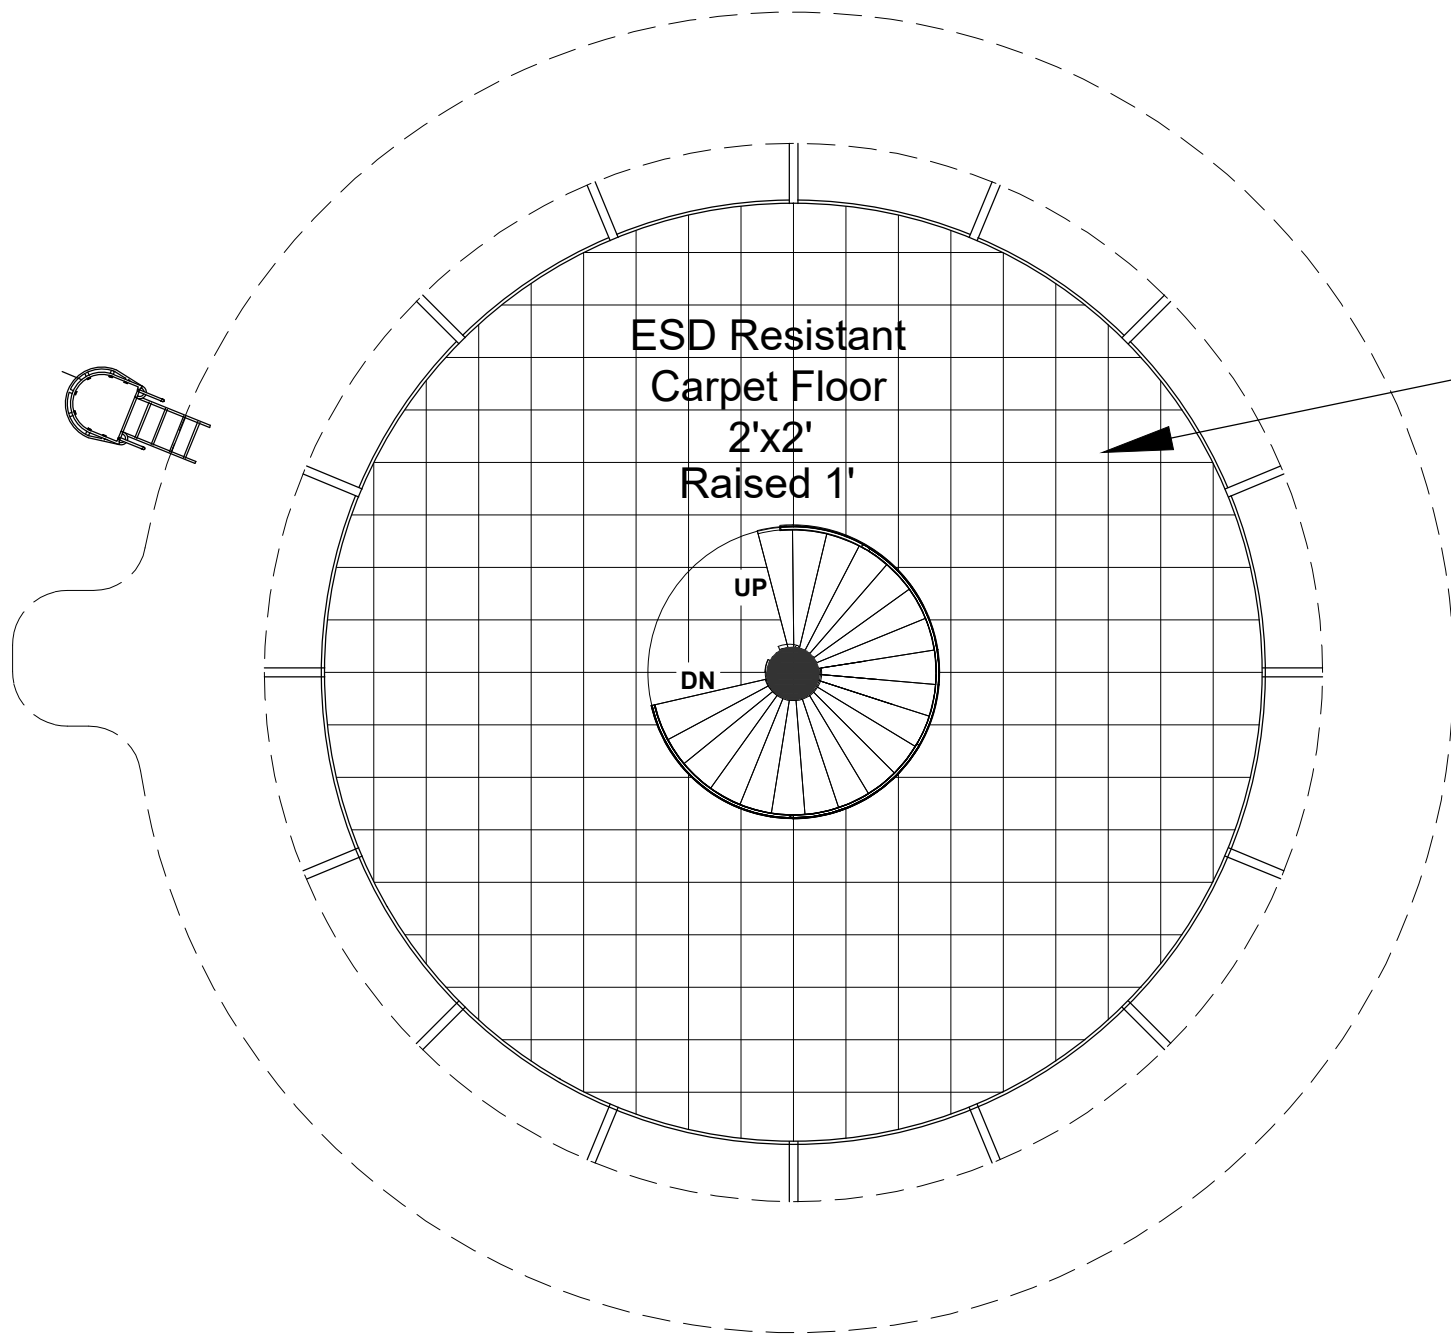


ARFF FLOOR PLAN LEVEL AT 56'-0"

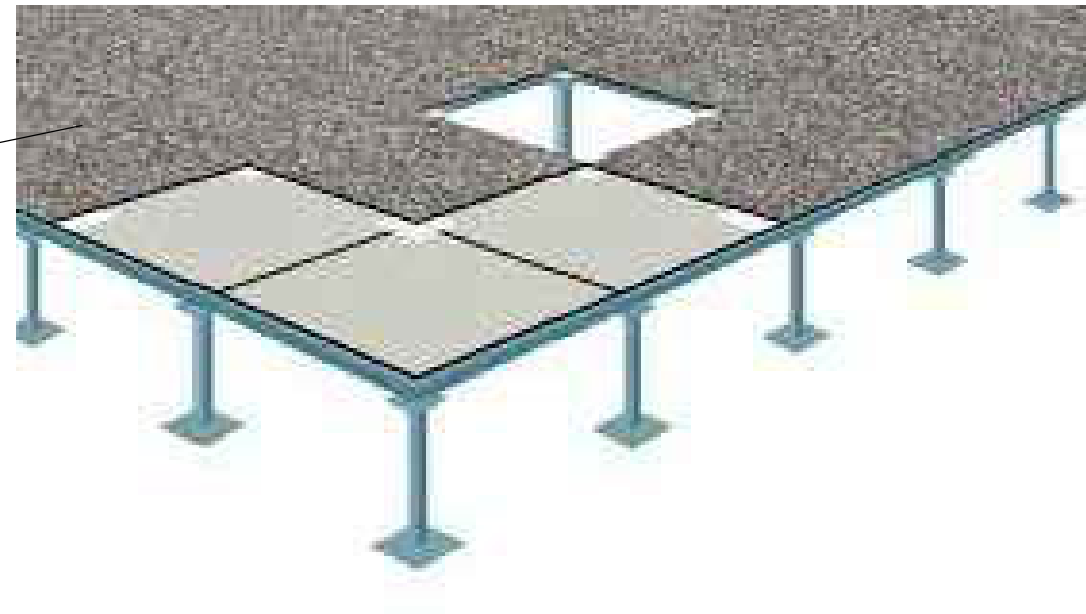


ISSUE FOR TENDER

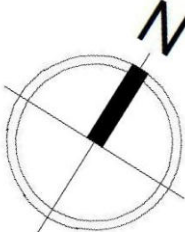NOTES: These drawings are confidential and is the exclusive property of AAA (Pvt)Ltd. And is loaned subject to the condition that it is not to be reproduced to furnish for the making of drawing or prints except as sanctioned in writing by AAA (Pvt)Ltd.	
CLIENT NAME	
 پاکستان ایئر پورٹس اتھارٹی	
MAIN CONSULTANT	
 Formerly Anwar Ali & Associates Since March 2006 to June 2018 Consulting Architects, Engineers, Planners & Management Consultants	
JV MEMBERS	
 leit-werk	
STRUCTURAL CONSULTANT	
NORTH ORIENTATION	
	
Project Name	
Consultancy Services for New Air Traffic Control Tower (ATCT), Fire Station and Allied Facilities at Skardu International Airport	
Detailed Architectural Design Drawings	
Sheet Name	
ARFF FLOOR PATTERN	
Date	14 JANUARY, 2026
Scale	NTS
Drawn by	Ar. Sidra Tabassum
Checked by	Ar. Ahmed Ali
Approved by	Ar. Anwar Ali
Drawing No.	AW-34 @A3

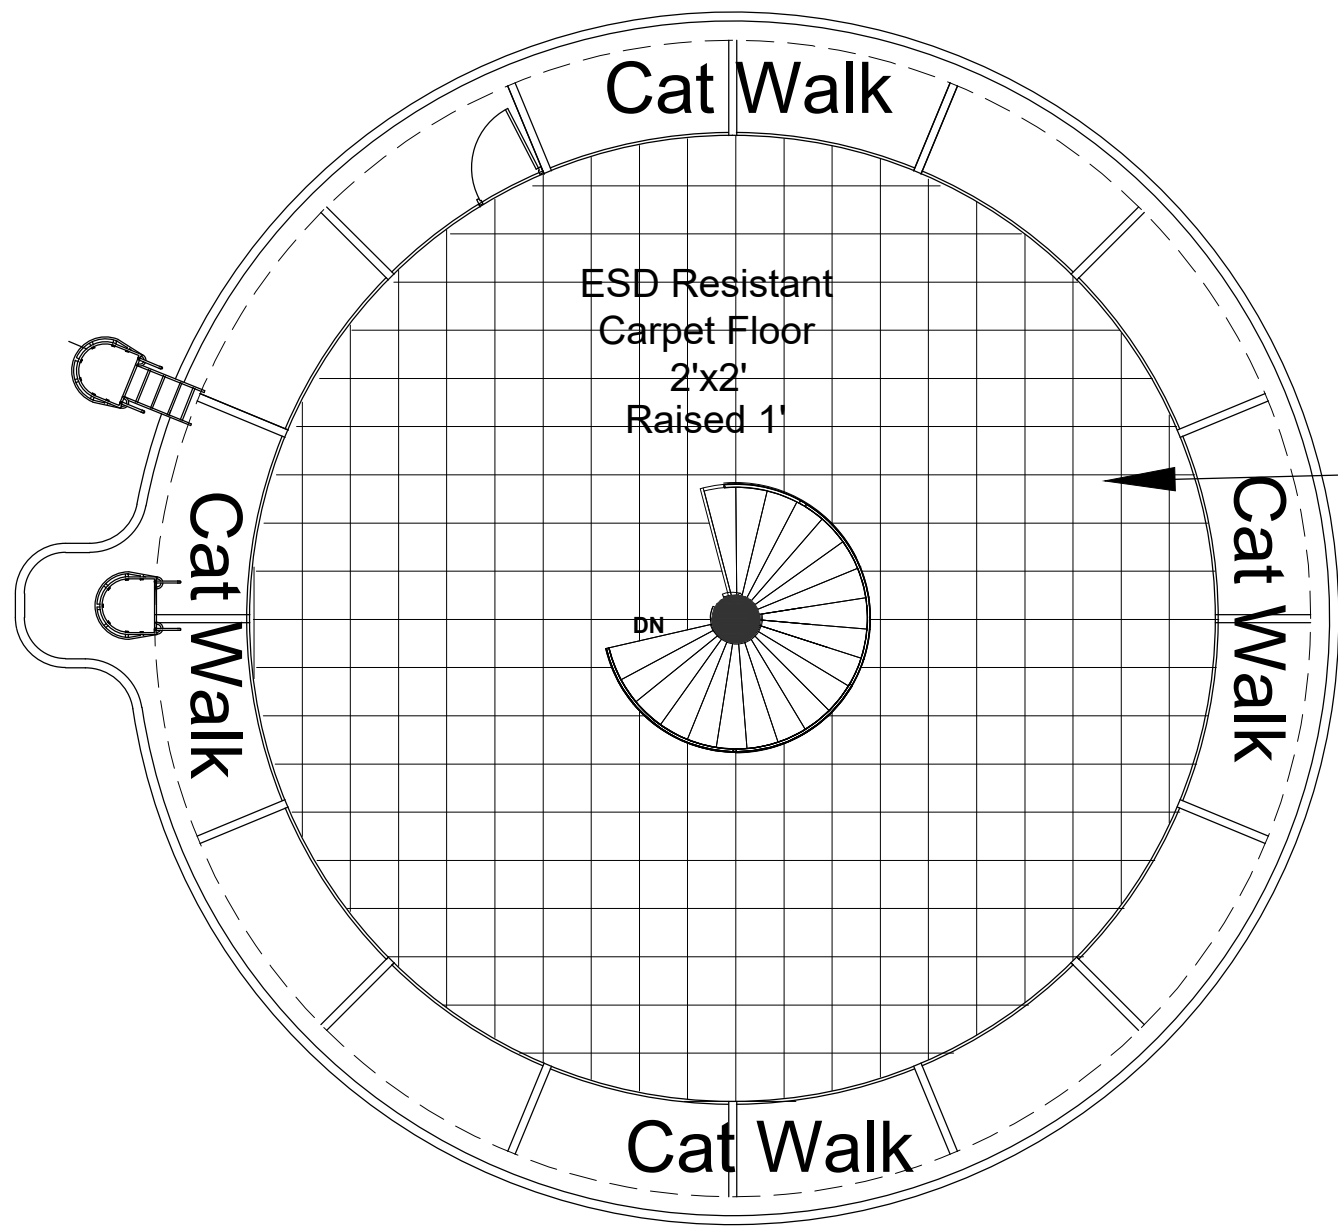

ATCT FLOOR PLAN LEVEL AT 68'-0"

ISSUE FOR TENDER

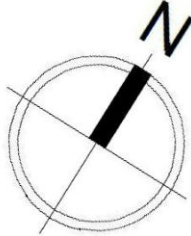NOTES: These drawings are confidential and is the exclusive property of AAA (Pvt)Ltd. And is loaned subject to the condition that it is not to be reproduced to furnish for the making of drawing or prints except as sanctioned in writing by AAA (Pvt)Ltd.	
CLIENT NAME	
	
MAIN CONSULTANT	
	
JV MEMBERS	
 	
STRUCTURAL CONSULTANT	
NORTH ORIENTATION	
	
Project Name	
Consultancy Services for New Air Traffic Control Tower (ATCT), Fire Station and Allied Facilities at Skardu International Airport	
Detailed Architectural Design Drawings	
Sheet Name	
ATCT FLOOR PATTERN	
Date	14 JANUARY, 2026
Scale	NTS
Drawn by	Ar. Sidra Tabassum
Checked by	Ar. Ahmed Ali
Approved by	Ar. Anwar Ali
Drawing No.	AW-35 @A3