


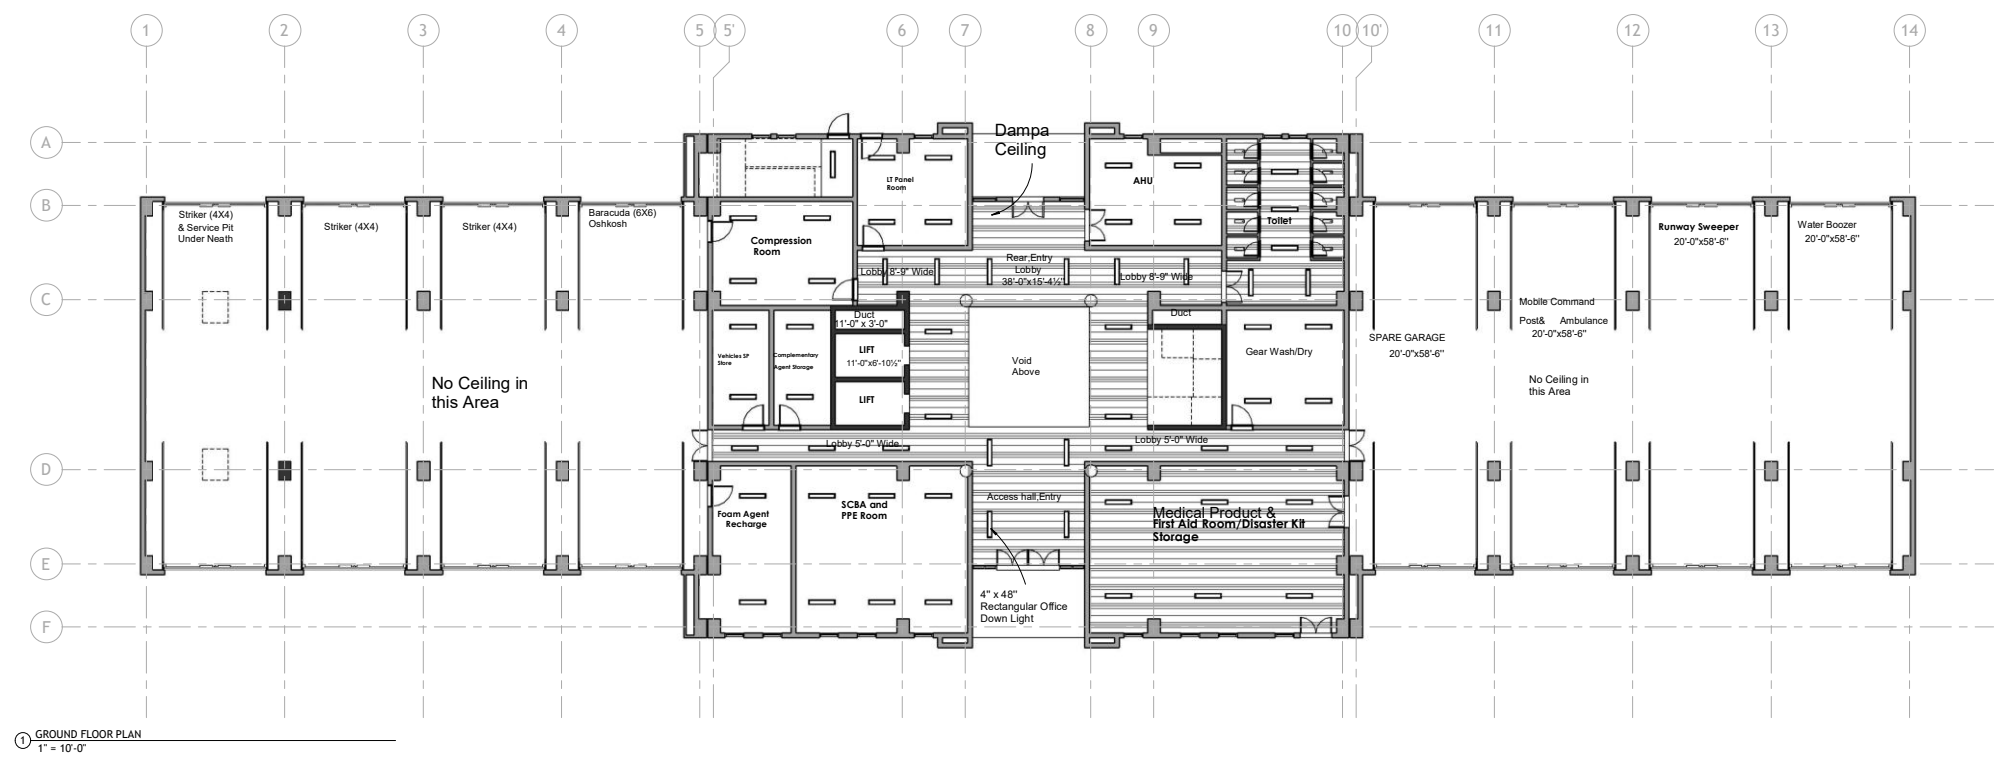

① GROUND FLOOR PLAN
1" = 10'-0"



Ground Floor Ceiling Design Reference

NOTES:

These drawings are confidential and are the exclusive property of AAA (Pvt) Ltd. and is loaned subject to the condition that it is not to be reproduced or furnished for the making of drawings or prints except as mentioned in writing by AAA (Pvt) Ltd.

CLIENT NAME



MAIN CONSULTANT




JV MEMBERS



Structural Consultant

North Orientation

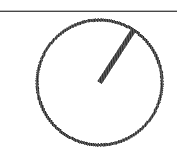

Project Name

Consultancy Services for the Design of New Air Traffic Control Tower (ATCT), Fire Station and Allied Facilities at Skardu International Airport


Detailed Architectural Design Drawings

GROUND FLOOR CEILING PLAN

Design By	Ar. Henrik Rothe
Checked By	Ar. Ahmed Ali
Approved By	Ar. Anwar Ali
Drawn By	Ar. Muhammad Tayyab
Date	March 2026

AW - 36

Scale @ 42" X 30" 1" = 10'-0"

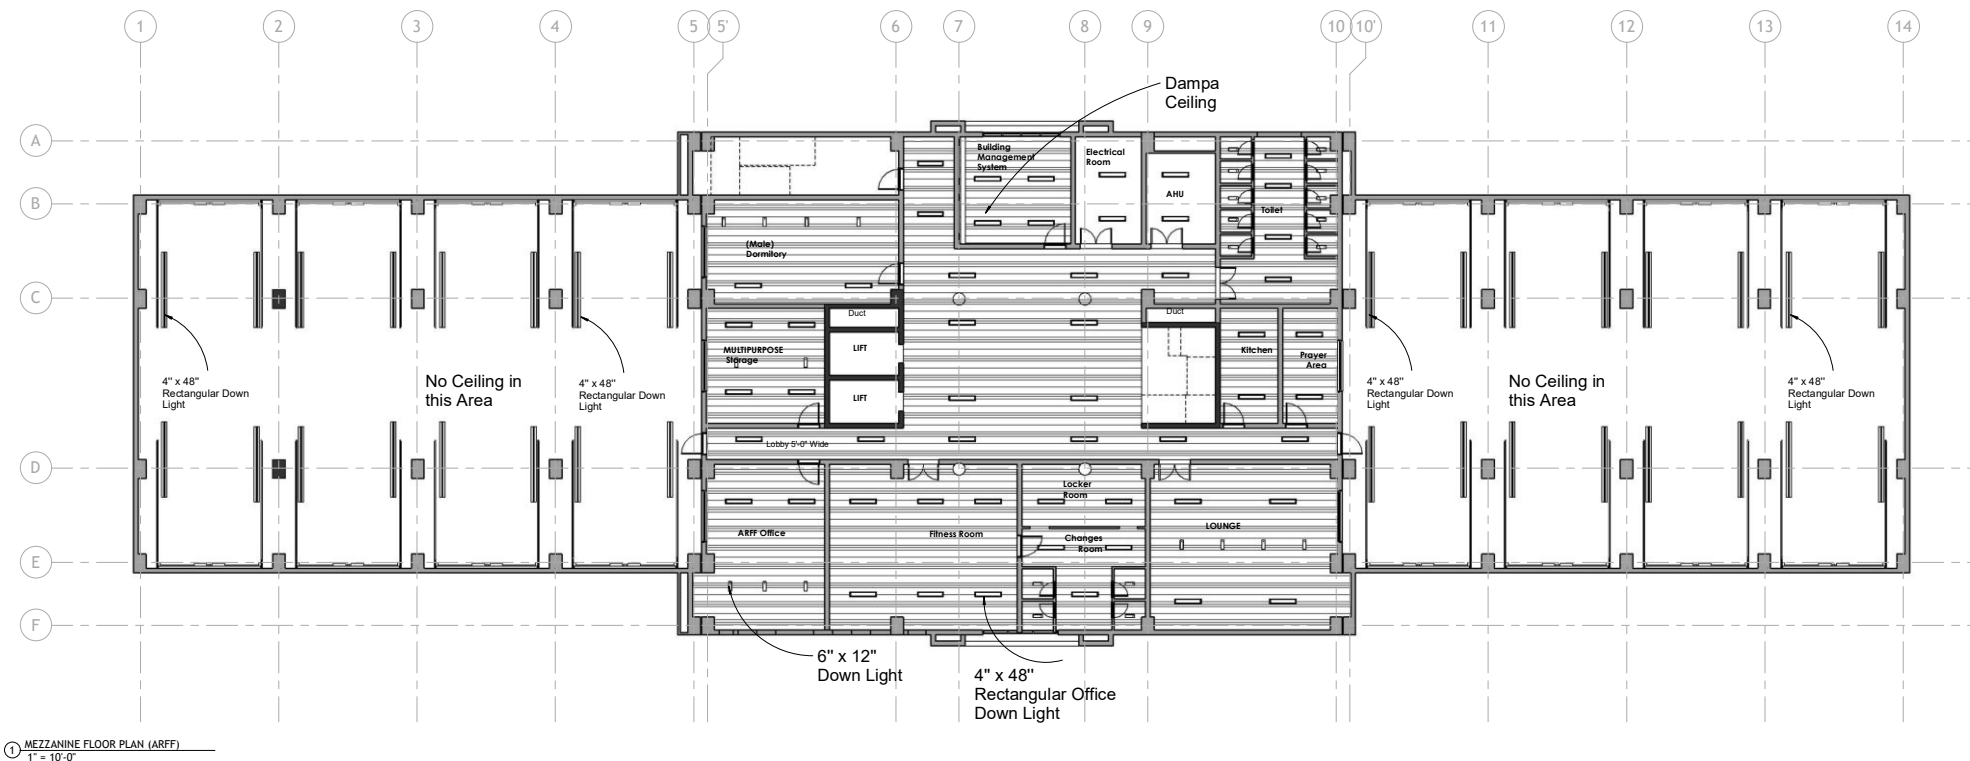

ISSUE FOR TENDER



Hanging Lights for Parking Bays

NOTES:

These drawings are confidential and are the exclusive property of PAA (Pvt.) Ltd. and are loaned subject to the condition that it is not to be reproduced or furnished for the making of drawings or prints except as mentioned in writing by PAA (Pvt.) Ltd.

CLIENT NAME



MAIN CONSULTANT



JV MEMBERS



Structural Consultant

North Orientation



Project Name

Consultancy Services for the Design of New Air Traffic Control Tower (ATCT), Fire Station and Allied Facilities at Skardu International Airport



Detailed Architectural Design Drawings

MEZZANINE FLOOR CEILING PLAN

Design By	Ar. Henrik Rothe
Checked By	Ar. Ahmed Ali
Approved By	Ar. Anwar Ali
Drawn By	Ar. Muhammad Tayyab
Date	March 2026

AW - 37

Scale @ 42" X 30" 1" = 10'-0"

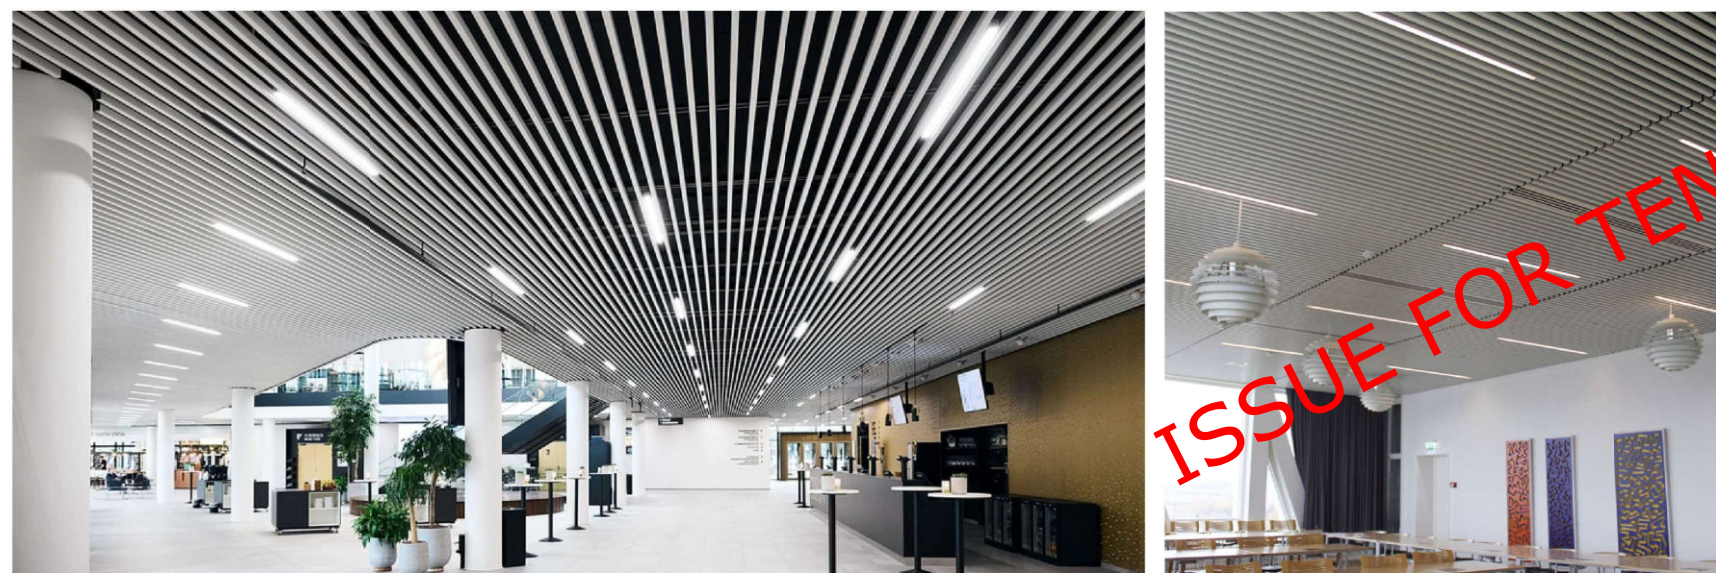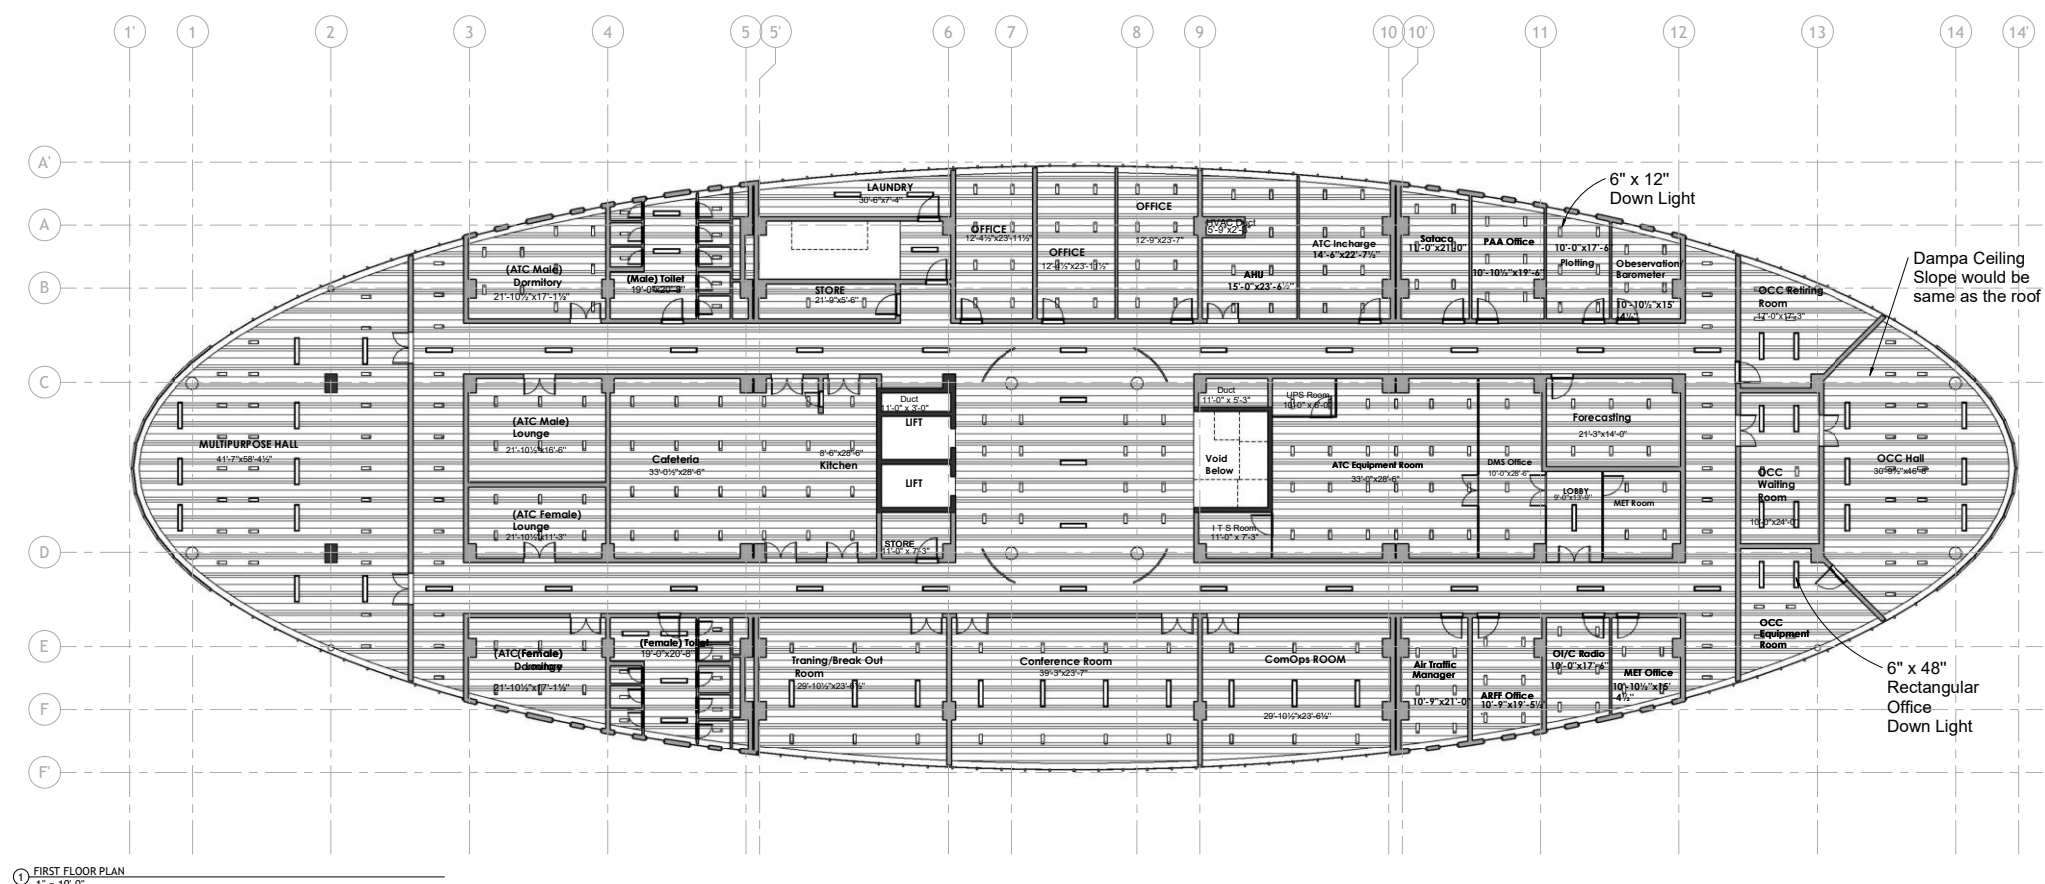

First Floor Ceiling Design Reference

NOTES:

These drawings are confidential and is the exclusive property of AAA (Pvt)Ltd. And is loaned subject to the condition that it is not to be reproduced to furnish for the making of drawing or prints except as sanctioned in writing by AAA (Pvt)Ltd.

CLIENT NAME




MAIN CONSULTANT



JV MEMBERS

**Structural Consultant**

North Orientation

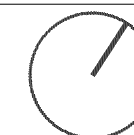

Project Name

Consultancy Services for the Design of New Air Traffic Control Tower (ATCT), Fire Station and Allied Facilities at Skardu International Airport

Detailed Architectural Design Drawings


FIRST FLOOR
CEILING PLAN

Design By	Ar. Henrik Rothe
Checked By	Ar. Ahmed Ali
Approved By	Ar. Anwar Ali
Drawn By	Ar. Muhammad Tayyab
Date	March 2026

AW - 38

Scale @ 42" X 30"

$$1'' = 10'-0''$$

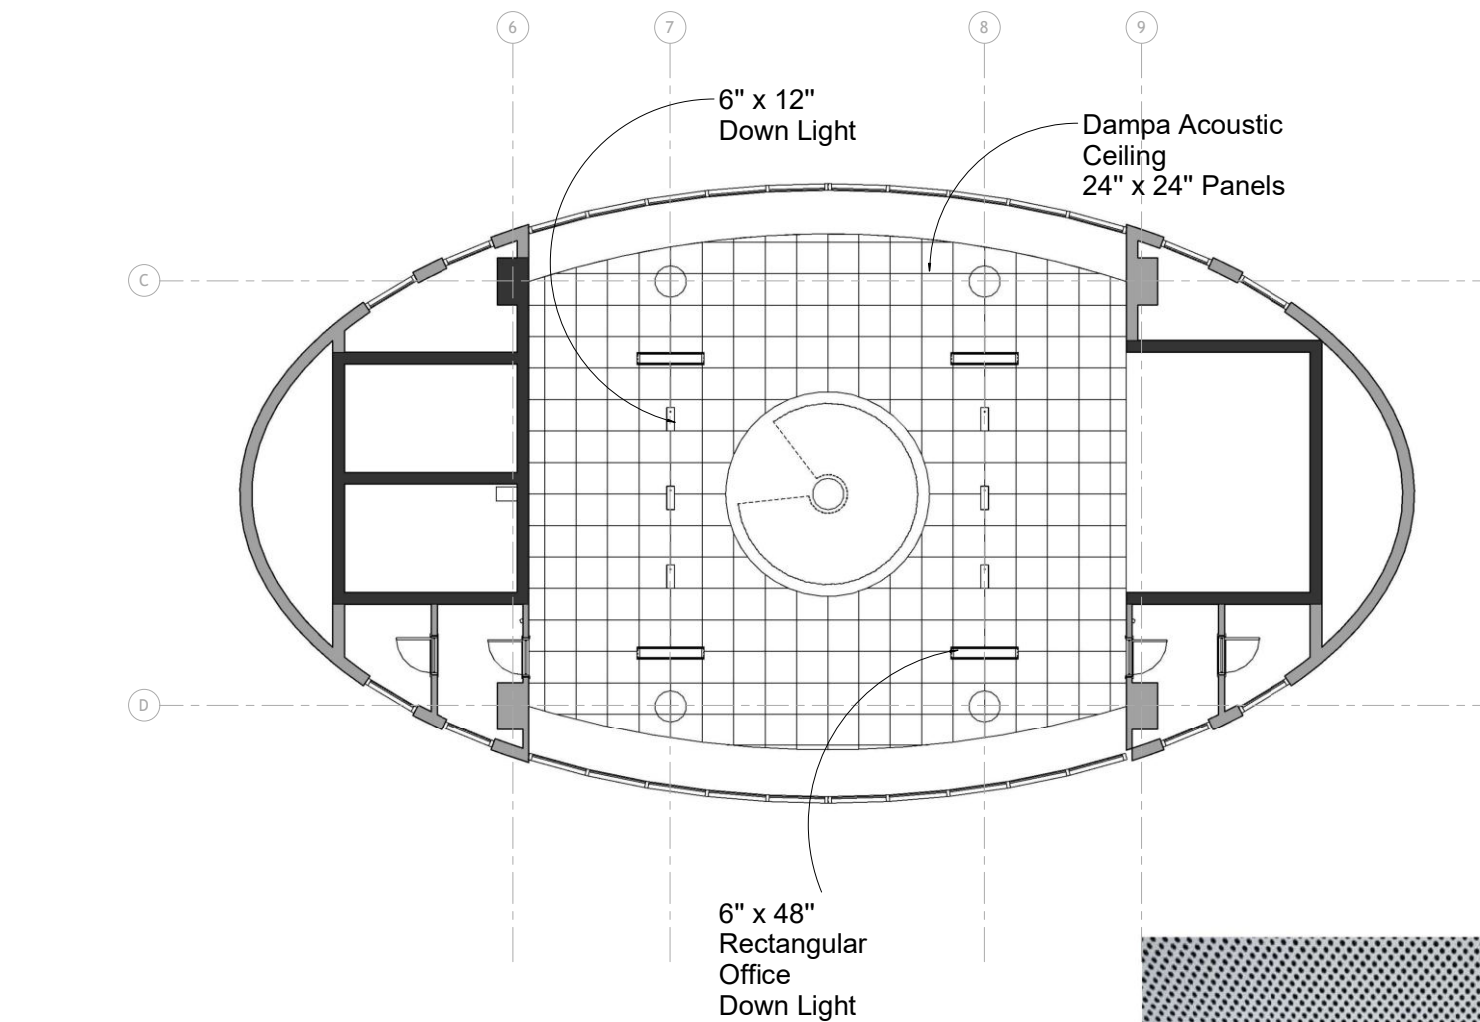

ISSUE FOR TENDER



NOTES:

These drawings are confidential and are the exclusive property of AAA (Pvt) Ltd. and are loaned subject to the condition that it is not to be reproduced or furnished for the making of drawings or prints except as mentioned in writing by AAA (Pvt) Ltd.

CLIENT NAME



MAIN CONSULTANT




JV MEMBERS



Structural Consultant

North Orientation

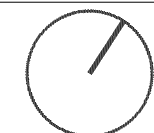

Project Name

Consultancy Services for the Design of New Air Traffic Control Tower (ATCT), Fire Station and Allied Facilities at Skardu International Airport

Detailed Architectural Design Drawings


ROOF TOP CEILING PLAN

Design By	Ar. Henrik Rothe
Checked By	Ar. Ahmed Ali
Approved By	Ar. Anwar Ali
Drawn By	Ar. Muhammad Tayyab
Date	March 2026

AW - 39

Scale @ 42" X 30"

1/4" = 1'-0"

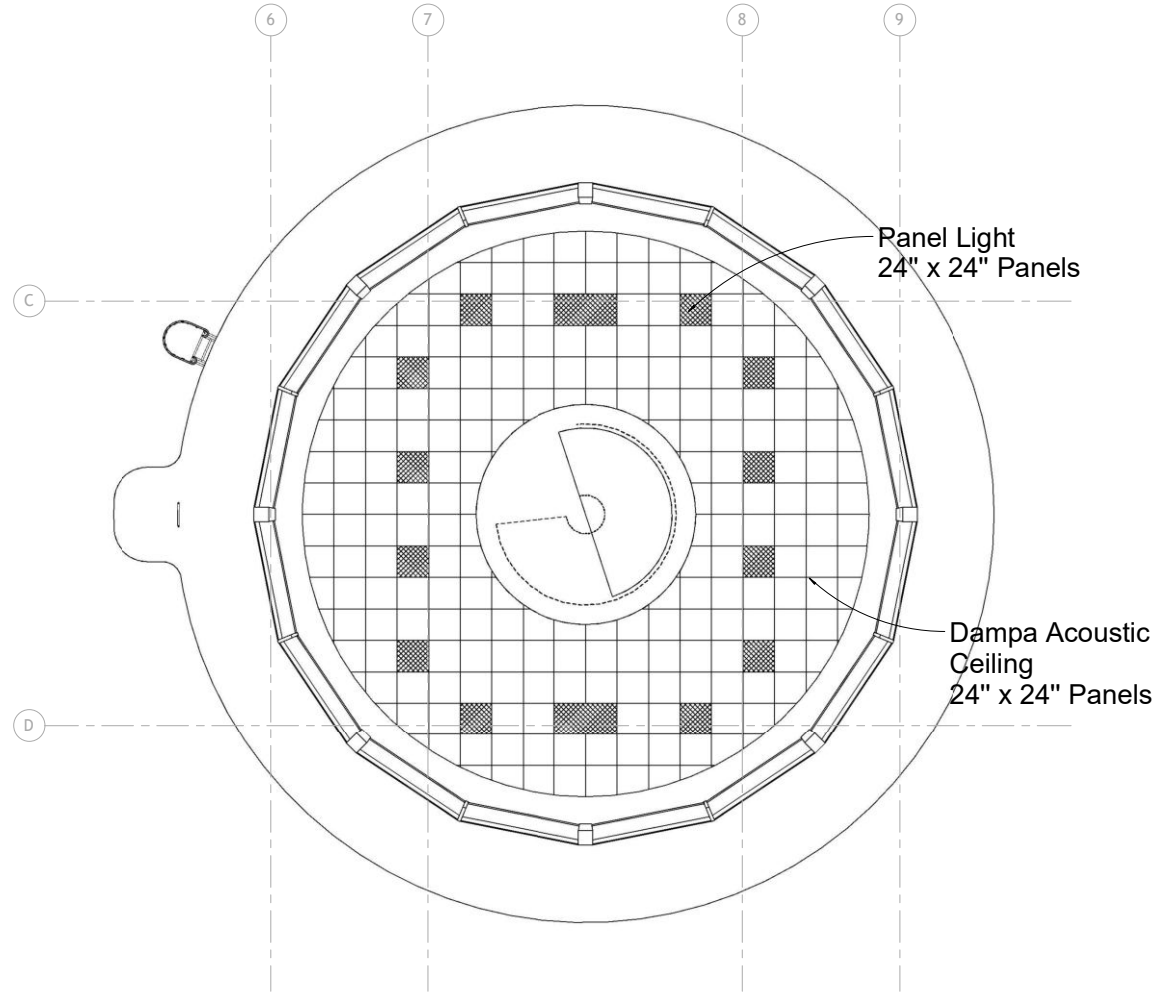

① ARFF CONTROL CABIN PLAN
1/4" = 1'-0"

ISSUE FOR TENDER



ARFF Floor Ceiling Design Reference

NOTES:

These drawings are confidential and are the exclusive property of AAA (Pvt.) Ltd. and are loaned subject to the condition that it is not to be reproduced or furnished for the making of drawings or prints except as mentioned in writing by AAA (Pvt.) Ltd.

CLIENT NAME



MAIN CONSULTANT



JV MEMBERS



Structural Consultant

North Orientation



Project Name

Consultancy Services for the Design of New Air Traffic Control Tower (ATCT), Fire Station and Allied Facilities at Skardu International Airport

Detailed Architectural Design Drawings


ARFF CONTROL CABIN CEILING PLAN

Design By	Ar. Henrik Rothe
Checked By	Ar. Ahmed Ali
Approved By	Ar. Anwar Ali
Drawn By	Ar. Muhammad Tayyab
Date	March 2026

AW - 40


Scale @ 42" X 30"

1/4" = 1'-0"

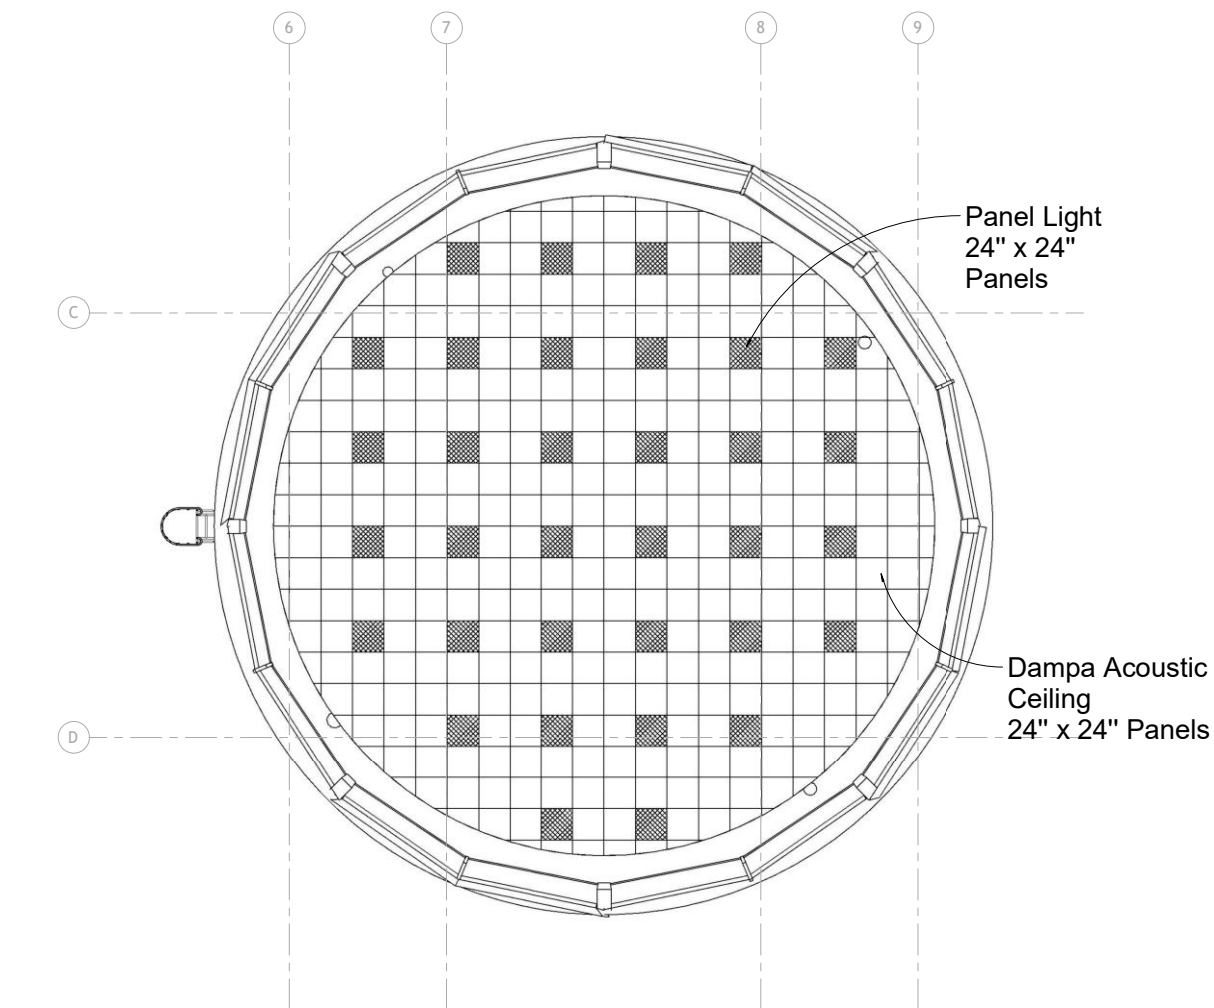

① ATCT CONTROL CABIN PLAN
1/4" = 1'-0"

ISSUE FOR TENDER

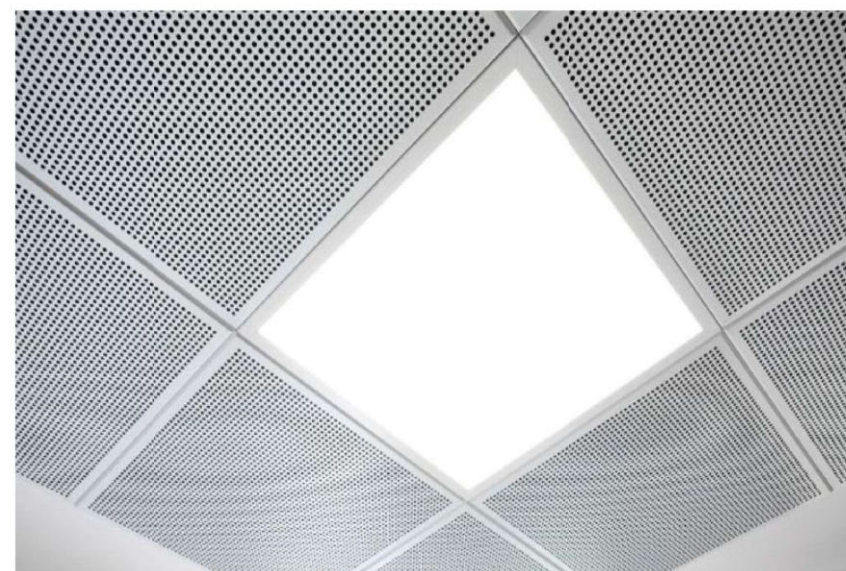

ARFF Floor Ceiling Design Reference

NOTES:

These drawings are confidential and are the exclusive property of AAA (Pvt) Ltd. and are loaned subject to the condition that it is not to be reproduced or furnished for the making of drawing or prints except as mentioned in writing by AAA (Pvt) Ltd.

CLIENT NAME



MAIN CONSULTANT




JV MEMBERS



Structural Consultant

North Orientation

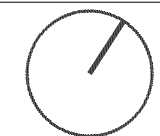

Project Name

Consultancy Services for the Design of New Air Traffic Control Tower (ATCT), Fire Station and Allied Facilities at Skardu International Airport

Detailed Architectural Design Drawings









ATCT CONTROL CABIN CEILING PLAN

Design By	Ar. Henrik Rothe
Checked By	Ar. Ahmed Ali
Approved By	Ar. Anwar Ali
Drawn By	Ar. Muhammad Tayyab
Date	March 2026

AW - 40-A

Scale @ 42" X 30"

1/4" = 1'-0"

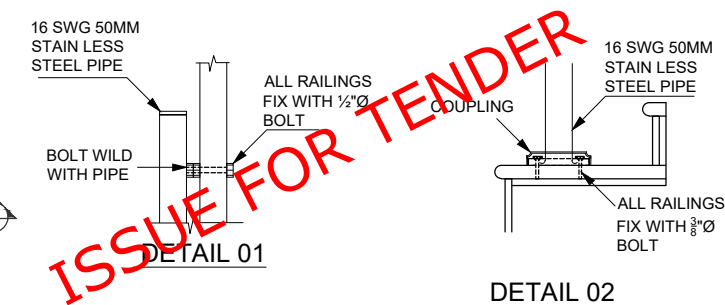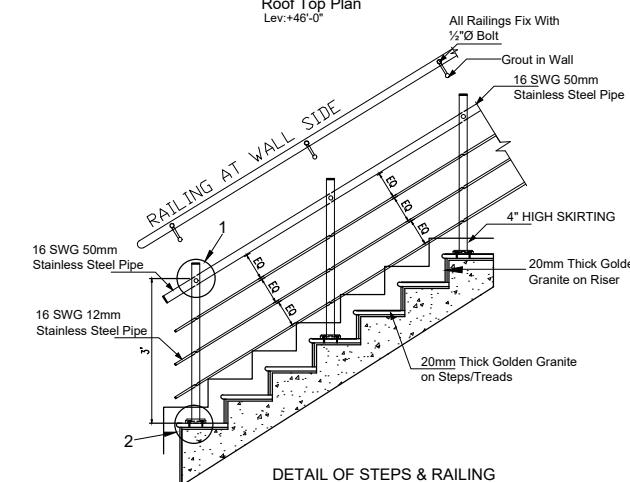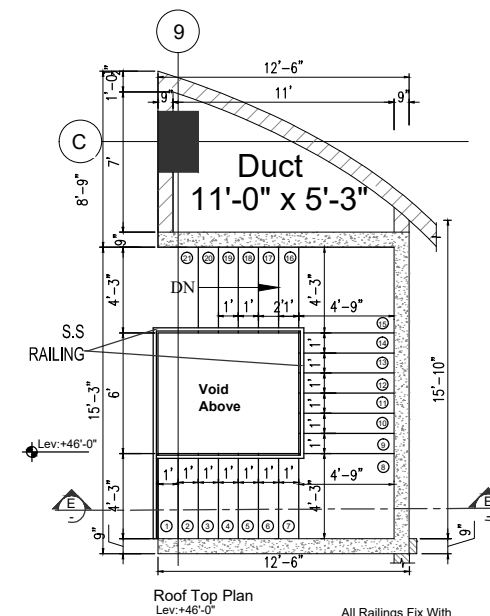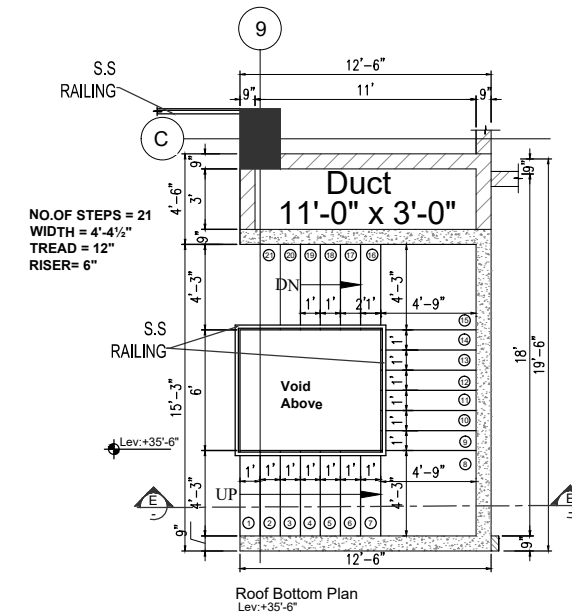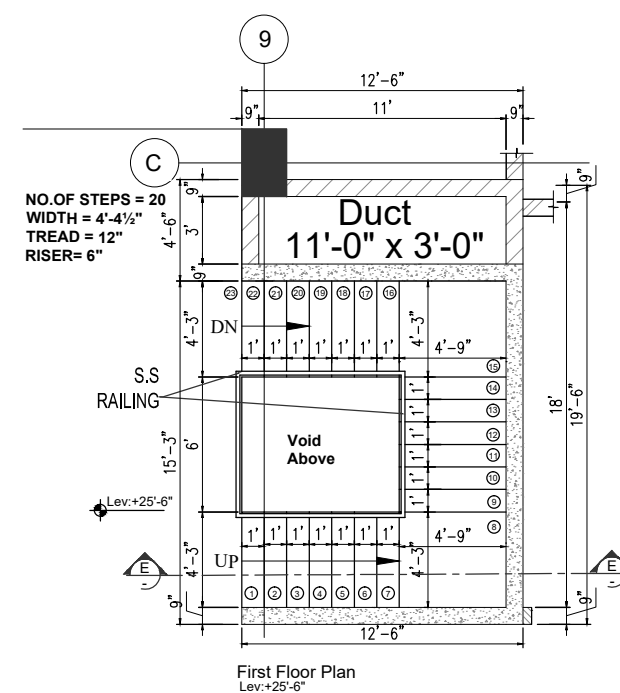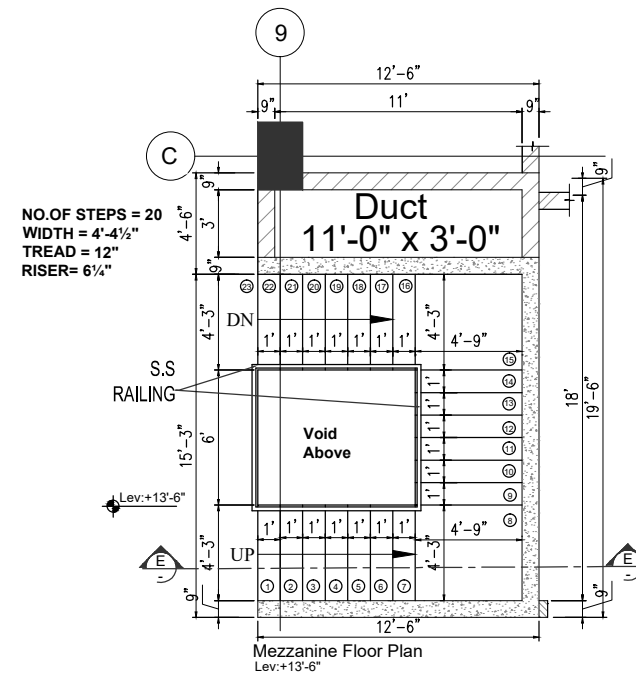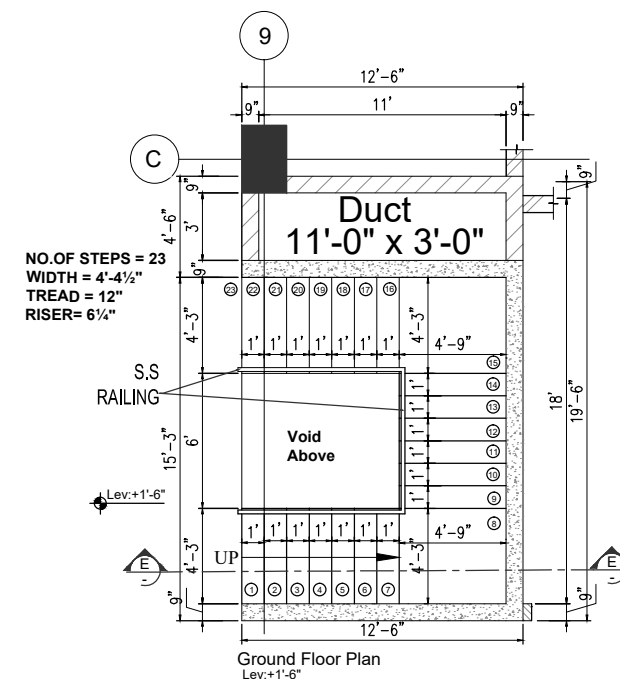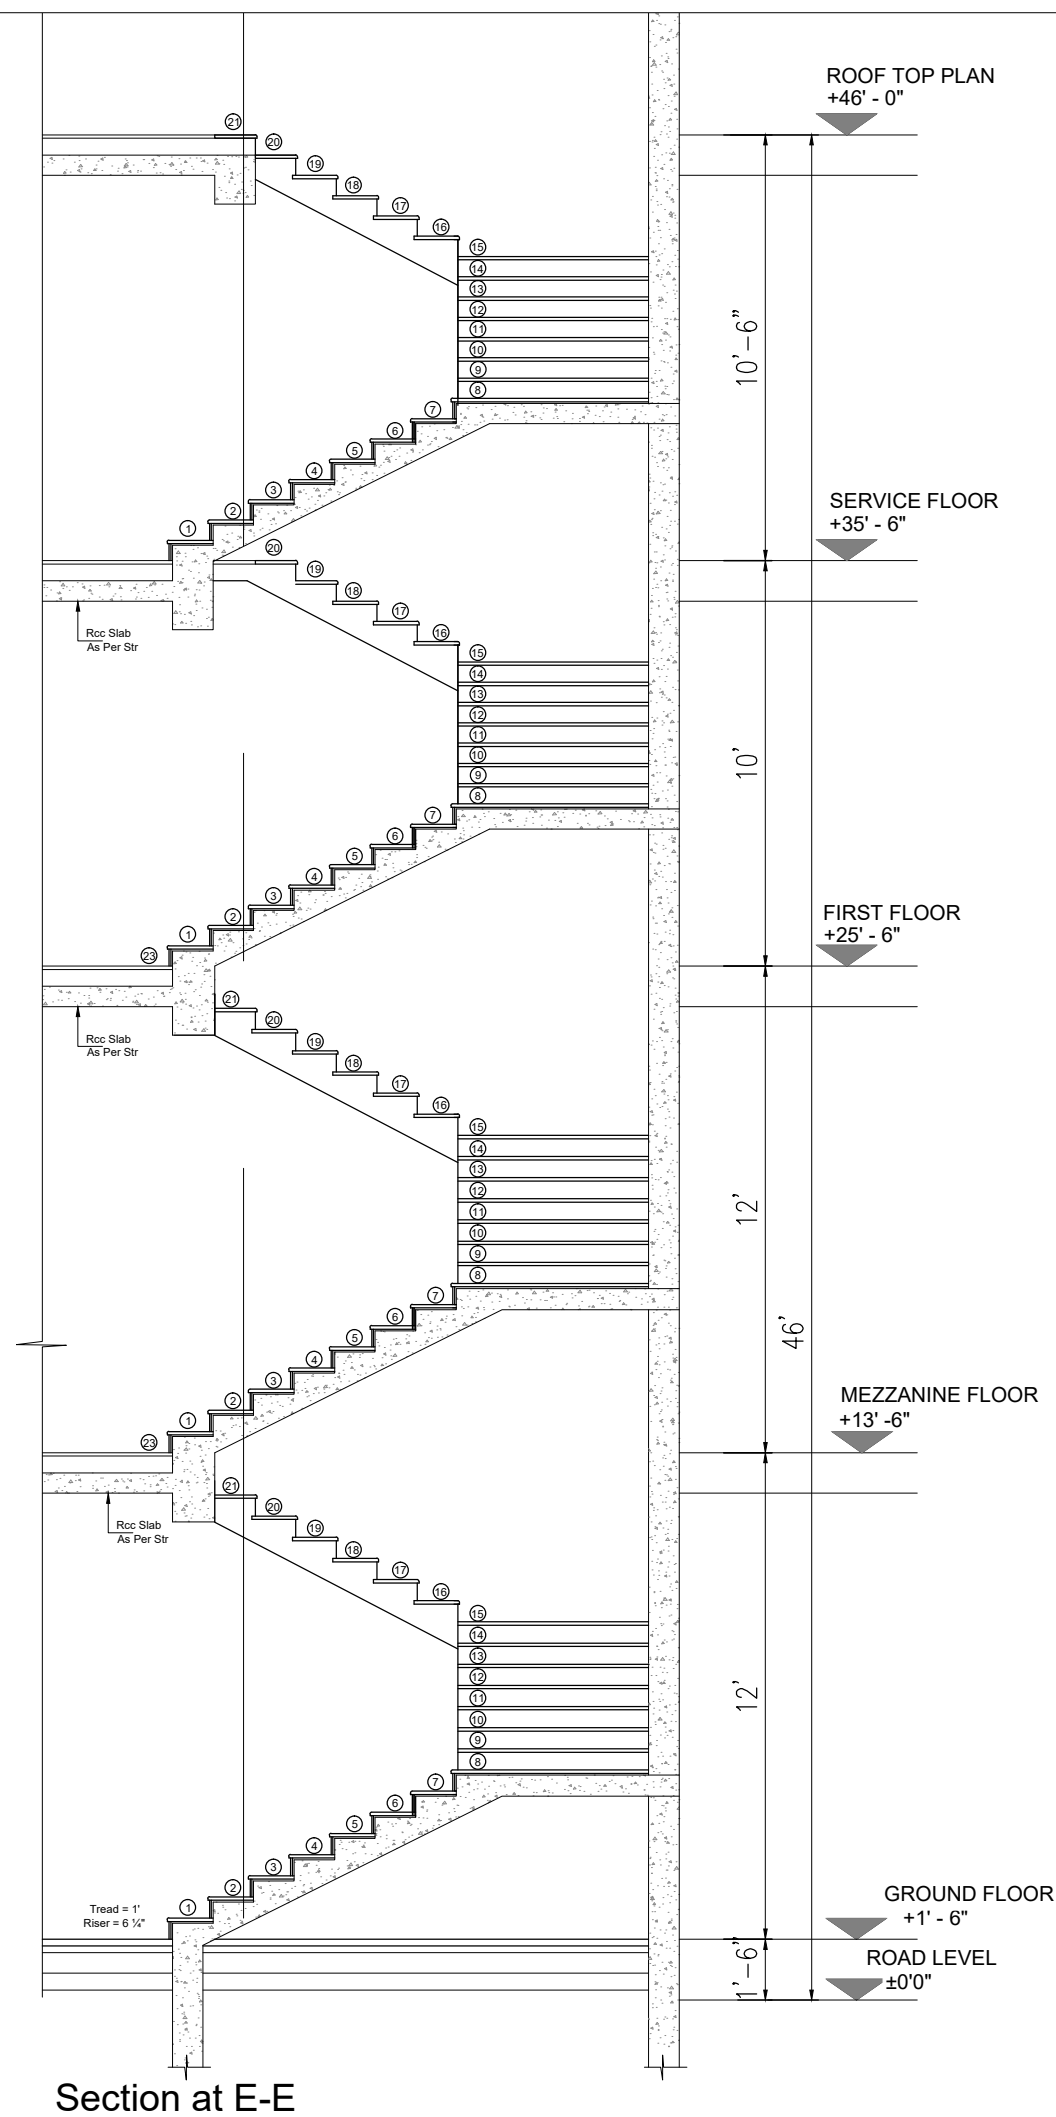

NOTES:

These drawings are confidential and is the exclusive property of AAA (Pvt)Ltd. And is loaned subject to the condition that it is not to be reproduced to furnish for the making of drawing or prints except as sanctioned in writing by AAA (Pvt)Ltd.

CLIENT NAME



MAIN CONSULTANT




JV MEMBERS



leit-werk
STRUCTURAL CONSULTANT

NORTH ORIENTATION

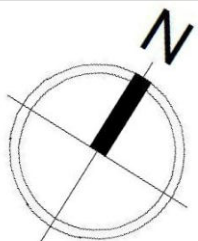

Project Name


Consultancy Services for New Air Traffic Control Tower (ATCT), Fire Station and Allied Facilities at Skardu International Airport

Detailed Architectural Design Drawings


Sheet Name

STAIR DETAIL-1




Date	12 January, 2026
Scale	NTS
Drawn by	Asad
Checked by	Ar. Ahmed Ali
Approved by	Ar. Anwar Ali
Drawing No.	AW-40b @A3

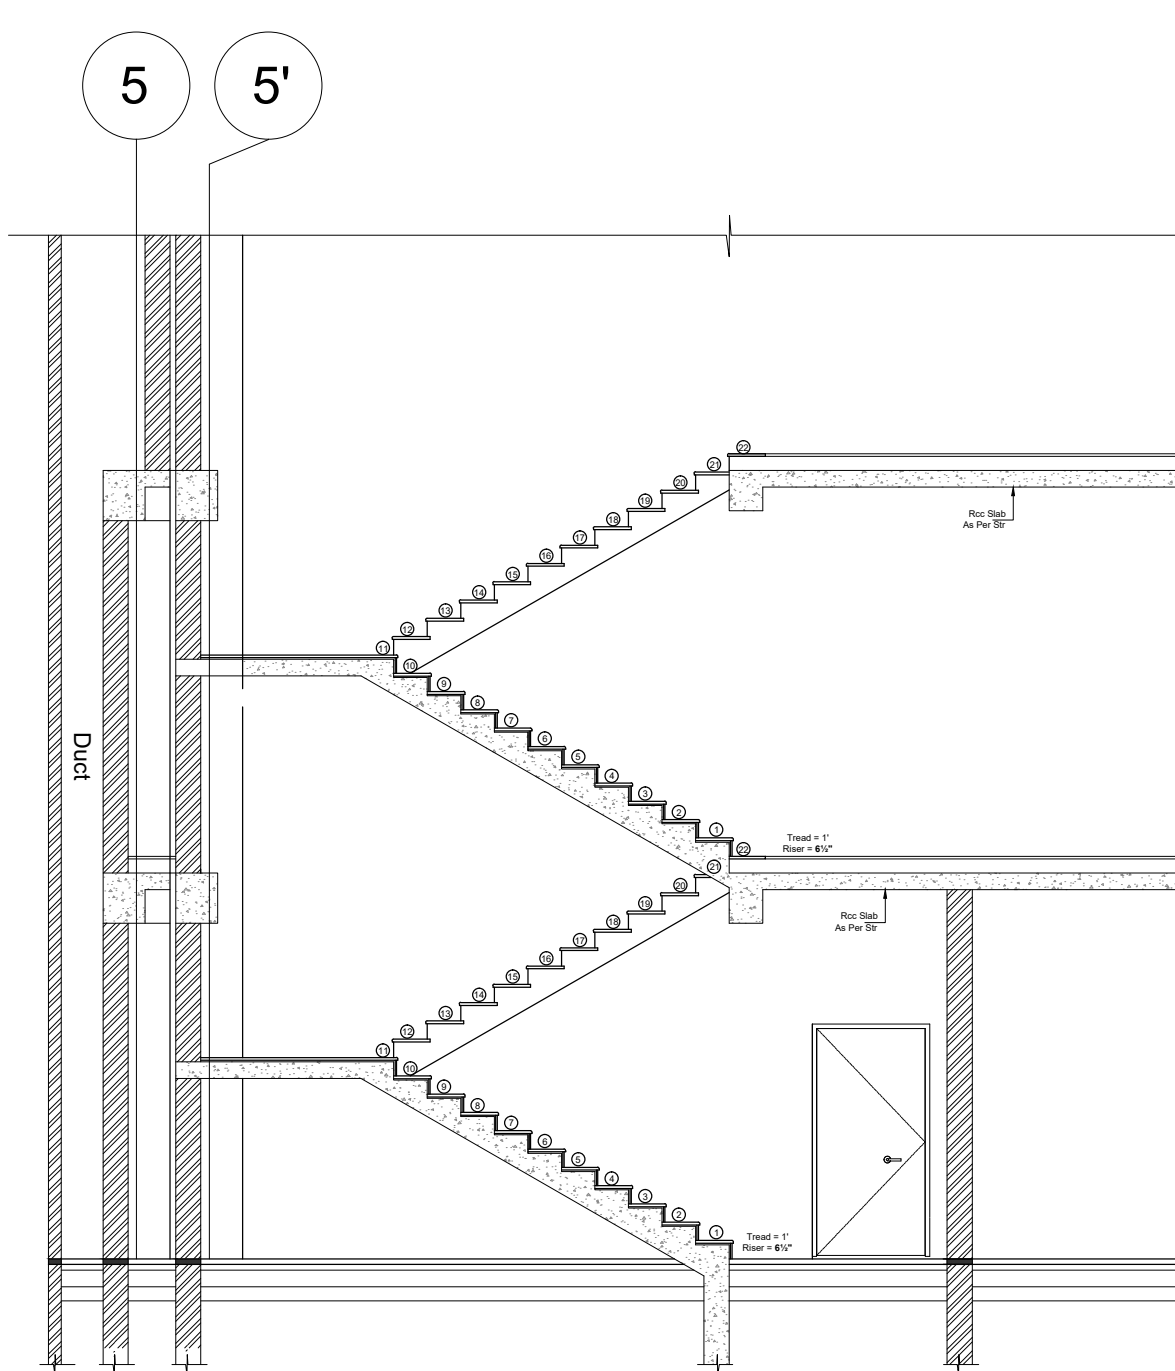



Section at F-F

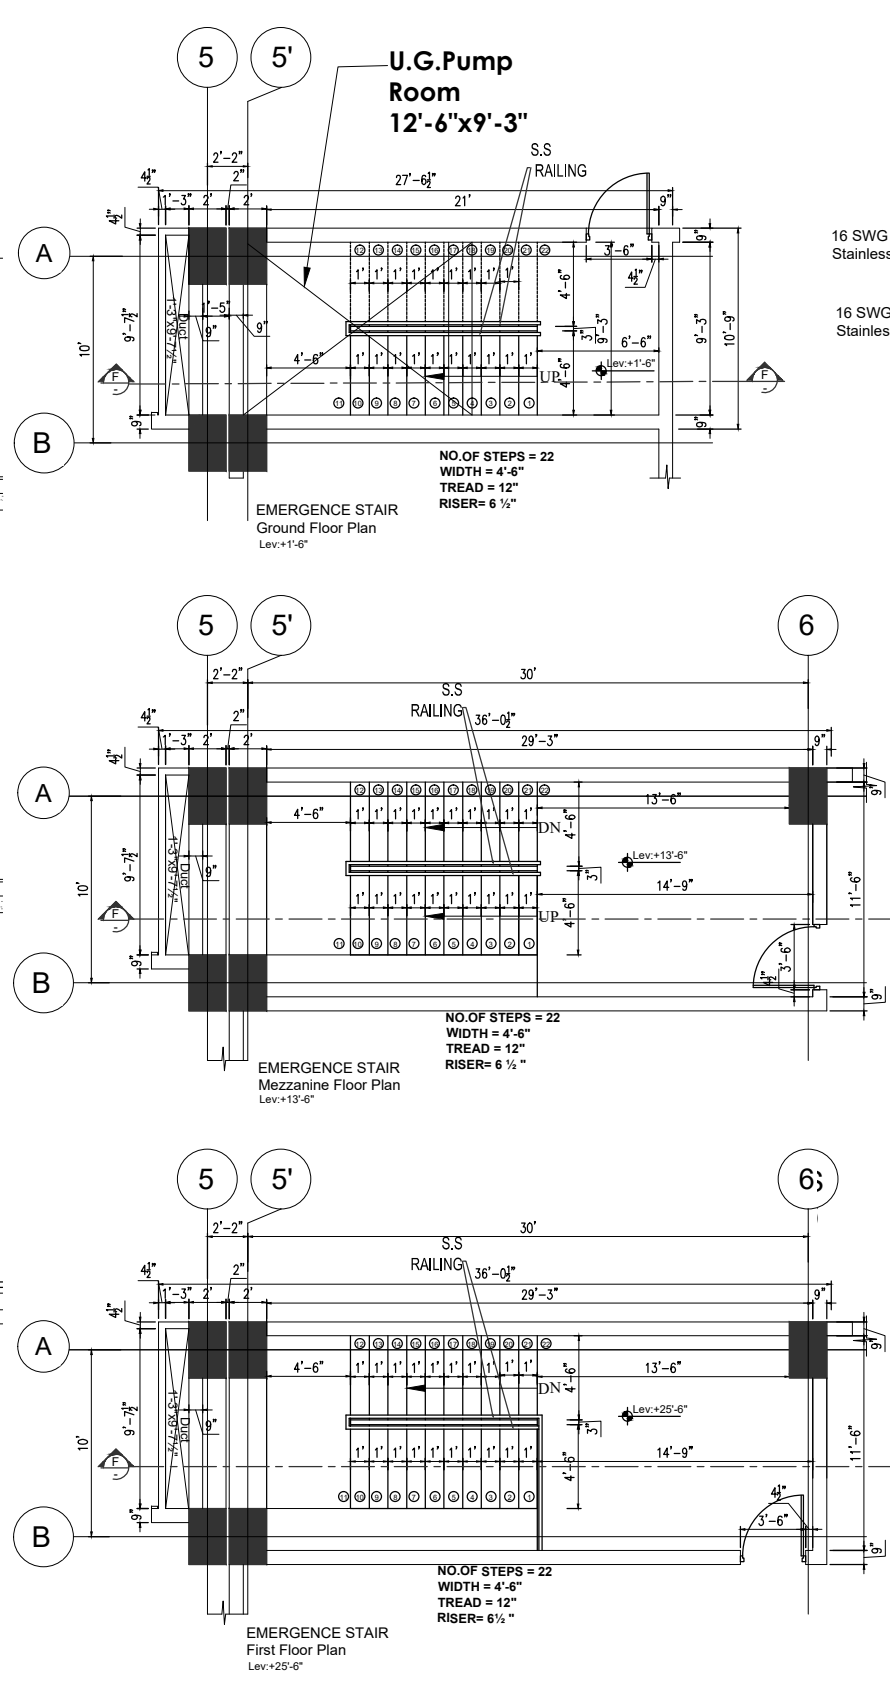


ISSUE FOR TENDER

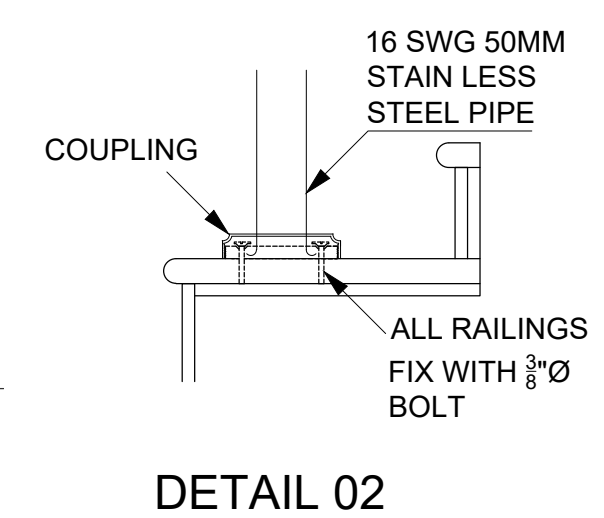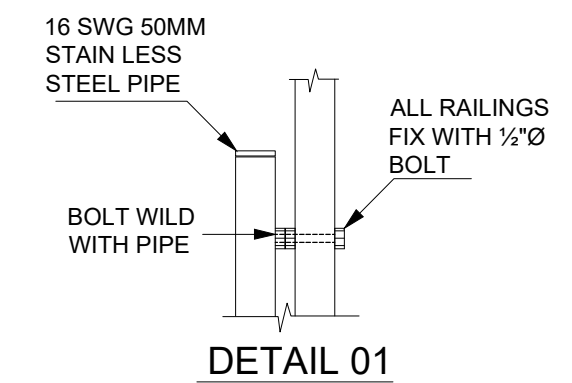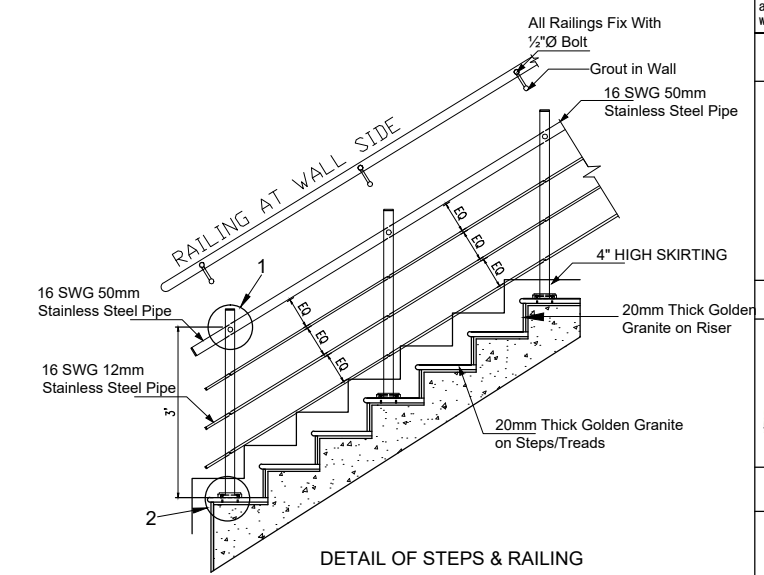

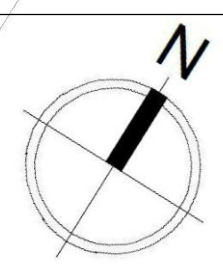NOTES: These drawings are confidential and is the exclusive property of AAA (Pvt)Ltd. And is loaned subject to the condition that it is not to be reproduced or furnish for the making of drawing or prints except as sanctioned in writing by AAA (Pvt)Ltd.	
CLIENT NAME	
 پاکستان انیورسٹی آف آرکیٹیکچر	
MAIN CONSULTANT	
 Formerly Anwar Ali & Associates Since March 2006 to June 2018 Consulting Architects, Engineers, Planners & Management Consultants	
JV MEMBERS	
	
leiti-werk	
STRUCTURAL CONSULTANT	
NORTH ORIENTATION	
	
Project Name	
Consultancy Services for New Air Traffic Control Tower (ATCT), Fire Station and Allied Facilities at Skardu International Airport	
Detailed Architectural Design Drawings	
Sheet Name	
EMERGENCE STAIR DETAIL-2	
Date	12 January, 2026
Scale	NTS
Drawn by	Asad
Checked by	Ar. Ahmed Ali
Approved by	Ar. Anwar Ali
Drawing No.	AW-41 @A3

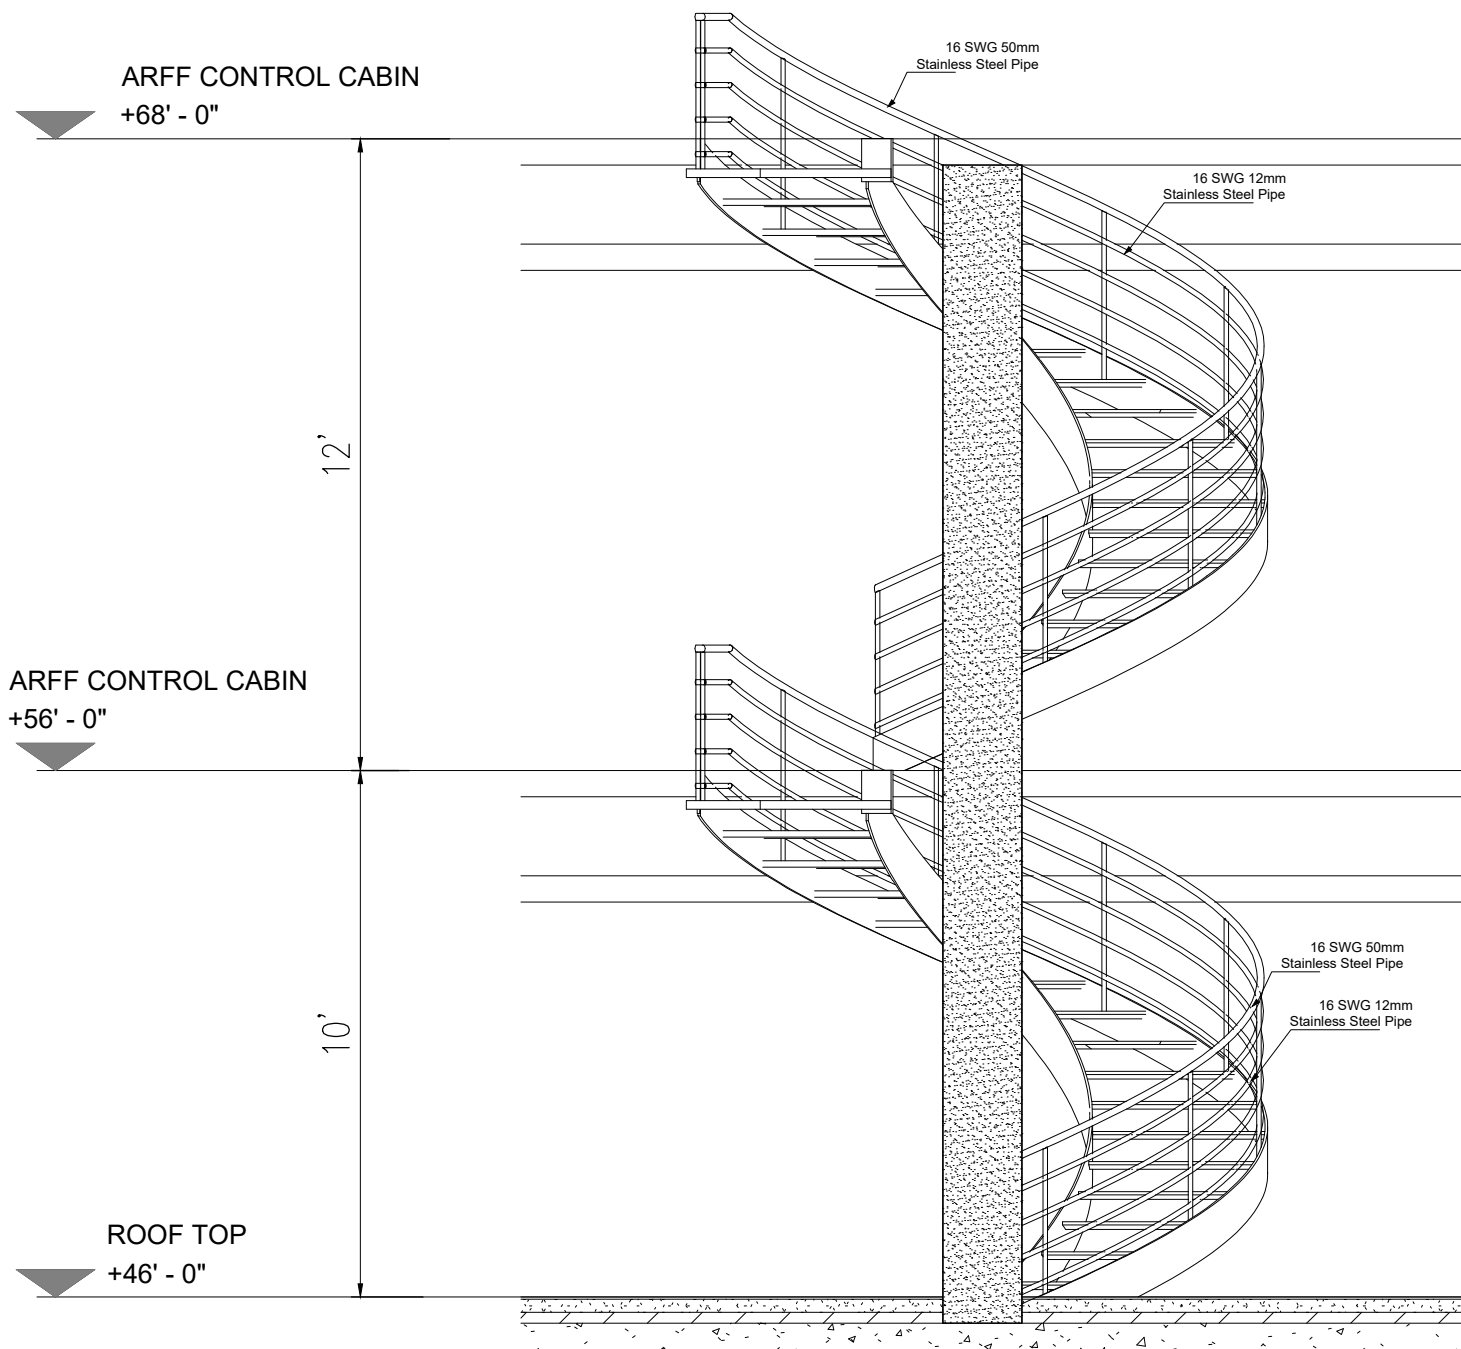


Section at G-G

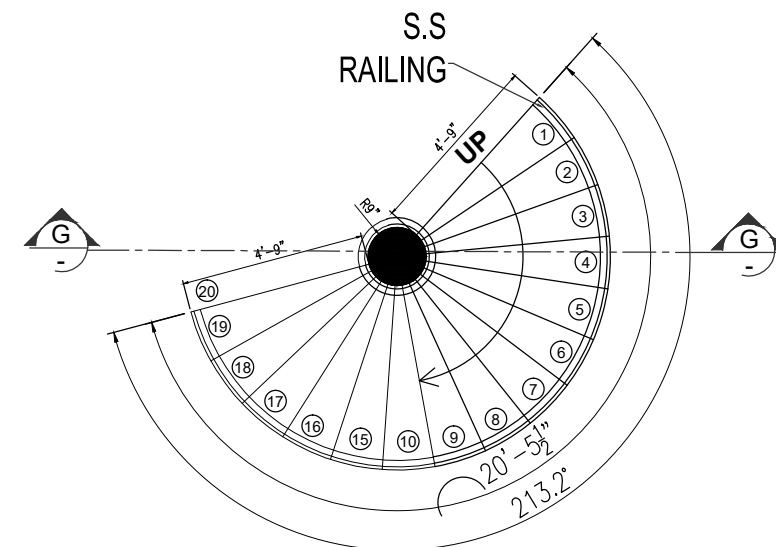


MS STAIR
Roof Plan
Level At +46' - 0"

NO.OF STEPS = 20
WIDTH = 4'-9"
TREAD = 10"
RISER= 6 "

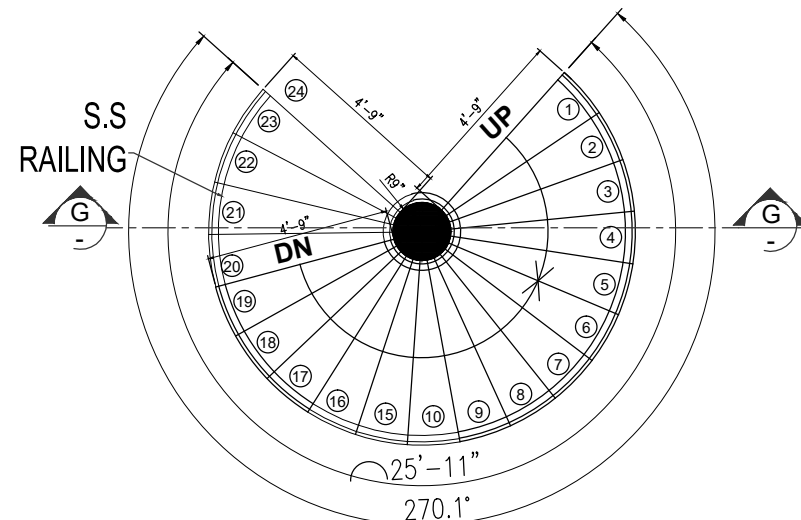


MS STAIR
ARFF Control Cabin
Level At +56' - 0"



NO.OF STEPS = 24
WIDTH = 4'-9"
TREAD = 10"
RISER= 6 "

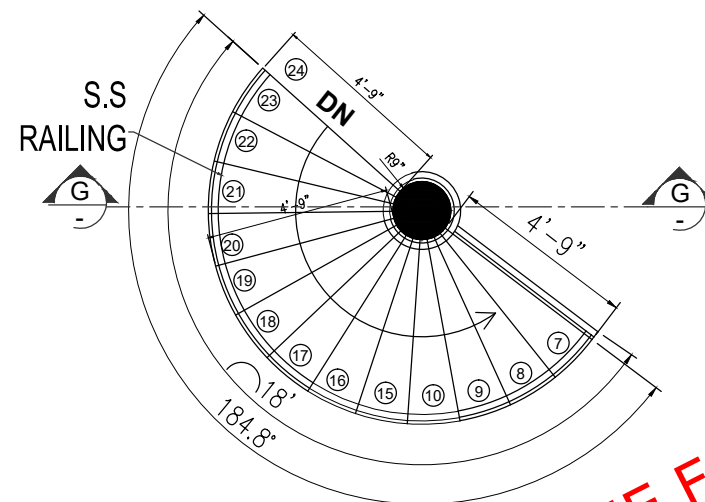


MS STAIR
ATCT Control Cabin
Level At +68' - 0"



ISSUE FOR TENDER

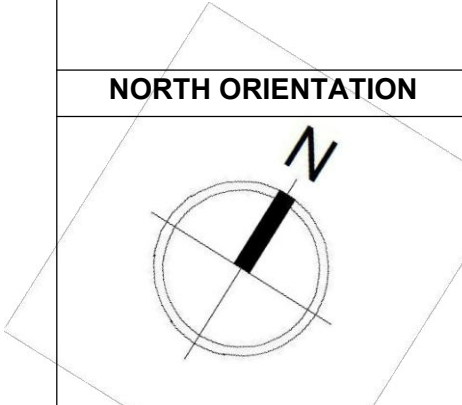NOTES: These drawings are confidential and is the exclusive property of AAA (Pvt)Ltd. And is loaned subject to the condition that it is not to be reproduced to furnish for the making of drawing or prints except as sanctioned in writing by AAA (Pvt)Ltd.	
CLIENT NAME	
 پاکستان ایئر پورٹس اتھارٹی	
MAIN CONSULTANT	
 Formerly Anwar Ali & Associates Since March 2006 to June 2018 Consulting Architects, Engineers, Planners & Management Consultants	
JV MEMBERS	
	
	
STRUCTURAL CONSULTANT	
NORTH ORIENTATION	
	
Project Name	
Consultancy Services for New Air Traffic Control Tower (ATCT), Fire Station and Allied Facilities at Skardu International Airport	
Detailed Architectural Design Drawings	
Sheet Name	
MS STAIR DETAIL-3	
Date	12 January, 2026
Scale	NTS
Drawn by	Asad
Checked by	Ar. Ahmed Ali
Approved by	Ar. Anwar Ali
Drawing No.	AW-42 @A3


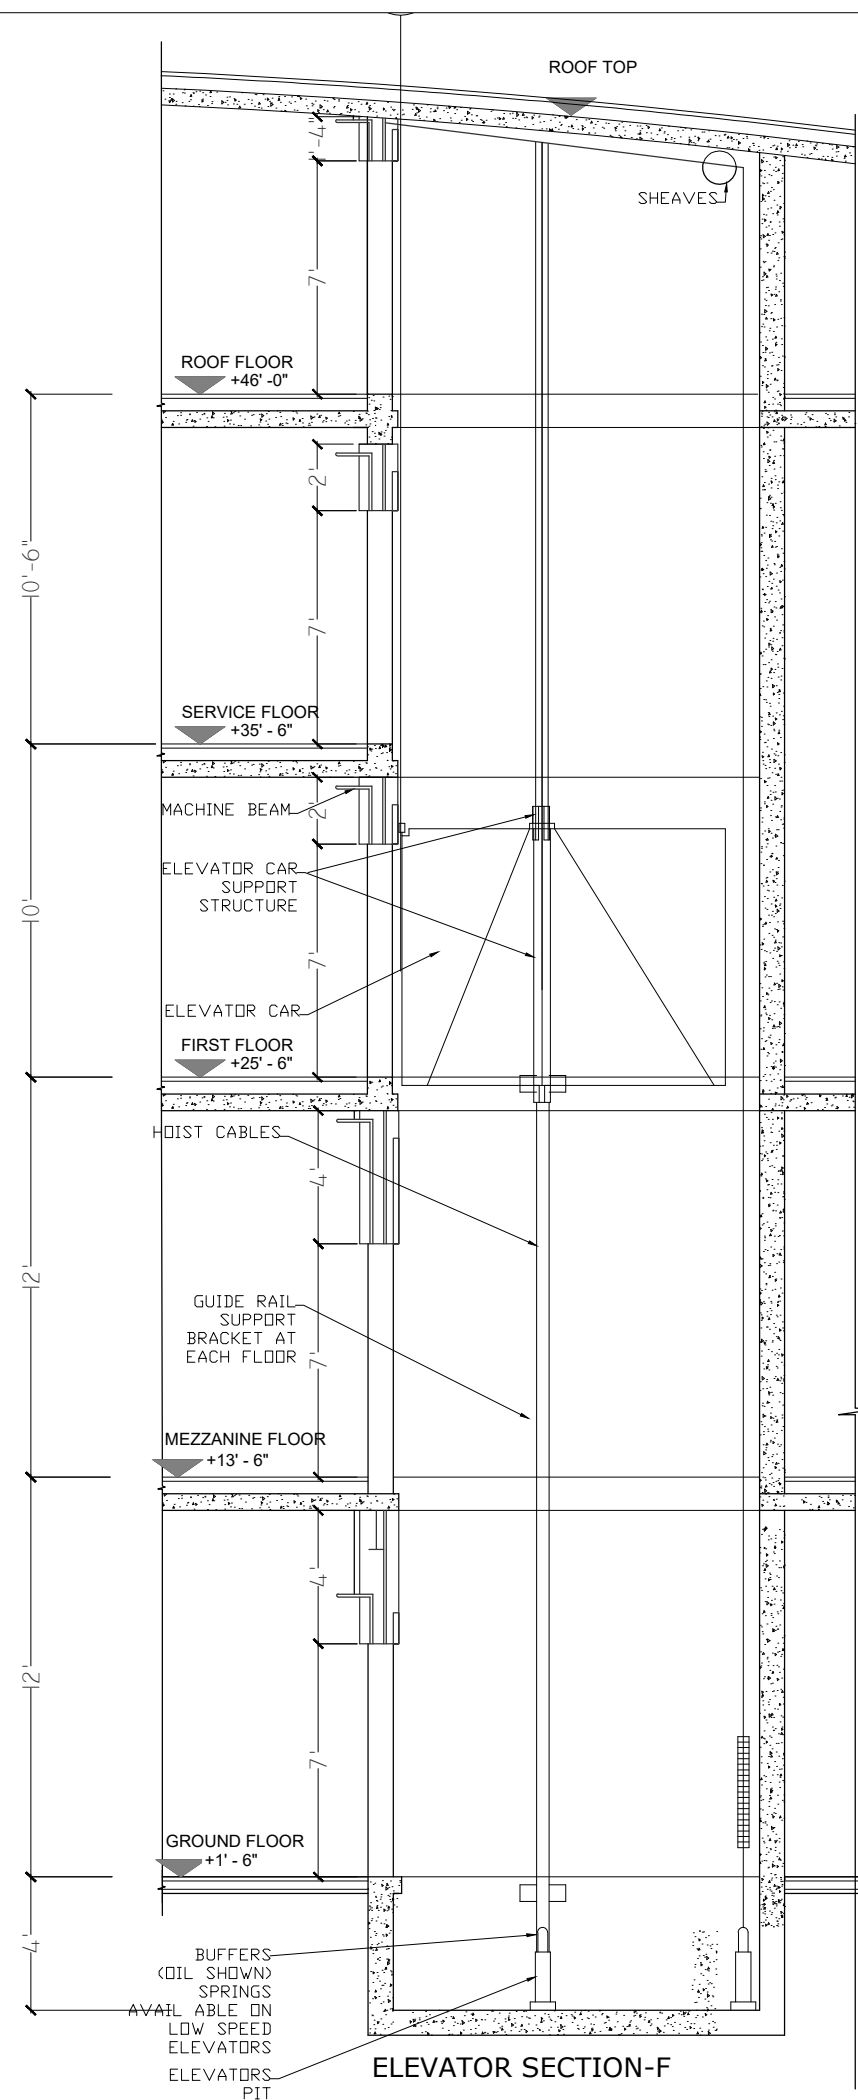
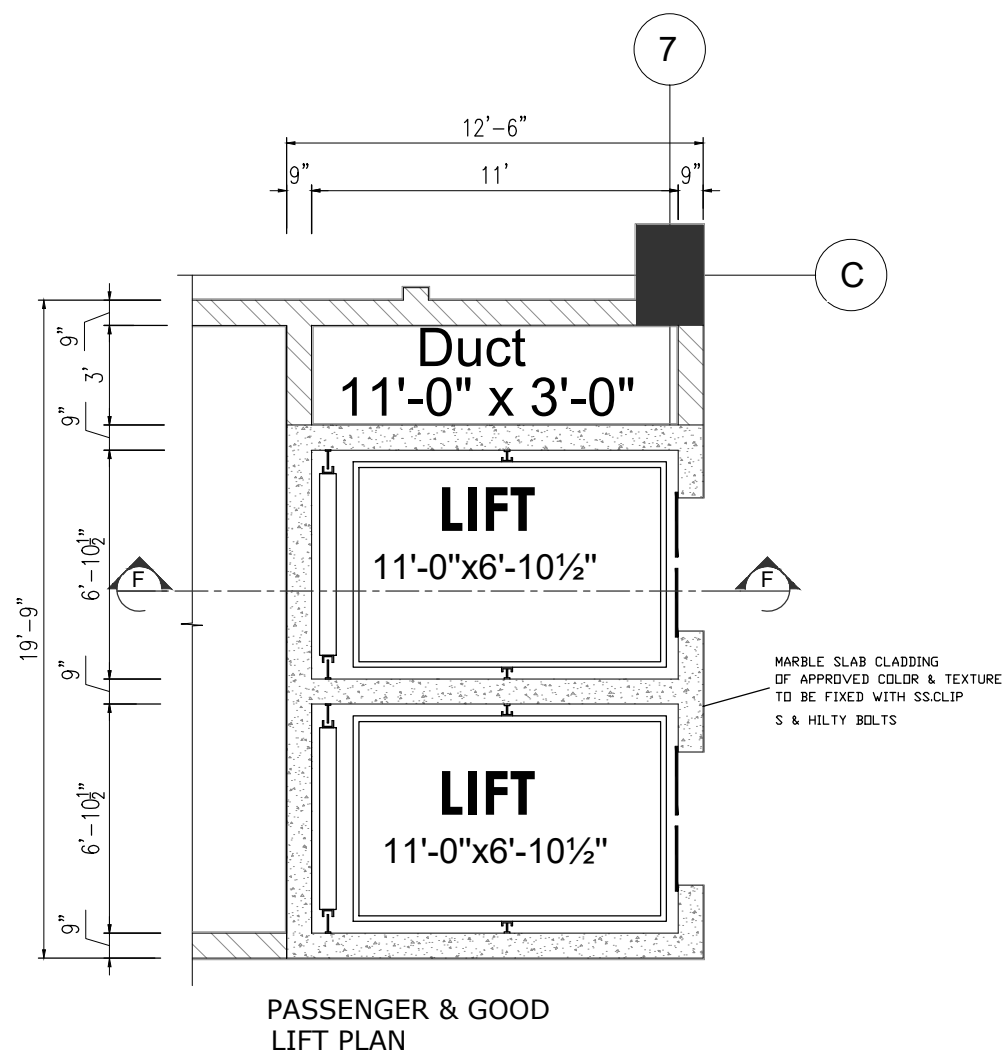


ISSUE FOR TENDER

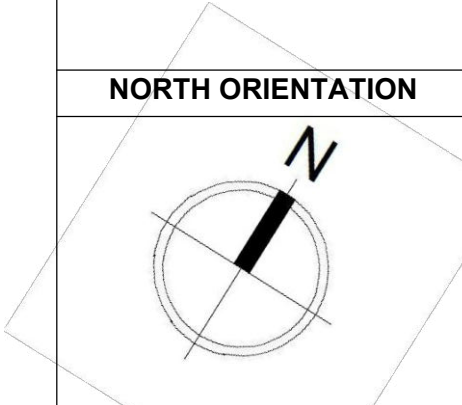
NOTES: These drawings are confidential and is the exclusive property of AAA (Pvt)Ltd. And is loaned subject to the condition that it is not to be reproduced to furnish for the making of drawing or prints except as sanctioned in writing by AAA (Pvt)Ltd.	
CLIENT NAME	
 پاکستان ایئر پورٹس اتھارٹی	
MAIN CONSULTANT	
 Anwar Ali Architects (Pvt.) Ltd. Formerly Anwar Ali & Associates Since March 2006 to June 2018 Consulting Architects, Engineers, Planners & Management Consultants	
JV MEMBERS	
	
	
STRUCTURAL CONSULTANT	
NORTH ORIENTATION	
	
Project Name	
Consultancy Services for New Air Traffic Control Tower (ATCT), Fire Station and Allied Facilities at Skardu International Airport	
Detailed Architectural Design Drawings	
Sheet Name	
LIFT DETAIL	
Date	12 January, 2026
Scale	NTS
Drawn by	Asad
Checked by	Ar. Ahmed Ali
Approved by	Ar. Anwar Ali
Drawing No.	AW-43 @A3

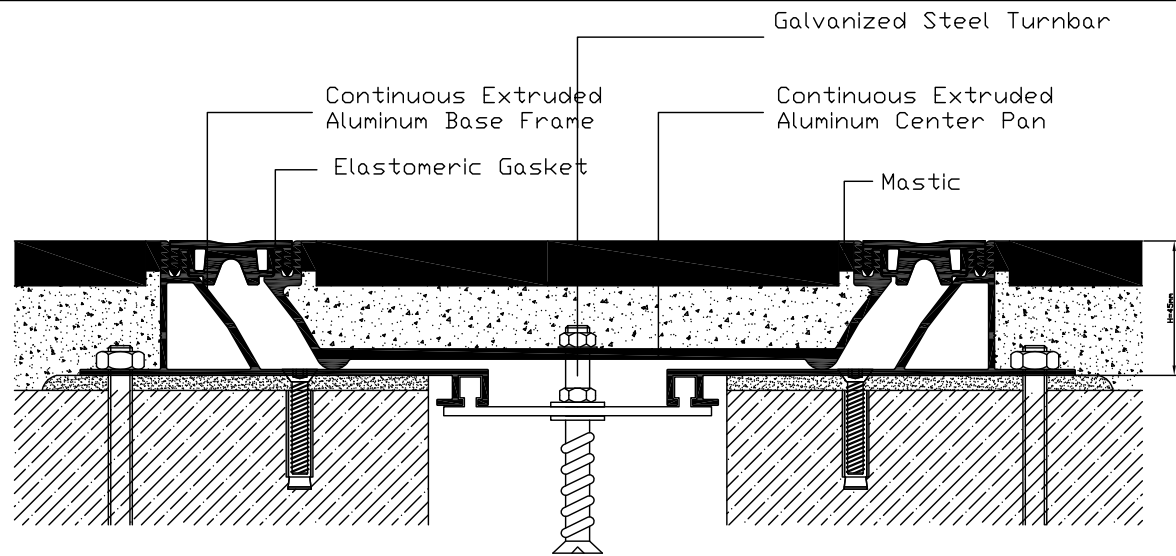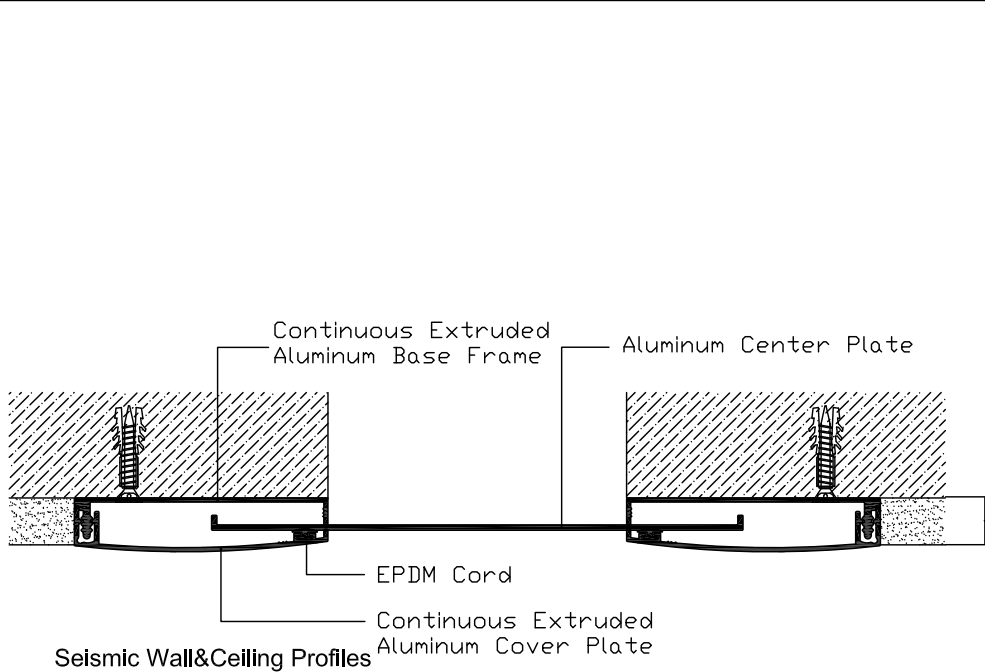

Seismic Floor Joint Profiles

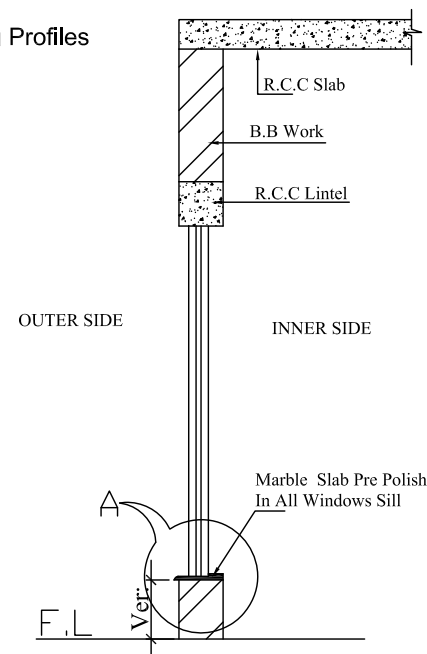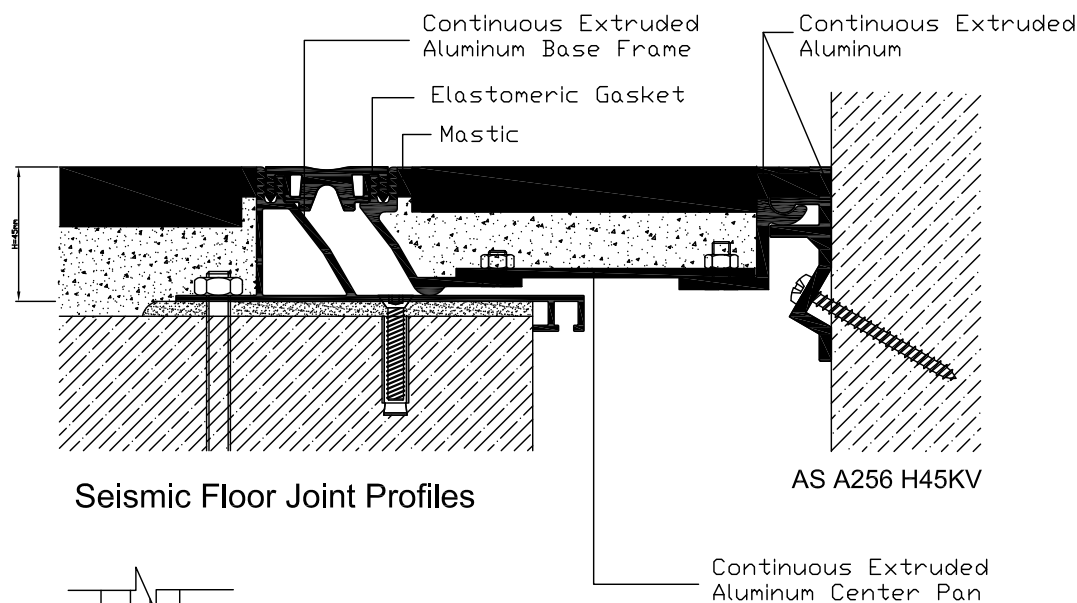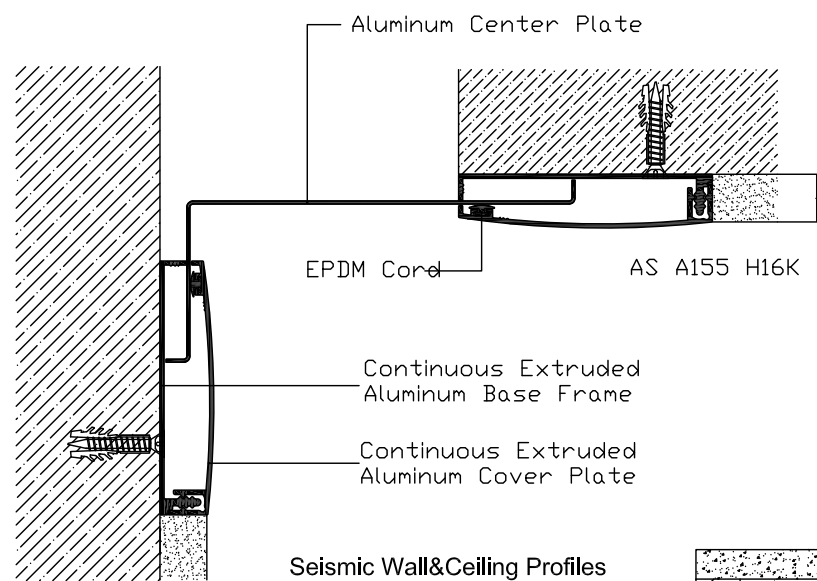

TYPICAL DETAIL OF MARBLE SLAB

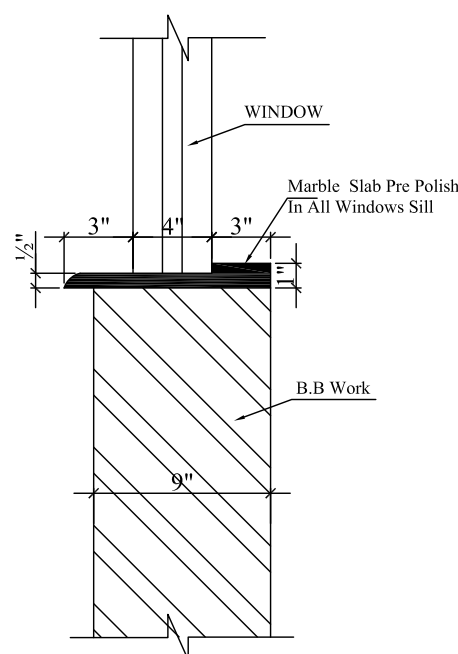

DETAIL-A

ISSUE FOR TENDER

NOTES:

These drawings are confidential and is the exclusive property of AAA (Pvt)Ltd. And is loaned subject to the condition that it is not to be reproduced to furnish for the making of drawing or prints except as sanctioned in writing by AAA (Pvt)Ltd.

CLIENT NAME



MAIN CONSULTANT




JV MEMBERS



leit-werk

STRUCTURAL CONSULTANT

NORTH ORIENTATION

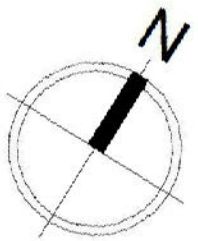

Project Name

Consultancy Services for New Air Traffic Control Tower (ATCT), Fire Station and Allied Facilities at Skardu International Airport

Detailed Architectural Design Drawings

Sheet Name

EXPANSION JOINT & TYPICAL DETAIL

Date	12 January, 2026
Scale	NTS
Drawn by	Asad
Checked by	Ar. Ahmed Ali
Approved by	Ar. Anwar Ali
Drawing No.	AW-44 @A3