




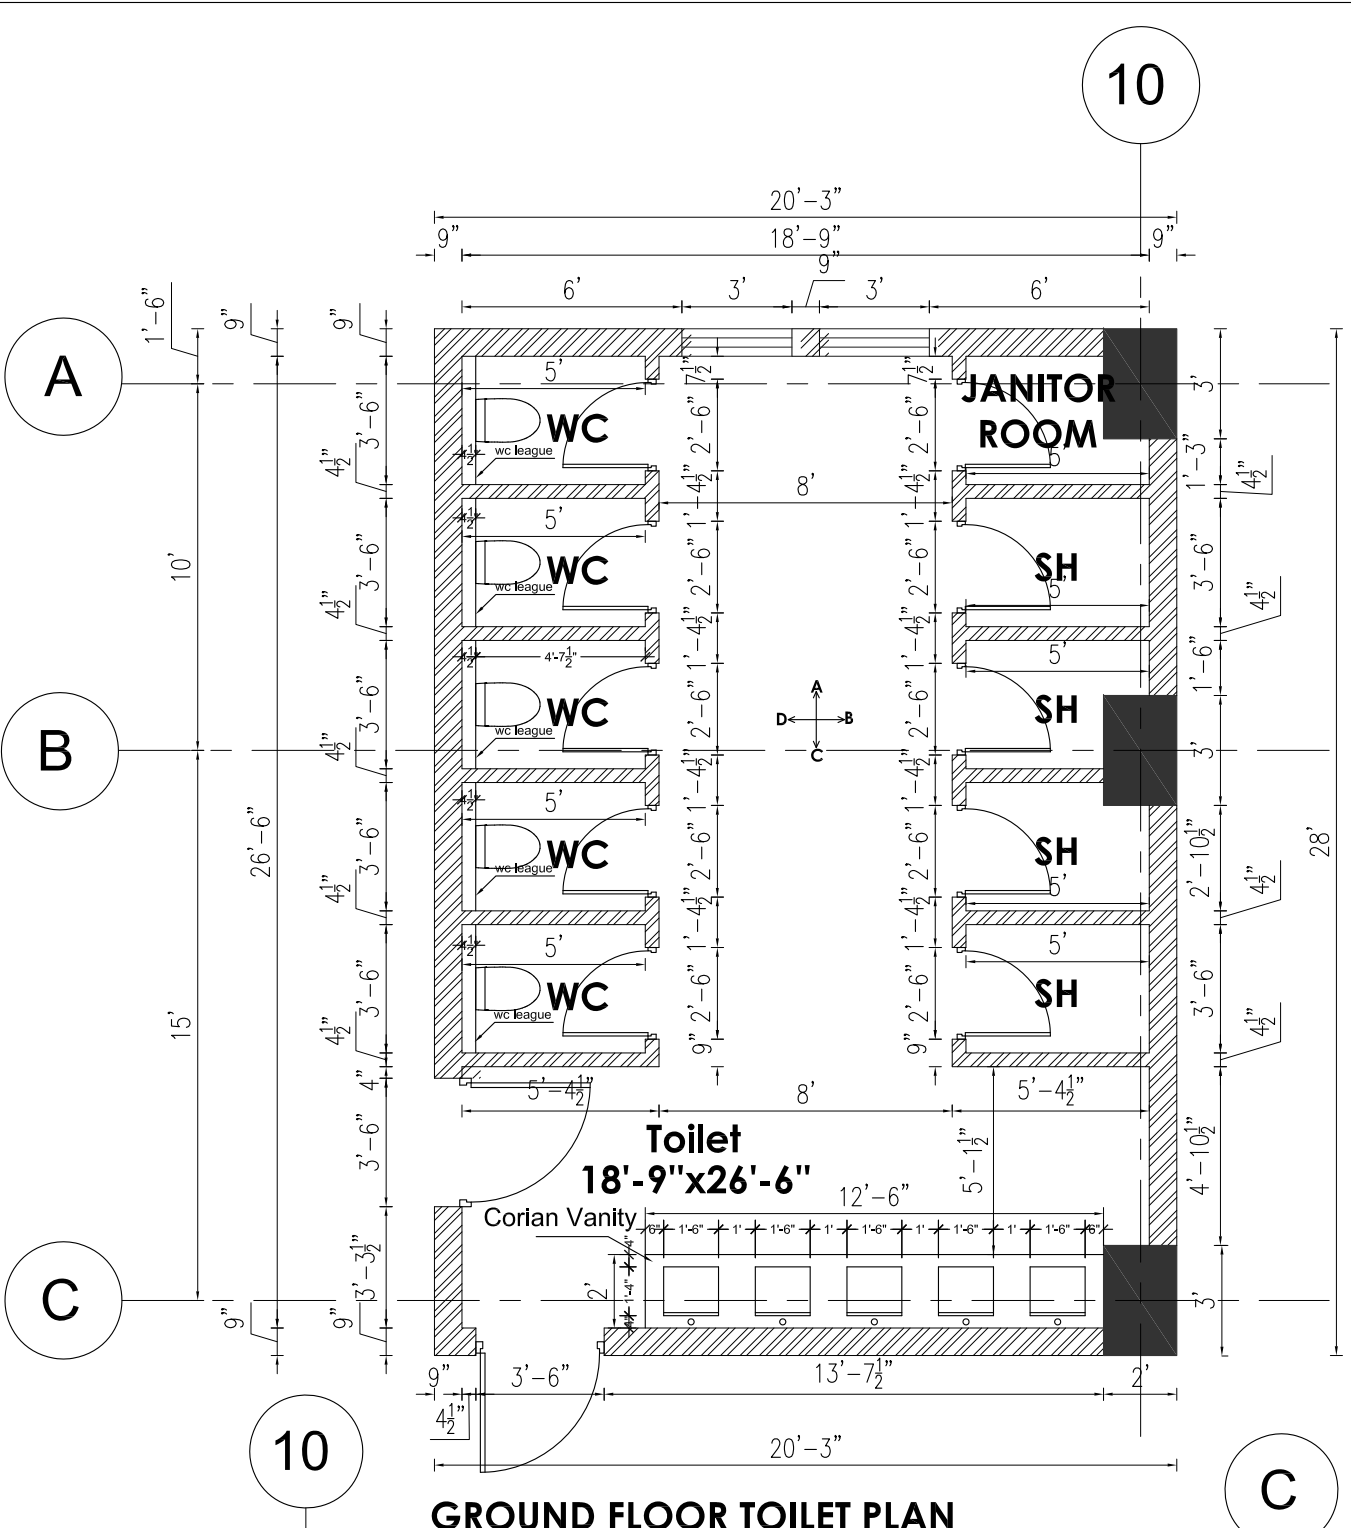


GROUND FLOOR TOILET PLAN

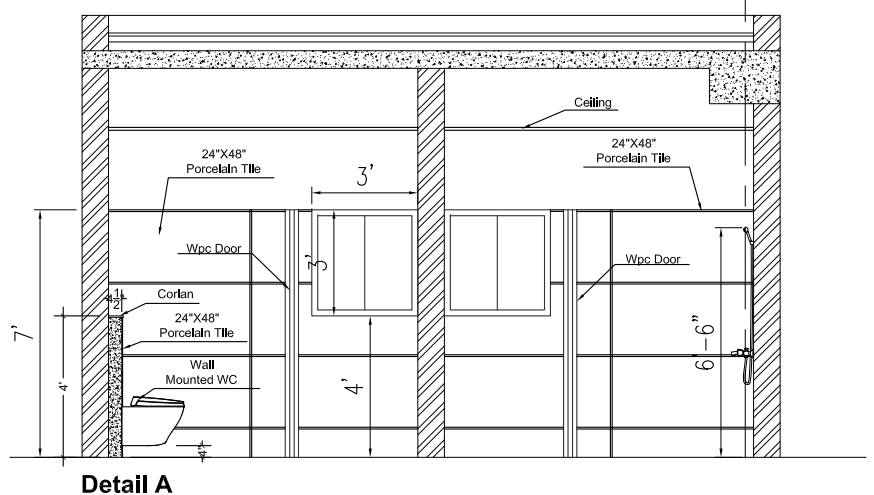


Detail A

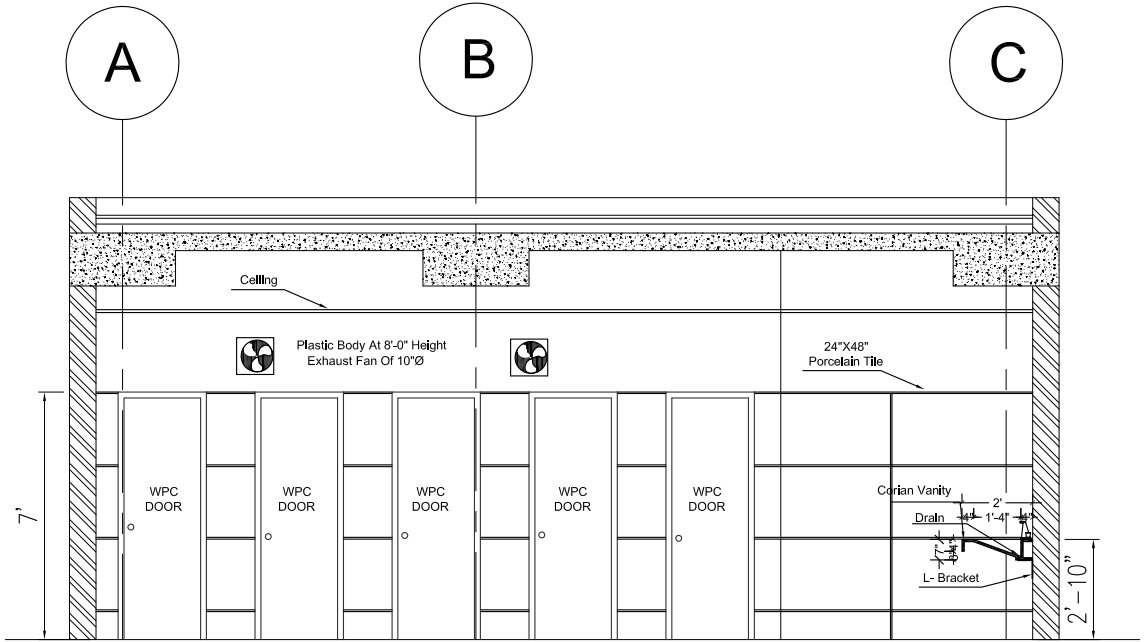

Detail B

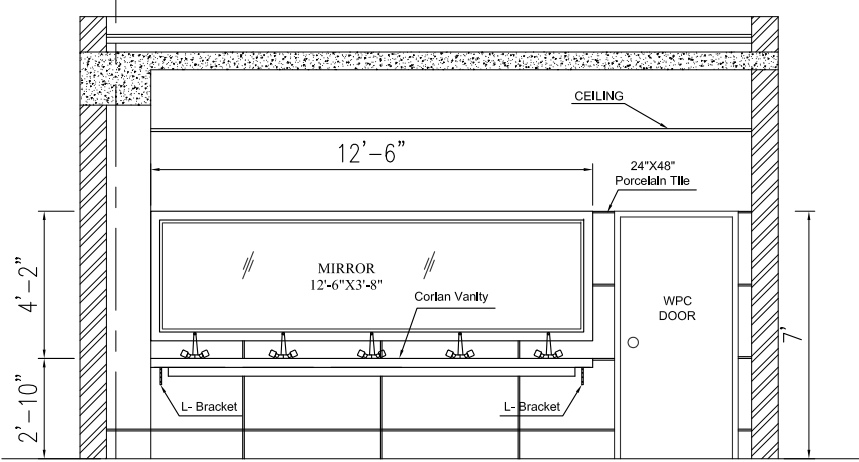



Detail C

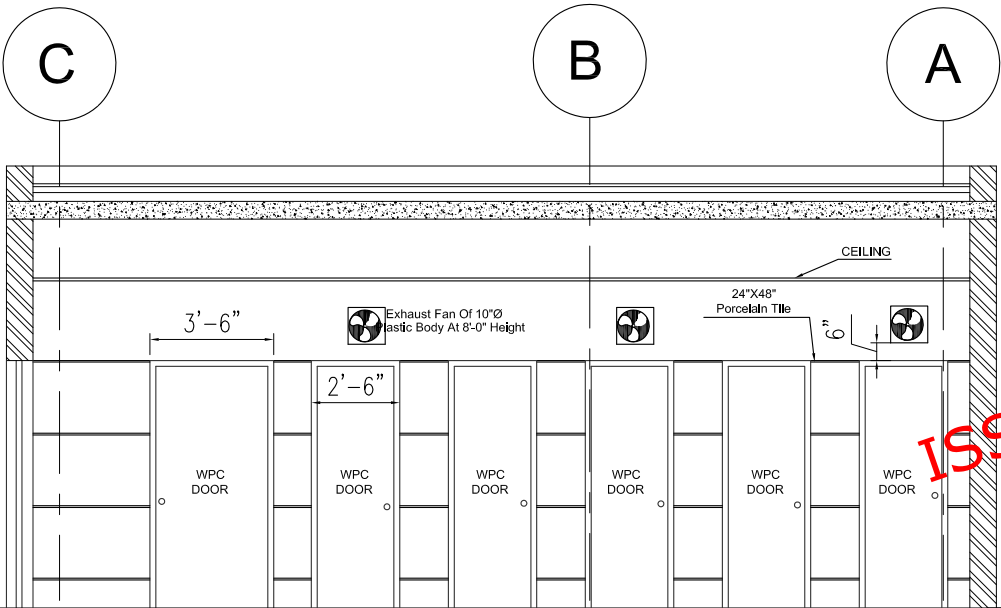


Detail D

ISSUE FOR TENDER

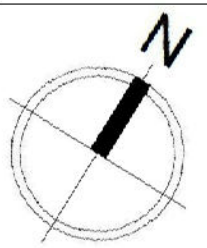
NOTES: These drawings are confidential and is the exclusive property of AAA (Pvt)Ltd. And is loaned subject to the condition that it is not to be reproduced or furnish for the making of drawing or prints except as sanctioned in writing by AAA (Pvt)Ltd.	
CLIENT NAME	
	
MAIN CONSULTANT	
	
JV MEMBERS	
	
leat-werk	
STRUCTURAL CONSULTANT	
NORTH ORIENTATION	
	
Project Name	
Consultancy Services for New Air Traffic Control Tower (ATCT), Fire Station and Allied Facilities at Skardu International Airport	
Detailed Architectural Design Drawings	
Sheet Name	
TOILET (GROUND FLOOR PLAN & SECTION)	
Date	12 January, 2026
Scale	NTS
Drawn by	Asad
Checked by	Ar. Ahmed Ali
Approved by	Ar. Anwar Ali
Drawing No.	AW-45 @A3

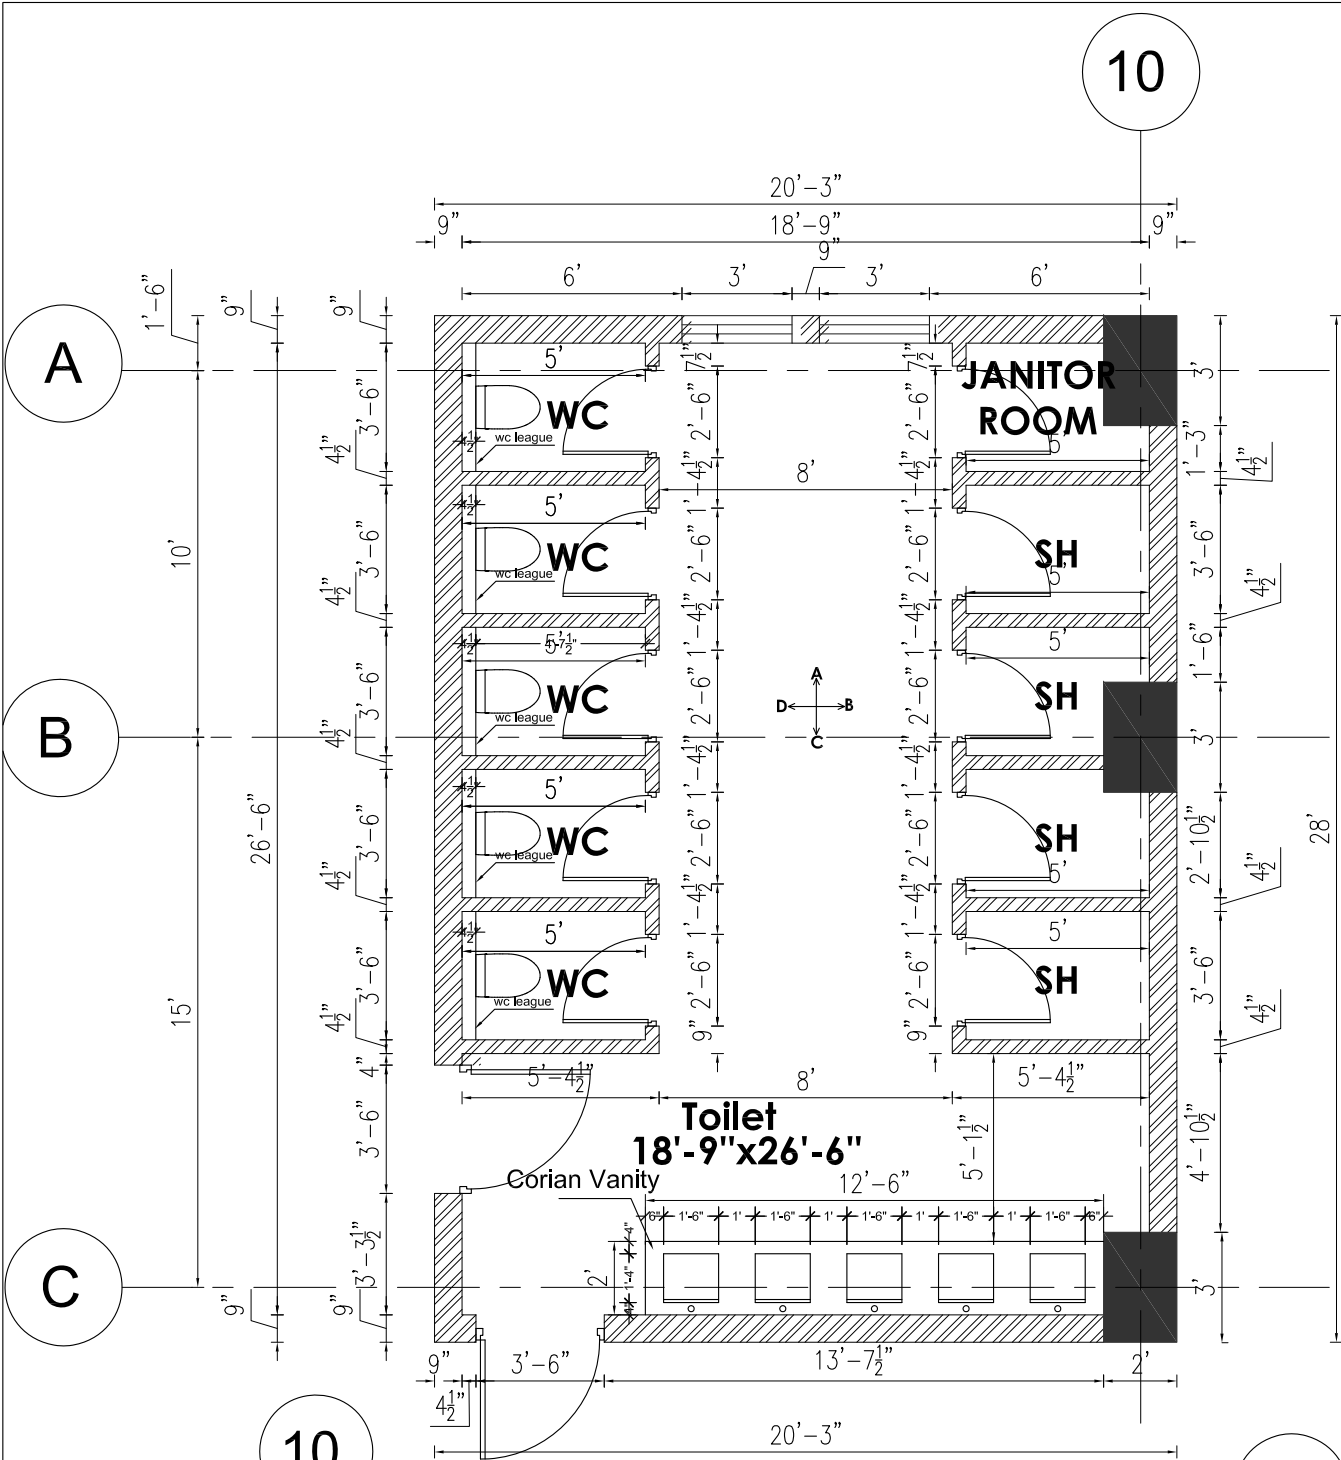


MEZZANINE FLOOR TOILET PLAN

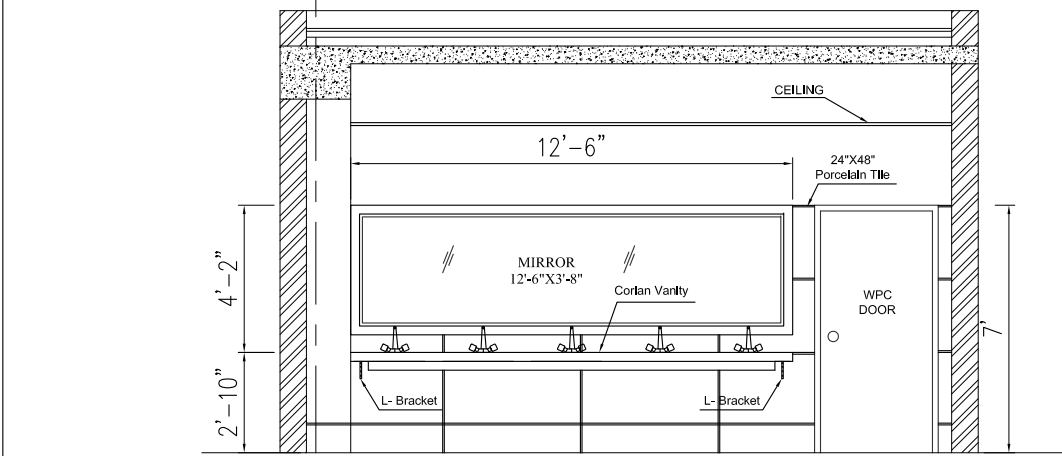


DETAIL C

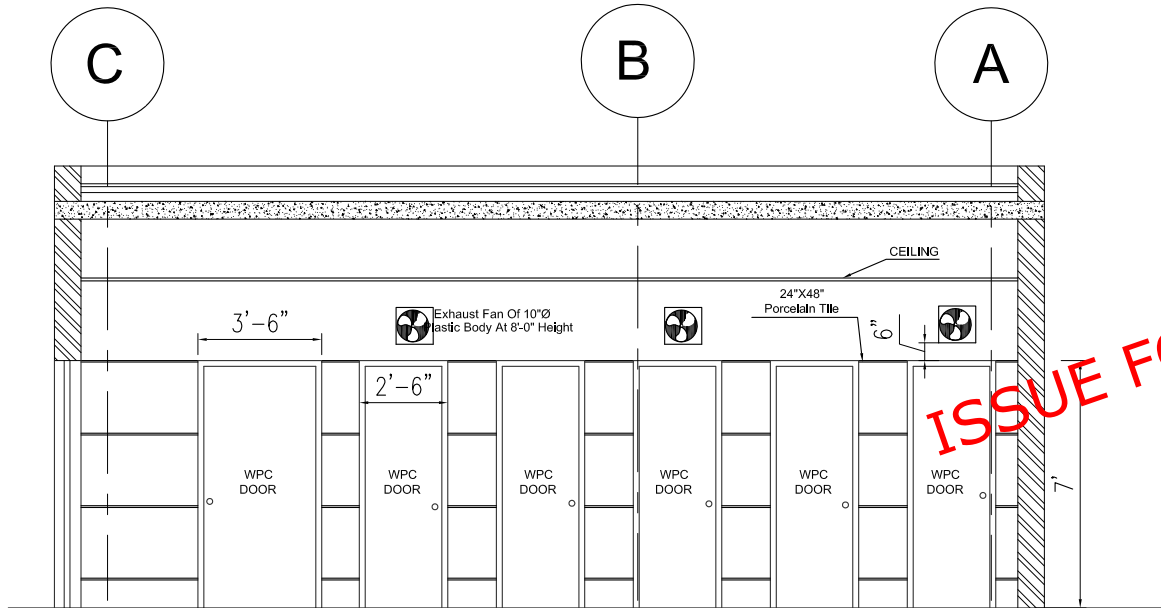


DETAIL D

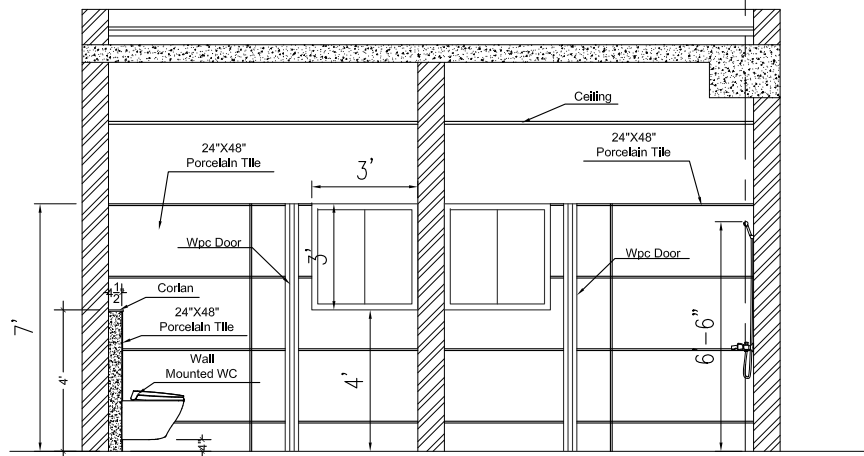






Detail A

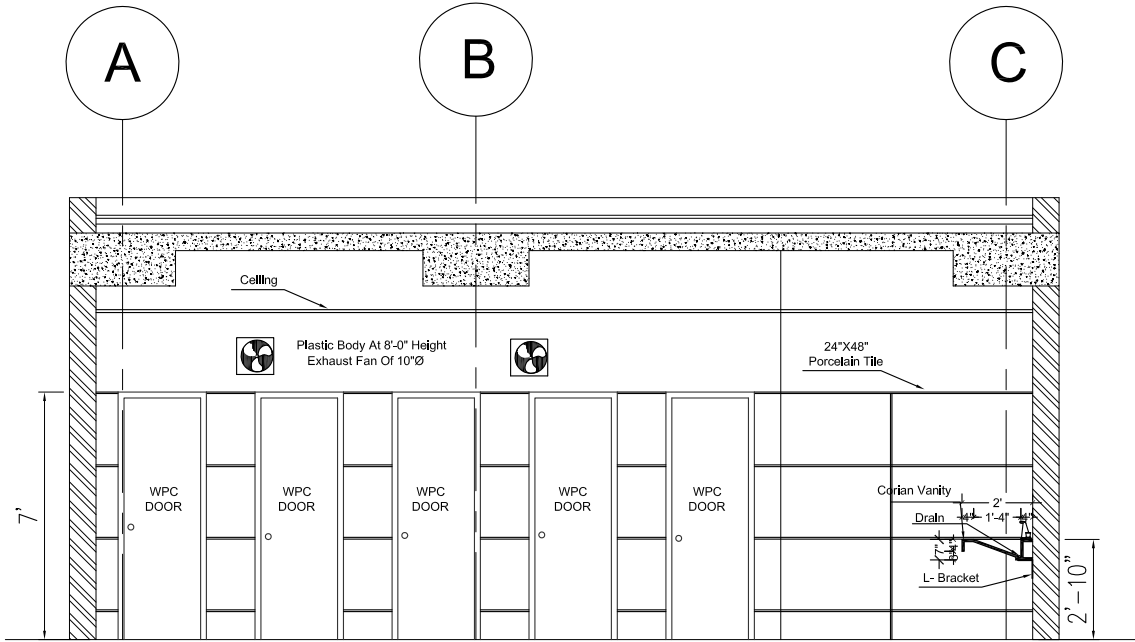

Detail B

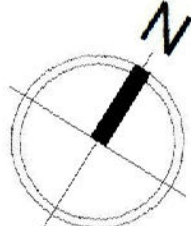NOTES: These drawings are confidential and is the exclusive property of AAA (Pvt)Ltd. And is loaned subject to the condition that it is not to be reproduced to furnish for the making of drawing or prints except as sanctioned in writing by AAA (Pvt)Ltd.	
CLIENT NAME	
 پاکستان انیئر پرائیویٹ لیمیٹڈ	
MAIN CONSULTANT	
 Formerly Anwar Ali & Associates Since March 2006 to June 2018 Consulting Architects, Engineers, Planners & Management Consultants	
JV MEMBERS	
	
leiti-werk	
STRUCTURAL CONSULTANT	
NORTH ORIENTATION	
	
Project Name	
Consultancy Services for New Air Traffic Control Tower (ATCT), Fire Station and Allied Facilities at Skardu International Airport	
Detailed Architectural Design Drawings	
Sheet Name	
TOILET (MEZZANINE FLOOR PLAN & SECTION)	
Date	12 January, 2026
Scale	NTS
Drawn by	Asad
Checked by	Ar. Ahmed Ali
Approved by	Ar. Anwar Ali
Drawing No.	AW-46 @A3

ISSUE FOR TENDER

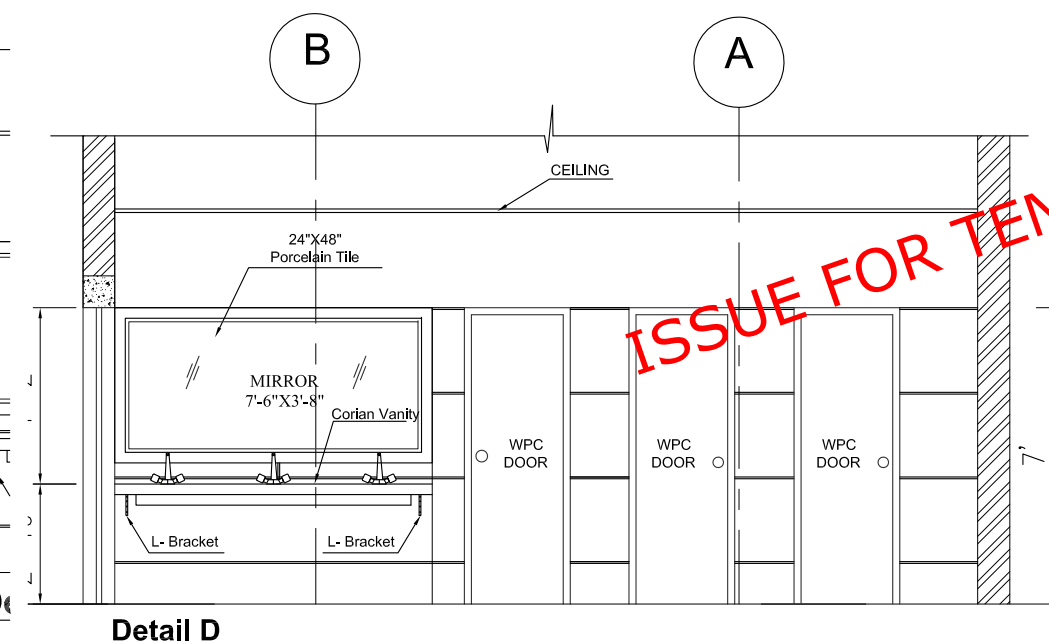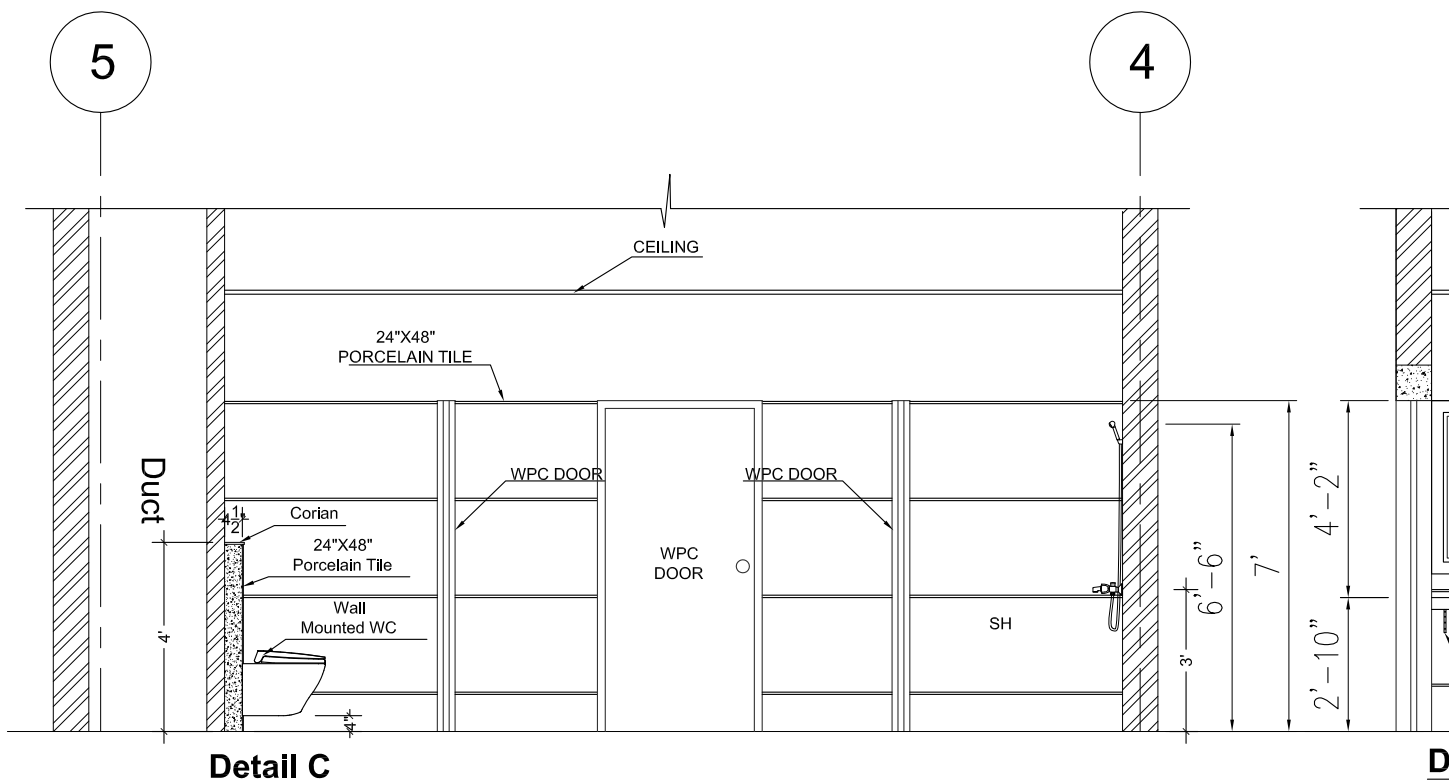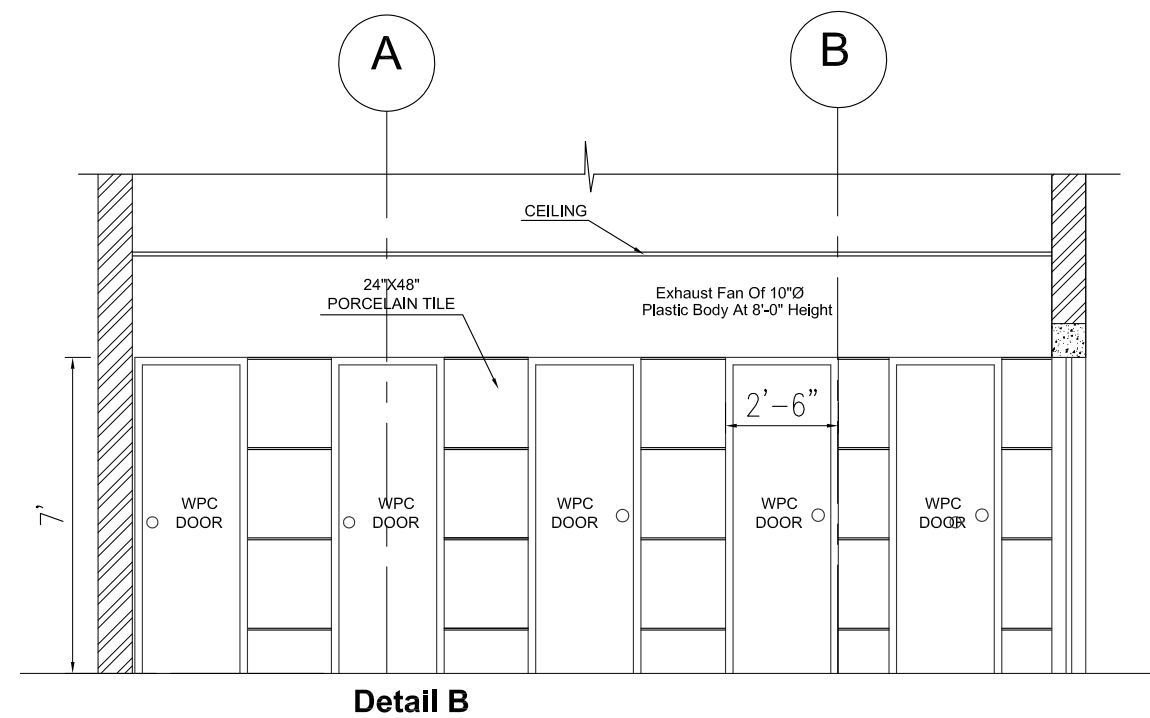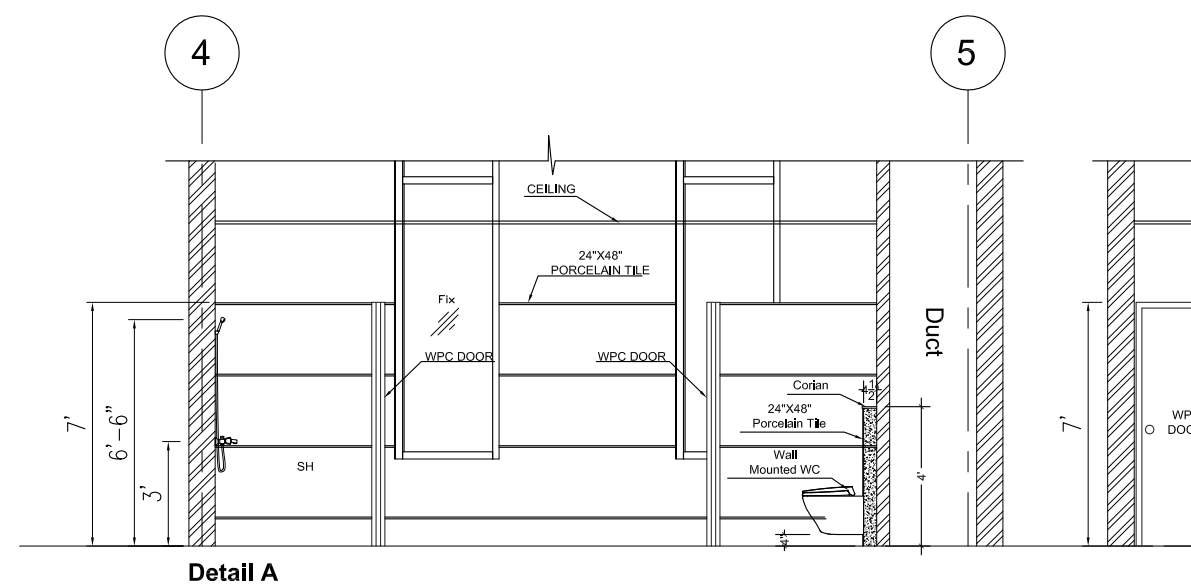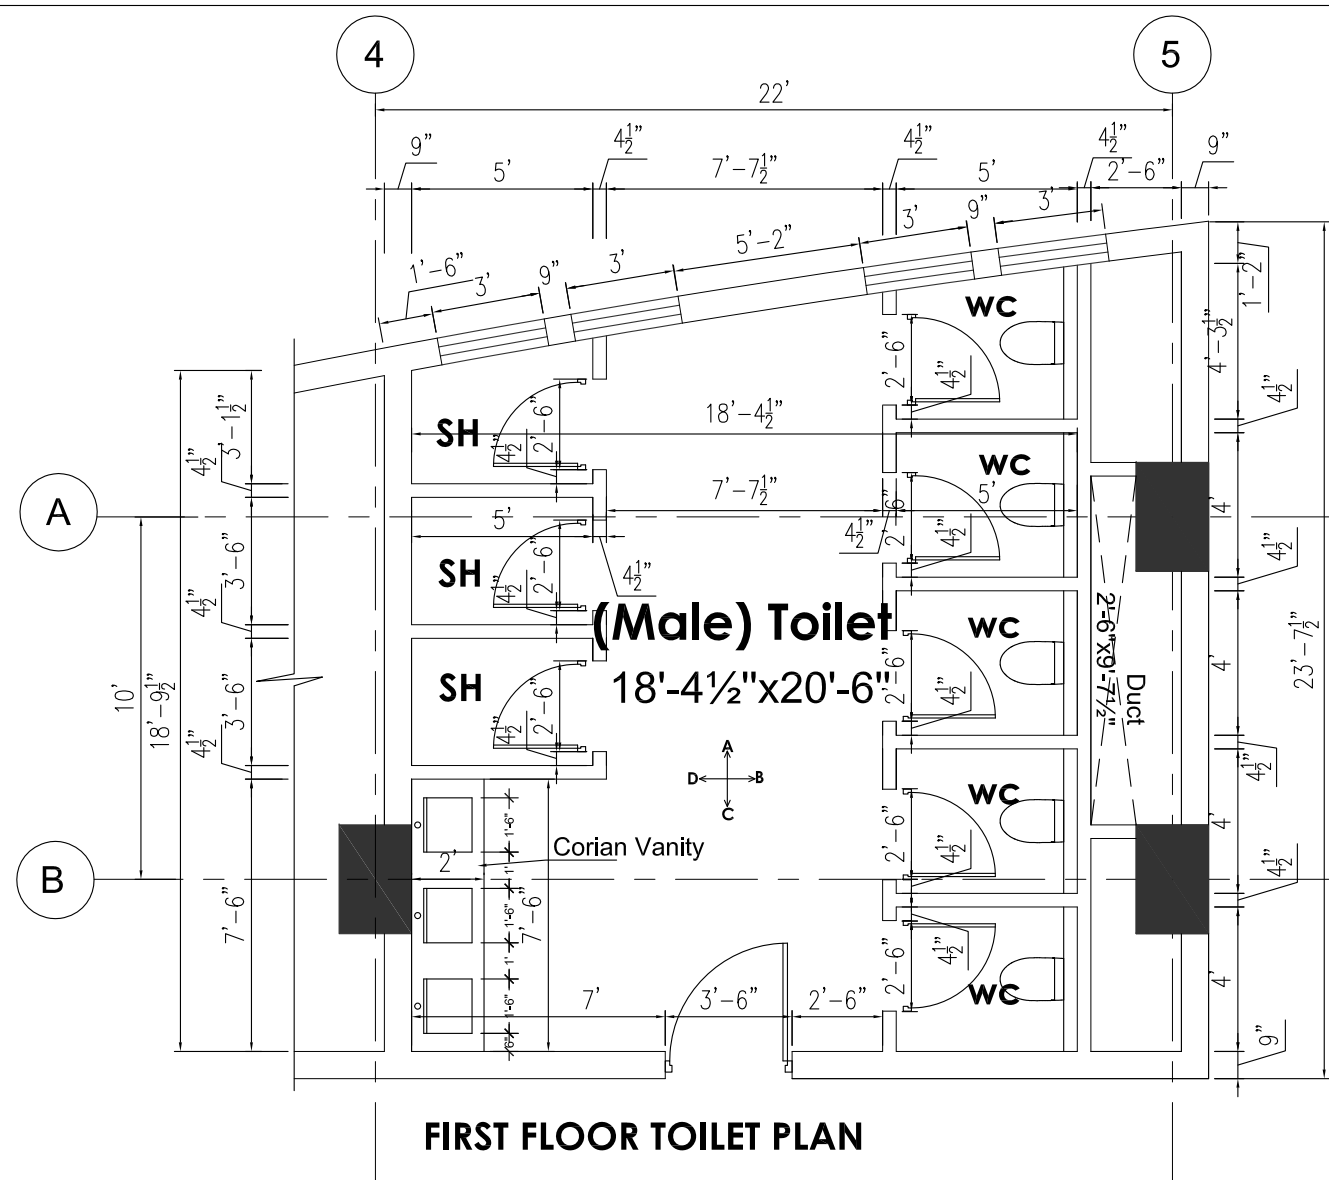

NOTES:

These drawings are confidential and is the exclusive property of AAA (Pvt)Ltd. and is loaned subject to the condition that it is not to be reproduced or furnish for the making of drawing or prints except as sanctioned in writing by AAA (Pvt)Ltd.

CLIENT NAME



MAIN CONSULTANT




JV MEMBERS



leit-werk

STRUCTURAL CONSULTANT

NORTH ORIENTATION

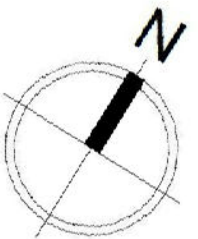

Project Name

Consultancy Services for New Air Traffic Control Tower (ATCT), Fire Station and Allied Facilities at Skardu International Airport

Detailed Architectural Design Drawings

Sheet Name

MALE TOILET (FIRST FLOOR
PLAN & SECTION)

Date	12 January, 2026
------	------------------






Scale	NTS
-------	-----

Drawn by	Asad
----------	------

Checked by	Ar. Ahmed Ali
------------	---------------

Approved by	Ar. Anwar Ali
-------------	---------------

Drawing No.	AW-47	@A3
-------------	-------	-----

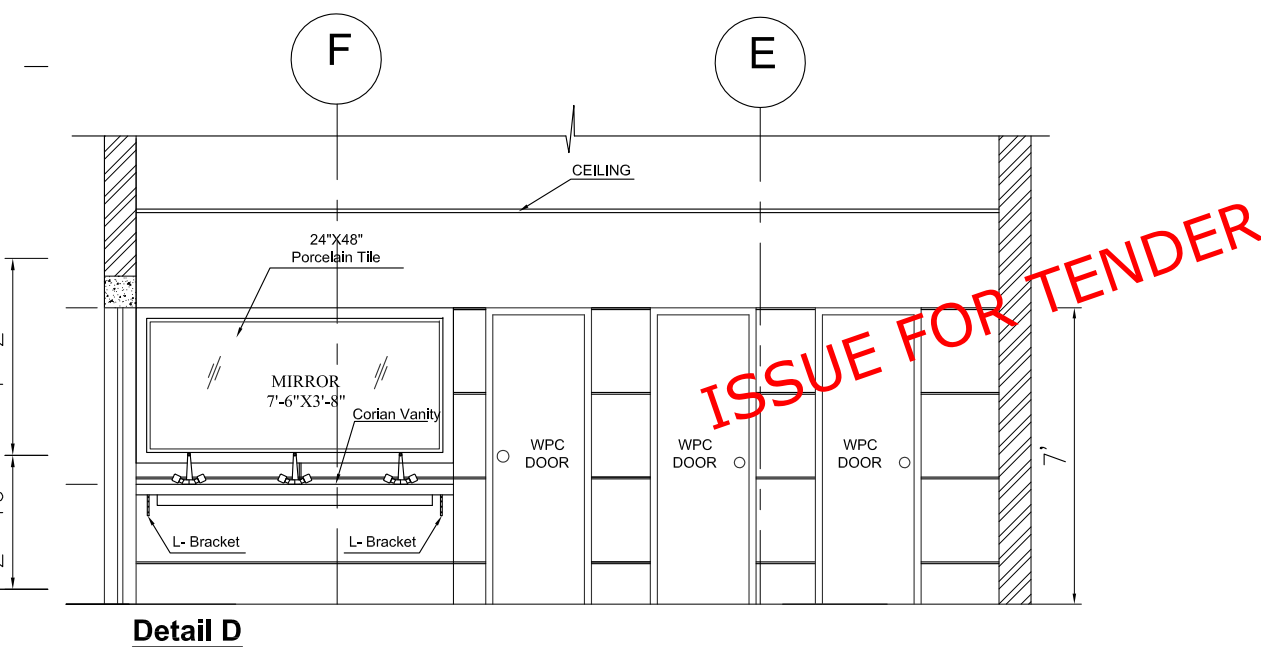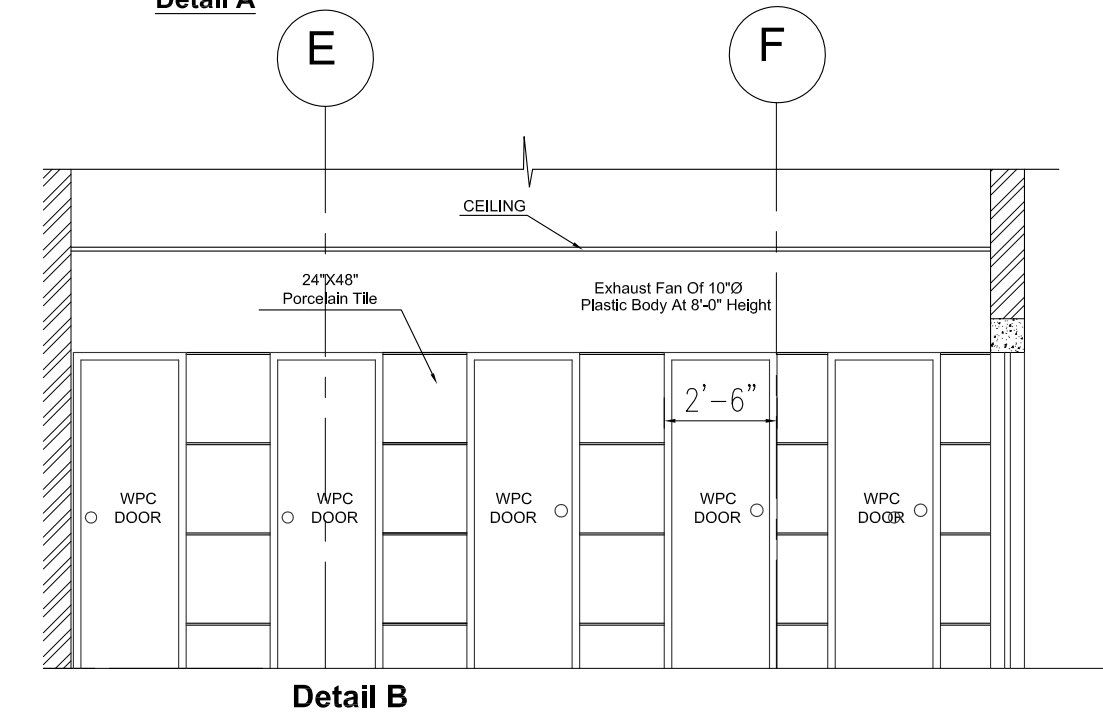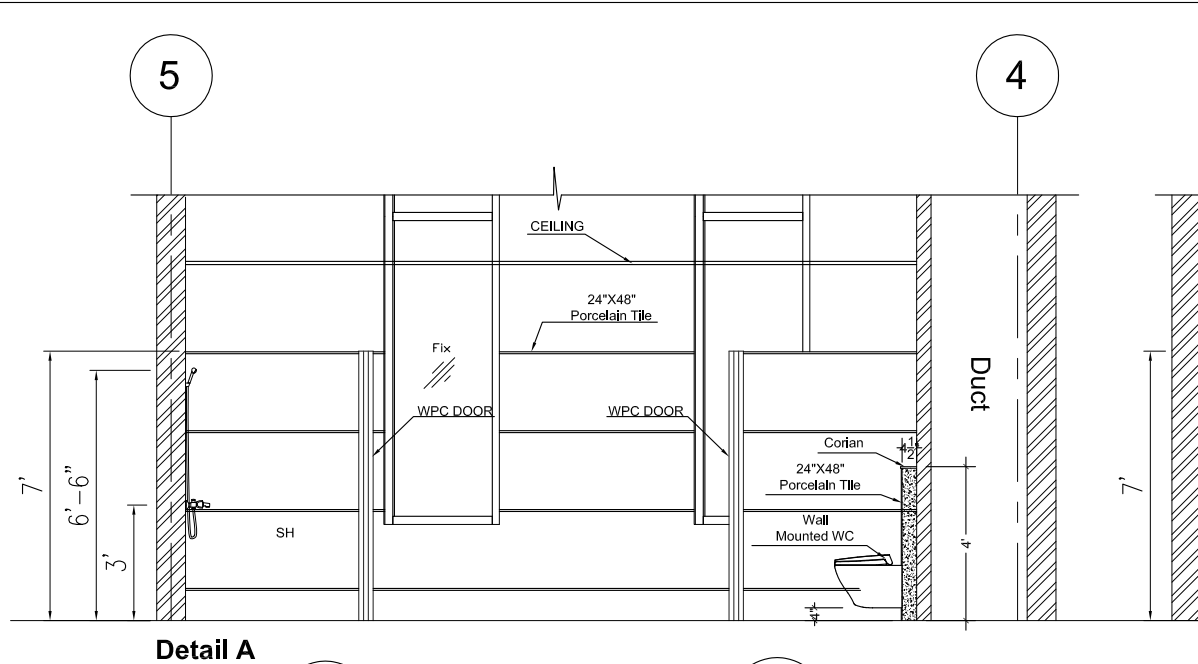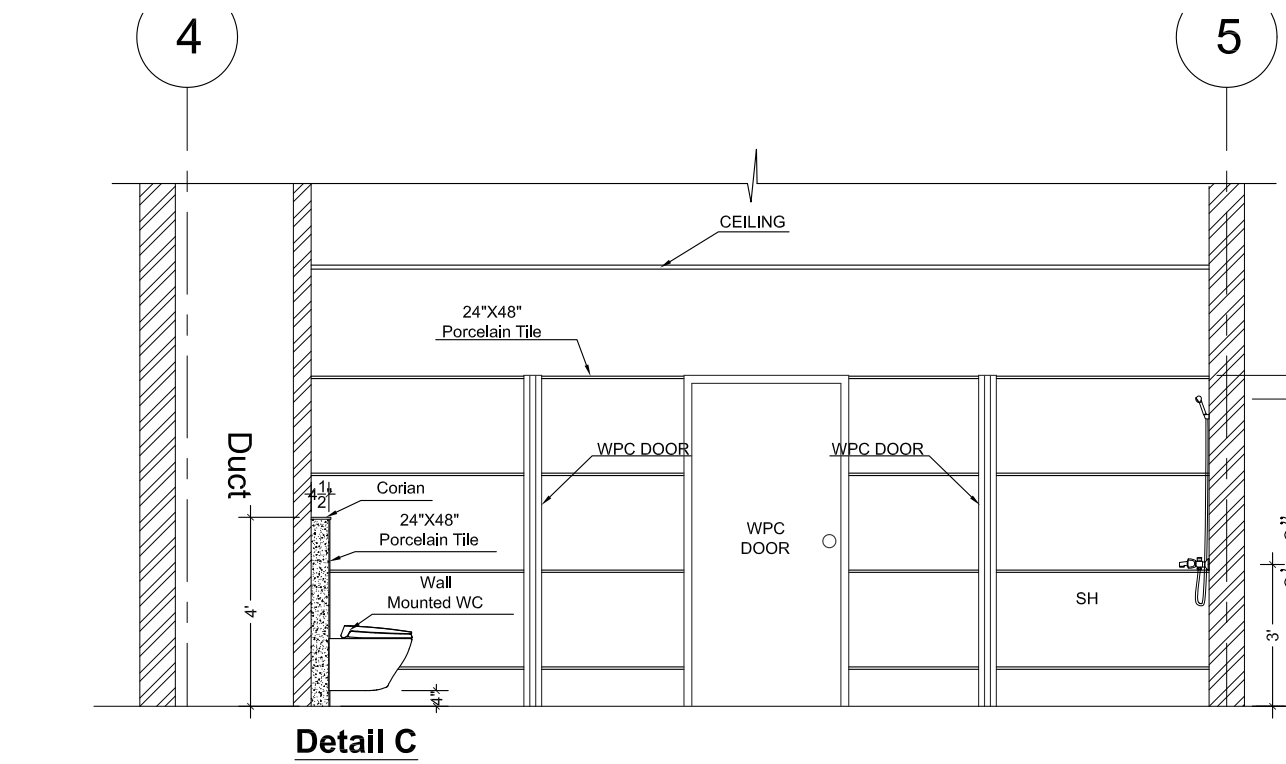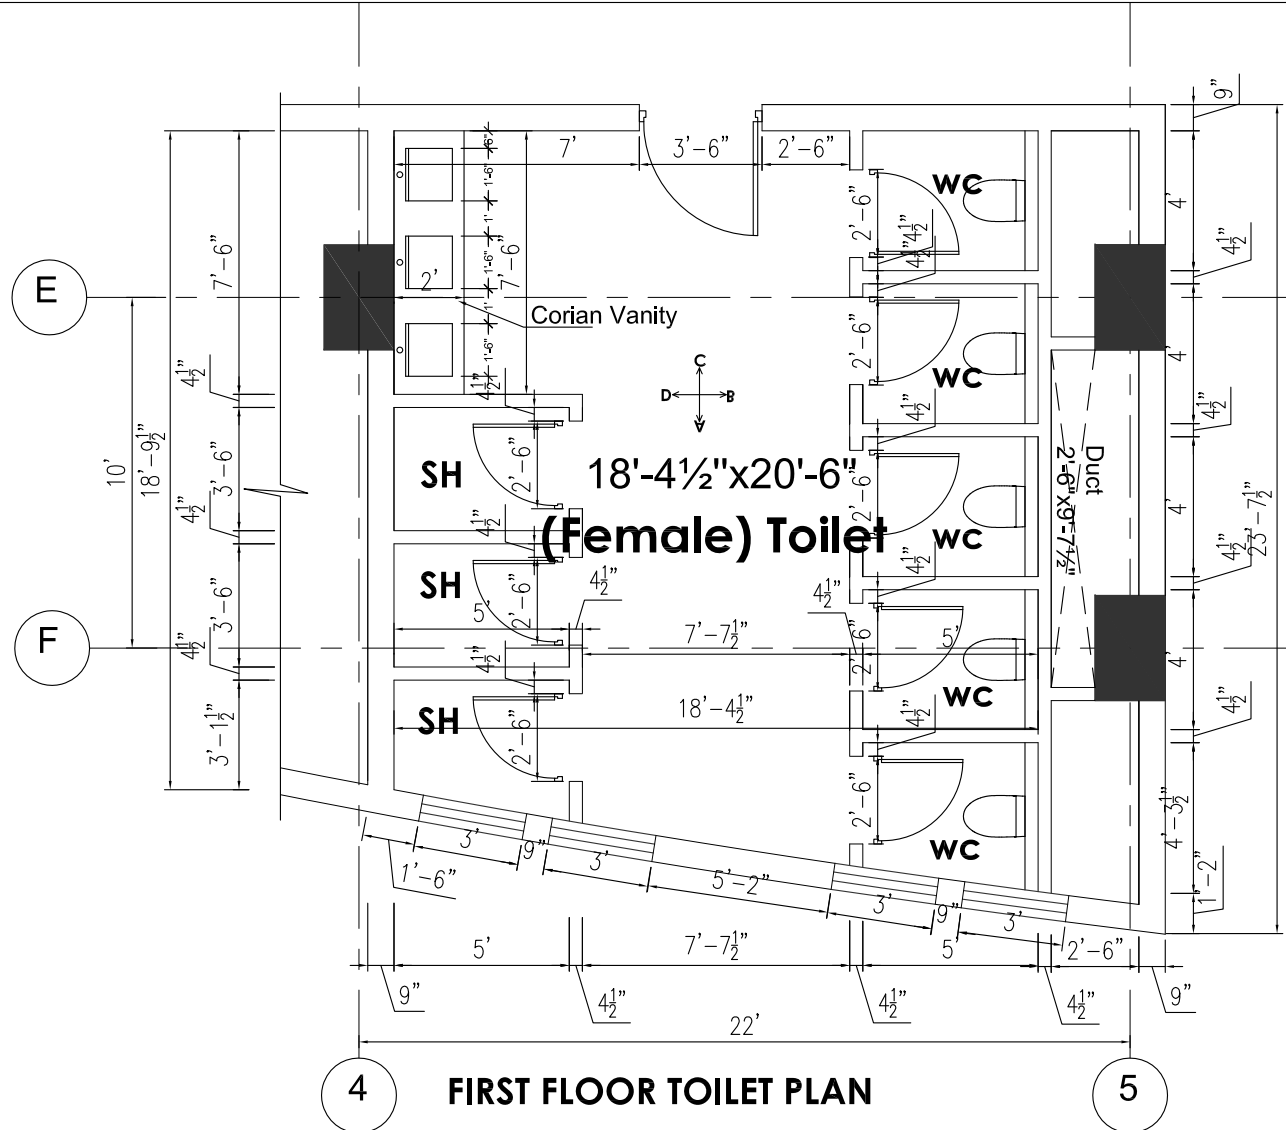

NOTES:
These drawings are confidential and is the exclusive property of AAA (Pvt)Ltd. And is loaned subject to the condition that it is not to be reproduced to furnish for the making of drawing or prints except as sanctioned in writing by AAA (Pvt)Ltd.

CLIENT NAME


پاکستان ایئر پورٹس اتھارٹی

MAIN CONSULTANT

Anwar Ali Architects (Pvt.) Ltd.
Formerly Anwar Ali & Associates Since March 2006 to June 2018
Consulting Architects, Engineers, Planners & Management Consultants

JV MEMBERS


STRUCTURAL CONSULTANT

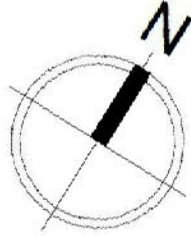
NORTH ORIENTATION


Project Name
Consultancy Services for
New Air Traffic
Control Tower (ATCT),
Fire Station and Allied
Facilities at Skardu
International Airport

**Detailed Architectural
Design Drawings**

Sheet Name
FEMALE TOILET (FIRST
FLOOR PLAN & SECTION)

Date	14 November, 2025
Scale	NTS
Drawn by	Asad
Checked by	Ar. Ahmed Ali
Approved by	Ar. Anwar Ali
Drawing No.	AW-48 @A3

These drawings are confidential and is the exclusive property of AAA (Pvt)Ltd. And is loaned subject to the condition that it is not to be reproduced or furnish for the making of drawing or prints except as sanctioned in writing by AAA (Pvt)Ltd.



Anwar Ali Architects (Pvt.) Ltd.
Formerly **Anwar Ali & Associates** Since March 2006 to June 2012
Consulting Architects, Engineers, Planners & Management Consultants



STRUCTURAL CONSULTANT

Consultancy Services for New Air Traffic Control Tower (ATCT), Fire Station and Allied Facilities at Skardu International Airport

Sheet Name

Date	12 January, 2026
------	------------------

Scale	NTS
-------	-----

Checked by	Ar. Ahmed Ali
------------	---------------

Drawing No.	AW 40	© A
-------------	-------	-----



G.F Covered Area =	23332 Sft
M.F Covered Area =	9064 Sft
F.F Covered Area =	27439 Sft
R.F COVERED AREA	2792 Sft
ARFF COVERED AREA	1277 Sft
ATCT COVERED AREA	1809 Sft
<u>TOTAL COVERED AREA</u>	<u>65713 SFT</u>

- 1) 03 For ARFF Vehicles - Striker 4x4
- 2) 01 For Water Bowzer
- 3) 01 For Domestic Fire Tender
- 4) 01 For Fire Crash Ambulance
- 5) 01 For Mobile Command Post Vehicle

ISSUE FOR TENDER

These drawings are confidential and is the exclusive property of AAA (Pvt)Ltd. And is loaned subject to the condition that it is not to be reproduced or furnish for the making of drawing or prints except as sanctioned in writing by AAA (Pvt)Ltd.



Anwar Ali Architects (Pvt.) Ltd.
Formerly **Anwar Ali & Associates** Since March 2006 to June 2012
Consulting Architects, Engineers, Planners & Management Consultants



STRUCTURAL CONSULTANT

Consultancy Services for New Air Traffic Control Tower (ATCT), Fire Station and Allied Facilities at Skardu International Airport


Sheet Name

Date	12 January, 2026
------	------------------

Drawn by	Asad
----------	------

Approved by	Ar. Anwar Ali
-------------	---------------

Drawing No.	AW-49	@A
-------------	-------	----

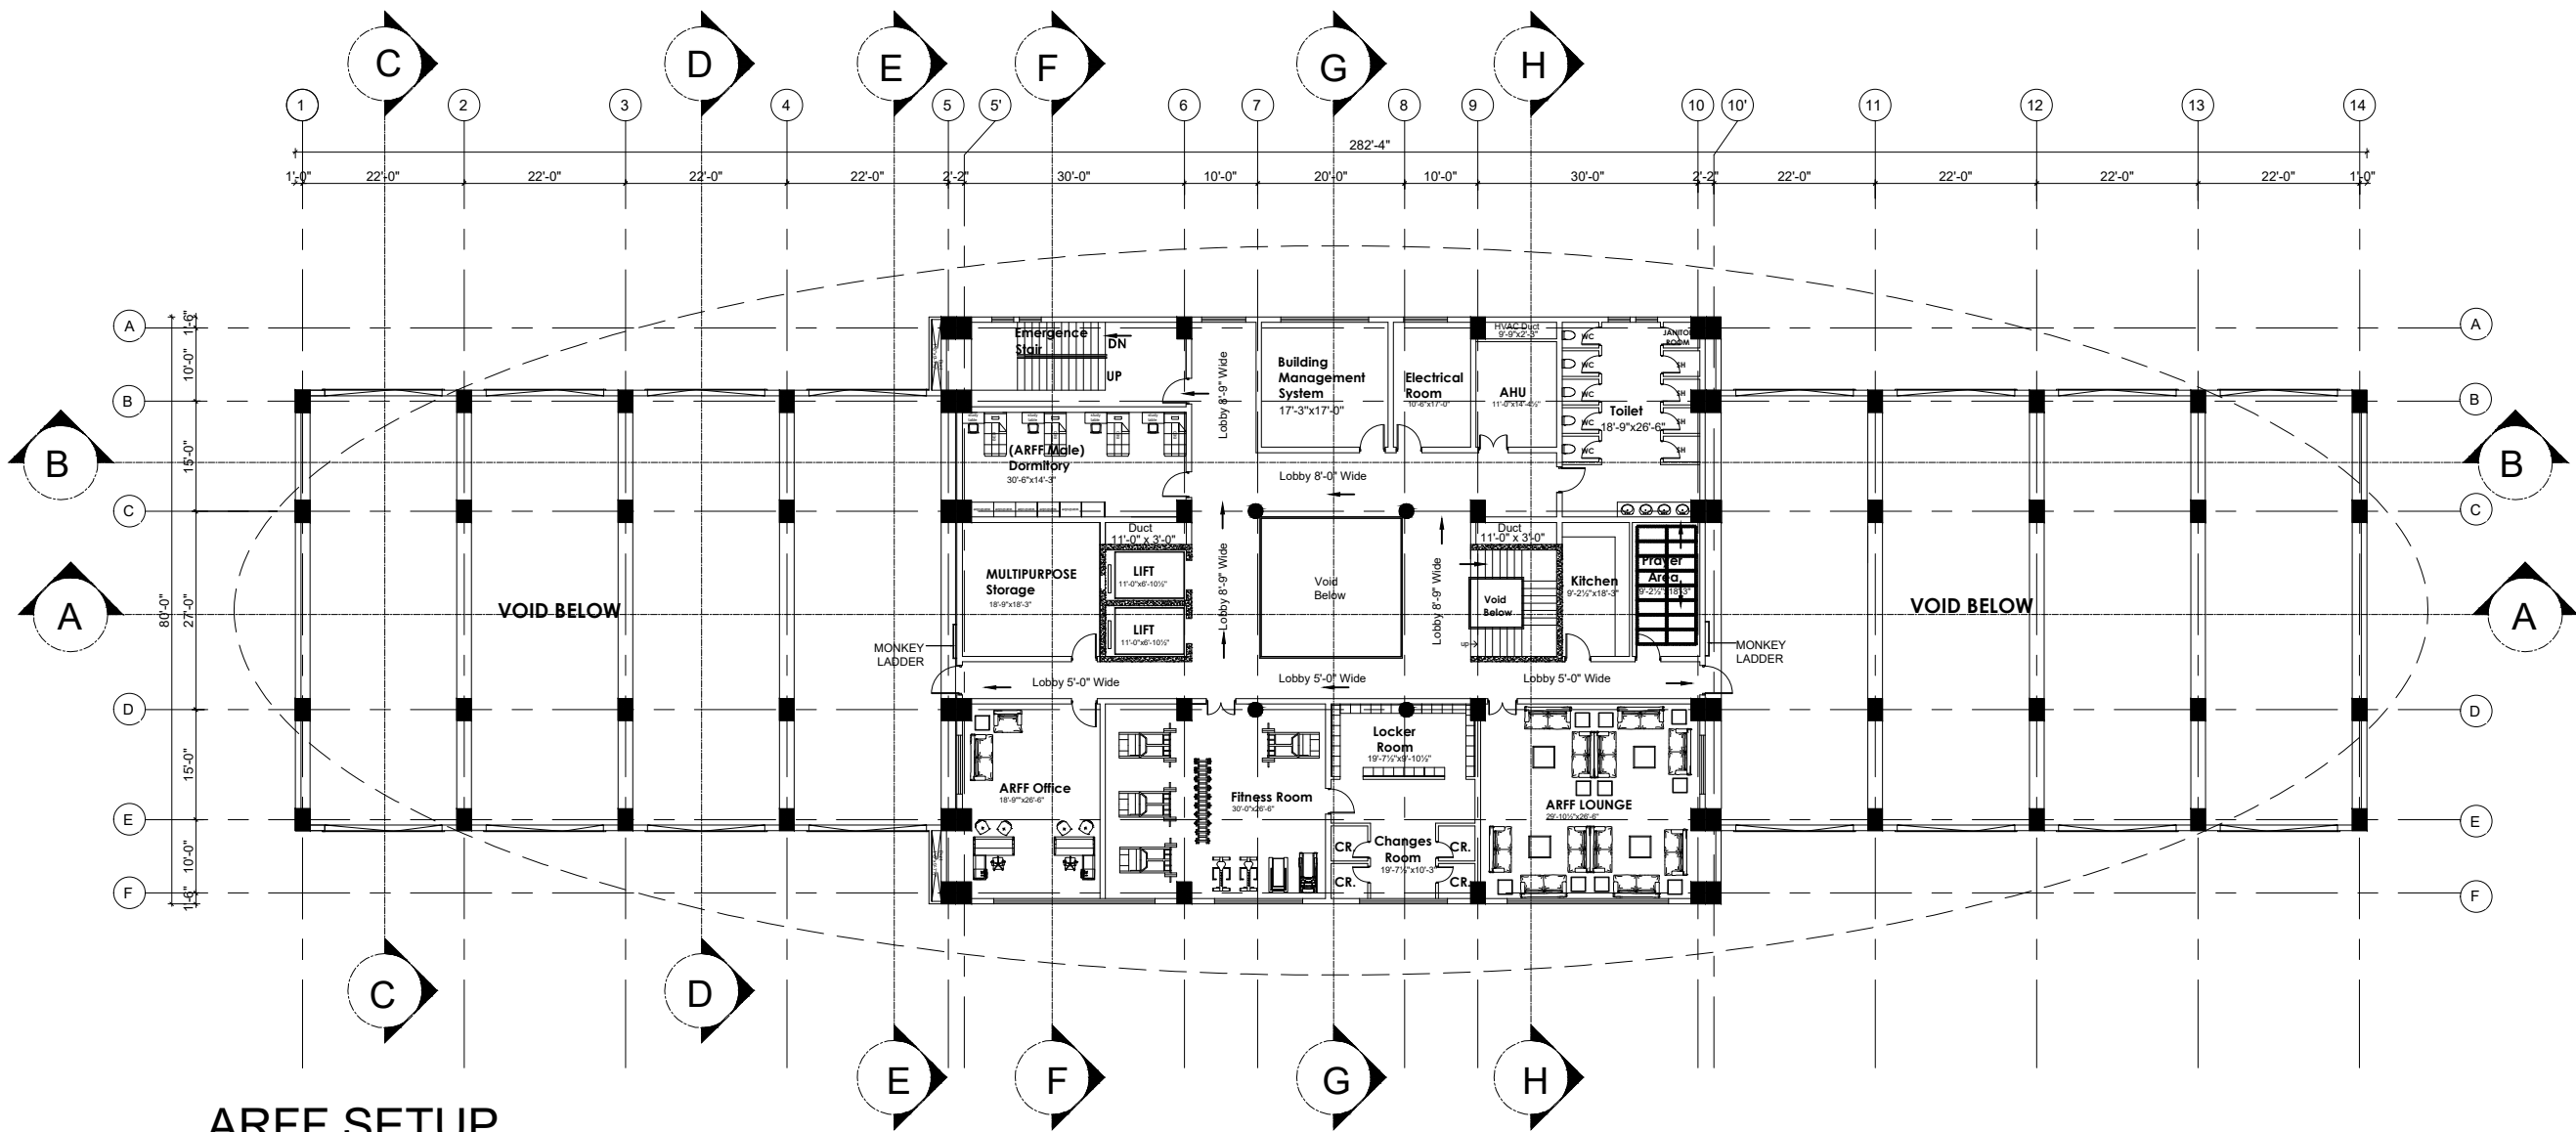

**ARFF SETUP
MEZZANINE FLOOR PLAN**
Covered Area = 9064 Sft

ISSUE FOR TENDER

NOTES:

These drawings are confidential and is the exclusive property of AAA (Pvt)Ltd. And is loaned subject to the condition that it is not to be reproduced to furnish for the making of drawing or prints except as sanctioned in writing by AAA (Pvt)Ltd.

CLIENT NAME



MAIN CONSULTANT




JV MEMBERS



leit-werk

STRUCTURAL CONSULTANT

NORTH ORIENTATION

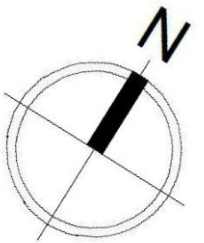

Project Name


Consultancy Services for
New Air Traffic
Control Tower (ATCT),
Fire Station and Allied
Facilities at Skardu
International Airport

**Detailed Architectural
Design Drawings**

Sheet Name

MEZZANINE FLOOR
FIRE EXIT PLAN

Date	12 January, 2026
Scale	NTS
Drawn by	Asad
Checked by	Ar. Ahmed Ali
Approved by	Ar. Anwar Ali
Drawing No.	AW-50 @A3

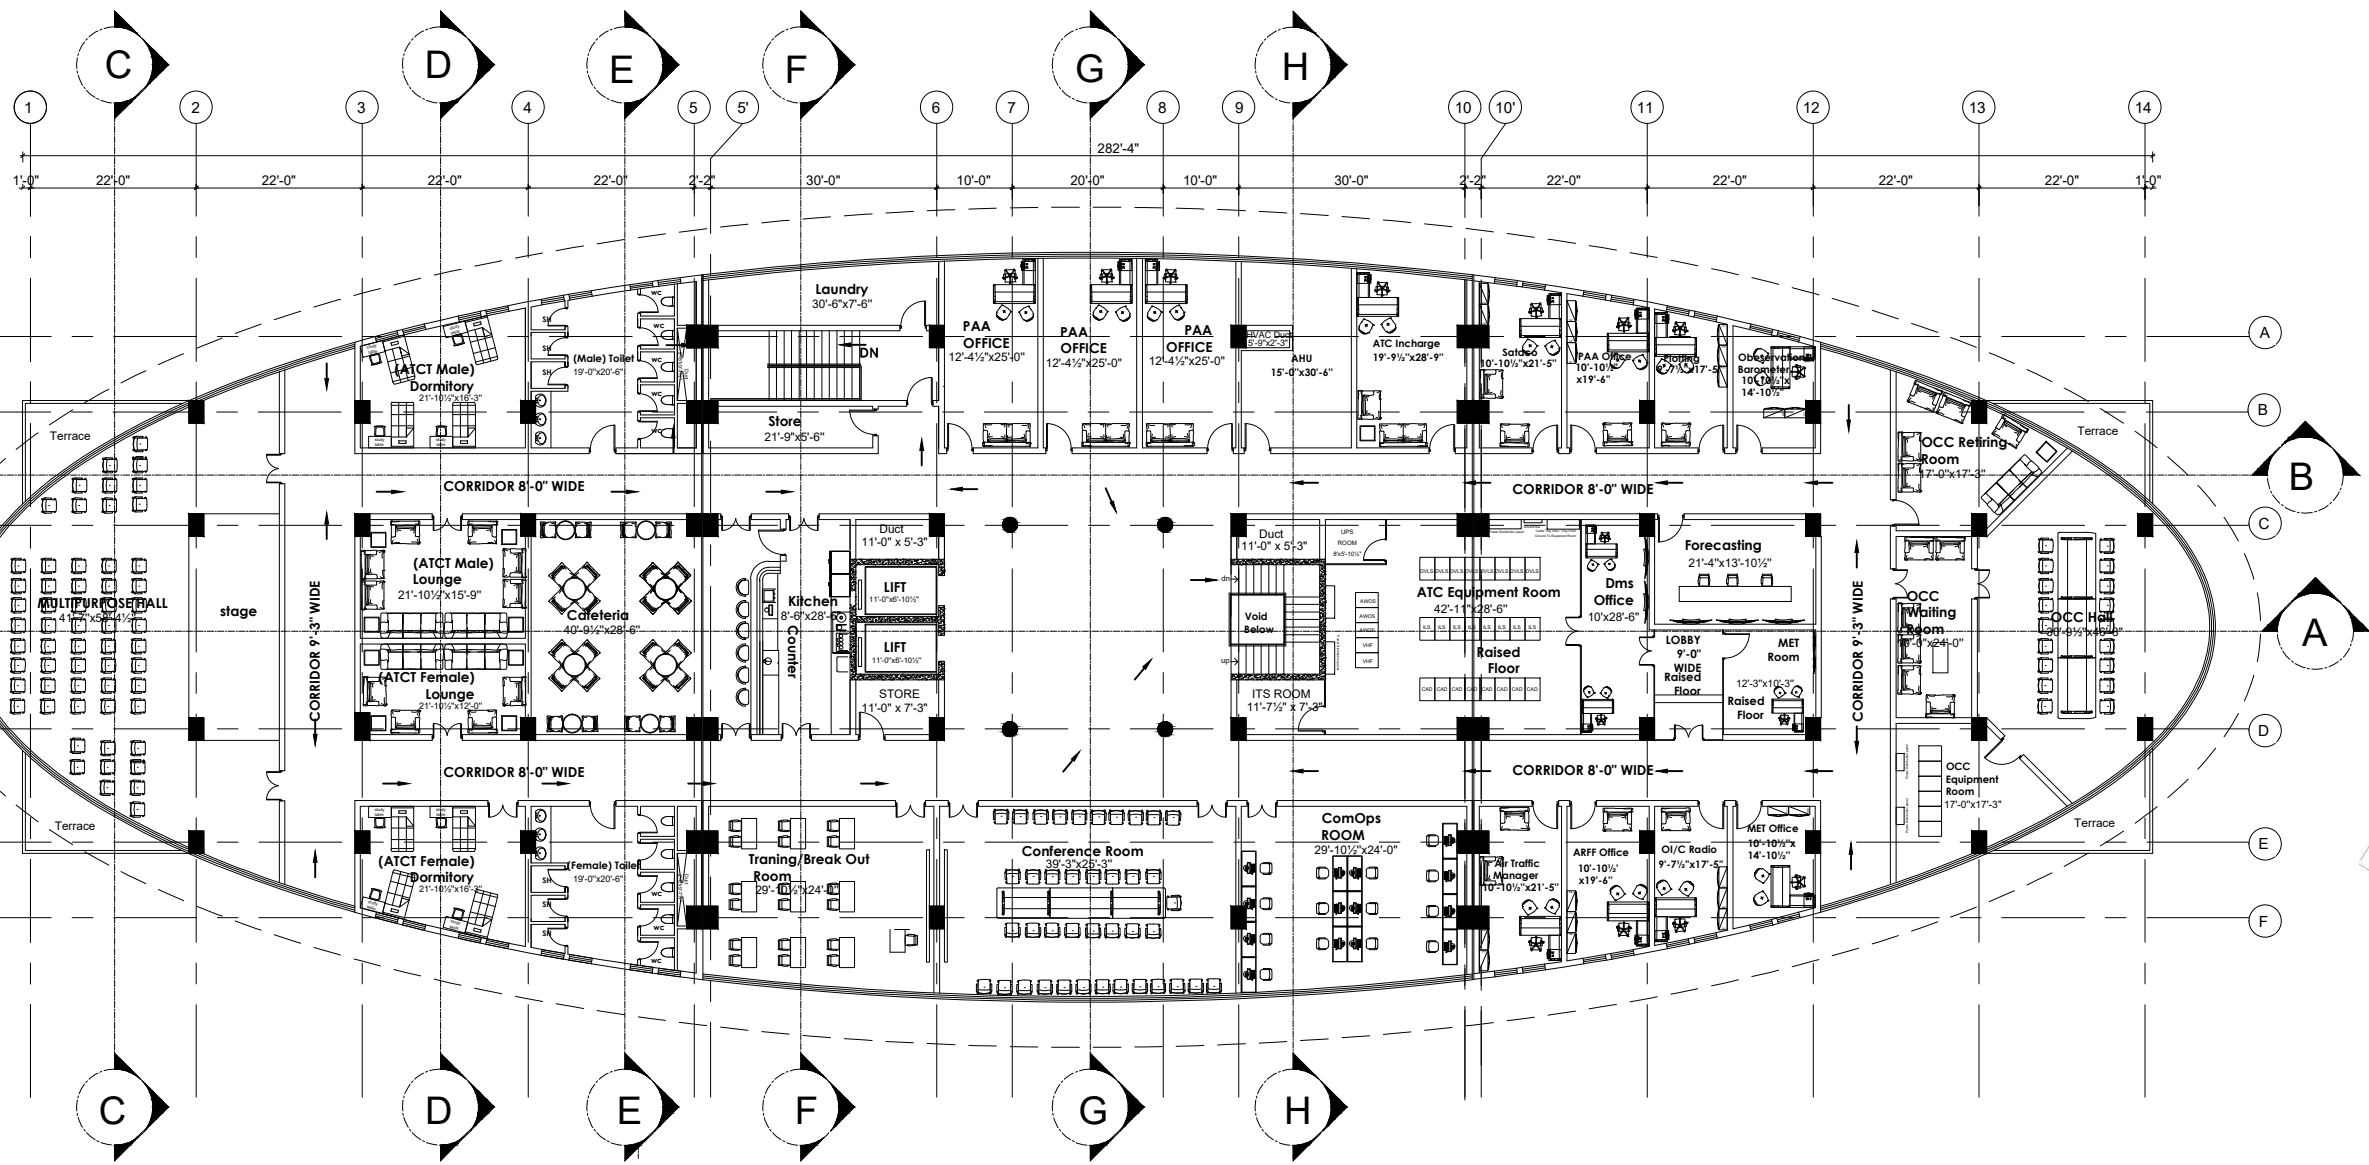

FIRST FLOOR PLAN
Covered Area = 27439 Sft

ISSUE FOR TENDER

NOTES:
These drawings are confidential and is the exclusive property of AAA (Pvt)Ltd. And is loaned subject to the condition that it is not to be reproduced to furnish for the making of drawing or prints except as sanctioned in writing by AAA (Pvt)Ltd.

CLIENT NAME



پاکستان ایئر پورٹس اتھارٹی

MAIN CONSULTANT



Anwar Ali Architects (Pvt.) Ltd.
Formerly Anwar Ali & Associates Since March 2006 to June 2018
Consulting Architects, Engineers, Planners & Management Consultants

JV MEMBERS




COMRADES CONSULTANTS



leit-werk

STRUCTURAL CONSULTANT

NORTH ORIENTATION

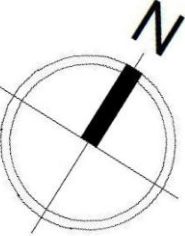

Project Name


Consultancy Services for
New Air Traffic
Control Tower (ATCT),
Fire Station and Allied
Facilities at Skardu
International Airport

Detailed Architectural
Design Drawings

Sheet Name


FIRST FLOOR
FIRE EXIT PLAN


Date	12 January, 2026
Scale	NTS
Drawn by	Asad
Checked by	Ar. Ahmed Ali
Approved by	Ar. Anwar Ali
Drawing No.	AW-51 @A3

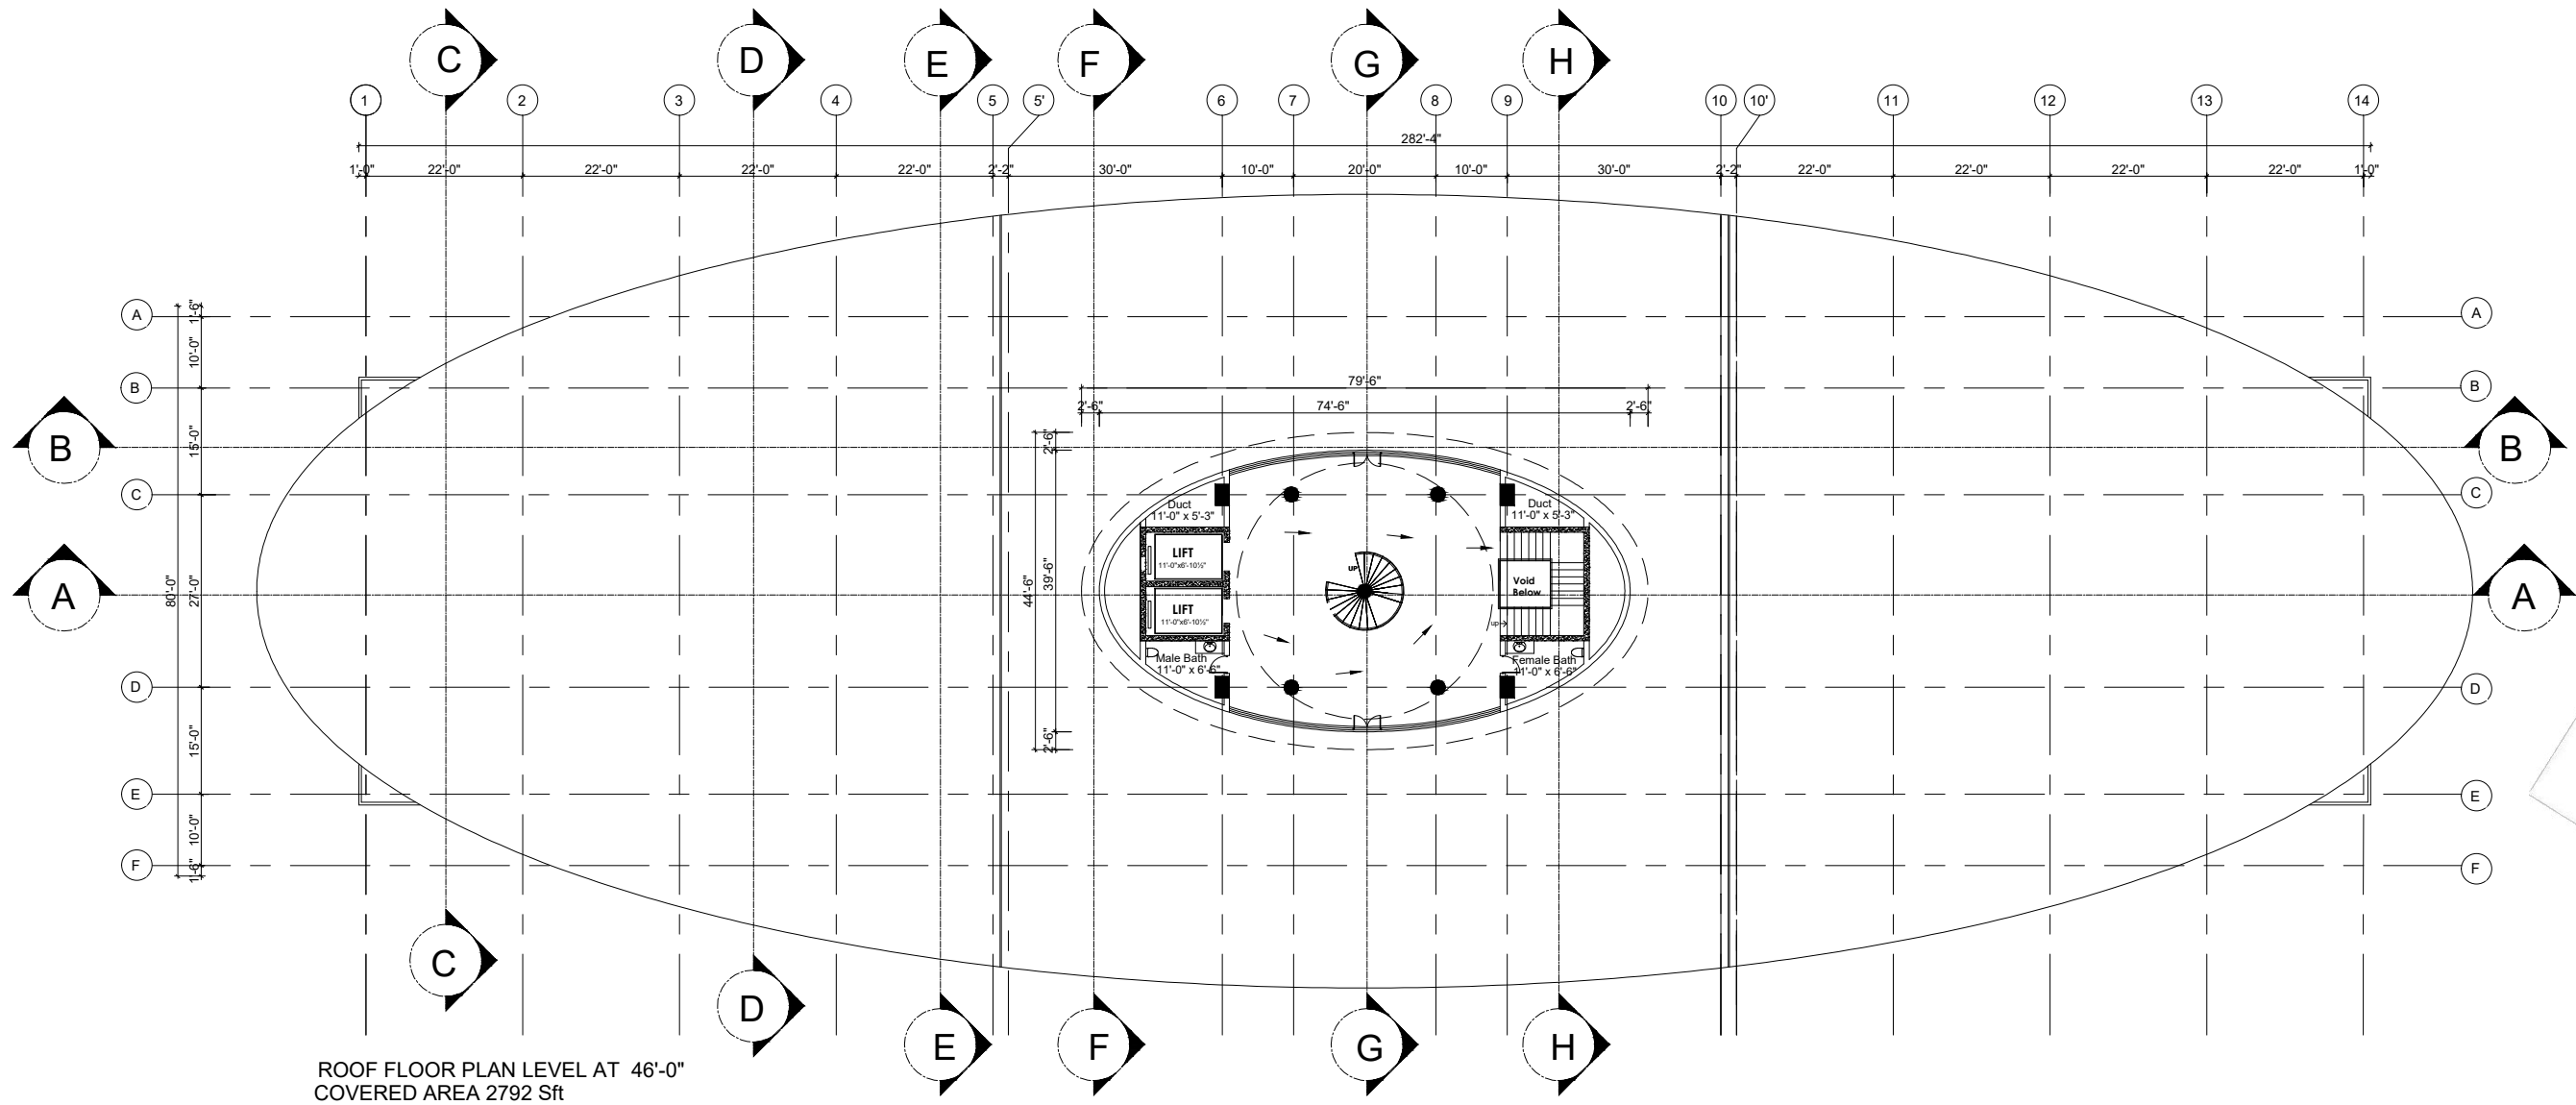

ROOF FLOOR PLAN LEVEL AT 46'-0"
COVERED AREA 2792 Sft

ISSUE FOR TENDER

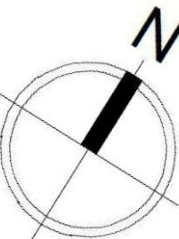NOTES: These drawings are confidential and is the exclusive property of AAA (Pvt)Ltd. And is loaned subject to the condition that it is not to be reproduced to furnish for the making of drawing or prints except as sanctioned in writing by AAA (Pvt)Ltd.	
CLIENT NAME	
	
MAIN CONSULTANT	
	
JV MEMBERS	
	
	
STRUCTURAL CONSULTANT	
NORTH ORIENTATION	
	
Project Name	
Consultancy Services for New Air Traffic Control Tower (ATCT), Fire Station and Allied Facilities at Skardu International Airport	
Detailed Architectural Design Drawings	
Sheet Name	
ROOF FLOOR LEVEL AT 46'-0" FIRE EXIT PLAN	
Date	12 January, 2026
Scale	NTS
Drawn by	Asad
Checked by	Ar. Ahmed Ali
Approved by	Ar. Anwar Ali
Drawing No.	AW-52 @A3

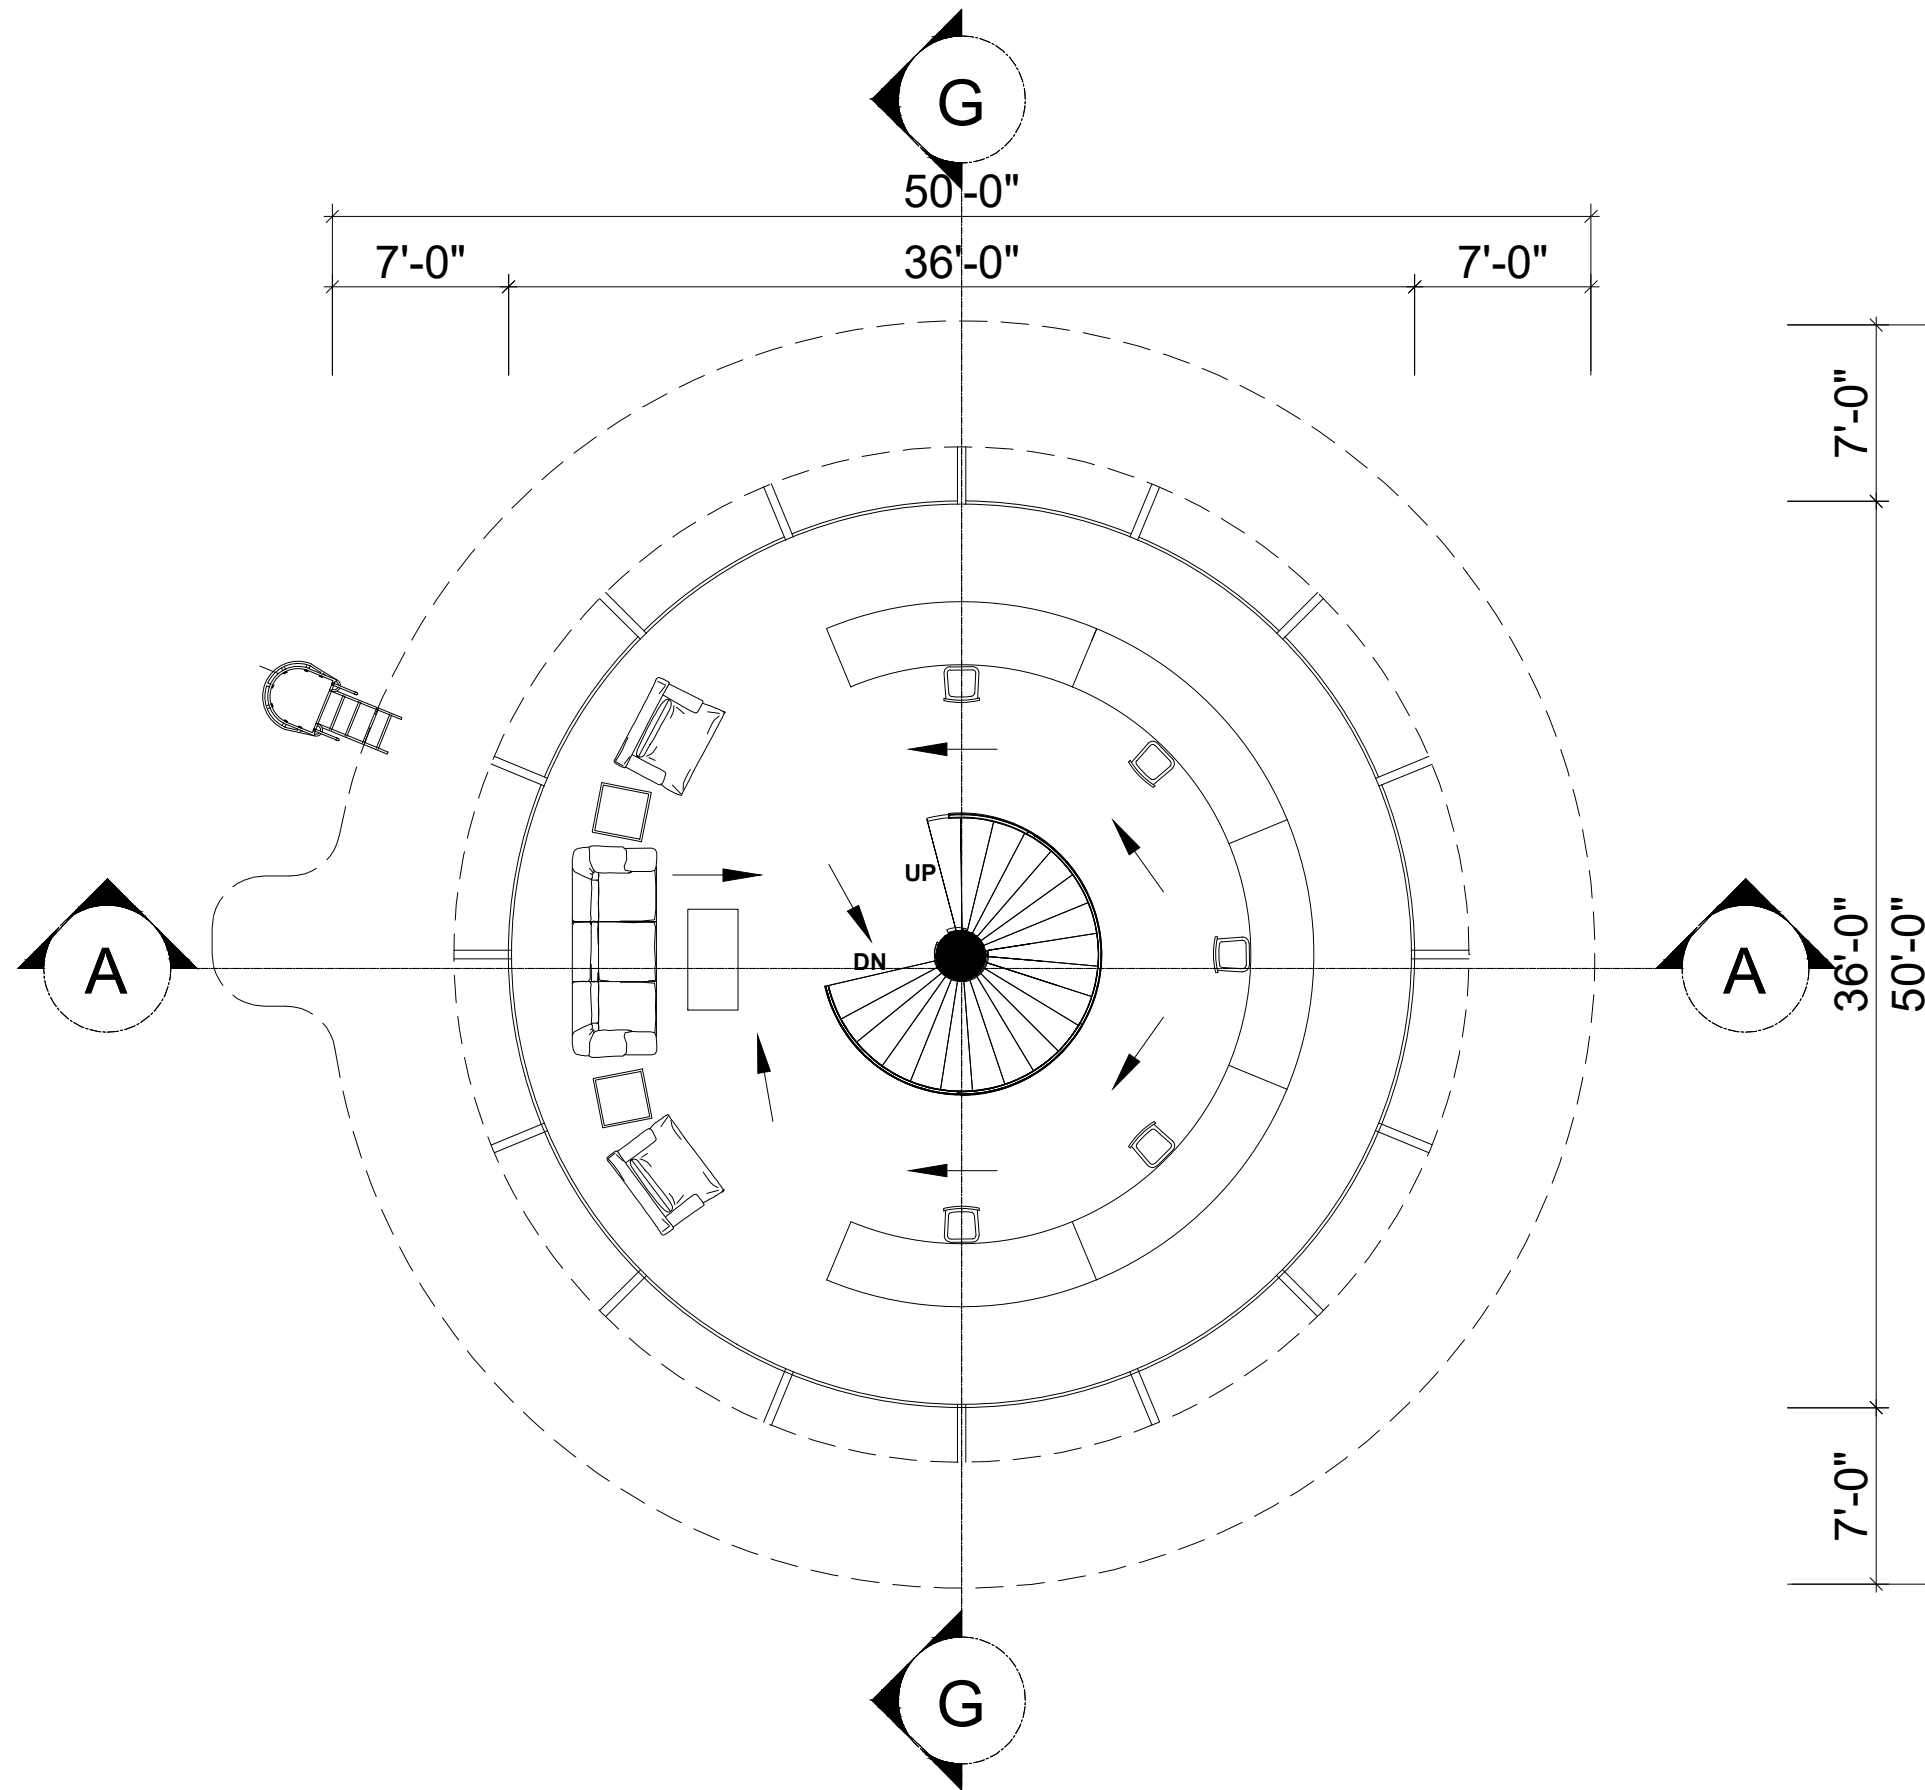

ARFF FLOOR PLAN LEVEL AT 56'-0"
COVERED AREA 1277 Sft

ISSUE FOR TENDER

NOTES:

These drawings are confidential and is the exclusive property of AAA (Pvt)Ltd. And is loaned subject to the condition that it is not to be reproduced to furnish for the making of drawing or prints except as sanctioned in writing by AAA (Pvt)Ltd.

CLIENT NAME



MAIN CONSULTANT




JV MEMBERS



leit-werk

STRUCTURAL CONSULTANT

NORTH ORIENTATION

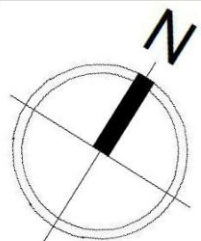

Project Name


Consultancy Services for
New Air Traffic
Control Tower (ATCT),
Fire Station and Allied
Facilities at Skardu
International Airport

Detailed Architectural Design Drawings

Sheet Name


ARFF FLOOR LEVEL AT 56'-0"
FIRE EXIT PLAN

Date	12 January, 2026
Scale	NTS
Drawn by	Asad
Checked by	Ar. Ahmed Ali
Approved by	Ar. Anwar Ali
Drawing No.	AW-53 @A3

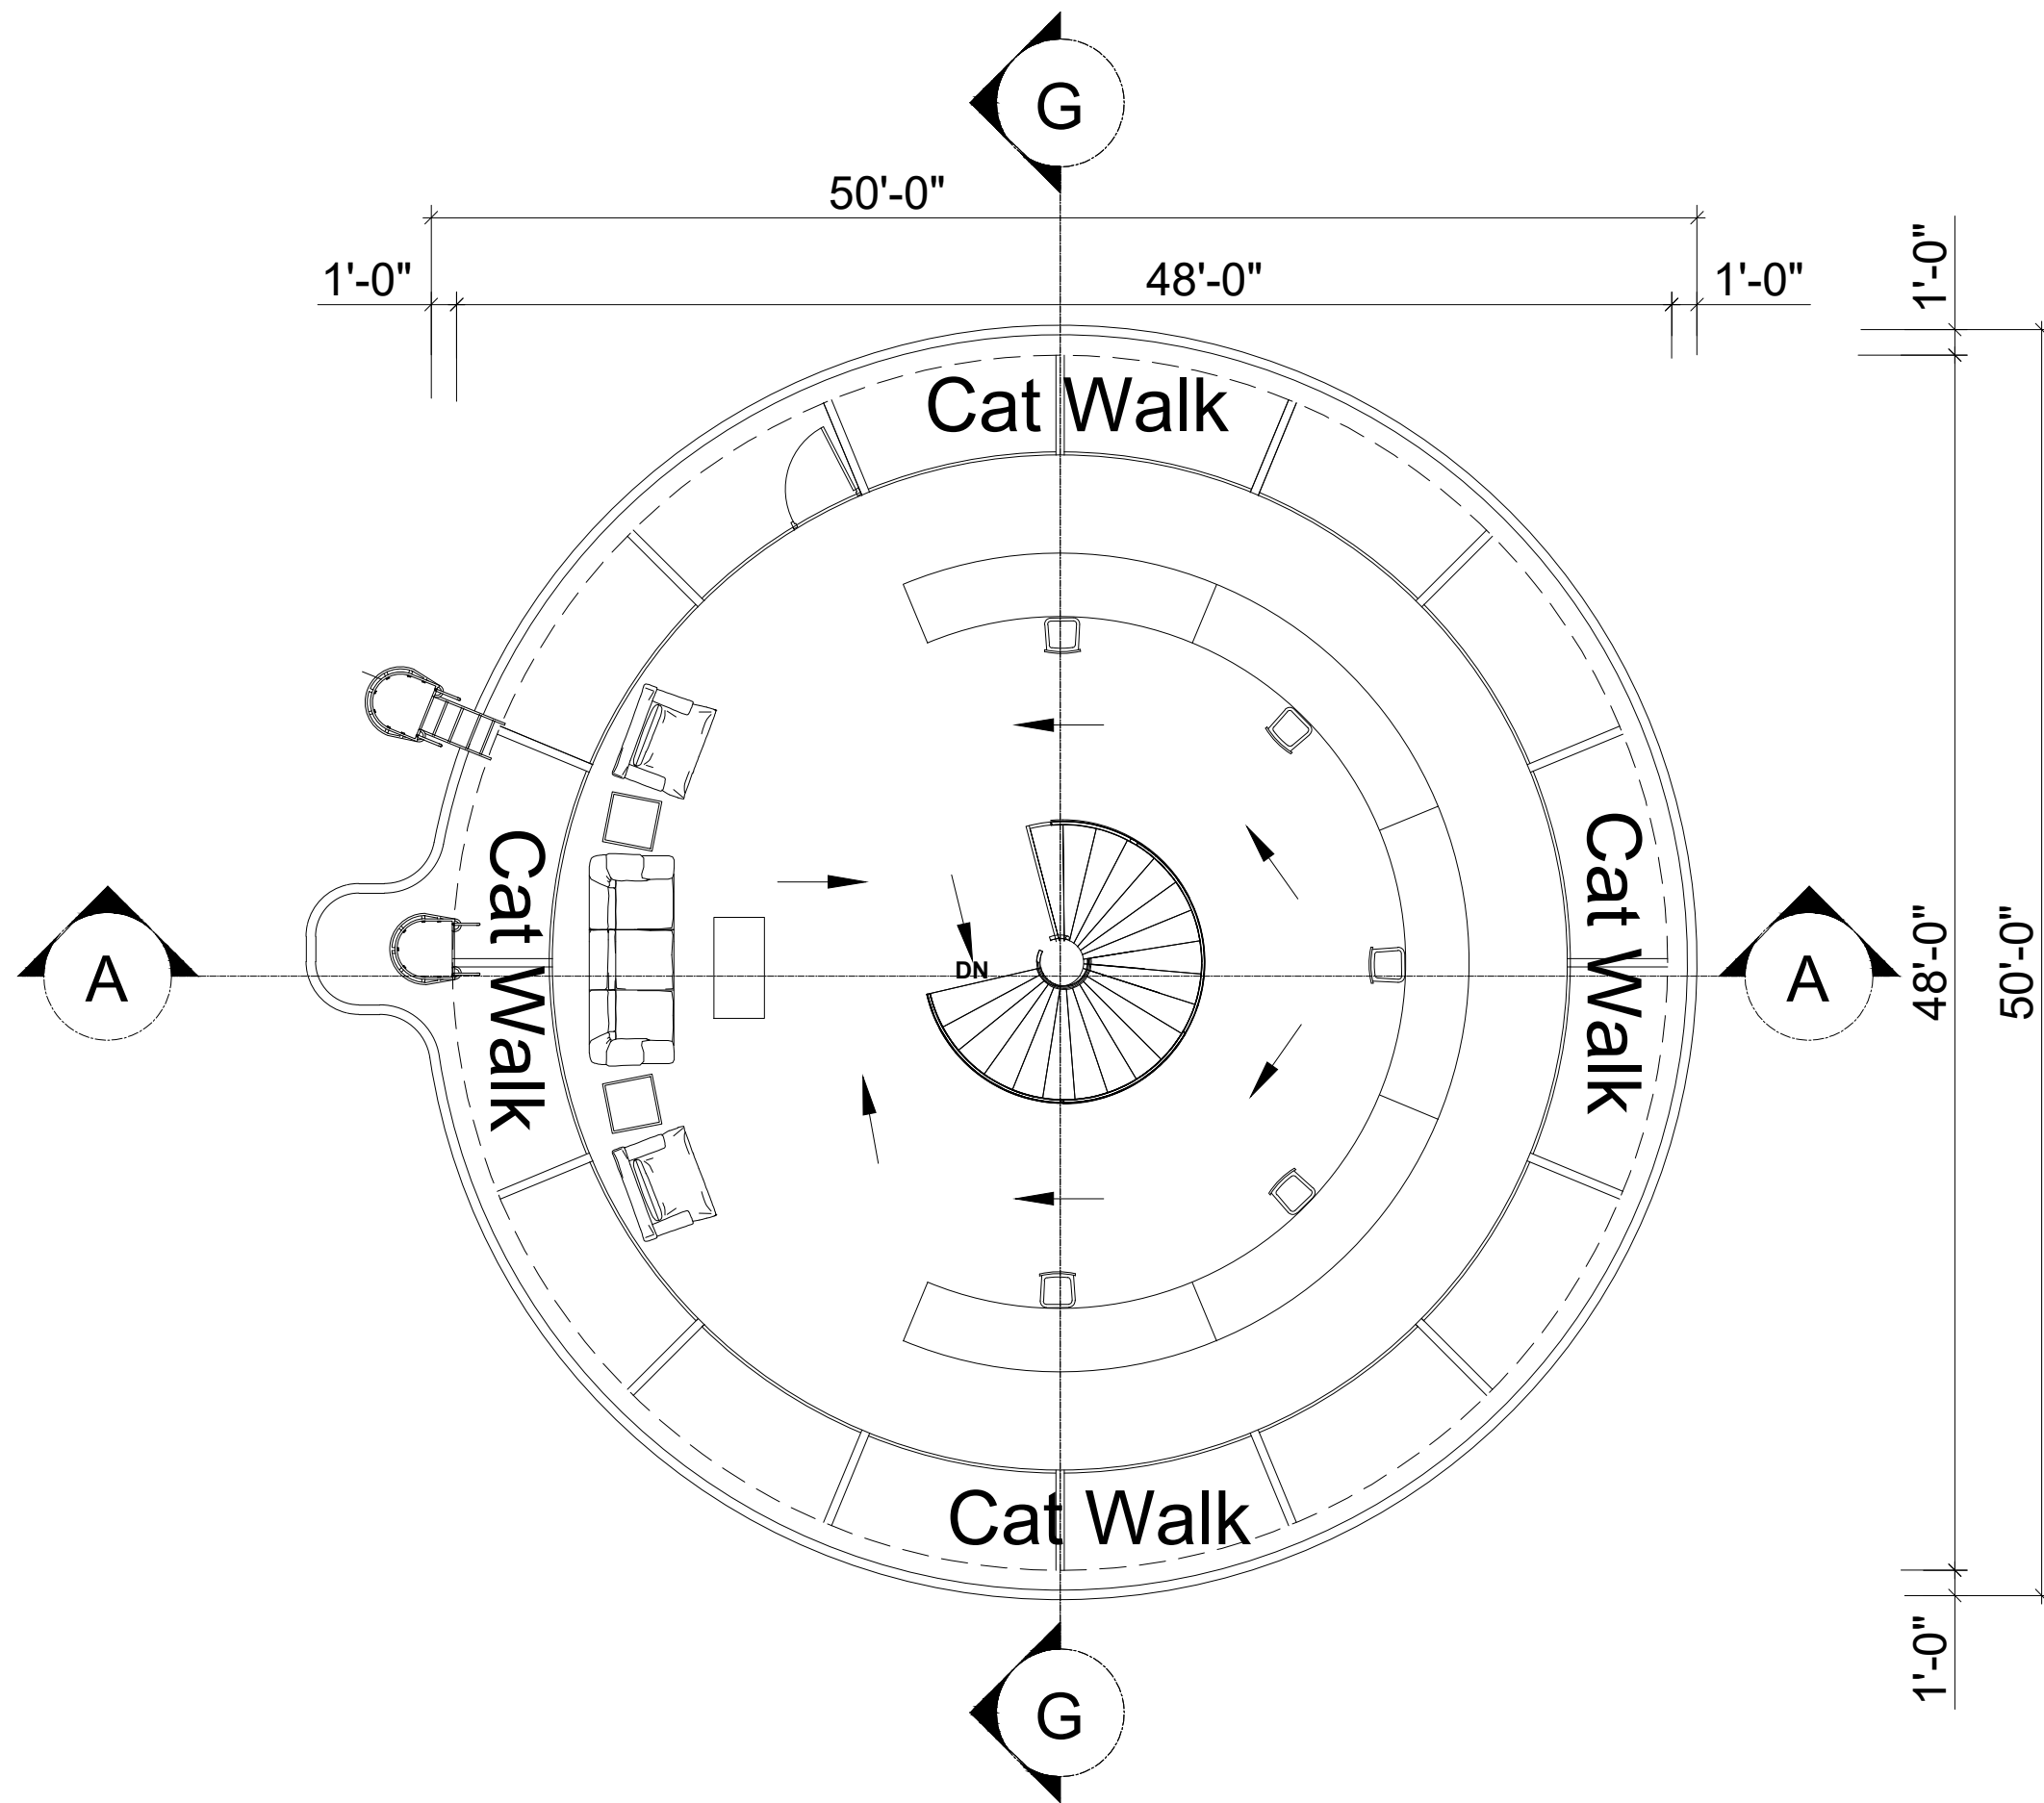

ATCT FLOOR PLAN LEVEL AT 68'-0"
COVERED AREA 1809 Sft

ISSUE FOR TENDER

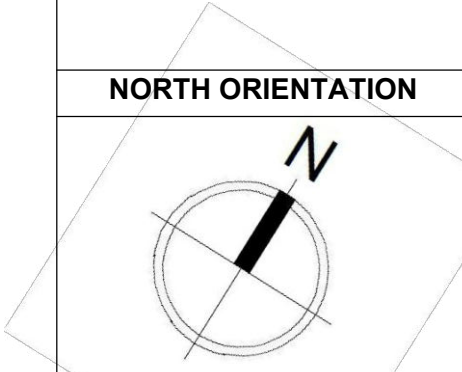NOTES: These drawings are confidential and is the exclusive property of AAA (Pvt)Ltd. And is loaned subject to the condition that it is not to be reproduced to furnish for the making of drawing or prints except as sanctioned in writing by AAA (Pvt)Ltd.	
CLIENT NAME	
 پاکستان ایئر پورٹس اتھارٹی	
MAIN CONSULTANT	
 Formerly Anwar Ali & Associates Since March 2006 to June 2018 Consulting Architects, Engineers, Planners & Management Consultants	
JV MEMBERS	
 leit-werk	
STRUCTURAL CONSULTANT	
NORTH ORIENTATION	
	
Project Name	
Consultancy Services for New Air Traffic Control Tower (ATCT), Fire Station and Allied Facilities at Skardu International Airport	
Detailed Architectural Design Drawings	
Sheet Name	
ATCT FLOOR LEVEL AT 68'-0" FIRE EXIT PLAN	
Date	12 January, 2026
Scale	NTS
Drawn by	Asad
Checked by	Ar. Ahmed Ali
Approved by	Ar. Anwar Ali
Drawing No.	AW-54 @A3