

STATE LIFE BUILDING NO.11

FIRE PROTECTION SYSTEM DRAWINGS

TENDER DRAWING

CLIENT:



CONSULTANT:



 
 
 
 
 
FIRE FIGHTING GENERAL NOTES:—

1. ALL DIMENSIONS ON DRAWINGS ARE IN FEET & INCHES UNLESS OTHERWISE NOTED.
2. SWAY BRACING ON FIRE SPRINKLER SYSTEM PIPING SHALL ALSO BE PROVIDED IN ACCORDANCE WITH LATEST EDITION OF NFPA–13. HOWEVER IN ANY CASE THE MAXIMUM SPACING BETWEEN TWO LATERAL SHALL BE 12.2M (40FT) AND THE MAXIMUM SPACING BETWEEN TWO LONGITUDINAL BRACES SHALL BE BRACES 24.4M (80FT).
3. THE CONTRACTOR SHALL COMPLY WITH THE CURRENT NFPA STANDARDS (*OR RELEVANT B.S) WITH RESPECT TO ANY MATERIALS OR WORK NOT SPECIFIED IN DETAIL IN THE CONSULTANT’S SPECIFICATIONS OR DRAWINGS.
4. MISCELLANEOUS DETAILS GIVEN IN TENDER DRAWINGS SHALL BE STRICTLY FOLLOWED FOR RELEVANT APPLICATION. INDICATION OF DETAIL DRAWING REFERENCE NUMBER ON OTHER DRAWINGS IS NOT ESSENTIAL.
5. MAKING ALL OPENINGS IN PRE–ENGINEERED BUILDING, MASONRY AND CONCRETE SHALL BE THE RESPONSIBILITY OF THE MECHANICAL CONTRACTOR. ALSO PROVIDING SLEEVES AND DRAWINGS FOR EXACT LOCATION SHALL BE THE RESPONSIBILITY OF THE CONTRACTOR.
6. THE DESIGN, CONSTRUCTION AND TESTING OF THE FIRE PROTECTION SYSTEM ARE IN ACCORDANCE WITH ALL THE LATEST RELEVANT CODES/STANDARDS OF THE NATIONAL FIRE PROTECTION ASSOCIATION (NFPA), INCLUDING BUT NOT LIMITED TO;

a) NFPA 13 (or 13R) & 14 : FOR FIRE FIGHTING SYSTEM

b) NFPA 20 & 22 : FOR CENTRIFUGAL FIRE PUMPS

c) NFPA 14 & 10 : FOR FIRE HOSE CABINET & FIRE EXTINGUISHER
7. (UNLESS OTHERWISE DETAILED) THE CONTRACTOR SHALL SUBMIT BEFORE CONSTRUCTION, COMPLETE WORK SHOP DRAWINGS (PLANS & SECTIONS ... ETC.) SHOWINGS ALL NECESSARY OPENINGS IN CONCRETE STRUCTURES (TO ACCOMMODATE THE MECHANICAL, ELECTRICAL, SANITARY, FIRE SAFETY & OTHER EQUIREMENTS) FOR THE ENGINEER’S APPROVAL.
8. THE FIRE PROTECTION SYSTEM DRAWINGS SHALL BE READ IN CONJUNCTION WITH THE CORRESPONDING ARCHITECTURAL, MECHANICAL, ELECTRICAL, SANITARY AND STRUCTURAL DRAWINGS. ANY DISCREPANCY SHALL BE BROUGHT TO THE CONSULTANT ENGINEER’S ATTENTION PRIOR TO CONSTRUCTION.
9. ALL EQUIPMENT AND DEVICES SHALL BE UL/ FM APPROVED
10. ALL SUPPORTS FOR PIPING SHALL BE FULLY HOT DIPPED GALVANISED.
11. ALL RISER TO HAVE DRAIN OUT CONNECTIONS AT LOW POINTS ALL PIPING AT LOWEST LEVELS TO BE PITCHED TOWARDS RISER.
12. SLEEVES FOR DRAINAGE PIPES ...ETC. OPENINGS TO BE PLACED BEFORE CASTING CONCRETE. THESE SLEEVES TO FIT THE PIPES SIZES WITH SUITABLE TOLERANCE.
13. ALL SUPERVISORY SWITCHES, PRESSURE SWITCHES, ZONE CONTROL VALVE ASSEMBLIES ARE OF THE ADDRESSABLE TYPE LINKED TO THE MAIN FIRE ALARM CONTROL PANEL (FACP).
14. FIRE PROTECTION SYSTEM & PIPING SHALL BE INSTALLED IN ACCORDANCE WITH LATEST EDITION OF NFPA–1
15. FIRE PROTECTION SYSTEM IS BASED ON CLASS–II HOSE PIPE AND STAND SYSTEM AS PER NFPA 14.
16. BURIED PIPING SHALL BE uPVC CLASS D SOLVENT CEMENT JOINT.
17. ABOVE GROUND PIPING SHALL BE BLACK STEEL SCHEDULE–40.
18. ALL BLACK STEEL PIPING OF DIAMETER ≤ 2 INCH SHALL BE THREADED.
19. DATA OF ELECTRICAL RATING EQUIPMENT IS INDICATIVE ONLY AND ALL ELECTRICAL WORK, VARIABLE FREQUENCY DRIVES AND MCC’s SHALL MEET THE REQUIREMENTS OF FINALLY SELECTED EQUIPMENT AS PER SPECIFICATIONS.
20. ALL DIMENSIONS ON DRAWINGS ARE IN MILLI–METER (mm) UNLESS OTHERWISE NOTED.

PLAN LEGEND	
SYMBOL	DESCRIPTION
	IDENTIFICATION NUMBER, SCHEDULED OR DETAILED
	FIRE WATER PIPE
	FLUE DUCT
	OS & Y VALVE
	BATTERY SET
	PUMP CONTROLLER
	PRESSURE RELIEF VALVE
	CHECK VALVE
	WASTE CONE WITH SIGHT GLASS
	FLOW METER
	SUCTION GAUGE
	BALL VALVE
	GATE VALVE
	SILENCER
	DIESEL ENGINE OPERATED PUMP
	ELECTRIC MOTOR OPERATED PUMP
	ELECTRIC MOTOR OPERATED JOCKEY PUMP
	PENDENT CONCEALED SPRINKLER
	UPRIGHT SPRINKLER
	REDUCER
	ZONE CONTROL VALVE
	FIRE BRIGADE CONNECTION
	FIRE HOSE REEL
	LANDING VALVE
	CO2 EXTINGUISHER
	DRY CHEMICAL EXTINGUISHER
	AUTOMATIC CO2 EXTINGUISHER TANK
	DOYMA SLEEVE
	STRAINER
	FIRE HOSE CABINET
	FIRE HYDRANT (WALL MOUNTED)

LIST OF DRAWINGS

S. NO.	DWG. NO.	DRAWING TITLE	SCALE
01	FP–00	TITLE SHEET	N.T.S
02	FP–01	LIST OF DRAWING, NOTES & LEGENDS	N.T.S
03	FP–02	STANDARD DETAILS	N.T.S
04	FP–03	SCHEMATIC DIAGRAM AT FIRE PROTECTION SYSTEM	N.T.S
05	FP–04	FIRE PROTECTION SYSTEM AT LOWER BASEMENT	1/8” = 1’–0”
06	FP–05	FIRE PROTECTION SYSTEM AT UPPER BASMEENT	1/8” = 1’–0”
07	FP–06	FIRE PROTECTION SYSTEM AT GROUND FLOOR	1/8” = 1’–0”
08	FP–07	FIRE PROTECTION SYSTEM AT MEZZANINE FLOOR	1/8” = 1’–0”
09	FP–08	FIRE PROTECTION SYSTEM AT 2ND FLOOR	1/8” = 1’–0”
10	FP–09	FIRE PROTECTION SYSTEM AT 3RD FLOOR	1/8” = 1’–0”
11	FP–10	FIRE PROTECTION SYSTEM AT 4TH FLOOR	1/8” = 1’–0”
12	FP–11	FIRE PROTECTION SYSTEM AT 5TH FLOOR	1/8” = 1’–0”
13	FP–12	FIRE PROTECTION SYSTEM AT 6TH FLOOR	1/8” = 1’–0”
14	FP–13	FIRE PROTECTION SYSTEM AT 7TH FLOOR	1/8” = 1’–0”
15	FP–14	FIRE PROTECTION SYSTEM AT 8TH FLOOR	1/8” = 1’–0”
16	FP–15	FIRE PROTECTION SYSTEM AT 9TH FLOOR	1/8” = 1’–0”
17	FP–16	FIRE PROTECTION SYSTEM AT 10TH FLOOR	1/8” = 1’–0”
18	FP–17	FIRE PROTECTION SYSTEM AT 11TH FLOOR	1/8” = 1’–0”
19	FP–18	FIRE PROTECTION SYSTEM AT 12TH FLOOR	1/8” = 1’–0”
20	FP–19	FIRE PROTECTION SYSTEM AT 13TH FLOOR	1/8” = 1’–0”

CLIENT:-



CONSULTANT:



Nexus Consulting
Office A-202, Second Floor,Blossom Trade Center Opposite NED University
University Road, SB-26,Block No.01 Gulistan-e-Jouhar, Karachi Pakistan
Phone:021-37240670
Email:nexusconsultingcompany@gmail.com Web:www.Nexuscon.pk


PROJECT:-

STATE LIFE BUILDING NO.11


TITLE:-

LIST OF DRAWING,
NOTES & LEGENDS


REV #	DATE	DESCRIPTION	CHK'D	APP'D	Project Ref:	DATE
00	02-07-2026	ISSUED FOR TENDER			.	JUNE.2026
					DRAWN BY A-A	SCALE 1/8" = 1'-0"
					CHECKED BY W-S	DWG. NO. FP-01

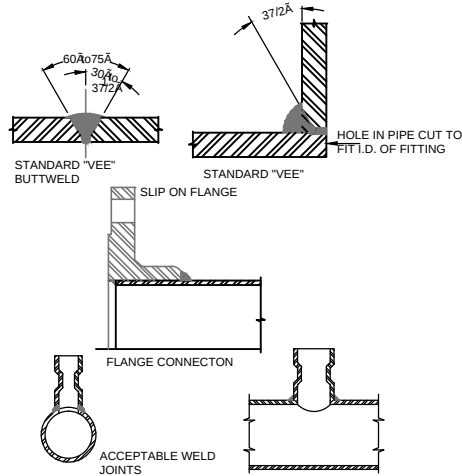


ACCEPTABLE WELD JOINTS

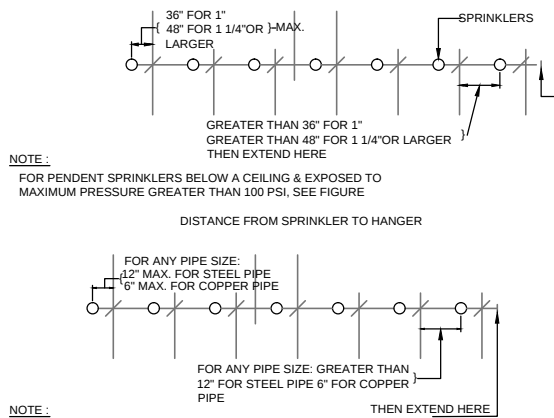


DISTANCE FROM SPRINKLER TO HANGER

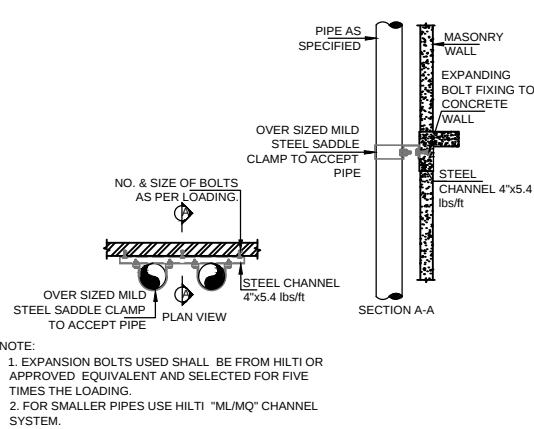


TYPICAL SUPPORT FOR VERTICAL PIPING RISER FOR PIPES

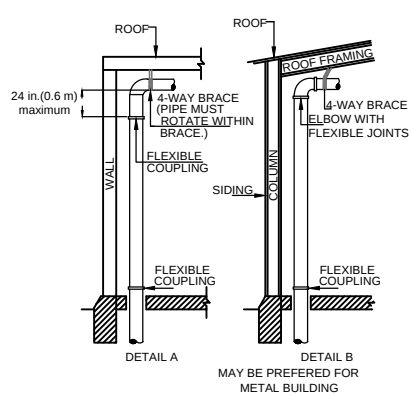


RISER DETAIL

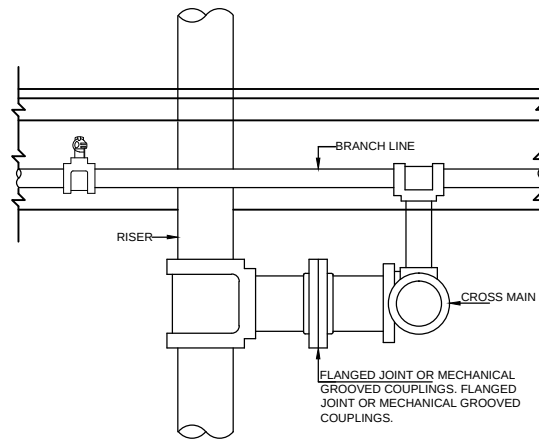


ARRANGEMENT OF FLANGED JOINT AT SPRINKLER RISER

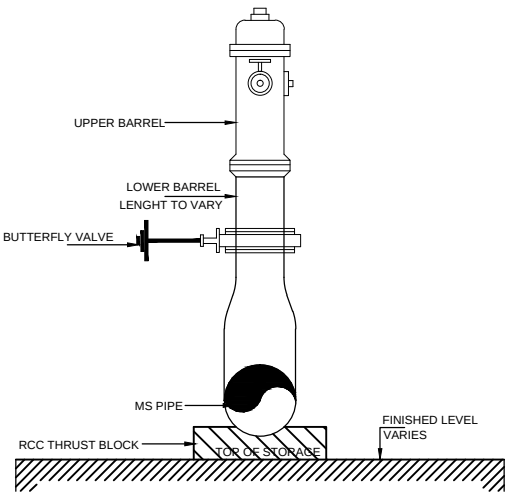


TYPICAL PILLAR HYDRANT DETAIL (FOR MAIN PIPE ABOVE FLOOR)

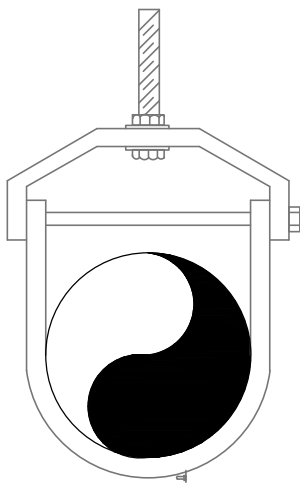


CLEVIS HANGER

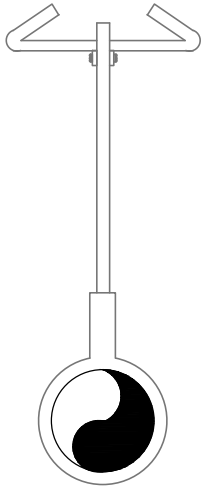

ADJUSTABLE COACH SCREW CLIP FOR BRANCH LINE

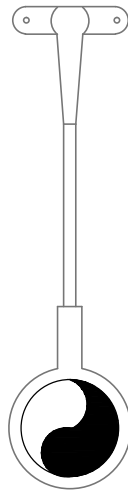

ADJUSTABLE CLIP FOR BRANCH LINES

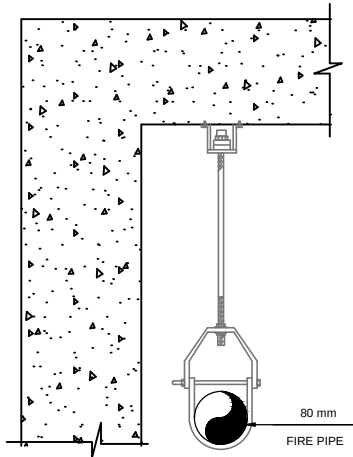

CLEVIS SUPPORT FOR PIPES RUNNING ALONG CEILING OF MEZZANINE /FIRST FLOOR

CLIENT:-



CONSULTANT:




PROJECT:-

STATE LIFE BUILDING NO.11

TITLE:-

STANDARD DETAILS

REV #	DATE	DESCRIPTION	CHKD	APPD	Project Ref:	DATE
00	02-07-2026	ISSUED FOR TENDER				JUNE.2026
					DRAWN BY A-A	SCALE 1/8" = 1'-0"
					CHECKED BY W-S	DWG. NO. FP-02A

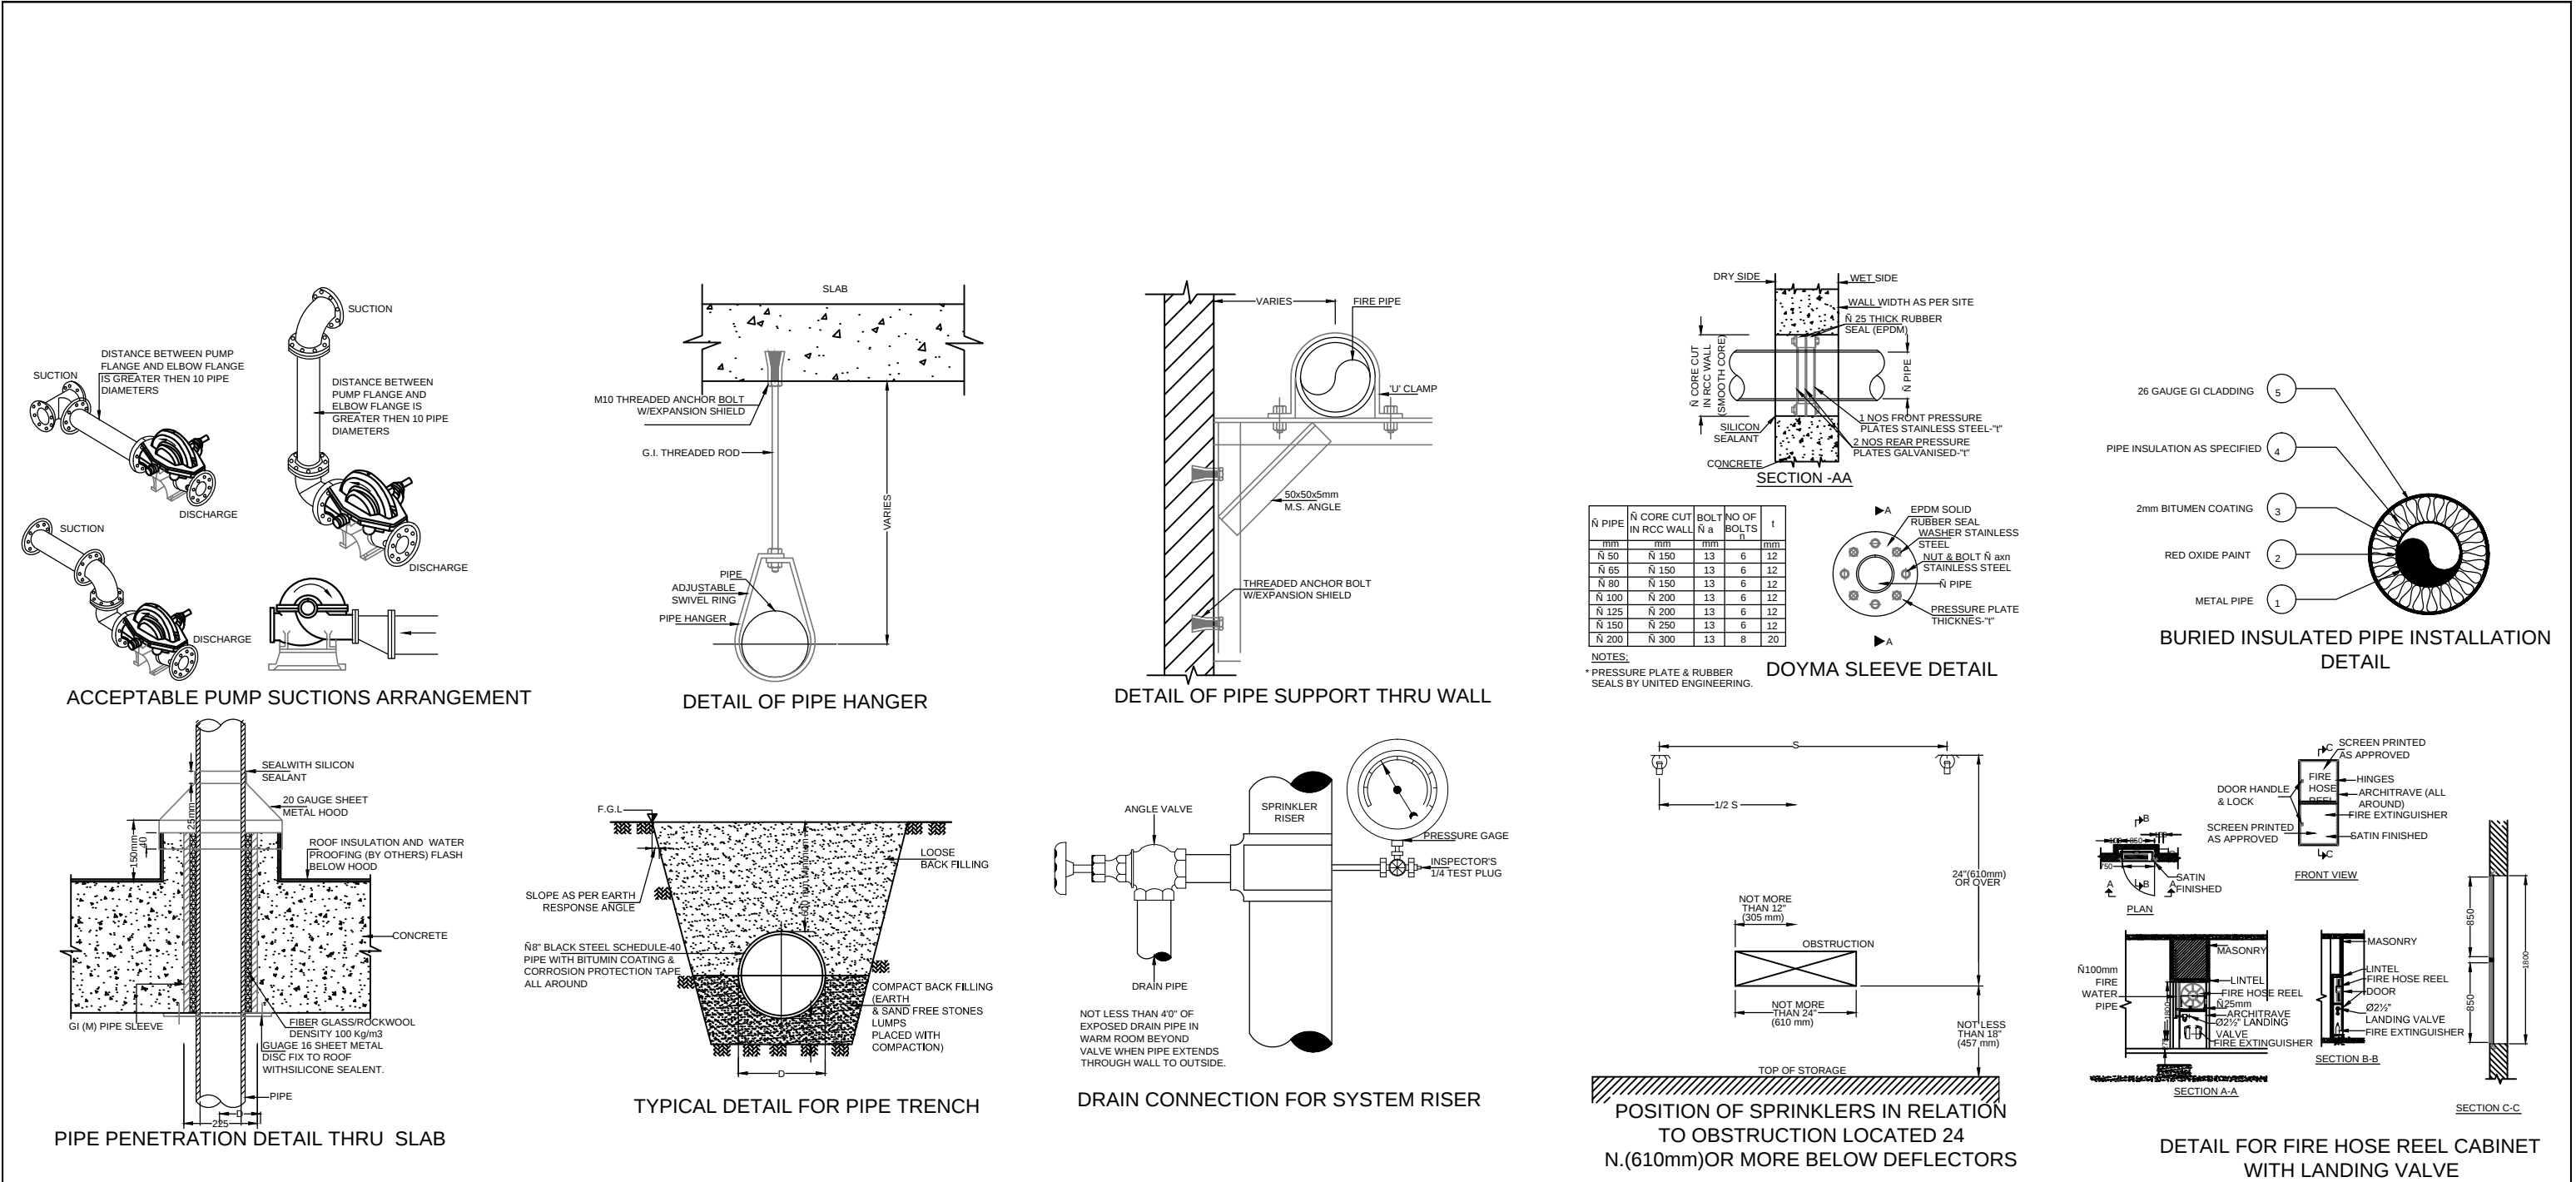

CLIENT:-



CONSULTANT:



PROJECT:-

STATE LIFE BUILDING NO.11


TITLE:-

STANDARD DETAILS


REV #	DATE	DESCRIPTION	CHK'D	APP'D	Project Ref:	DATE
00	02-07-2026	ISSUED FOR TENDER				JUNE.2026
					DRAWN BY A-A	SCALE 1/8" = 1'-0"
					CHECKED BY W-S	DWG. NO. FP-02B

POSITION OF DEFLECTOR WHEN LOCATED ABOVE BOTTOM OF BEAM	
DISTANCE FROM SPRINKLER TO SIDE OF BEAM	MAXIMUM ALLOWABLE DISTANCE DEFLECTOR ABOVE BOTTOM OF BEAM
LESS THAN 1 FT	0 IN.
1 FT TO LESS THAN 2 FT	1 IN.
2 FT TO LESS THAN 2 FT 6 IN.	2 IN.
2 FT 6 IN. TO LESS THAN 3 FT	3 IN.
3 FT TO LESS THAN 3 FT 6 IN.	4 IN.
3 FT 6 IN. TO LESS THAN 4 FT	6 IN.
4 FT TO LESS THAN 4 FT 6 IN.	7 IN.
4 FT 6 IN. TO LESS THAN 5 FT	9 IN.
5 FT TO LESS THAN 5 FT 6 IN.	11 IN.
5 FT 6 IN. TO LESS THAN 6 FT	14 IN.


For SI Units: 1 in. = 25.4 mm; 1 ft = 0.3048 m.

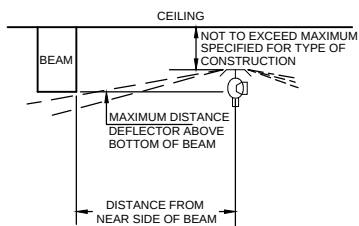

POSITION OF DEFLECTOR; UPRIGHT, OR PENDENT SPRINKLER WHEN LOCATED BELOW CEILING

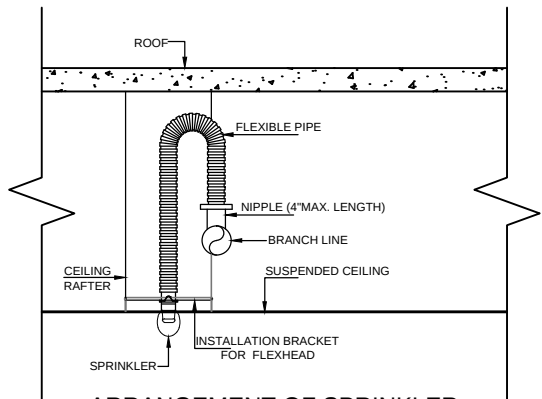


ARRANGEMENT OF SPRINKLER IN BELOW CEILING (PENDENT TYPE)

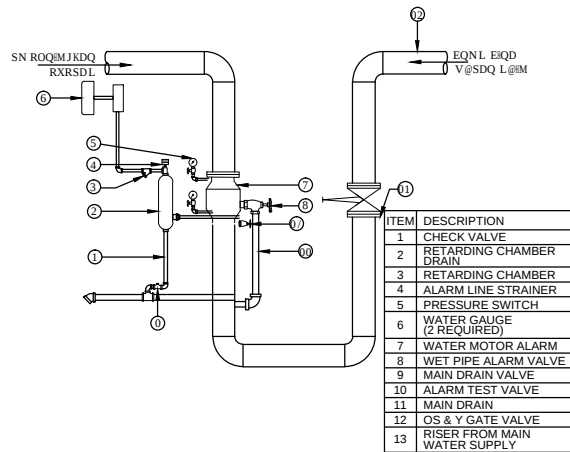


ALARM CHECK VALVE ASSEMBLY


POSITION OF SPRINKLERS IN RELATION TO OBSTRUCTIONS LOCATED ENTIRELY BELOW THE SPRINKLERS	
DISTANCE OF DEFLECTOR ABOVE BOTTOM OF OBSTRUCTION	MINIMUM DISTANCE FROM NEAR SIDE OF OBSTRUCTION
LESS THAN 6 IN.	2
6 IN TO LESS THAN 12 IN.	3
12 IN TO LESS THAN 18 IN.	4
18 IN TO LESS THAN 24 IN.	5

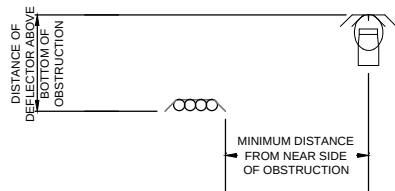


POSITION OF SPRINKLERS IN RELATION TO OBSTRUCTIONS LOCATED ENTIRELY BELOW THE SPRINKLERS

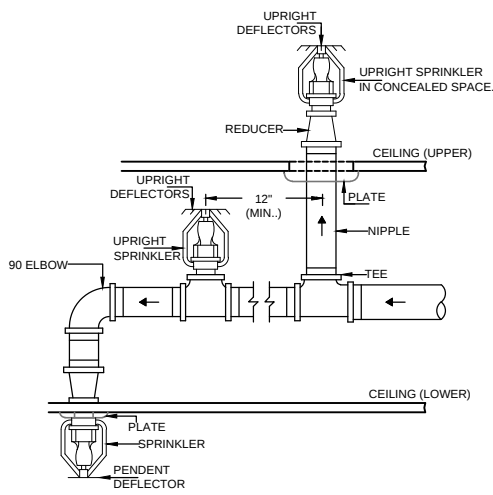


ARRANGEMENT OF BRANCH LINES SUPPLYING SPRINKLERS ABOVE & BELOW CEILING

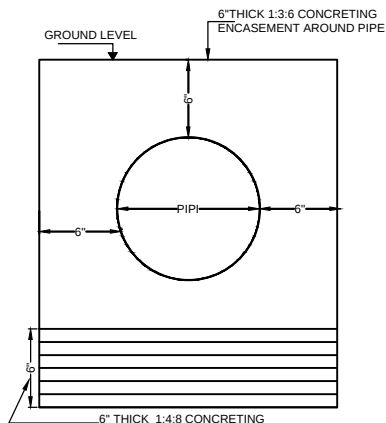

BURIED PIPE DETAIL

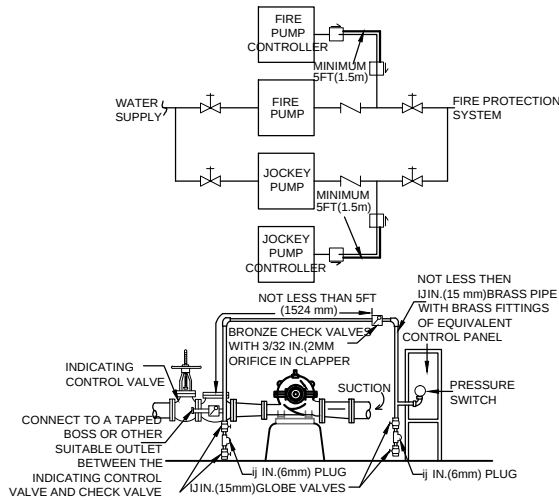


PIPING CONNECTION FOR AUTOMATIC PRESSURE SWITCH (PRESSURE SENSING LINE) OF FIRE PUMP CONTROLLER

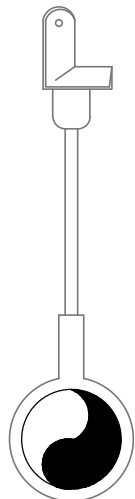


SIDE BEAM ADJUSTABLE HANGER

HORIZONTAL AND MINIMUM VERTICAL DISTANCES FOR SPRINKLERS	
HORIZONTAL DISTANCE	MINIMUM VERTICAL DISTANCE BELOW DEFLECTOR
6 IN. OR LESS	3 IN.
MORE THAN 6 IN. UP TO 9 IN.	4 IN.
MORE THAN 9 IN. UP TO 12 IN.	6 IN.
MORE THAN 12 IN. UP TO 15 IN.	8 IN.
MORE THAN 15 IN. UP TO 18 IN.	9 1/2 IN.
MORE THAN 18 IN. UP TO 24 IN.	12 1/2 IN.
MORE THAN 24 IN. UP TO 30 IN.	15 1/2 IN.
MORE THAN 30 IN.	18 IN.


For SI Units: 1 in. = 25.4 mm.

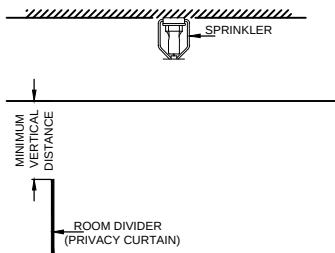


STANDARD SPRINKLER INSTALLED NEAR PRIVACY CURTAINS, FREE-STANDING PARTITIONS, OR ROOM DIVIDERS. (TO BE USED WITH TABLE ABOVE)

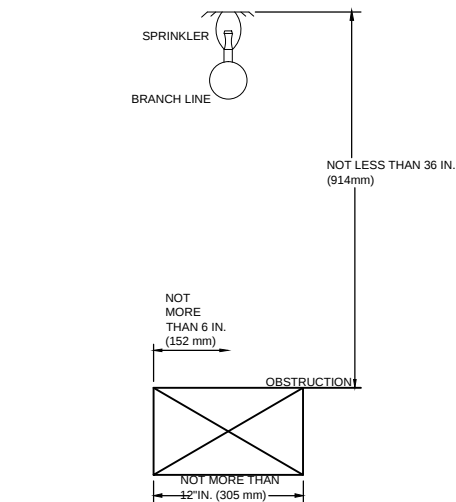


POSITION OF SPRINKLERS IN RELATION TO OBSTRUCTION RUNNING PARALLEL TO & DIRECTLY BELOW BRANCH LINES

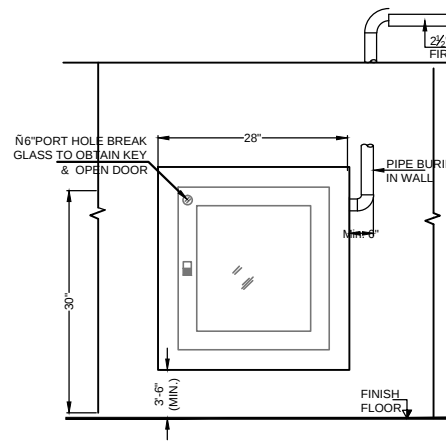


ELEVATION FOR INSTALLATION OF FIRE HOSE REEL CABINET (FHRC)

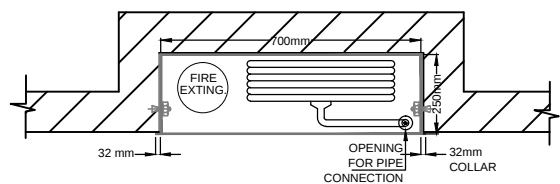


PLAN OF FIRE HOSE REEL CABINET (FHRC) (RECESSED TYPE)

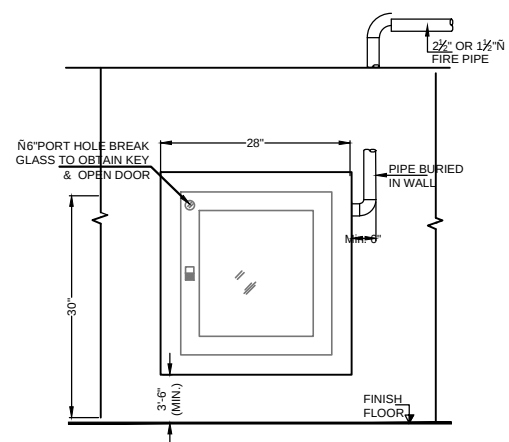

ELEVATION FOR INSTALLATION OF FIRE HOSE REEL CABINET (FHRC)

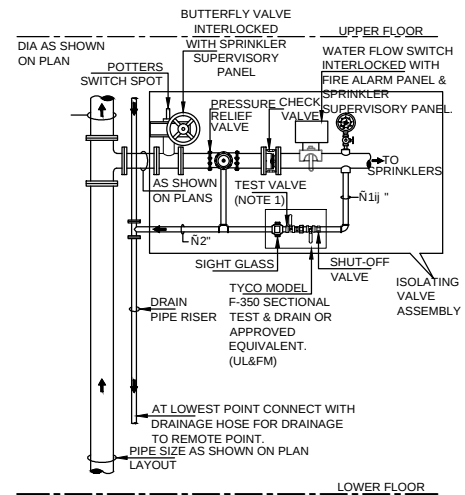

ZONE CONTROL VALVE WITH PRV ASSEMBLY DETAIL

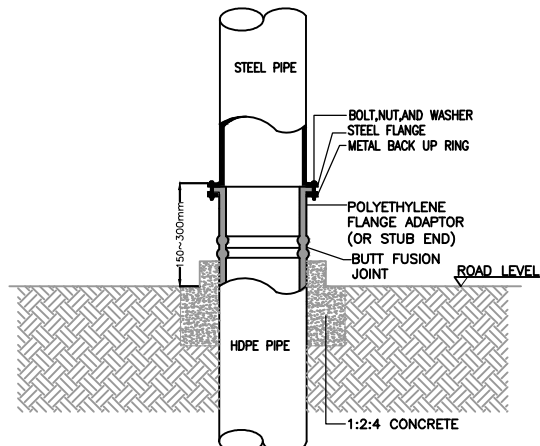

HDPE TO MS PIPE DETAIL

CLIENT:-



CONSULTANT:




PROJECT:-

STATE LIFE BUILDING NO.11

TITLE:-


STANDARD DETAILS

REV #	DATE	DESCRIPTION	CHK'D	APP'D	Project Ref:	DATE
00	02-07-2026	ISSUED FOR TENDER				JUNE.2026
					DRAWN BY A-A	SCALE 1/8" = 1'-0"
					CHECKED BY W-S	DWG. NO. FP-02C

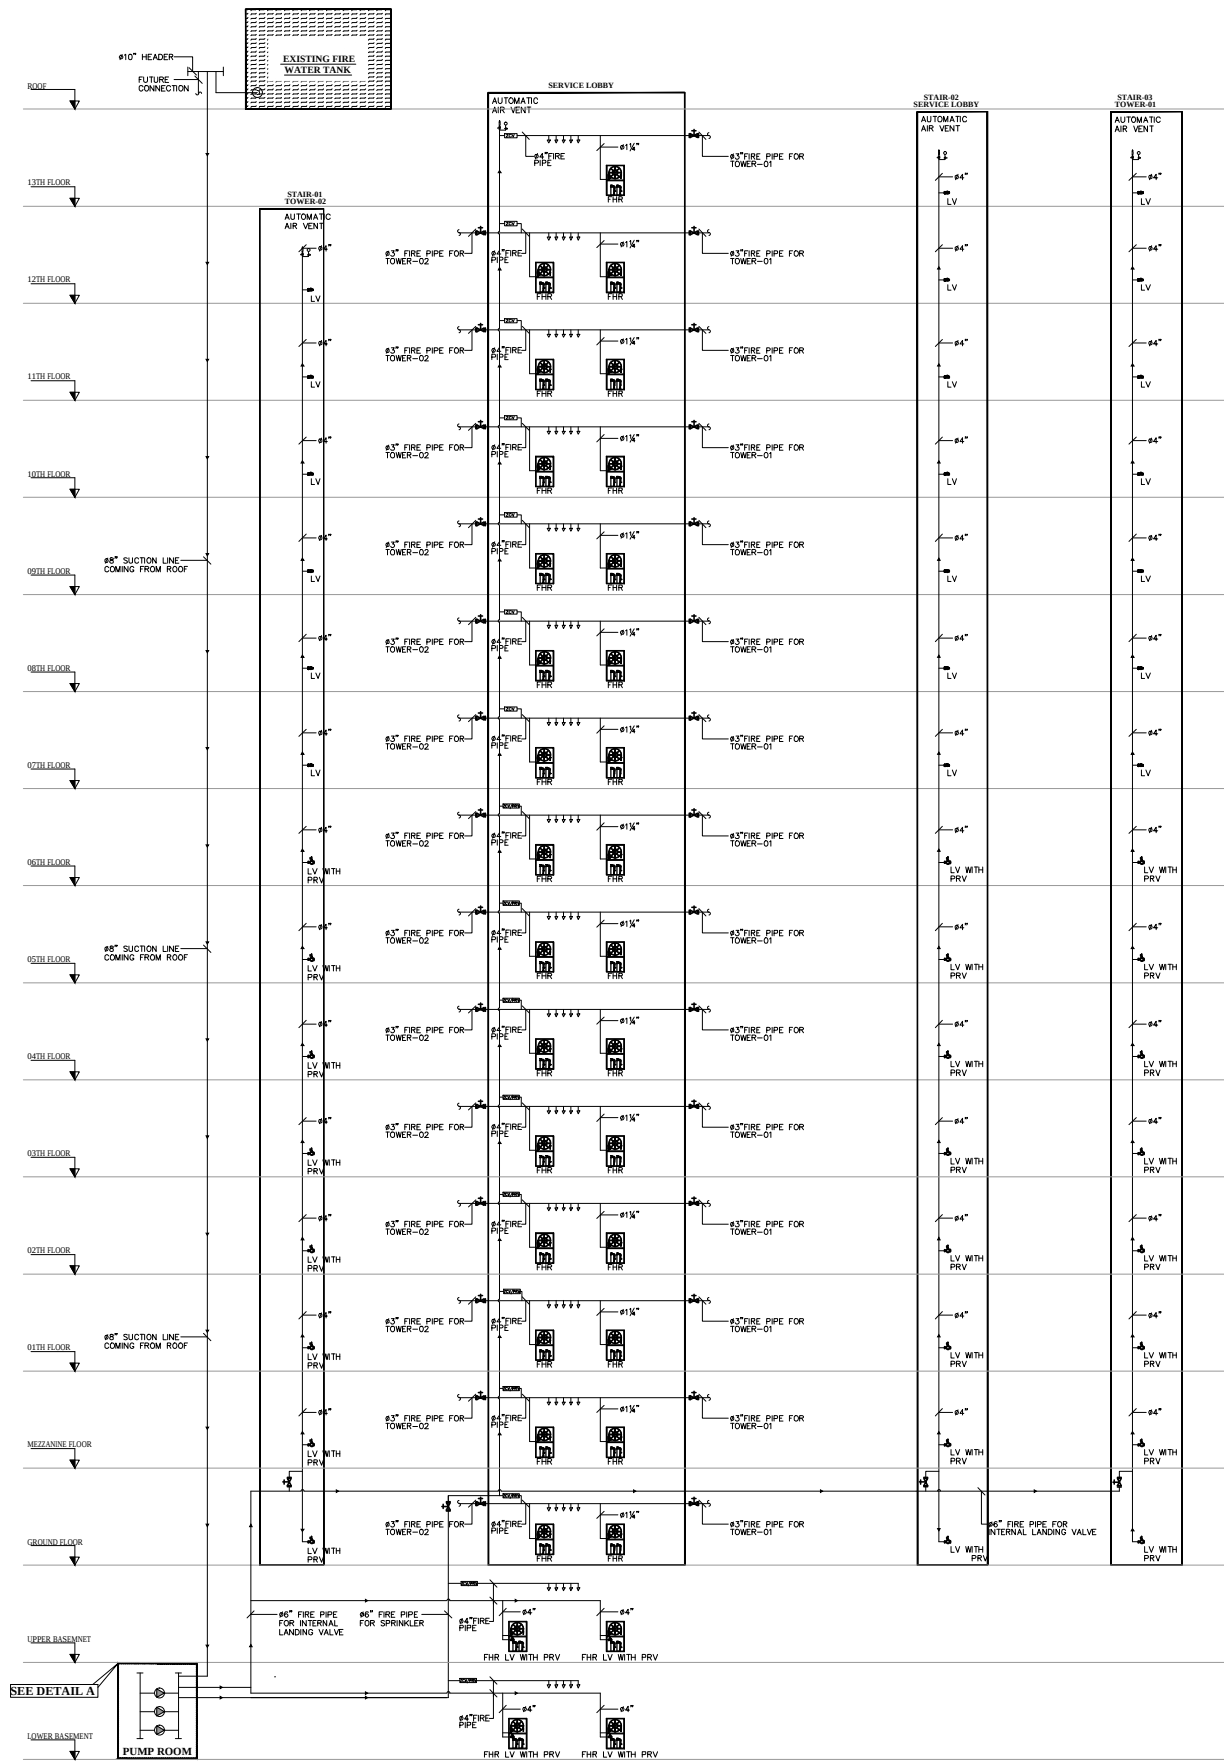

SYMBOL	DESCRIPTION
	IDENTIFICATION NUMBER, SCHEDULED OR DETAILED
	FIRE WATER PIPE
	DIESEL PIPE
	DRAIN PIPE
	FLEXIBLE CONNECTOR
	PRESSURE GAUGE WITH COCK
	BALL VALVE
	OS & Y GATE VALVE
	INSPECTOR TEST & DRAIN VALVE
	GATE VALVE
	AUTOMATIC AIR VENT WITH BALL VALVE
	LANDING VALVE / HYDRANT VALVE
	ALARM CHECK VALVE
	CHECK VALVE
	PRESSURE RELIEF VALVE
	WASTE CONE
	FLOW METER
	STRAINER WITH BALL VALVE
	FIRE PUMP

S.NO	TAG	DESCRIPTION	FLOW USGPM	HEAD (BAR)
1	FP-01	DIESEL ENGINE OPERATED FIRE PUMP	1000	7.5
2	FP-02	ELECTRIC MOTOR OPERATED FIRE PUMP	1000	7.5
3	JP-01	ELECTRIC MOTOR OPERATED JOCKEY PUMP	20	08

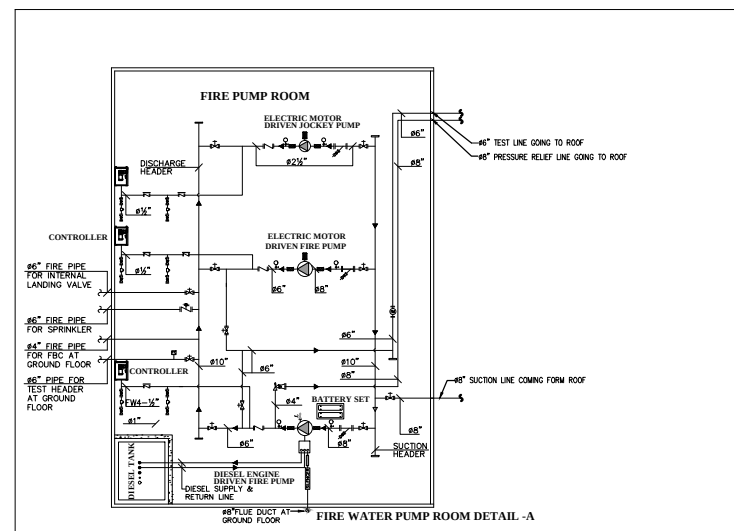

PUMP RATING (gpm)	MINIMUM PIPE SIZES (NOMINAL) (in.) AS PER NFPA 20					
	SUCTION	DISCHARGE	RELIEF VALVE	RELIEF VALVE DISCHARGE	METER DEVICE	HOSE HEADER SUPPLY
750	6	6	4	6	6	3-2 1/2
1000	8	8	6	8	8	4-2 1/2
1250	8	8	6	8	8	6-2 1/2
1500	8	8	6	8	8	6-2 1/2
2000	10	10	6	10	8	6-2 1/2

CLIENT:-

STATE LIFEINSURANCE CORPORATION OF PAKISTAN

CONSULTANT:-

NexusConsulting

Office A-202, Second Floor, Blossom Trade Center Opposite NED University
University Road, SB-26, Block No.01 Gulistan-e-Jouhar, Karachi Pakistan
Phone: 021-37240670
Email: nexusconsultingcompany@gmail.com Web: www.Nexuscon.pk

PROJECT:-



STATE LIFE BUILDING NO.11

TITLE:-

SCHEMATIC DIAGRAM AT FIRE PROTECTION SYSTEM

REV #	DATE	DESCRIPTION	CHK'D	APP'D
00	02-07-2026	ISSUED FOR TENDER		

Project Ref:	DATE
	JUNE.2026
DRAWN BY	SCALE
A-A	1/8" = 1'-0"
CHECKED BY	DWG. NO.
W-S	FP-03

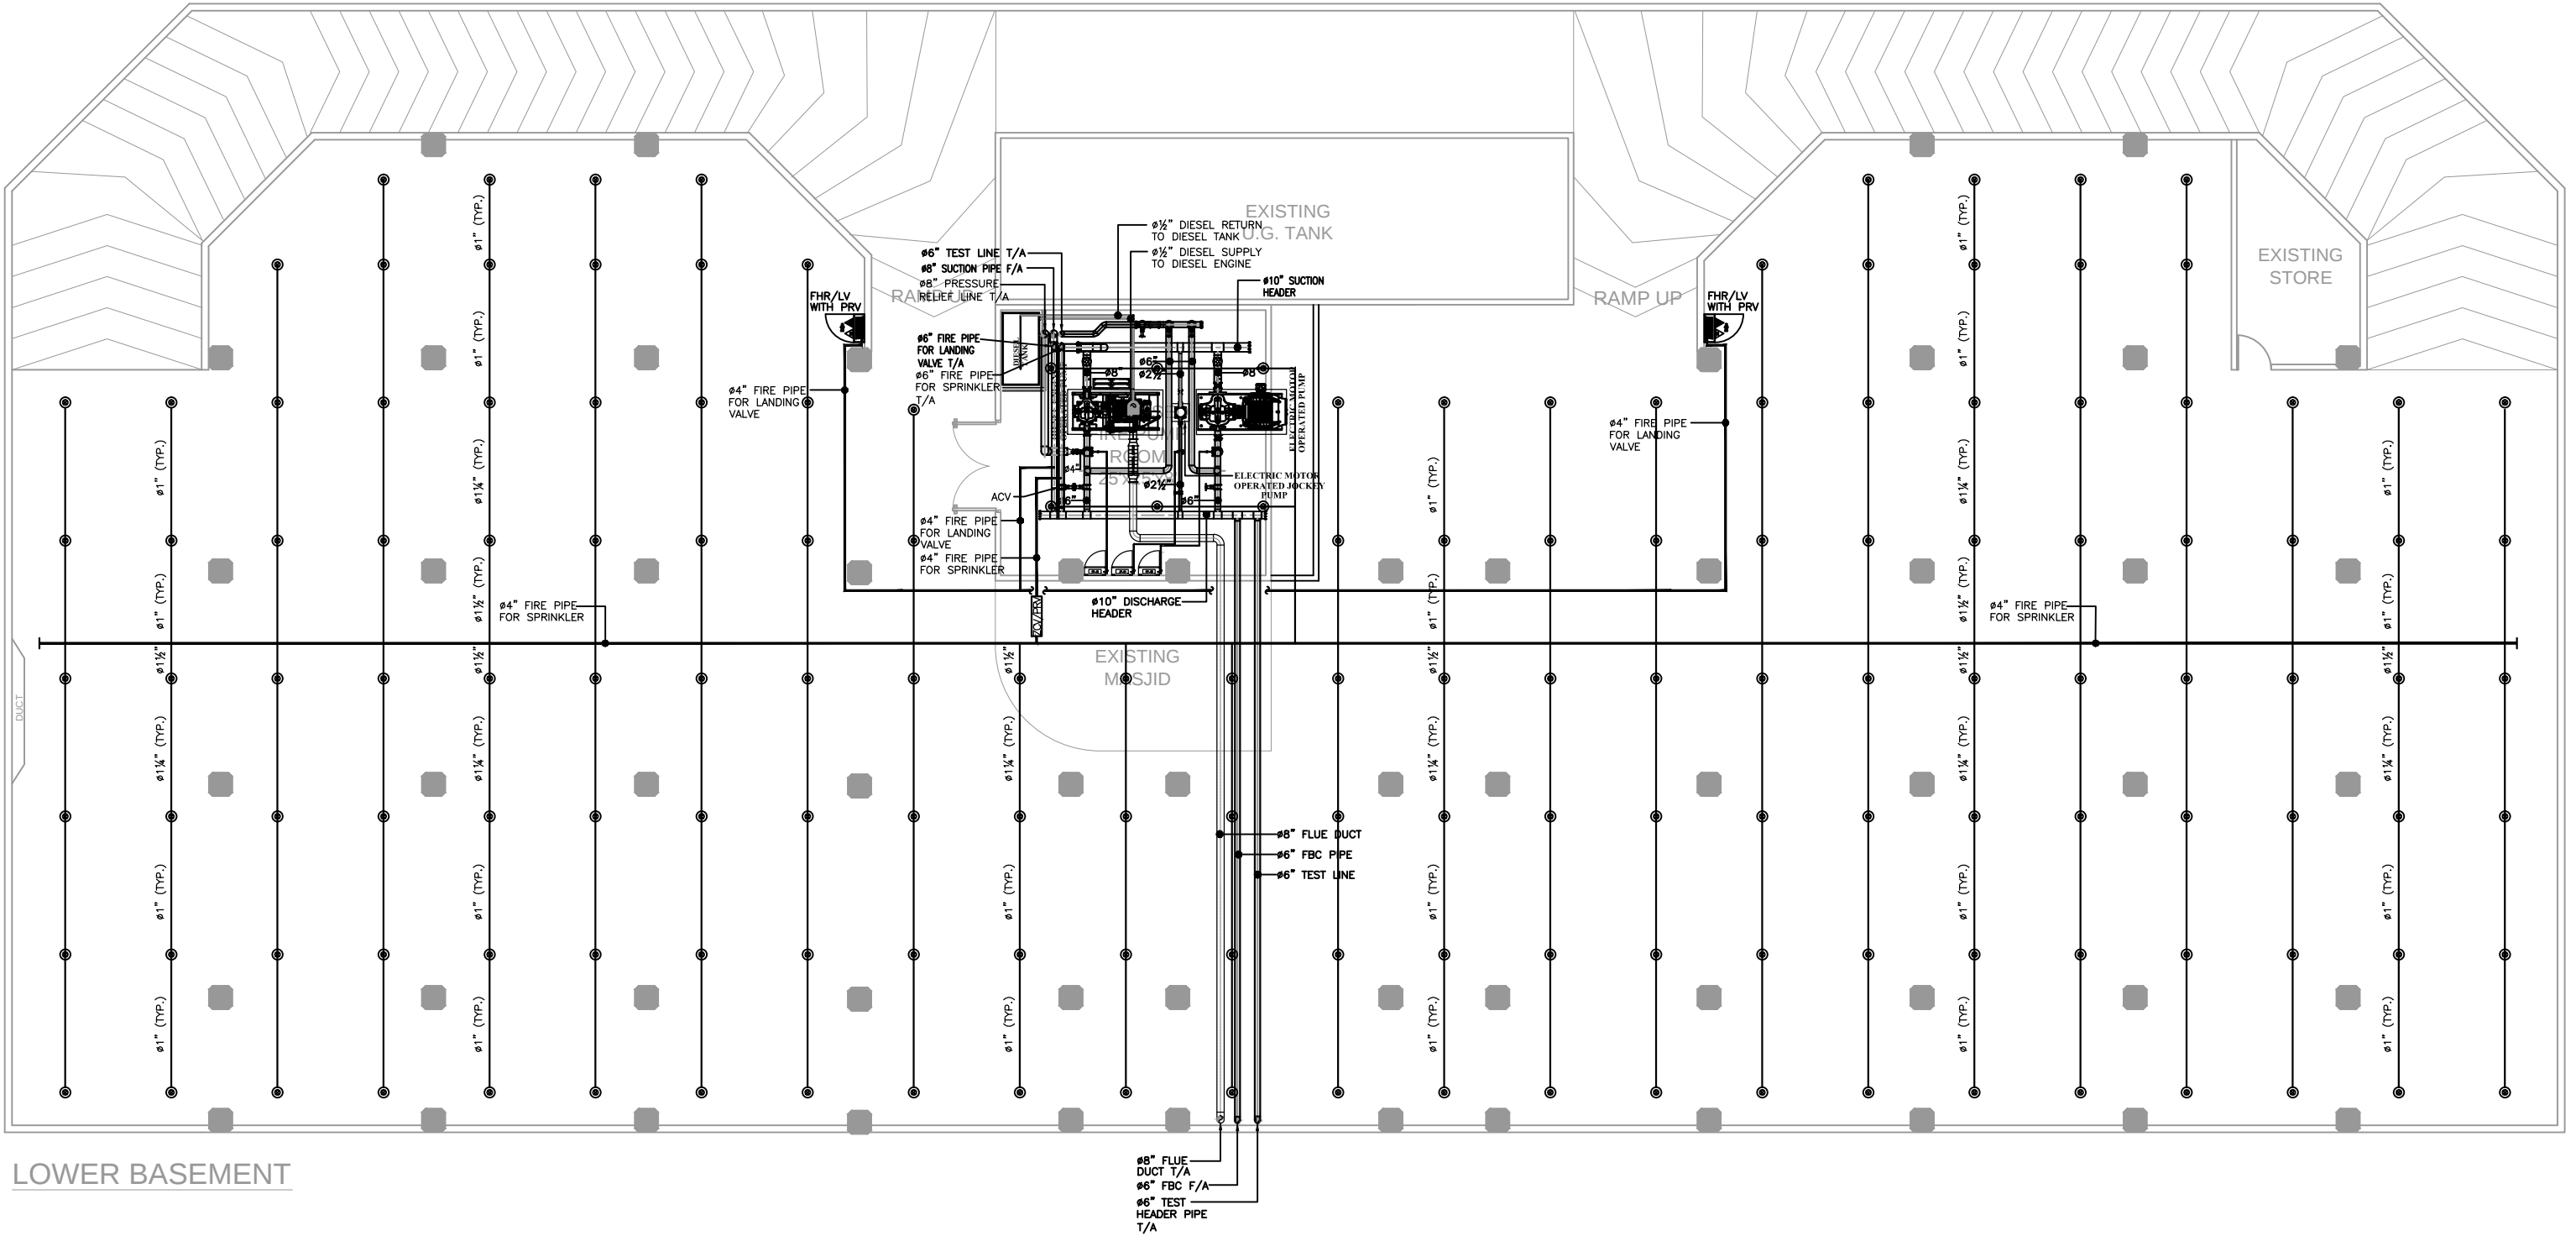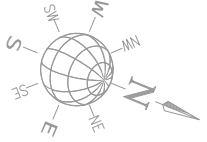

LOWER BASEMENT

CLIENT:-



CONSULTANT:



Nexus
Consulting
Office A-202, Second Floor, Blossom Trade Center Opposite NED University
University Road, SB-26, Block No.01 Gulistan-e-Jouhar, Karachi Pakistan
Phone: 021-37240670
Email: nexusconsultingcompany@gmail.com Web: www.Nexuscon.pk


PROJECT:-

STATE LIFE BUILDING NO.11

TITLE:-

FIRE PROTECTION SYSTEM
AT LOWER BASEMENT

REV #	DATE	DESCRIPTION	CHK'D	APP'D	Project Ref:	DATE
00	02-07-2026	ISSUED FOR TENDER				JUNE.2026
					DRAWN BY A-A	SCALE 1/8" = 1'-0"
					CHECKED BY W-S	DWG. NO. F-04

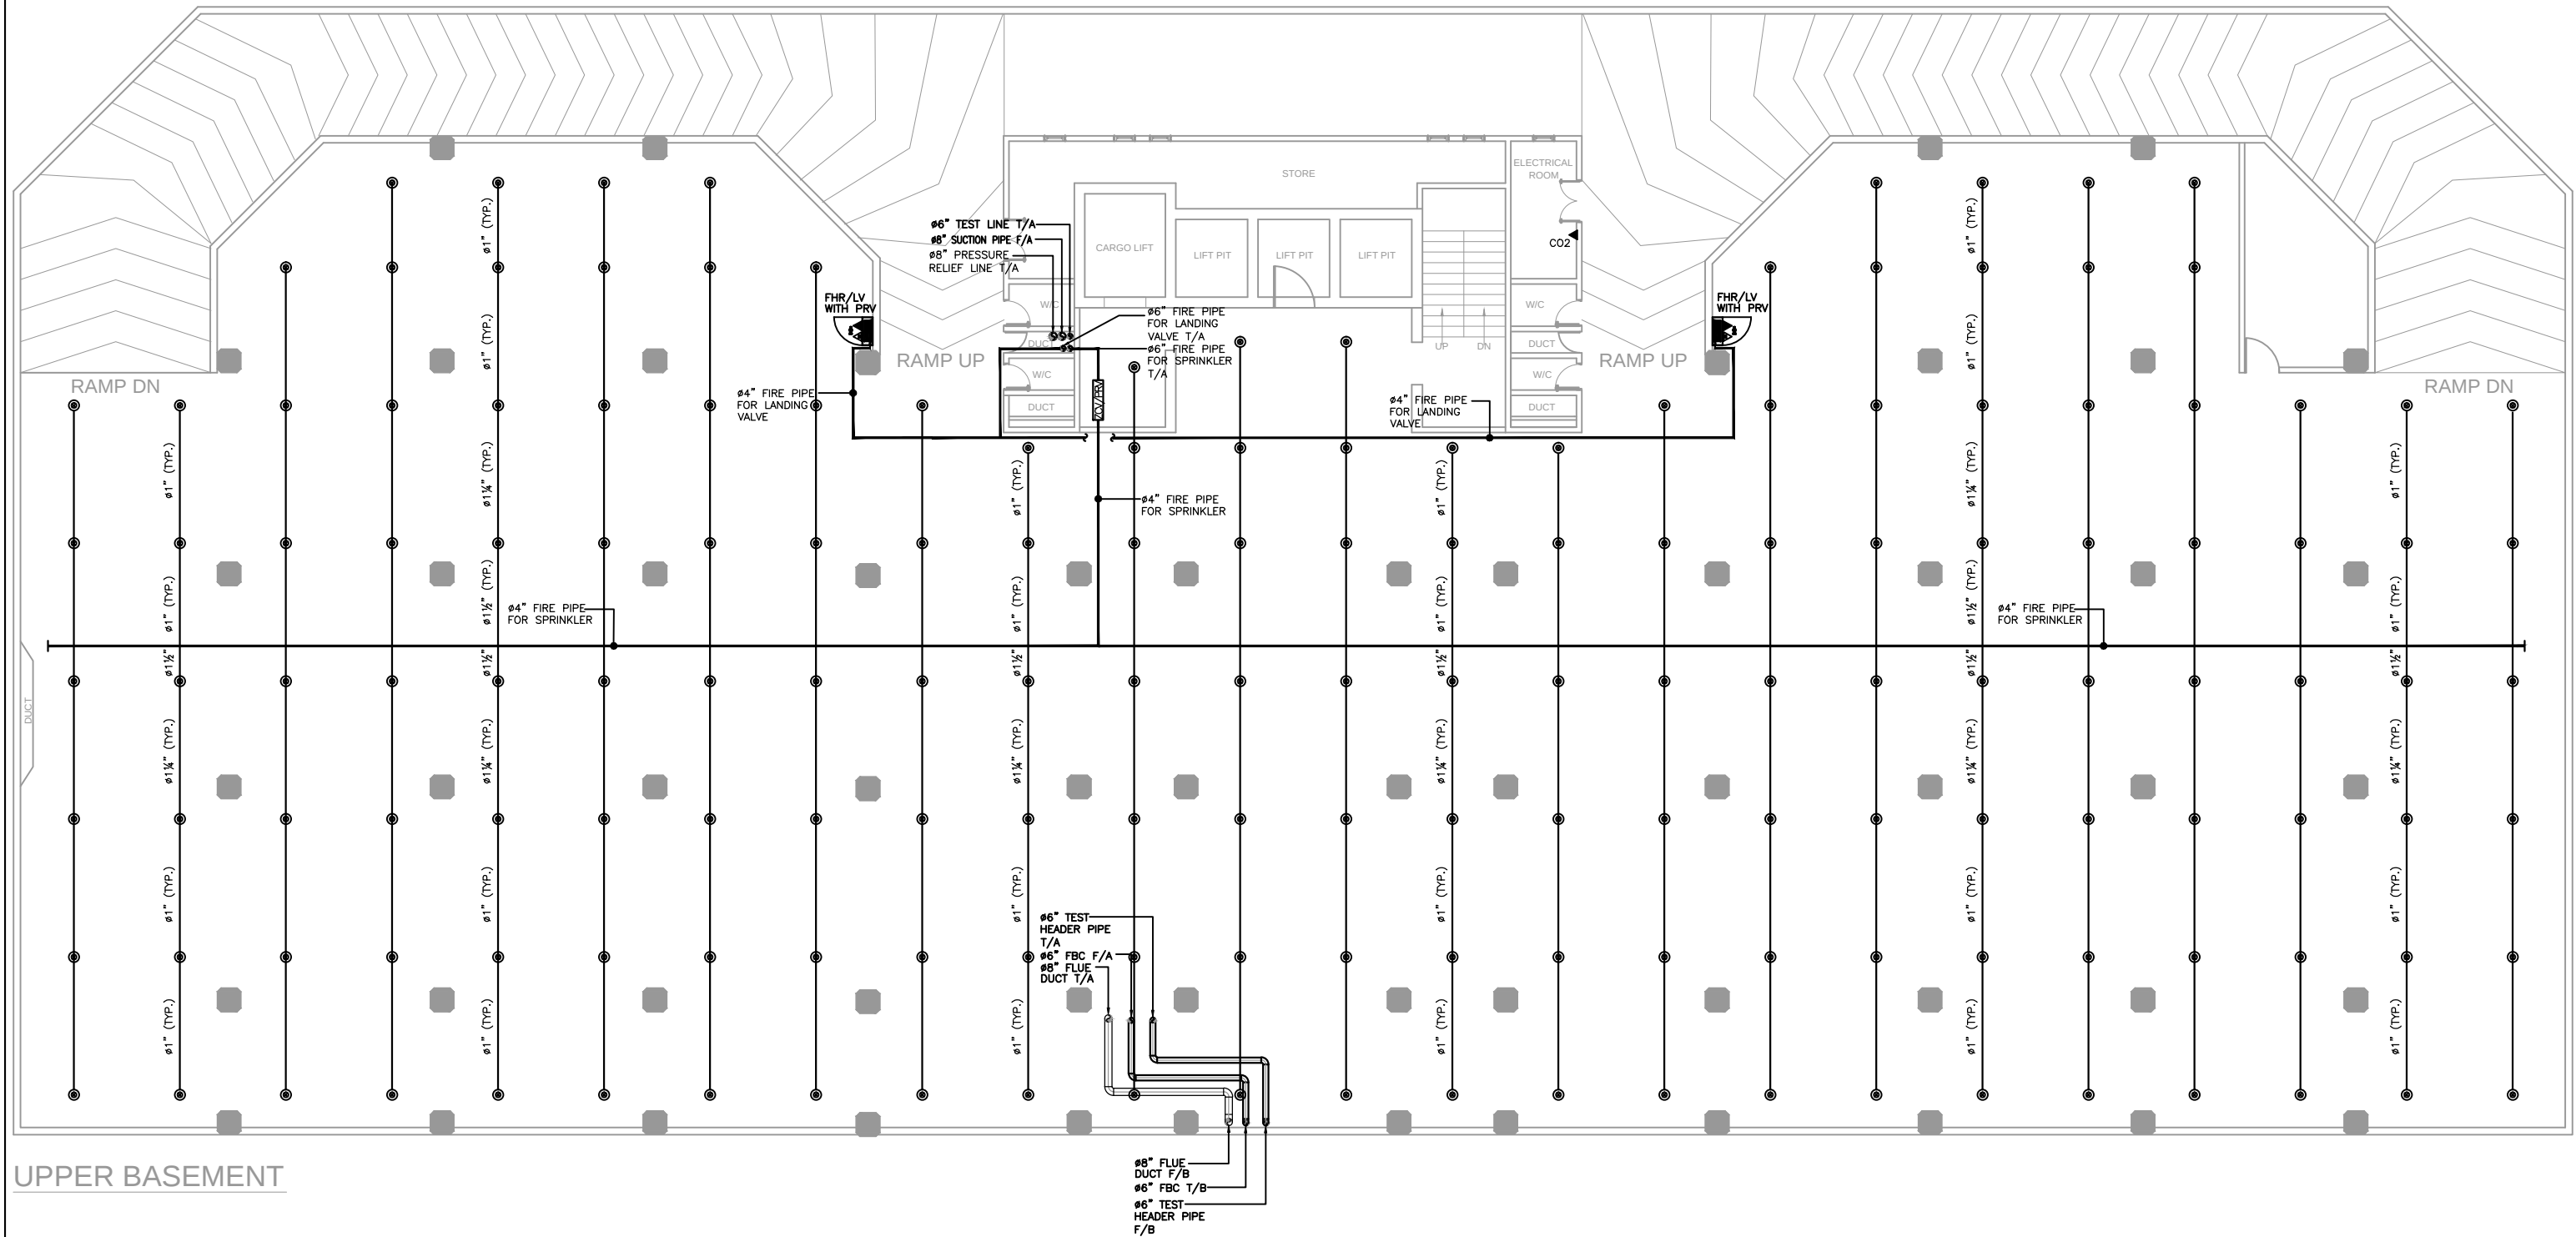

UPPER BASEMENT

CLIENT:-



CONSULTANT:




PROJECT:-

STATE LIFE BUILDING NO.11

TITLE:-

FIRE PROTECTION SYSTEM
AT UPPER BASEMENT

REV #	DATE	DESCRIPTION	CHK'D	APP'D	Project Ref:	DATE
00	02-07-2026	ISSUED FOR TENDER				JUNE.2026
					DRAWN BY A-A	SCALE 1/8" = 1'-0"
					CHECKED BY W-S	DWG. NO. F-05

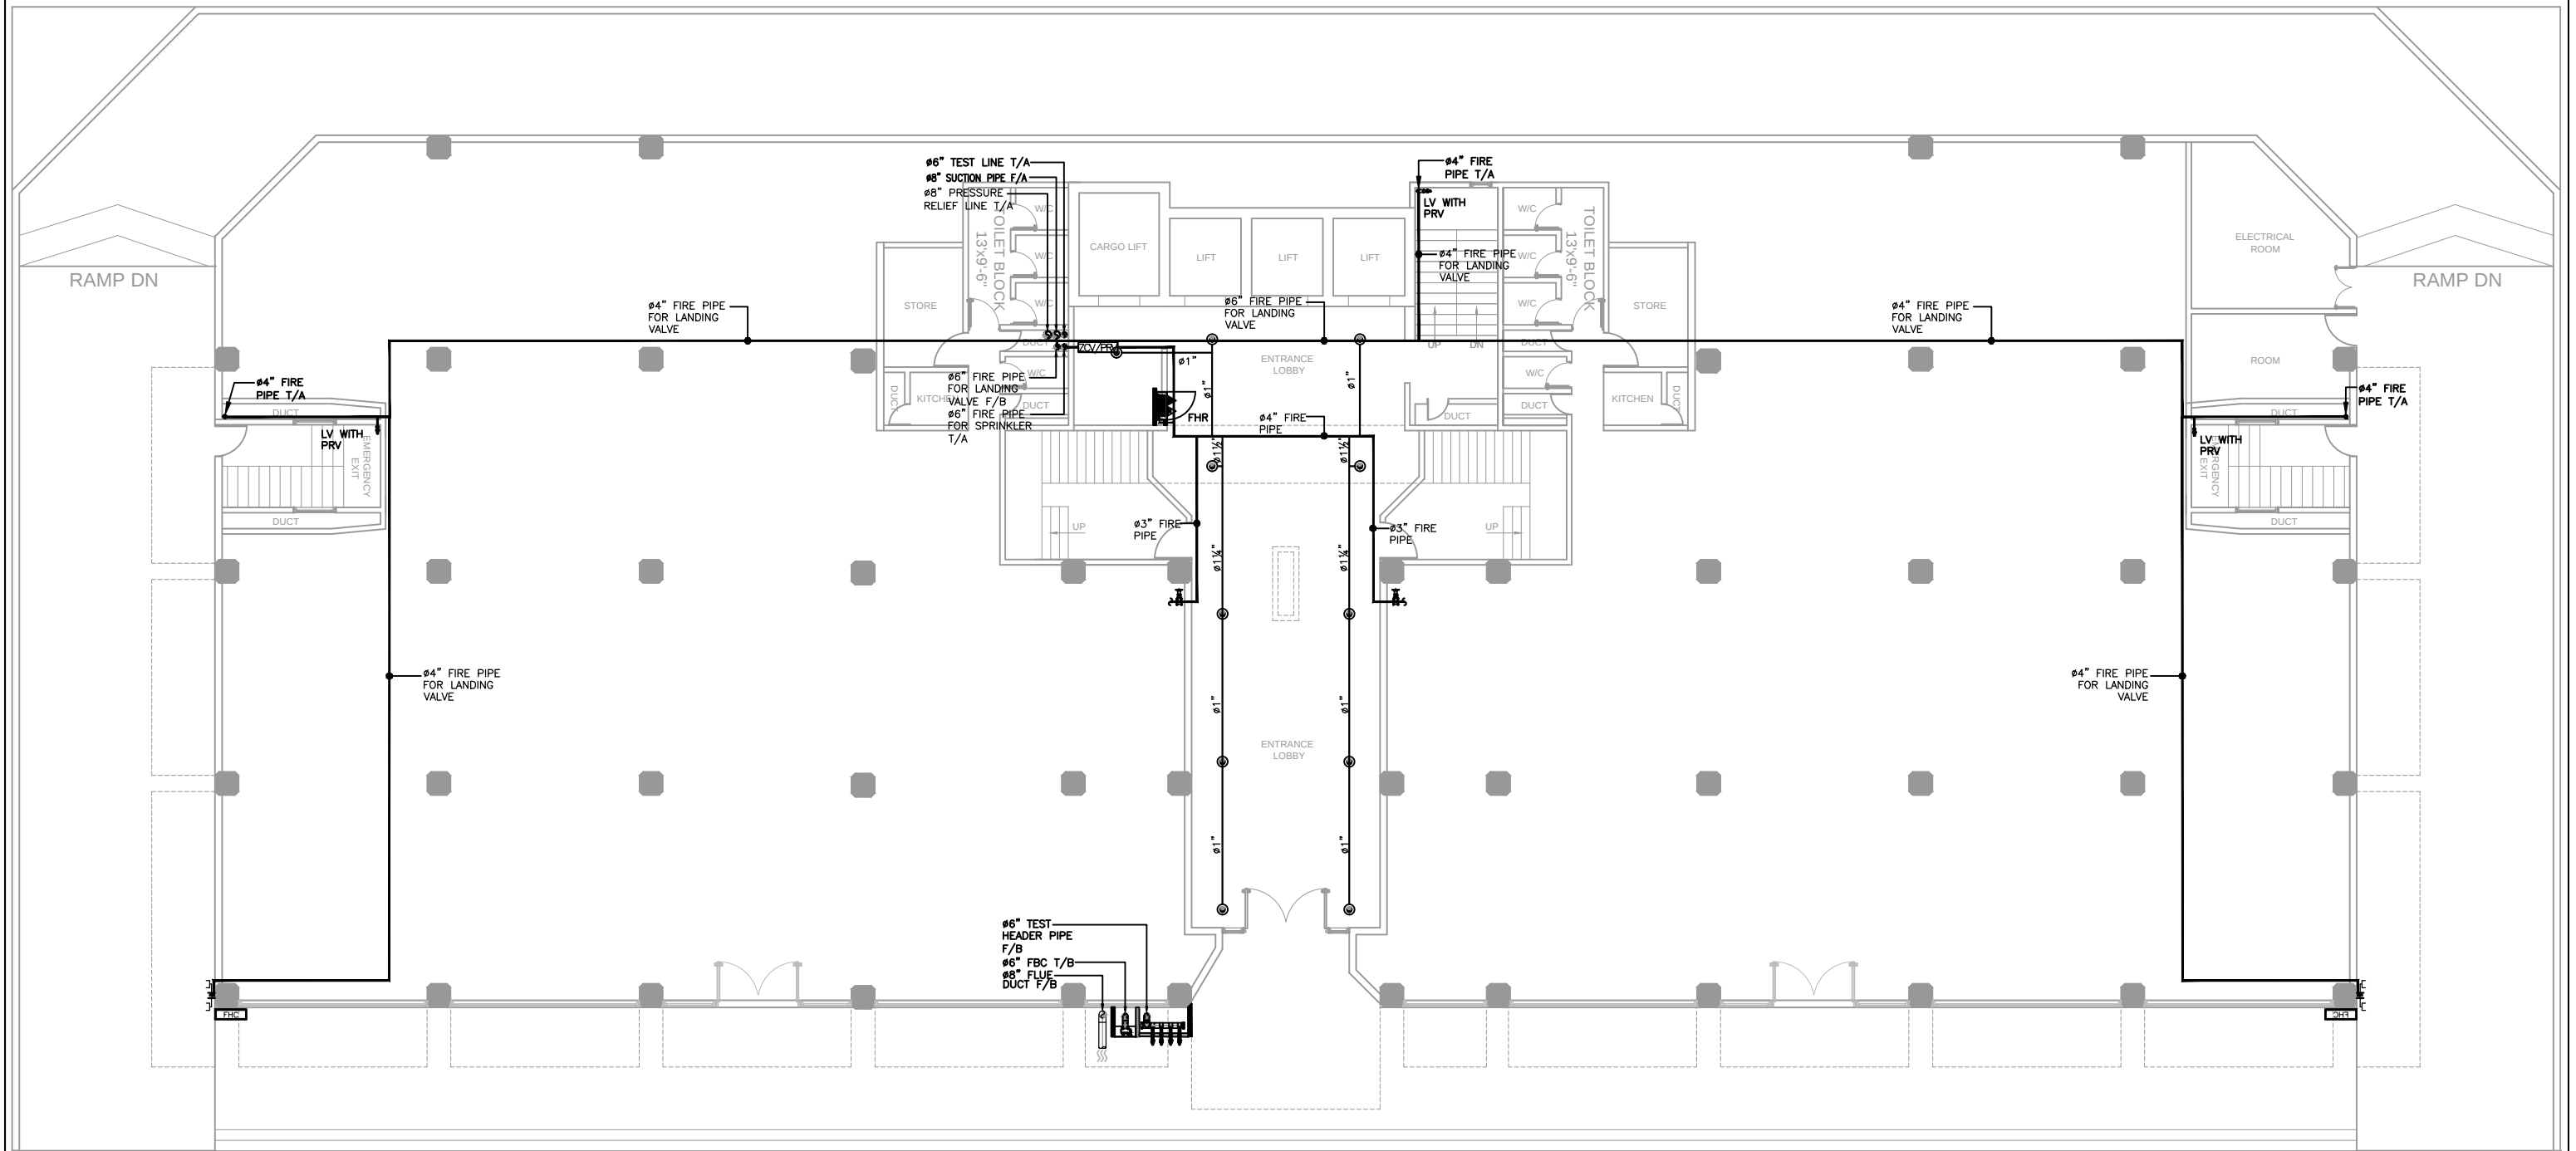

GROUND FLOOR

CLIENT:-



CONSULTANT:



Nexus
Consulting
Office A-202, Second Floor, Blossom Trade Center Opposite NED University
University Road, SB-26, Block No.01 Gulistan-e-Jouhar, Karachi Pakistan
Phone: 021-37240670
Email: nexusconsultingcompany@gmail.com Web: www.Nexuscon.pk


PROJECT:-

STATE LIFE BUILDING NO.11

TITLE:-

FIRE PROTECTION SYSTEM
AT GROUND FLOOR

REV #	DATE	DESCRIPTION	CHK'D	APP'D	Project Ref:	DATE
00	02-07-2026	ISSUED FOR TENDER				JUNE.2026
					DRAWN BY A-A	SCALE 1/8" = 1'-0"
					CHECKED BY W-S	DWG. NO. F-06

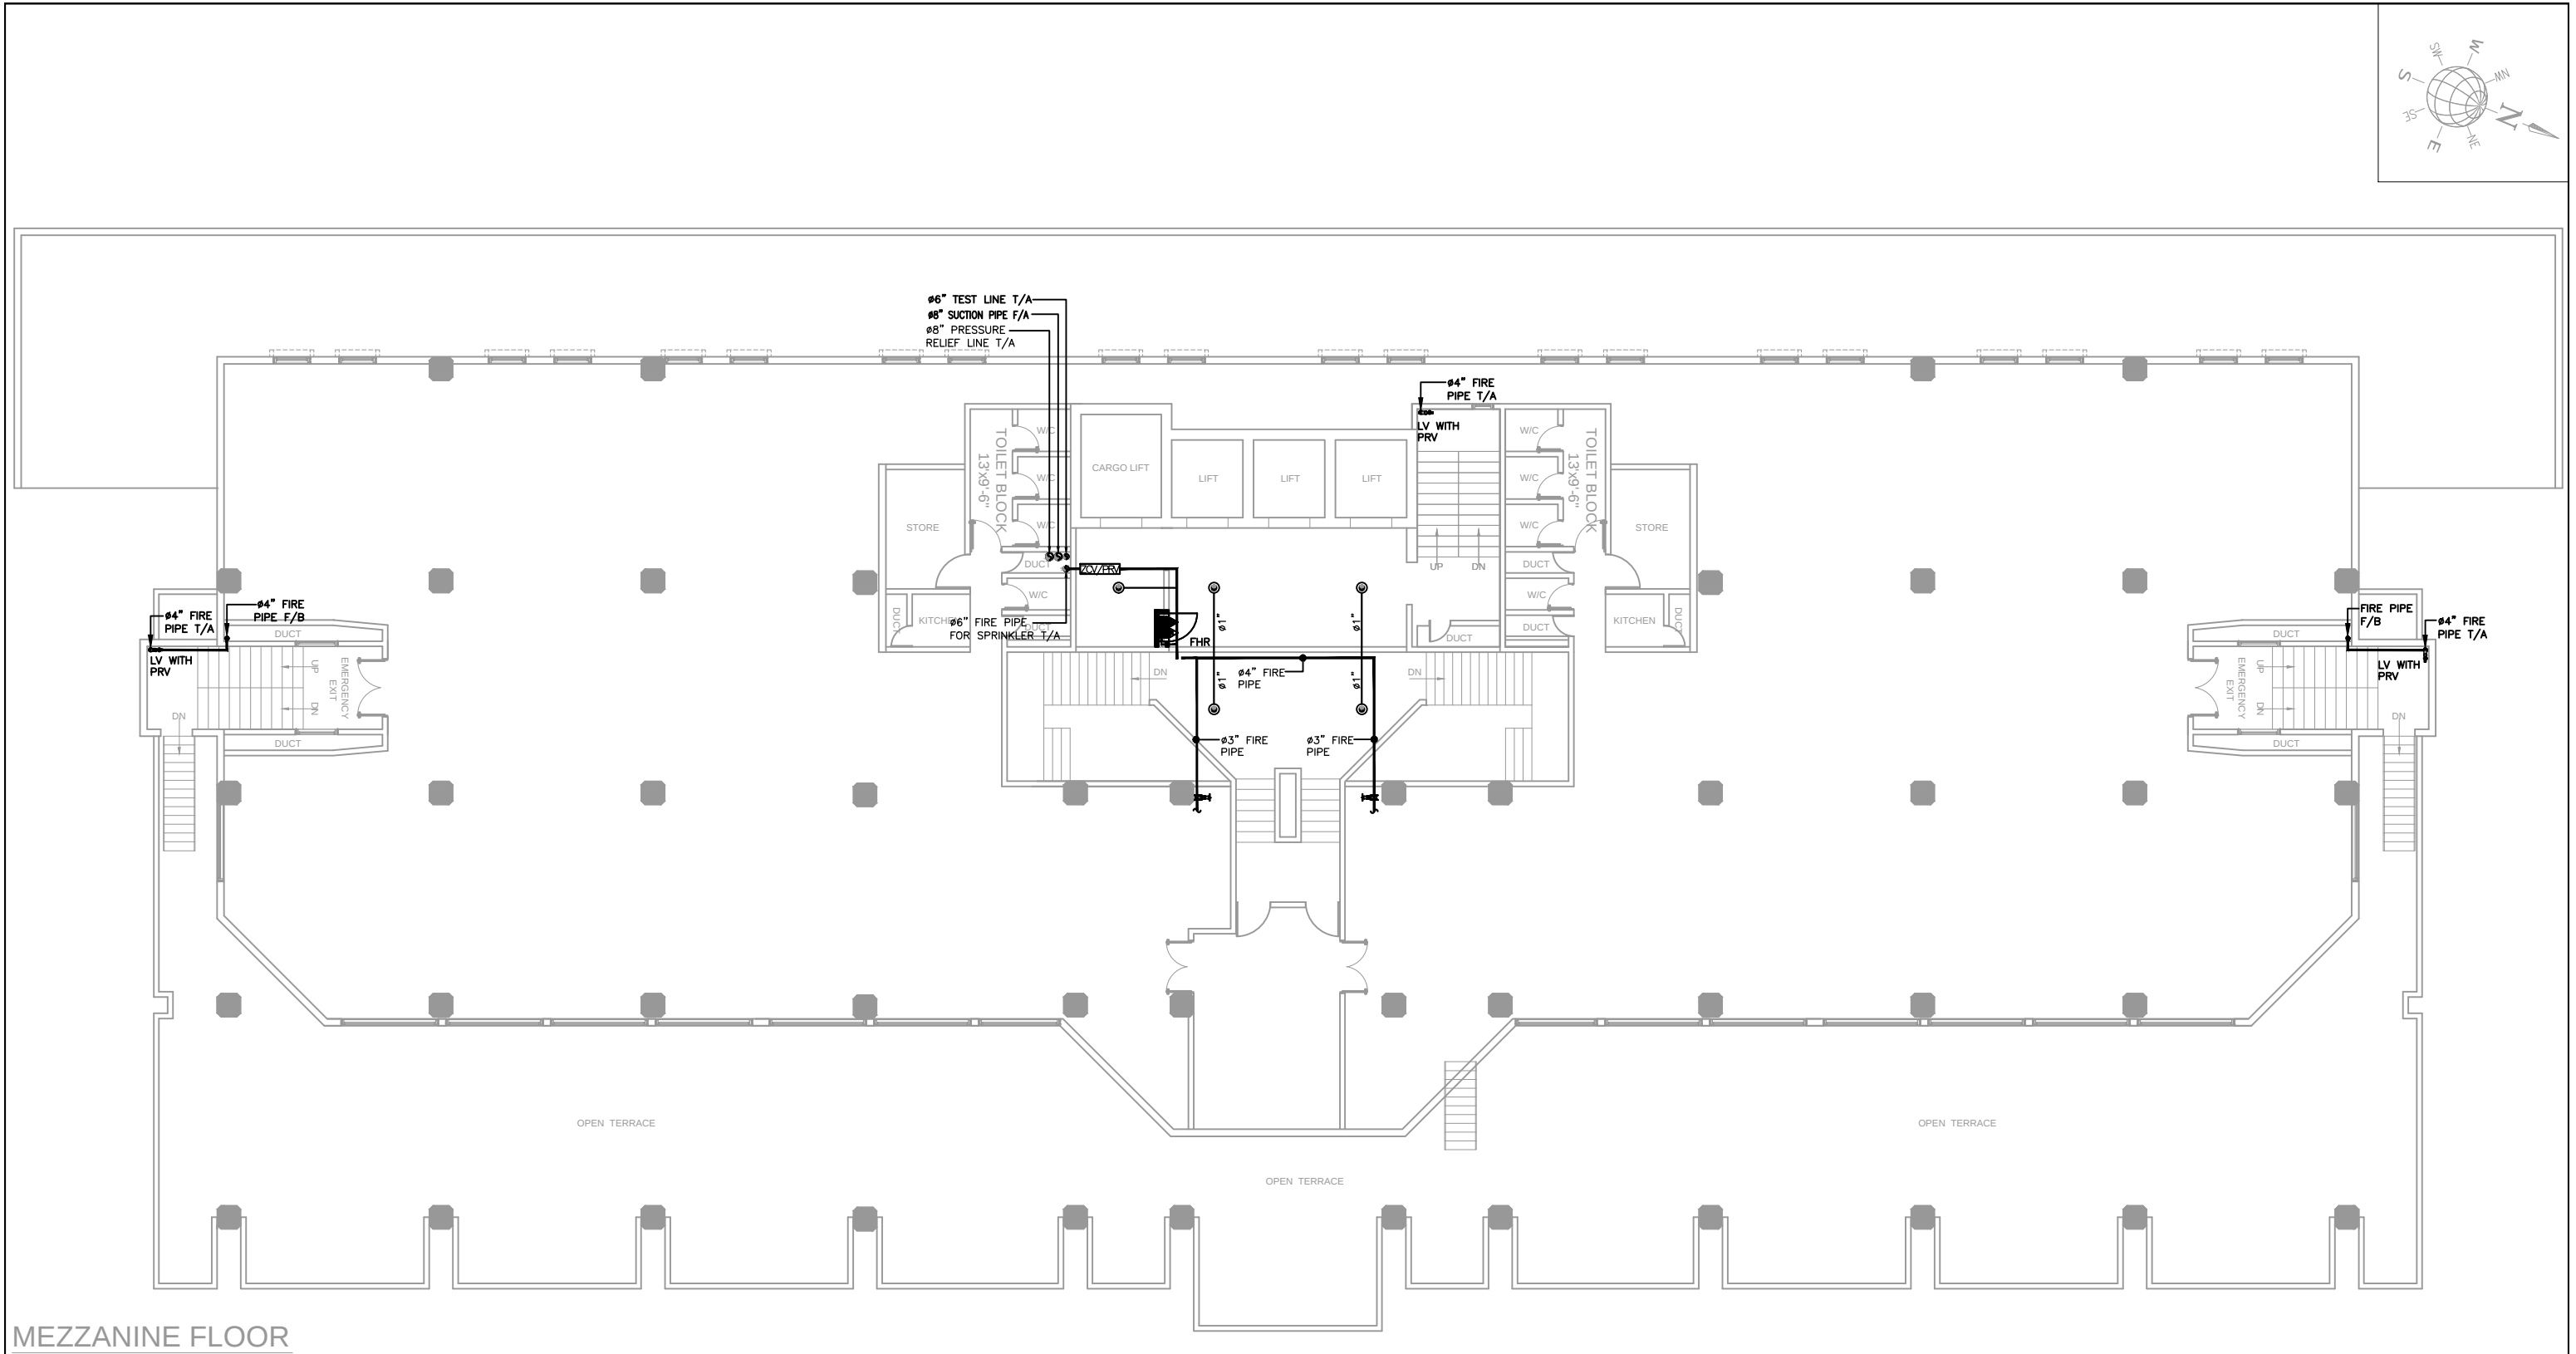

CLIENT:-



CONSULTANT:



Office A-202, Second Floor, Blossom Trade Center Opposite NED University
University Road, SB-26, Block No.01 Gulistan-e-Jouhar, Karachi Pakistan
Phone: 021-37240670
Email: nexusconsultingcompany@gmail.com Web: www.Nexuscon.pk



PROJECT:-

STATE LIFE BUILDING NO.11

TITLE:-

FIRE PROTECTION SYSTEM AT MEZZANINE FLOOR

REV #	DATE	DESCRIPTION	CHKD	APPD	Project Ref: . DRAWN BY A-A CHECKED BY W-S	DATE
00	02-07-2026	ISSUED FOR TENDER				JUNE.2026
						SCALE
						1/8" = 1'-0"
						DWG. NO.
						F-07

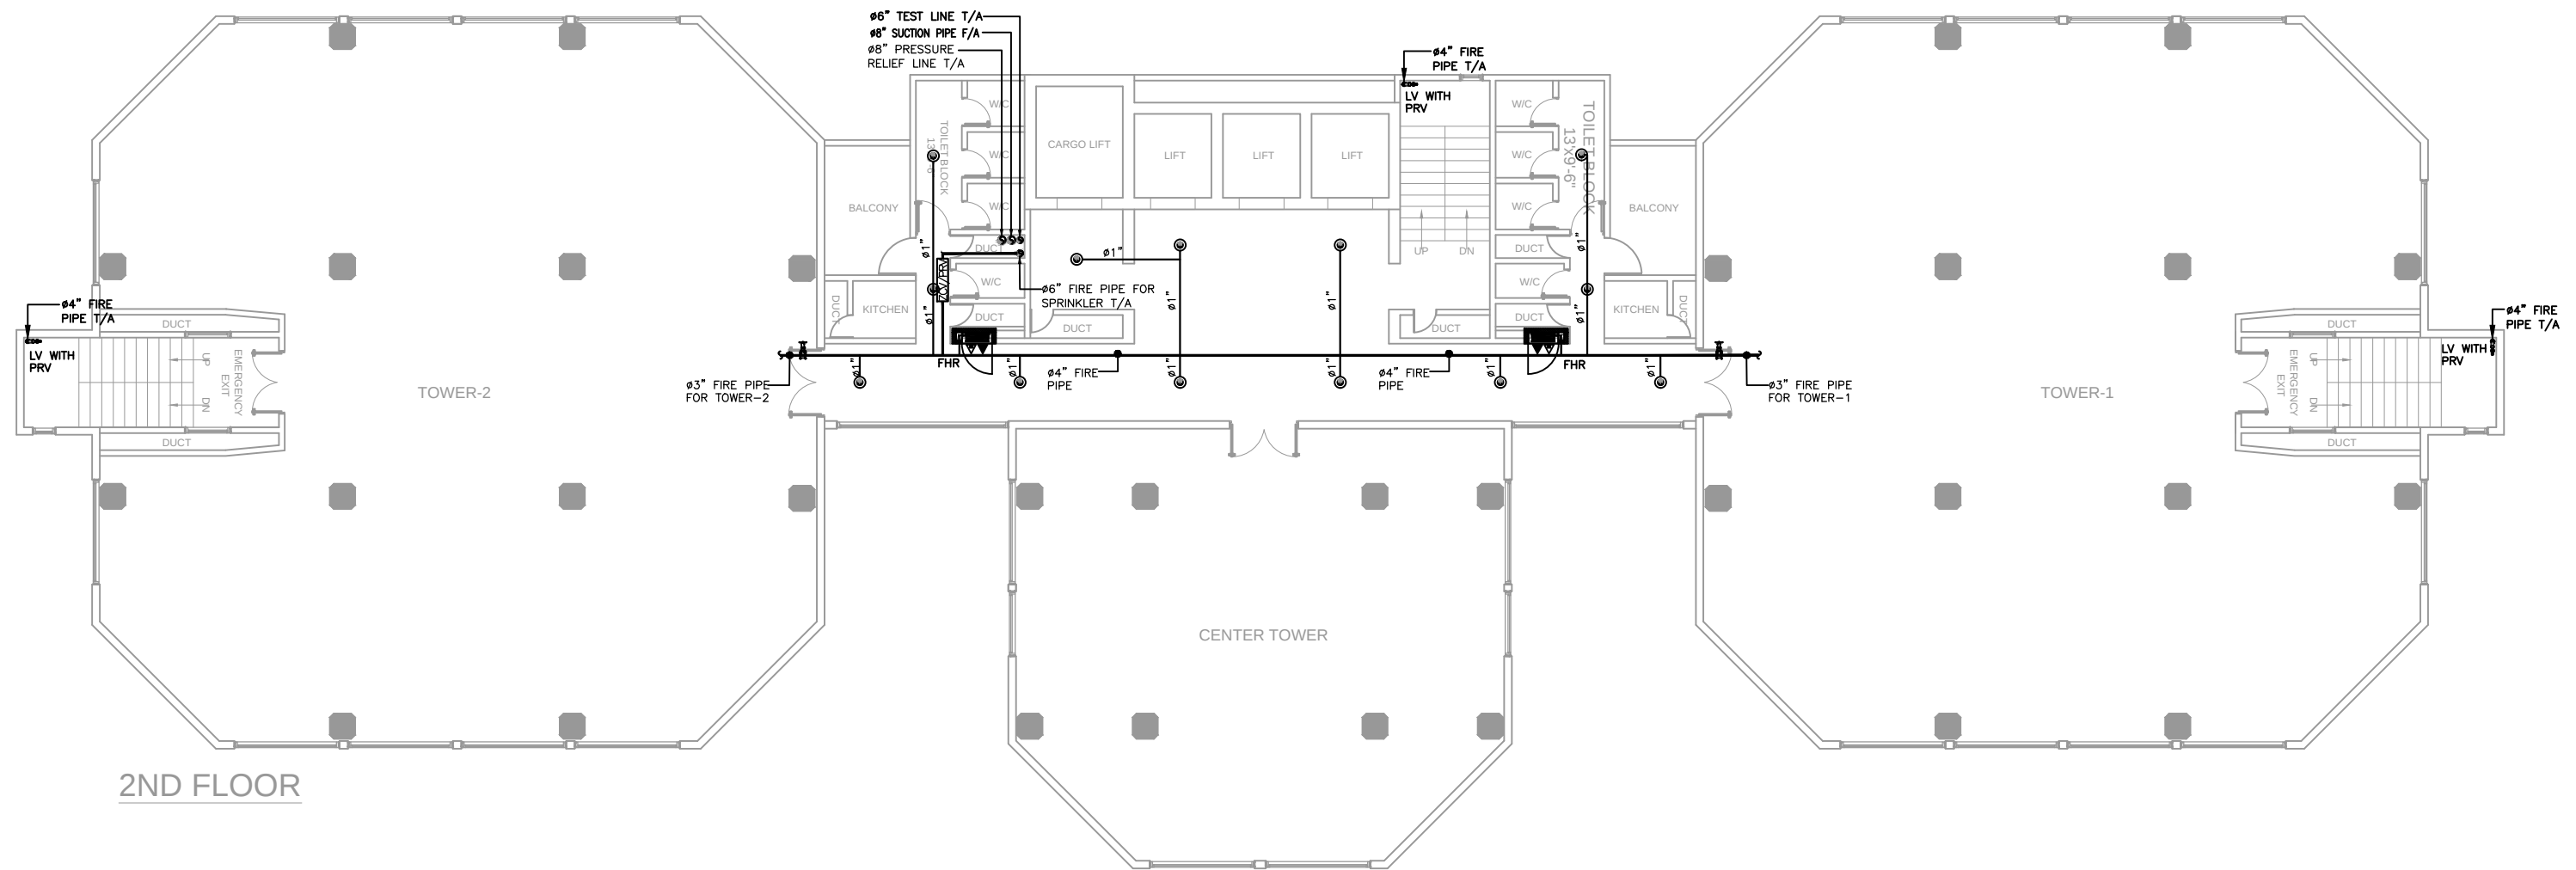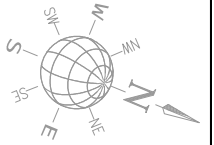

CLIENT:-



CONSULTANT:



Nexus
Consulting
Office A-202, Second Floor, Blossom Trade Center Opposite NED University
University Road, SB-26, Block No.01 Gulistan-e-Jouhar, Karachi Pakistan
Phone: 021-37240670
Email: nexusconsultingcompany@gmail.com Web: www.Nexuscon.pk



PROJECT:-

STATE LIFE BUILDING NO.11

TITLE:-

FIRE PROTECTION SYSTEM
AT 2ND FLOOR

REV #	DATE	DESCRIPTION	CHK'D	APP'D	Project Ref:	DATE
00	02-07-2026	ISSUED FOR TENDER				JUNE.2026
					DRAWN BY A-A	SCALE 1/8" = 1'-0"
					CHECKED BY W-S	DWG. NO. F-08

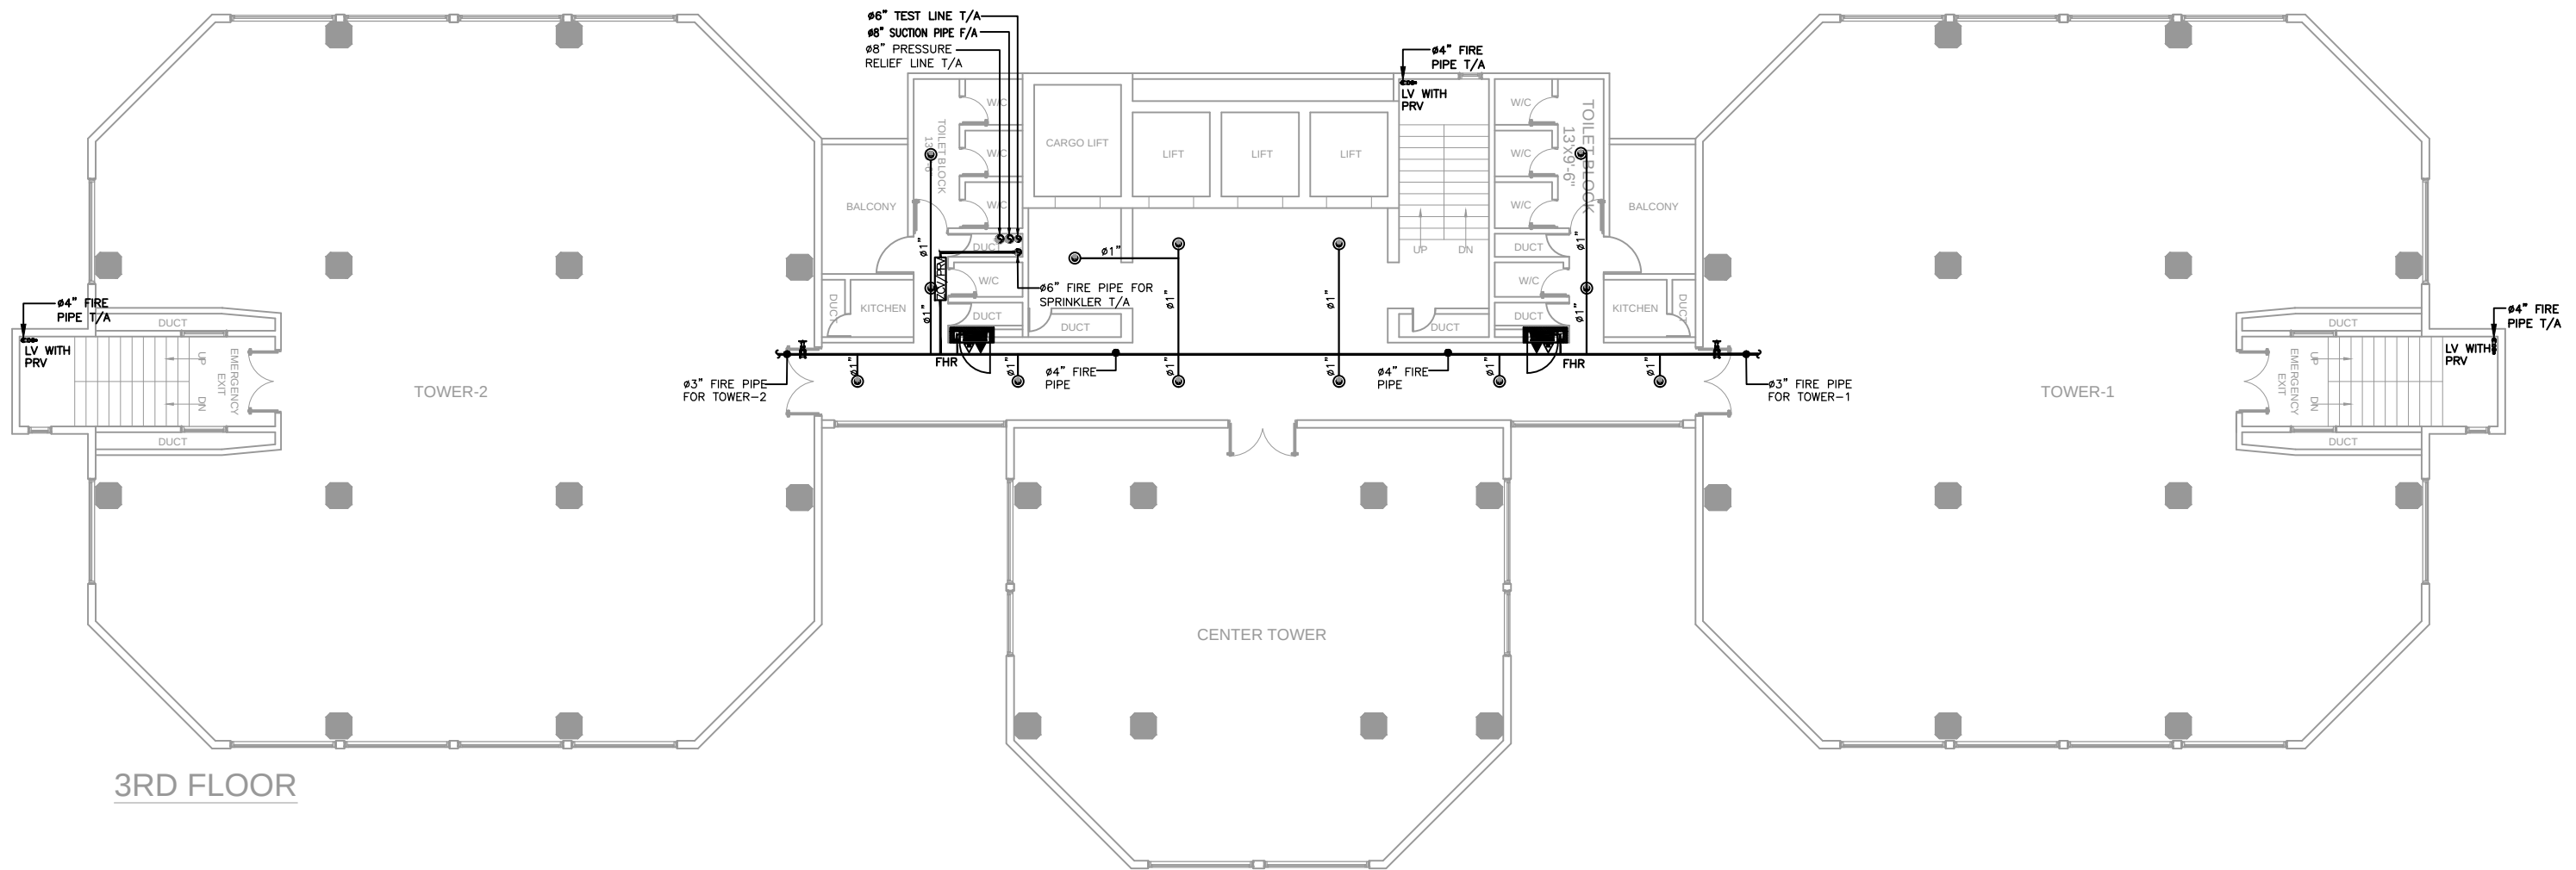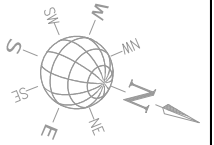

3RD FLOOR

CLIENT:-



CONSULTANT:



Nexus
Consulting
Office A-202, Second Floor, Blossom Trade Center Opposite NED University
University Road, SB-26, Block No.01 Gulistan-e-Jouhar, Karachi Pakistan
Phone: 021-37240670
Email: nexusconsultingcompany@gmail.com Web: www.Nexuscon.pk


PROJECT:-

STATE LIFE BUILDING NO.11

TITLE:-

FIRE PROTECTION SYSTEM
AT 3RD FLOOR

REV #	DATE	DESCRIPTION	CHK'D	APP'D	Project Ref:	DATE
00	02-07-2026	ISSUED FOR TENDER			.	JUNE.2026
					DRAWN BY A-A	SCALE 1/8" = 1'-0"
					CHECKED BY W-S	DWG. NO. F-09

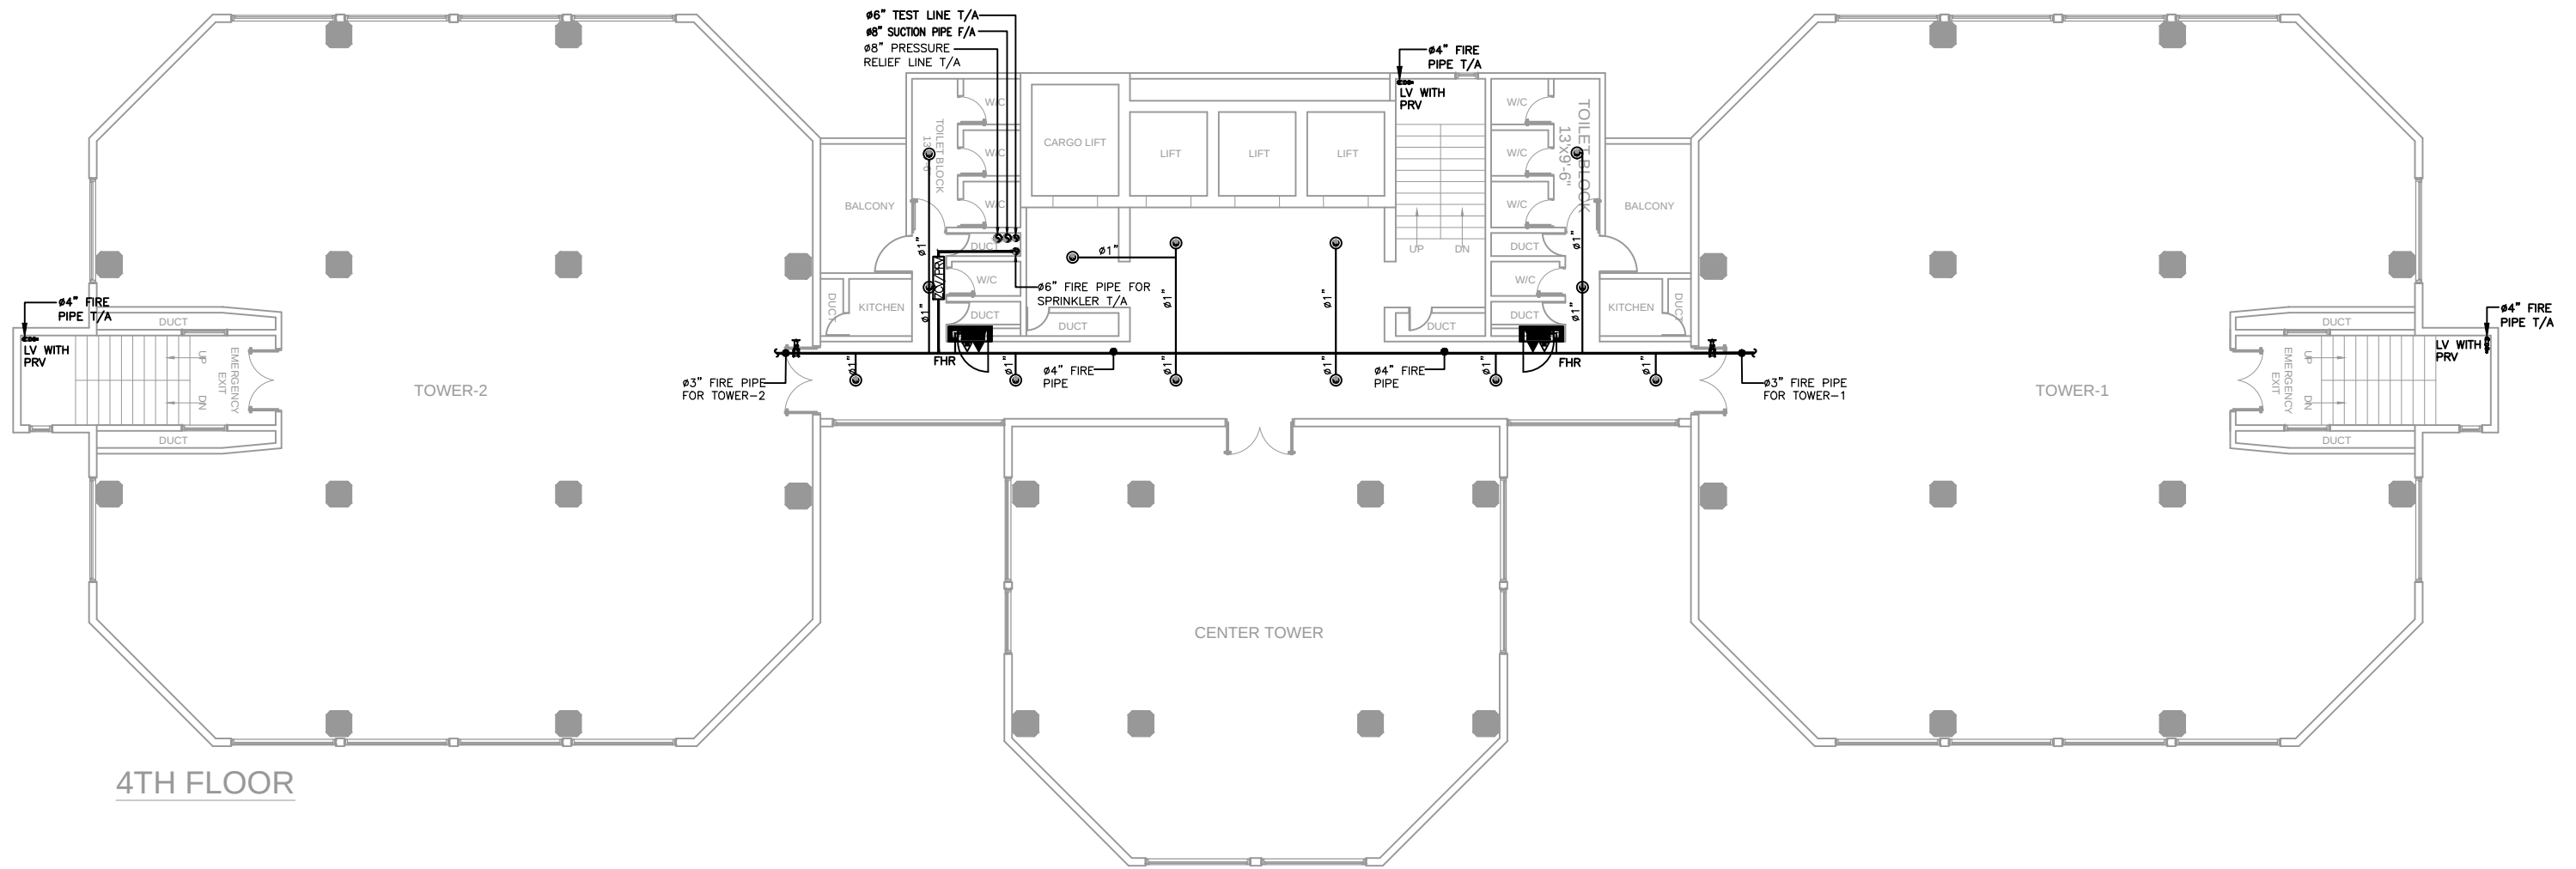

4TH FLOOR

CLIENT:-



CONSULTANT:



Nexus
Consulting
Office A-202, Second Floor, Blossom Trade Center Opposite NED University
University Road, SB-26, Block No.01 Gulistan-e-Jouhar, Karachi Pakistan
Phone: 021-37240670
Email: nexusconsultingcompany@gmail.com Web: www.Nexuscon.pk



PROJECT:-

STATE LIFE BUILDING NO.11

TITLE:-

FIRE PROTECTION SYSTEM
AT 4TH FLOOR

REV #	DATE	DESCRIPTION	CHK'D	APP'D	Project Ref:	DATE
00	02-07-2026	ISSUED FOR TENDER			.	JUNE.2026
					DRAWN BY A-A	SCALE 1/8" = 1'-0"
					CHECKED BY W-S	DWG. NO. F-10

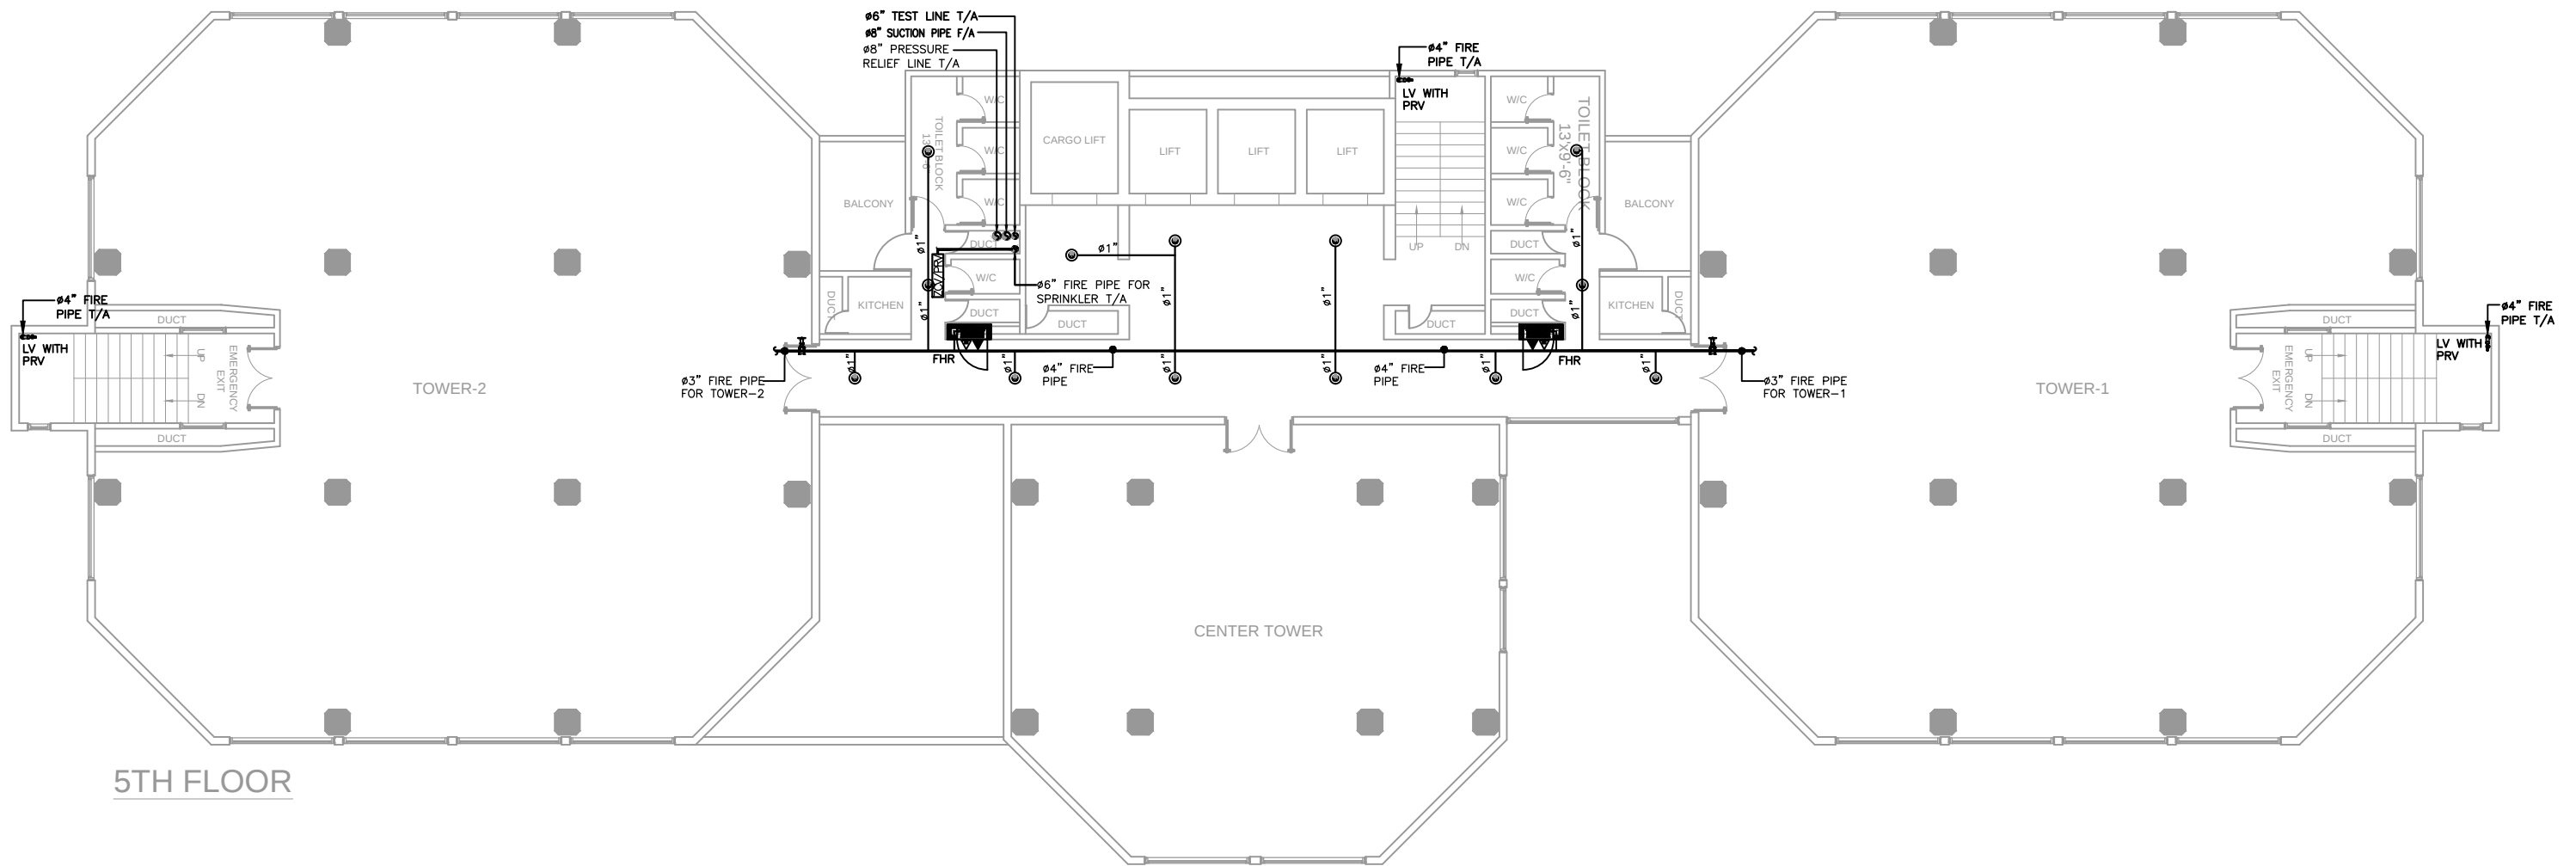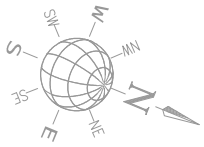

5TH FLOOR

CLIENT:-



CONSULTANT:



Nexus
Consulting

Office A-202, Second Floor, Blossom Trade Center Opposite NED University
University Road, SB-26, Block No.01 Gulistan-e-Jouhar, Karachi Pakistan
Phone: 021-37240670
Email: nexusconsultingcompany@gmail.com Web: www.Nexuscon.pk


PROJECT:-

STATE LIFE BUILDING NO.11

TITLE:-

FIRE PROTECTION SYSTEM
AT 5TH FLOOR

REV #	DATE	DESCRIPTION	CHK'D	APP'D	Project Ref:	DATE
00	02-07-2026	ISSUED FOR TENDER			.	JUNE.2026
					DRAWN BY A-A	SCALE 1/8" = 1'-0"
					CHECKED BY W-S	DWG. NO. FP-11

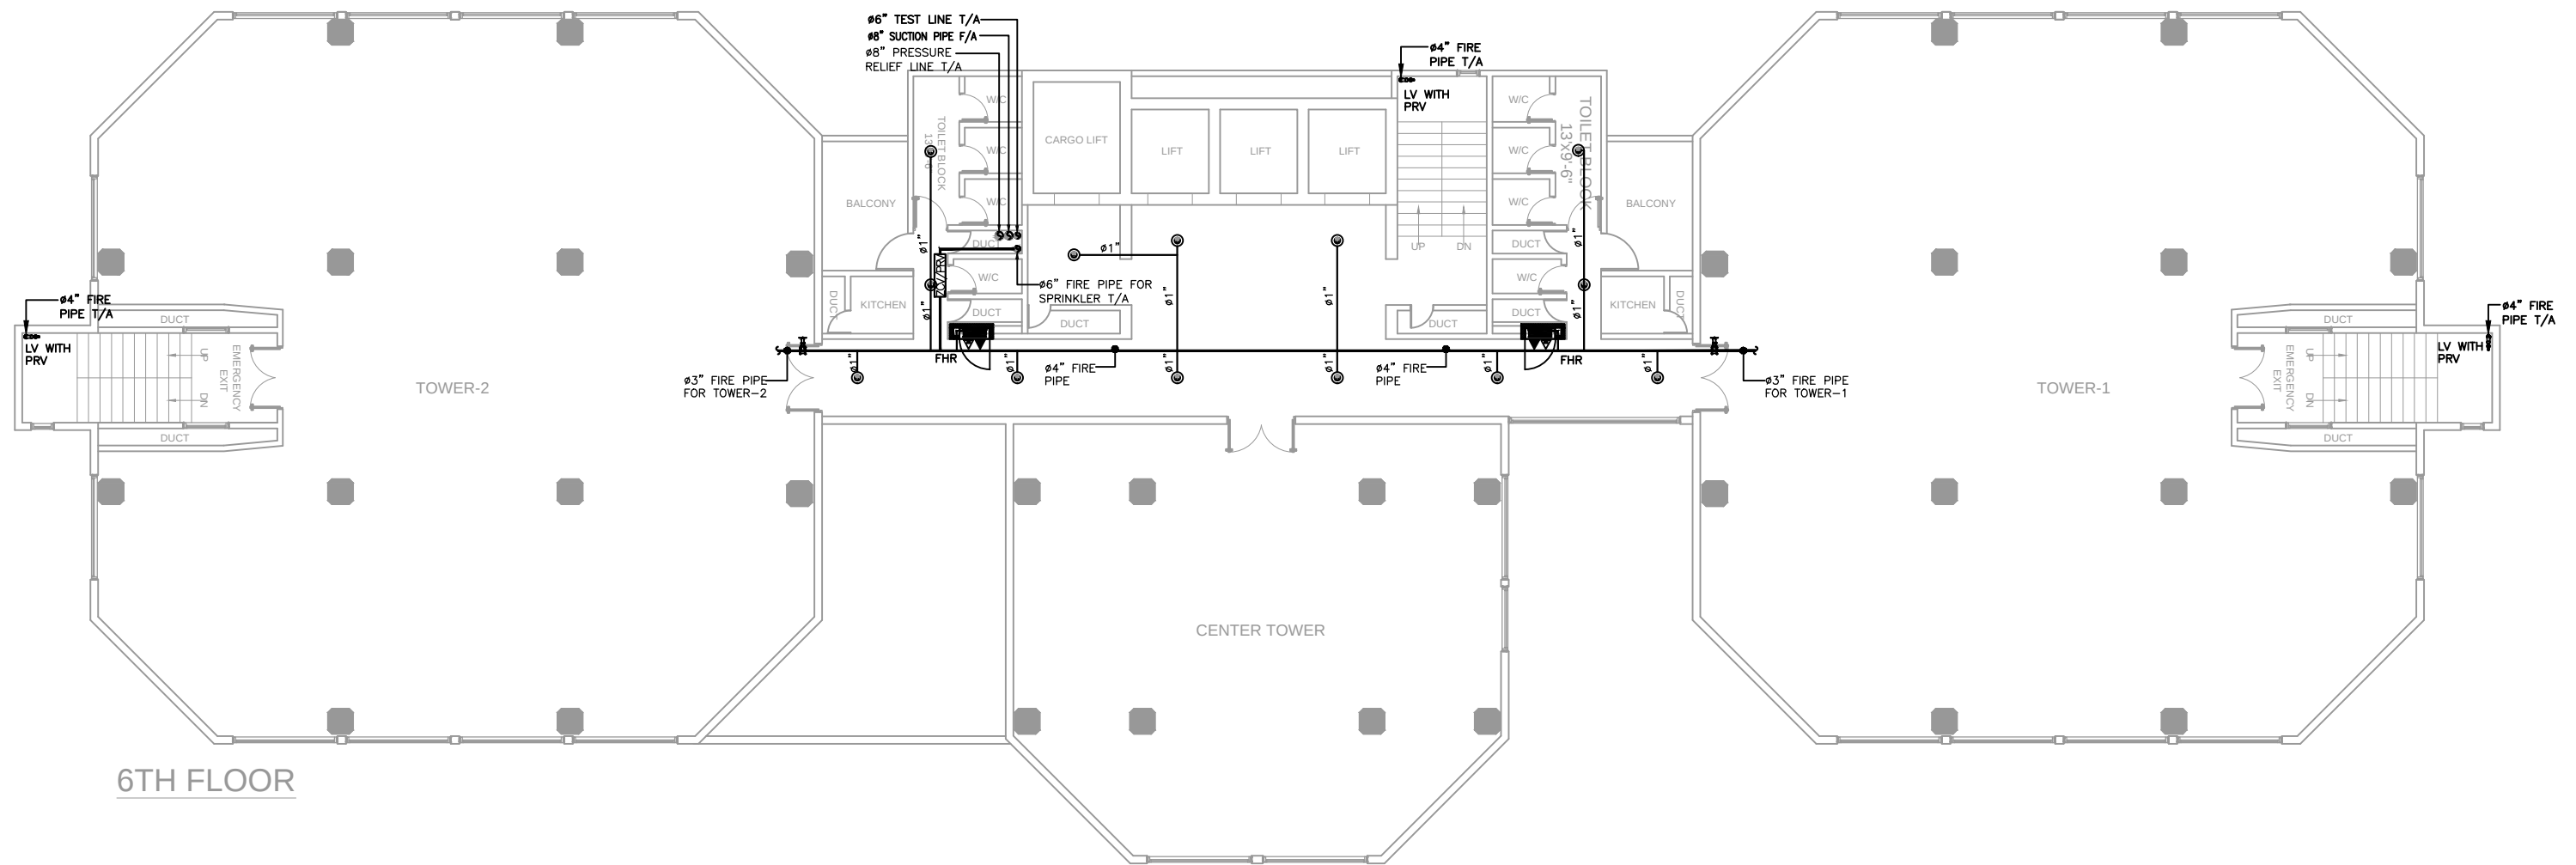

6TH FLOOR



STATE LIFE
INSURANCE CORPORATION OF PAKISTAN

Nexus
Consulting

STATE LIFE BUILDING NO.11

FIRE PROTECTION SYSTEM AT 6TH FLOOR

REV #	DATE	DESCRIPTION	CHK'D	APP'D	Project Ref:	DATE
00	02-07-2026	ISSUED FOR TENDER				JUNE.2026
					DRAWN BY A-A	SCALE 1/8" = 1'-0"
					CHECKED BY W-S	DWG. NO. FP-12

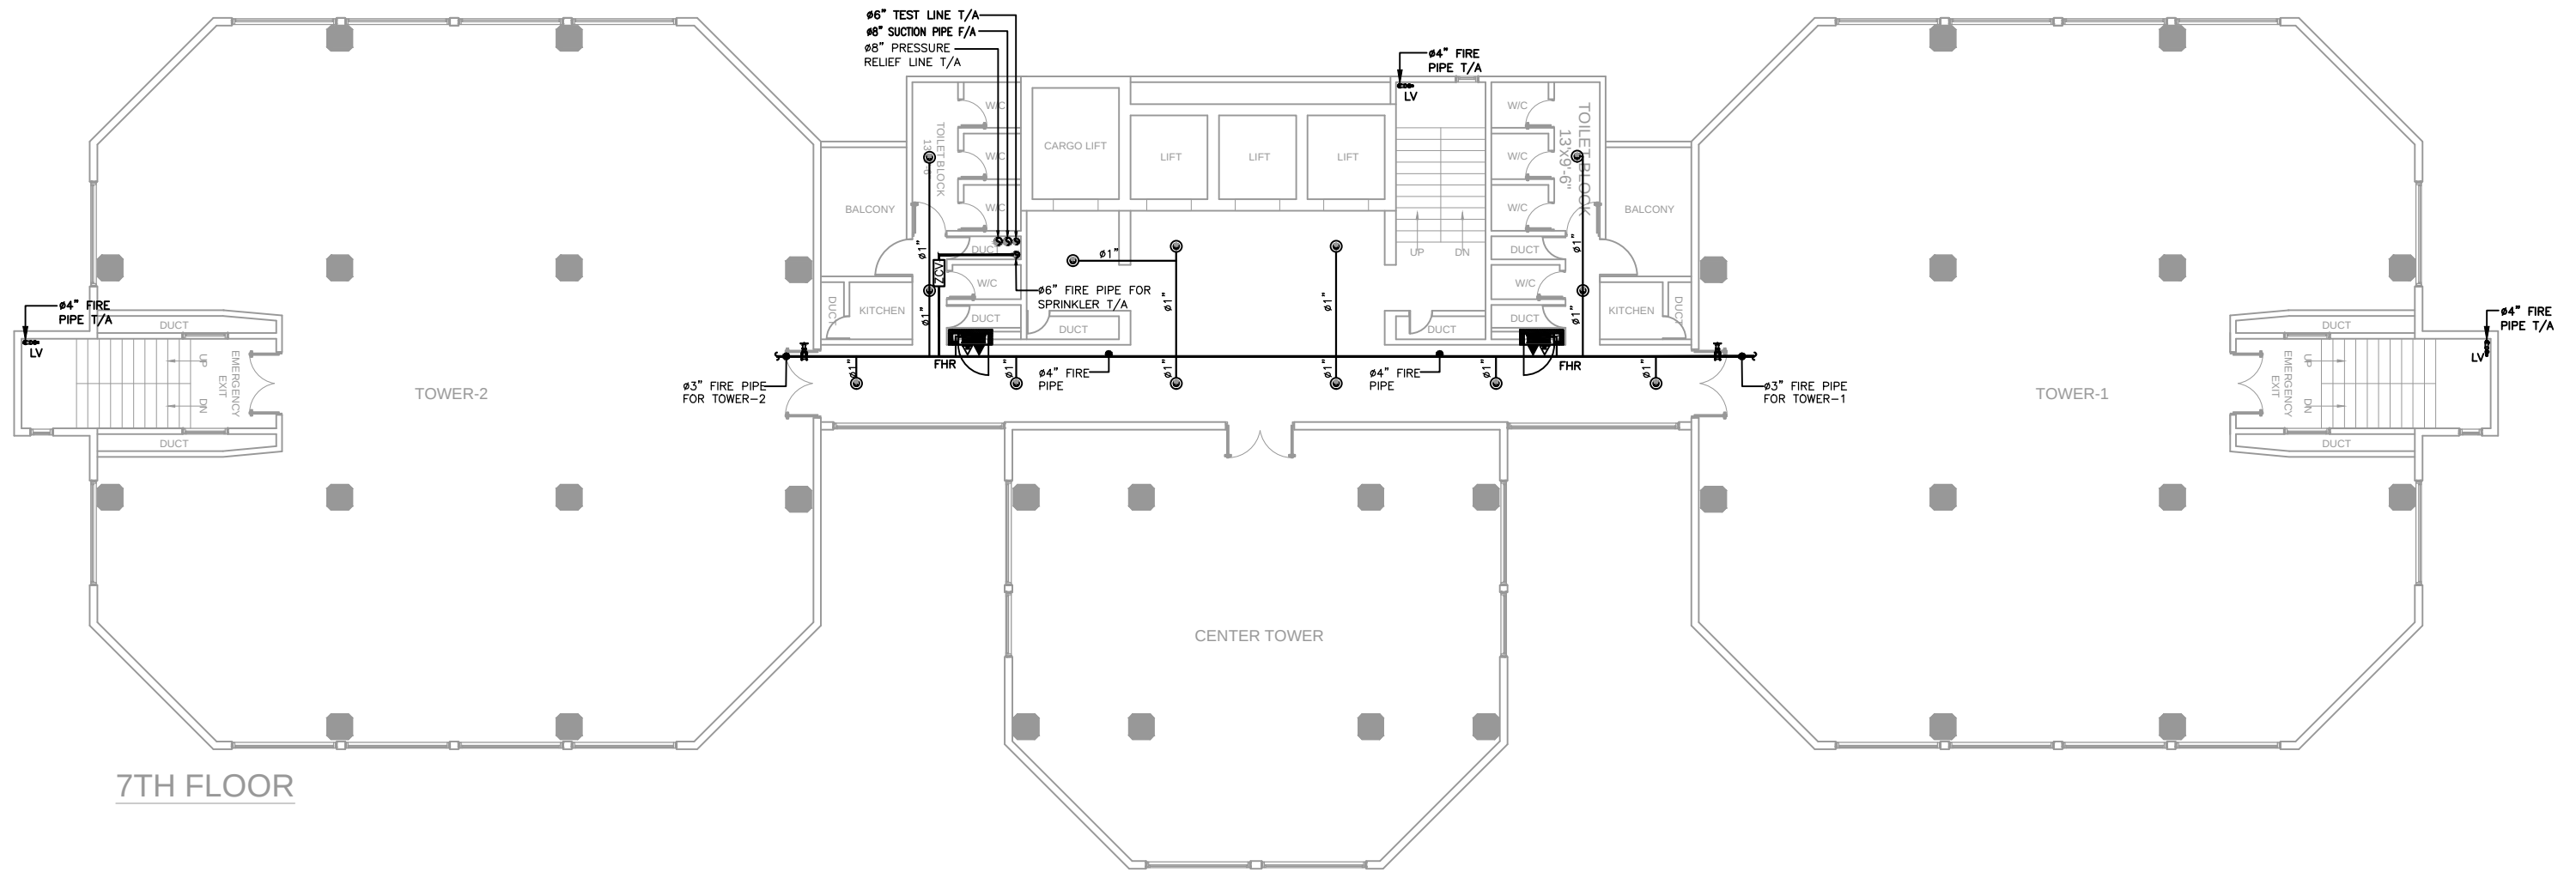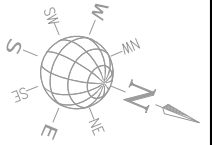

CLIENT:-



CONSULTANT:



Nexus
Consulting
Office A-202, Second Floor, Blossom Trade Center Opposite NED University
University Road, SB-26, Block No.01 Gulistan-e-Jouhar, Karachi Pakistan
Phone: 021-37240670
Email: nexusconsultingcompany@gmail.com Web: www.Nexuscon.pk


PROJECT:-

STATE LIFE BUILDING NO.11

TITLE:-

FIRE PROTECTION SYSTEM
AT 7TH FLOOR

REV #	DATE	DESCRIPTION	CHK'D	APP'D	Project Ref:	DATE
00	02-07-2026	ISSUED FOR TENDER				JUNE.2026
					DRAWN BY A-A	SCALE 1/8" = 1'-0"
					CHECKED BY W-S	DWG. NO. FP-13

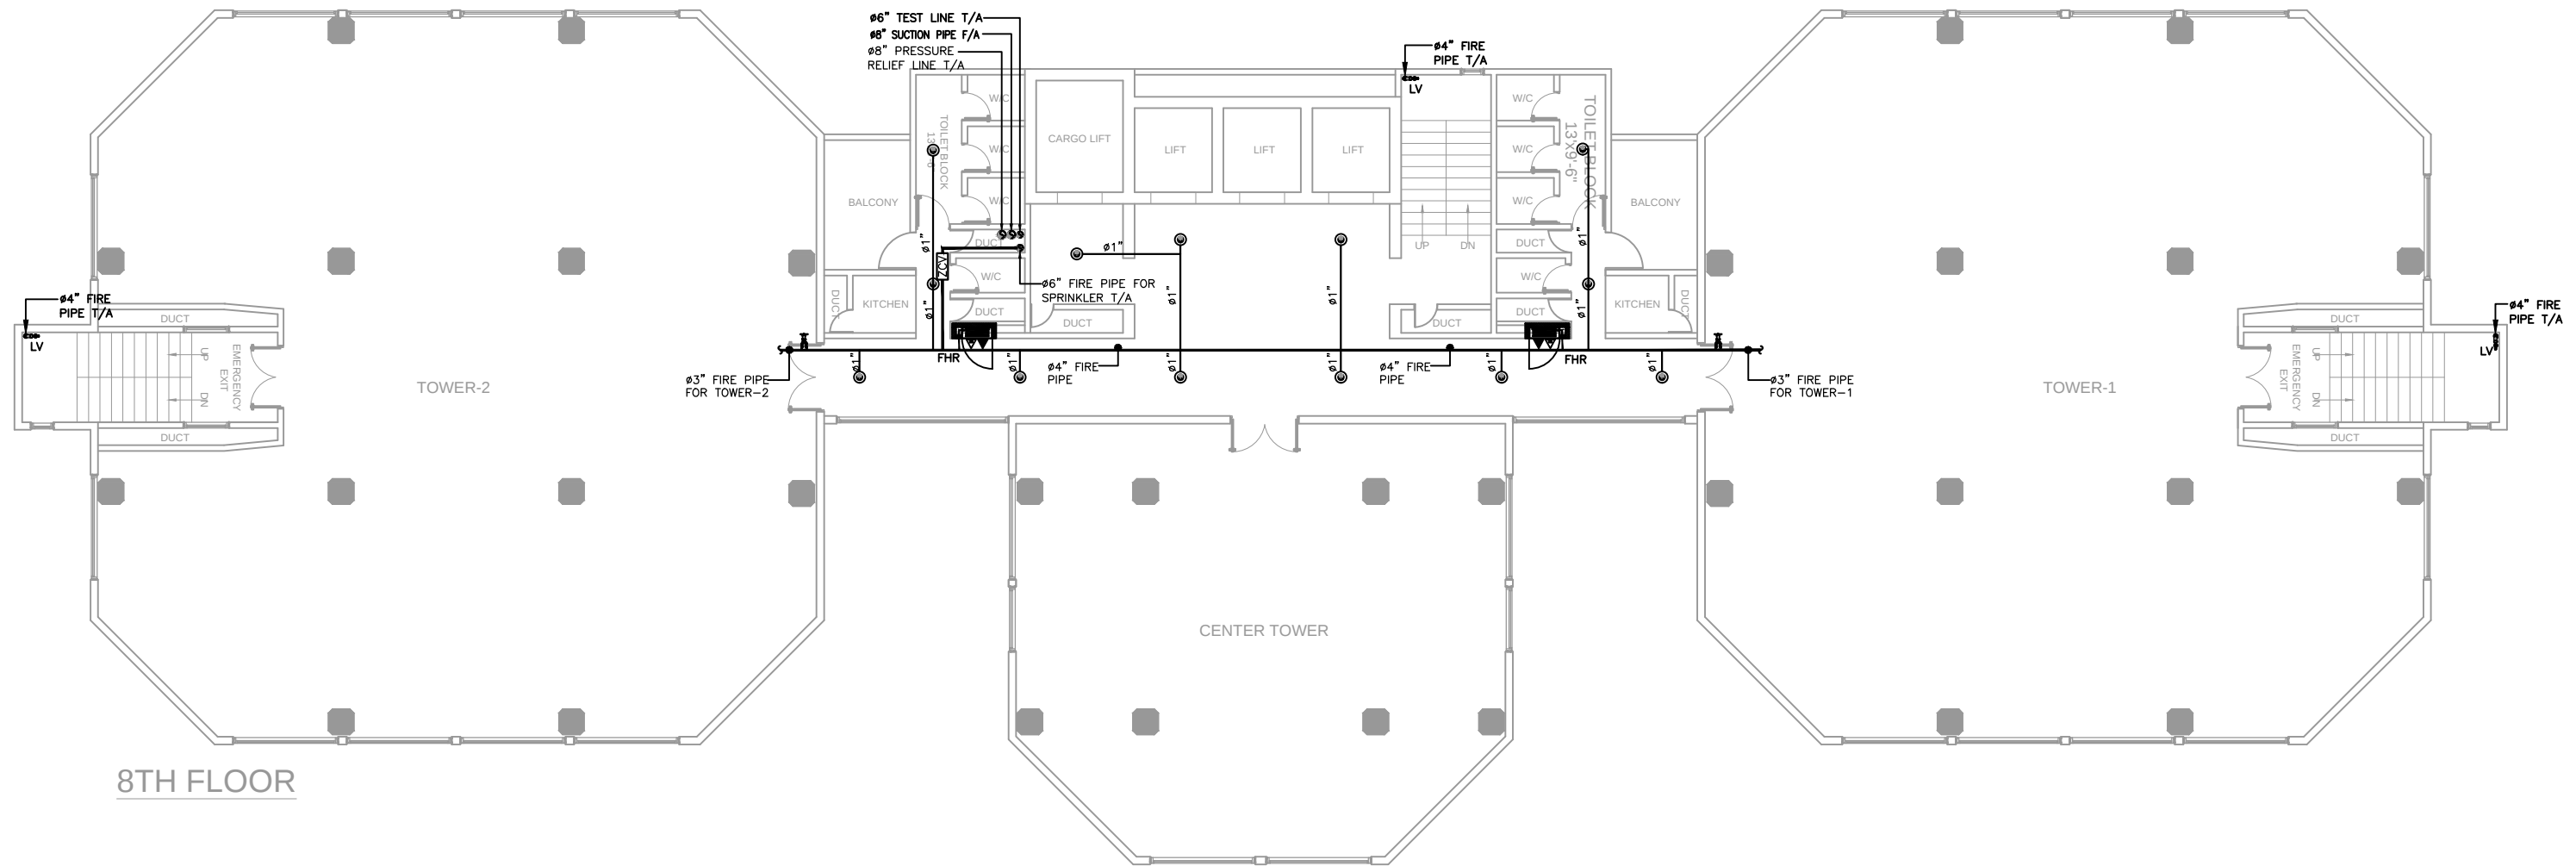

8TH FLOOR

CLIENT:-



CONSULTANT:



Nexus
Consulting
Office A-202, Second Floor, Blossom Trade Center Opposite NED University
University Road, SB-26, Block No.01 Gulistan-e-Jouhar, Karachi Pakistan
Phone: 021-37240670
Email: nexusconsultingcompany@gmail.com Web: www.Nexuscon.pk



PROJECT:-

STATE LIFE BUILDING NO.11

TITLE:-

FIRE PROTECTION SYSTEM
AT 8TH FLOOR

REV #	DATE	DESCRIPTION	CHK'D	APP'D	Project Ref:	DATE
00	02-07-2026	ISSUED FOR TENDER			.	JUNE.2026
					DRAWN BY A-A	SCALE 1/8" = 1'-0"
					CHECKED BY W-S	DWG. NO. FP-14

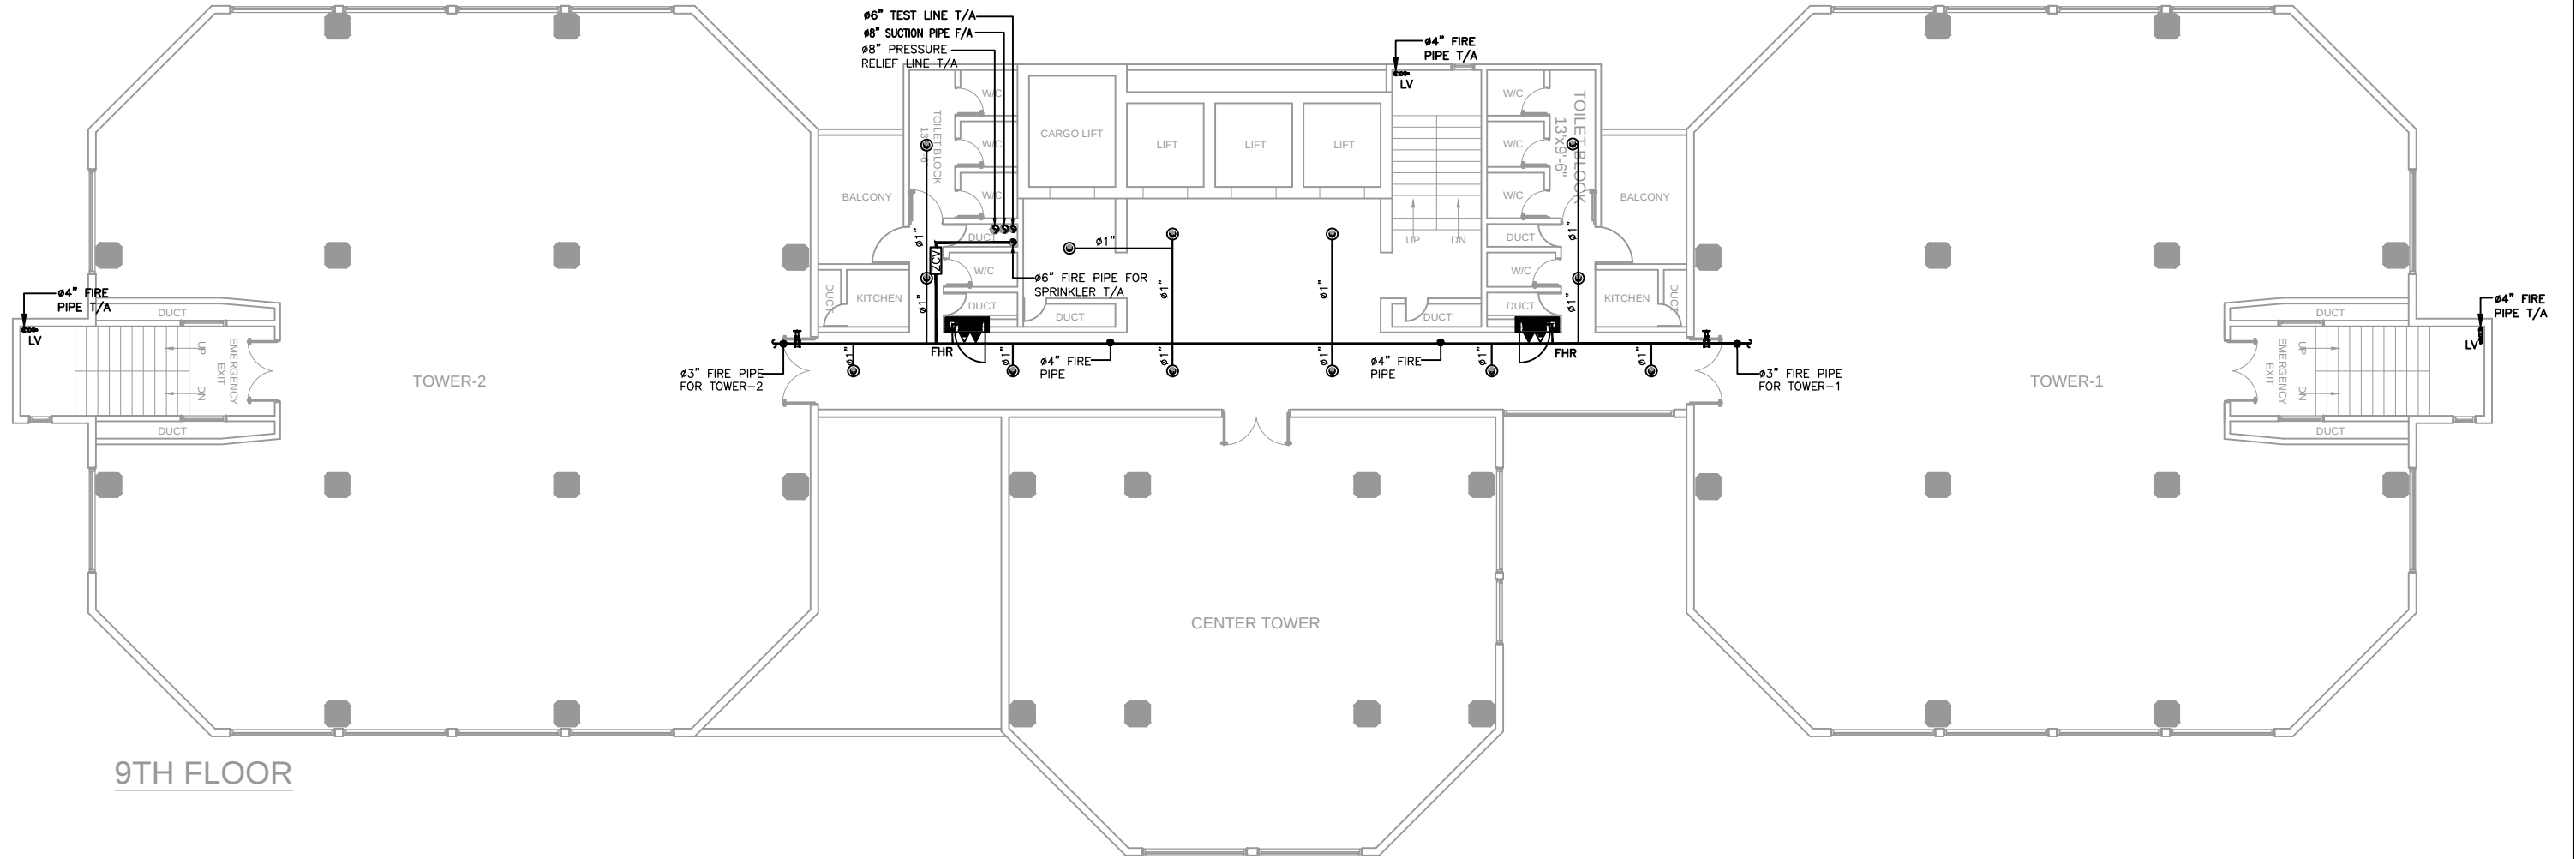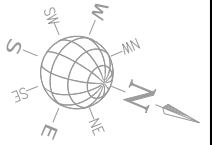

CLIENT:-



STATE LIFE
INSURANCE CORPORATION OF PAKISTAN

CONSULTANT:



Nexus
Consulting

Office A-202, Second Floor, Blossom Trade Center Opposite NED University
University Road, SB-26, Block No.01 Gulistan-e-Jouhar, Karachi Pakistan
Phone: 021-37240670
Email: nexusconsultingcompany@gmail.com Web: www.Nexuscon.pk



PROJECT:-

STATE LIFE BUILDING NO.11

TITLE:-

FIRE PROTECTION SYSTEM
AT 9TH FLOOR

REV #	DATE	DESCRIPTION	CHK'D	APP'D	Project Ref:	DATE
00	02-07-2026	ISSUED FOR TENDER			.	JUNE.2026
					DRAWN BY A-A	SCALE 1/8" = 1'-0"
					CHECKED BY W-S	DWG. NO. FP-15

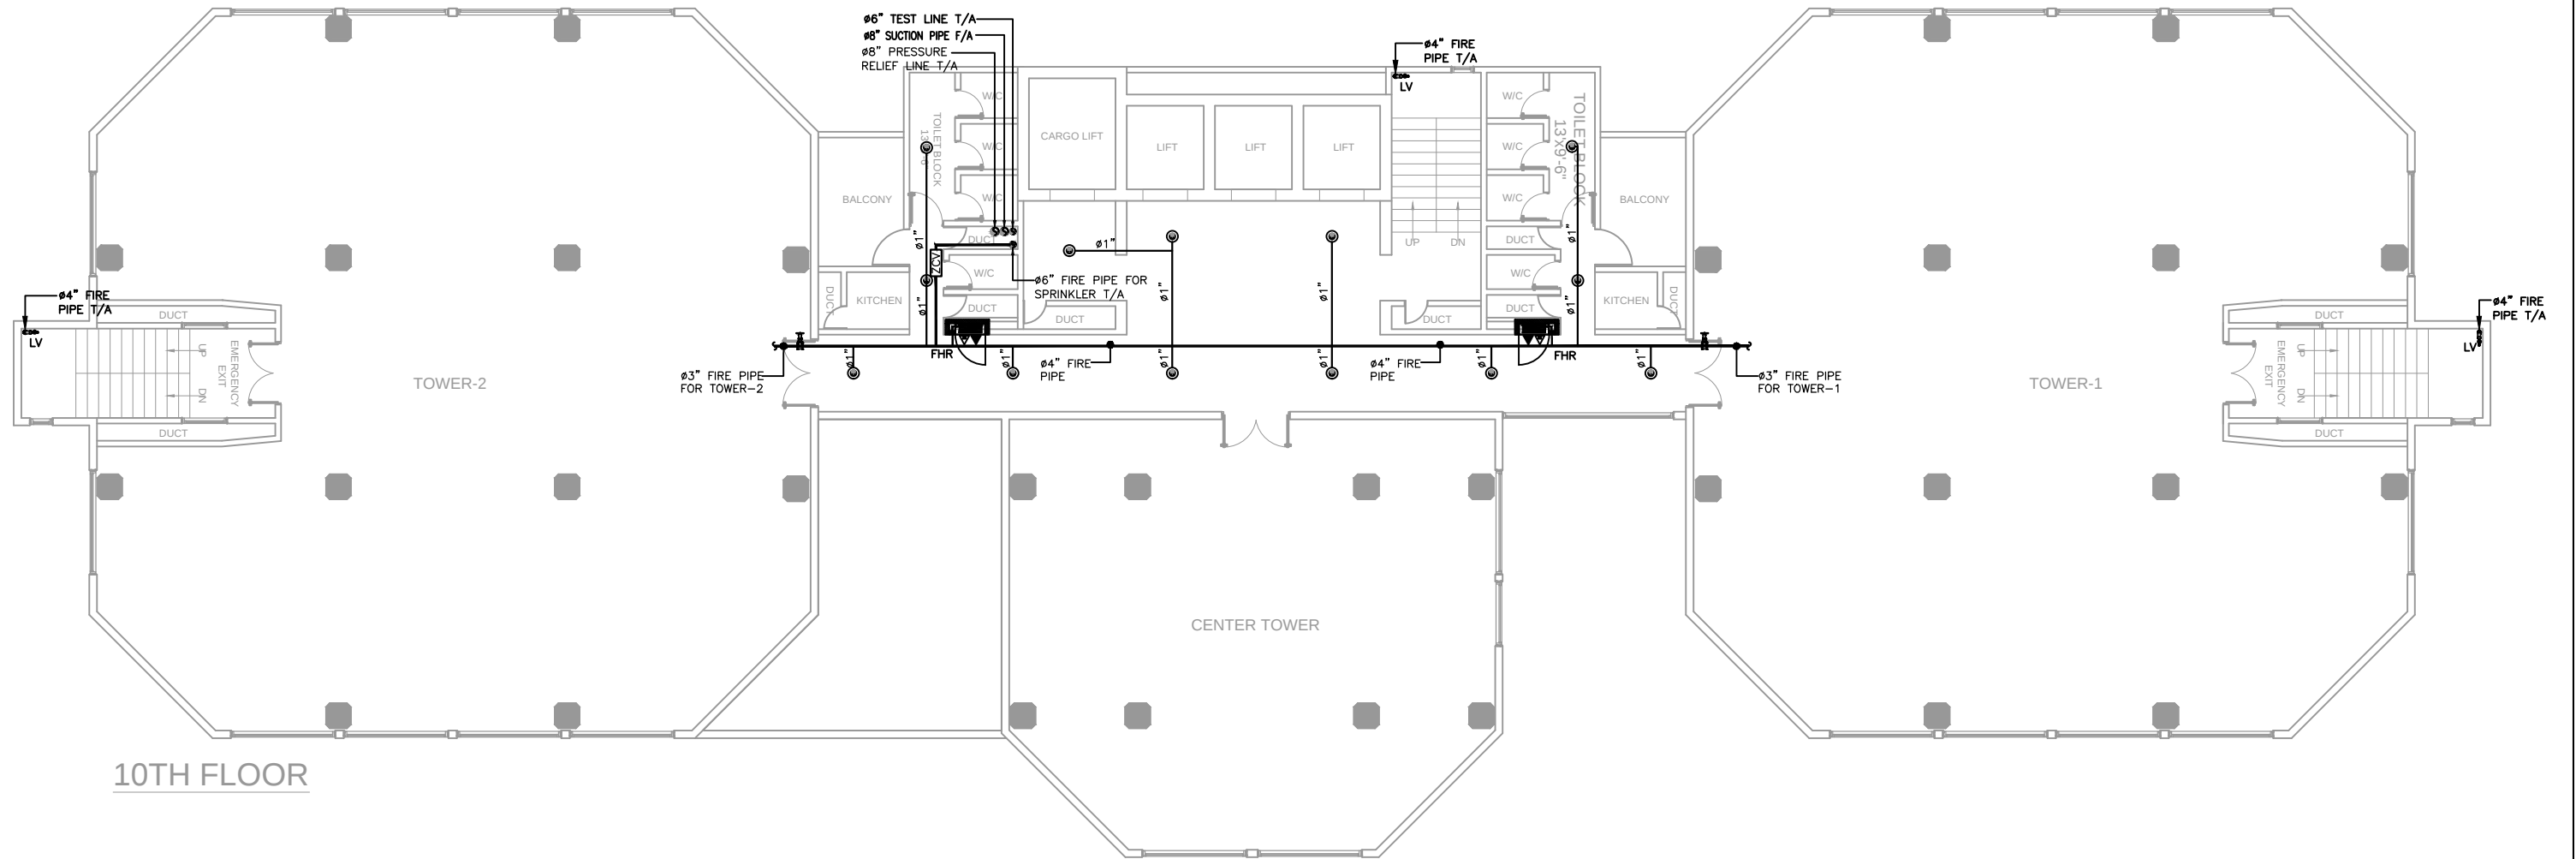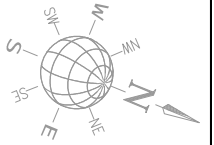

CLIENT:-



CONSULTANT:



Nexus
Consulting
Office A-202, Second Floor, Blossom Trade Center Opposite NED University
University Road, SB-26, Block No.01 Gulistan-e-Jouhar, Karachi Pakistan
Phone: 021-37240670
Email: nexusconsultingcompany@gmail.com Web: www.Nexuscon.pk


PROJECT:-

STATE LIFE BUILDING NO.11

TITLE:-

FIRE PROTECTION SYSTEM
AT 10TH FLOOR

REV #	DATE	DESCRIPTION	CHK'D	APP'D	Project Ref:	DATE
00	02-07-2026	ISSUED FOR TENDER			.	JUNE.2026
					DRAWN BY A-A	SCALE 1/8" = 1'-0"
					CHECKED BY W-S	DWG. NO. FP-16

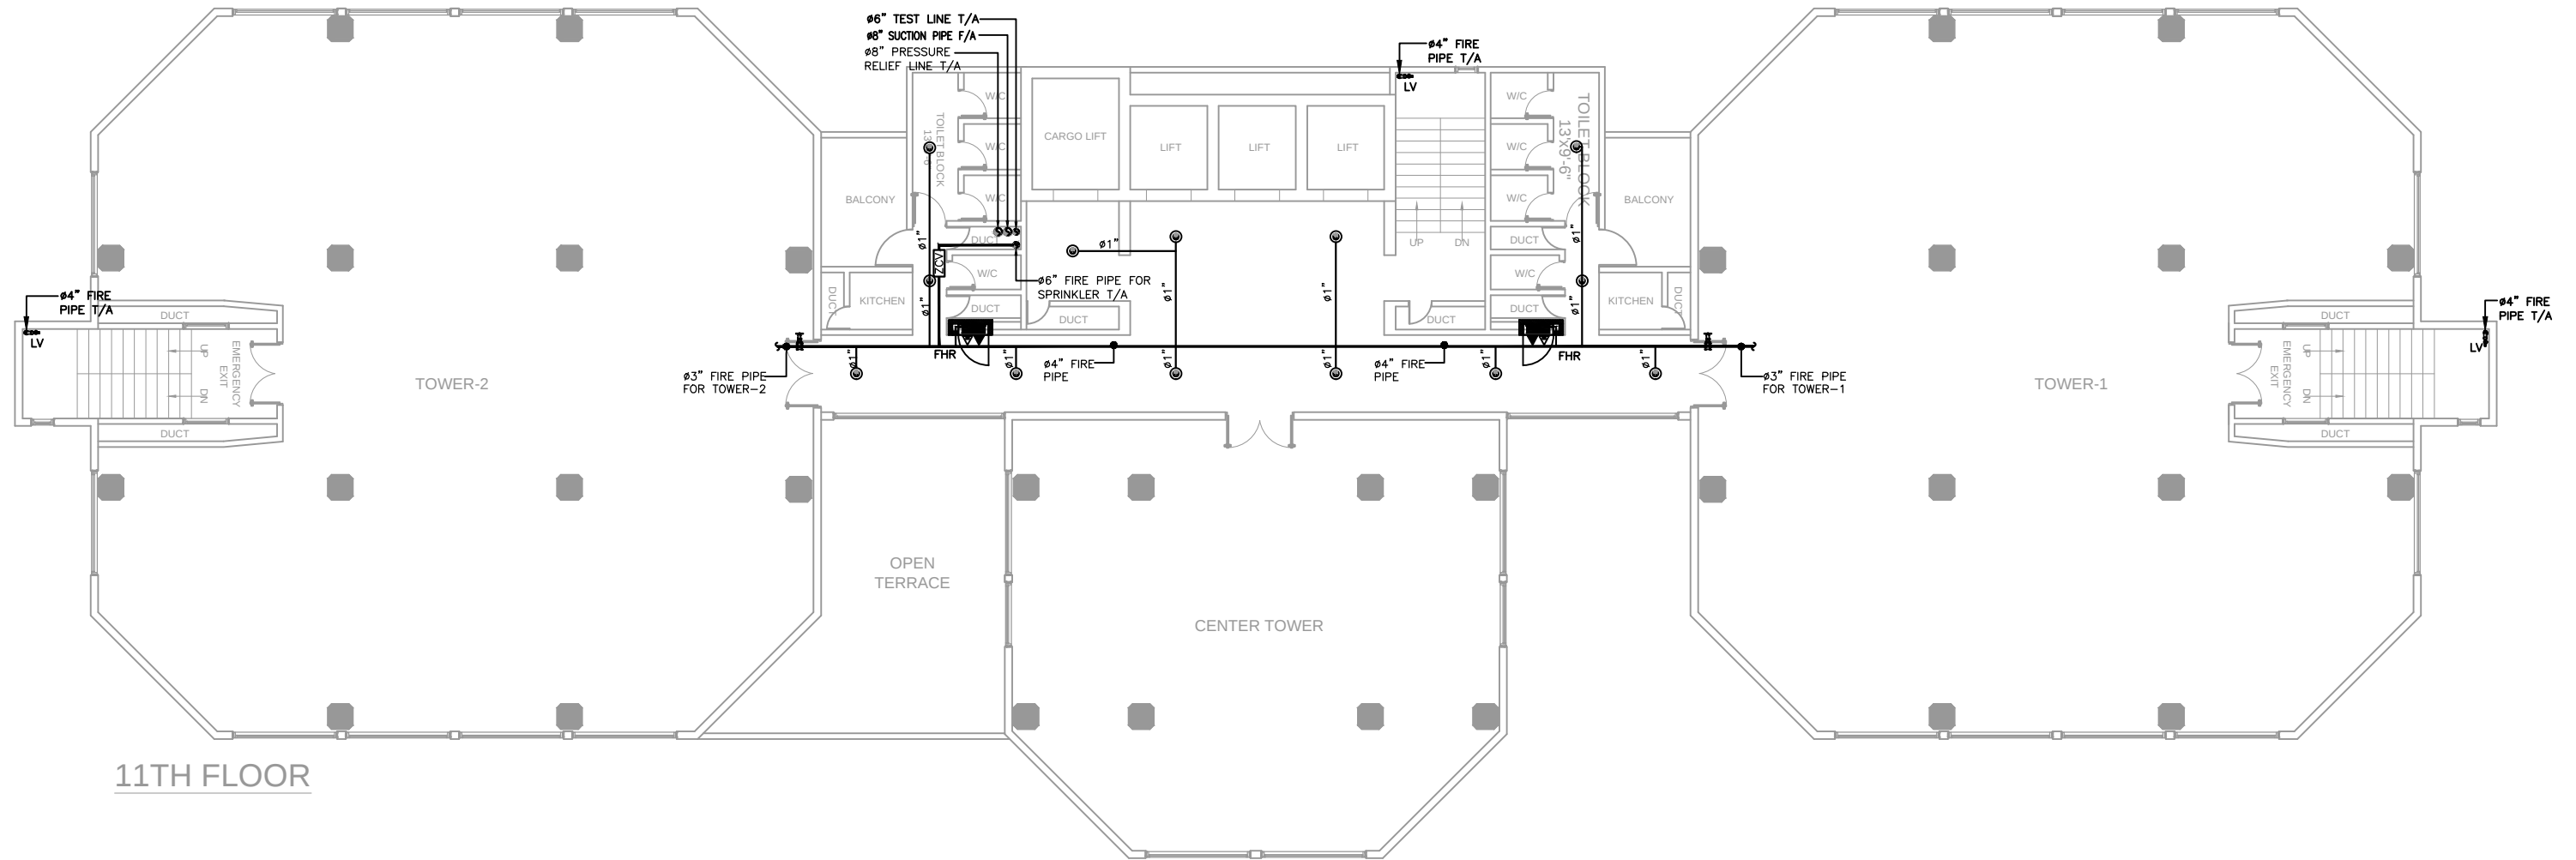

CLIENT:-



CONSULTANT:



Nexus
Consulting

Office A-202, Second Floor, Blossom Trade Center Opposite NED University
University Road, SB-26, Block No.01 Gulistan-e-Jouhar, Karachi Pakistan
Phone: 021-37240670
Email: nexusconsultingcompany@gmail.com Web: www.Nexuscon.pk


PROJECT:-

STATE LIFE BUILDING NO.11


TITLE:-

FIRE PROTECTION SYSTEM
AT 11TH FLOOR

REV #	DATE	DESCRIPTION	CHK'D	APP'D	Project Ref:	DATE
00	02-07-2026	ISSUED FOR TENDER				JUNE.2026
					DRAWN BY A-A	SCALE 1/8" = 1'-0"
					CHECKED BY W-S	DWG. NO. FP-17

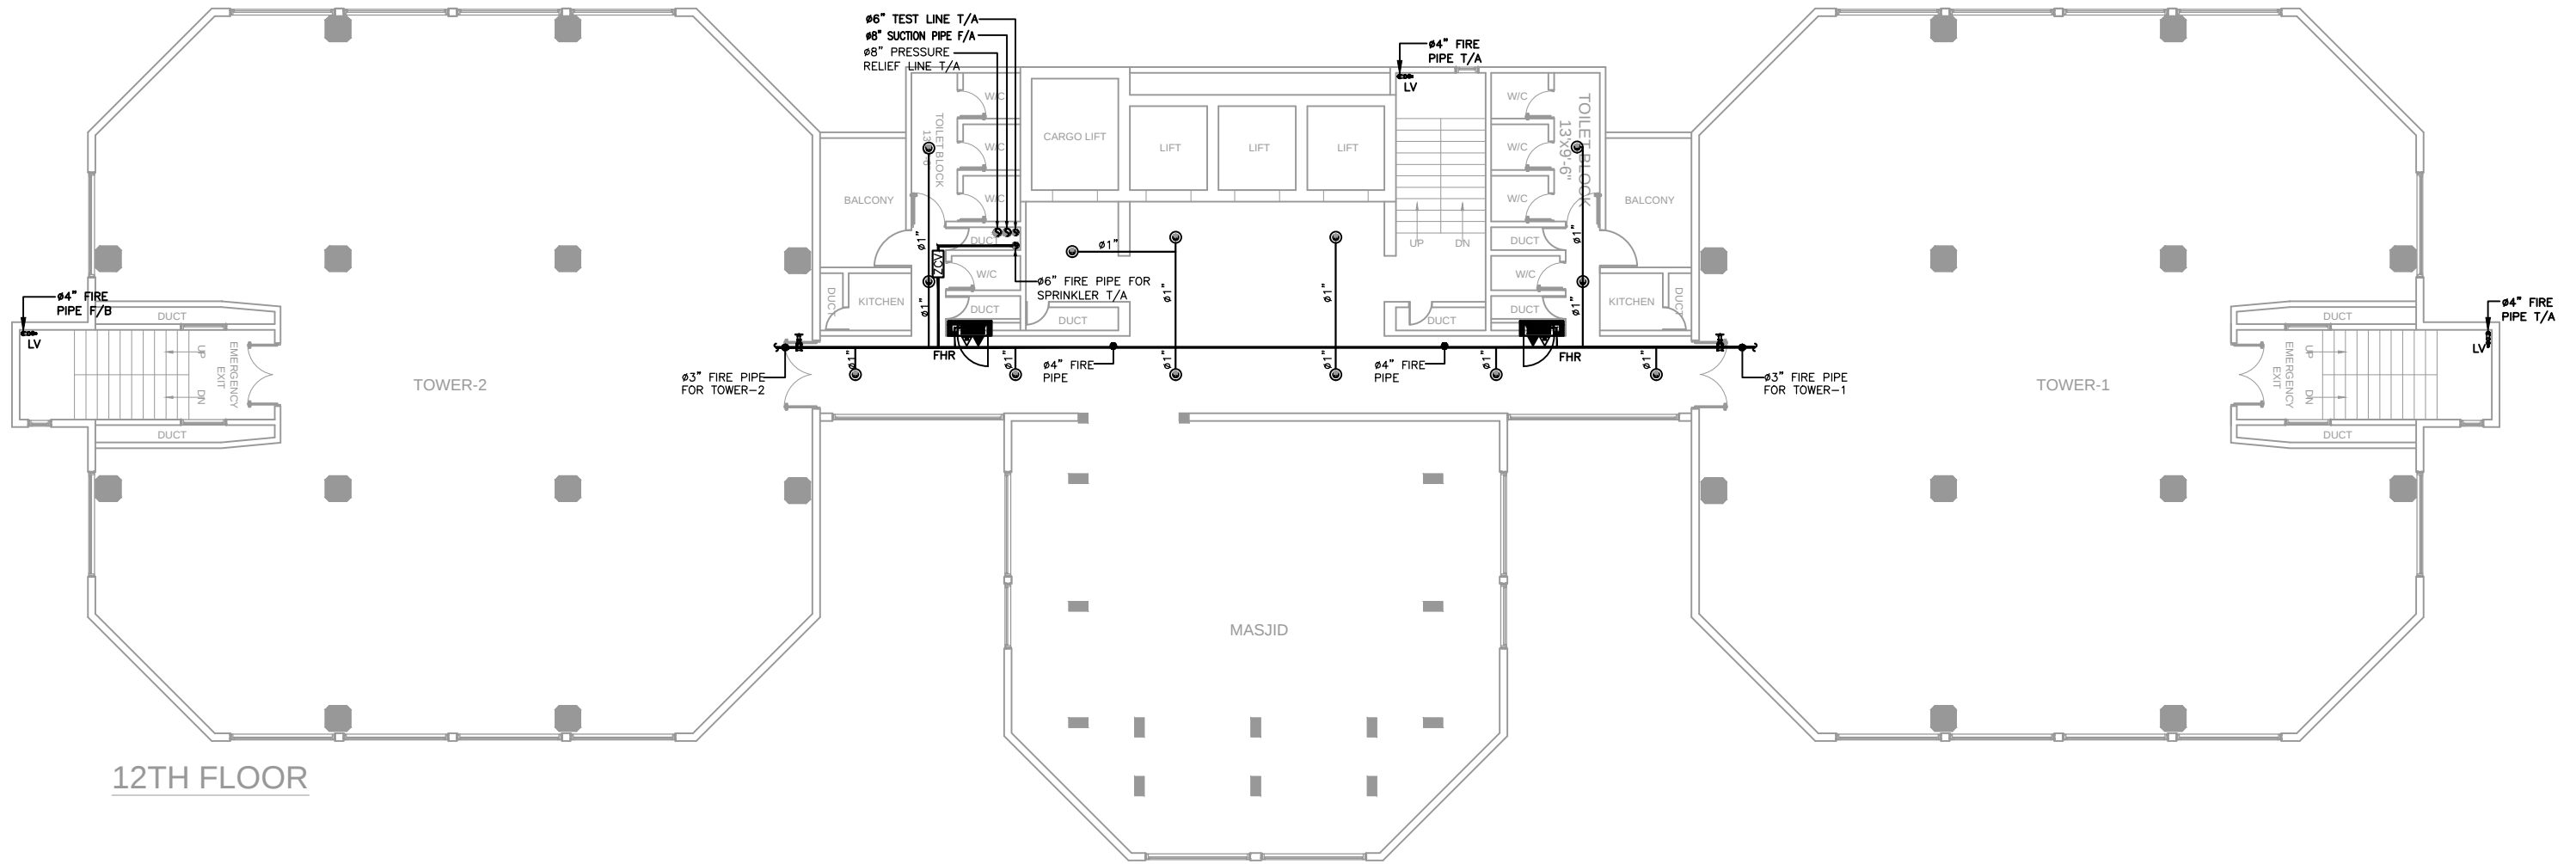

CLIENT:- 	CONSULTANT:  Nexus Consulting Office A-202, Second Floor, Blossom Trade Center Opposite NED University University Road, SB-26, Block No.01 Gulistan-e-Jouhar, Karachi Pakistan Phone: 021-37240670 Email: nexusconsultingcompany@gmail.com Web: www.Nexuscon.pk	PROJECT:- STATE LIFE BUILDING NO.11	TITLE:- FIRE PROTECTION SYSTEM AT 12TH FLOOR	REV #	DATE	DESCRIPTION	CHK'D	APP'D	Project Ref:	DATE
				00	02-07-2026	ISSUED FOR TENDER				JUNE.2026
									DRAWN BY A-A	SCALE 1/8" = 1'-0"
									CHECKED BY W-S	DWG. NO. FP-18

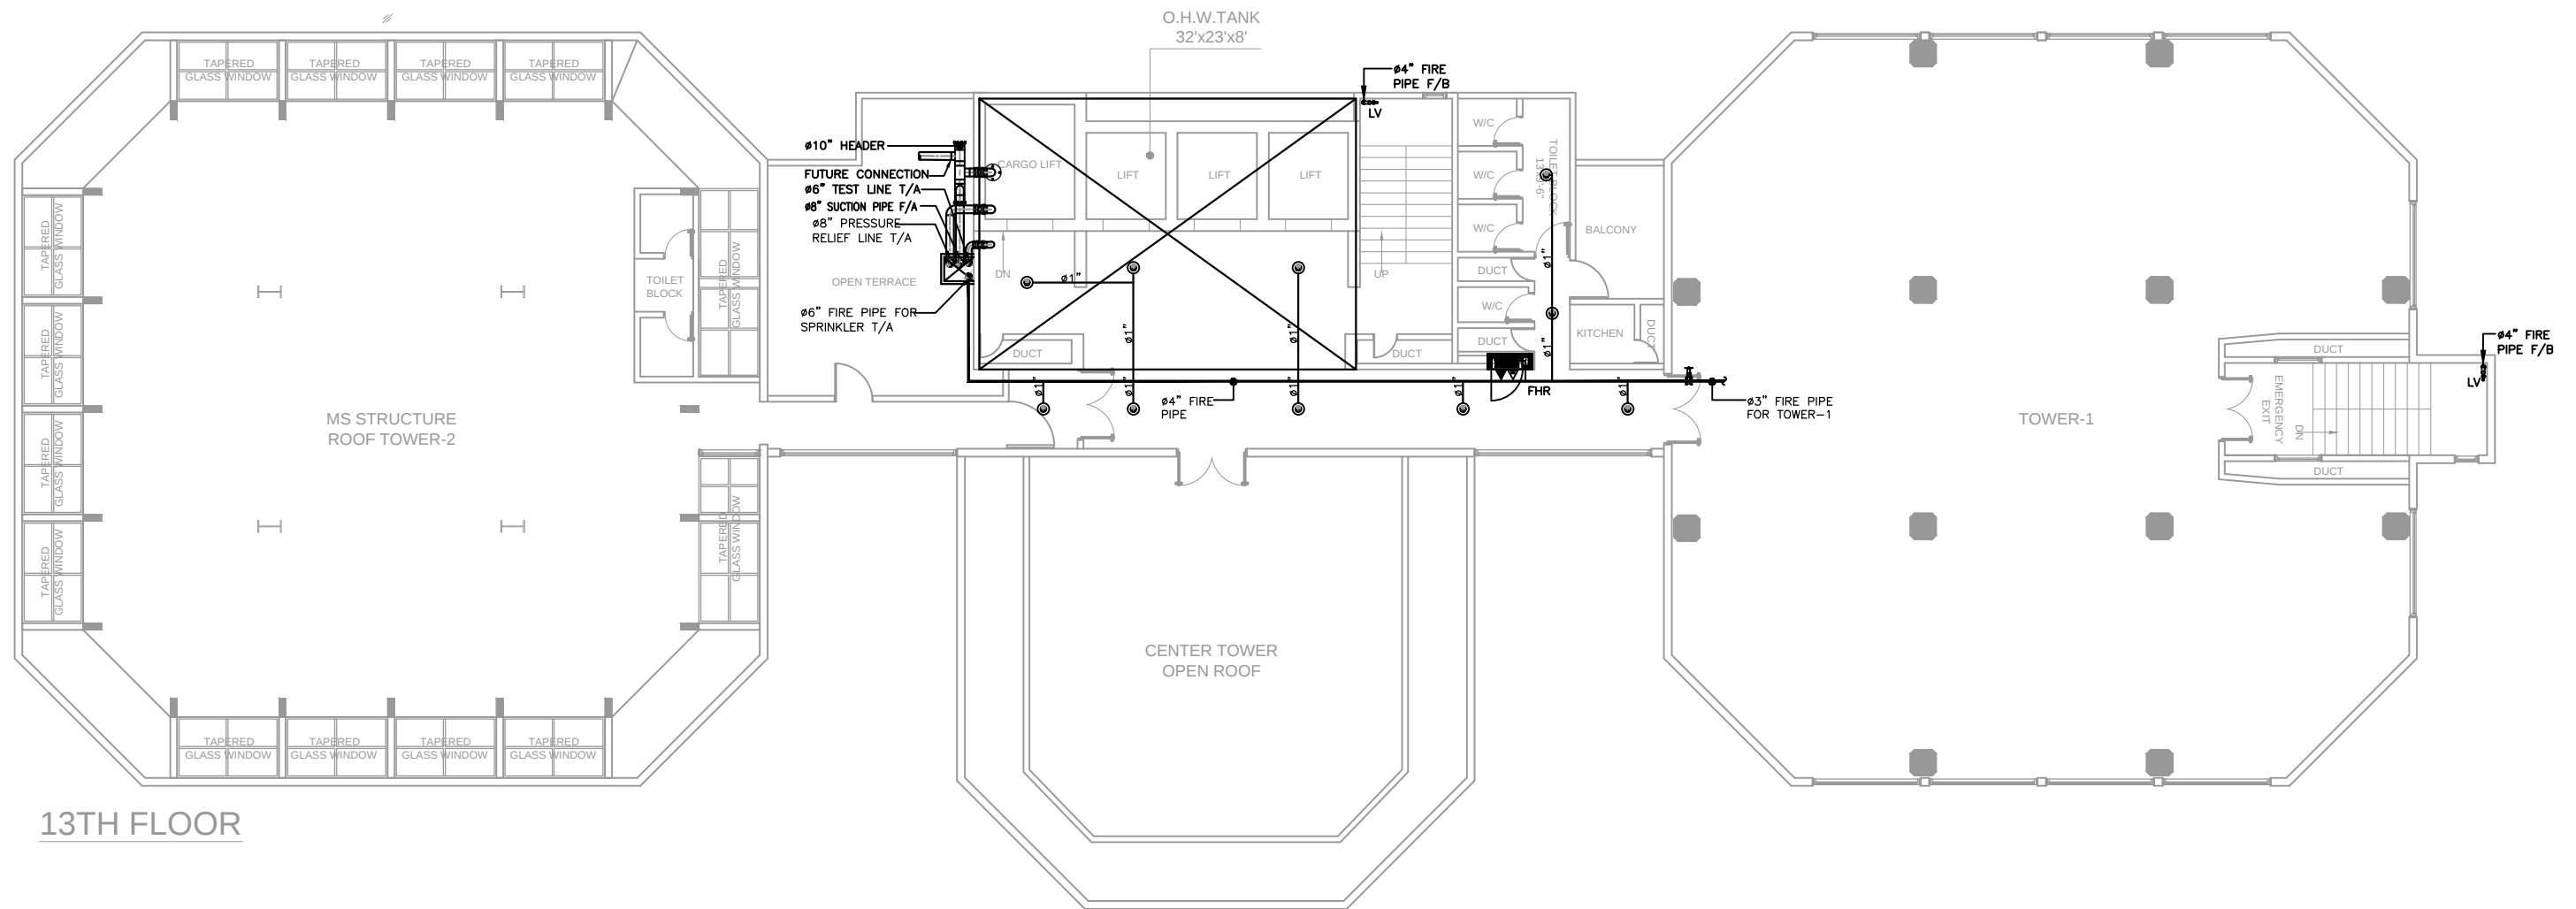

13TH FLOOR

CLIENT:-



CONSULTANT:



Nexus
Consulting
Office A-202, Second Floor, Blossom Trade Center Opposite NED University
University Road, SB-26, Block No.01 Gulistan-e-Jouhar, Karachi Pakistan
Phone: 021-37240670
Email: nexusconsultingcompany@gmail.com Web: www.Nexuscon.pk

PROJECT:-

STATE LIFE BUILDING NO.11

TITLE:-

FIRE PROTECTION SYSTEM
AT 13TH FLOOR

REV #	DATE	DESCRIPTION	CHK'D	APP'D	Project Ref:	DATE
00	02-07-2026	ISSUED FOR TENDER				JUNE.2026
					DRAWN BY A-A	SCALE 1/8" = 1'-0"
					CHECKED BY W-S	DWG. NO. FP-19