

STATE LIFE BUILDING NO.11

FIRE ALARM SYSTEM DRAWINGS TENDER DRAWING

CLIENT:



CONSULTANT:



DWG NO.	SHEET NO.	INDEX	DRAWING TITLE	REV NO.
FIRE ALARM SYSTEM WORK				
FA-01	01 OF 01	-	ELECTRICAL LIST OF DRAWINGS	00
FA-02	01 OF 01	-	GENERAL NOTES FIRE ALARM SYSTEM	00
FA-03	01 OF 01	-	GENERAL FIRE ALARM SYSTEM DETAIL	00
FA-04	01 OF 01	-	FIRE ALARM SYSTEM LOWER BASEMENT	00
FA-05	01 OF 01	-	FIRE ALARM SYSTEM UPPER BASEMENT	00
FA-06	01 OF 01	-	FIRE ALARM SYSTEM GROUND FLOOR	00
FA-07	01 OF 01	-	FIRE ALARM SYSTEM MEZZANINE FLOOR	00
FA-08	01 OF 01	-	FIRE ALARM SYSTEM SECOND FLOOR	00
FA-09	01 OF 01	-	FIRE ALARM SYSTEM THIRD FLOOR	00
FA-10	01 OF 01	-	FIRE ALARM SYSTEM FOURTH FLOOR	00
FA-11	01 OF 01	-	FIRE ALARM SYSTEM FIFTH FLOOR	00
FA-12	01 OF 01	-	FIRE ALARM SYSTEM SIXTH FLOOR	00
FA-13	01 OF 01	-	FIRE ALARM SYSTEM SEVENTH FLOOR	00
FA-14	01 OF 01	-	FIRE ALARM SYSTEM EIGHT FLOOR	00
FA-15	01 OF 01	-	FIRE ALARM SYSTEM NINTH FLOOR	00
FA-16	01 OF 01	-	FIRE ALARM SYSTEM TENTH FLOOR	00
FA-17	01 OF 01	-	FIRE ALARM SYSTEM ELEVENTH FLOOR	00
FA-18	01 OF 01	-	FIRE ALARM SYSTEM TWELVETH FLOOR	00
FA-19	01 OF 01	-	FIRE ALARM SYSTEM THIRTEENTH FLOOR	00
FA-20	01 OF 01	-	FIRE ALARM SYSTEM RISER	00

CLIENT:-



CONSULTANT:



Nexus Consulting
Office A-202, Second Floor, Blossom Trade Center Opposite NED University
University Road, SB-26, Block No.01 Gulistan-e-Jouhar, Karachi Pakistan
Phone: 021-37240670
Email: nexusconsultingcompany@gmail.com Web: www.Nexuscon.pk

PROJECT:-

STATE LIFE BUILDING NO.11

TITLE:-

ELECTRICAL LIST
OF DRAWINGS

REV #	DATE	DESCRIPTION	CHK'D	APP'D	Project Ref:	DATE
					.	JUNE. 2026
					DRAWN BY HASSAN KHAN	SCALE AS SHOWN
					CHECKED BY WAQAS SHAHAB	DWG. NO. FA-01

GENERAL NOTES – ADDRESSABLE FIRE ALARM SYSTEM

1. The fire alarm system shall be a fully addressable, intelligent fire detection and alarm system.
2. All equipment, materials, and installation shall comply with the project specifications, applicable local authority requirements, and the latest editions of NFPA 72 and other relevant codes and standards.
3. The contractor shall submit shop drawings, product data, wiring diagrams, and flow chart for approval before installation.
4. All fire alarm equipment shall be listed and approved by the relevant certification authority and shall be supplied by a single manufacturer.
5. The contractor shall verify all field dimensions and site conditions before commencing installation.
6. Device locations shown on the drawings are approximate and shall be coordinated with architectural, structural, mechanical, and electrical services.
7. Fire alarm cables shall be installed in conduit as specified and shall be separated from power cables in accordance with applicable codes.
8. All addressable devices shall have unique addresses and shall be clearly labeled for identification.
9. Smoke detectors shall not be installed until construction activities that generate dust are complete.
10. Manual Call Points (MCPs), smoke detectors, sounders, and other devices shall be installed at the locations shown on the approved drawings and in accordance with the manufacturer's recommendations.
11. All cable terminations shall be properly identified and tested before commissioning.
12. The fire alarm control panel shall continuously monitor all initiating devices, notification appliances, communication loops, and power supplies for alarm, fault, and supervisory conditions.
13. Interface modules(I/O Device) shall be provided where required for monitoring and controlling other building systems, including HVAC, elevators, generators, fire pumps, sprinkler systems, and other life safety equipment.
14. Each tenant shall install an individual fire alarm system. The tenant fire alarm system shall be interfaced with the building Fire Alarm Control Panel (FACP) in accordance with the approved drawings and project specifications.
15. The contractor shall perform complete testing, commissioning, and programming of the fire alarm system before handover.
16. Upon completion, the contractor shall provide as-built drawings, operation and maintenance manuals, test reports, and user training.
17. All installations shall be inspected and approved by the Engineer and the relevant authority before occupancy.
18. The contractor shall provide all accessories, mounting hardware, junction boxes, and interface modules required for a complete and fully operational system, whether specifically shown on the drawings or not.
19. The fire alarm system shall remain fully operational during a power failure through standby batteries sized in accordance with NFPA 72 and the manufacturer's recommendations. In addition, the fire alarm control panel shall be provided with an uninterruptible power supply (UPS) backup to ensure continuous operation.
20. All circuits shall be tested for continuity, insulation resistance, and correct polarity before energizing the system.
21. Any deviations from the approved drawings or specifications shall require written approval from the Engineer before implementation.

CLIENT:-



CONSULTANT:







PROJECT:-

STATE LIFE BUILDING NO.11

TITLE:-

GENERAL NOTES
FIRE
ALARM SYSTEM

REV #	DATE	DESCRIPTION	CHK'D	APP'D	Project Ref:	DATE
						JUNE, 2026
					DRAWN BY HASSAN KHAN	SCALE AS SHOWN
					CHECKED BY WAQAS SHAHAB	DWG. NO. FA-02

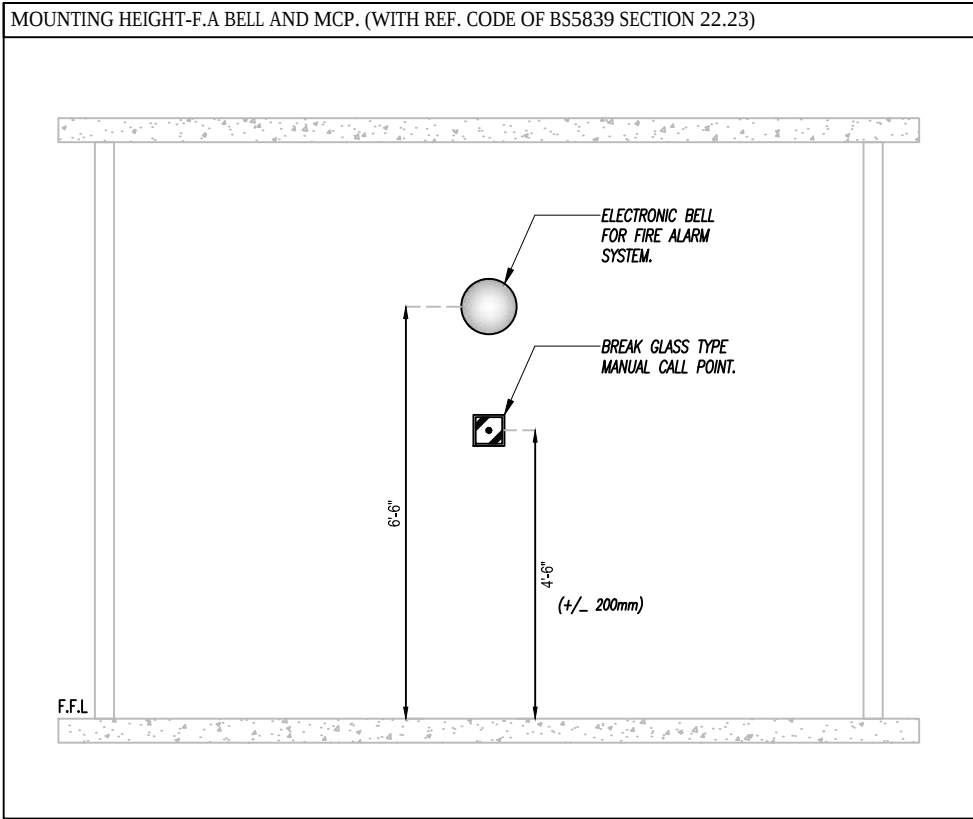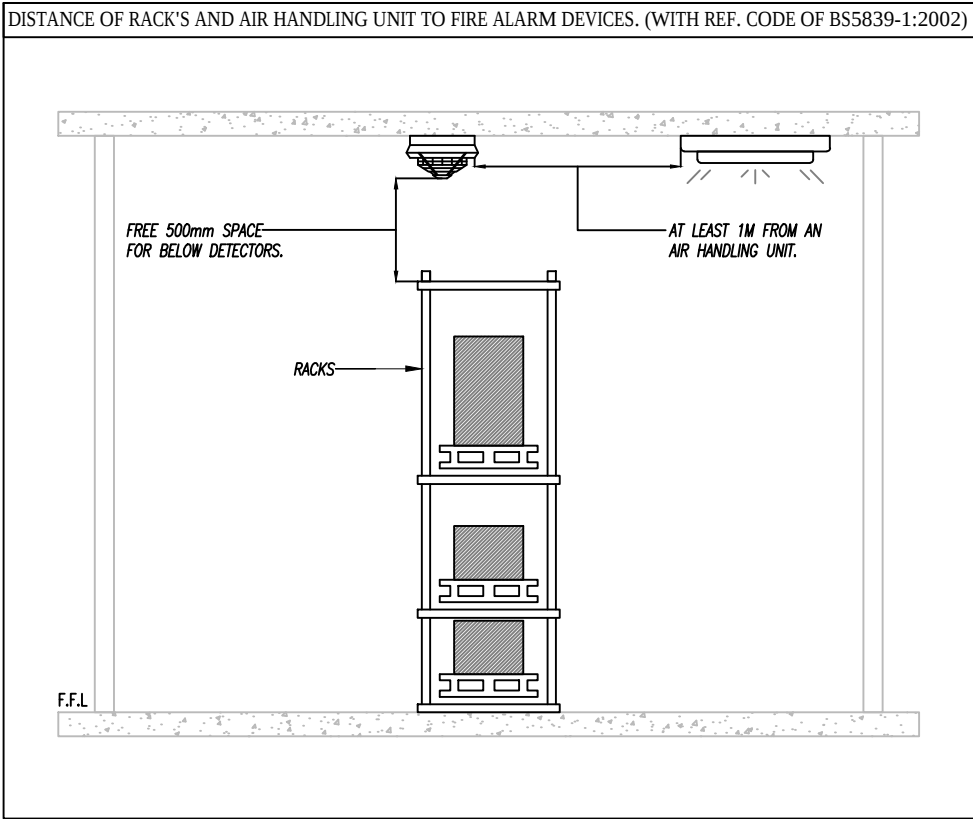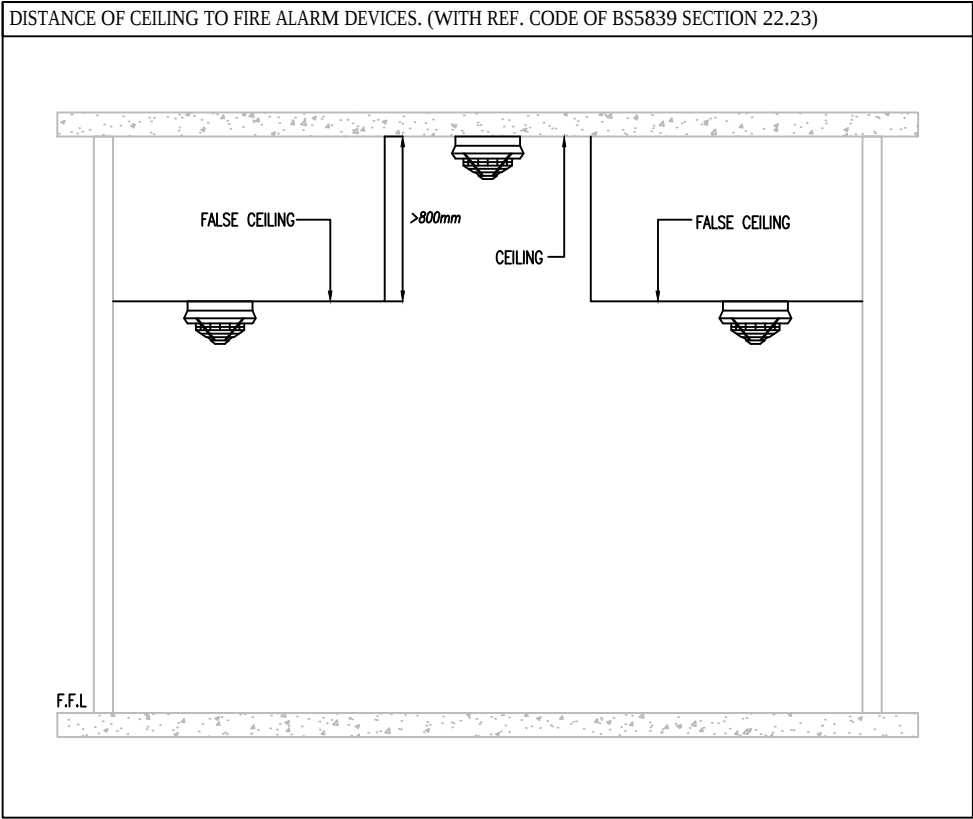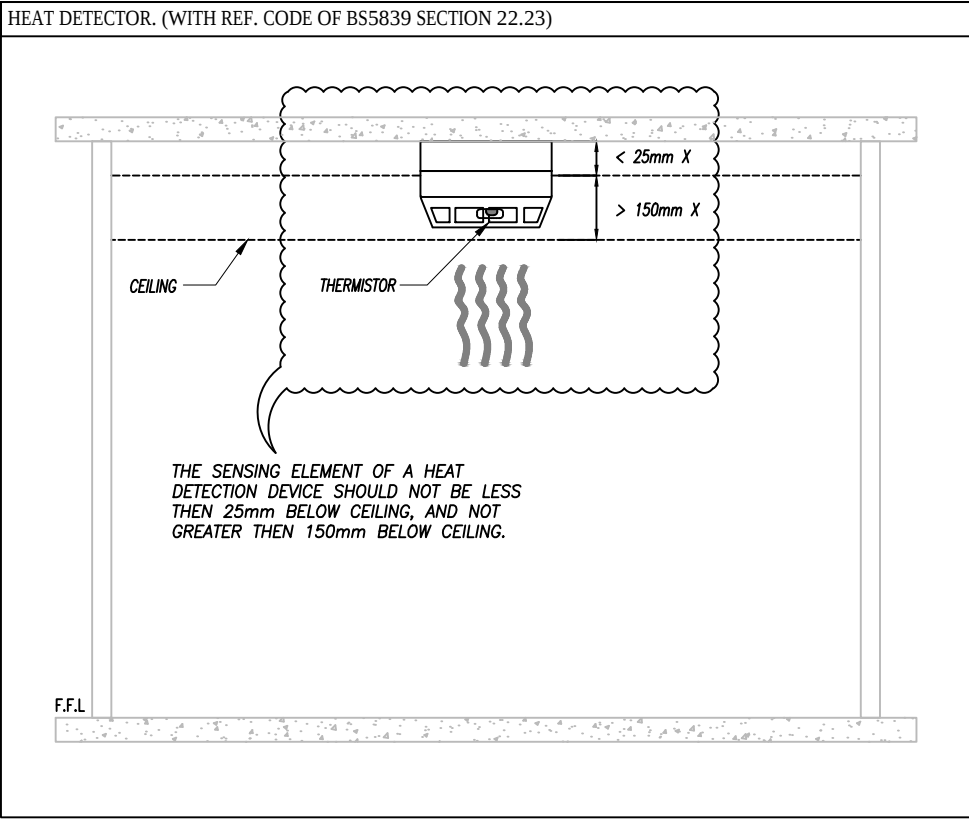

CLIENT:-



CONSULTANT:



Nexus
Consulting
Office A-202, Second Floor, Blossom Trade Center Opposite NED University
University Road, SB-26, Block No.01 Gulistan-e-Jouhar, Karachi Pakistan
Phone: 021-37240670
Email: nexusconsultingcompany@gmail.com Web: www.Nexuscon.pk


PROJECT:-

STATE LIFE BUILDING NO.11

TITLE:-

GENERAL
FIRE ALARM SYSTEM
DETAIL-01

REV #	DATE	DESCRIPTION	CHK'D	APP'D	Project Ref:	DATE
						JUNE. 2026
					DRAWN BY HASSAN KHAN	SCALE AS SHOWN
					CHECKED BY WAQAS SHAHAB	DWG. NO. FA-03

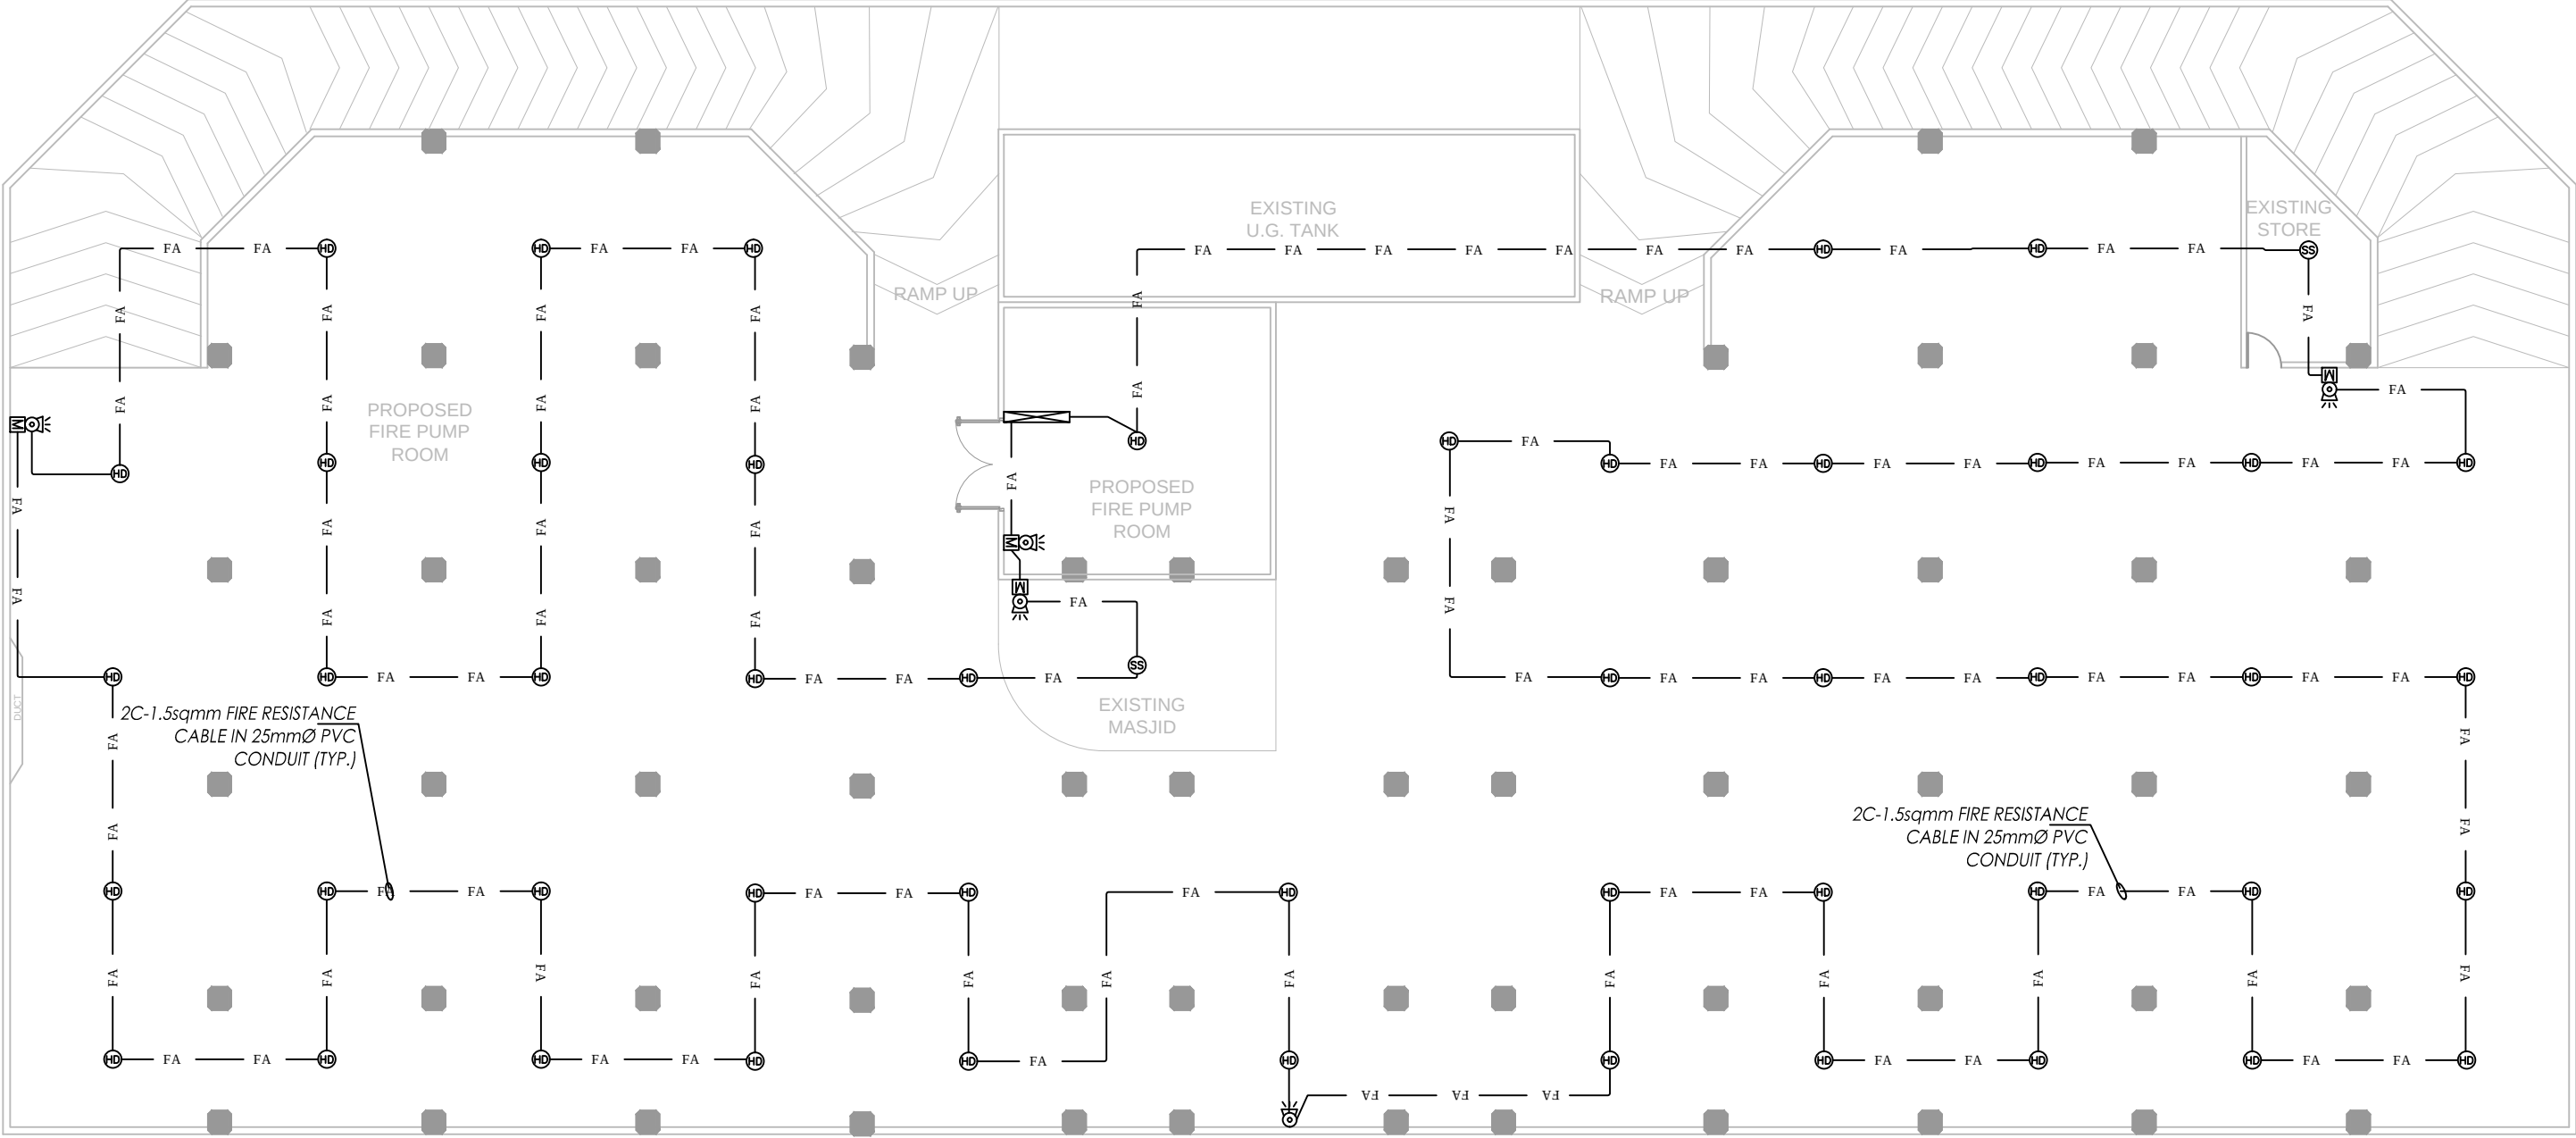

LEGENDS					
	SMOKE DETECTOR	CEILING			
	HEAT DETECTOR	CEILING			
	SOUNDER WITH FLASHER	8'-0" FFL			
	MANUAL BREAK GLASS	3'-6" FFL			
	INPUT/OUTPUT MODULE	WALL			
	FIRE ALARM CONTROL PANEL	3'-6" FFL			

CLIENT:-

CONSULTANT:

Office A-202, Second Floor, Blossom Trade Center Opposite NED University
University Road, SB-26, Block No.01 Gulistan-e-Jouhar, Karachi Pakistan
Phone: 021-37240670
Email: nexusconsultingcompany@gmail.com Web: www.Nexuscon.pk

PROJECT:-

STATE LIFE BUILDING NO.11

TITLE:-

FIRE ALARM SYSTEM
LOWER BASEMENT

REV #	DATE	DESCRIPTION	CHK'D	APP'D

Project Ref: .


DRAWN BY
HASSAN KHAN

CHECKED BY
WAQAS SHAHAB

DATE
JUNE, 2026

SCALE
AS SHOWN

DWG. NO.
FA-04

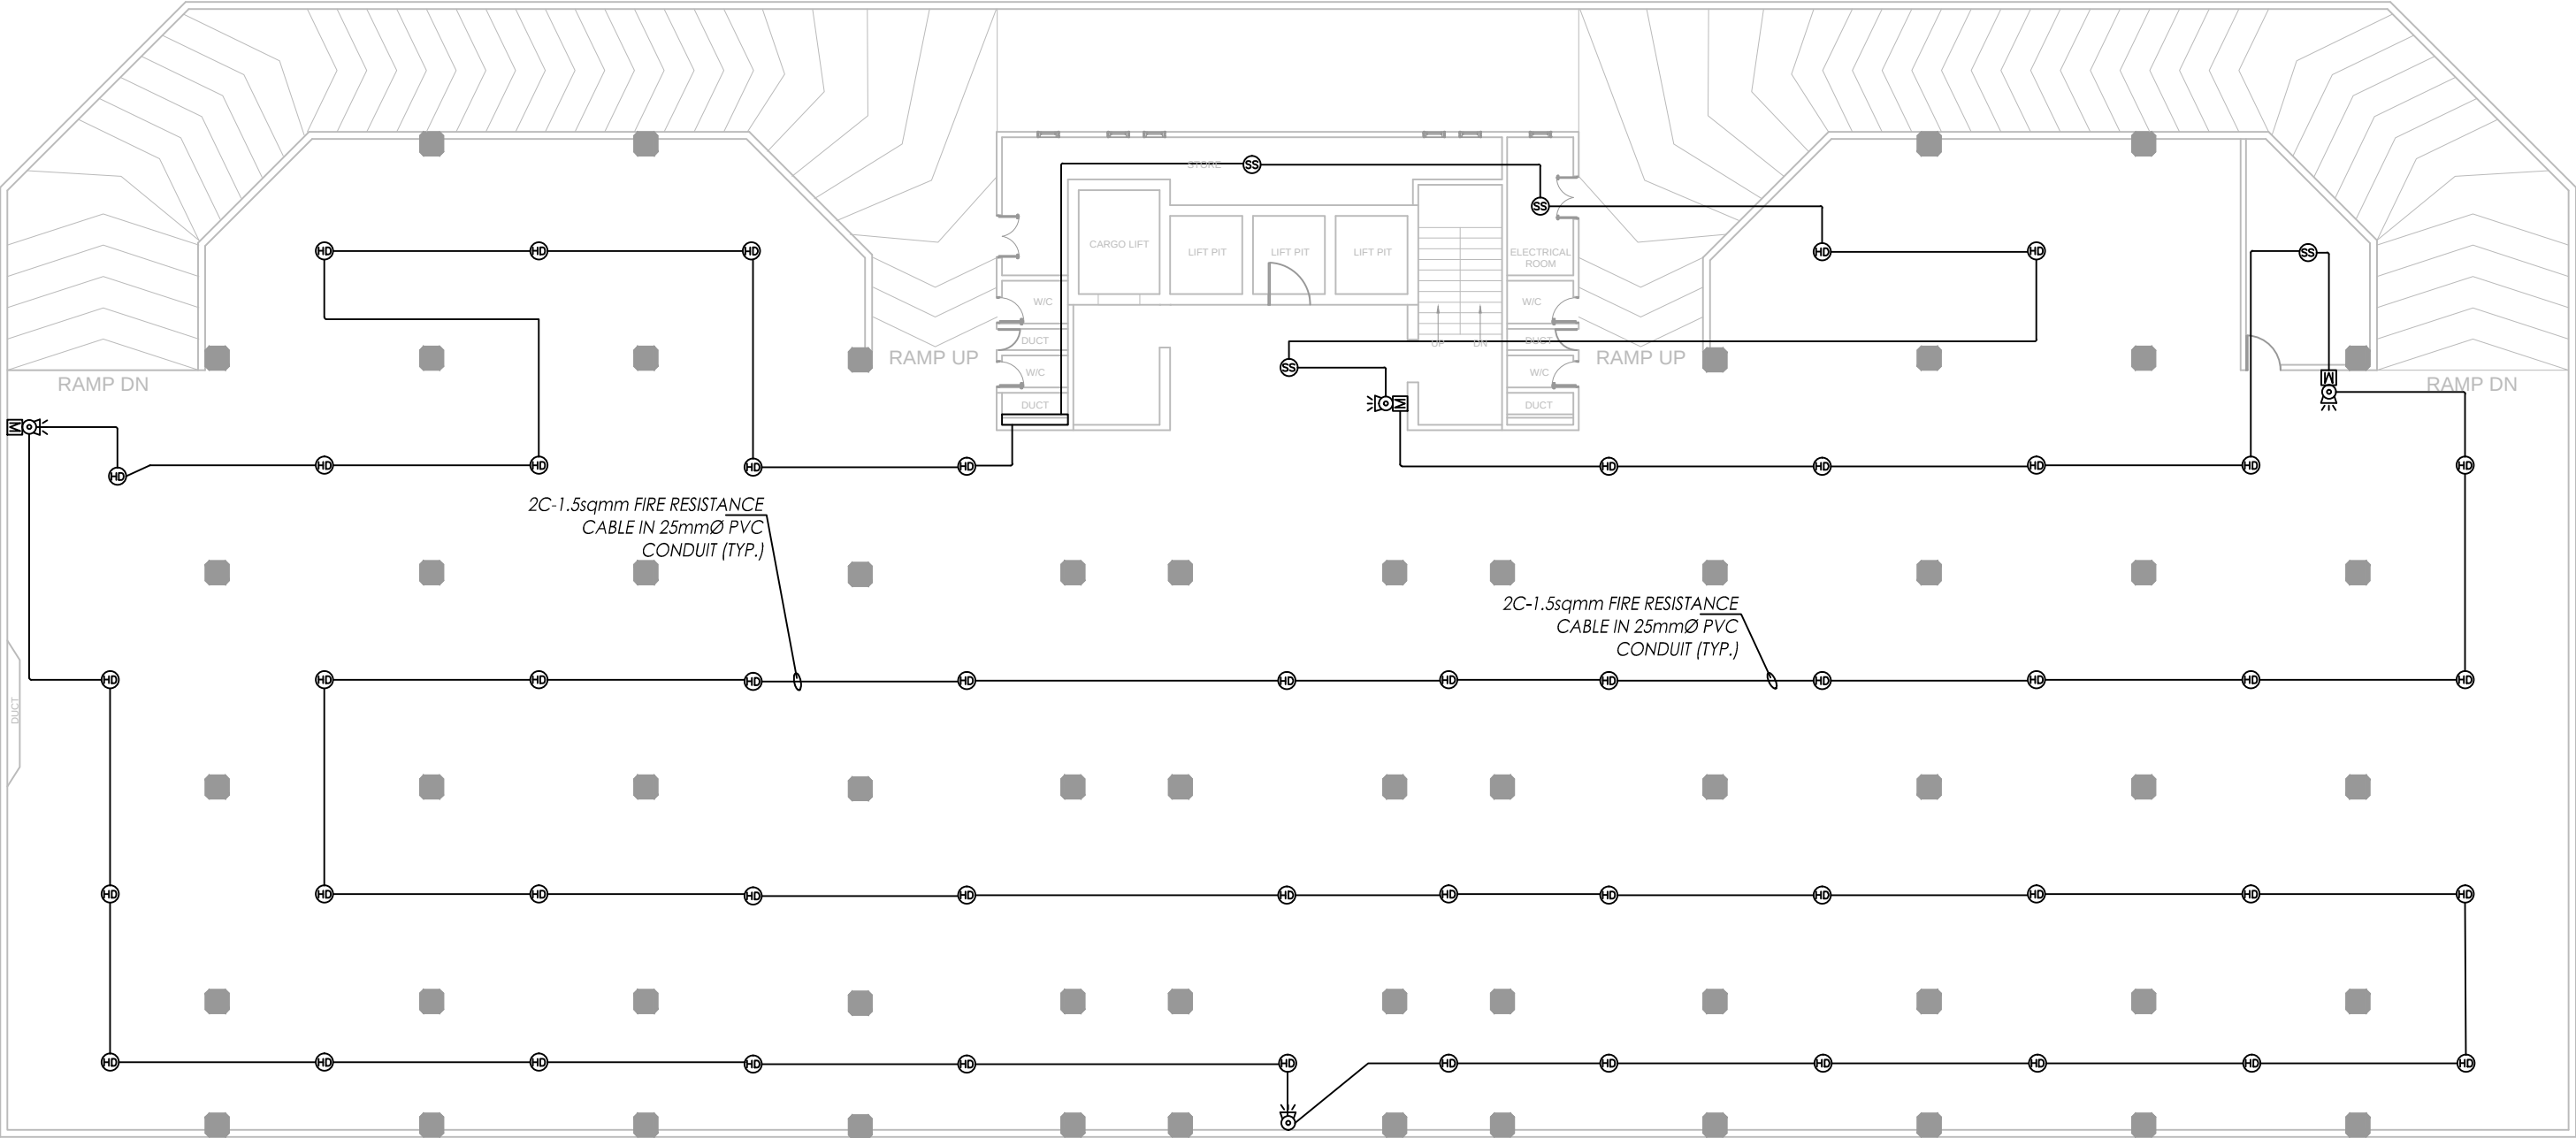

LEGENDS									
	SMOKE DETECTOR								CEILING
	HEAT DETECTOR								CEILING
	SOUNDER WITH FLASHER								8'-0" FFL
	MANUAL BREAK GLASS								3'-6" FFL
	INPUT/OUTPUT MODULE								WALL
	FIRE ALARM CONTROL PANEL								3'-6" FFL
REV #	DATE	DESCRIPTION	CHK'D	APP'D	Project Ref:		DATE		
							JUNE, 2026		
					DRAWN BY		SCALE		
					HASSAN KHAN		AS SHOWN		
					CHECKED BY		DWG. NO.		
					WAQAS SHAHAB		FA-05		

CLIENT:-



STATE LIFE
INSURANCE CORPORATION OF PAKISTAN

CONSULTANT:




Nexus
Consulting
Office A-202, Second Floor, Blossom Trade Center Opposite NED University
University Road, SB-26, Block No.01 Gulistan-e-Jouhar, Karachi Pakistan
Phone: 021-37240670
Email: nexusconsultingcompany@gmail.com Web: www.Nexuscon.pk

PROJECT:-


STATE LIFE BUILDING NO.11

TITLE:-

FIRE ALARM SYSTEM
UPPER BASEMENT

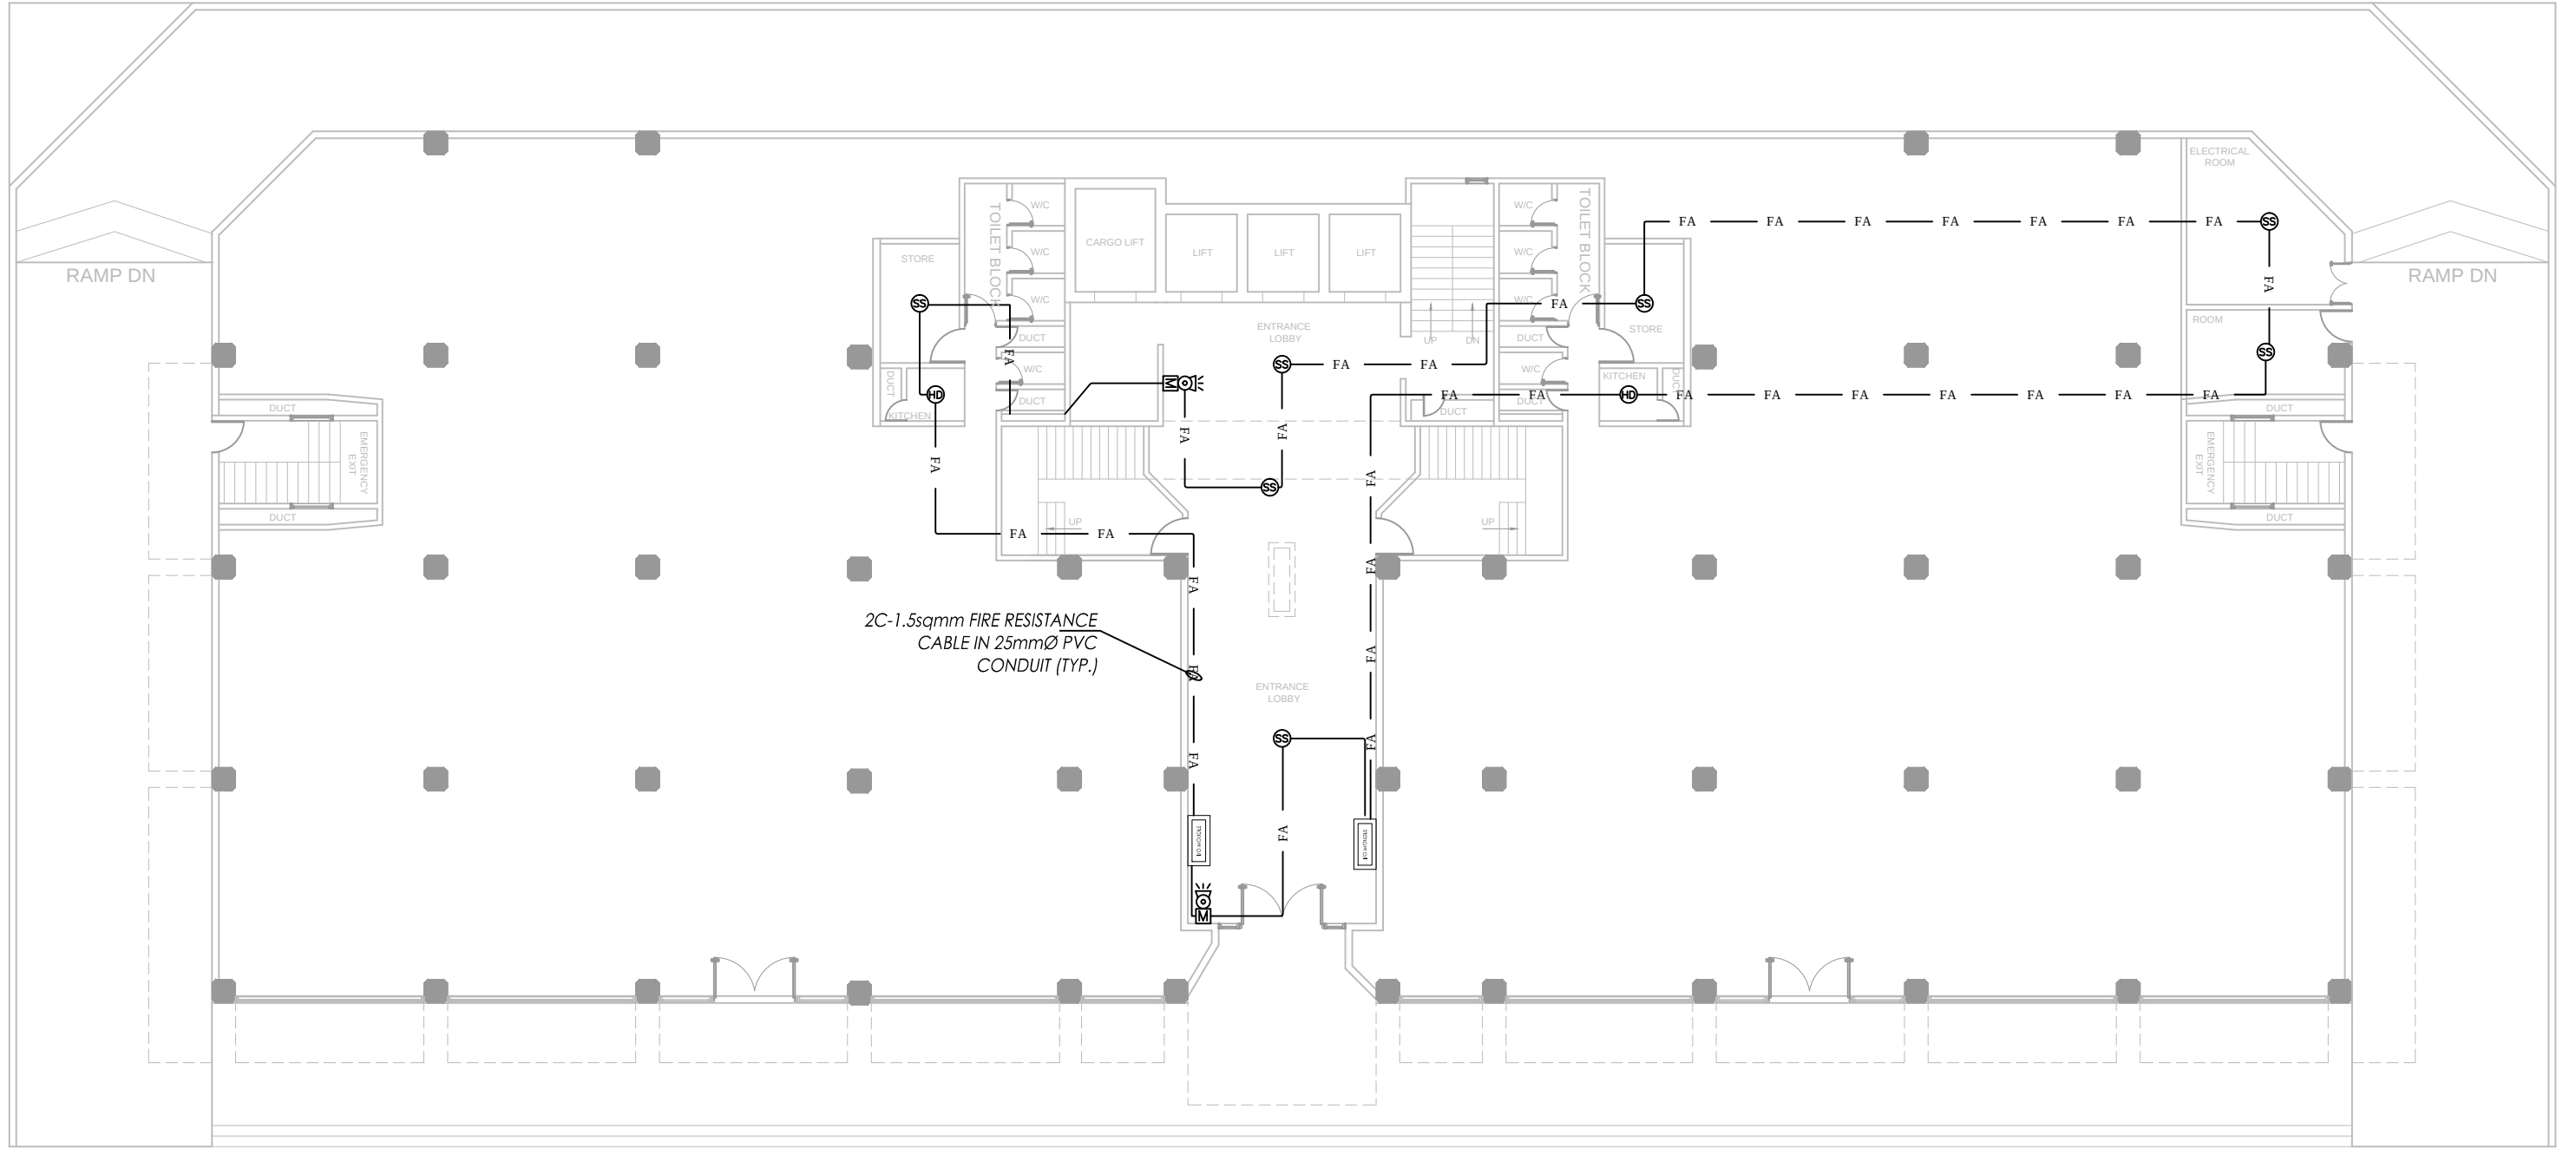

LEGENDS									
	SMOKE DETECTOR								CEILING
	HEAT DETECTOR								CEILING
	SOUNDER WITH FLASHER								8'-0" FFL
	MANUAL BREAK GLASS								3'-6" FFL
	INPUT/OUTPUT MODULE								WALL
	FIRE ALARM CONTROL PANEL								3'-6" FFL
REV #	DATE	DESCRIPTION	CHKD	APPD	Project Ref:		DATE		
					.		JUNE. 2026		
					DRAWN BY		SCALE		
					HASSAN KHAN		AS SHOWN		
					CHECKED BY		DWG. NO.		
					WAQAS SHAHAB		FA-06		

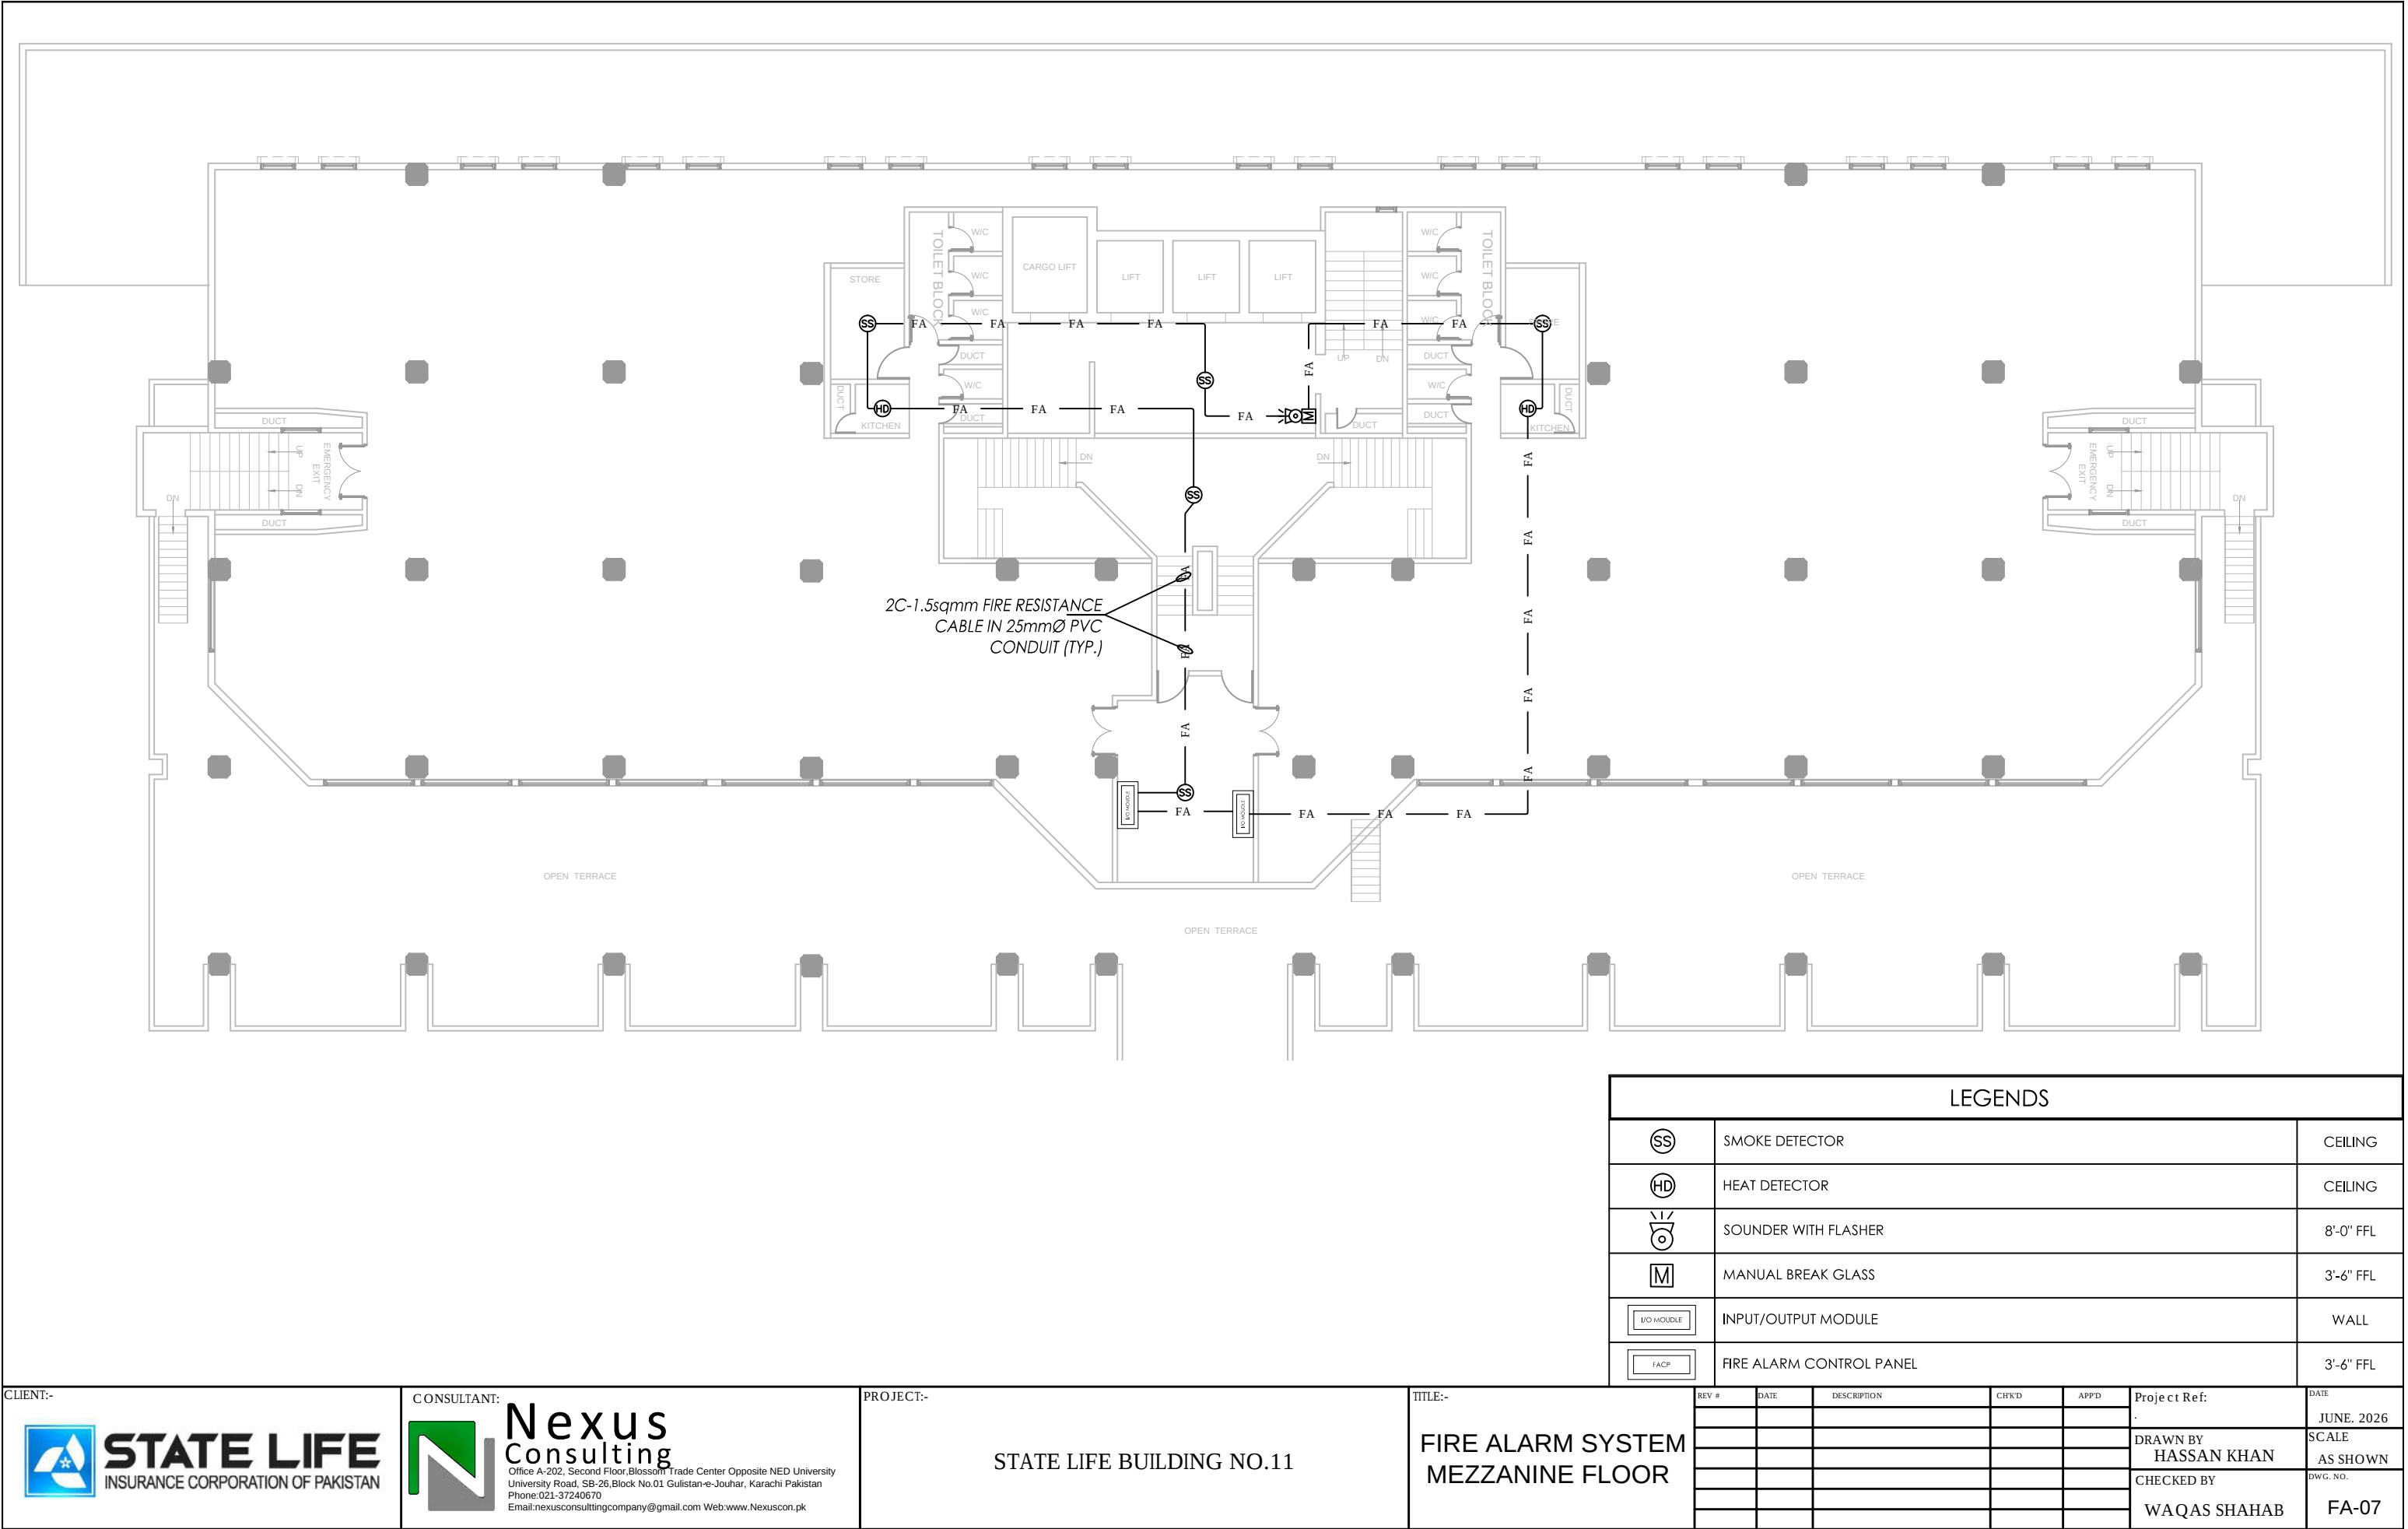

LEGENDS									
	SMOKE DETECTOR								CEILING
	HEAT DETECTOR								CEILING
	SOUNDER WITH FLASHER								8'-0" FFL
	MANUAL BREAK GLASS								3'-6" FFL
	INPUT/OUTPUT MODULE								WALL
	FIRE ALARM CONTROL PANEL								3'-6" FFL
REV #	DATE	DESCRIPTION	CHK'D	APP'D	Project Ref:		DATE		
							JUNE. 2026		
					DRAWN BY		SCALE		
					HASSAN KHAN		AS SHOWN		
					CHECKED BY		DWG. NO.		
					WAQAS SHAHAB		FA-07		

CLIENT:-

CONSULTANT:


Nexus
Consulting
Office A-202, Second Floor, Blossom Trade Center Opposite NED University
University Road, SB-26, Block No.01 Gulistan-e-Jouhar, Karachi Pakistan
Phone: 021-37240670
Email: nexusconsultingcompany@gmail.com Web: www.Nexuscon.pk

PROJECT:-

STATE LIFE BUILDING NO.11

TITLE:-

FIRE ALARM SYSTEM
MEZZANINE FLOOR

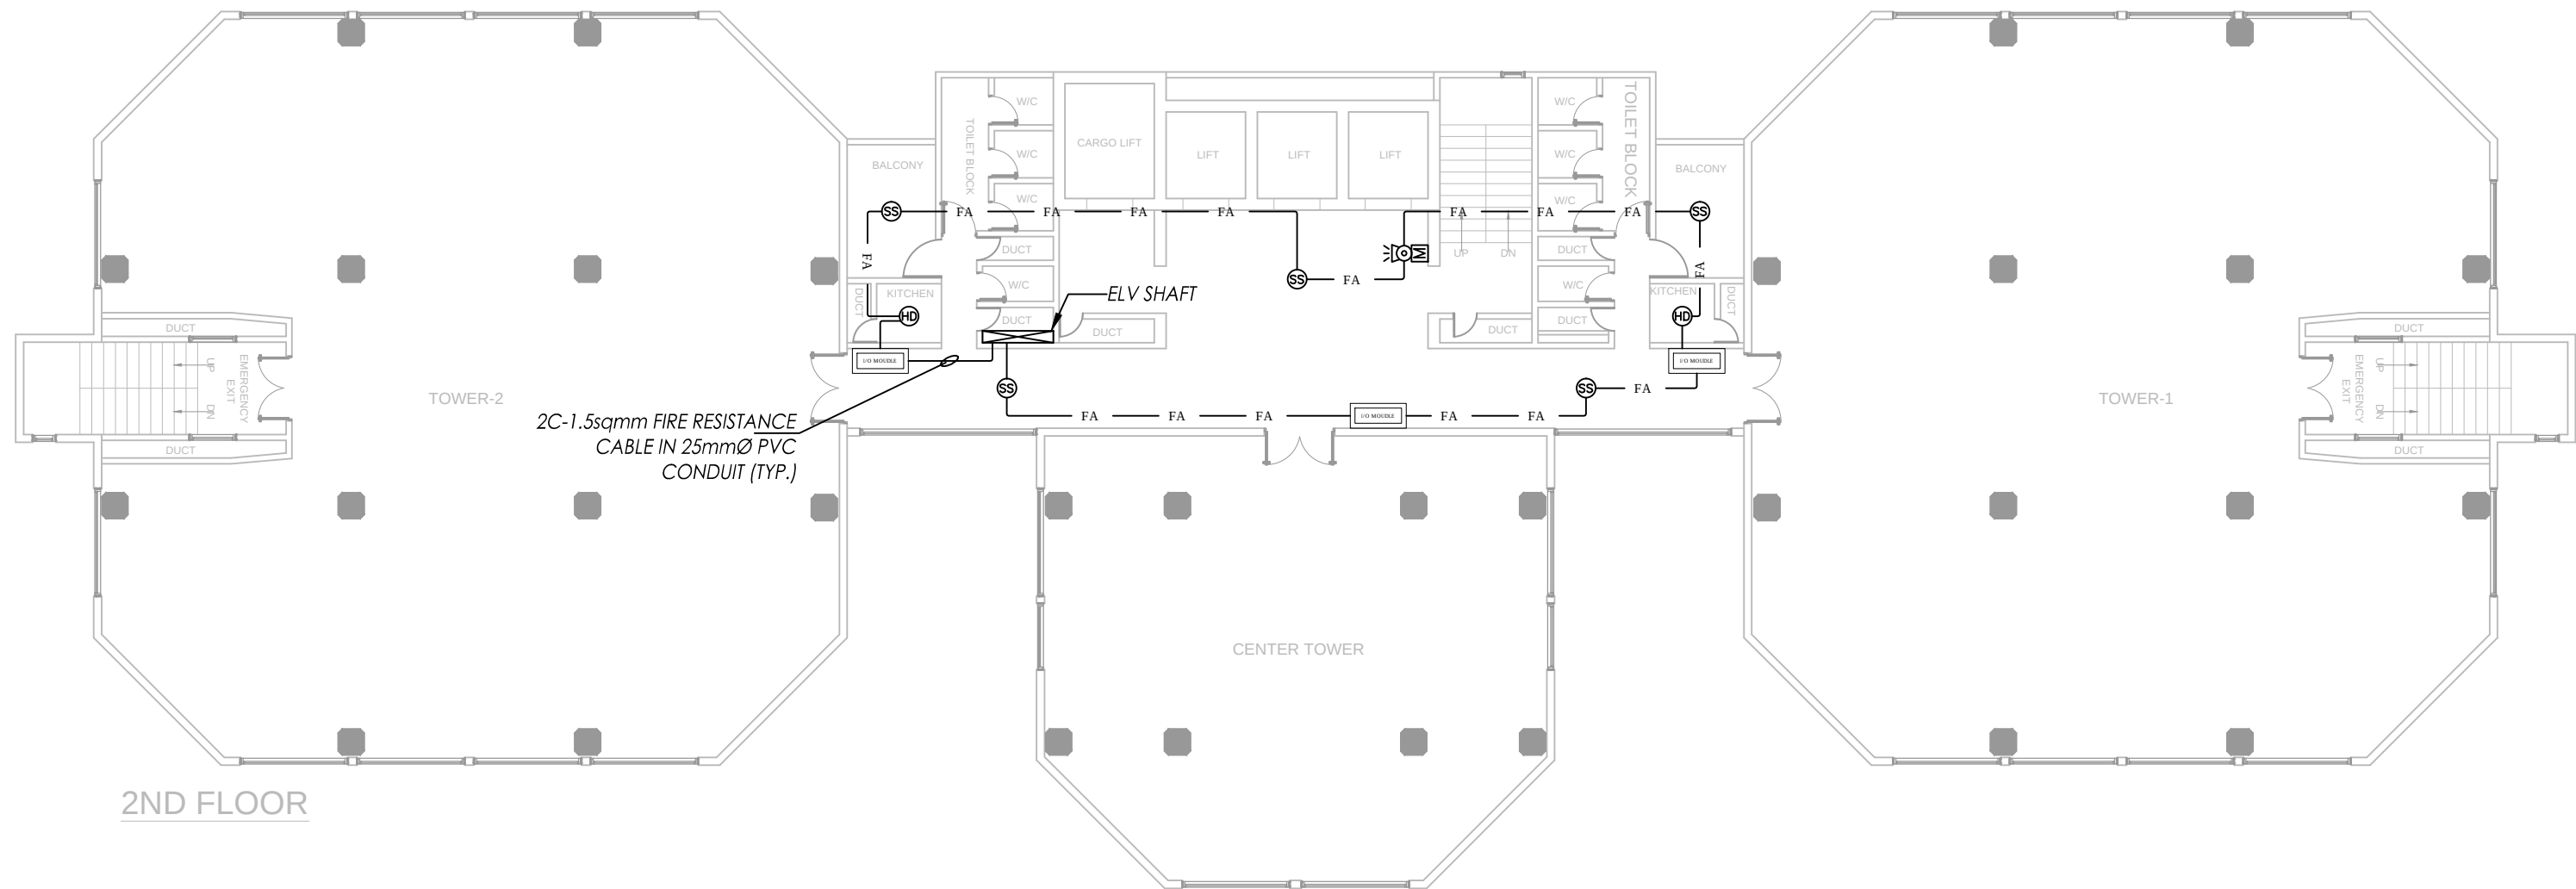

2ND FLOOR

LEGENDS									
	SMOKE DETECTOR								CEILING
	HEAT DETECTOR								CEILING
	SOUNDER WITH FLASHER								8'-0" FFL
	MANUAL BREAK GLASS								3'-6" FFL
	INPUT/OUTPUT MODULE								WALL
	FIRE ALARM CONTROL PANEL								3'-6" FFL
REV #	DATE	DESCRIPTION	CHK'D	APP'D	Project Ref:		DATE		
					.		JUNE. 2026		
					DRAWN BY		SCALE		
					HASSAN KHAN		AS SHOWN		
					CHECKED BY		DWG. NO.		
					WAQAS SHAHAB		FA-08		

CLIENT:-

CONSULTANT:

Nexus

Consulting


Office A-202, Second Floor, Blossom Trade Center Opposite NED University
University Road, SB-26, Block No.01 Gulistan-e-Jouhar, Karachi Pakistan
Phone: 021-37240670
Email: nexusconsultingcompany@gmail.com Web: www.Nexuscon.pk

PROJECT:-

STATE LIFE BUILDING NO.11

TITLE:-

FIRE ALARM SYSTEM
SECOND FLOOR

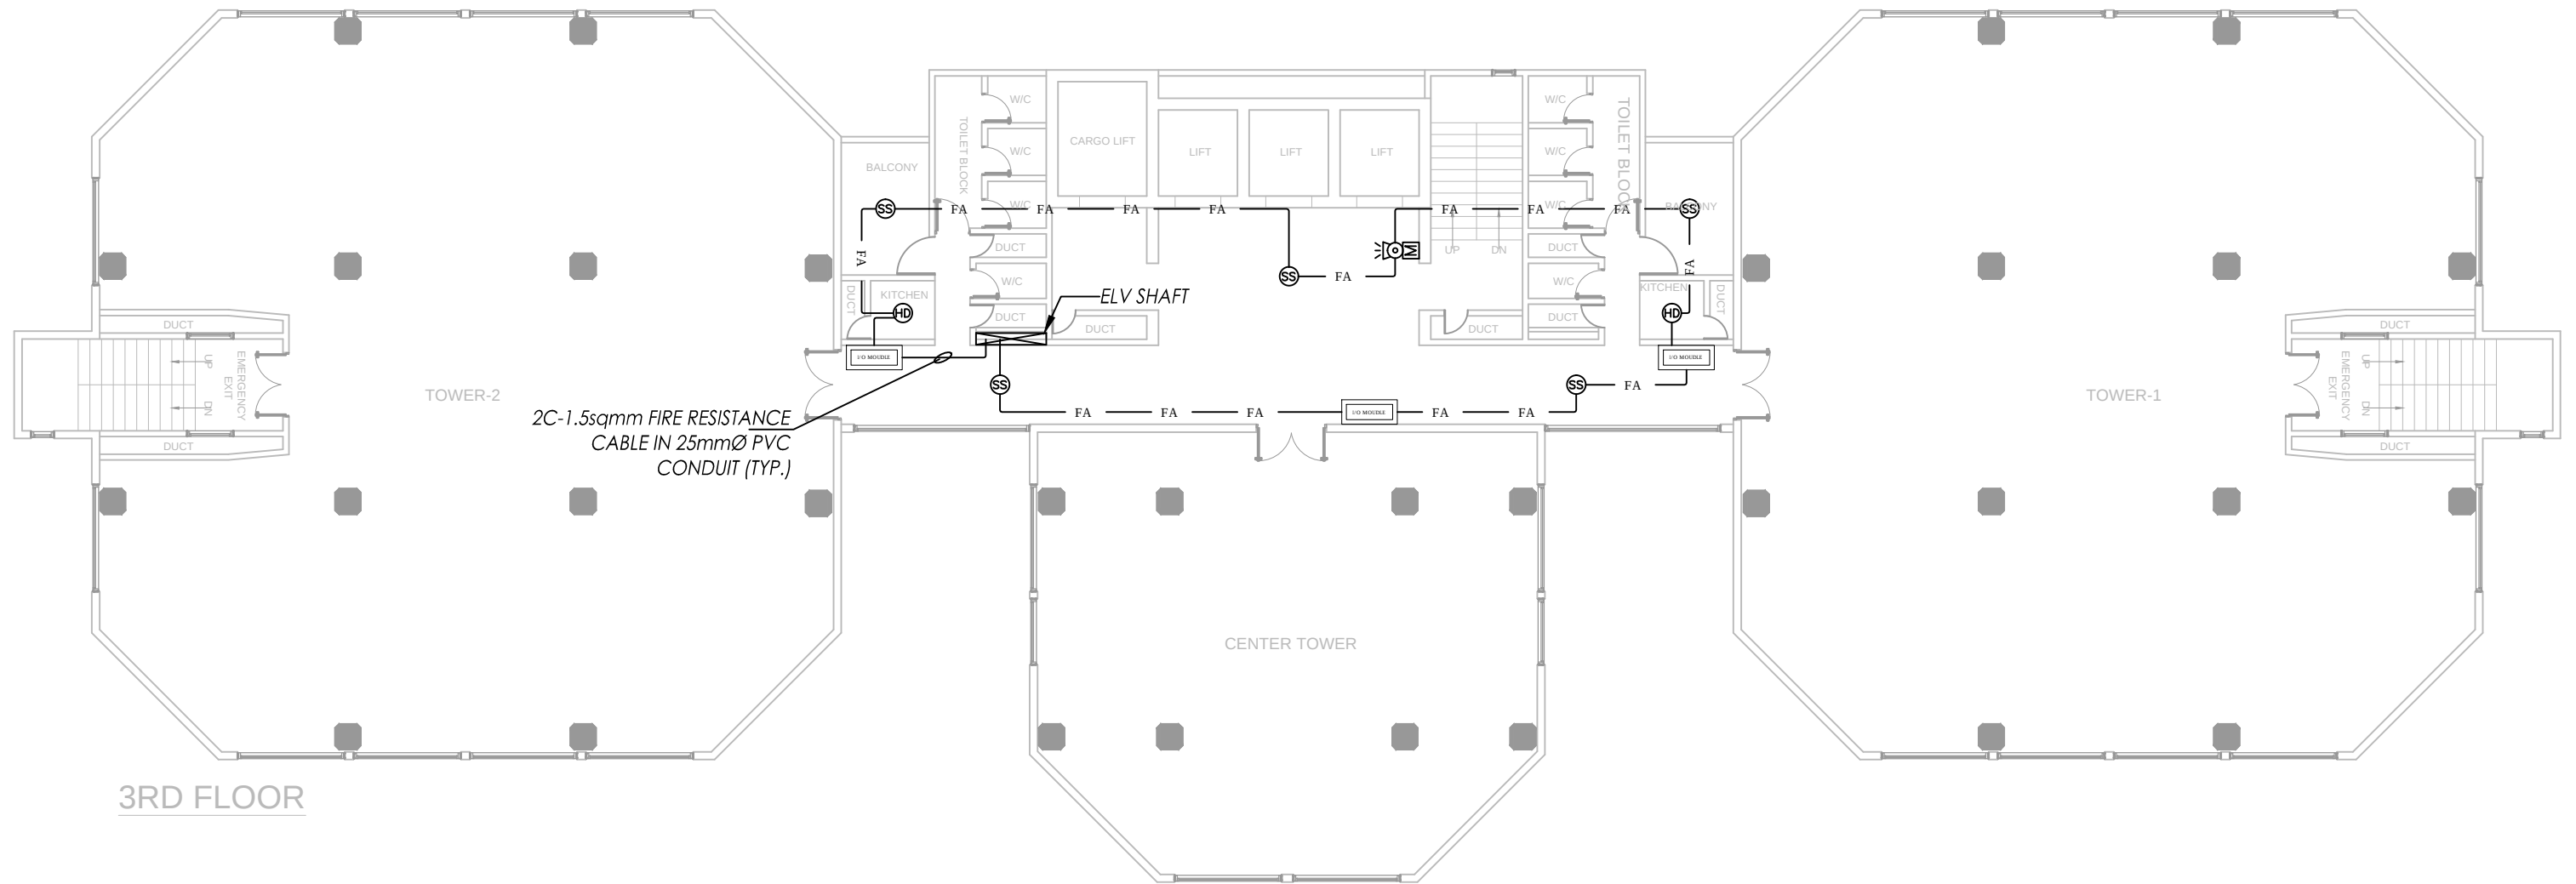

3RD FLOOR

LEGENDS									
	SMOKE DETECTOR								CEILING
	HEAT DETECTOR								CEILING
	SOUNDER WITH FLASHER								8'-0" FFL
	MANUAL BREAK GLASS								3'-6" FFL
	INPUT/OUTPUT MODULE								WALL
	FIRE ALARM CONTROL PANEL								3'-6" FFL
REV #	DATE	DESCRIPTION	CHK'D	APP'D	Project Ref:		DATE		
							JUNE. 2026		
					DRAWN BY		SCALE		
					HASSAN KHAN		AS SHOWN		
					CHECKED BY		DWG. NO.		
					WAQAS SHAHAB		FA-09		

CLIENT:-



CONSULTANT:





PROJECT:-

STATE LIFE BUILDING NO.11

TITLE:-

FIRE ALARM SYSTEM
THIRD FLOOR

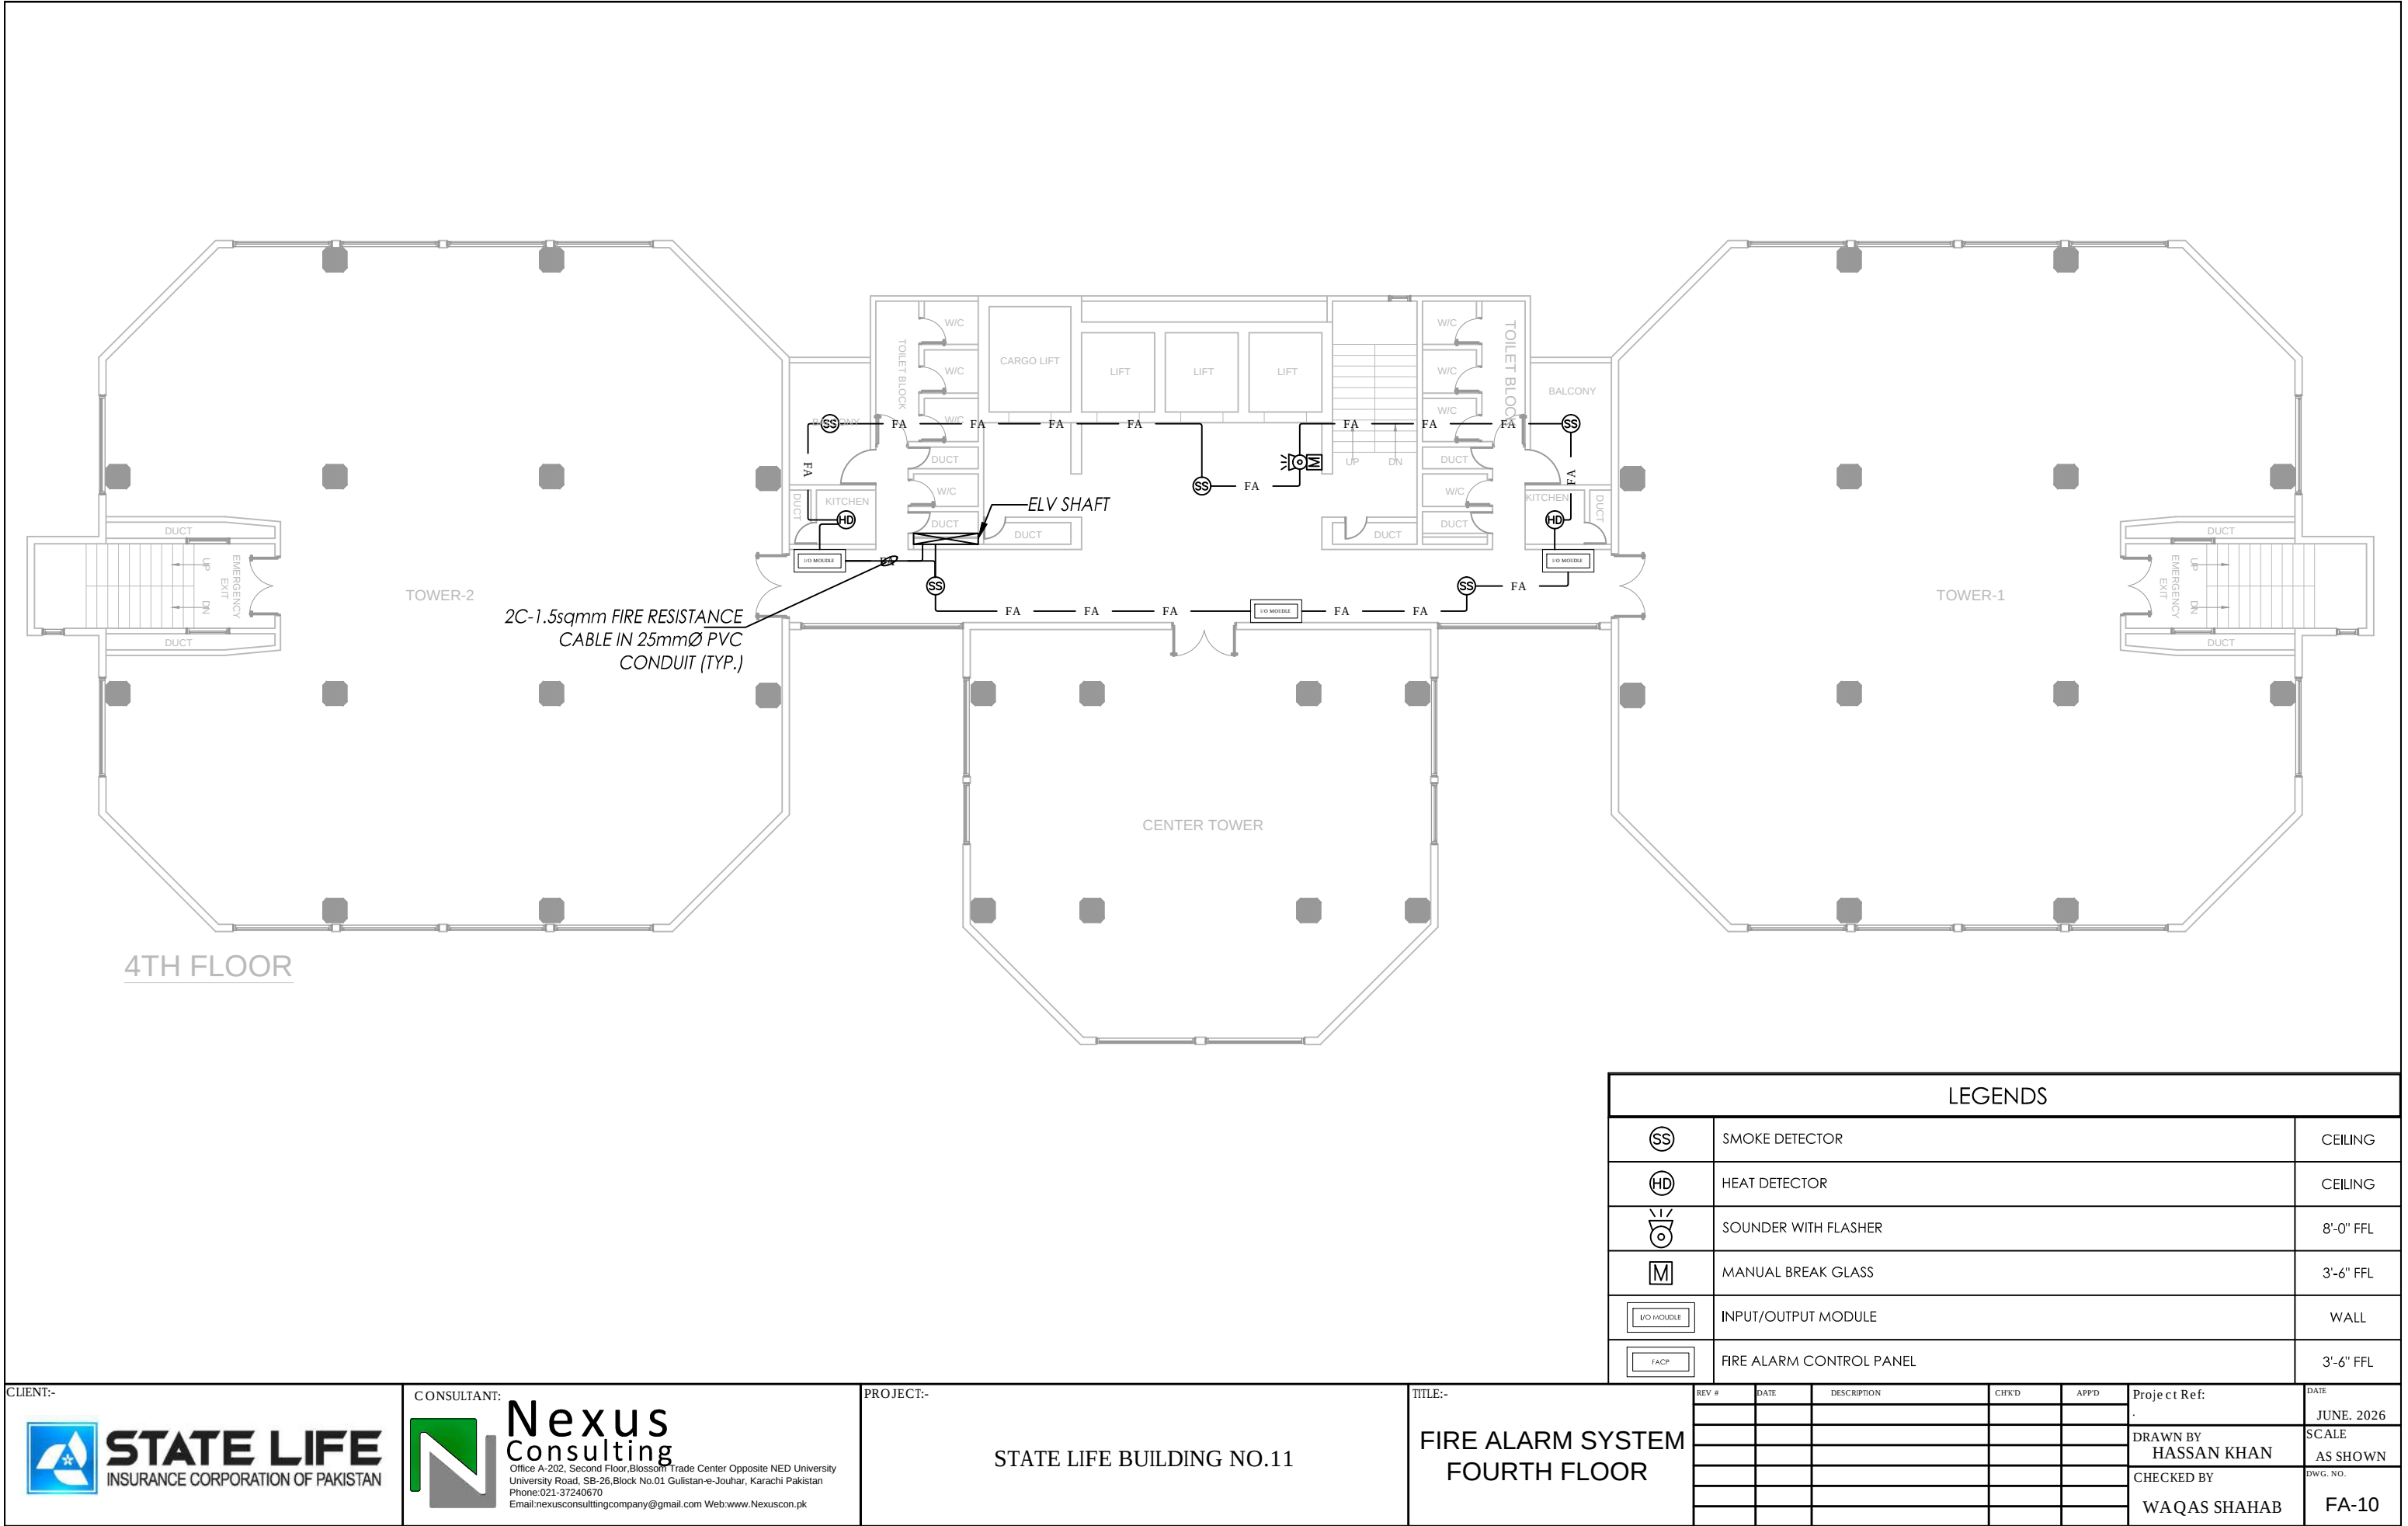

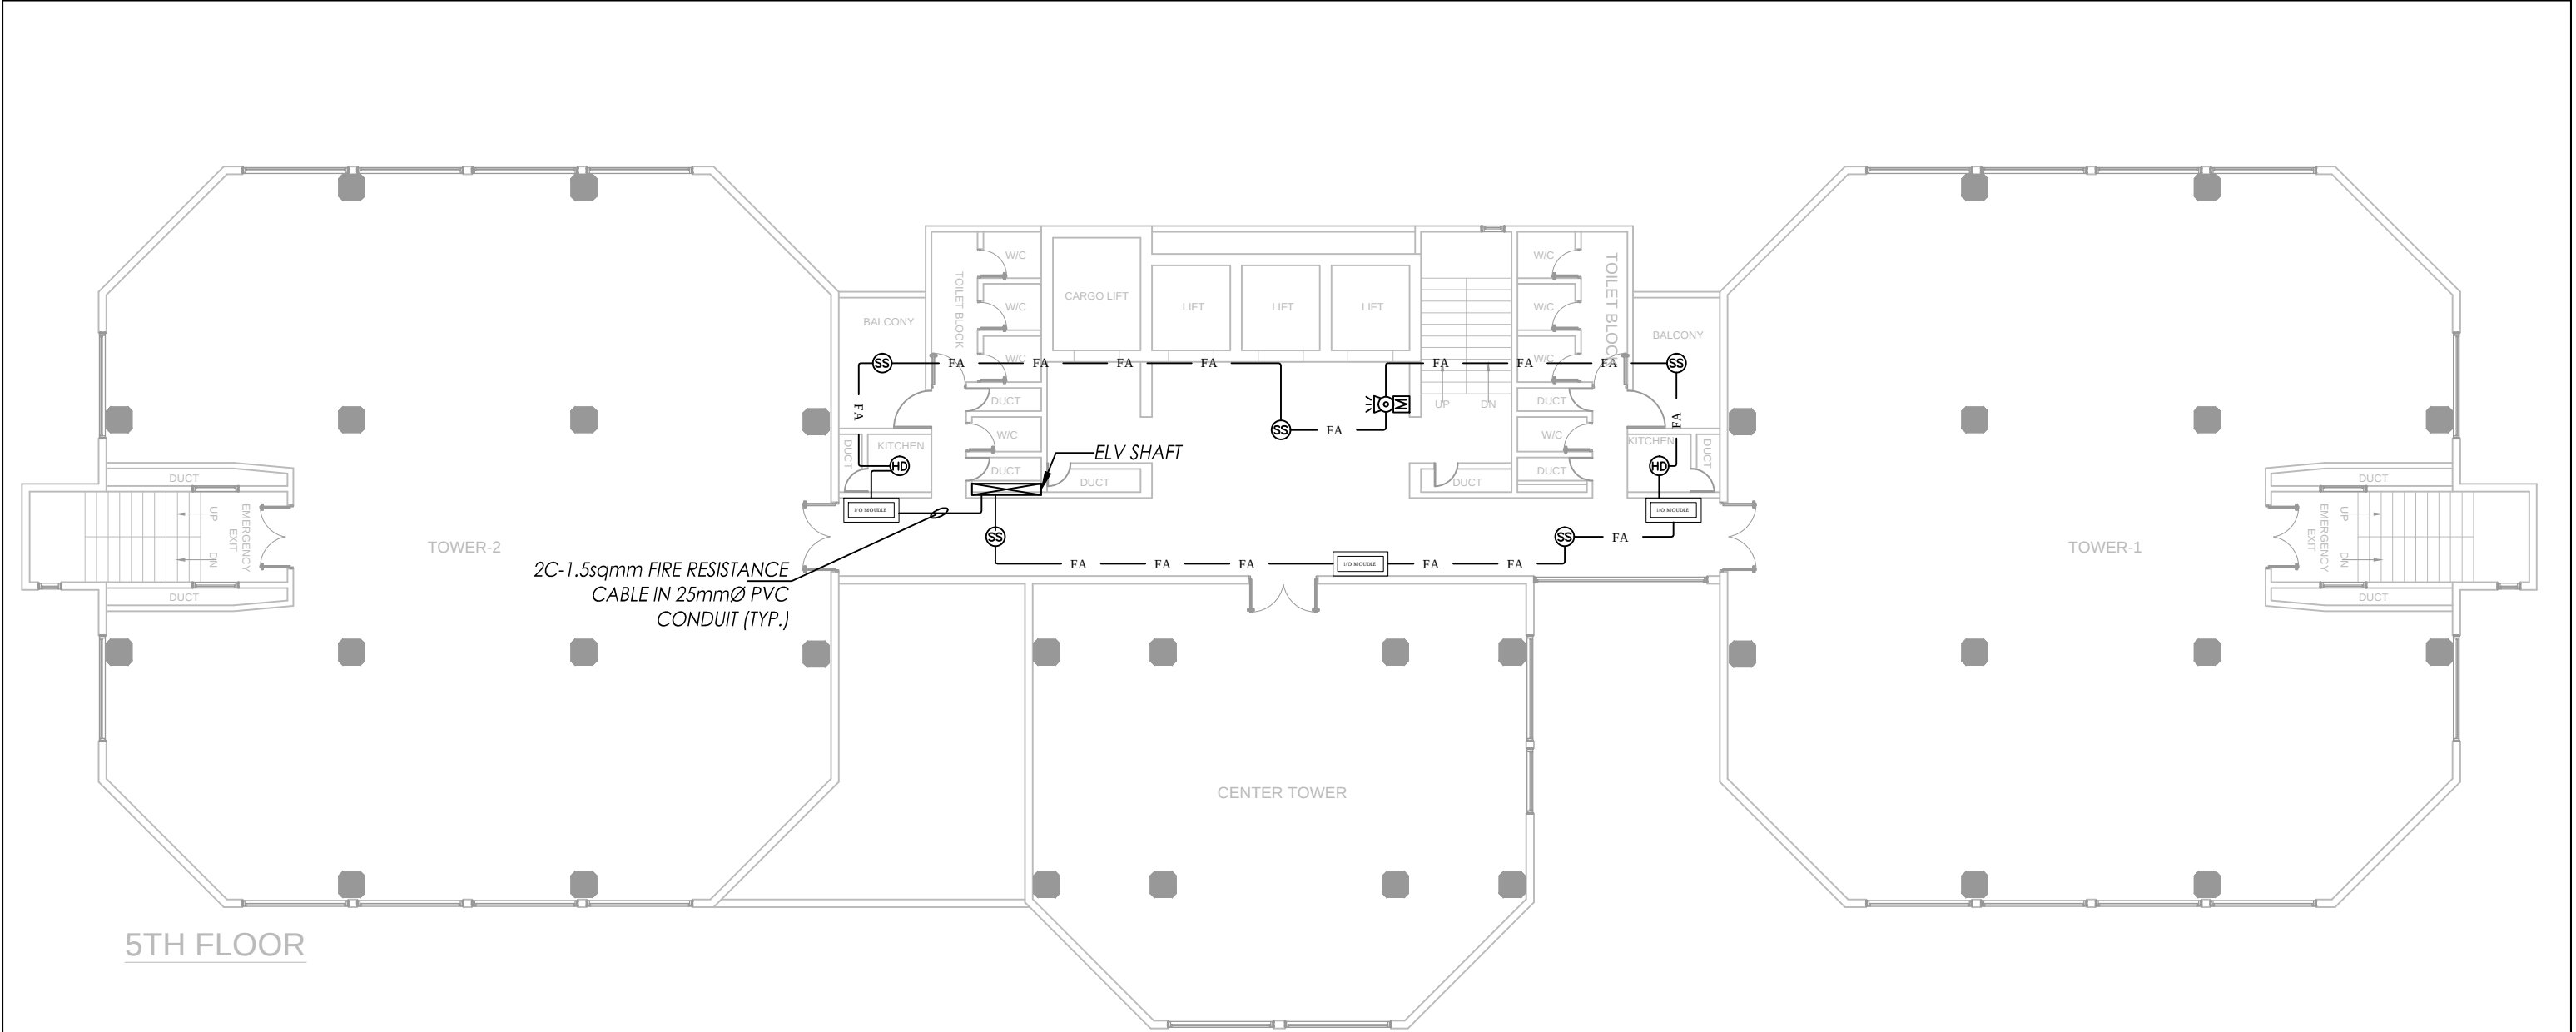

5TH FLOOR

LEGENDS									
	SMOKE DETECTOR								CEILING
	HEAT DETECTOR								CEILING
	SOUNDER WITH FLASHER								8'-0" FFL
	MANUAL BREAK GLASS								3'-6" FFL
	INPUT/OUTPUT MODULE								WALL
	FIRE ALARM CONTROL PANEL								3'-6" FFL
REV #	DATE	DESCRIPTION	CHK'D	APP'D	Project Ref:		DATE		
							JUNE. 2026		
					DRAWN BY		SCALE		
					HASSAN KHAN		AS SHOWN		
					CHECKED BY		DWG. NO.		
					WAQAS SHAHAB		FA-11		

CLIENT:-

CONSULTANT:


Nexus
Consulting
Office A-202, Second Floor, Blossom Trade Center Opposite NED University
University Road, SB-26, Block No.01 Gulistan-e-Jouhar, Karachi Pakistan
Phone: 021-37240670
Email: nexusconsultingcompany@gmail.com Web: www.Nexuscon.pk

PROJECT:-

STATE LIFE BUILDING NO.11

TITLE:-

FIRE ALARM SYSTEM
FIFTH FLOOR

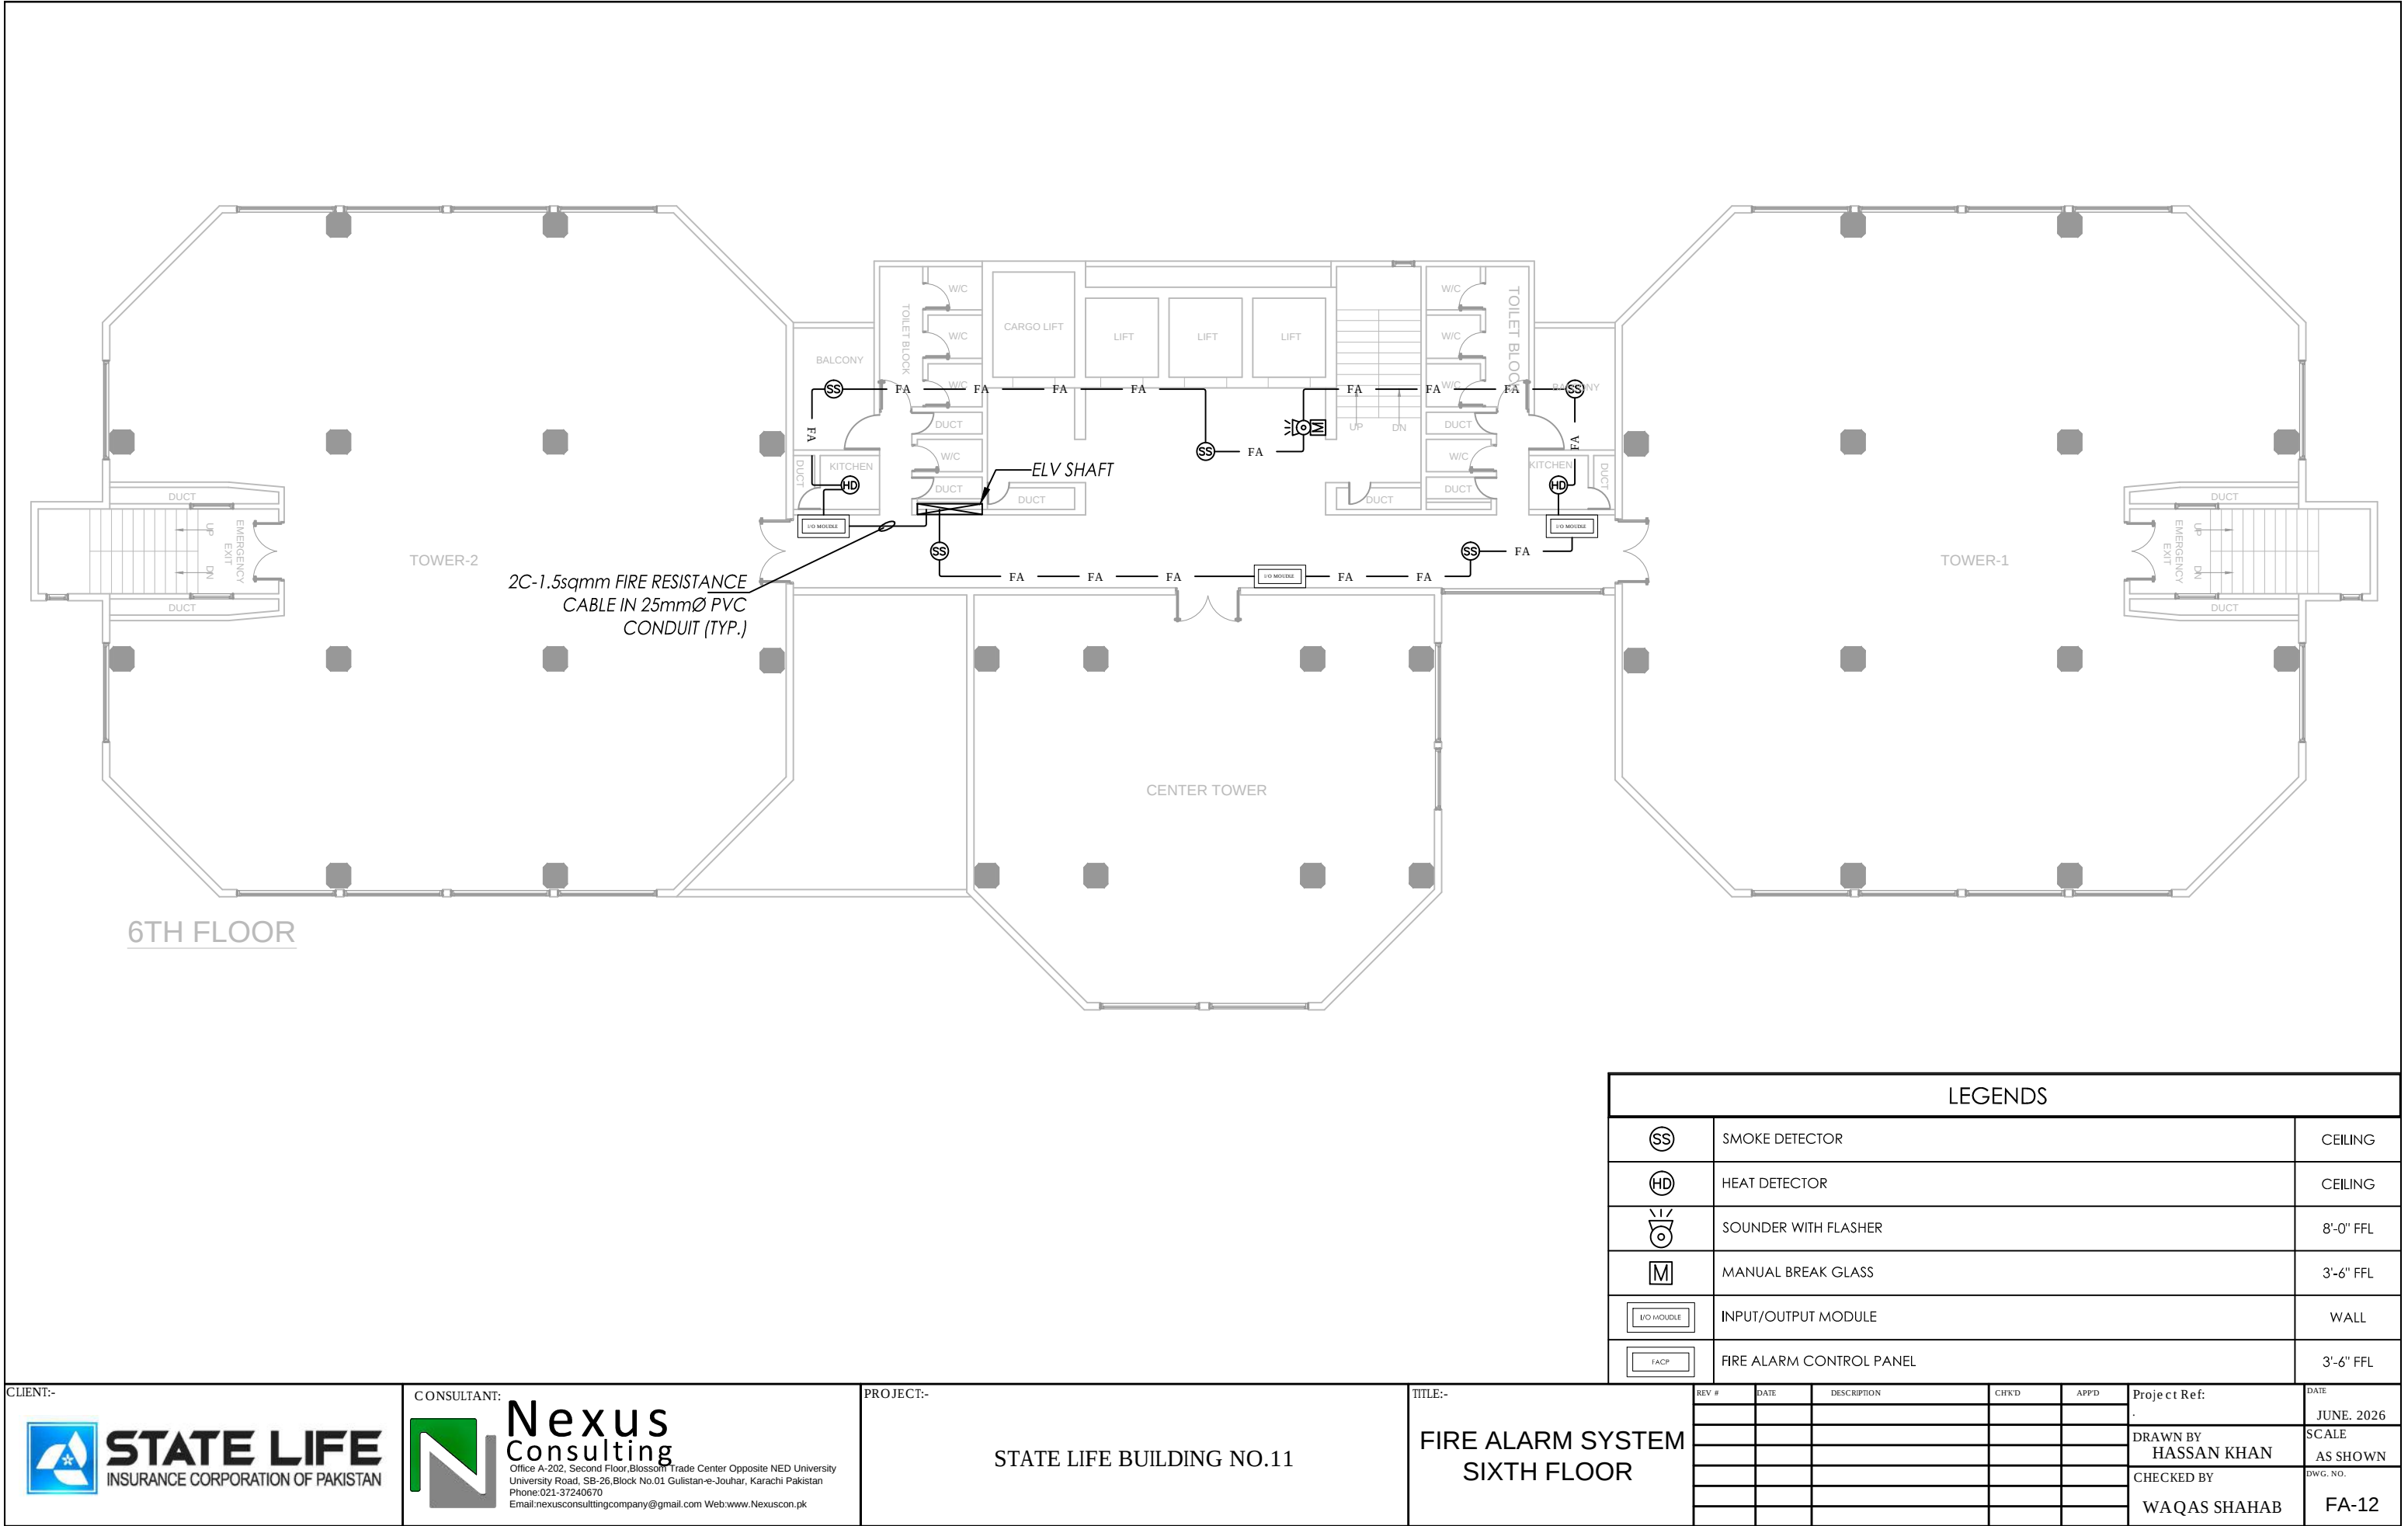

LEGENDS									
	SMOKE DETECTOR								CEILING
	HEAT DETECTOR								CEILING
	SOUNDER WITH FLASHER								8'-0" FFL
	MANUAL BREAK GLASS								3'-6" FFL
	INPUT/OUTPUT MODULE								WALL
	FIRE ALARM CONTROL PANEL								3'-6" FFL
REV. #	DATE	DESCRIPTION	CHK'D	APP'D	Project Ref:		DATE		
							JUNE. 2026		
					DRAWN BY		SCALE		
					HASSAN KHAN		AS SHOWN		
					CHECKED BY		DWG. NO.		
					WAQAS SHAHAB		FA-12		

CLIENT:-



STATE LIFE
INSURANCE CORPORATION OF PAKISTAN

CONSULTANT:




Nexus
Consulting
Office A-202, Second Floor, Blossom Trade Center Opposite NED University
University Road, SB-26, Block No.01 Gulistan-e-Jouhar, Karachi Pakistan
Phone: 021-37240670
Email: nexusconsultingcompany@gmail.com Web: www.Nexuscon.pk

PROJECT:-

STATE LIFE BUILDING NO.11

TITLE:-

FIRE ALARM SYSTEM
SIXTH FLOOR

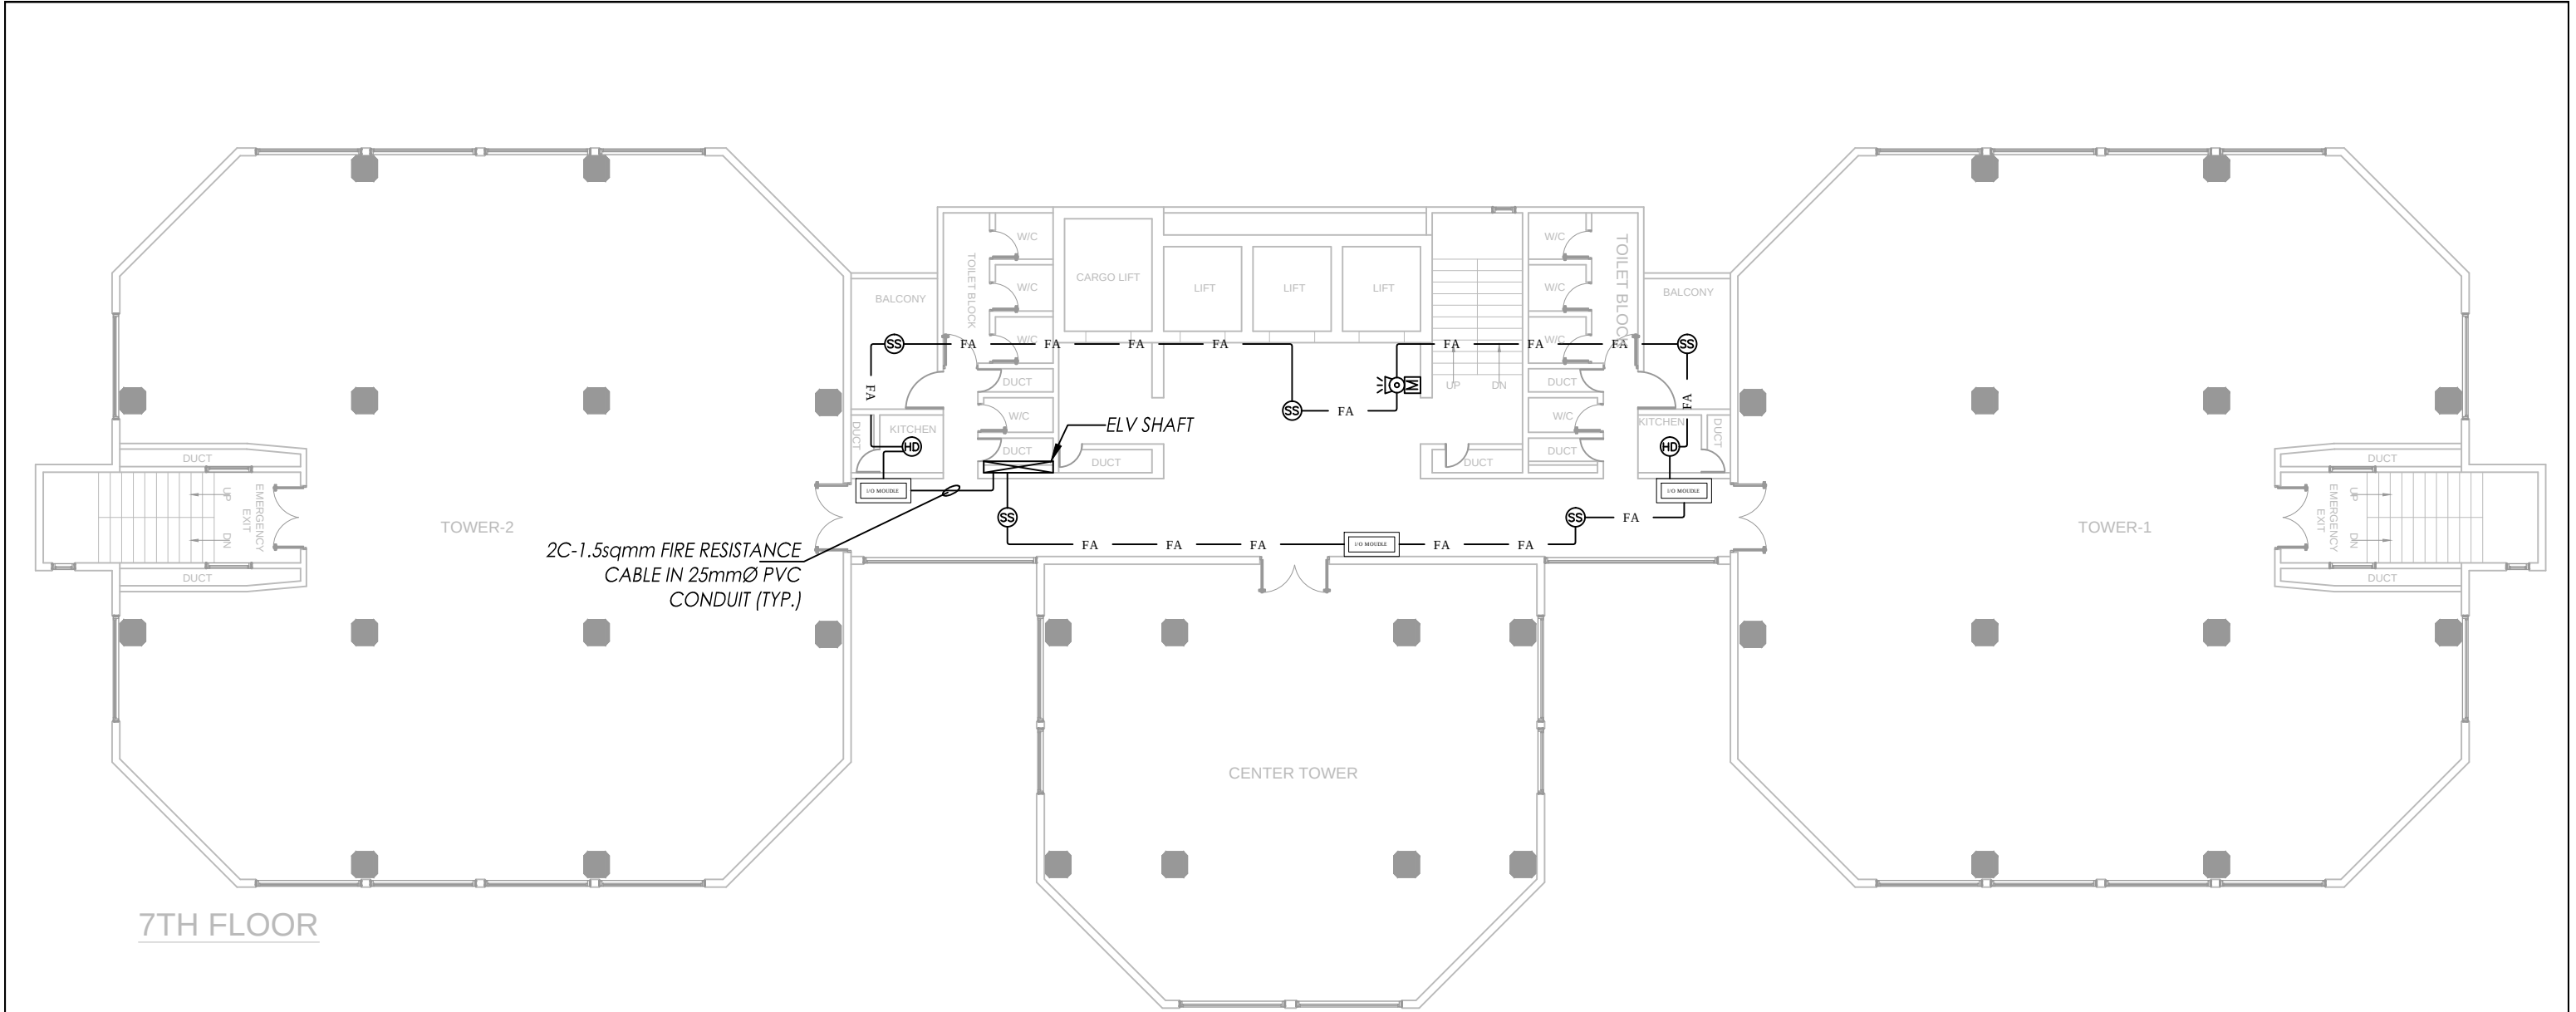

LEGENDS									
	SMOKE DETECTOR								CEILING
	HEAT DETECTOR								CEILING
	SOUNDER WITH FLASHER								8'-0" FFL
	MANUAL BREAK GLASS								3'-6" FFL
	INPUT/OUTPUT MODULE								WALL
	FIRE ALARM CONTROL PANEL								3'-6" FFL
REV #	DATE	DESCRIPTION	CHK'D	APP'D	Project Ref:		DATE		
							JUNE. 2026		
					DRAWN BY		SCALE		
					HASSAN KHAN		AS SHOWN		
					CHECKED BY		DWG. NO.		
					WAQAS SHAHAB		FA-13		

CLIENT:-

CONSULTANT:


Nexus
Consulting
Office A-202, Second Floor, Blossom Trade Center Opposite NED University
University Road, SB-26, Block No.01 Gulistan-e-Jouhar, Karachi Pakistan
Phone: 021-37240670
Email: nexusconsultingcompany@gmail.com Web: www.Nexuscon.pk

PROJECT:-

STATE LIFE BUILDING NO.11

TITLE:-

FIRE ALARM SYSTEM
SEVENTH FLOOR

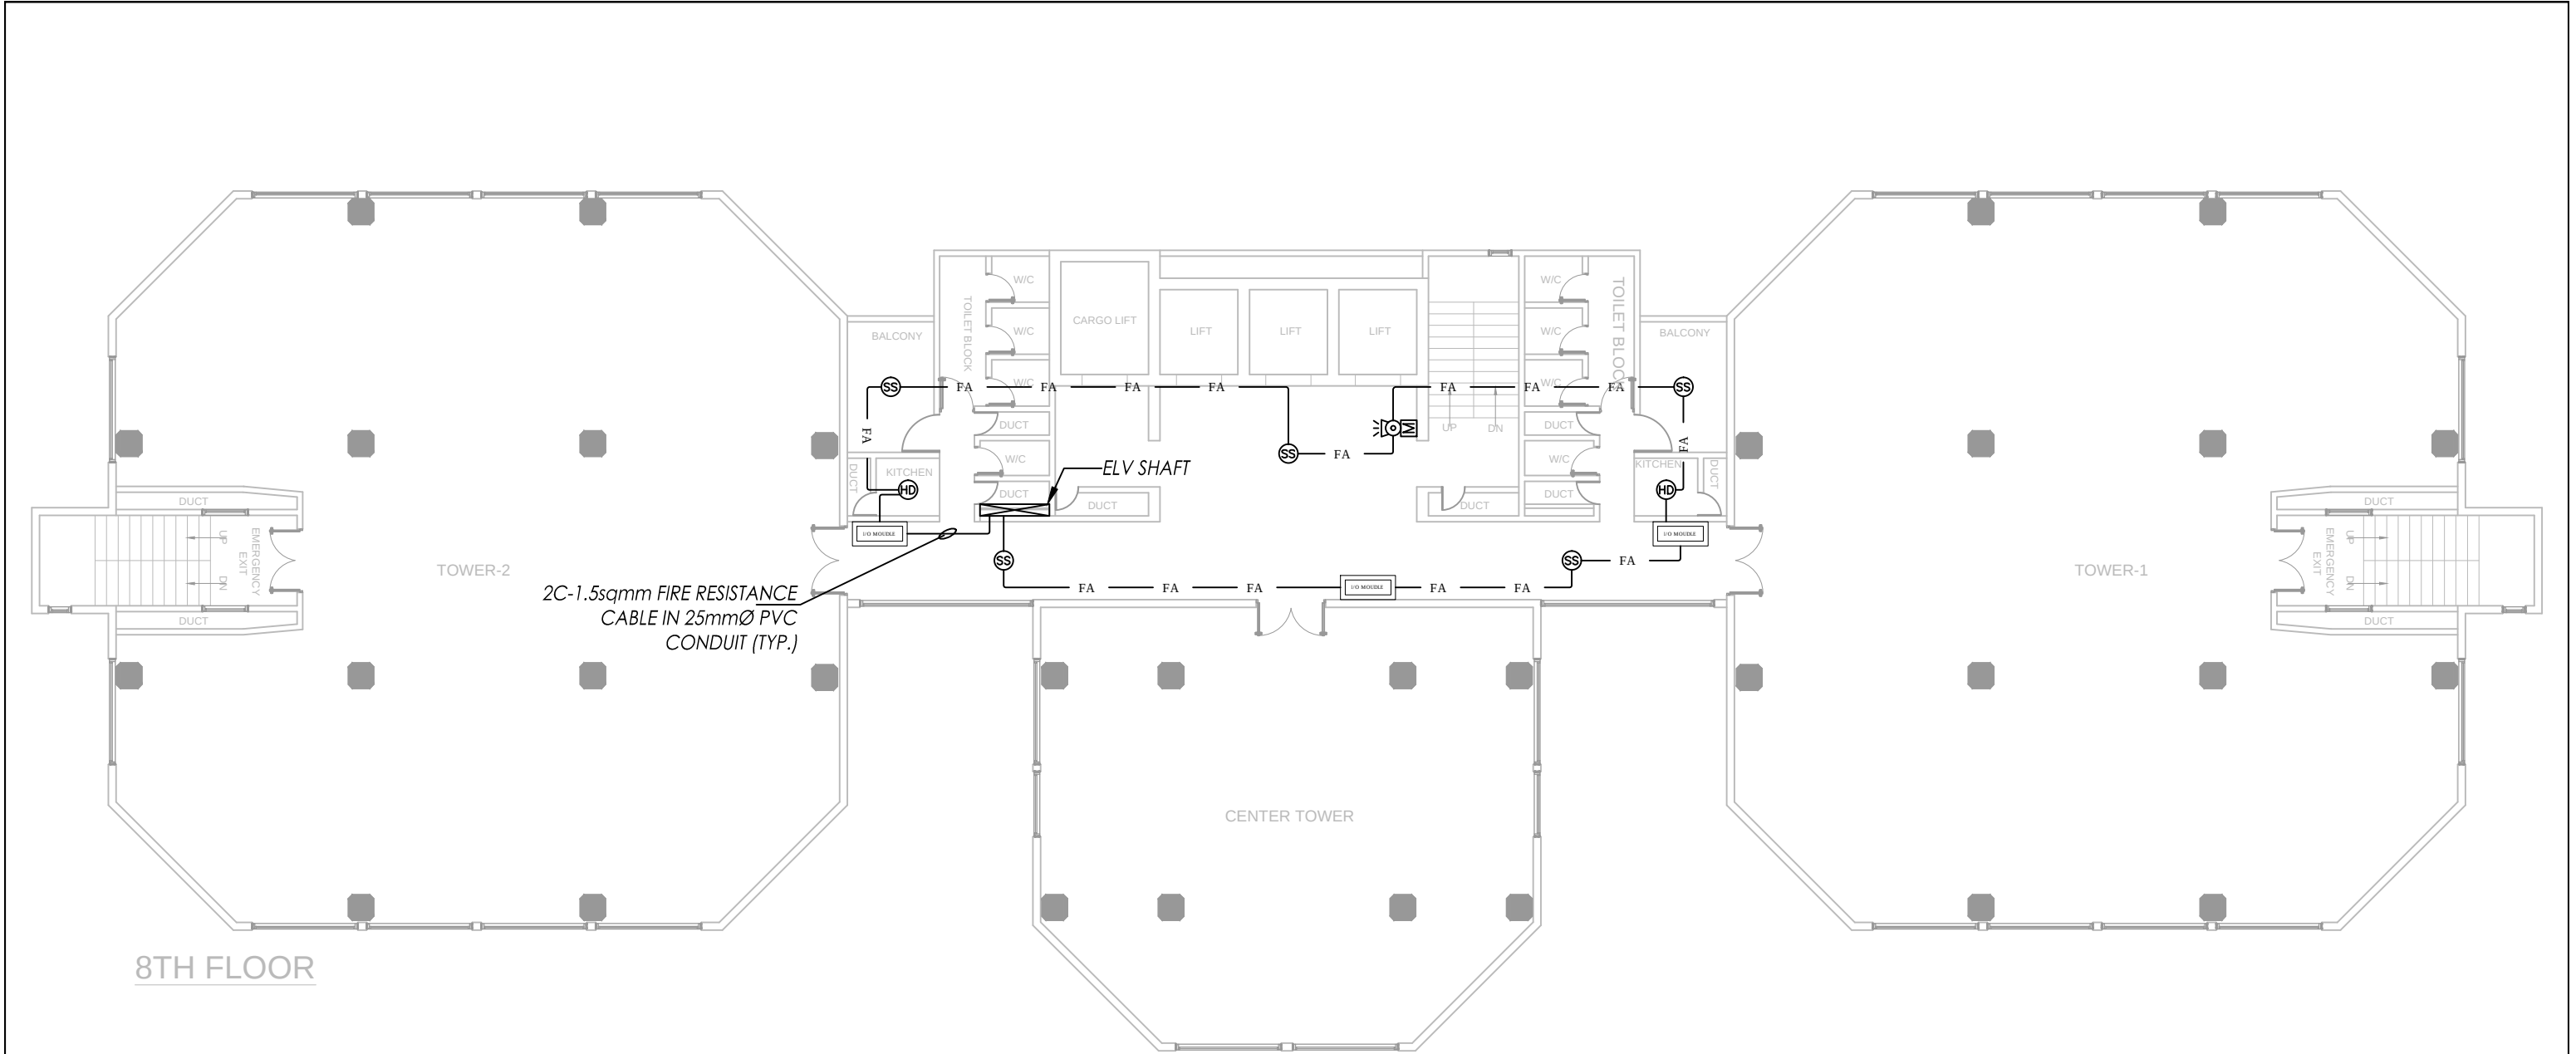

LEGENDS									
	SMOKE DETECTOR								CEILING
	HEAT DETECTOR								CEILING
	SOUNDER WITH FLASHER								8'-0" FFL
	MANUAL BREAK GLASS								3'-6" FFL
	INPUT/OUTPUT MODULE								WALL
	FIRE ALARM CONTROL PANEL								3'-6" FFL
REV #	DATE	DESCRIPTION	CHK'D	APP'D	Project Ref:		DATE		
					.		JUNE. 2026		
					DRAWN BY		SCALE		
					HASSAN KHAN		AS SHOWN		
					CHECKED BY		DWG. NO.		
					WAQAS SHAHAB		FA-14		

CLIENT:-



STATE LIFE
INSURANCE CORPORATION OF PAKISTAN

CONSULTANT:




Nexus
Consulting
Office A-202, Second Floor, Blossom Trade Center Opposite NED University
University Road, SB-26, Block No.01 Gulistan-e-Jouhar, Karachi Pakistan
Phone: 021-37240670
Email: nexusconsultingcompany@gmail.com Web: www.Nexuscon.pk

PROJECT:-

STATE LIFE BUILDING NO.11

TITLE:-

FIRE ALARM SYSTEM
EIGHT FLOOR

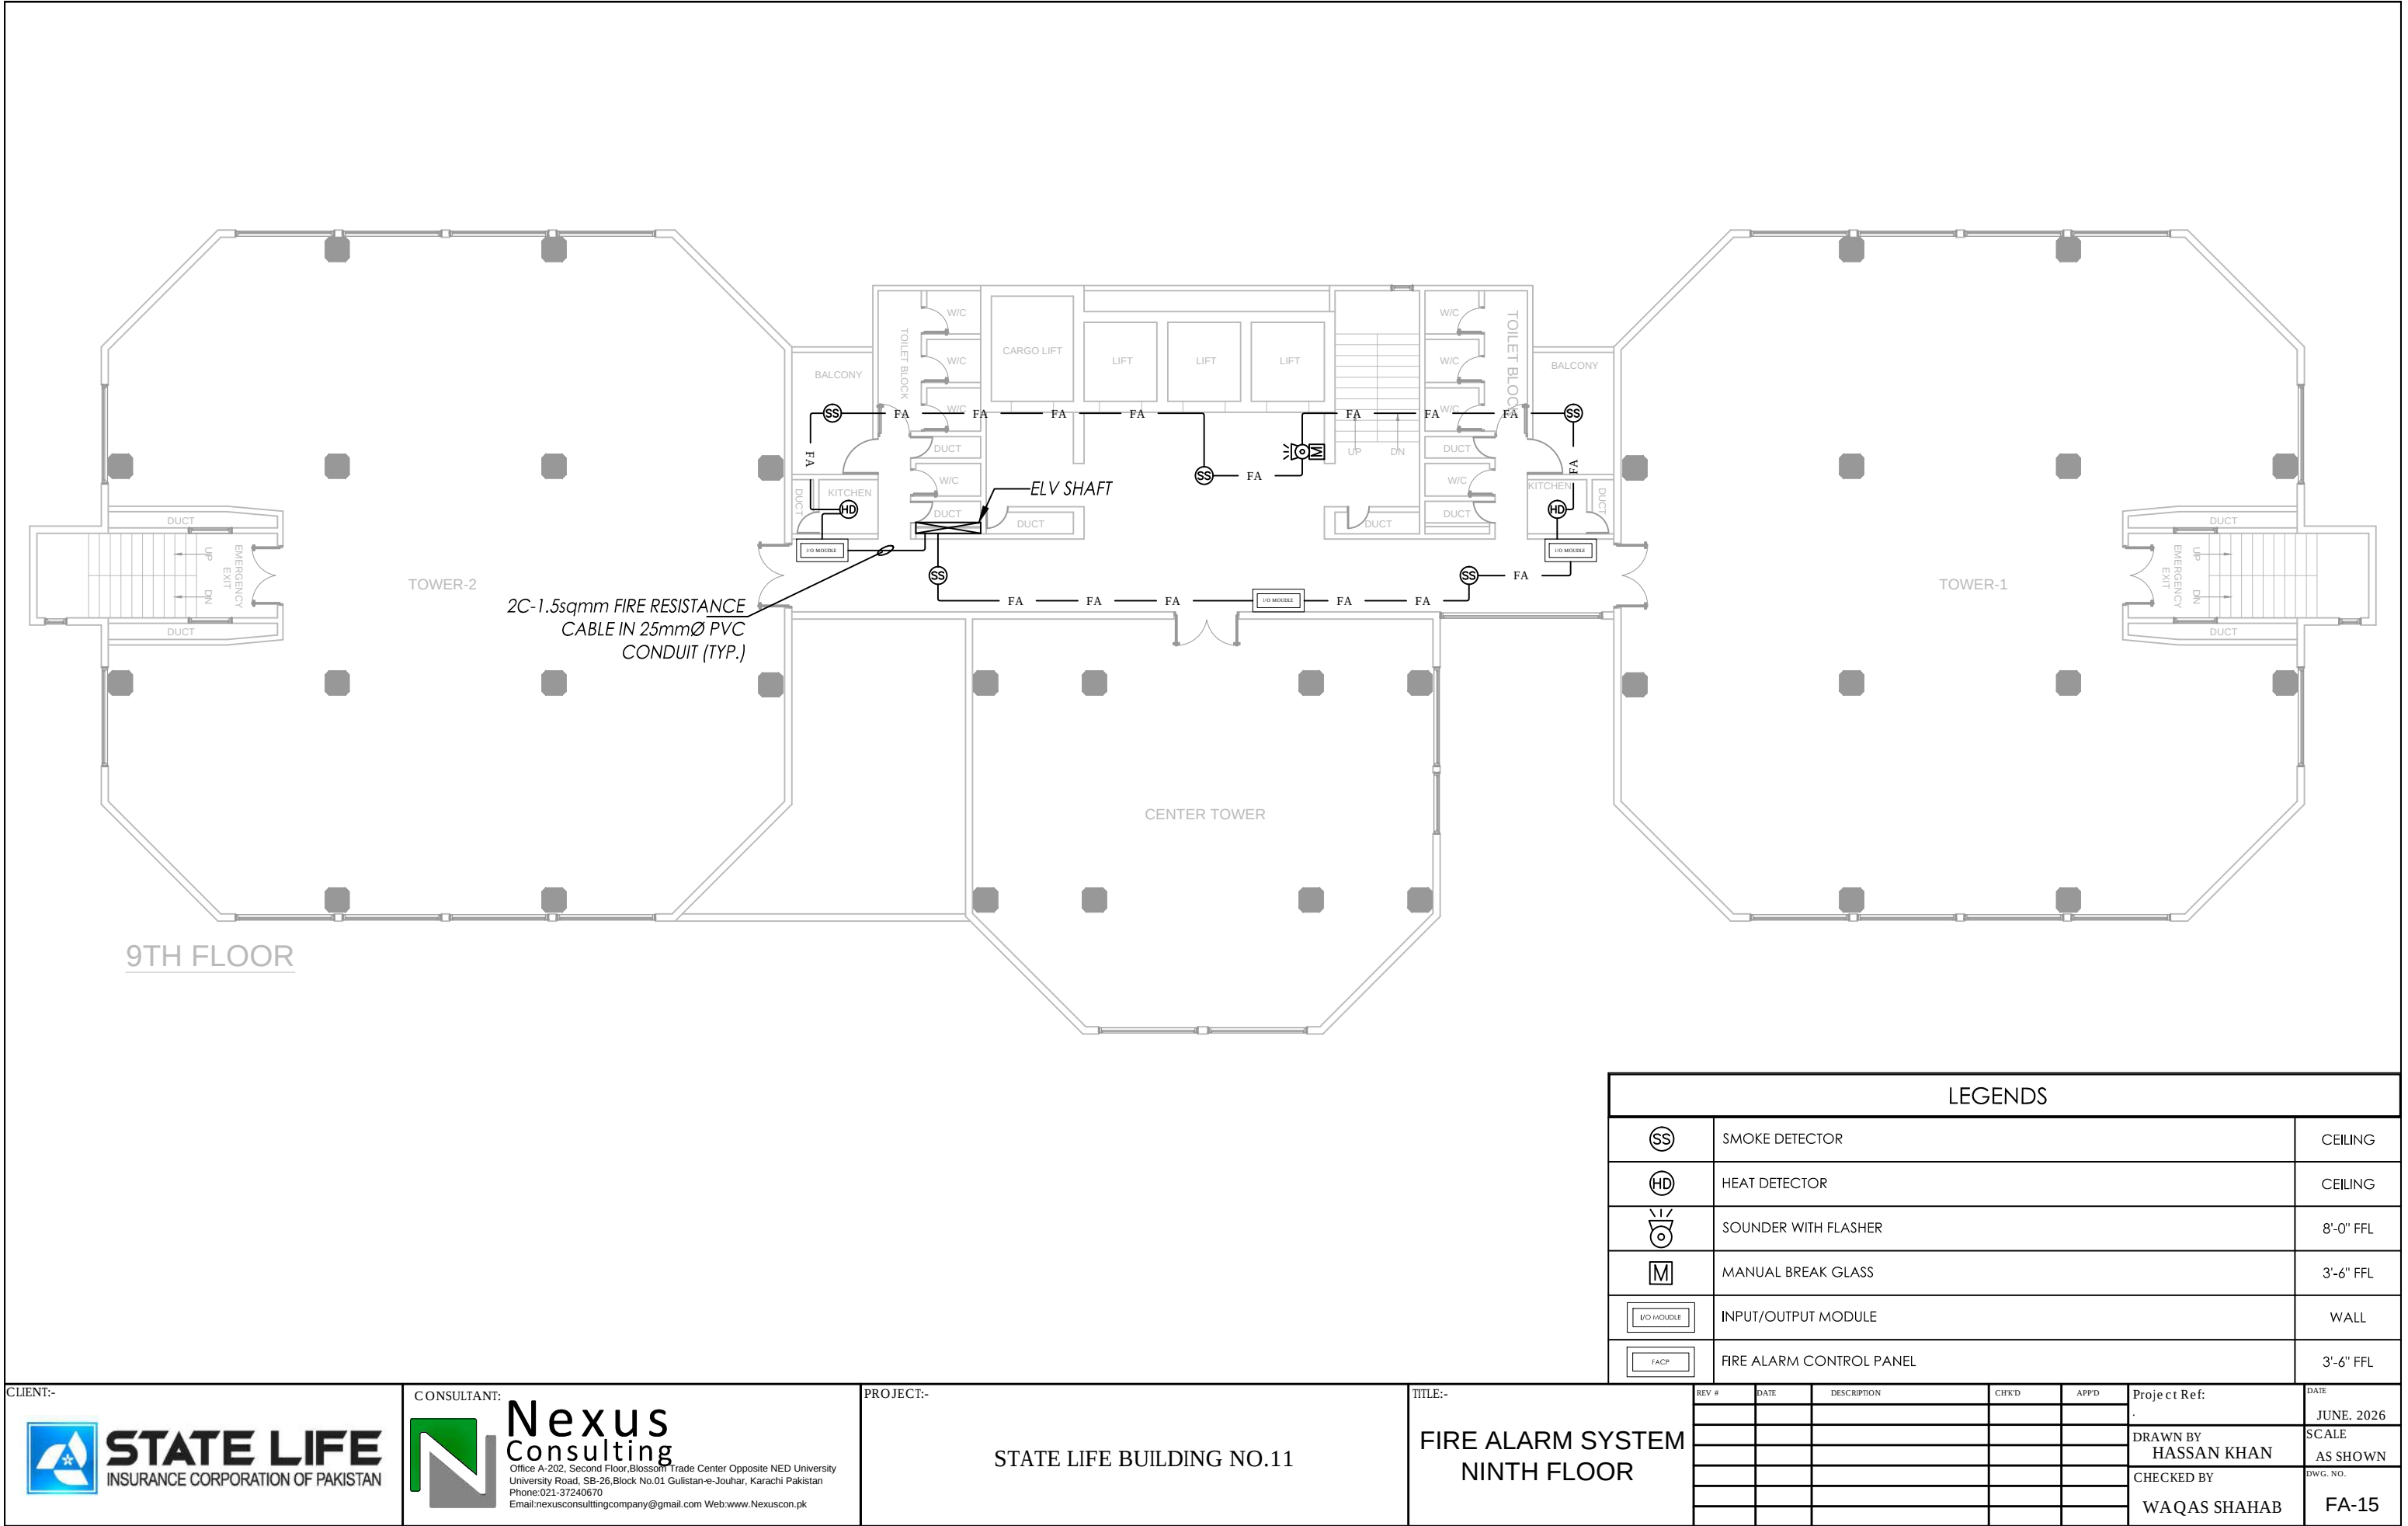

LEGENDS									
	SMOKE DETECTOR								CEILING
	HEAT DETECTOR								CEILING
	SOUNDER WITH FLASHER								8'-0" FFL
	MANUAL BREAK GLASS								3'-6" FFL
	INPUT/OUTPUT MODULE								WALL
	FIRE ALARM CONTROL PANEL								3'-6" FFL
REV #	DATE	DESCRIPTION	CHK'D	APP'D	Project Ref:		DATE		
					.		JUNE. 2026		
					DRAWN BY		SCALE		
					HASSAN KHAN		AS SHOWN		
					CHECKED BY		DWG. NO.		
					WAQAS SHAHAB		FA-15		

CLIENT:-



STATE LIFE
INSURANCE CORPORATION OF PAKISTAN

CONSULTANT:




Nexus
Consulting
Office A-202, Second Floor, Blossom Trade Center Opposite NED University
University Road, SB-26, Block No.01 Gulistan-e-Jouhar, Karachi Pakistan
Phone: 021-37240670
Email: nexusconsultingcompany@gmail.com Web: www.Nexuscon.pk

PROJECT:-

STATE LIFE BUILDING NO.11

TITLE:-

FIRE ALARM SYSTEM
NINTH FLOOR

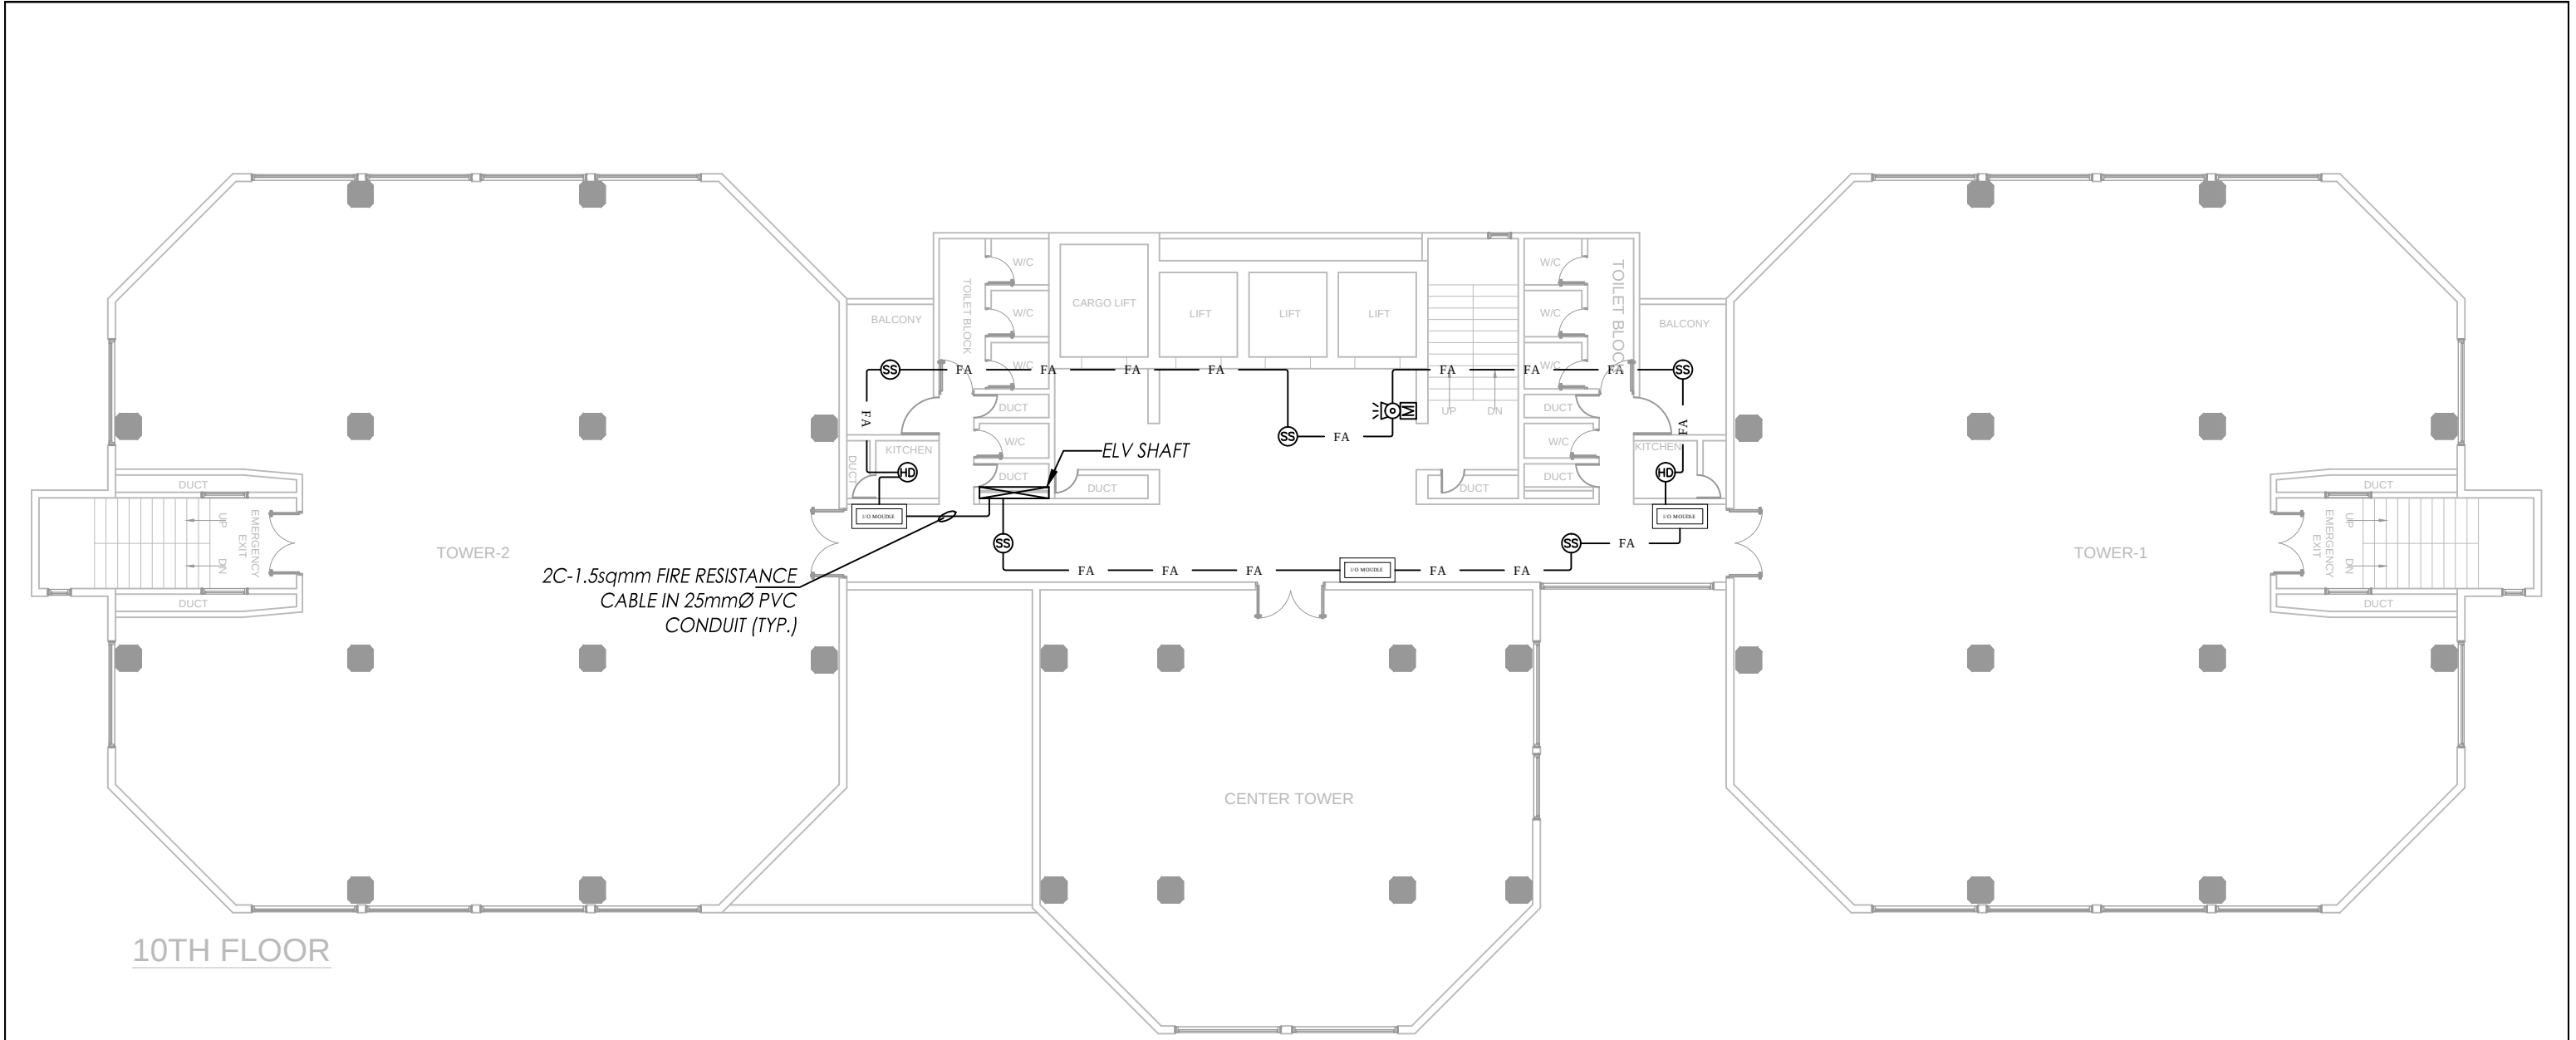

10TH FLOOR

LEGENDS									
	SMOKE DETECTOR								CEILING
	HEAT DETECTOR								CEILING
	SOUNDER WITH FLASHER								8'-0" FFL
	MANUAL BREAK GLASS								3'-6" FFL
	INPUT/OUTPUT MODULE								WALL
	FIRE ALARM CONTROL PANEL								3'-6" FFL
REV #	DATE	DESCRIPTION	CHK'D	APP'D	Project Ref:		DATE		
							JUNE. 2026		
					DRAWN BY		SCALE		
					HASSAN KHAN		AS SHOWN		
					CHECKED BY		DWG. NO.		
					WAQAS SHAHAB		FA-16		

CLIENT:-



STATE LIFE
INSURANCE CORPORATION OF PAKISTAN

CONSULTANT:




Nexus
Consulting
Office A-202, Second Floor, Blossom Trade Center Opposite NED University
University Road, SB-26, Block No.01 Gulistan-e-Jouhar, Karachi Pakistan
Phone: 021-37240670
Email: nexusconsultingcompany@gmail.com Web: www.Nexuscon.pk


PROJECT:-

STATE LIFE BUILDING NO.11

TITLE:-

FIRE ALARM SYSTEM
TENTH FLOOR

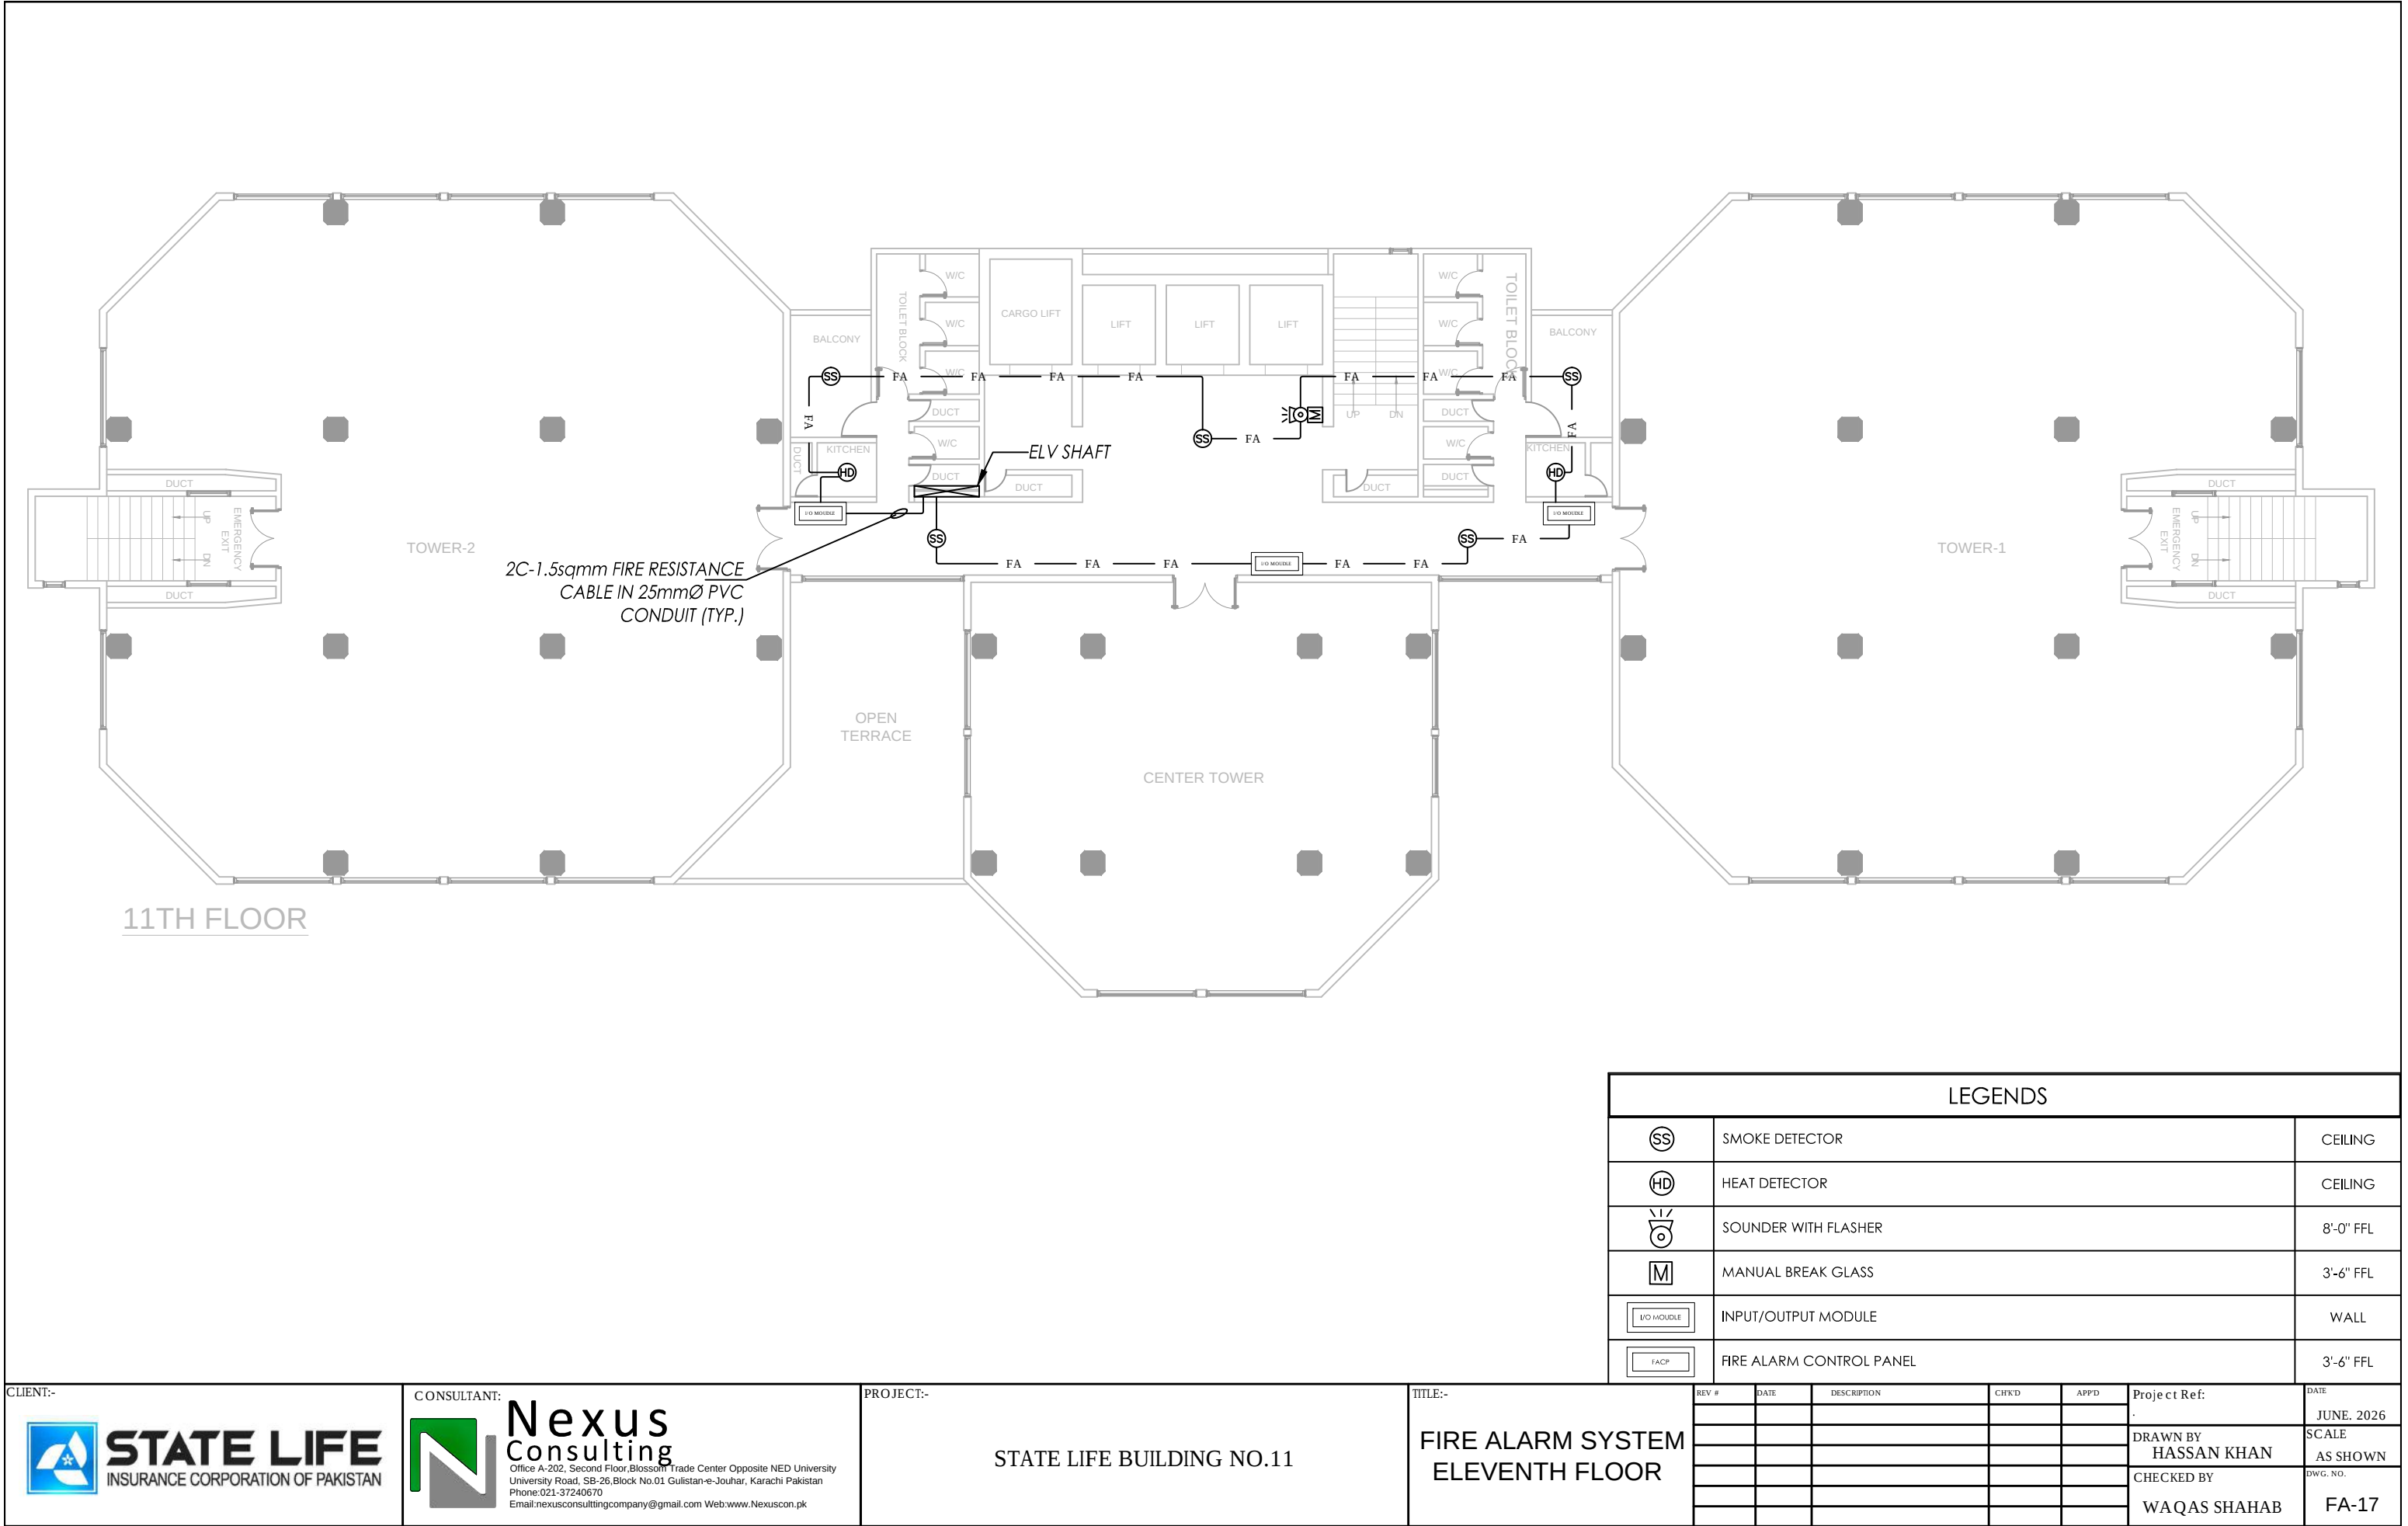

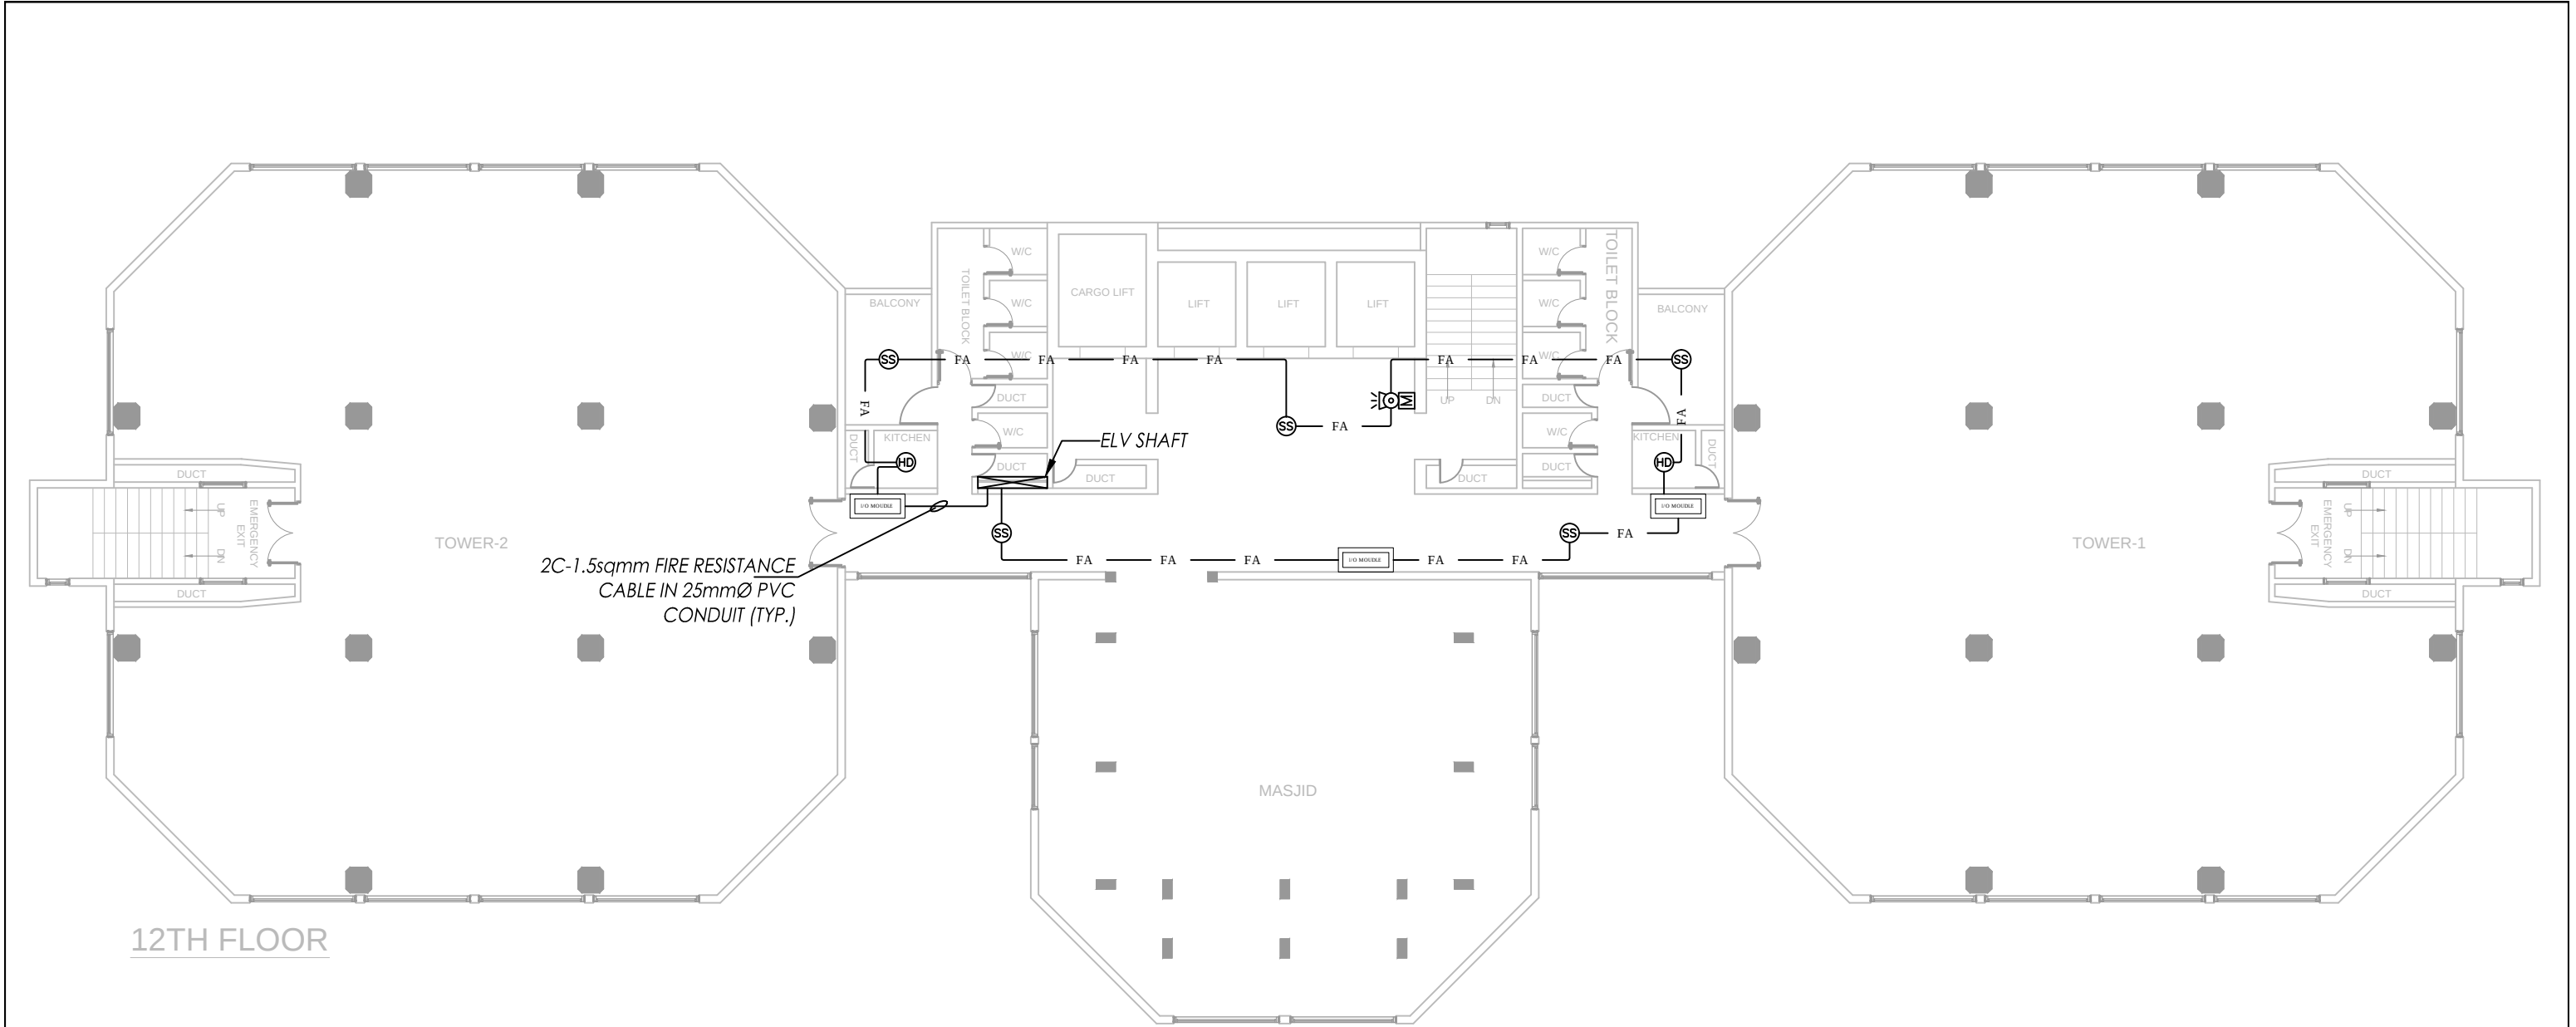

LEGENDS									
	SMOKE DETECTOR								CEILING
	HEAT DETECTOR								CEILING
	SOUNDER WITH FLASHER								8'-0" FFL
	MANUAL BREAK GLASS								3'-6" FFL
	INPUT/OUTPUT MODULE								WALL
	FIRE ALARM CONTROL PANEL								3'-6" FFL

REV #	DATE	DESCRIPTION	CHK'D	APP'D	Project Ref:	DATE
						JUNE. 2026
					DRAWN BY HASSAN KHAN	SCALE AS SHOWN
					CHECKED BY WAQAS SHAHAB	DWG. NO. FA-18

CLIENT:-



STATE LIFE
INSURANCE CORPORATION OF PAKISTAN

CONSULTANT:




Nexus
Consulting
Office A-202, Second Floor, Blossom Trade Center Opposite NED University
University Road, SB-26, Block No.01 Gulistan-e-Jouhar, Karachi Pakistan
Phone: 021-37240670
Email: nexusconsultingcompany@gmail.com Web: www.Nexuscon.pk

PROJECT:-

STATE LIFE BUILDING NO.11

TITLE:-

FIRE ALARM SYSTEM
TWELFTH FLOOR

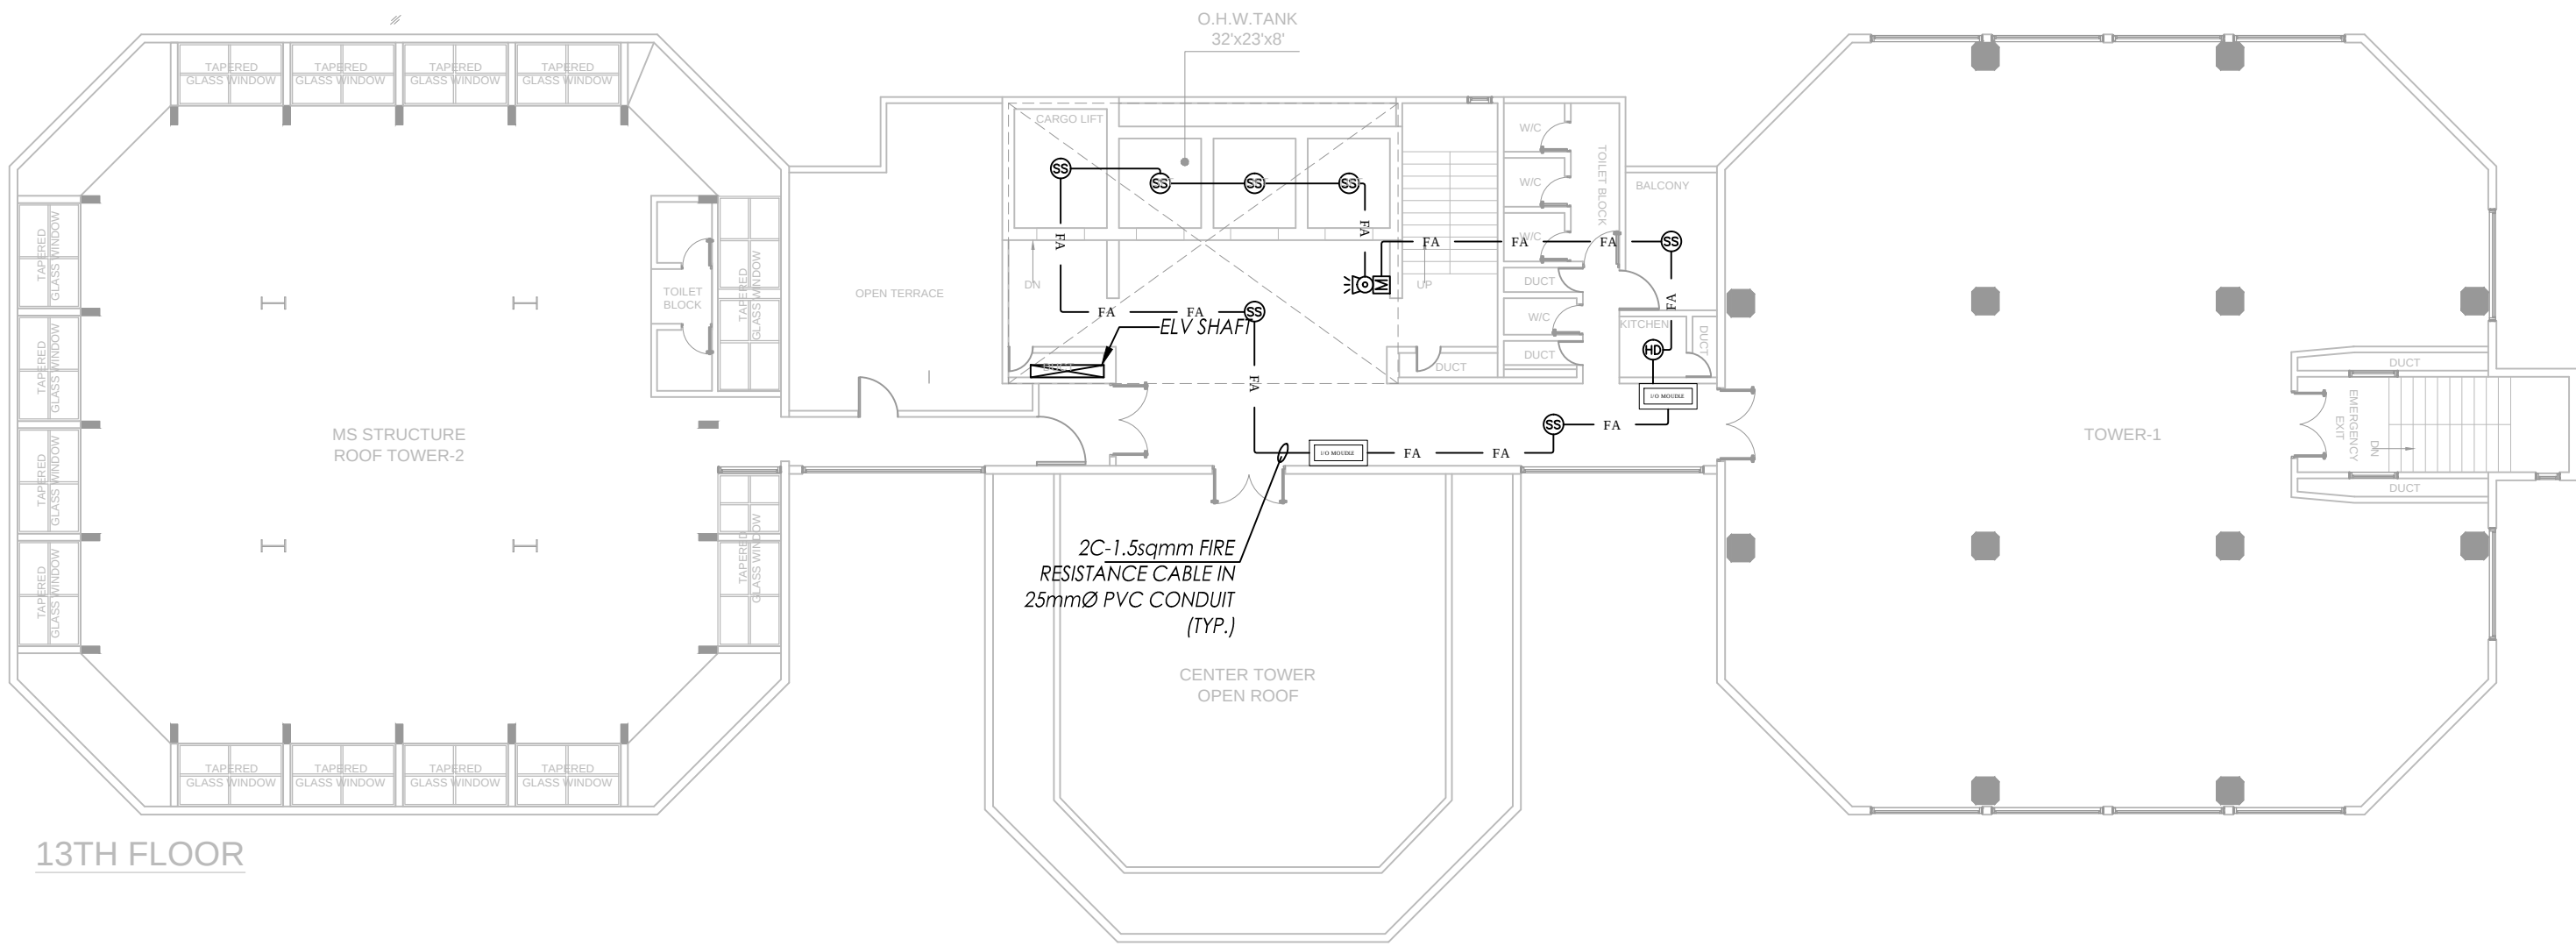

13TH FLOOR

LEGENDS									
	SMOKE DETECTOR								CEILING
	HEAT DETECTOR								CEILING
	SOUNDER WITH FLASHER								8'-0" FFL
	MANUAL BREAK GLASS								3'-6" FFL
	INPUT/OUTPUT MODULE								WALL
	FIRE ALARM CONTROL PANEL								3'-6" FFL
REV #	DATE	DESCRIPTION	CHK'D	APP'D	Project Ref:		DATE		
							JUNE. 2026		
					DRAWN BY		SCALE		
					HASSAN KHAN		AS SHOWN		
					CHECKED BY		DWG. NO.		
					WAQAS SHAHAB		FA-19		

CLIENT:-

CONSULTANT:

Nexus
Consulting
Office A-202, Second Floor, Blossom Trade Center Opposite NED University
University Road, SB-26, Block No.01 Gulistan-e-Johar, Karachi Pakistan
Phone: 021-37240670
Email: nexusconsultingcompany@gmail.com Web: www.Nexuscon.pk


PROJECT:-

STATE LIFE BUILDING NO.11

TITLE:-

FIRE ALARM SYSTEM
THIRTEEN FLOOR

FIRE ALARM SYSTEM CEILING

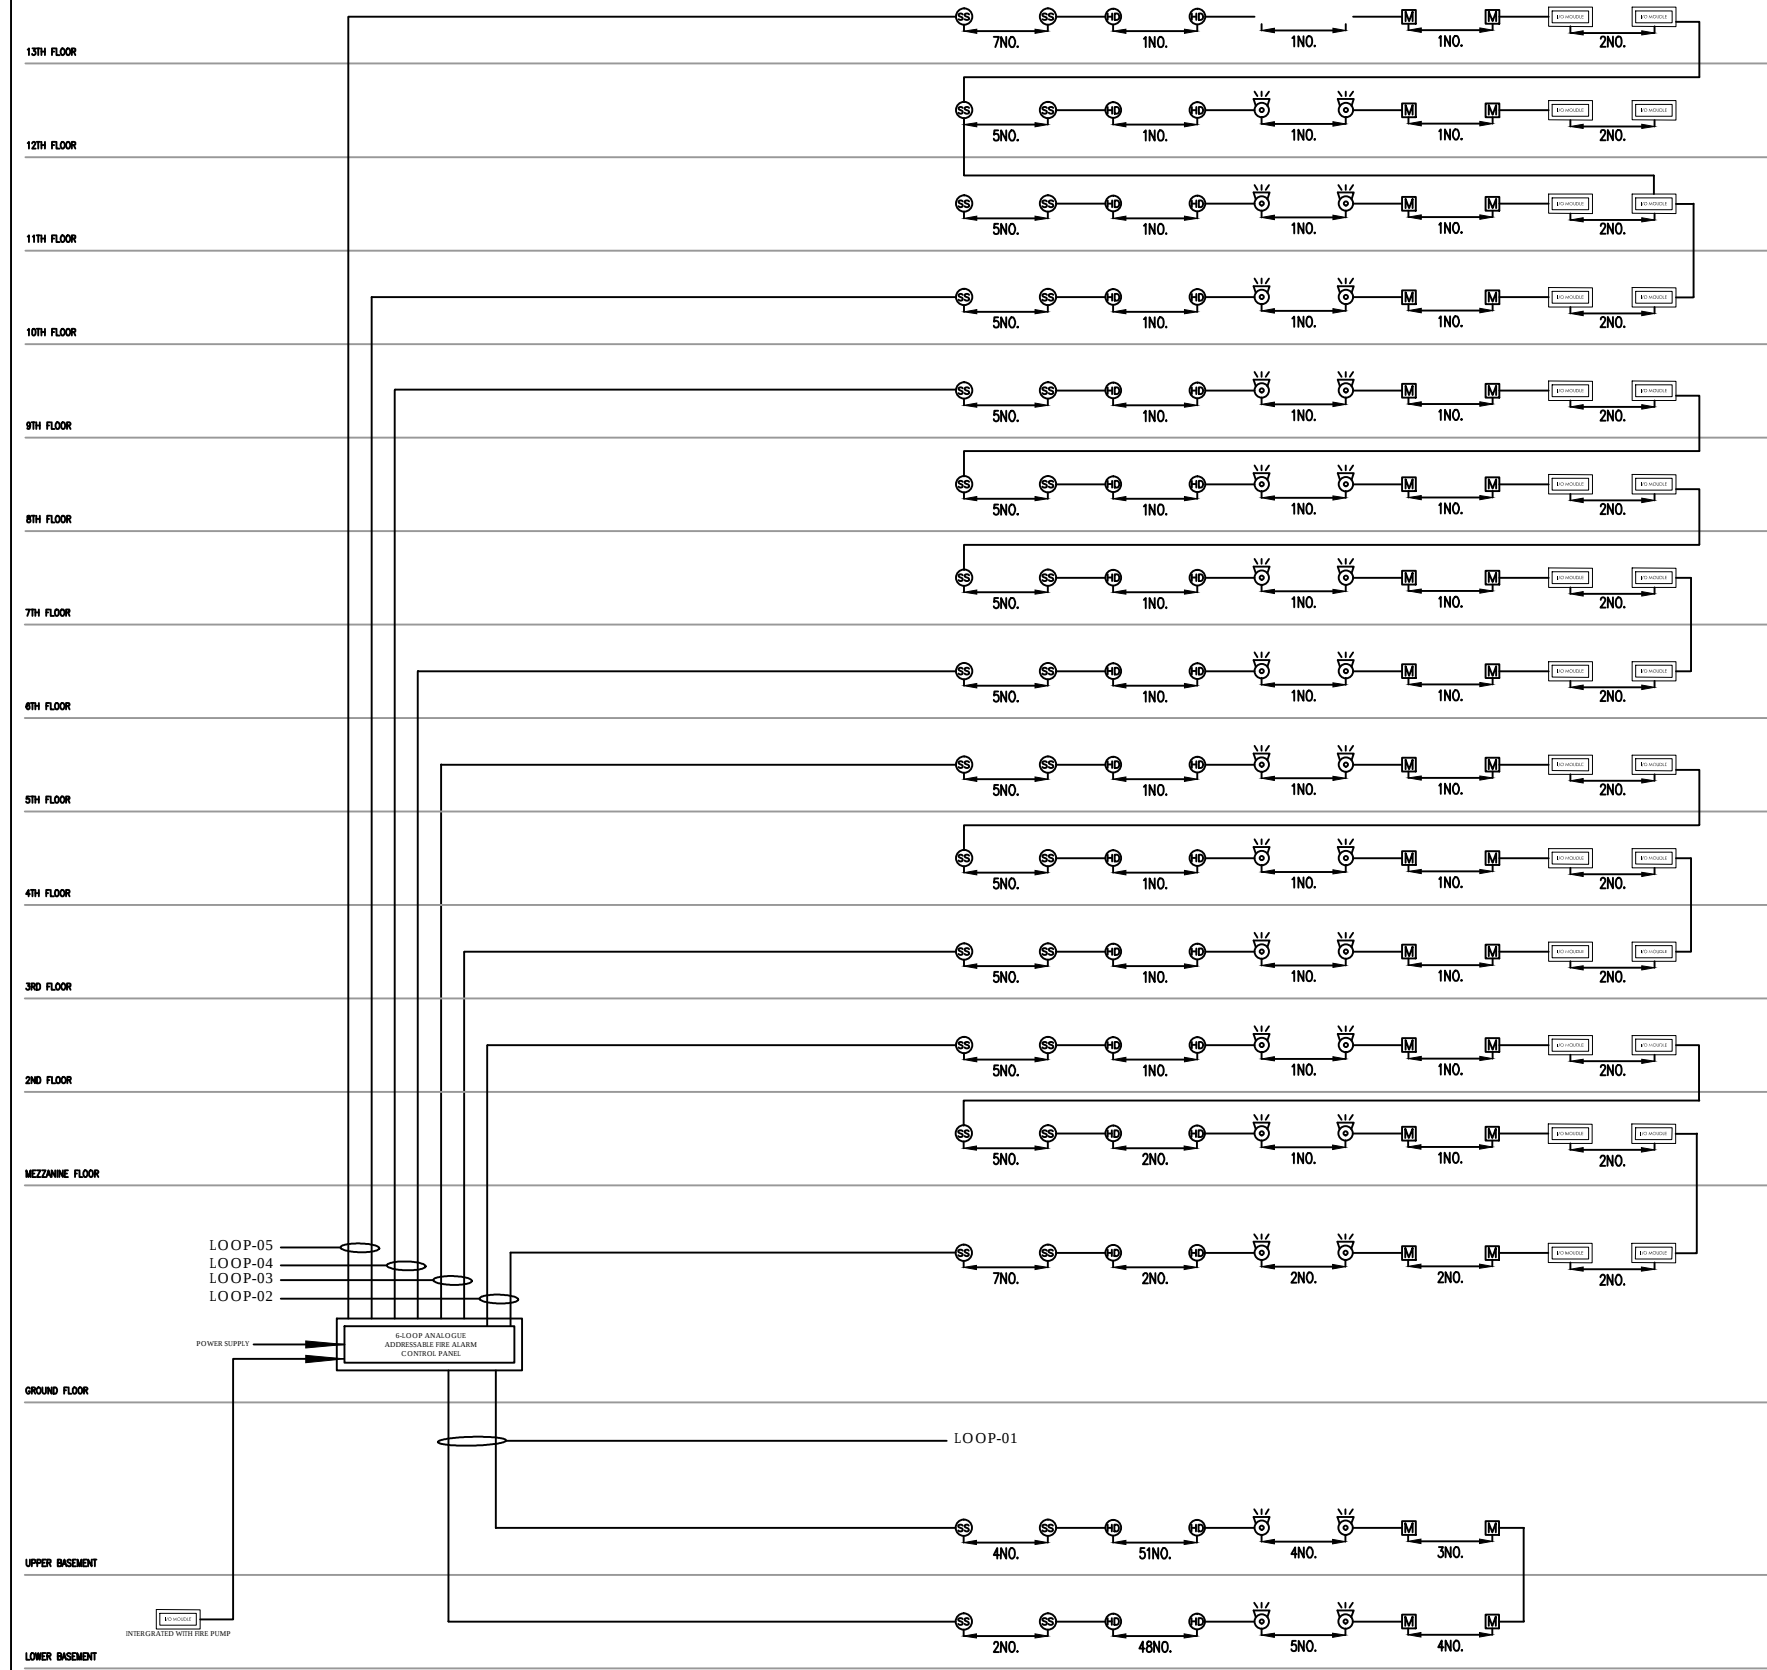

CLIENT:-  STATE LIFE INSURANCE CORPORATION OF PAKISTAN	CONSULTANT:-  Nexus Consulting Office A-202, Second Floor, Blossom Trade Center Opposite NED University University Road, SB-26, Block No.01 Gulistan-e-Jouhar, Karachi Pakistan Phone: 021-37240670 Email: nexusconsultingcompany@gmail.com Web: www.Nexuscon.pk	PROJECT:- STATE LIFE BUILDING NO.11	TITLE:- FIRE ALARM SYSTEM RISER	REV #	DATE	DESCRIPTION	CHK'D	APP'D	Project Ref:	DATE
										JUNE, 2026
									DRAWN BY HASSAN KHAN	SCALE AS SHOWN
									CHECKED BY WAQAS SHAHAB	DWG. NO. FA-20

STATE LIFE BUILDING NO.11


(LOWER BASEMENT, TO 13th FLOOR)

CLIENT:



CONSULTANT:




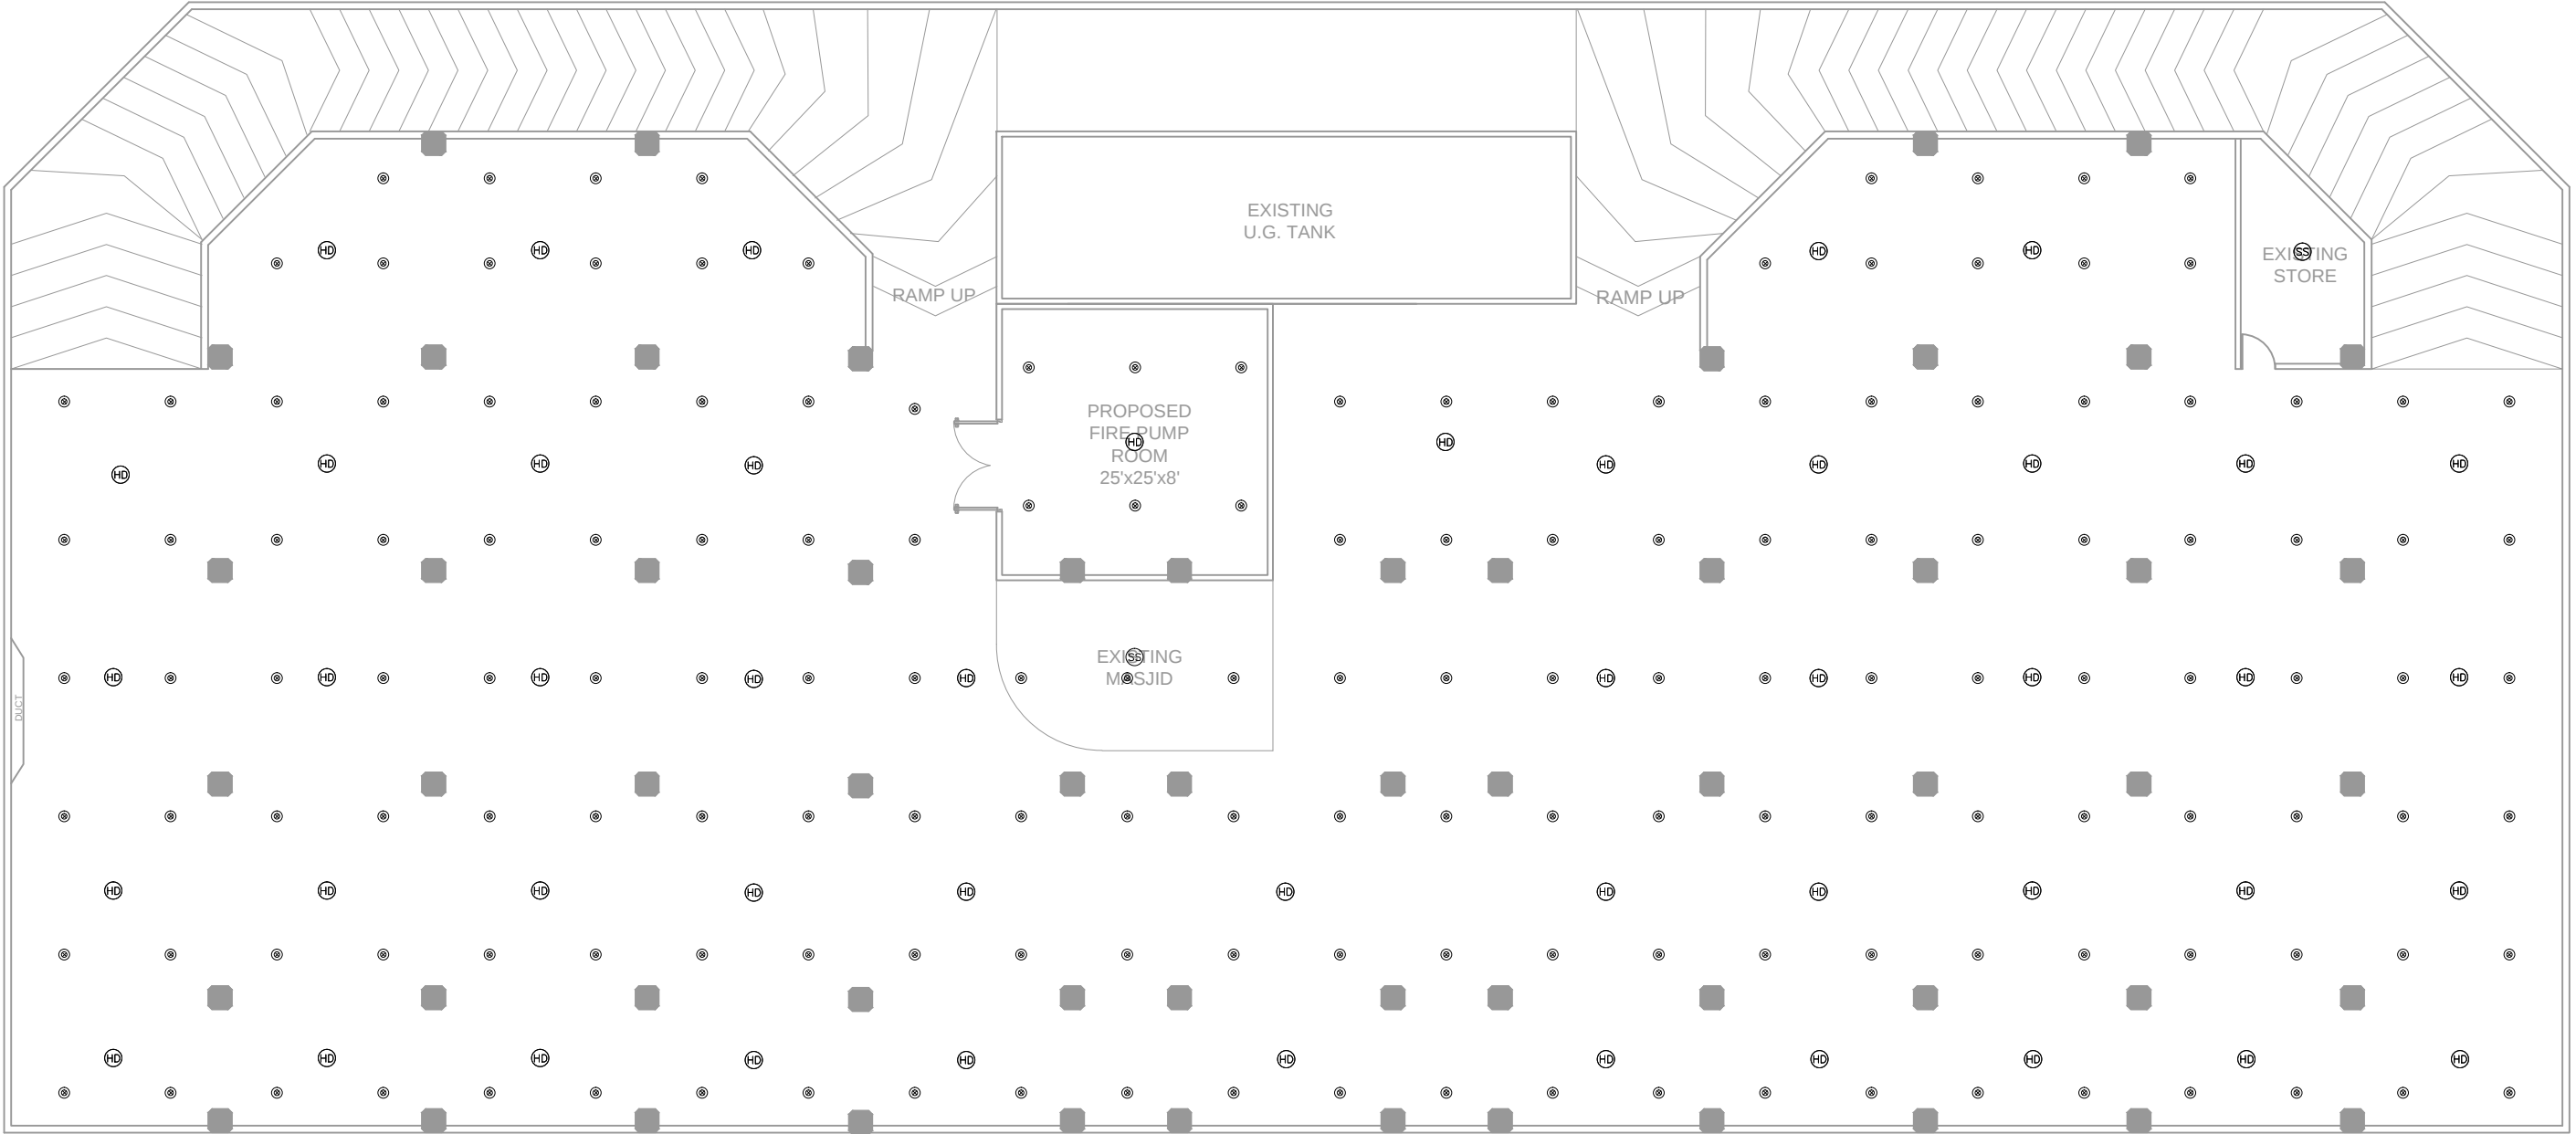

LOWER BASEMENT

LEGENDS		
	SMOKE DETECTOR	CEILING
	HEAT DETECTOR	CEILING
	PENDENT CONCEALED SPRINKLER	CEILING
	UPRIGHT SPRINKLER	
	REELECTED CEILING AREA	

CLIENT:- 	CONSULTANT:  Nexus Consulting Office A-202, Second Floor, Blossom Trade Center Opposite NED University University Road, SB-26, Block No.01 Gulistan-e-Jouhar, Karachi Pakistan Phone: 021-37240670 Email: nexusconsultingcompany@gmail.com Web: www.Nexuscon.pk	PROJECT:- STATE LIFE BUILDING NO.11	TITLE:- BUILDING CEILING PLAN	REV #	DATE	DESCRIPTION	CHKD	APPD	Project Ref:	DATE		
											JULY, 2026	
											DRAWN BY	SCALE
										A-A	AS SHOWN	
										CHECKED BY	DWG. NO.	
										O-A	BC-01	

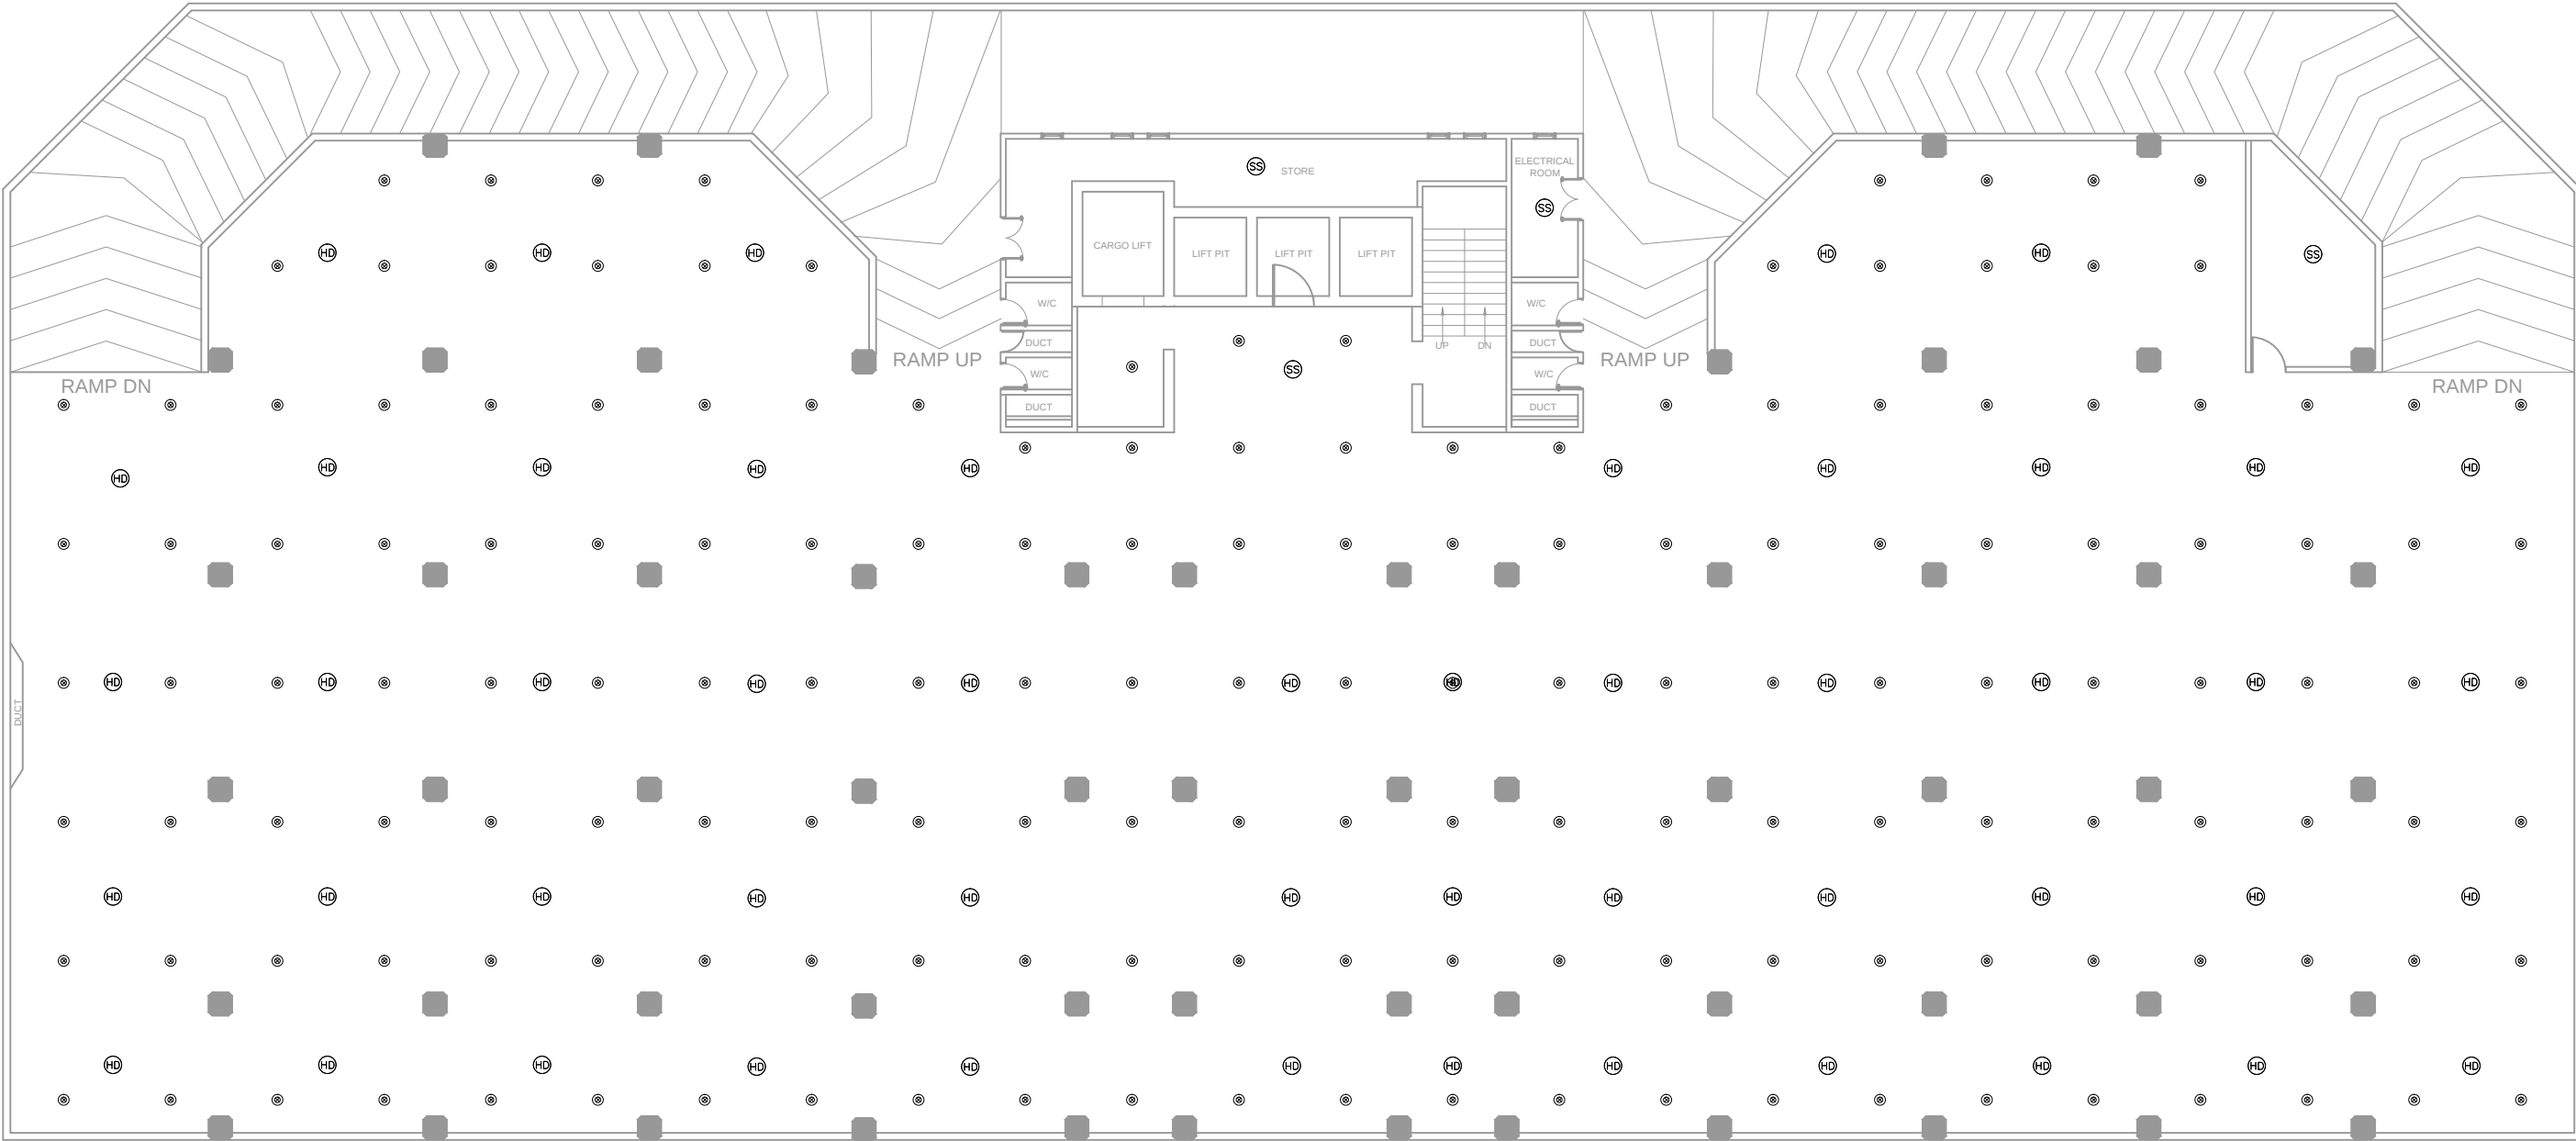

UPPER BASEMENT

LEGENDS		
SS	SMOKE DETECTOR	CEILING
HD	HEAT DETECTOR	CEILING
@	PENDENT CONCEALED SPRINKLER	CEILING
⊗	UPRIGHT SPRINKLER	
	REELECTED CEILING AREA	

CLIENT:-



STATE LIFE
INSURANCE CORPORATION OF PAKISTAN

CONSULTANT:



Nexus
Consulting
Office A-202, Second Floor, Blossom Trade Center Opposite NED University
University Road, SB-26, Block No.01 Gulistan-e-Jouhar, Karachi Pakistan
Phone: 021-37240670
Email: nexusconsultingcompany@gmail.com Web: www.Nexuscon.pk


PROJECT:-

STATE LIFE BUILDING NO.11

TITLE:-

BUILDING
CEILING PLAN


REV #	DATE	DESCRIPTION	CHKD	APPD	Project Ref:	DATE
					.	JULY, 2026
					DRAWN BY A-A	SCALE AS SHOWN
					CHECKED BY O-A	DWG. NO. BC-02

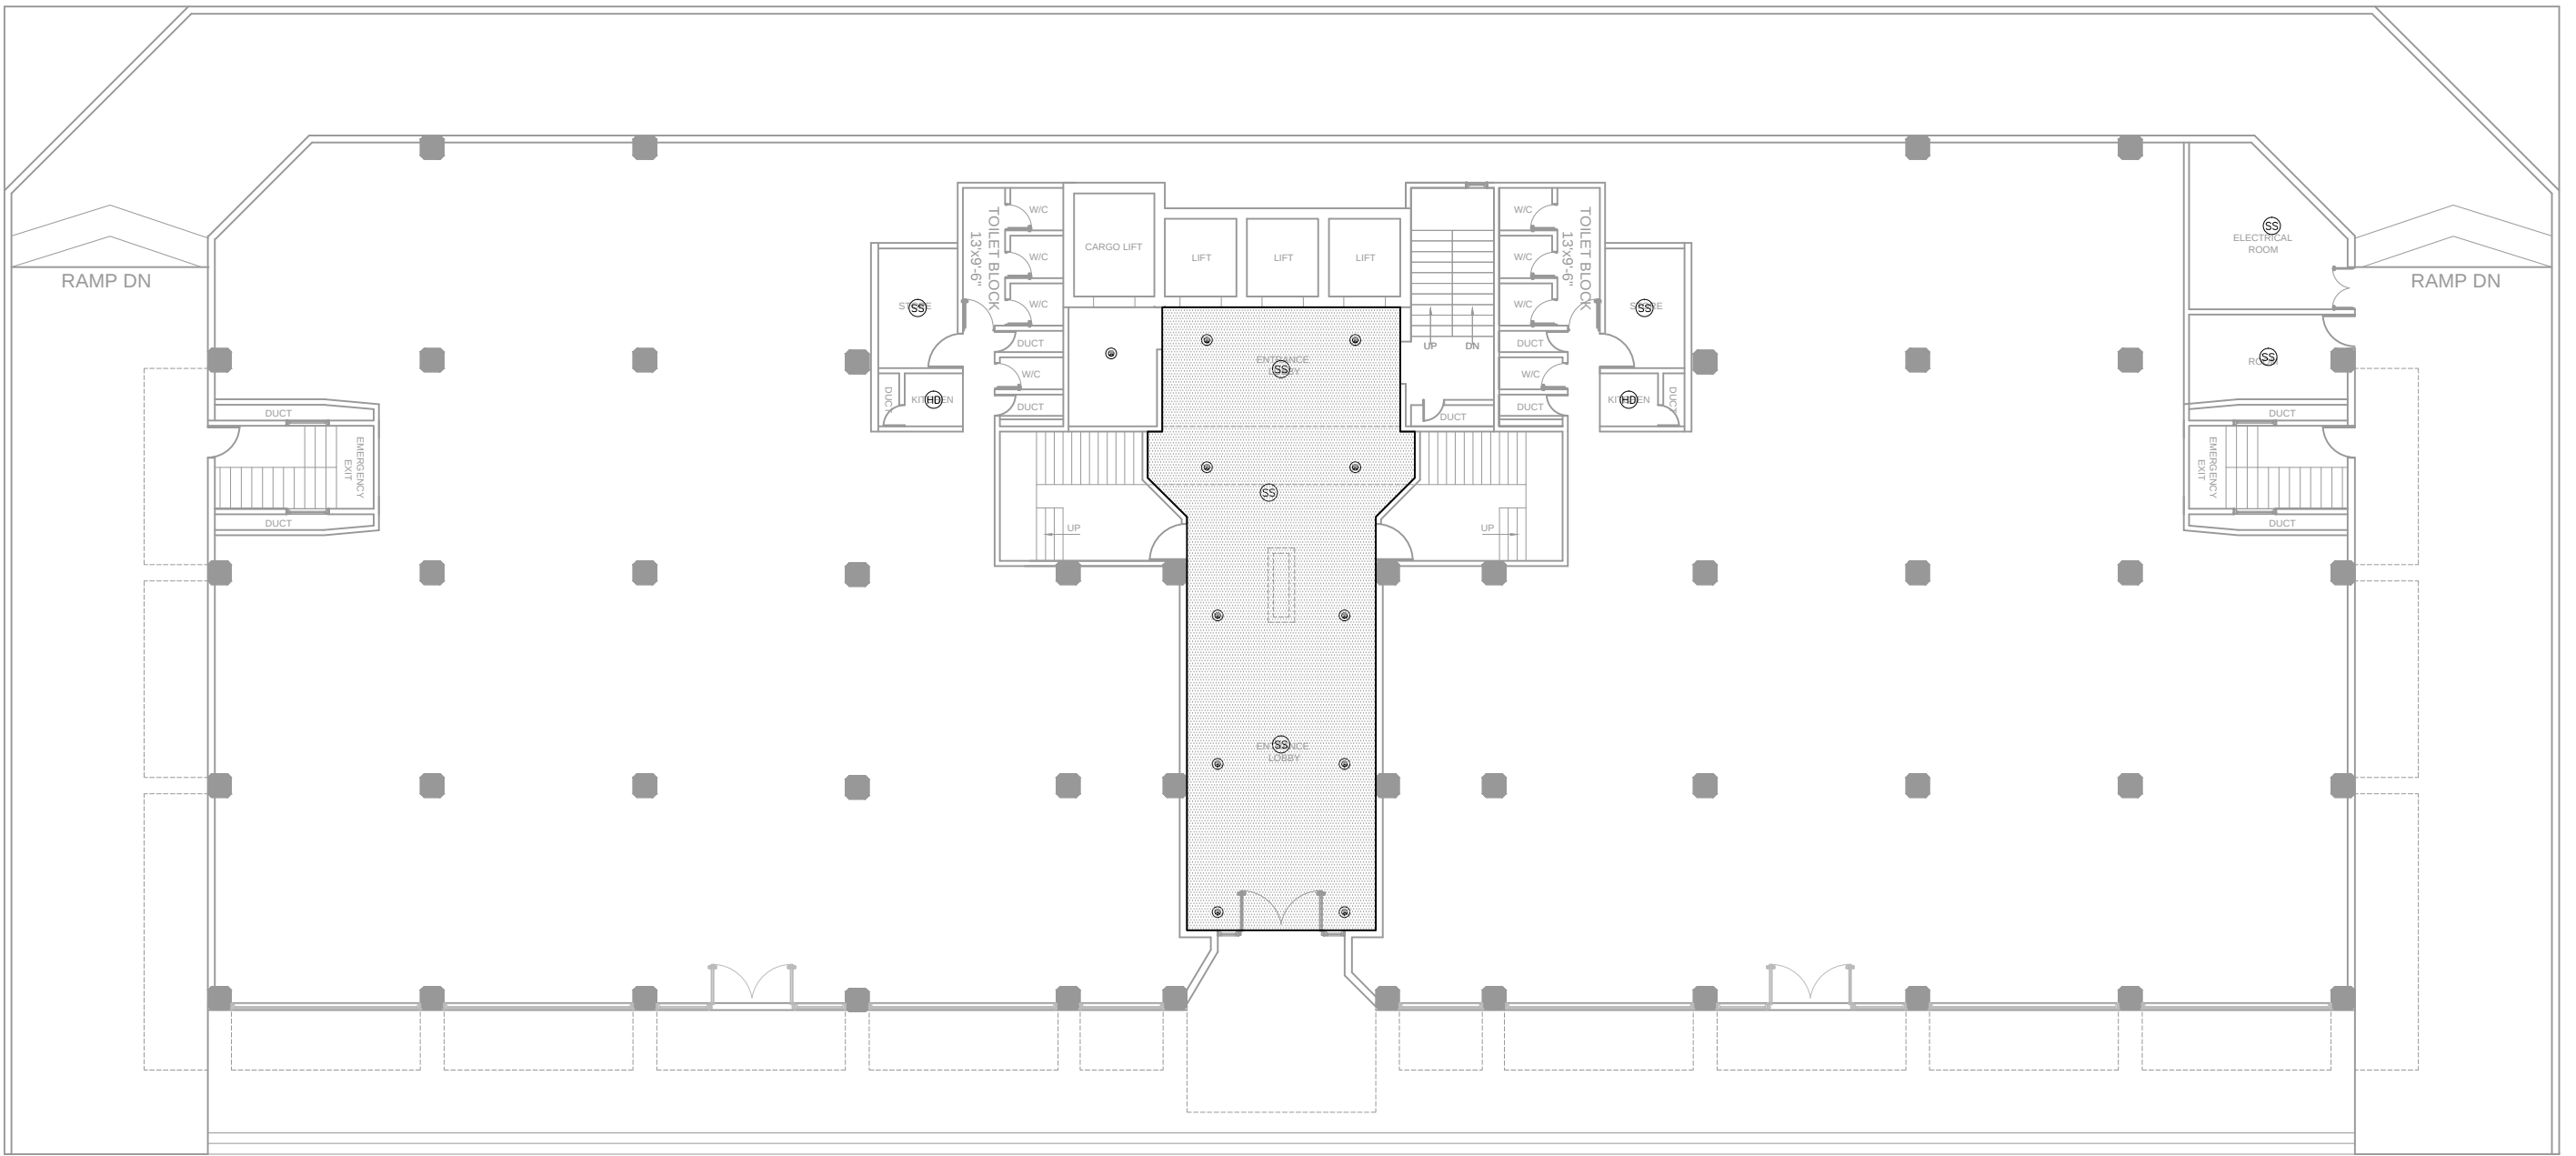

GROUND FLOOR

LEGENDS		
SS	SMOKE DETECTOR	CEILING
HD	HEAT DETECTOR	CEILING
@	PENDENT CONCEALED SPRINKLER	CEILING
⊗	UPRIGHT SPRINKLER	
	REFLECTED CEILING AREA	

CLIENT:-  STATE LIFE INSURANCE CORPORATION OF PAKISTAN	CONSULTANT:  Nexus Consulting Office A-202, Second Floor, Blossom Trade Center Opposite NED University University Road, SB-26, Block No.01 Gulistan-e-Jouhar, Karachi Pakistan Phone: 021-37240670 Email: nexusconsultingcompany@gmail.com Web: www.Nexuscon.pk	PROJECT:- STATE LIFE BUILDING NO.11	TITLE:- BUILDING CEILING PLAN	REV #	DATE	DESCRIPTION	CHKD	APPD	Project Ref:	DATE
										JULY, 2026
									DRAWN BY A-A	SCALE AS SHOWN
									CHECKED BY O-A	DWG. NO. BC-03

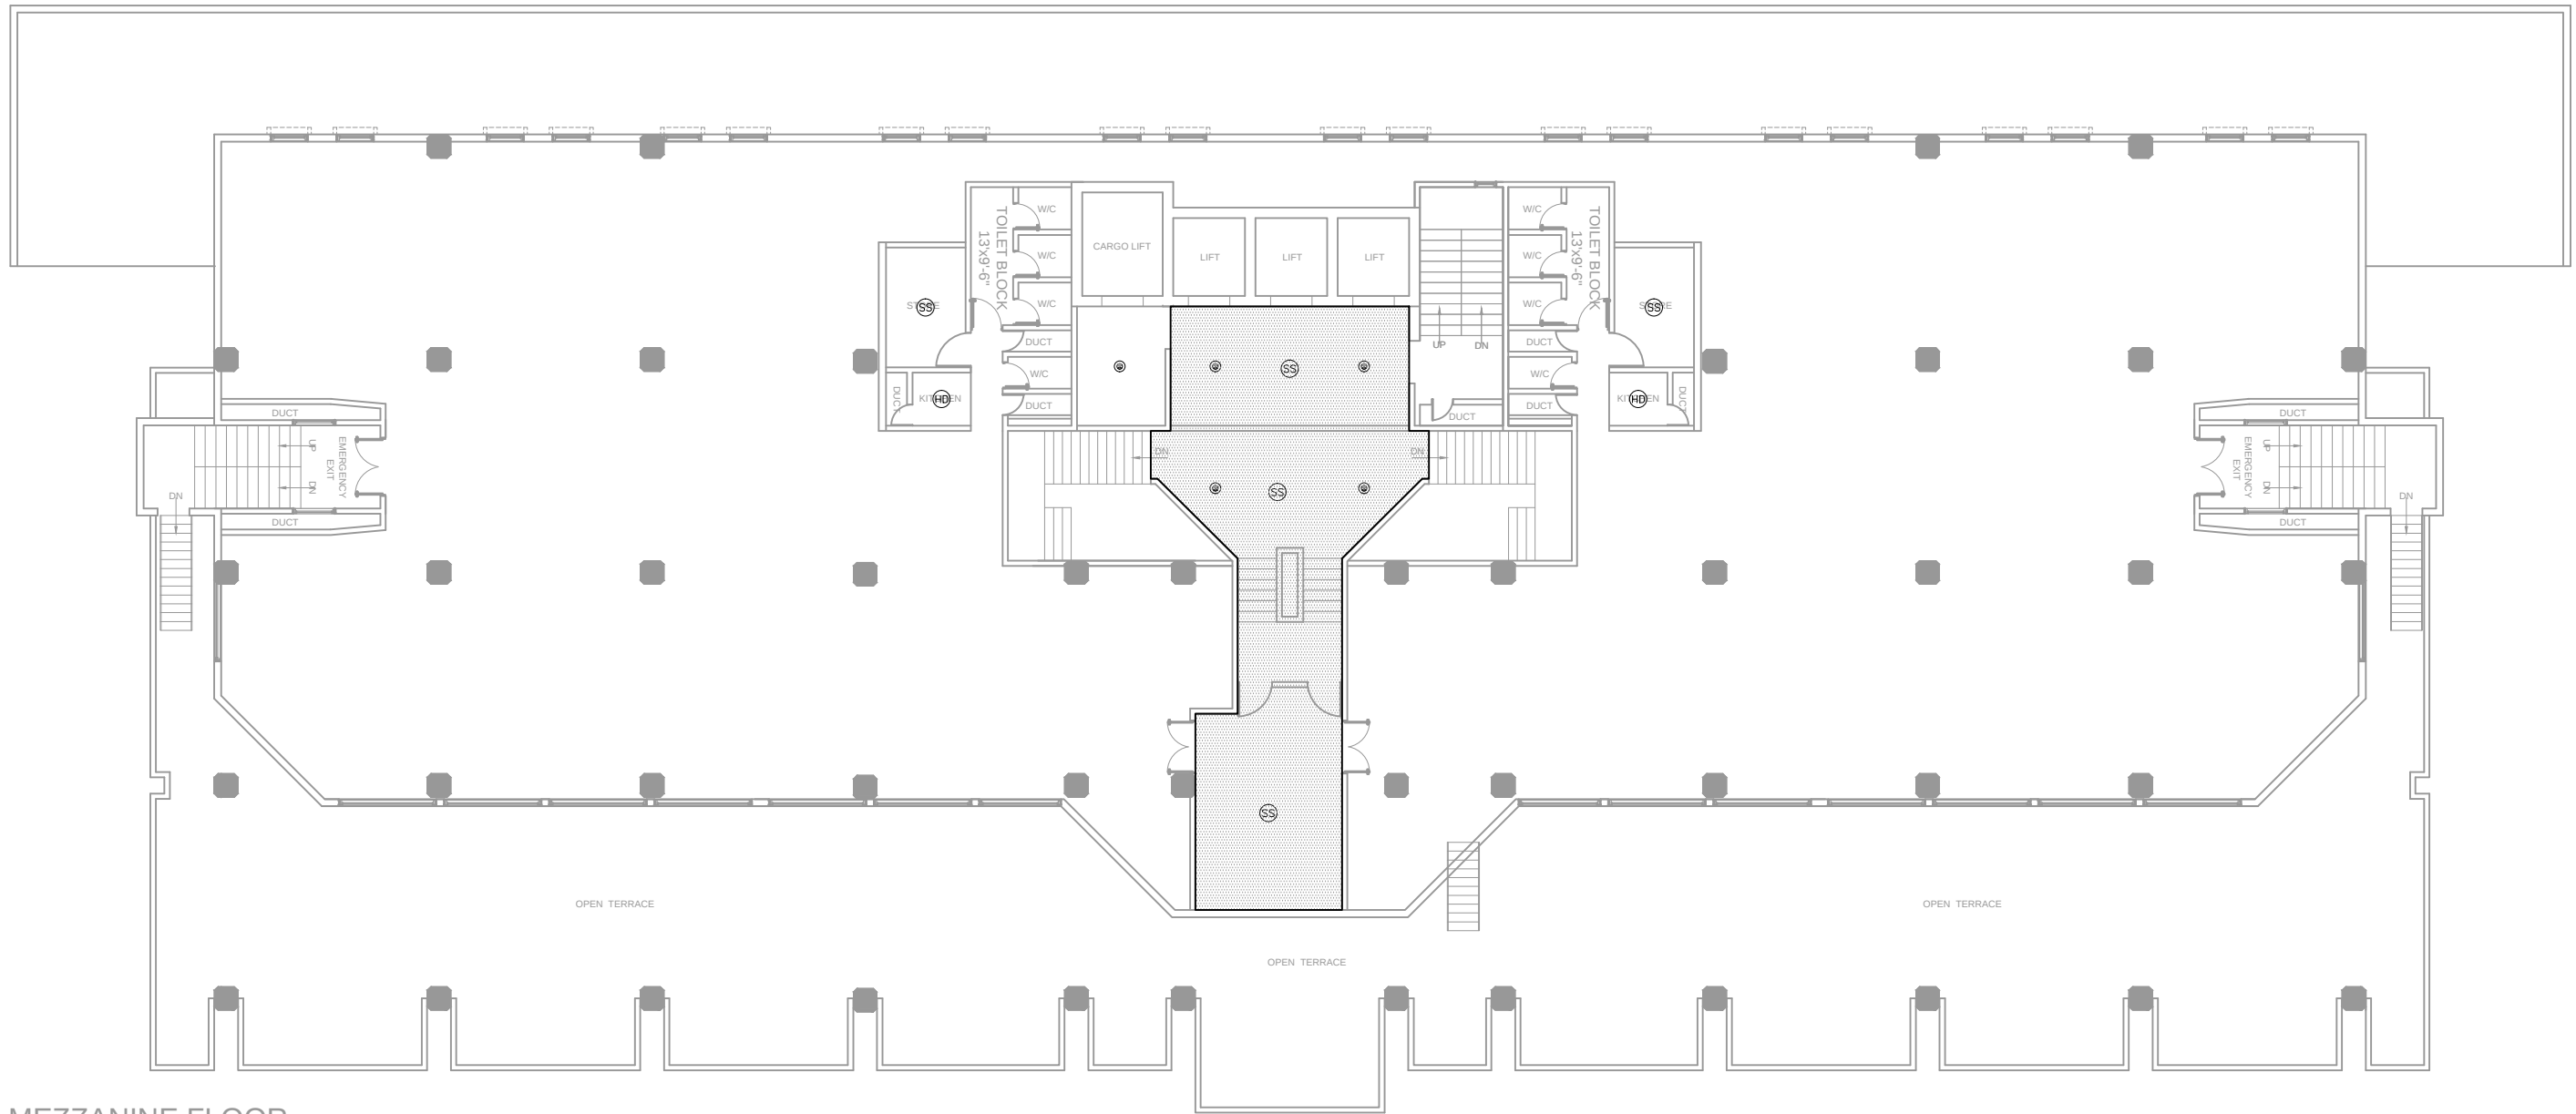

MEZZANINE FLOOR

LEGENDS		
SS	SMOKE DETECTOR	CEILING
HD	HEAT DETECTOR	CEILING
@	PENDENT CONCEALED SPRINKLER	CEILING
⊗	UPRIGHT SPRINKLER	
	REELECTED CEILING AREA	

CLIENT:-



STATE LIFE
INSURANCE CORPORATION OF PAKISTAN

CONSULTANT:



Nexus
Consulting
Office A-202, Second Floor, Blossom Trade Center Opposite NED University
University Road, SB-26, Block No.01 Gulistan-e-Jouhar, Karachi Pakistan
Phone: 021-37240670
Email: nexusconsultingcompany@gmail.com Web: www.Nexuscon.pk


PROJECT:-

STATE LIFE BUILDING NO.11

TITLE:-

BUILDING
CEILING PLAN

REV #	DATE	DESCRIPTION	CHKD	APPD	Project Ref:	DATE
						JULY, 2026
					DRAWN BY A-A	SCALE AS SHOWN
					CHECKED BY O-A	DWG. NO. BC-04

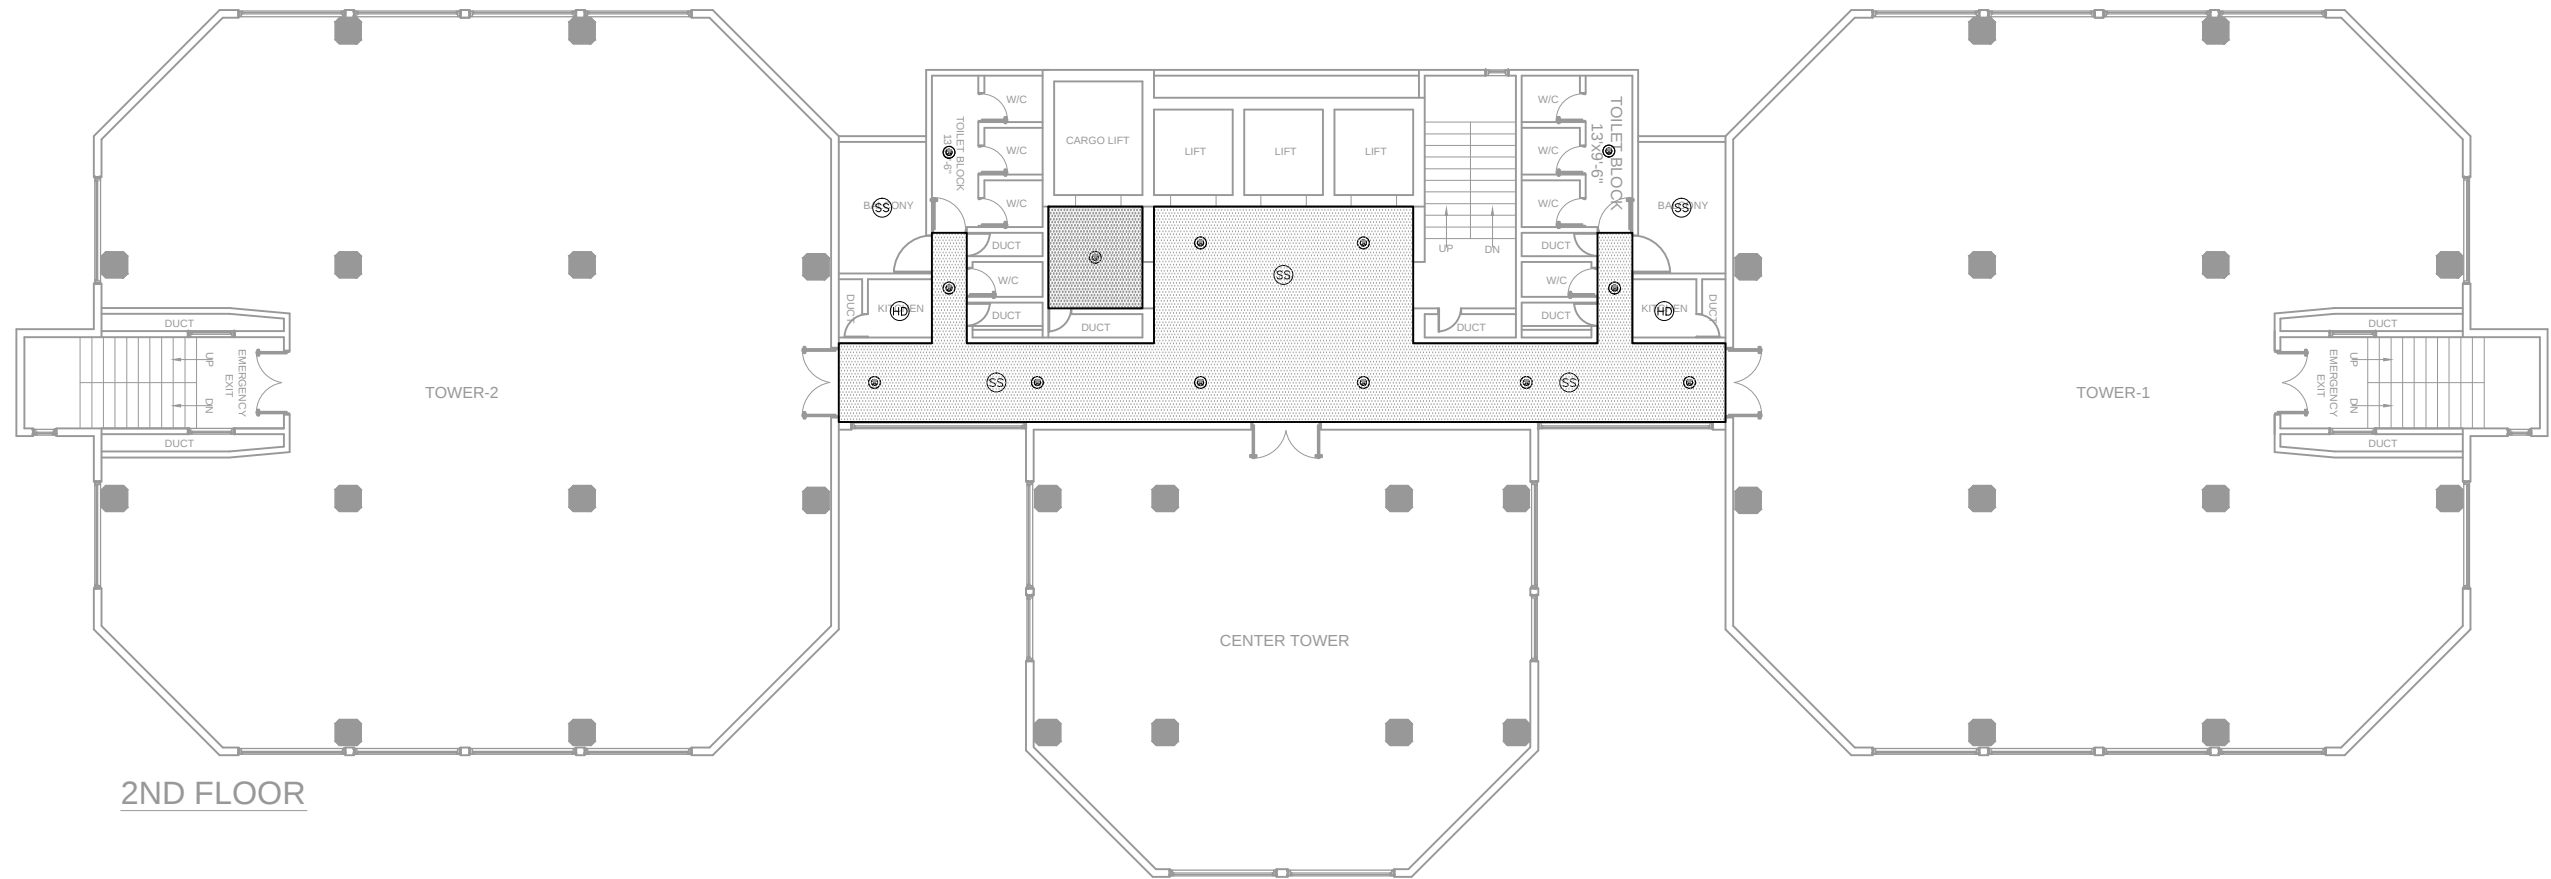

LEGENDS		
⊗	SMOKE DETECTOR	CEILING
⊕	HEAT DETECTOR	CEILING
⊙	PENDENT CONCEALED SPRINKLER	CEILING
⊛	UPRIGHT SPRINKLER	
	REELECTED CEILING AREA	

CLIENT:-



STATE LIFE
INSURANCE CORPORATION OF PAKISTAN

CONSULTANT:



Nexus
Consulting
Office A-202, Second Floor, Blossom Trade Center Opposite NED University
University Road, SB-26, Block No.01 Gulistan-e-Jouhar, Karachi Pakistan
Phone: 021-37240670
Email: nexusconsultingcompany@gmail.com Web: www.Nexuscon.pk


PROJECT:-

STATE LIFE BUILDING NO.11

TITLE:-

BUILDING
CEILING PLAN

REV #	DATE	DESCRIPTION	CHKD	APPD	Project Ref:	DATE
						JULY, 2026
					DRAWN BY	SCALE
					A-A	AS SHOWN
					CHECKED BY	DWG. NO.
					O-A	BC-05

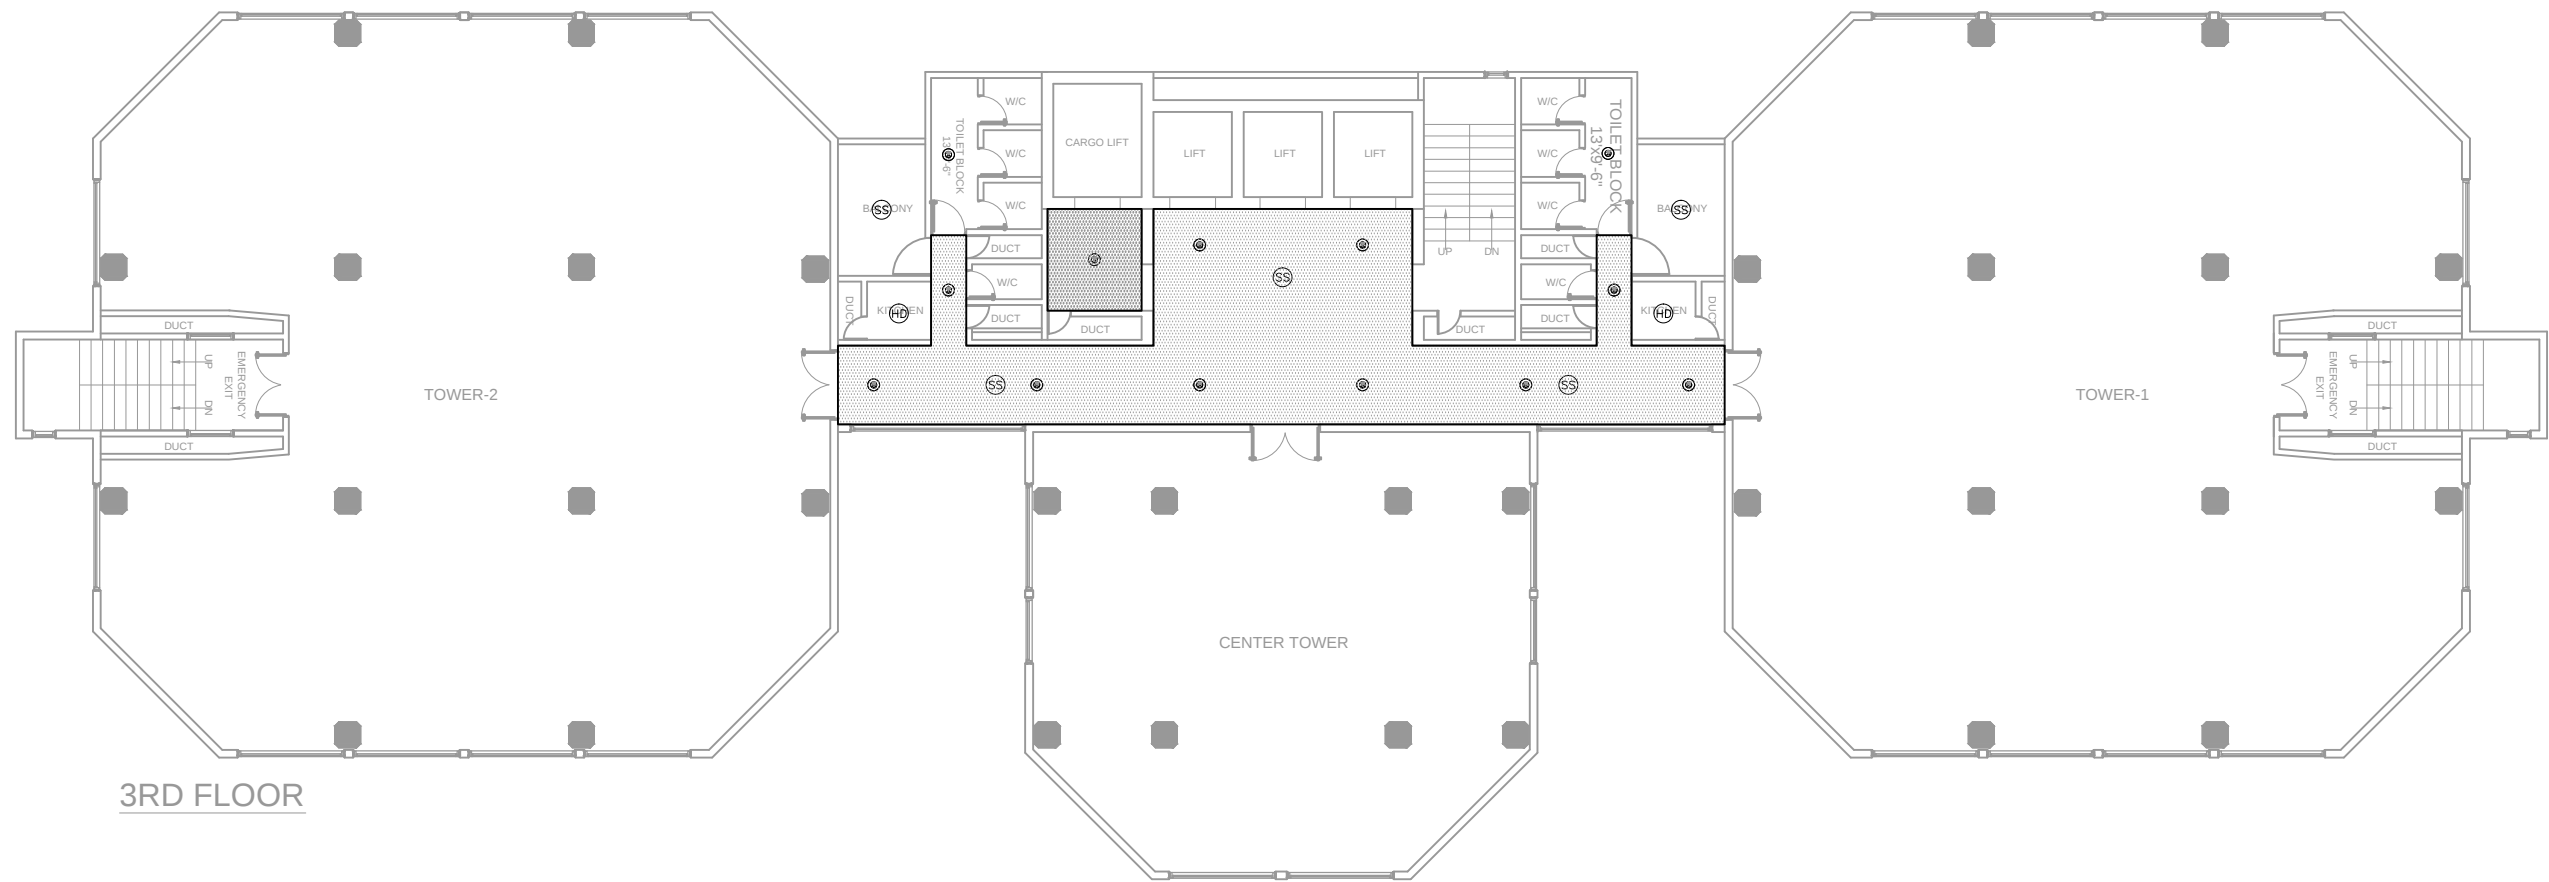

3RD FLOOR

LEGENDS		
SS	SMOKE DETECTOR	CEILING
HD	HEAT DETECTOR	CEILING
@	PENDENT CONCEALED SPRINKLER	CEILING
⊗	UPRIGHT SPRINKLER	
	REELECTED CEILING AREA	

CLIENT:-



STATE LIFE
INSURANCE CORPORATION OF PAKISTAN

CONSULTANT:



Nexus
Consulting
Office A-202, Second Floor, Blossom Trade Center Opposite NED University
University Road, SB-26, Block No.01 Gulistan-e-Jouhar, Karachi Pakistan
Phone: 021-37240670
Email: nexusconsultingcompany@gmail.com Web: www.Nexuscon.pk


PROJECT:-

STATE LIFE BUILDING NO.11

TITLE:-

BUILDING
CEILING PLAN

REV #	DATE	DESCRIPTION	CHKD	APPD	Project Ref:	DATE
						JULY, 2026
					DRAWN BY A-A	SCALE AS SHOWN
					CHECKED BY O-A	DWG. NO. BC-06

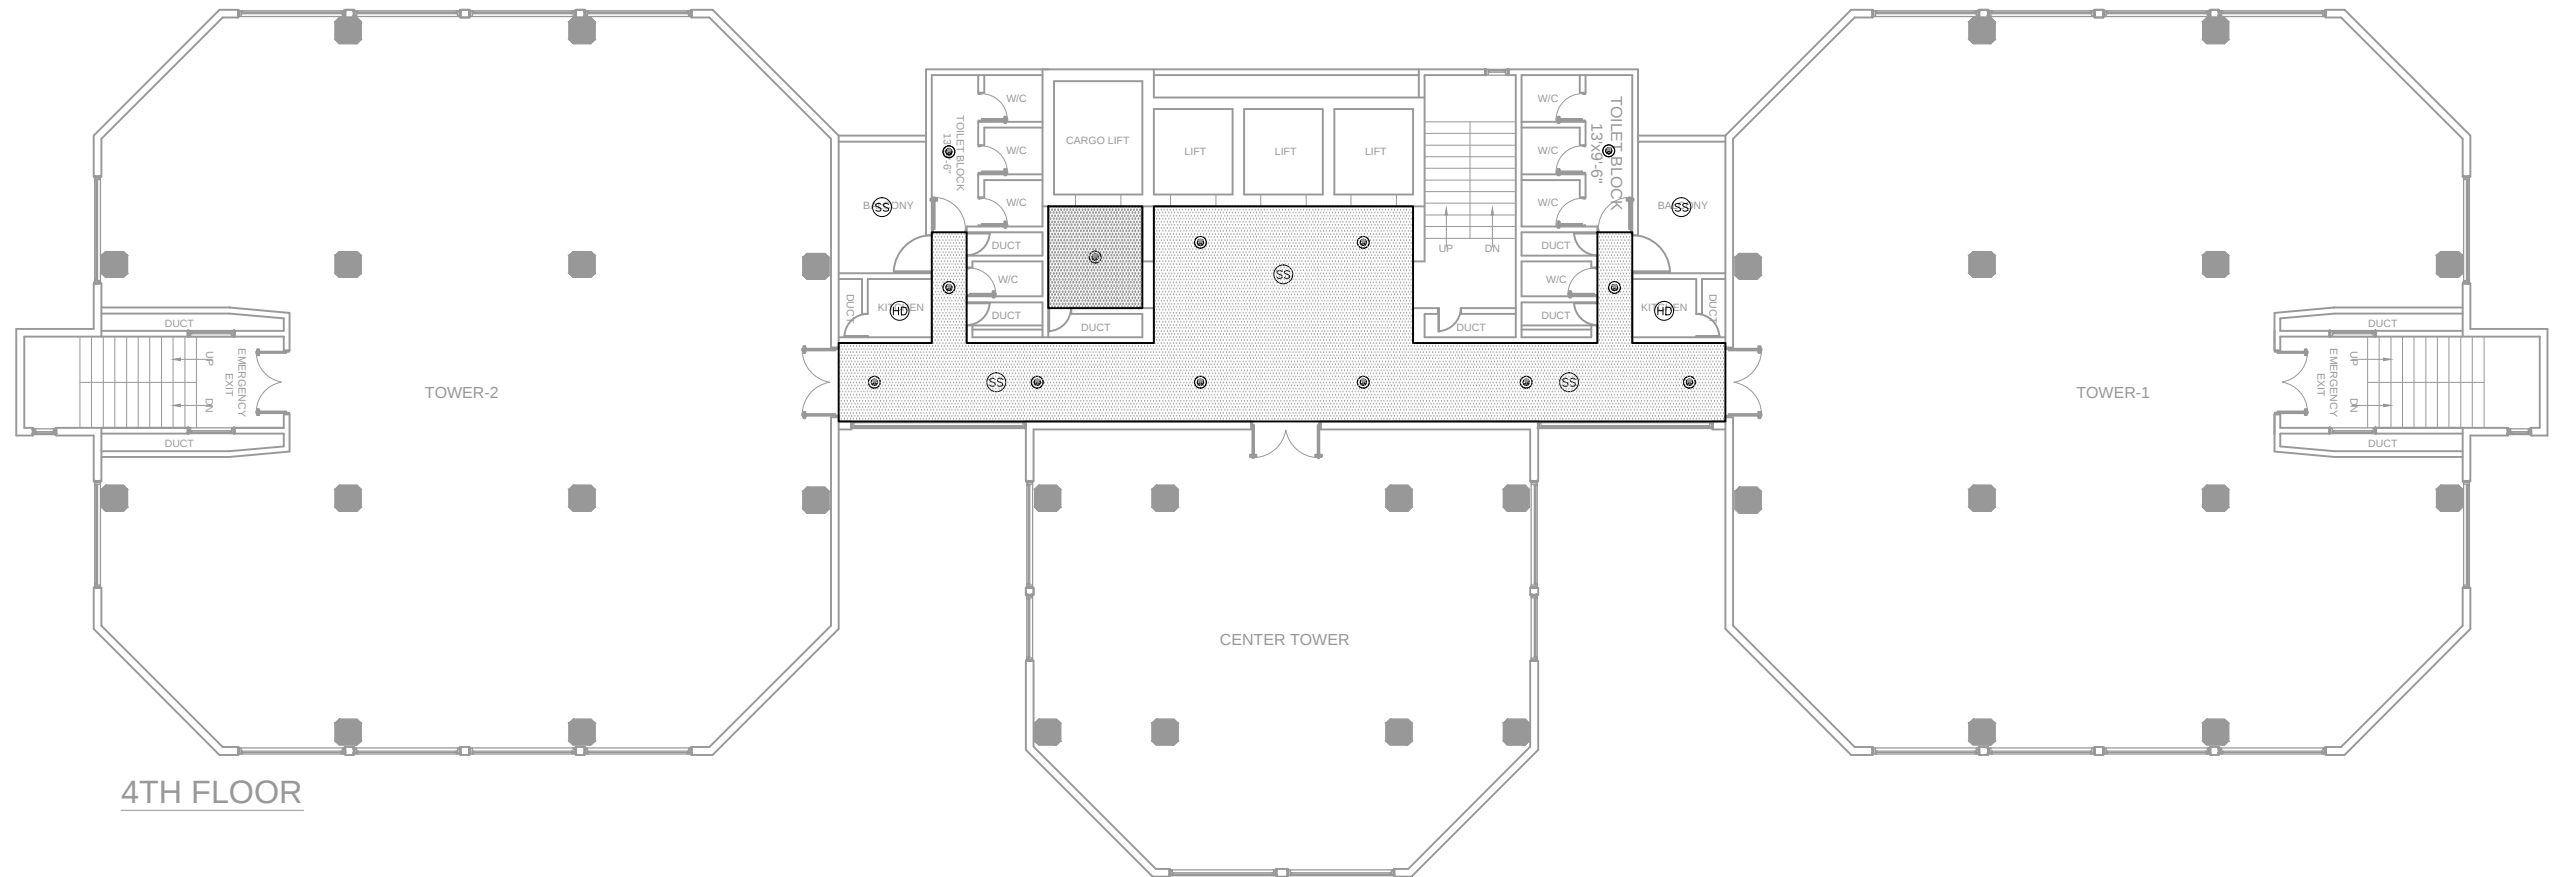

LEGENDS		
⊙	SMOKE DETECTOR	CEILING
⊕	HEAT DETECTOR	CEILING
⊗	PENDENT CONCEALED SPRINKLER	CEILING
⊗	UPRIGHT SPRINKLER	
	REELECTED CEILING AREA	

CLIENT:-



STATE LIFE
INSURANCE CORPORATION OF PAKISTAN

CONSULTANT:



Nexus
Consulting
Office A-202, Second Floor, Blossom Trade Center Opposite NED University
University Road, SB-26, Block No.01 Gulistan-e-Jouhar, Karachi Pakistan
Phone: 021-37240670
Email: nexusconsultingcompany@gmail.com Web: www.Nexuscon.pk


PROJECT:-

STATE LIFE BUILDING NO.11

TITLE:-

BUILDING
CEILING PLAN


REV #	DATE	DESCRIPTION	CHKD	APPD	Project Ref:	DATE
						JULY, 2026
					DRAWN BY A-A	SCALE AS SHOWN
					CHECKED BY O-A	DWG. NO. BC-07

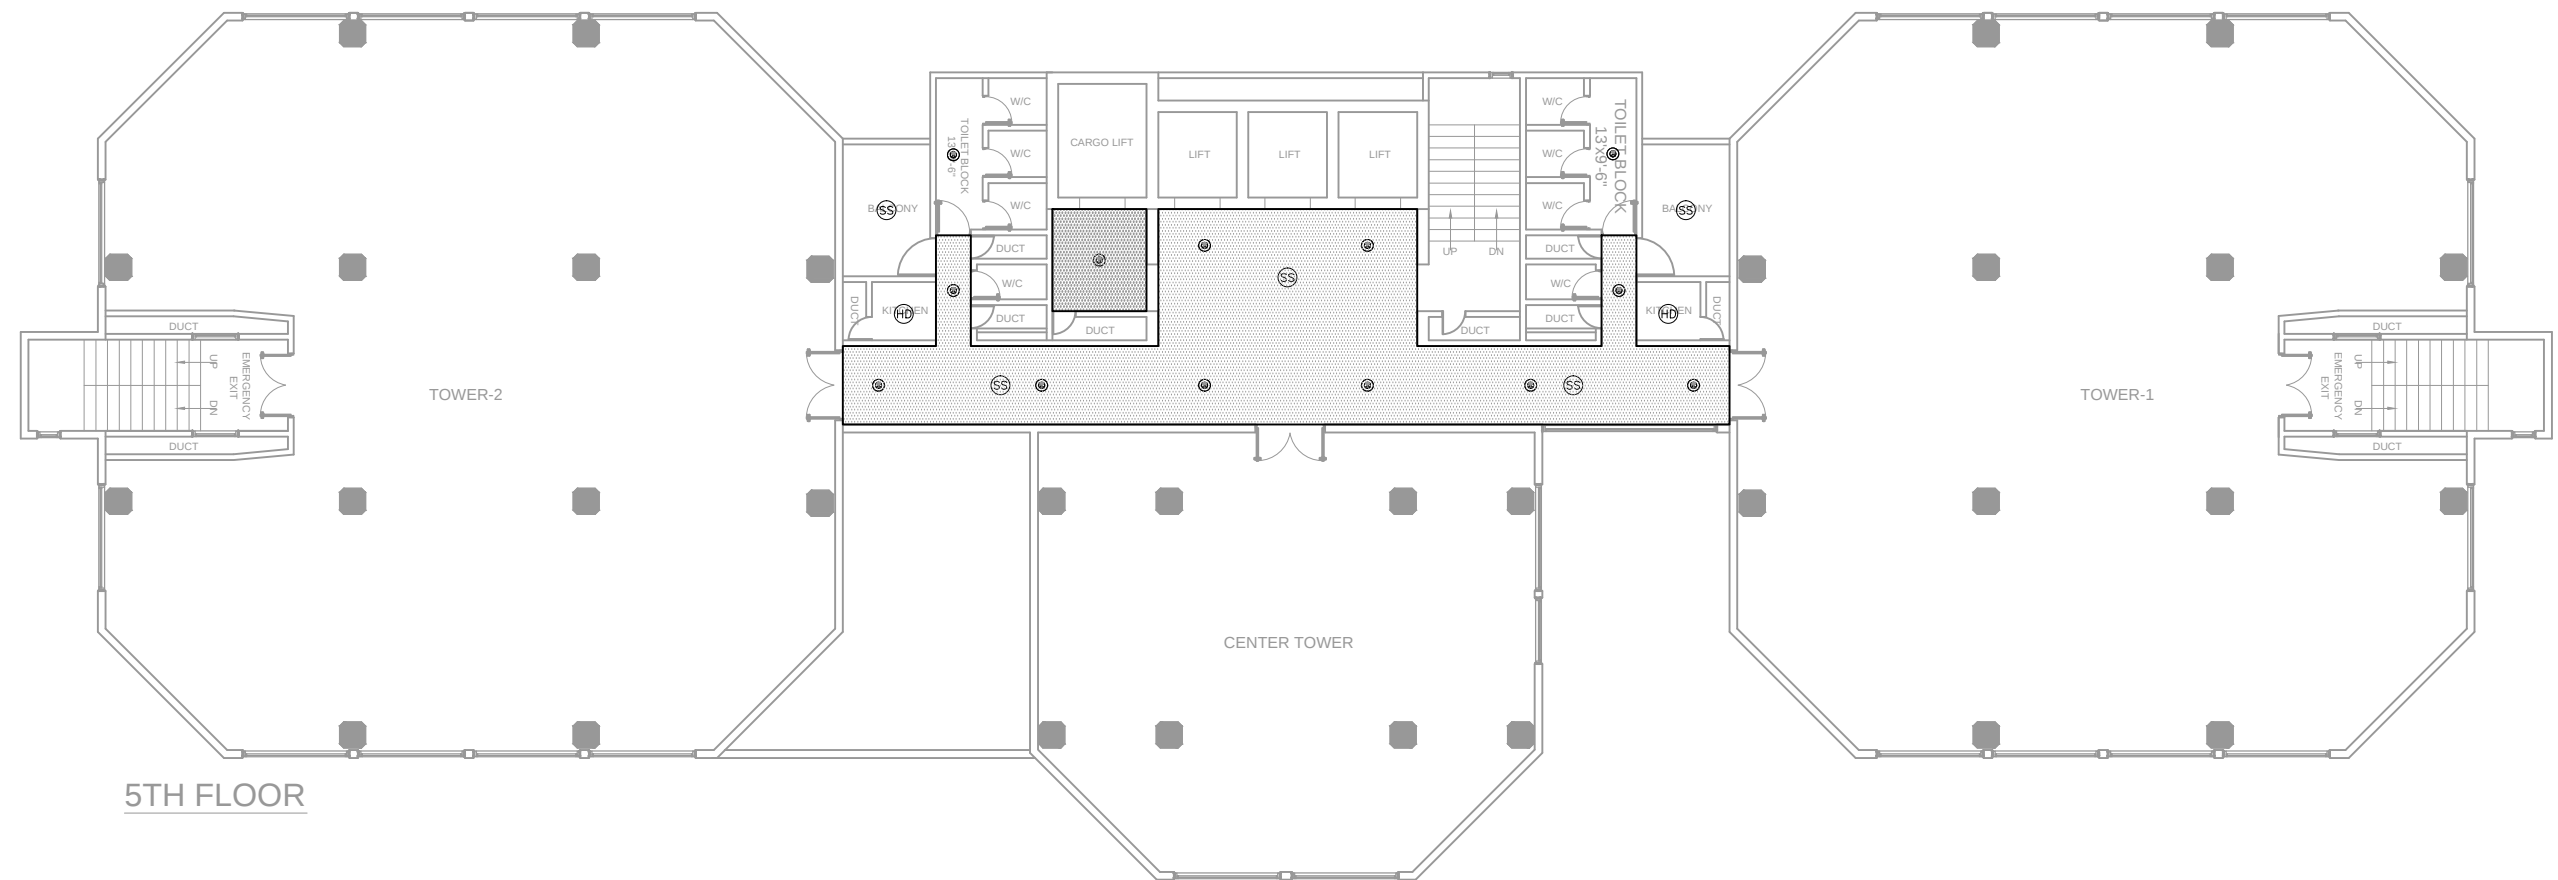

5TH FLOOR

LEGENDS		
⊗	SMOKE DETECTOR	CEILING
HD	HEAT DETECTOR	CEILING
@	PENDENT CONCEALED SPRINKLER	CEILING
⊗	UPRIGHT SPRINKLER	
[Shaded Box]	REFLECTED CEILING AREA	

CLIENT:- 	CONSULTANT:- Nexus Consulting Office A-202, Second Floor, Blossom Trade Center Opposite NED University University Road, SB-26, Block No.01 Gulistan-e-Jouhar, Karachi Pakistan Phone: 021-37240670 Email: nexusconsultingcompany@gmail.com Web: www.Nexuscon.pk	PROJECT:- STATE LIFE BUILDING NO.11	TITLE:- BUILDING CEILING PLAN	REV #	DATE	DESCRIPTION	CHKD	APPD	Project Ref:	DATE
									.	JULY, 2026
									DRAWN BY	SCALE
									A-A	AS SHOWN
									CHECKED BY	DWG. NO.
									O-A	BC-08

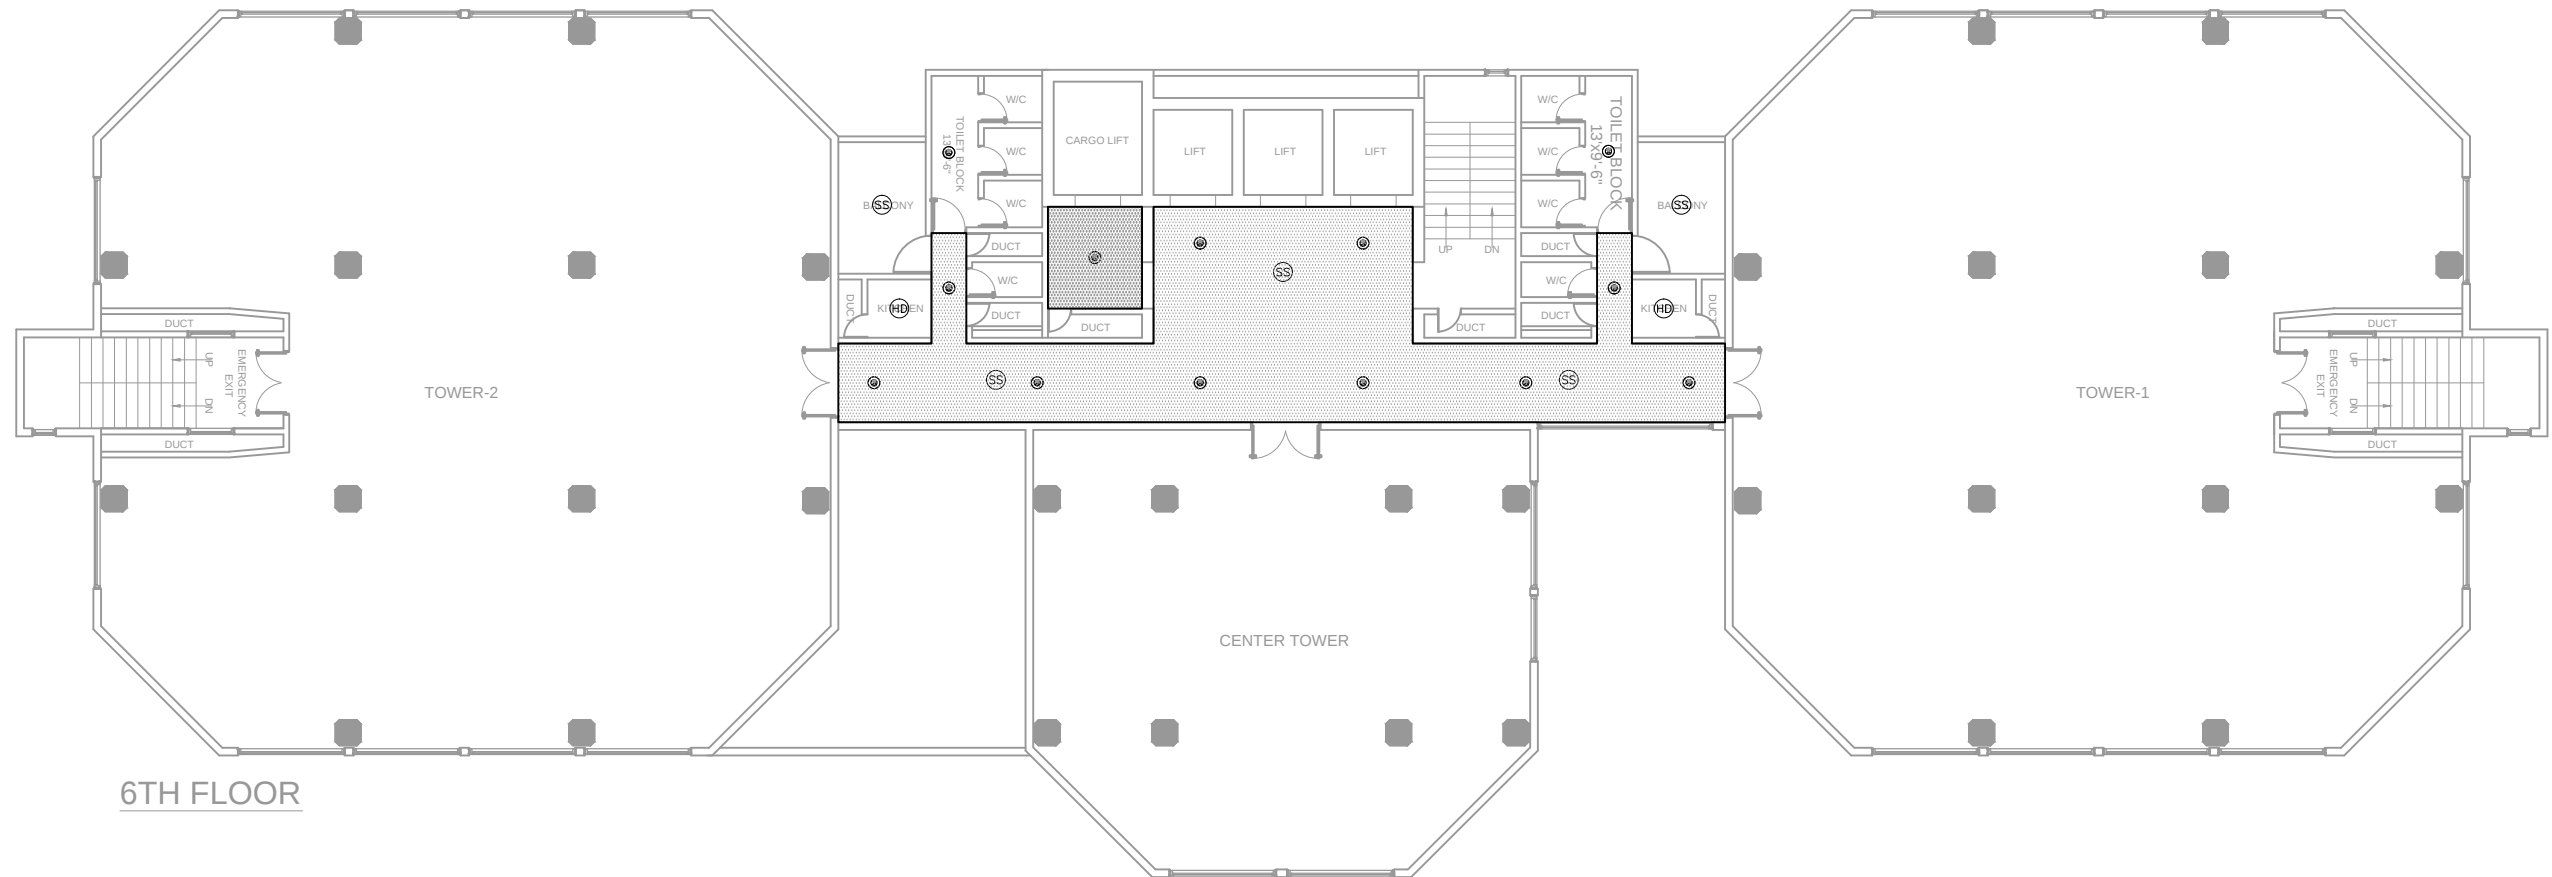

LEGENDS		
SS	SMOKE DETECTOR	CEILING
HD	HEAT DETECTOR	CEILING
@	PENDENT CONCEALED SPRINKLER	CEILING
⊗	UPRIGHT SPRINKLER	
	REELECTED CEILING AREA	

CLIENT:-



STATE LIFE
INSURANCE CORPORATION OF PAKISTAN

CONSULTANT:



Nexus
Consulting
Office A-202, Second Floor, Blossom Trade Center Opposite NED University
University Road, SB-26, Block No.01 Gulistan-e-Johar, Karachi Pakistan
Phone: 021-37240670
Email: nexusconsultingcompany@gmail.com Web: www.Nexuscon.pk


PROJECT:-

STATE LIFE BUILDING NO.11

TITLE:-


BUILDING
CEILING PLAN

REV #	DATE	DESCRIPTION	CHKD	APPD	Project Ref:	DATE
						JULY, 2026
					DRAWN BY A-A	SCALE AS SHOWN
					CHECKED BY O-A	DWG. NO. BC-09

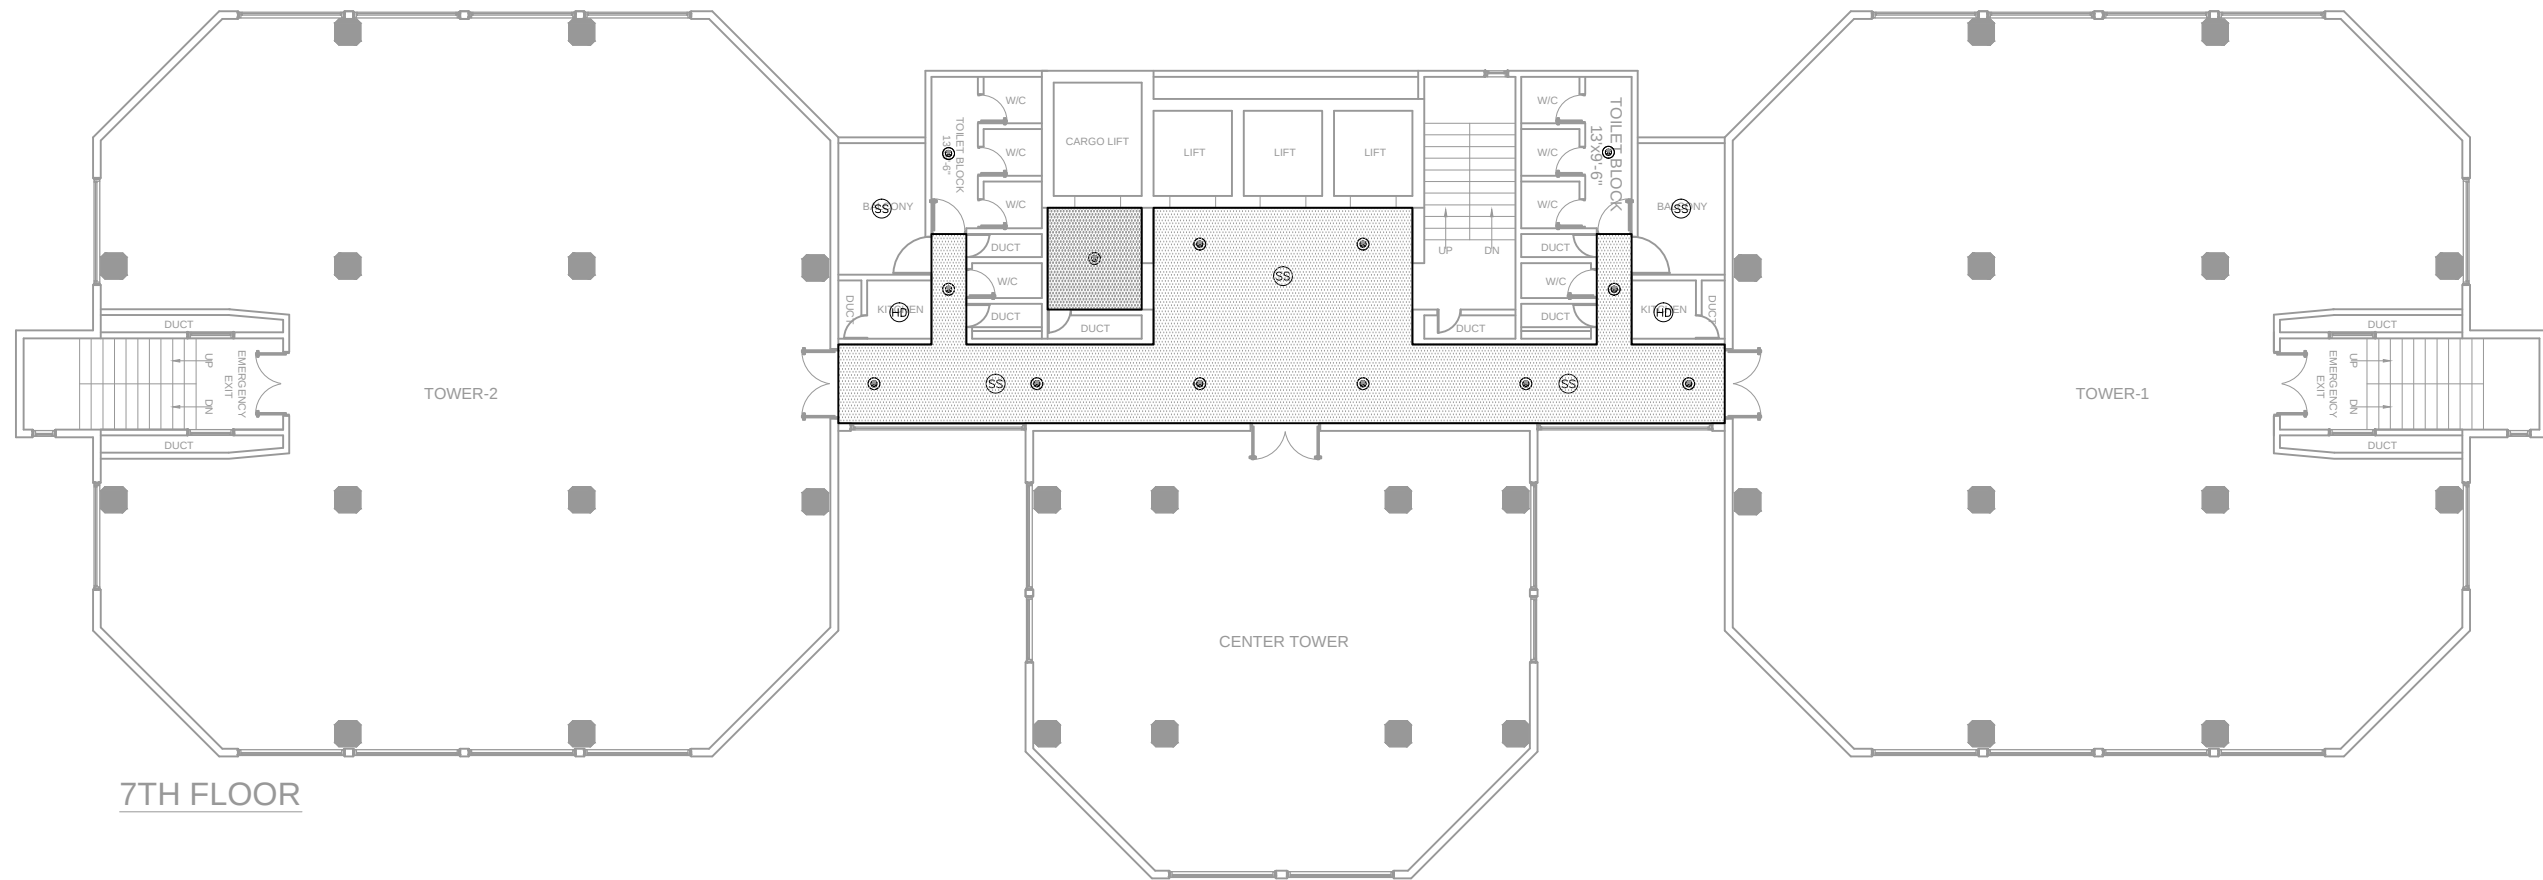

LEGENDS		
SS	SMOKE DETECTOR	CEILING
HD	HEAT DETECTOR	CEILING
@	PENDENT CONCEALED SPRINKLER	CEILING
⊗	UPRIGHT SPRINKLER	
	REELECTED CEILING AREA	


CLIENT:- STATE LIFE INSURANCE CORPORATION OF PAKISTAN	CONSULTANT: Nexus Consulting Office A-202, Second Floor, Blossom Trade Center Opposite NED University University Road, SB-26, Block No.01 Gulistan-e-Jouhar, Karachi Pakistan Phone: 021-37240670 Email: nexusconsultingcompany@gmail.com Web: www.Nexuscon.pk	PROJECT:- STATE LIFE BUILDING NO.11	TITLE:- BUILDING CEILING PLAN	REV #	DATE	DESCRIPTION	CHKD	APPD	Project Ref:	DATE	
											JULY, 2026
										DRAWN BY A-A	SCALE AS SHOWN
										CHECKED BY O-A	DWG. NO. BC-10

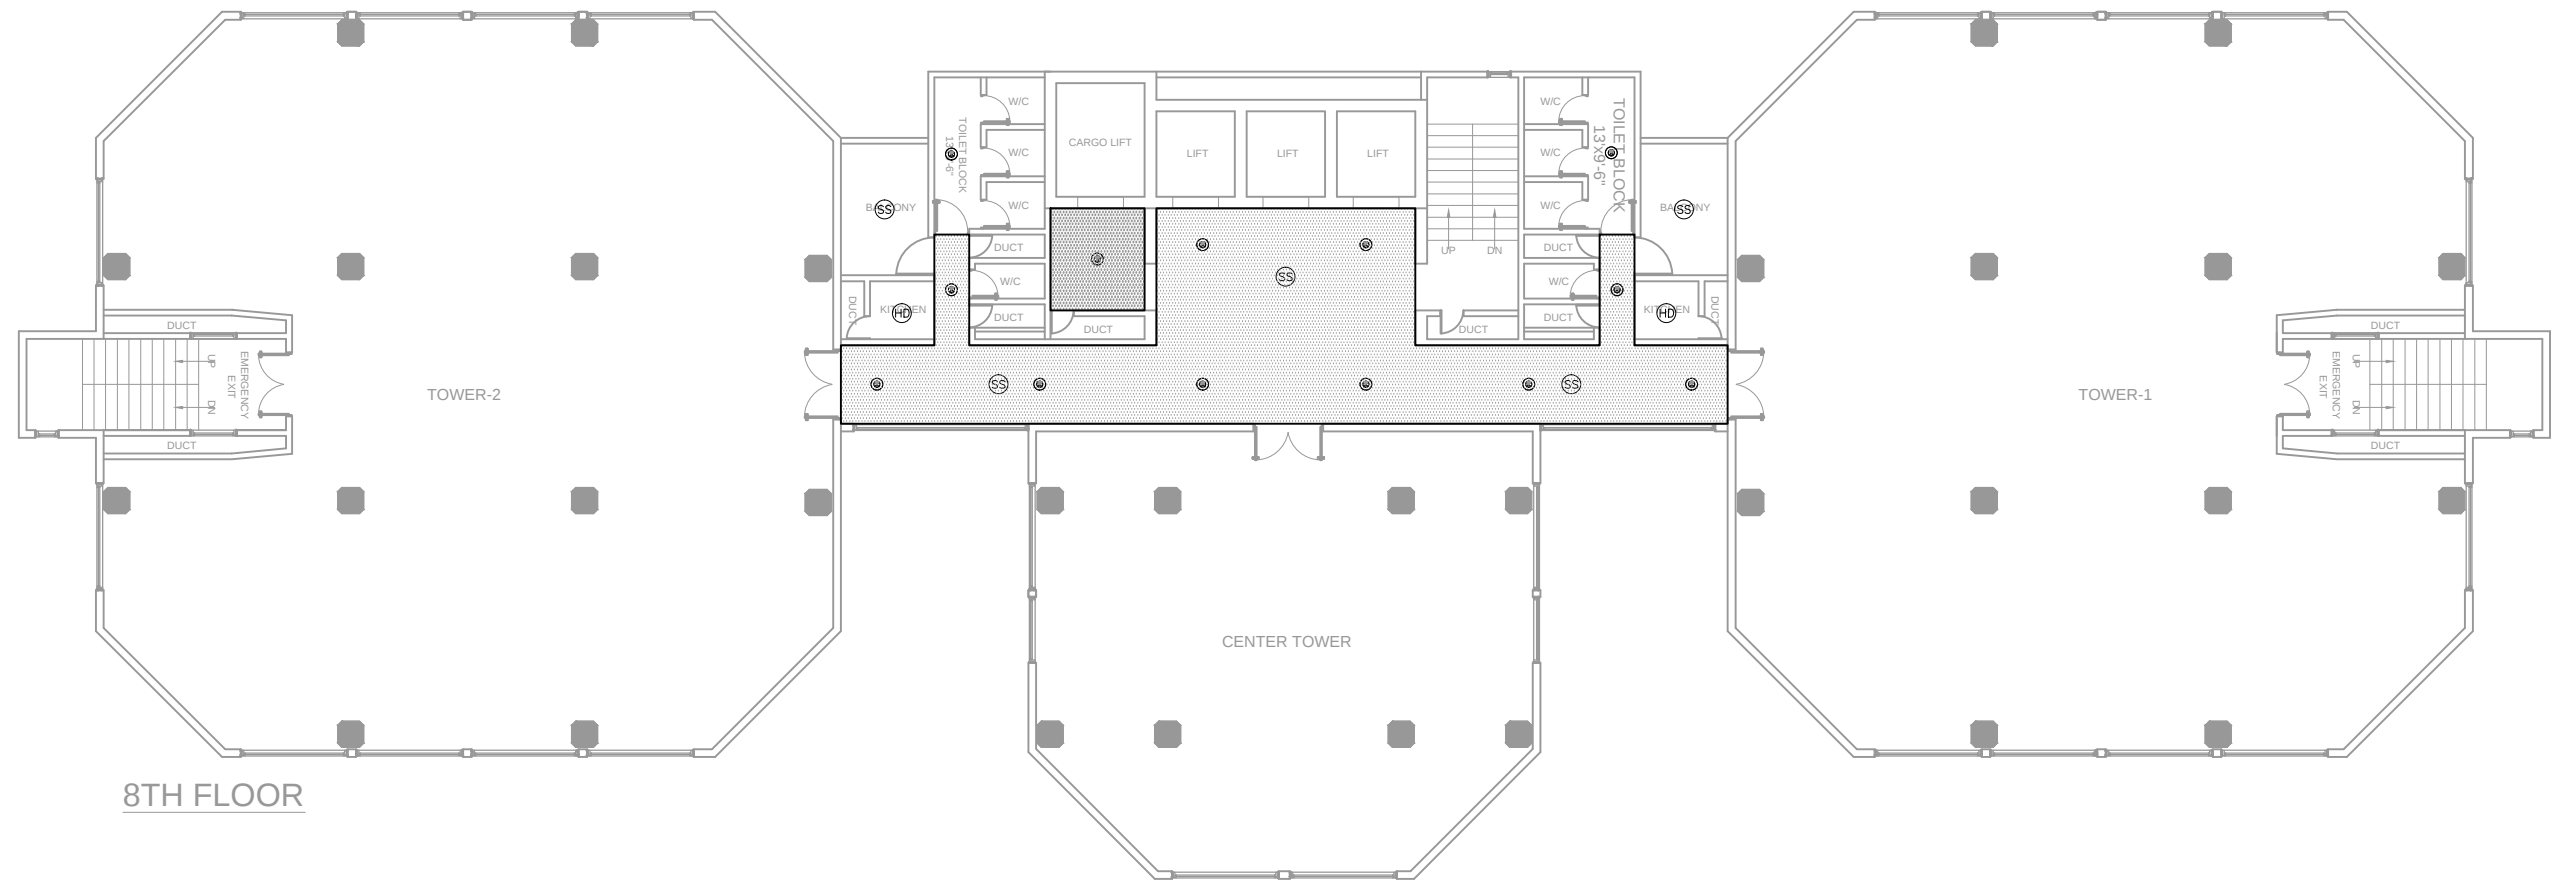

8TH FLOOR

LEGENDS		
SS	SMOKE DETECTOR	CEILING
HD	HEAT DETECTOR	CEILING
@	PENDENT CONCEALED SPRINKLER	CEILING
⊗	UPRIGHT SPRINKLER	
	REELECTED CEILING AREA	

CLIENT:-  STATE LIFE INSURANCE CORPORATION OF PAKISTAN	CONSULTANT:  Nexus Consulting Office A-202, Second Floor, Blossom Trade Center Opposite NED University University Road, SB-26, Block No.01 Gullistan-e-Jouhar, Karachi Pakistan Phone: 021-37240670 Email: nexusconsultingcompany@gmail.com Web: www.Nexuscon.pk	PROJECT:- STATE LIFE BUILDING NO.11	TITLE:- BUILDING CEILING PLAN	REV #	DATE	DESCRIPTION	CHKD	APPD	Project Ref:	DATE
										JULY, 2026
									DRAWN BY	SCALE
									A-A	AS SHOWN
									CHECKED BY	DWG. NO.
									O-A	BC-11

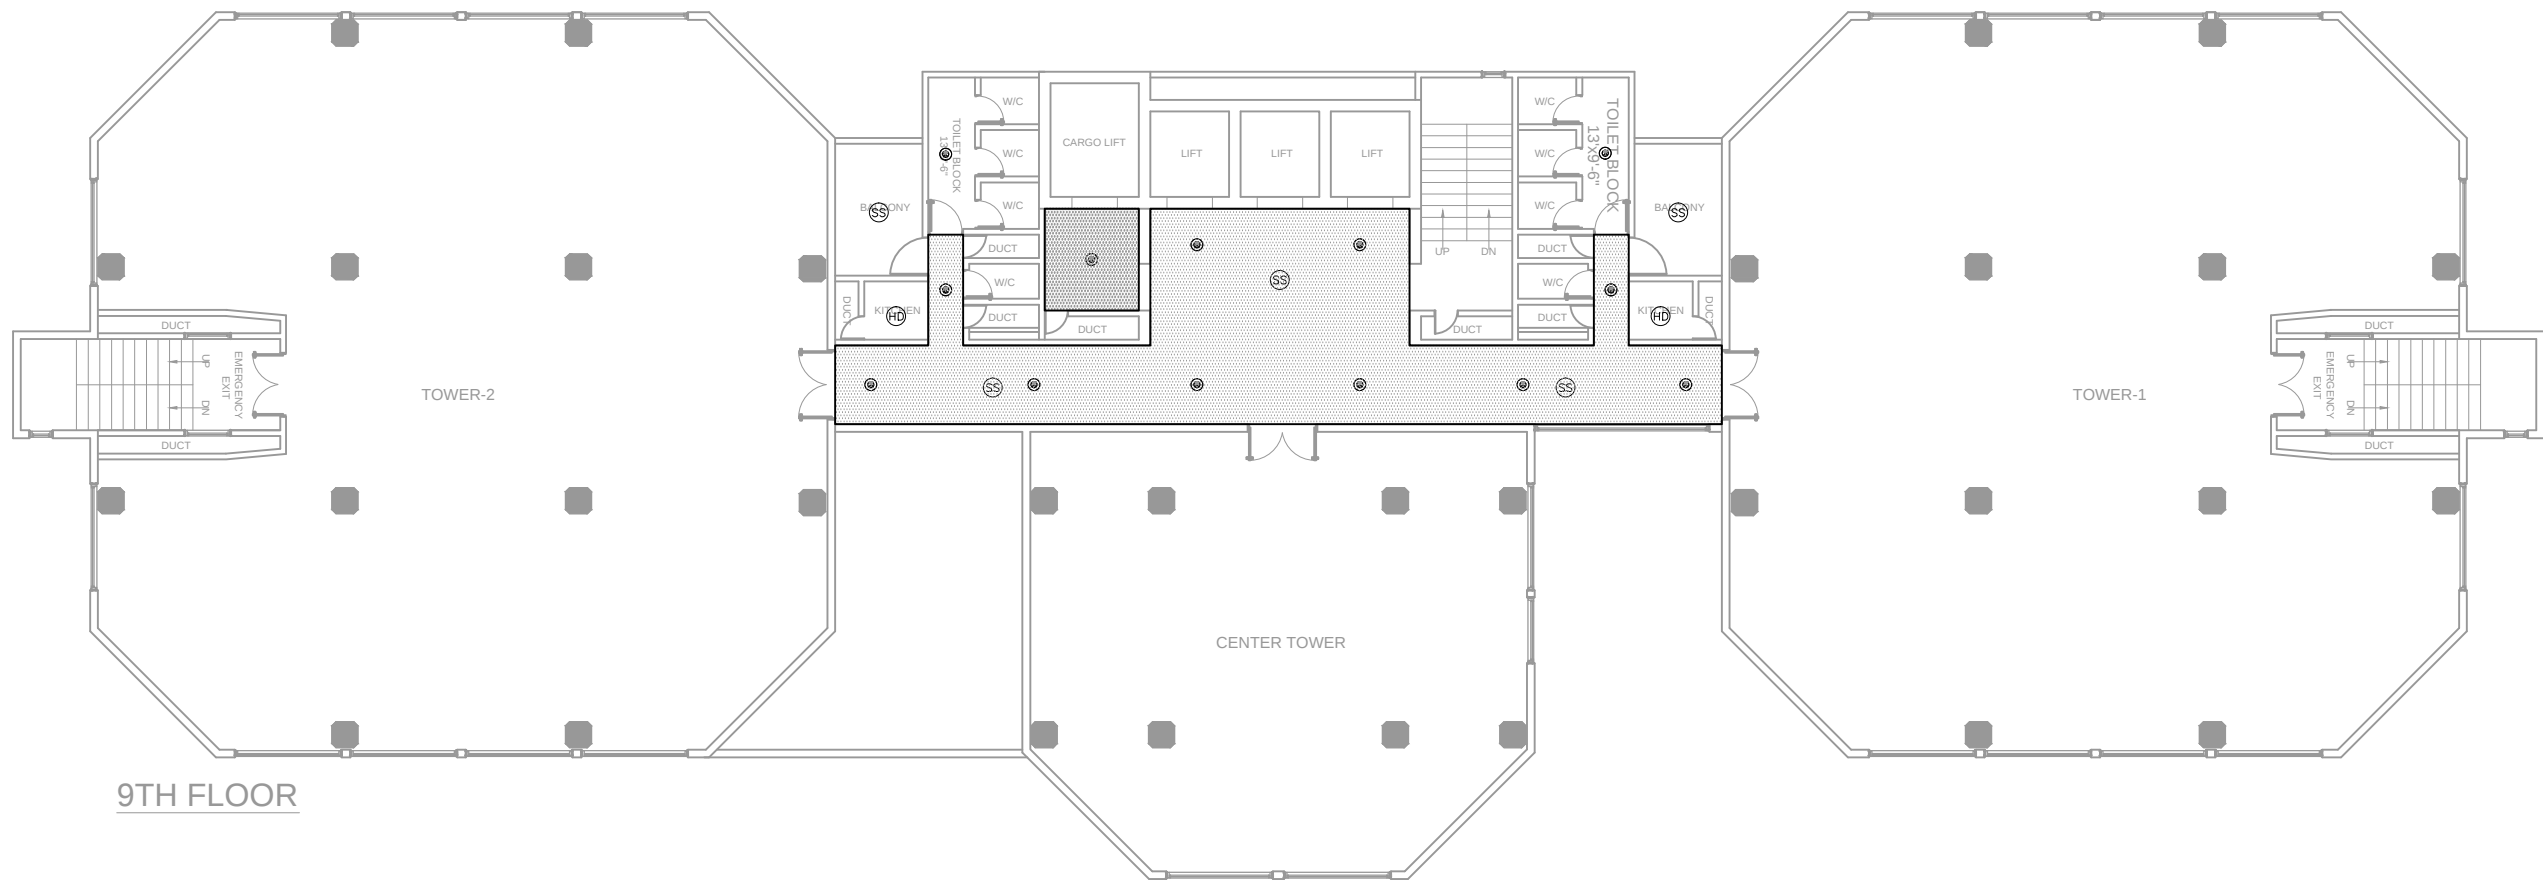

LEGENDS		
SS	SMOKE DETECTOR	CEILING
HD	HEAT DETECTOR	CEILING
⦿	PENDENT CONCEALED SPRINKLER	CEILING
⊗	UPRIGHT SPRINKLER	
	REELECTED CEILING AREA	

CLIENT:-



STATE LIFE
INSURANCE CORPORATION OF PAKISTAN

CONSULTANT:



Nexus
Consulting
Office A-202, Second Floor, Blossom Trade Center Opposite NED University
University Road, SB-26, Block No.01 Gulistan-e-Johar, Karachi Pakistan
Phone: 021-37240670
Email: nexusconsultingcompany@gmail.com Web: www.Nexuscon.pk


PROJECT:-

STATE LIFE BUILDING NO.11

TITLE:-

BUILDING
CEILING PLAN

REV #	DATE	DESCRIPTION	CHKD	APPD	Project Ref:	DATE
					.	JULY, 2026
					DRAWN BY A-A	SCALE AS SHOWN
					CHECKED BY O-A	DWG. NO. BC-12

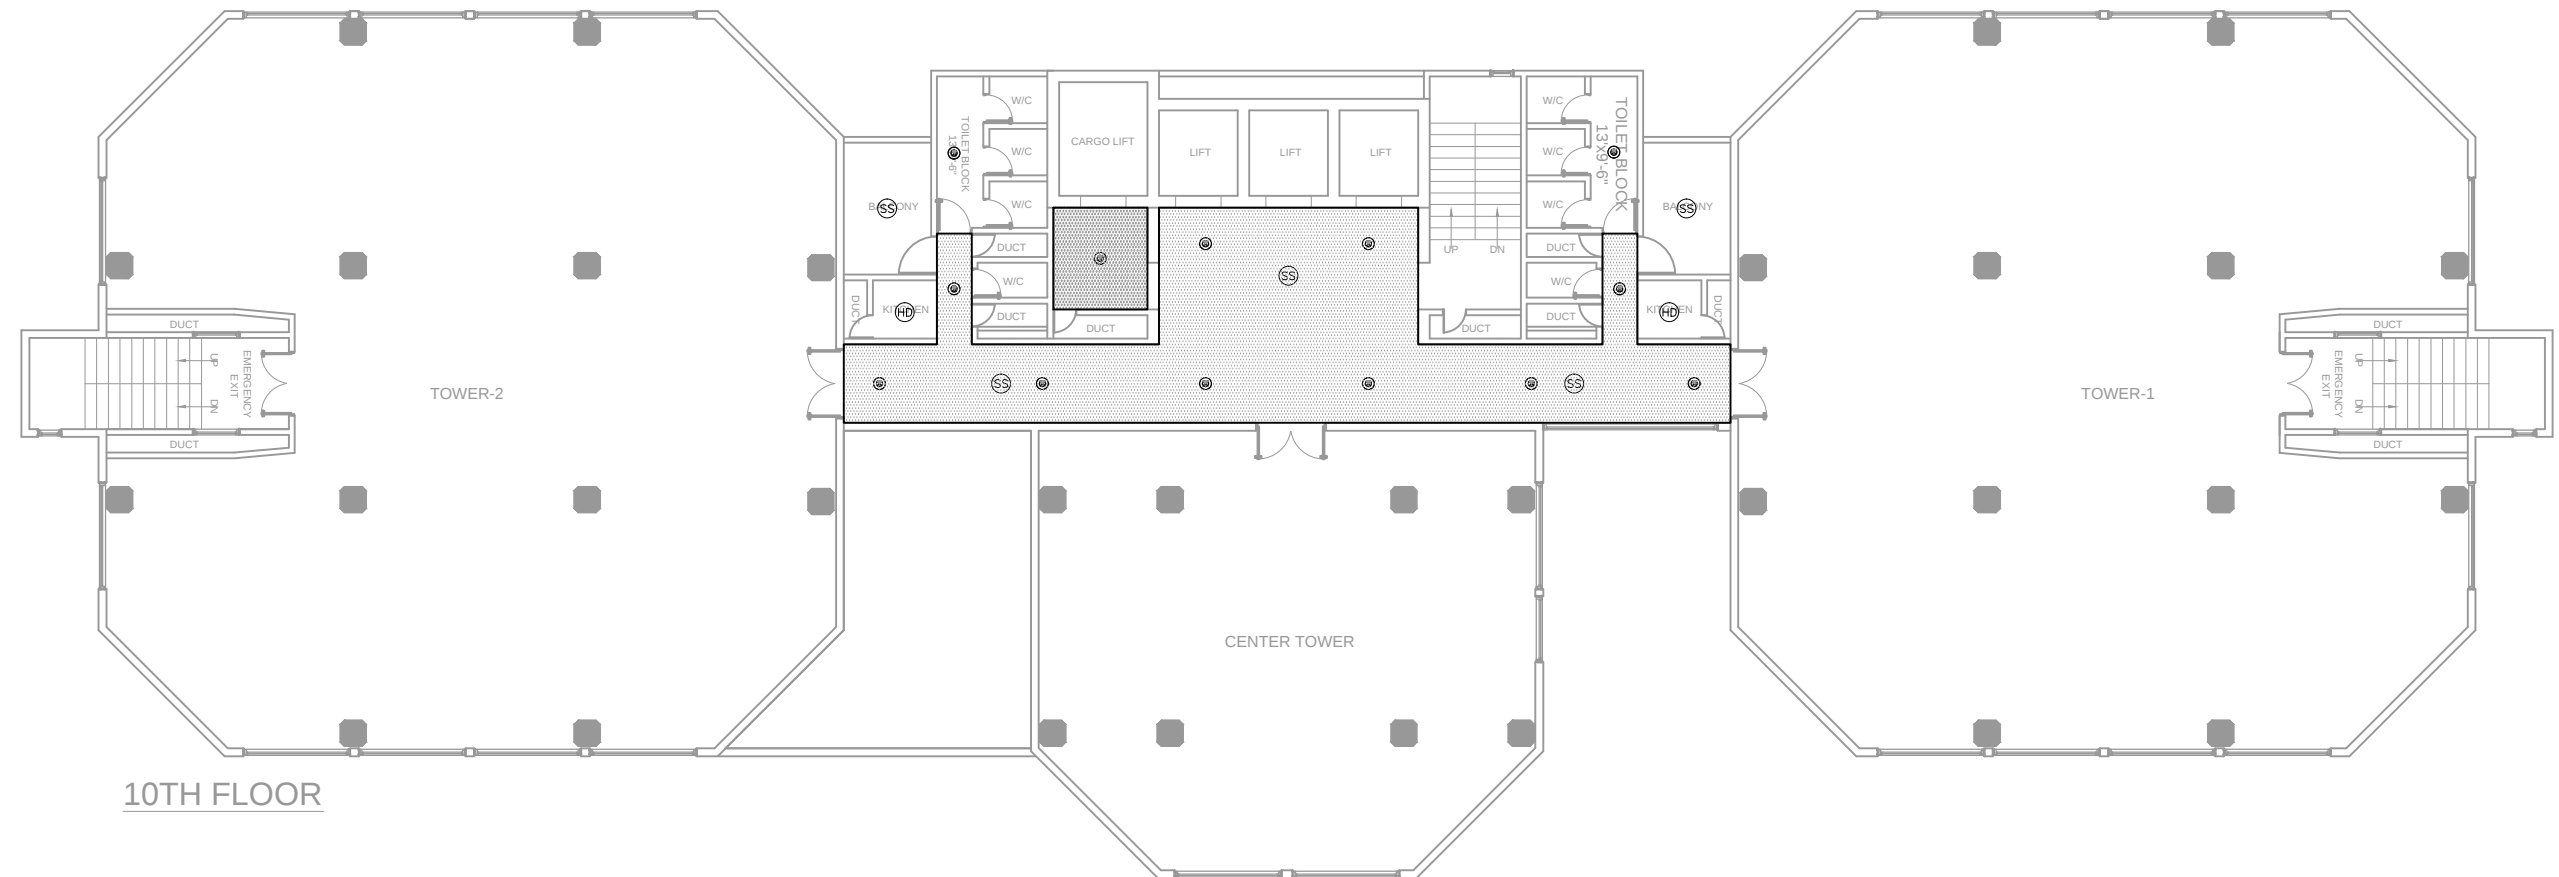

LEGENDS		
SS	SMOKE DETECTOR	CEILING
HD	HEAT DETECTOR	CEILING
⊙	PENDENT CONCEALED SPRINKLER	CEILING
⊗	UPRIGHT SPRINKLER	
	REELECTED CEILING AREA	

CLIENT:-



STATE LIFE
INSURANCE CORPORATION OF PAKISTAN

CONSULTANT:



Nexus
Consulting
Office A-202, Second Floor, Blossom Trade Center Opposite NED University
University Road, SB-26, Block No.01 Gullistan-e-Jouhar, Karachi Pakistan
Phone: 021-37240670
Email: nexusconsultingcompany@gmail.com Web: www.Nexuscon.pk


PROJECT:-

STATE LIFE BUILDING NO.11

TITLE:-

BUILDING
CEILING PLAN

REV #	DATE	DESCRIPTION	CHKD	APPD	Project Ref:	DATE
						JULY, 2026
					DRAWN BY A-A	SCALE AS SHOWN
					CHECKED BY O-A	DWG. NO. BC-13

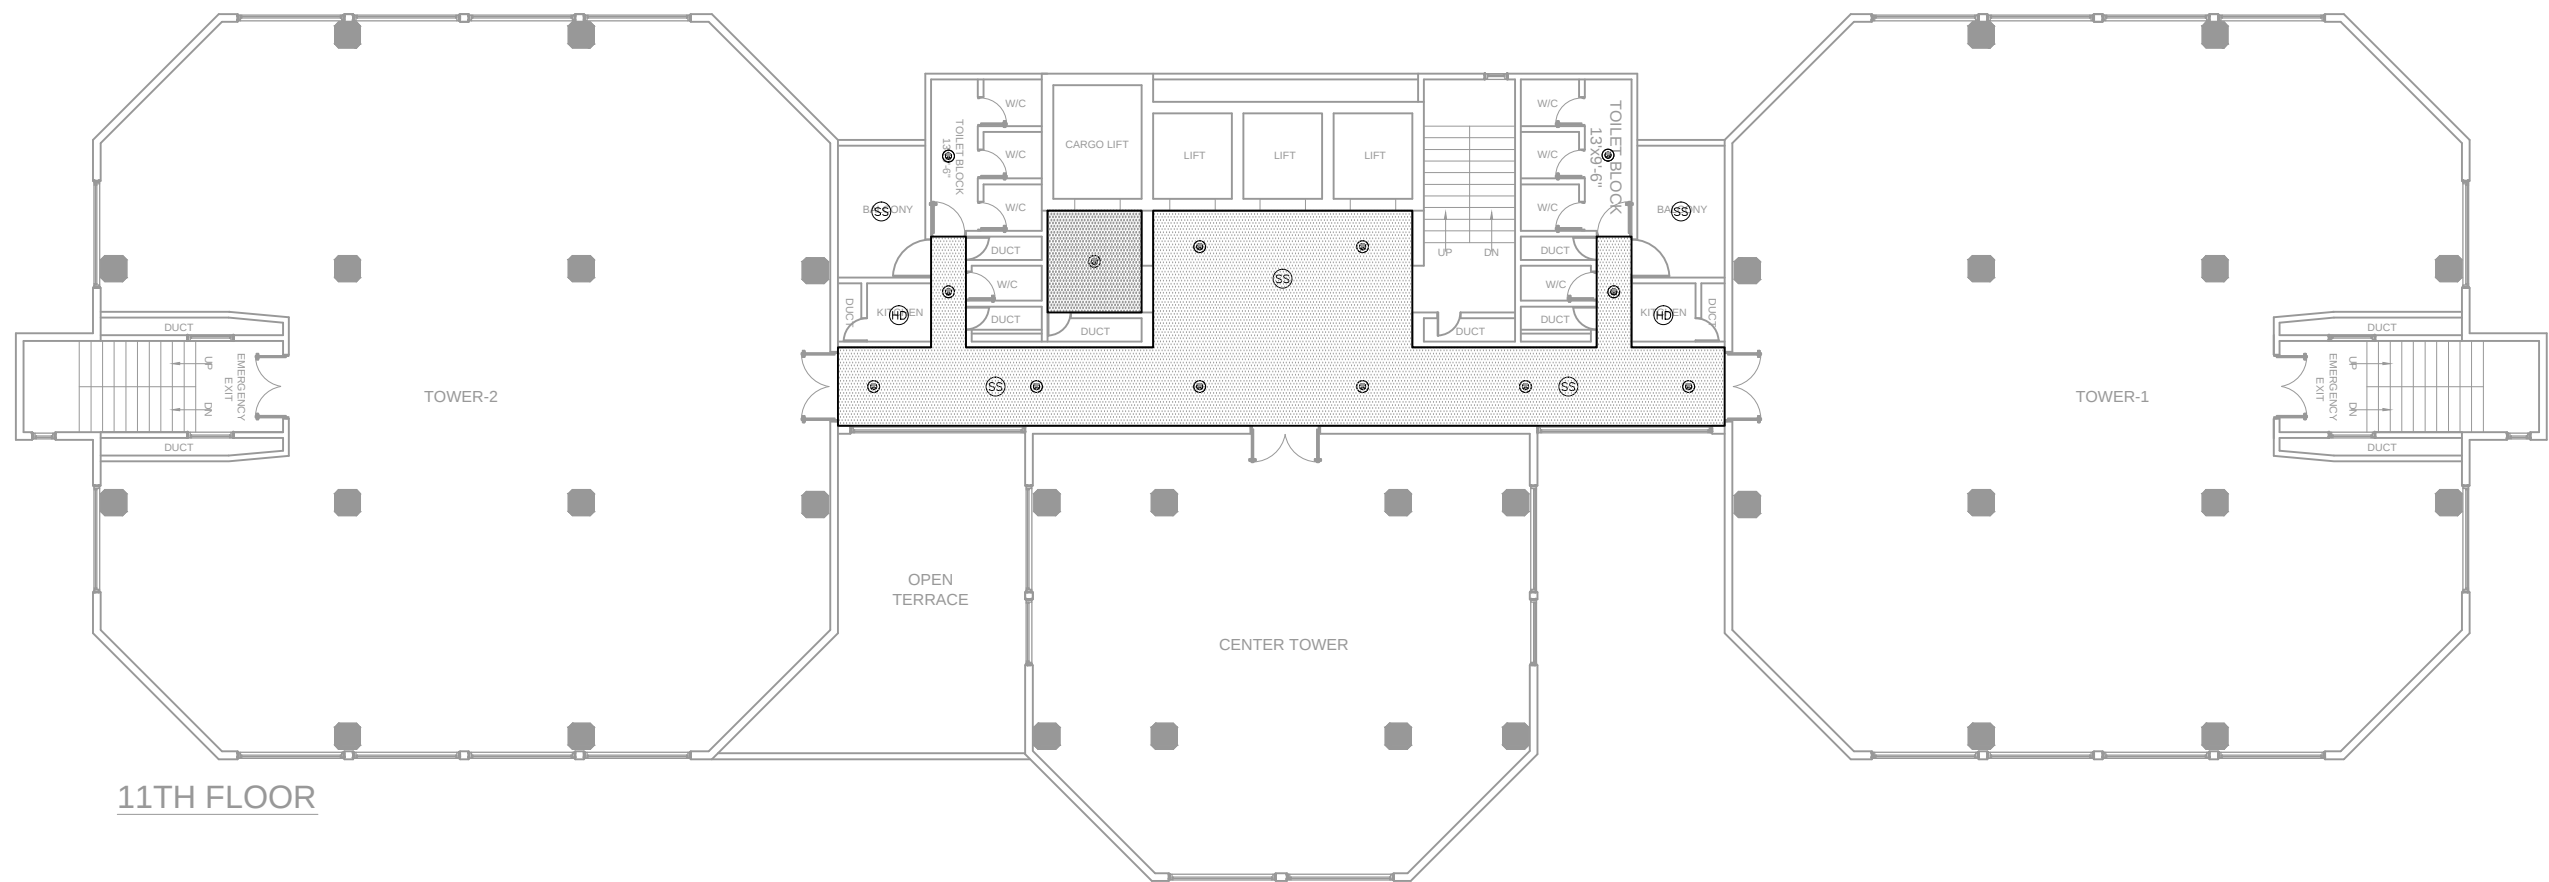

11TH FLOOR

LEGENDS		
SS	SMOKE DETECTOR	CEILING
HD	HEAT DETECTOR	CEILING
@	PENDENT CONCEALED SPRINKLER	CEILING
⊗	UPRIGHT SPRINKLER	
	REFLECTED CEILING AREA	

CLIENT:-



STATE LIFE
INSURANCE CORPORATION OF PAKISTAN

CONSULTANT:



Nexus
Consulting
Office A-202, Second Floor, Blossom Trade Center Opposite NED University
University Road, SB-26, Block No.01 Gulistan-e-Johar, Karachi Pakistan
Phone: 021-37240670
Email: nexusconsultingcompany@gmail.com Web: www.Nexuscon.pk


PROJECT:-

STATE LIFE BUILDING NO.11

TITLE:-

BUILDING
CEILING PLAN

REV #	DATE	DESCRIPTION	CHKD	APPD	Project Ref:	DATE
						JULY, 2026
					DRAWN BY	SCALE
					A-A	AS SHOWN
					CHECKED BY	DWG. NO.
					O-A	BC-14

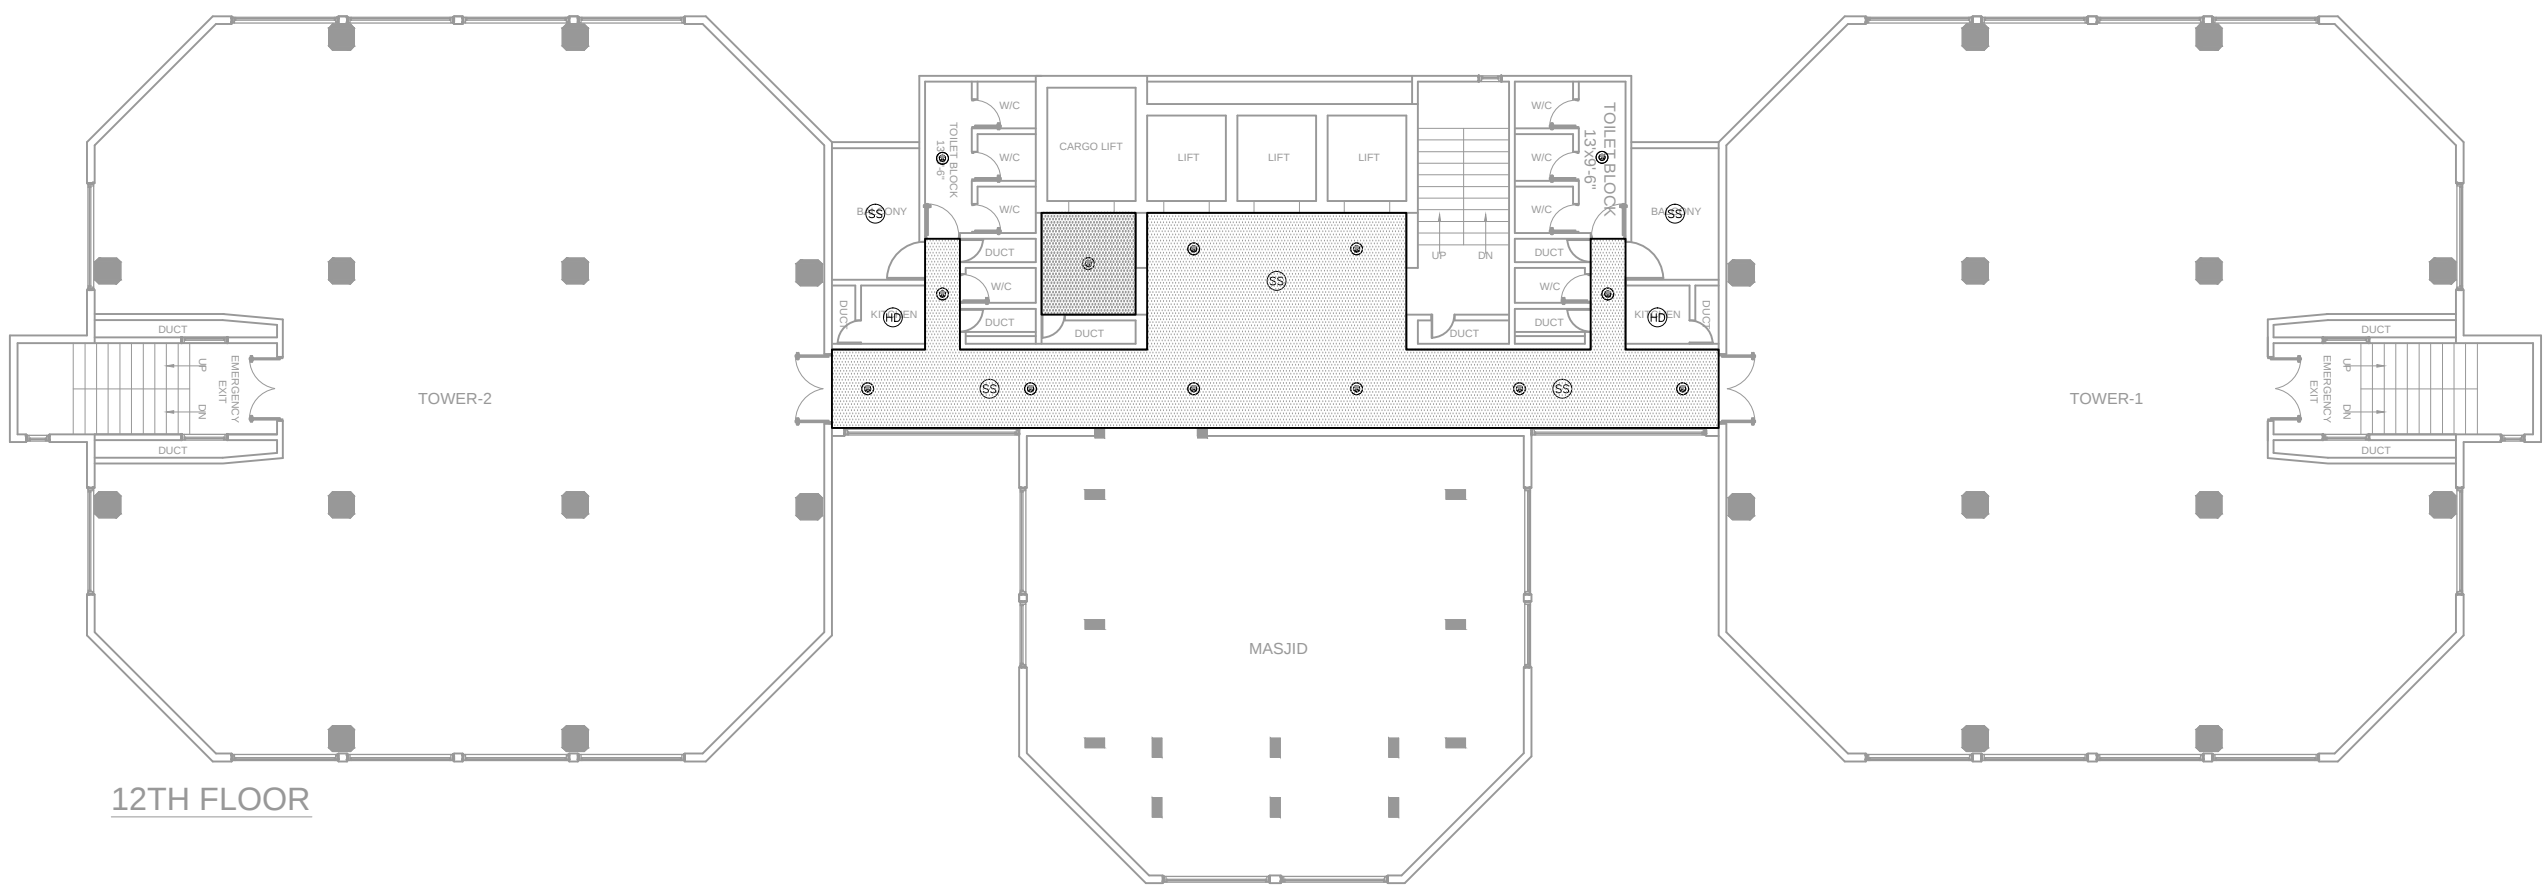

LEGENDS		
SS	SMOKE DETECTOR	CEILING
HD	HEAT DETECTOR	CEILING
@	PENDENT CONCEALED SPRINKLER	CEILING
⊗	UPRIGHT SPRINKLER	
	REELECTED CEILING AREA	

CLIENT:-



STATE LIFE
INSURANCE CORPORATION OF PAKISTAN

CONSULTANT:



Nexus
Consulting
Office A-202, Second Floor, Blossom Trade Center Opposite NED University
University Road, SB-26, Block No.01 Gullistan-e-Jouhar, Karachi Pakistan
Phone: 021-37240670
Email: nexusconsultingcompany@gmail.com Web: www.Nexuscon.pk


PROJECT:-

STATE LIFE BUILDING NO.11

TITLE:-

BUILDING
CEILING PLAN

REV #	DATE	DESCRIPTION	CHKD	APPD	Project Ref:	DATE
						JULY, 2026
					DRAWN BY	SCALE
					A-A	AS SHOWN
					CHECKED BY	DWG. NO.
					O-A	BC-15

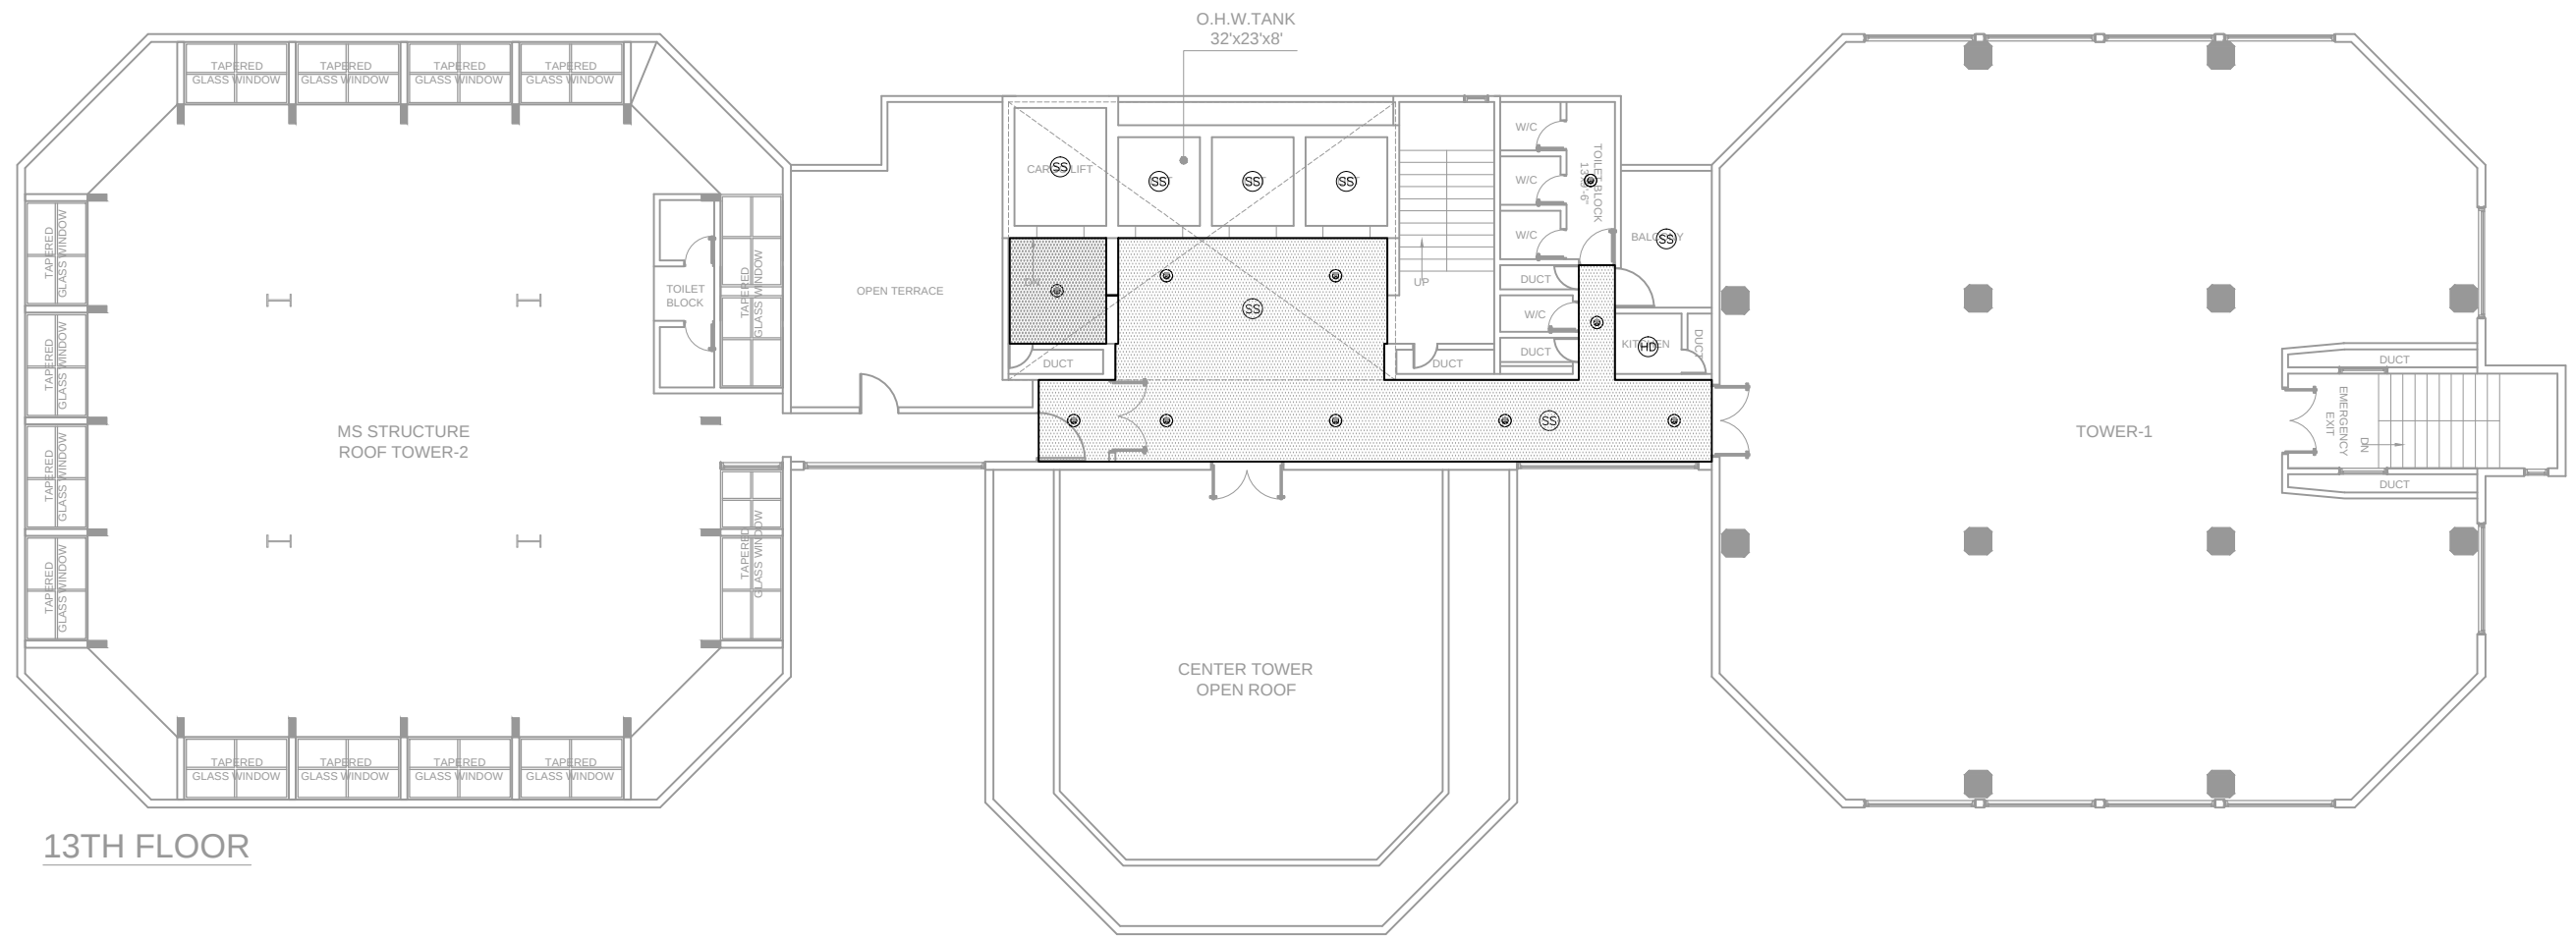

LEGENDS		
SS	SMOKE DETECTOR	CEILING
HD	HEAT DETECTOR	CEILING
@	PENDENT CONCEALED SPRINKLER	CEILING
⊗	UPRIGHT SPRINKLER	
	REELECTED CEILING AREA	

CLIENT:-



STATE LIFE
INSURANCE CORPORATION OF PAKISTAN

CONSULTANT:



Nexus
Consulting
Office A-202, Second Floor, Blossom Trade Center Opposite NED University
University Road, SB-26, Block No.01 Gulistan-e-Jouhar, Karachi Pakistan
Phone: 021-37240670
Email: nexusconsultingcompany@gmail.com Web: www.Nexuscon.pk




PROJECT:-

STATE LIFE BUILDING NO.11

TITLE:-

BUILDING
CEILING PLAN

REV #	DATE	DESCRIPTION	CHKD	APPD	Project Ref:	DATE
						JULY, 2026
					DRAWN BY A-A	SCALE AS SHOWN
					CHECKED BY O-A	DWG. NO. BC-16

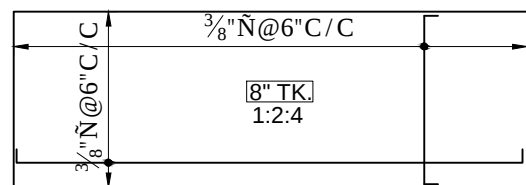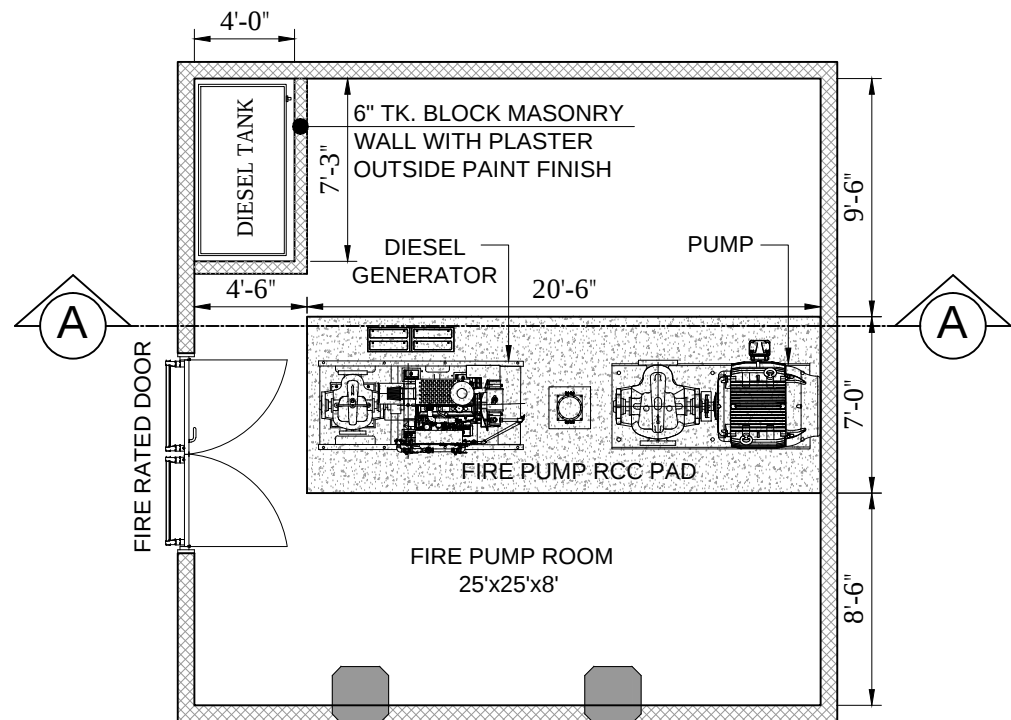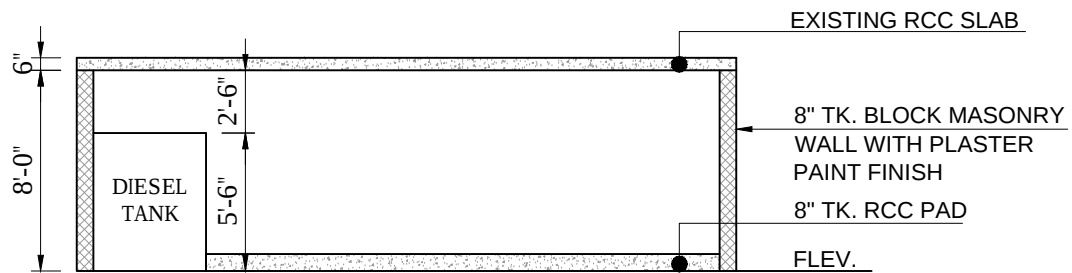

INTERIOR FINISHES (FLOORING)


DESCRIPTION		SUB FLOOR			MAIN FLOORING			
TYPICAL FLOOR		COMPACTED EARTH FILLING	6" SOLING	4" PCC 1:4:8	2" PCC 1:2:4	PORCELAIN TILE	MALBLE TILE	PCC FLOOR
1	FIRE PUMP ROOM							●
2	DIESEL TANK							●
3								

INTERIOR FINISHES (PLASTER/ PAINT/ VERNISHED)

DESCRIPTION							
TYPICAL FLOOR		FALSE CEILING	WALL PLASTER	CEILING PAINT DISTEMPER	WALL PAINT DISTEMPER	WALL TILE	WEATHER SHEET
1	FIRE PUMP ROOM		●	●	●		
2	DIESEL TANK		●		●		
3							

EXTERIOR FINISHES

PAINT	●				
PLASTER	●				

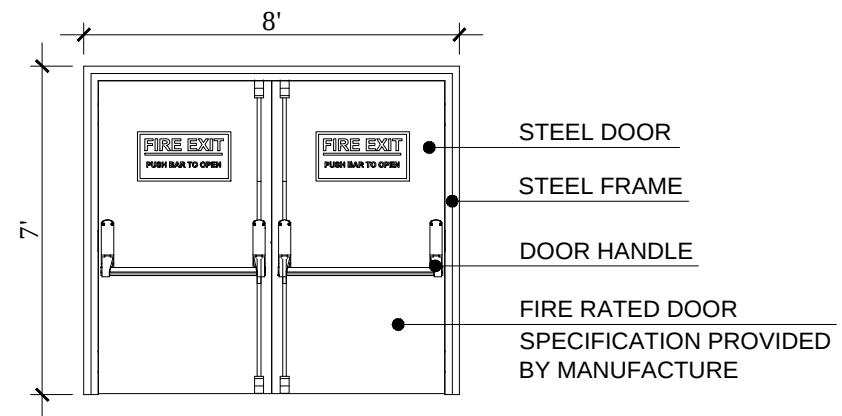

CLIENT:-



CONSULTANT:-



PROJECT:-

STATE LIFE BUILDING NO.11

TITLE:-

FIRE PUMP ROOM DETAILS

REV #	DATE	DESCRIPTION	CHKD	APPD	Project Ref:	DATE
						JULY, 2026
					DRAWN BY	SCALE
					A-A	AS SHOWN
					CHECKED BY	DWG. NO.
					O-A	BC-17